
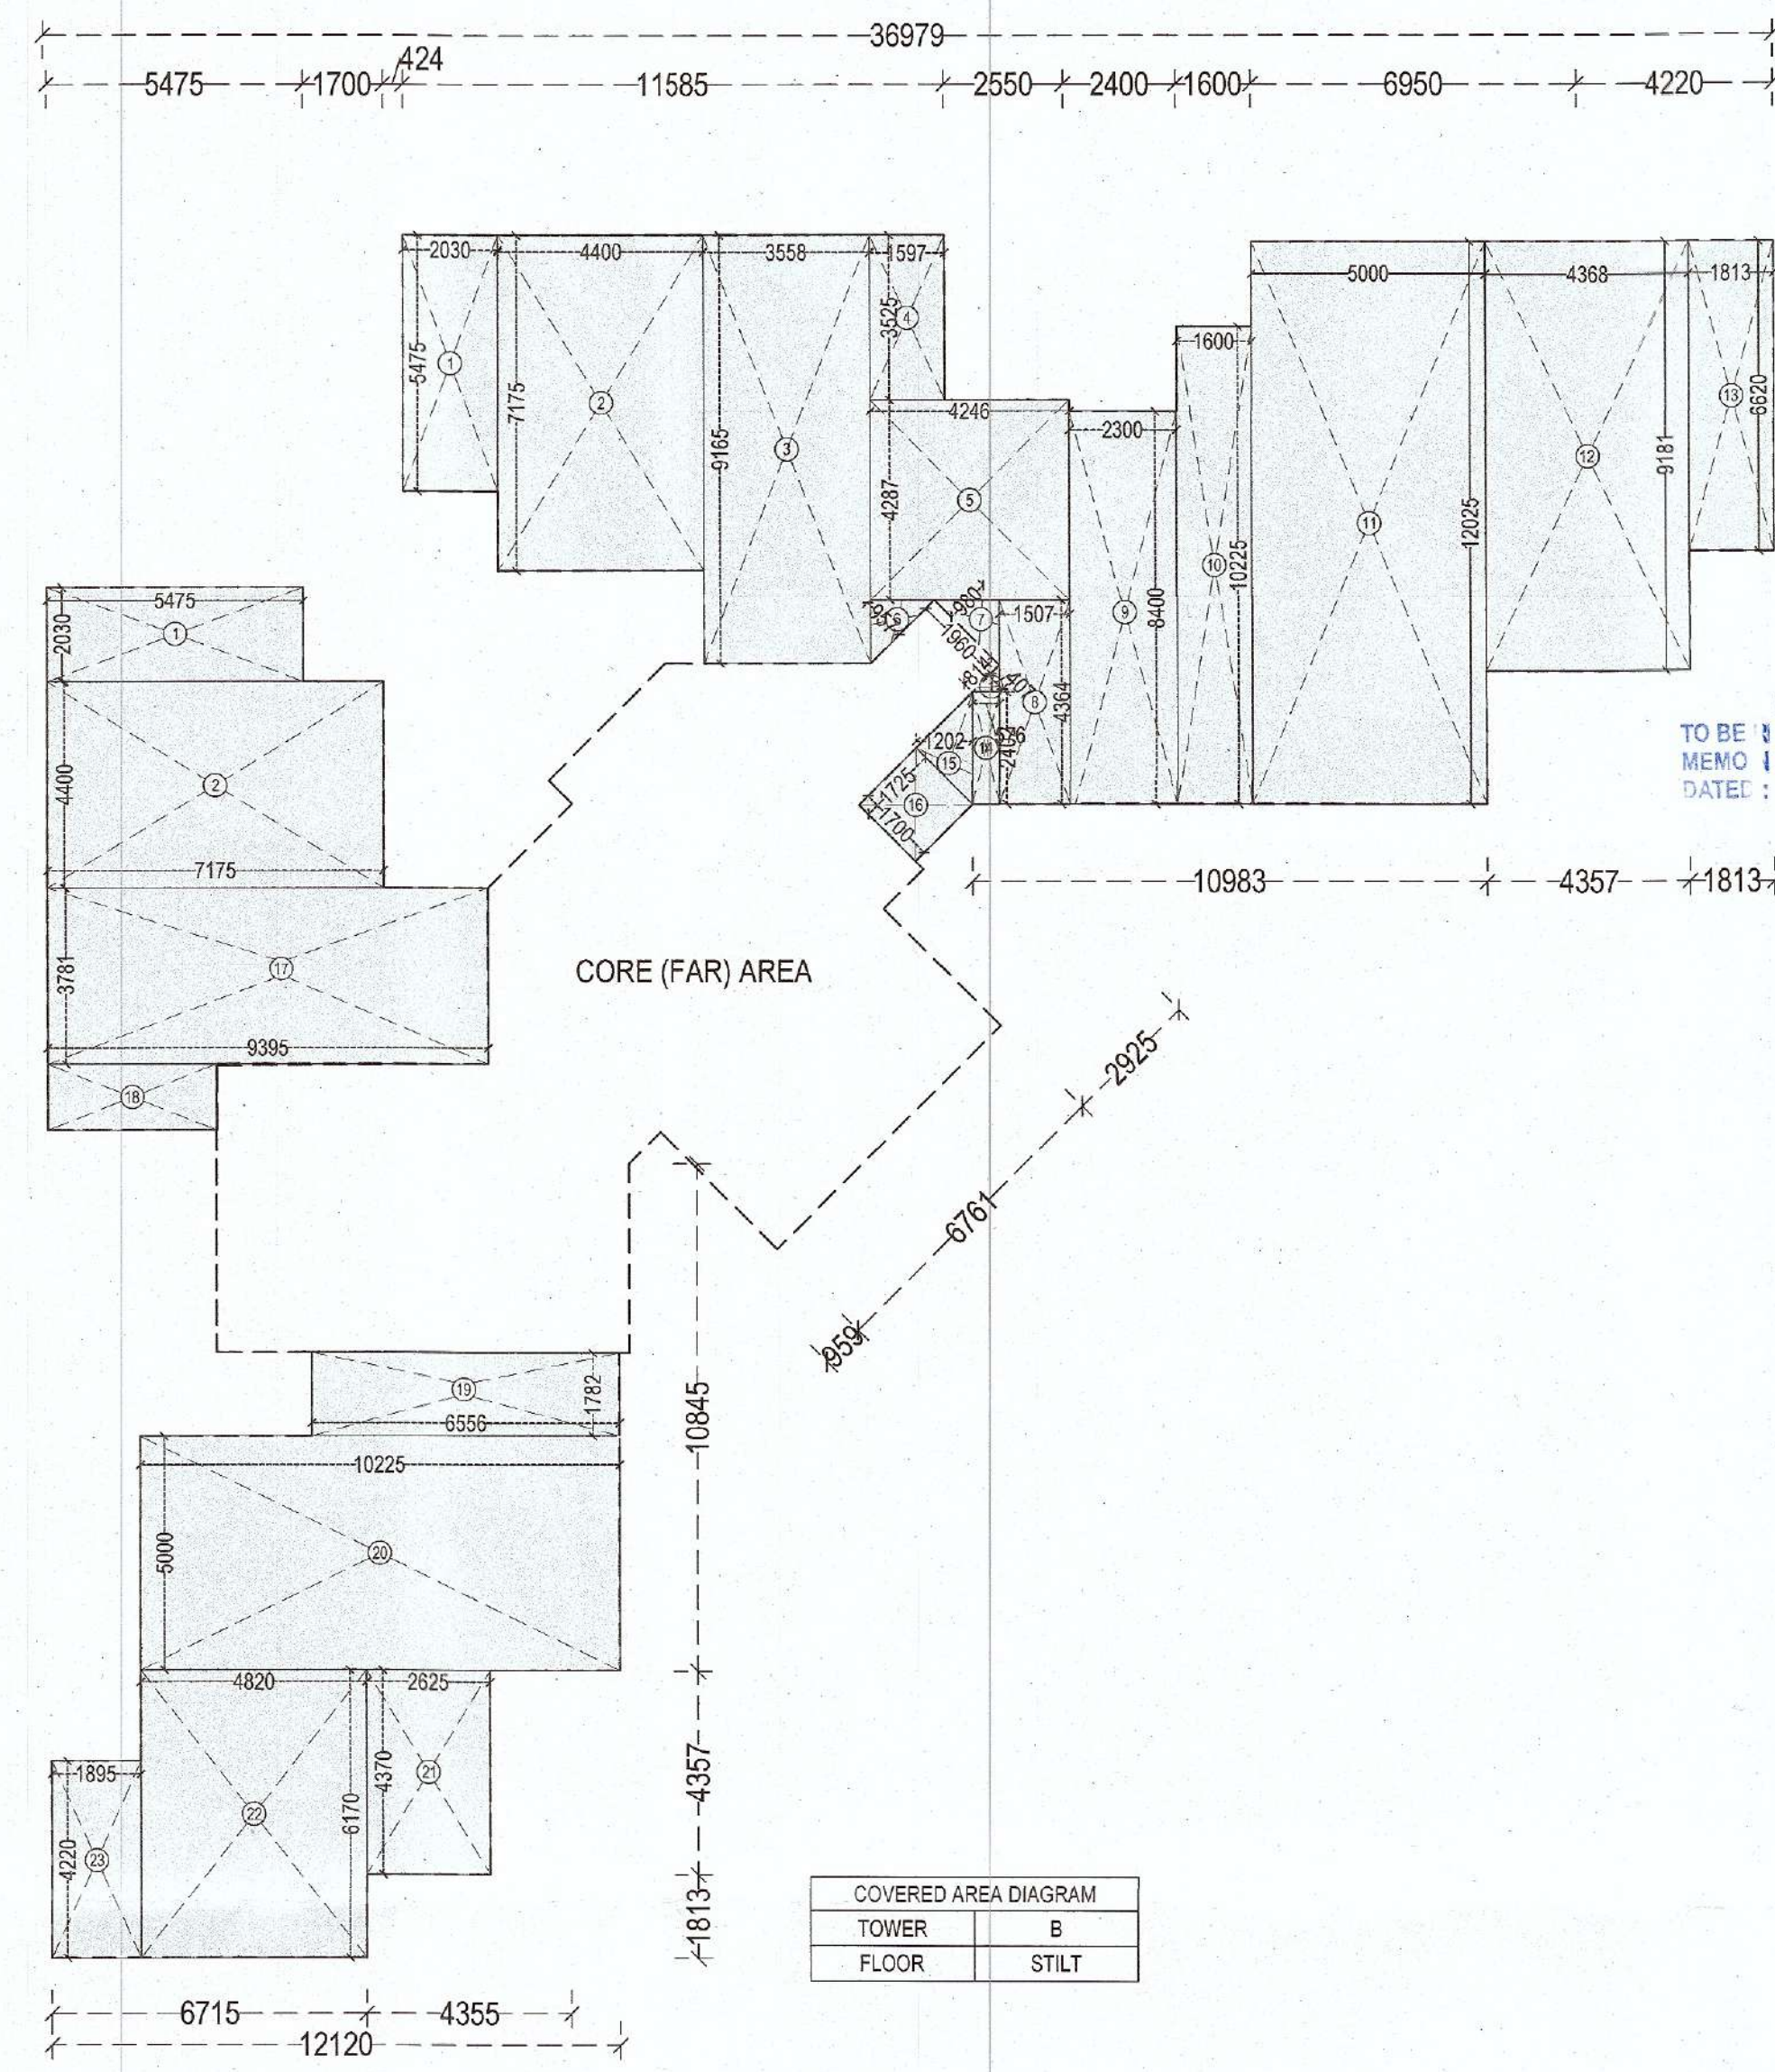


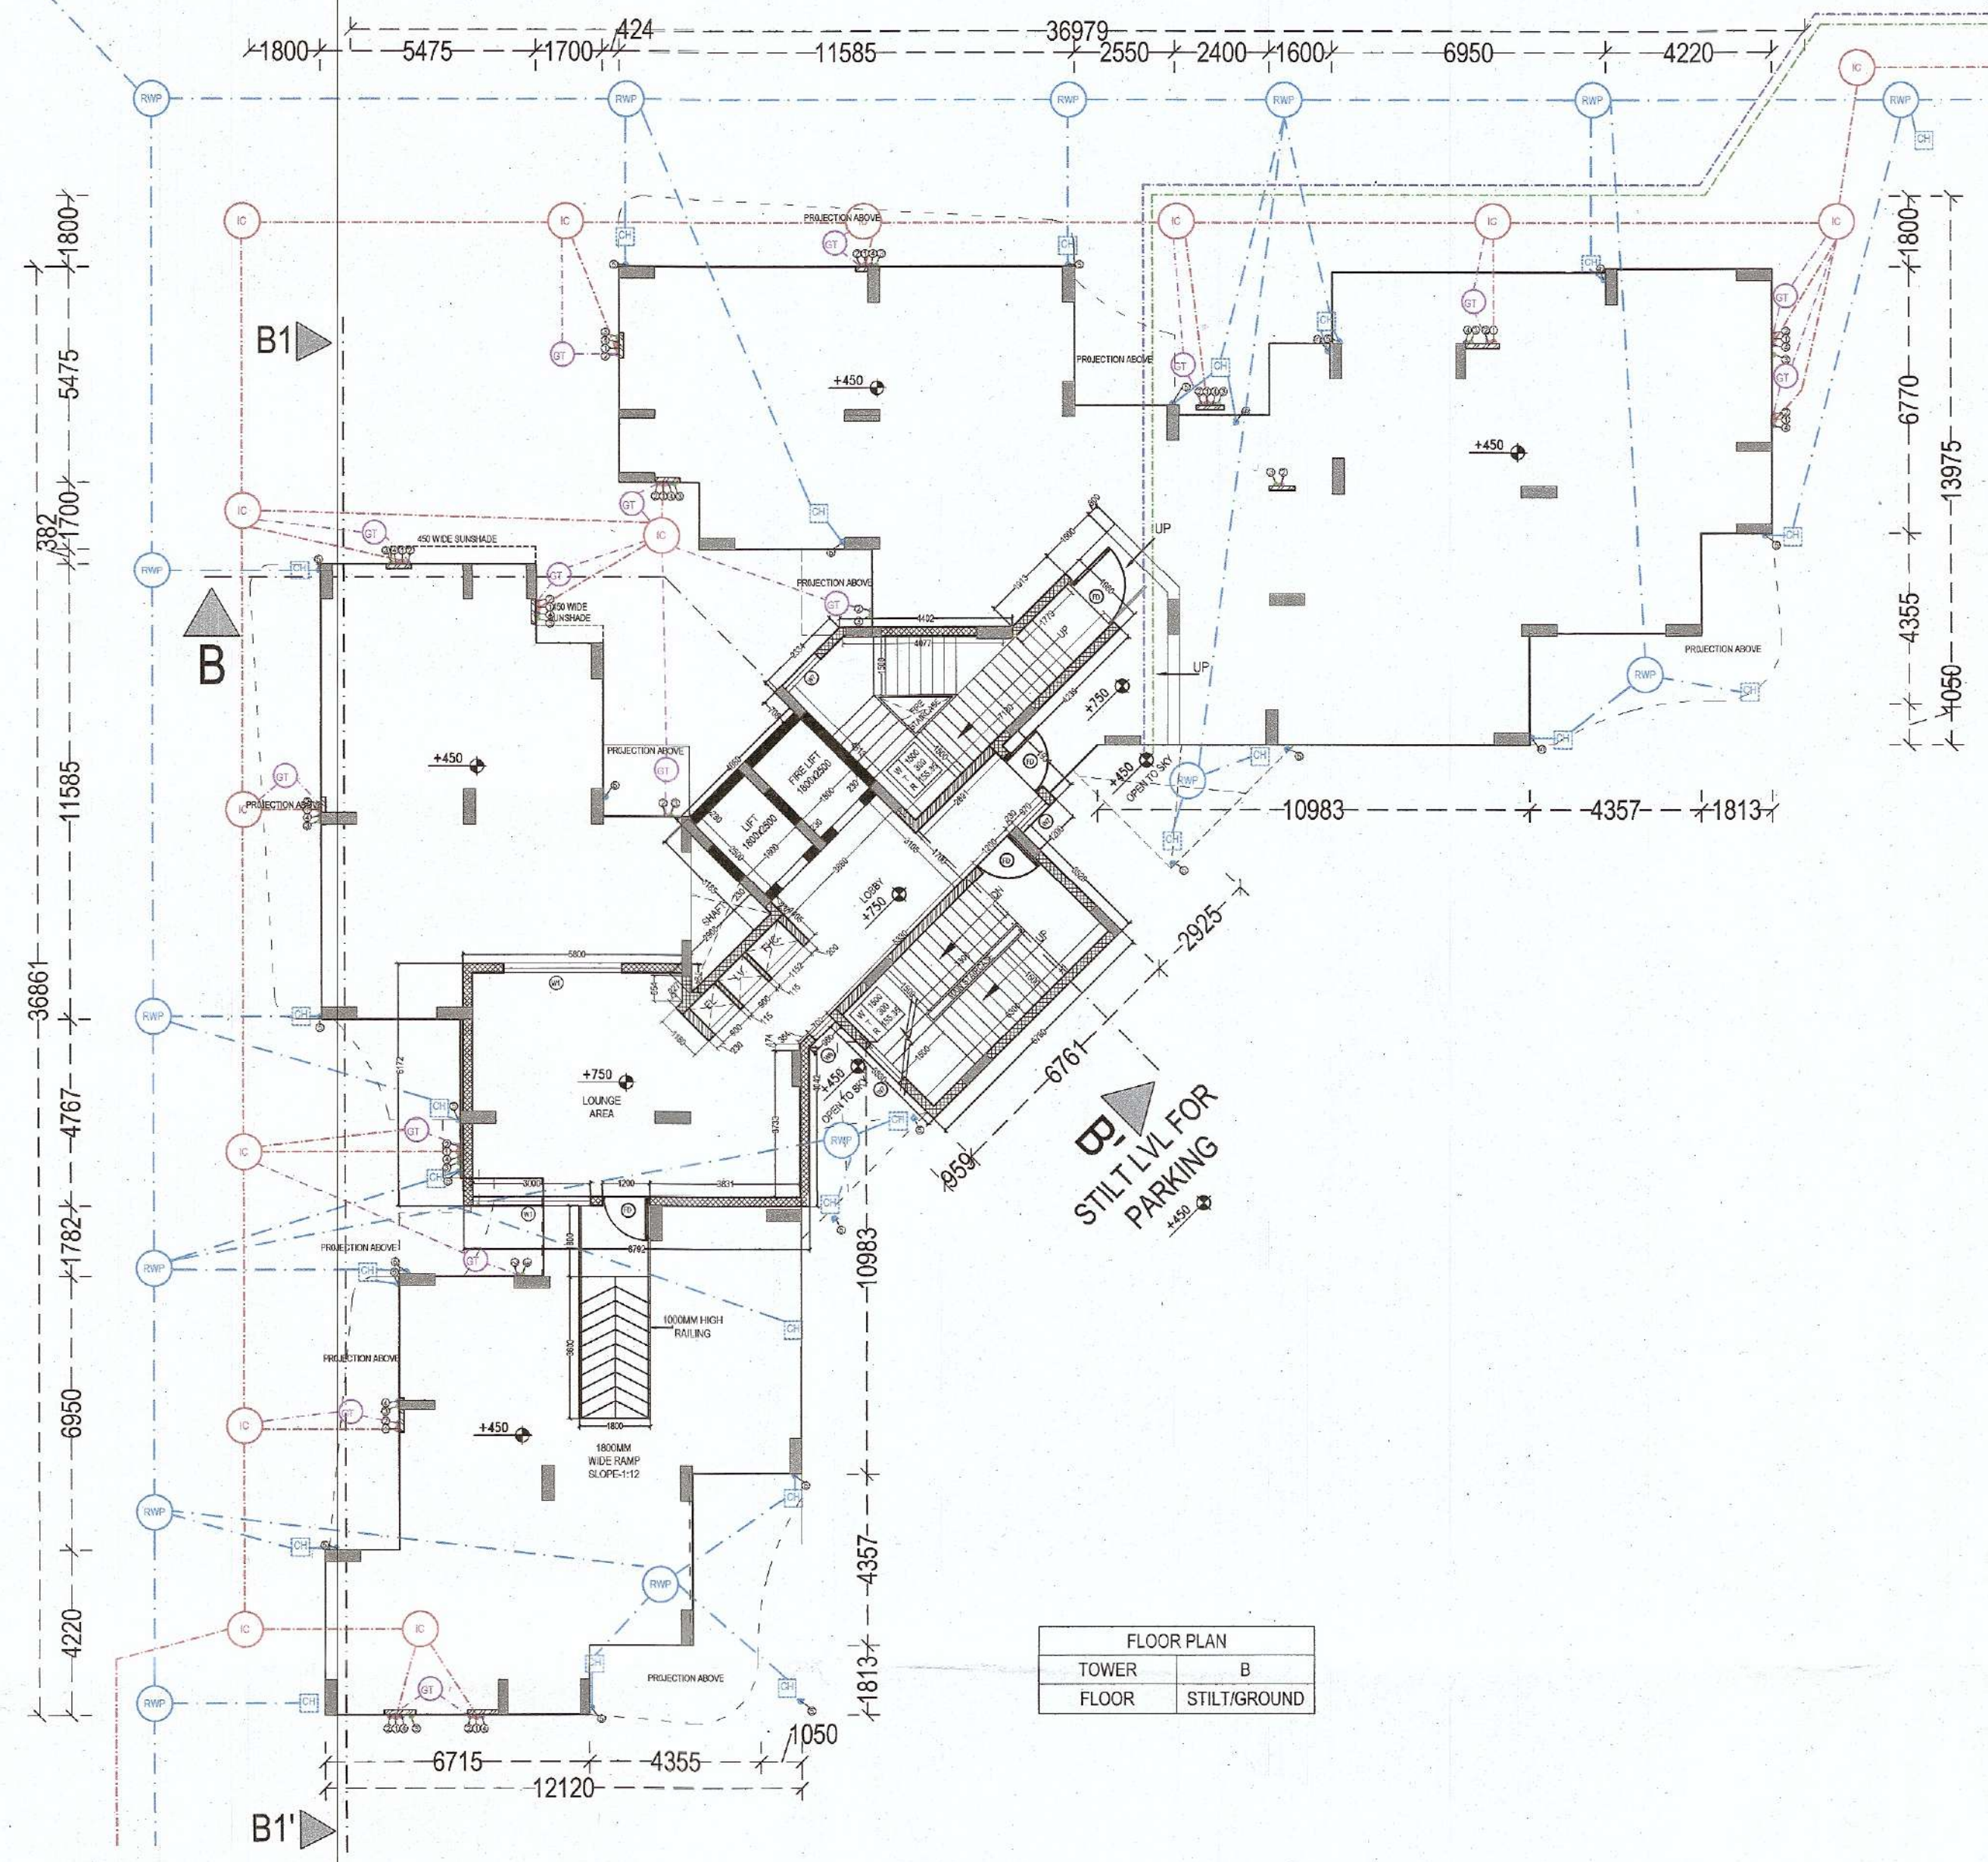

PLUMBING LEGEND:-

1	100 OD uPVC SOIL PIPE
2	100 OD uPVC WASTE PIPE
3	65mm CPVC DWS DN.TAKE PIPE
4	50mm CPVC FWS DN.TAKE PIPE
5	100 OD uPVC RAIN WATER
6	50mm DWS RISER PIPE
7	50mm FWS RISER PIPE
8	100mm WASTE PIPE
9	100mm SOIL PIPE
10	75mm RAIN WATER PIPE
11	FLOOR TRAP
12	FLOOR DRAIN
13	FLOOR CLEAN OUT
14	CLEAN OUT PLUG
15	CUTOUT SIZE-150x150mm


Sanctioned
TO BE SUBMITTED WITH THIS OFFICE
MEMO NO. :
DATE :

Member B.P.A.C. Member B.P.A.C. Member B.P.A.C. Member B.P.A.C.

ATP(HQ) VARINDER KUMAR JD(HQ)

JOINTLY

SR. NO.	NAME	WIDTH	CLL	INTEL
1	D1	1250	0	2500
2	D2	1050	0	2500
3	D3	750	0	2500
4	D4	900	0	2500
5	FCD	1500	0	2500
6	W1	3000	600	2500
7	W2	1000	600	2500
8	W3	1500	1050	2500
9	W4	1050	1050	2500
10	W5	2000	800	2500
11	W6	700	1050	2500
12	W7	1200	3100	4300
13	DW1	3000	0 & 900	2500
14	DW2	2500	0 & 1050	2500
15	DW3	2000	0 & 600	2500
16	DW4	1500	0 & 600	2500
17	DW5	1350	0 & 1050	2500
18	DW6	2300	0 & 600	2500
19	DW7	1950	0 & 1050	2500
20	V1	500	1050	2500
21	V2	750	1050	2500
22	V3	1500	1050	2500

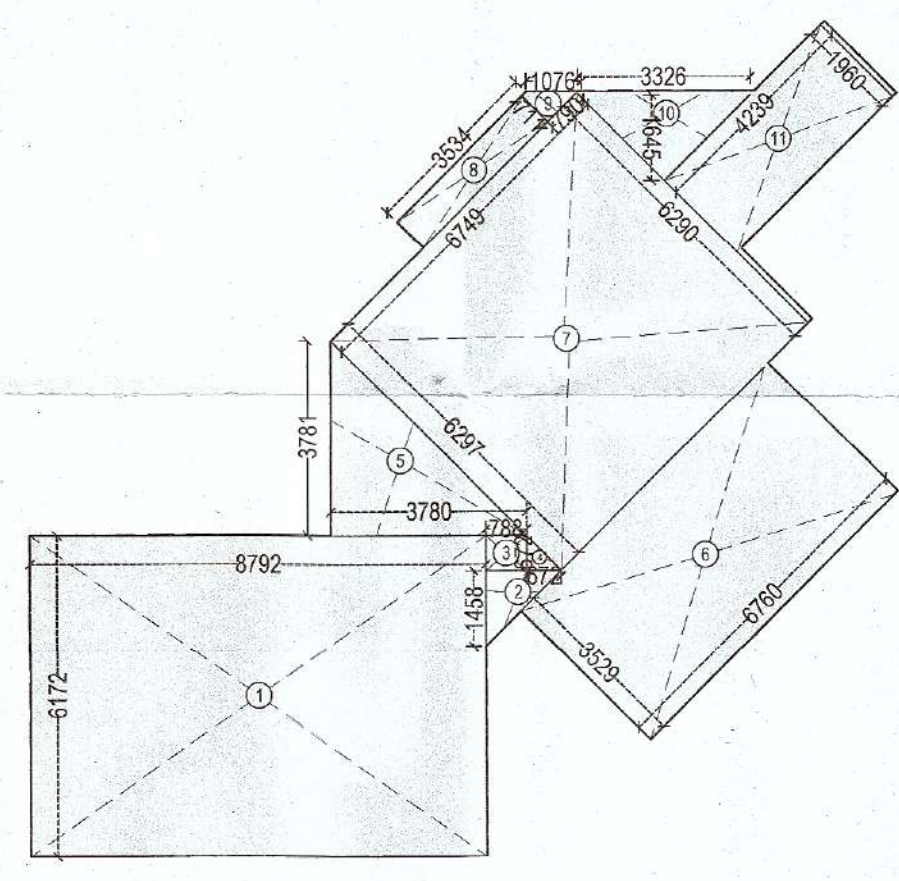

COVERED AREA				
TOWER		B		
FLOOR		STILT		
NAME	NO.	LENGTH	WIDTH	AREA (IN SQ.MT.)
ADDITION				
1	1	8.792	6.172	54.264
2	0.5	1.460	1.498	1.064
3	1	0.672	0.788	0.530
4	0.5	0.672	0.672	0.226
5	0.5	3.780	3.781	7.146
6	1	6.790	3.529	23.856
7	1	6.290	6.749	42.451
8	1	3.534	0.711	2.513
9	0.5	1.076	0.711	0.383
10	0.5	3.326	1.845	2.736
11	1	4.239	1.990	8.306
TOTAL				143.476

BUILT-UP AREA				
TOWER		B		
FLOOR		STILT		
NAME	NO.	LENGTH	WIDTH	AREA (IN SQ.MT.)
COVERED AREA				
STILT PARKING AREA				
TOTAL				599.89

STILT AREA FOR PARKING				
TOWER		B		
FLOOR		STILT		
NAME	NO.	LENGTH	WIDTH	AREA (IN SQ.MT.)
ADDITION				
1	2	5.475	2.030	22.23
2	2	7.175	4.400	63.14
3	1	3.558	9.155	32.61
4	1	1.597	3.525	5.63
5	1	4.246	4.287	18.20
6	0.5	1.353	0.957	0.65
7	0.5	1.960	0.980	0.96
8	1	1.507	4.364	6.58
9	1	2.300	8.400	19.32
10	1	1.600	10.225	16.36
11	1	5.000	12.025	60.13
12	1	4.368	9.181	40.10
13	1	1.813	6.620	12.00
14	0.5	0.814	0.407	0.17
15	1	0.576	2.402	1.38
16	0.5	1.700	1.700	1.45
17	1	1.700	1.725	2.93
18	1	9.395	3.781	35.52
19	1	3.595	1.404	5.05
20	1	6.556	1.782	11.68
21	1	10.225	5.000	51.13
22	1	2.625	4.370	11.47
23	1	4.820	6.170	29.74
24	1	1.895	4.220	8.00
TOTAL				455.42

EE(WS) GMDA
EE(Drainage) GMDA
EE(Saw) GMDA
EE(Nodal Officer) Infra-II, GMDA
CE(Infra-II) GMDA

PROJECT:
PROPOSED BUILDING PLAN OF GROUP HOUSING COLONY OVER AN AREA MEASURING 4.1875 ACRES UNDER TOD POLICY (LICENCE NO 97 OF 2021 DATED 12.11.2021) IN SECTOR 103, GURUGRAM. DEVELOPED BY SUNITA KUMARI W/o SH.ASHOK KUMAR & OTHERS IN COLLABORATION WITH M/s AVIANA GREEN ESTATES PVT. LTD.

SHEET TITLE:
TOWER - B
STILT FLOOR PLAN & AREA DIAGRAM

ARCHITECT:
ARCHITECTS AND CONSULTANTS
AE STUDIO
A-3, CHANDAN PARK, CH-1, NEW DELHI-110016, Ph: 011-4760359, E-Mail: info@ae-studio.in, Web: www.ae-studio.in

DATE: SEPTEMBER 2022
SCALE: 1:100
NORTH
SHEET SIZE: A0
CLIENT SIGNATURE: Sundeep Tandon, Director
ARCHITECT SIGNATURE: Sundeep Tandon, Architect, 097121634