

PLUMBING LEGEND:-	
①	100 ØD UPVC SOIL PIPE
②	100 ØD UPVC WASTE PIPE
③	65 ØD CPVC DWS DNTAKE PIPE
④	50 ØD CPVC FWS DNTAKE PIPE
⑤	100 ØD UPVC RAIN WATER
⑥	50 ØD DWS RISER PIPE
⑦	50 ØD FWS RISER PIPE
⑧	100 ØD WASTE PIPE
⑨	100 ØD SOIL PIPE
⑩	75 ØD RAIN WATER PIPE
⑪	FT FLOOR TRAP
⑫	FD FLOOR DRAIN
⑬	CD FLOOR CLEAN OUT
⑭	TOP CLEAN OUT PLUG
⑮	CUTOUT SIZE-150x150mm

D.P. (HQ) Member B.P.A.C.
 S.P. (HQ) Member B.P.A.C.
 S.P. (G) Member B.P.A.C.
 S.P. (G) Member B.P.A.C.

NARINDER KUMAR JODH
 A.T.P. (HQ)

SANCTIONED
 TO BE READ WITH THIS OFFICE
 MEMO NO.:
 DATED:

J.D.
 P.A.
 A.T.P.

JOINERY				
SR. NO.	NAME	WIDTH	CILL	LINTEL
1	D1	1200	0	2500
2	D2	1050	0	2500
3	D3	750	0	2500
4	D4	600	0	2500
5	FCD	1500	0	2500
6	W1	3000	600	2500
7	W2	1000	600	2500
8	W3	1500	1050	2500
9	W4	1050	1050	2500
10	W5	2000	600	2500
11	W6	700	1050	2500
12	W7	1200	3100	4300
13	DW1	3000	0 & 600	2500
14	DW2	2500	0 & 1050	2500
15	DW3	2000	0 & 600	2500
16	DW4	1500	0 & 600	2500
17	DW5	1350	0 & 1050	2500
18	DW6	2300	0 & 600	2500
19	DW7	1950	0 & 1050	2500
20	V1	600	1050	2500
21	V2	750	1050	2500
22	V3	1500	1050	2500

PROJECT:
 PROPOSED BUILDING PLAN OF
 GROUP HOUSING COLONY
 OVER AN AREA MEASURING
 4.1875 ACRES UNDER TOD
 POLICY (LICENCE NO 97 OF
 2021 DATED 12.11.2021)
 IN SECTOR 103, GURUGRAM,
 DEVELOPED BY SUNITA KUMARI
 W/o SH.ASHOK KUMAR &
 OTHERS IN COLLABORATION
 WITH M/s AVIANA GREEN
 ESTATES PVT. LTD.

SHEET TITLE:
 TOWER - B
 TERRACE &
 AREA DIAGRAM

ARCHITECT:
 ARCHITECTS AND CONSULTANTS
 AE STUDIO
 an architectural design studio
 A-6, GREEN PARK EXT.,
 NEW DELHI-110016, Ph: 011 4266389
 E-Mail: info@ae-studio.in, Web: www.ae-studio.in

DATE	SEPTEMBER 2022
SCALE	1:100
NORTH	13
CLIENT SIGNATURE	ARCHITECT SIGNATURE
Director	Sandeep


For AVIANA GREENESTATES PVT. LTD.

Director


Sandeep

Arch


CAV9712 534

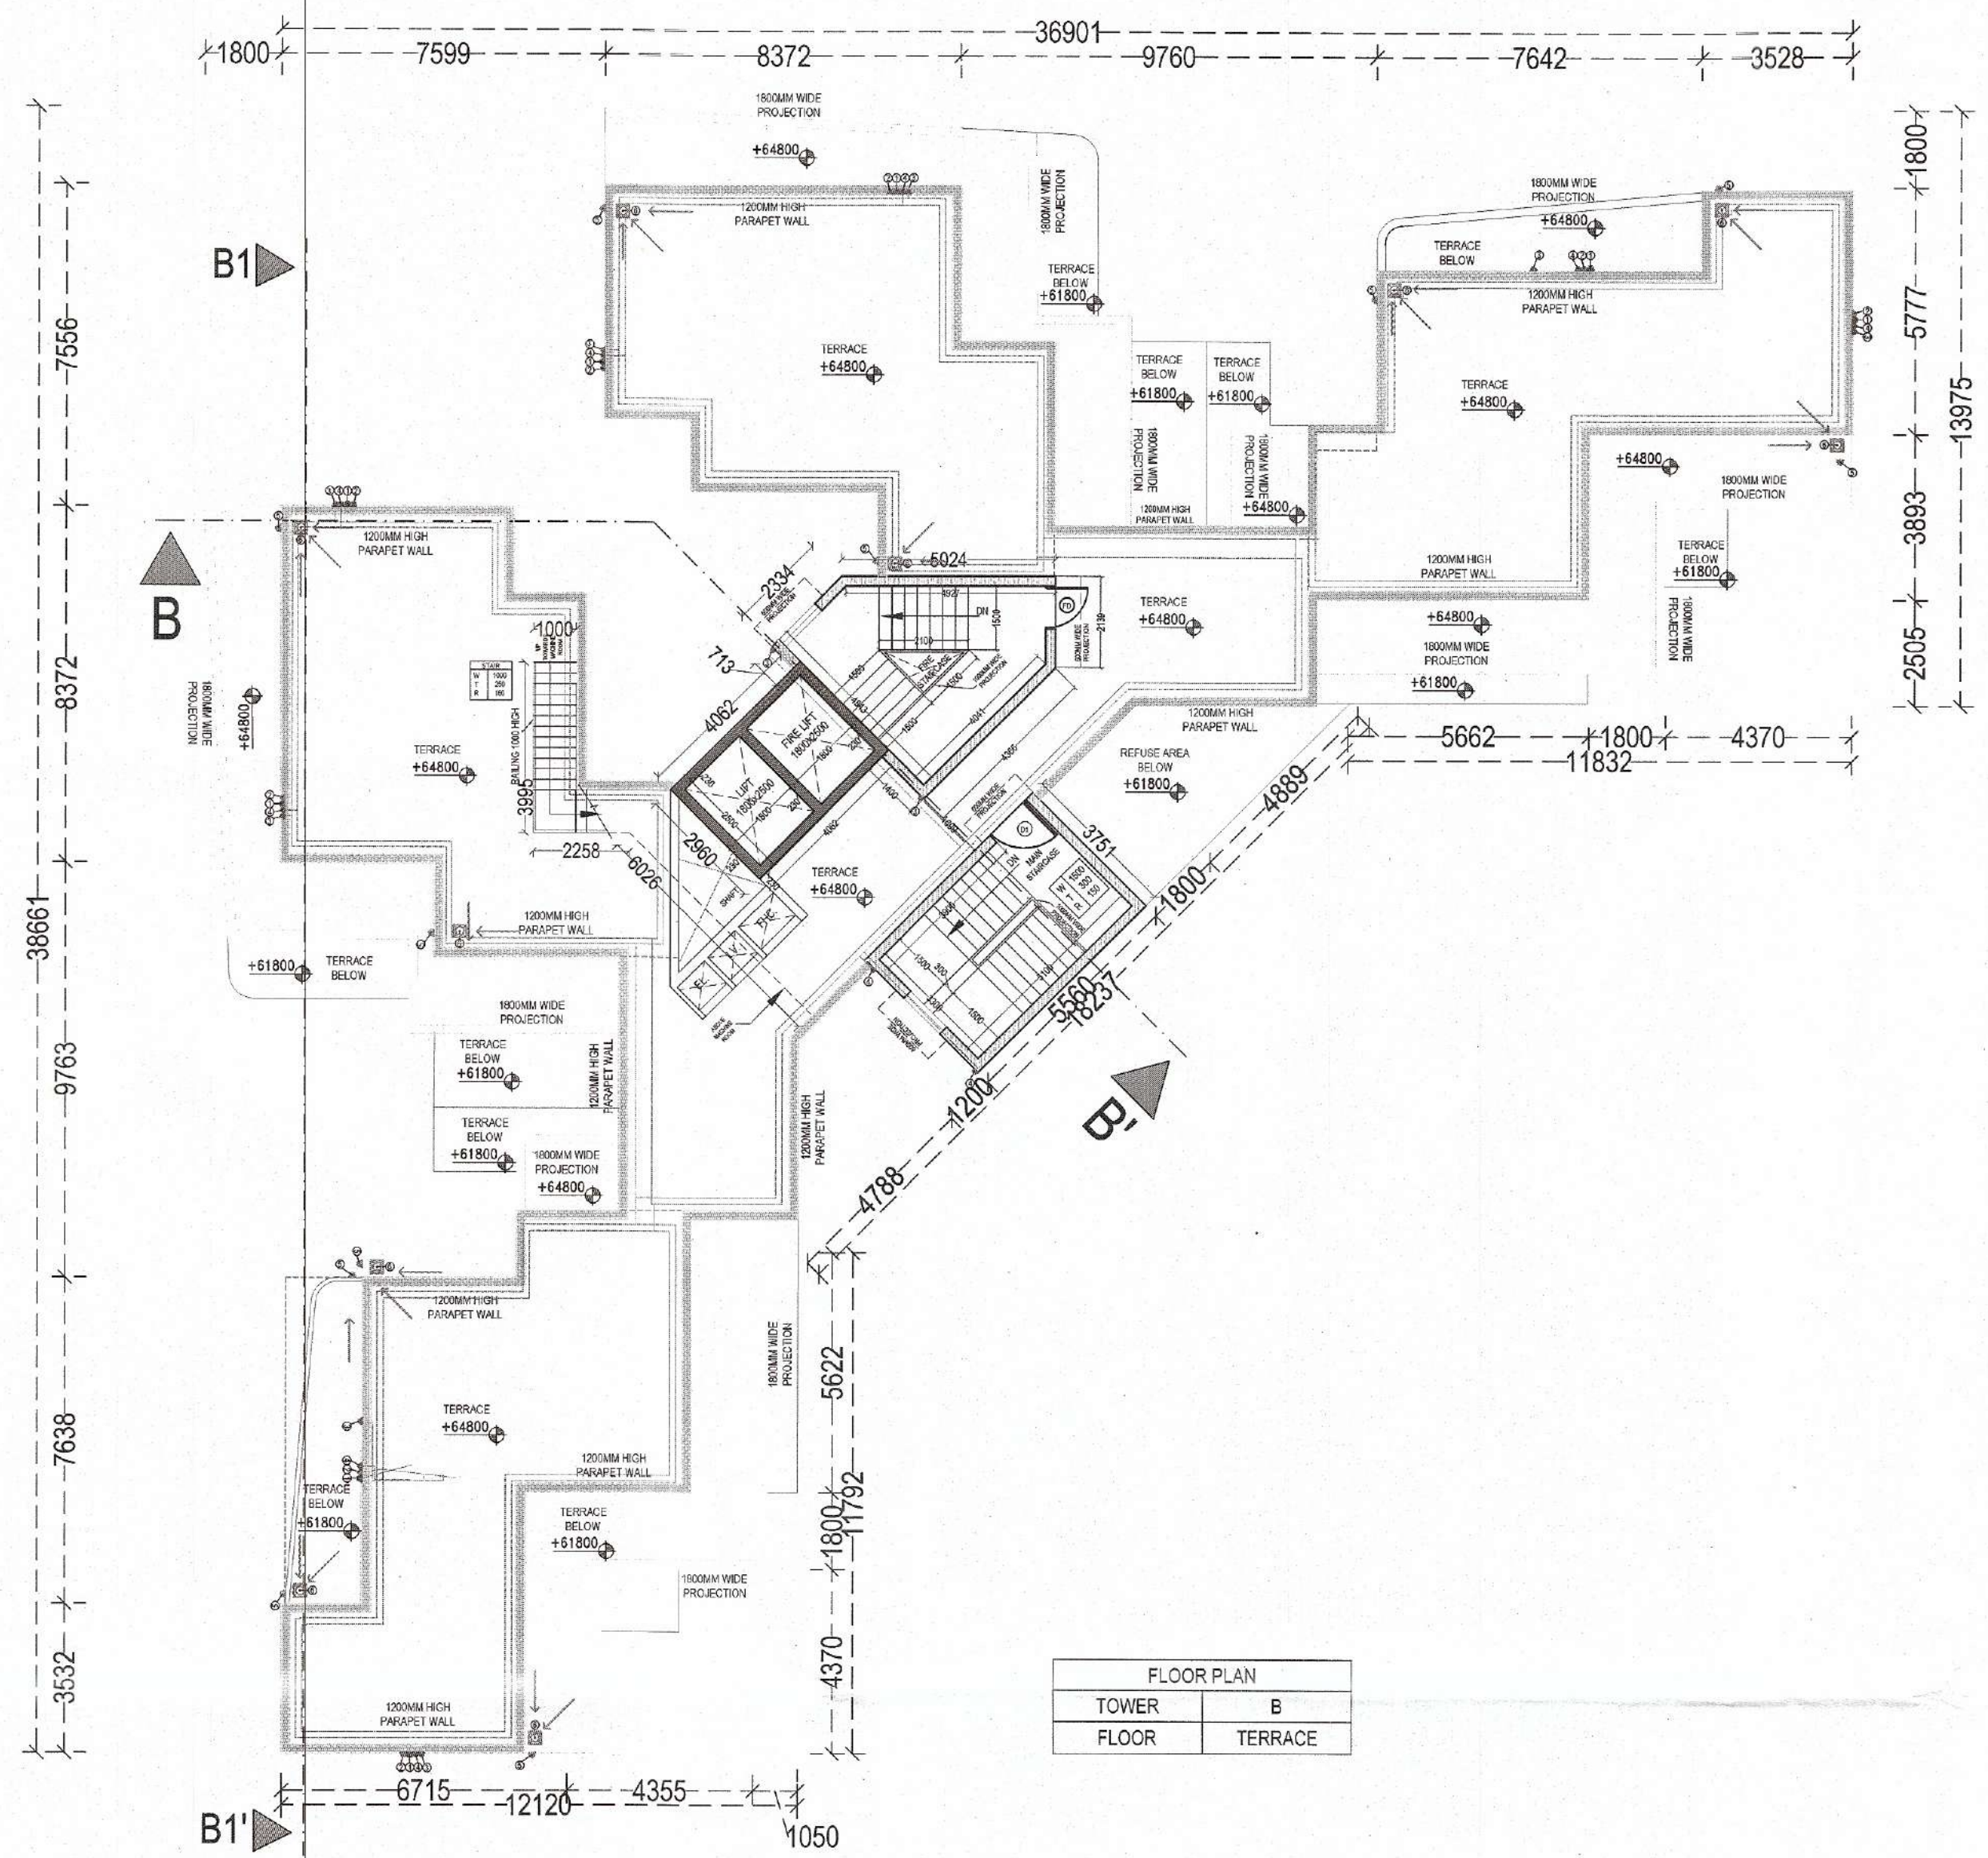


FLOOR PLAN	
TOWER	B
FLOOR	TERRACE

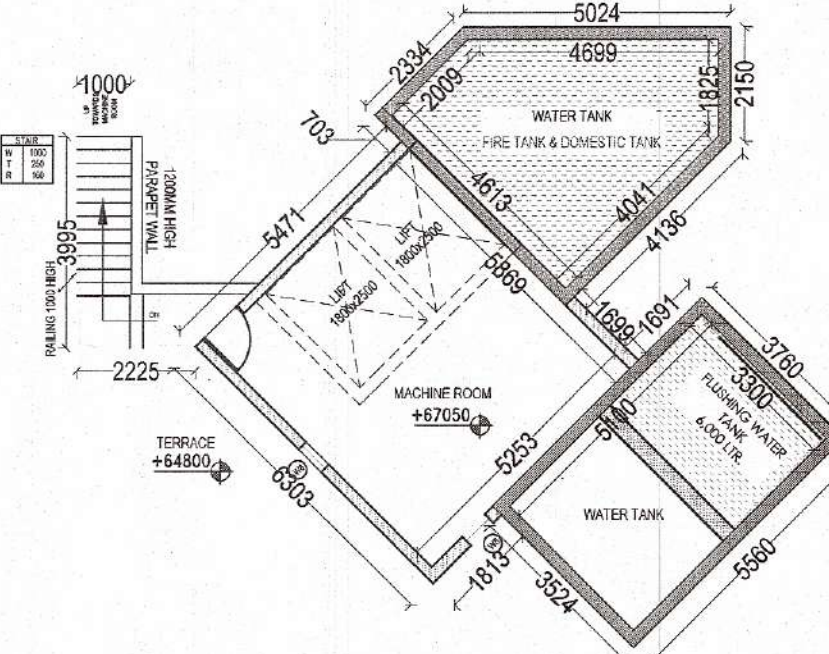

FLOOR PLAN	
TOWER	B
FLOOR	MACHINE ROOM /

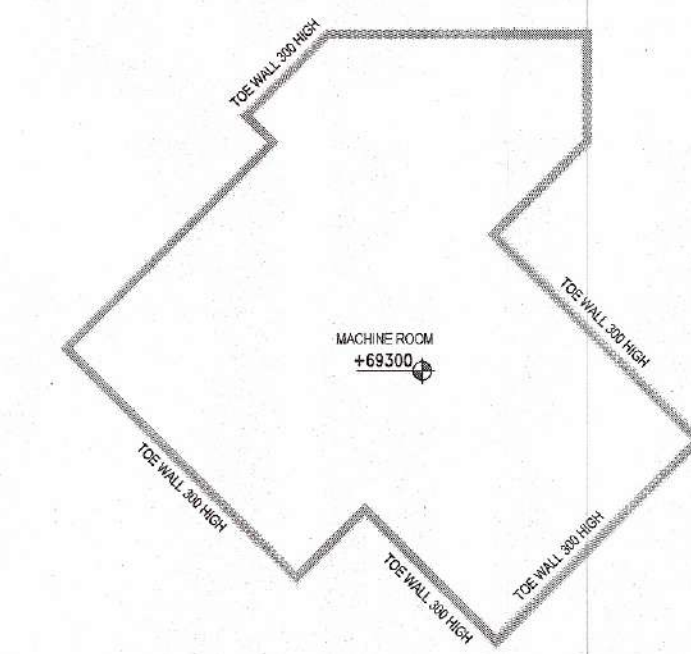

FLOOR PLAN	
TOWER	B
FLOOR	TOP LEVEL

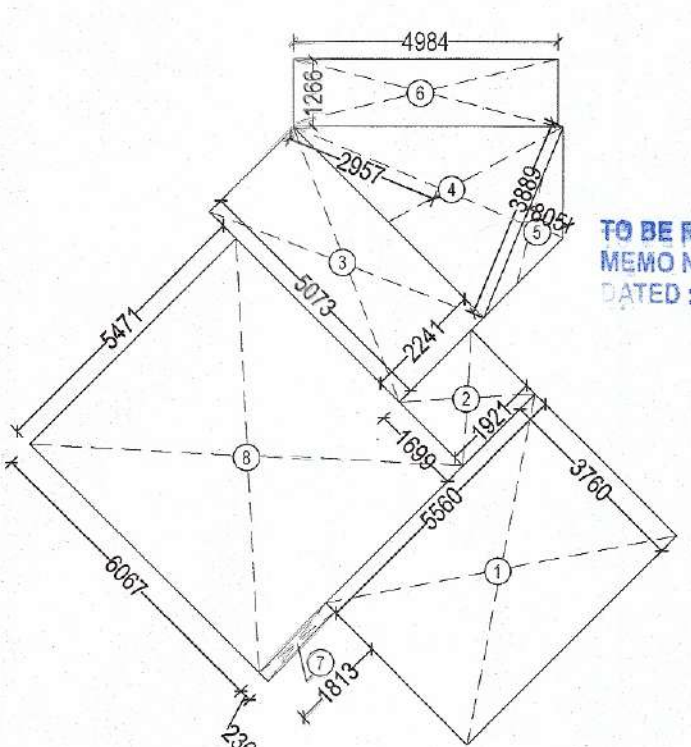

BUILT-UP AREA DAIGRAM	
TOWER	B
FLOOR	MACHINE ROOM

BUILT-UP AREA				
TOWER	B			
FLOOR	MUMTY / MACHINE ROOM			
NAME	NO.	LENGTH	WIDTH	AREA
1	1	5.580	3.760	20.91
2	1	1.699	1.921	3.26
3	1	5.073	2.241	11.37
4	0.5	3.889	4.694	9.13
5	0.5	3.889	3.760	7.31
6	1	5.580	0.805	4.48
7	1	0.235	1.813	0.43
8	1	5.471	6.670	36.49
TOTAL				93.37

Existing plans have been checked and found in order
 as per Public Health Services point of view.

EE(W/S) GMDA
 EE(Drainage) GMDA
 EE(Sew.) GMDA
 EE(Nodal Officer) Infra-II, GMDA
 CE(Infra-II) GMDA

DDT (HQ)
 Member
 BPAC