



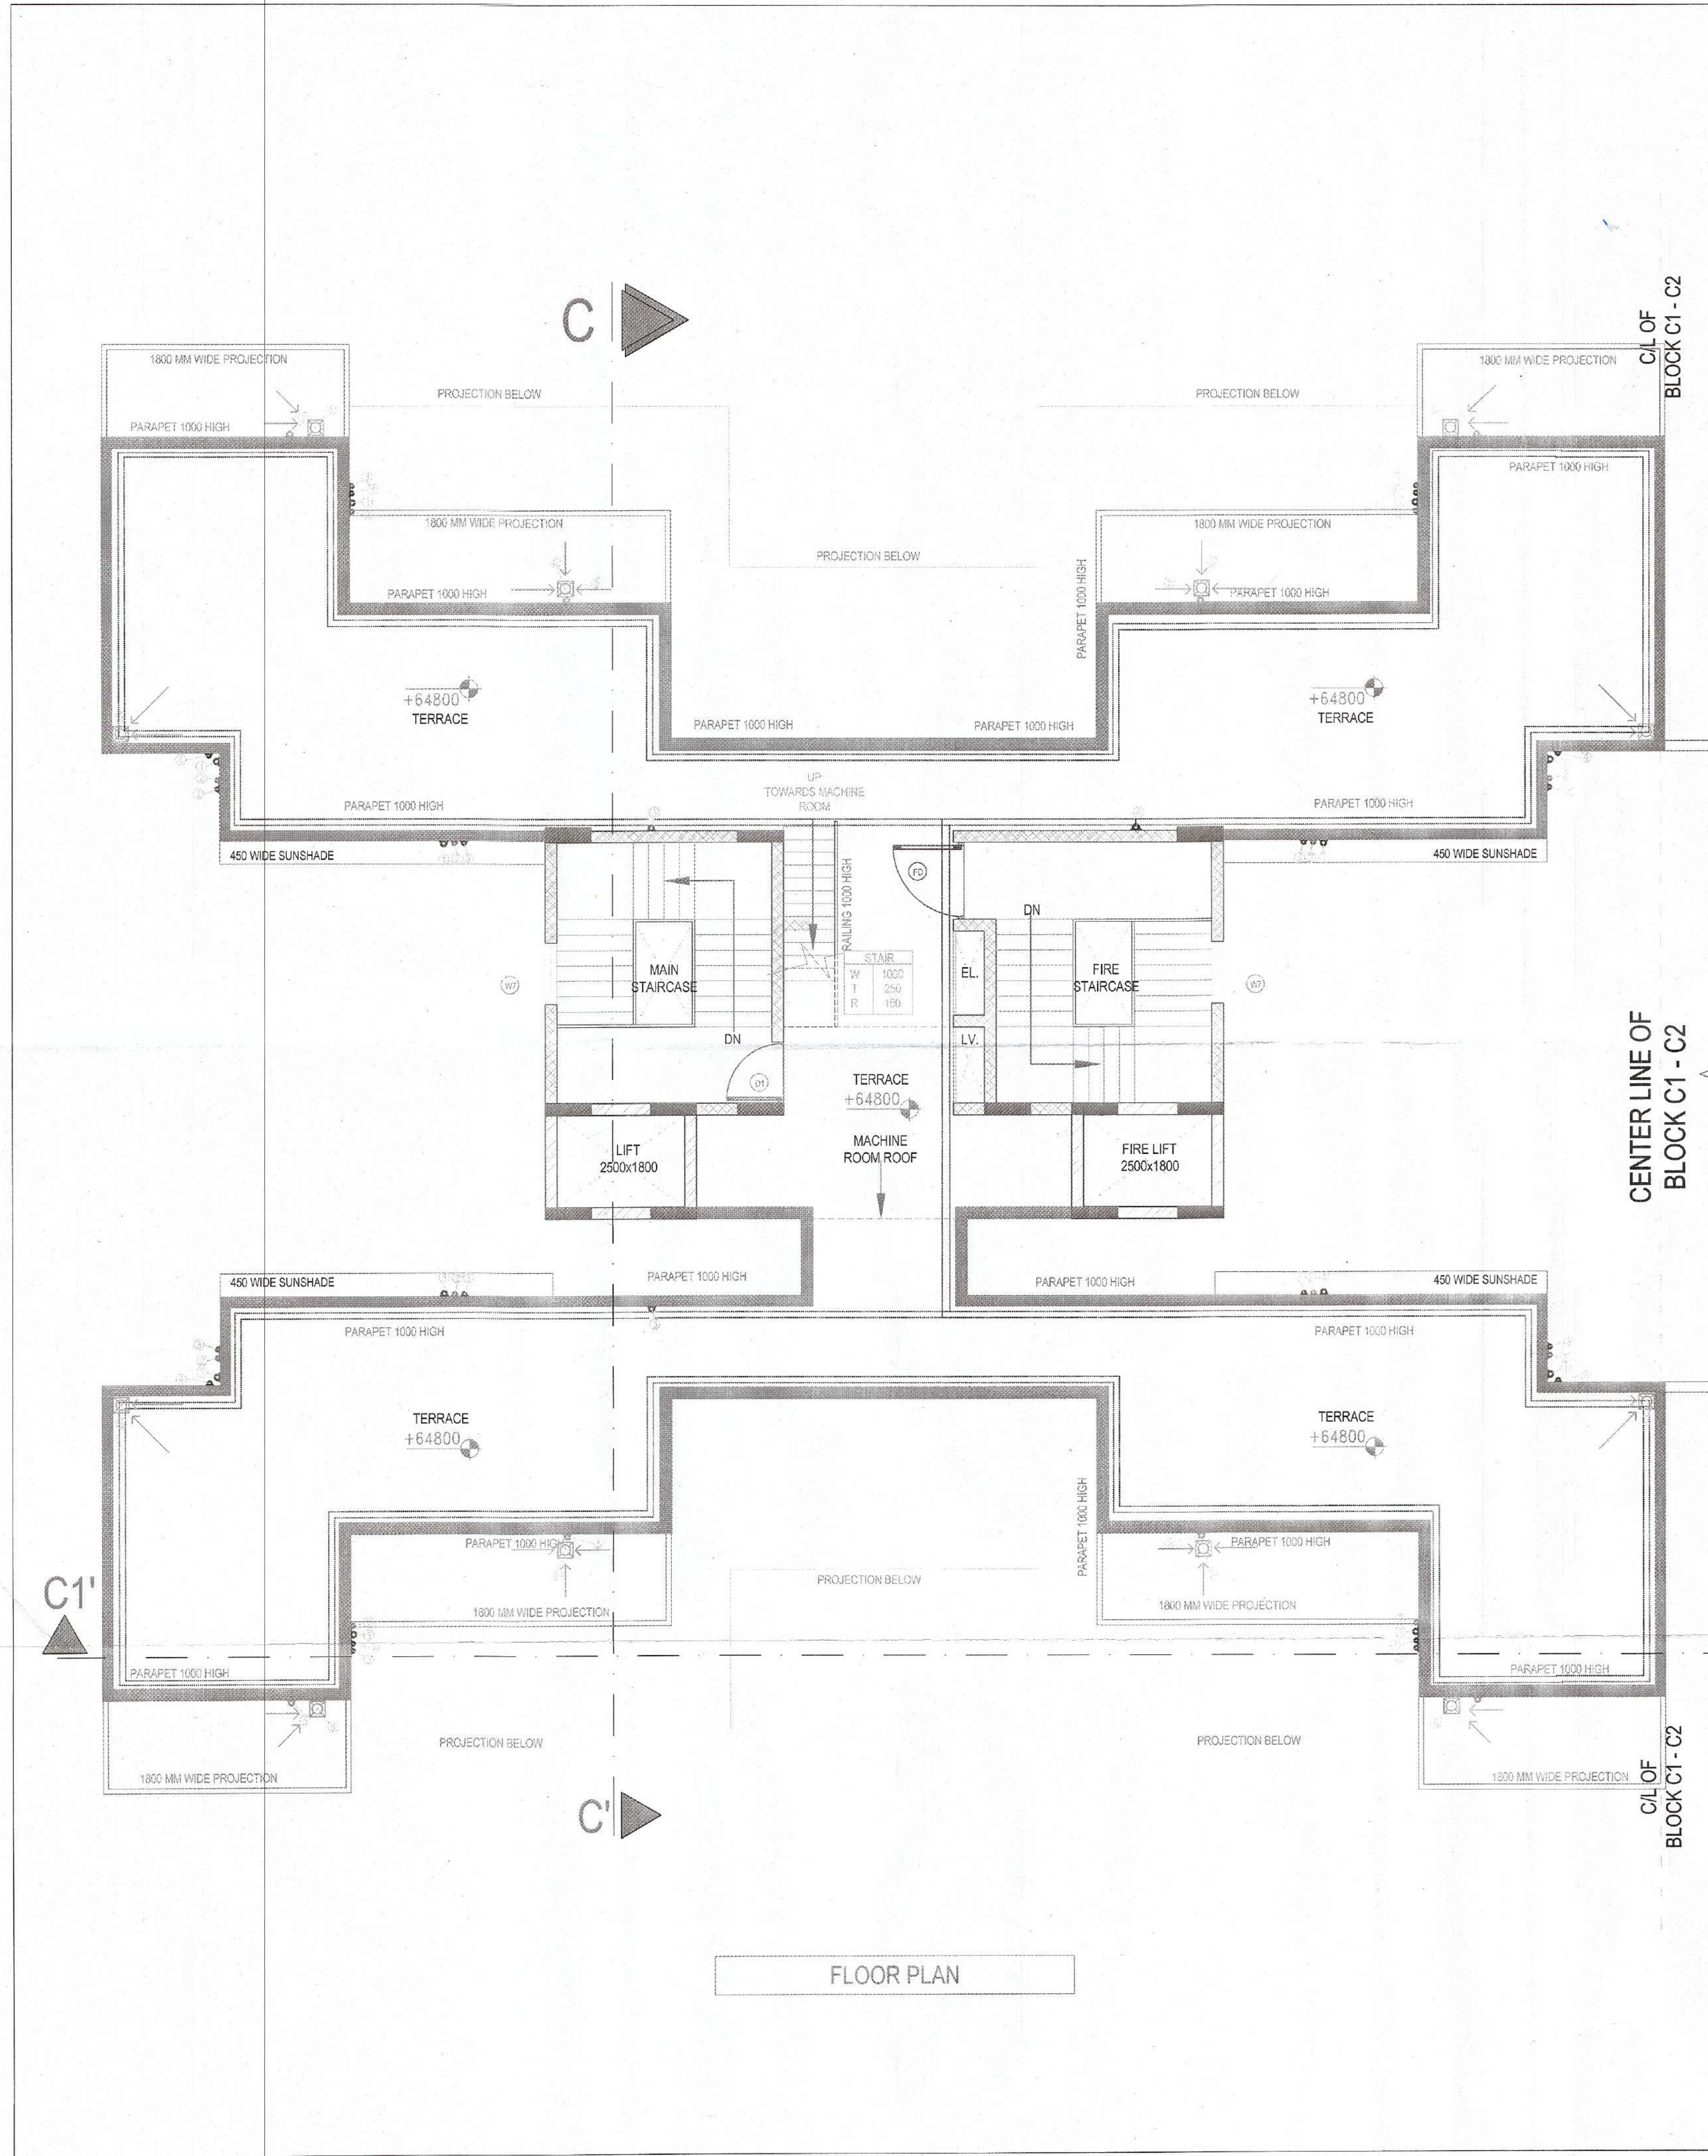

EXTENSION TOWER C2

40Ø DOMESTIC WATER RISER FROM U.G.T

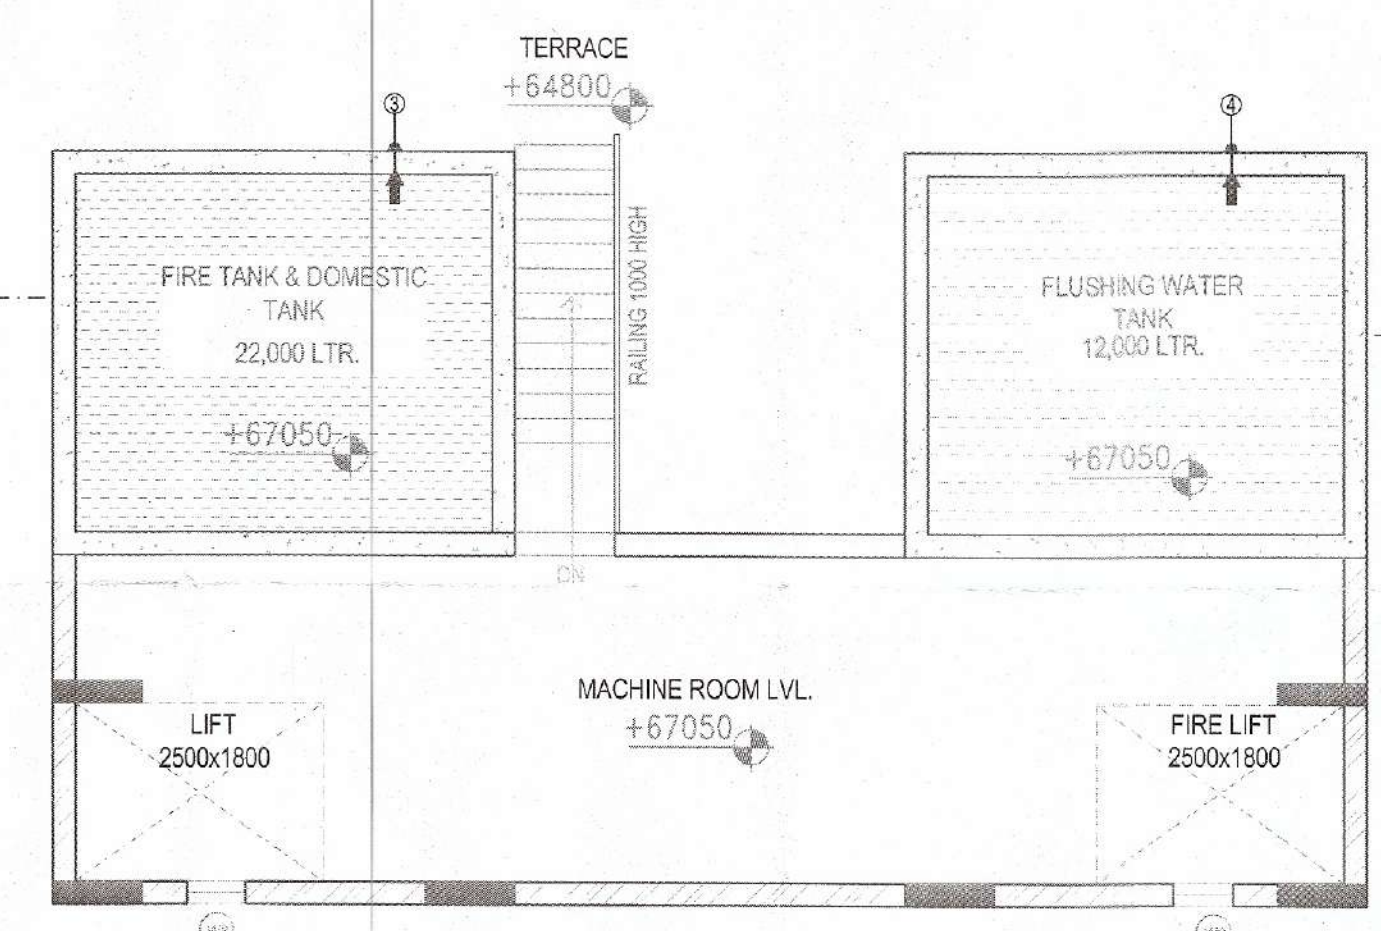

FLOOR PLAN	
TOWER	C1/C2
FLOOR	TANK & MACHINE ROOM FLOOR LVL.



BUILT-UP AREA DIAGRAM	
TOWER	C1/C2
FLOOR	TANK & MACHINE ROOM ROOF LVL.

PLUMBING LEGEND:-

①	110 ØØ UPVC SOIL PIPE
②	110 ØØ UPVC WASTE PIPE
③	35Ø CPVC DWS DN TAKE PIPE
④	35Ø CPVC FWS DN TAKE PIPE
⑤	150 ØØ UPVC RAIN WATER
■	KHURRA 450x450mm
—	40Ø DWS RISER PIPE
—	35Ø FWS RISER PIPE
---	110Ø WASTE PIPE
---	110Ø SOIL PIPE
---	110Ø RAIN WATER PIPE
⊗	FT FLOOR TRAP
⊙	FD FLOOR DRAIN
⊙	FCO FLOOR CLEAN OUT
⊙	COP CLEAN OUT PLUG
⊙	CUTOUT SIZE - 150x150mm

1. All plans have been checked and found in order as per Public Health Services point of view.

EE(W/S) GMDA
EE(Diploma) GMDA
EE(N/A Officer) Infra-II GMDA
EE(Civil) GMDA
EE(Mech) GMDA

SANCTIONED
TO BE READ WITH THIS OFFICE
MEMO NO.:
DATED :

NARINDER KUMAR
JD(HQ)

JD.
P.A.
A.T.P.

PROJECT:
PROPOSED BUILDING PLAN OF
GROUP HOUSING COLONY
OVER AN AREA MEASURING
4.1875 ACRES UNDER TOD
POLICY (LICENCE NO 97 OF
2021 DATED 12.11.2021)
IN SECTOR 103, GURUGRAM.
DEVELOPED BY SUNITA KUMARI
W/o SH.ASHOK KUMAR &
OTHERS IN COLLABORATION
WITH M/s AVIANA GREEN
ESTATES PVT. LTD.

SHEET TITLE:
TOWER - C1/C2
TERRACE LAYOUT
PLUMBING PLAN

MEP CONSULTANT:
V.S. KUKREJA & ASSOCIATES PVT. LTD.
CONSULTING ENGINEERS
190-A GAUTAM NAGAR
NEW DELHI-110049 PH:26921075/76
EMAIL:info@vskukreja.com

ARCHITECT:
ARCHITECTURAL CONSULTANTS
AE STUDIO
an architectural design studio
A-4, GREEN PARK EXT.
NEW DELHI-110016 Ph: 011 47560369
E-MAIL: info@aesstudio.in Web: www.aesstudio.in

DATE SEPTEMBER 2022
SCALE 1:100
NORTH 35 SHEET SIZE A2

CLIENT SIGNATURE
For AVIANA GREENESTATES PVT. LTD.
Director
ARCHITECT SIGNATURE
Sandeep Tandon
Architect
CA/97/21634