


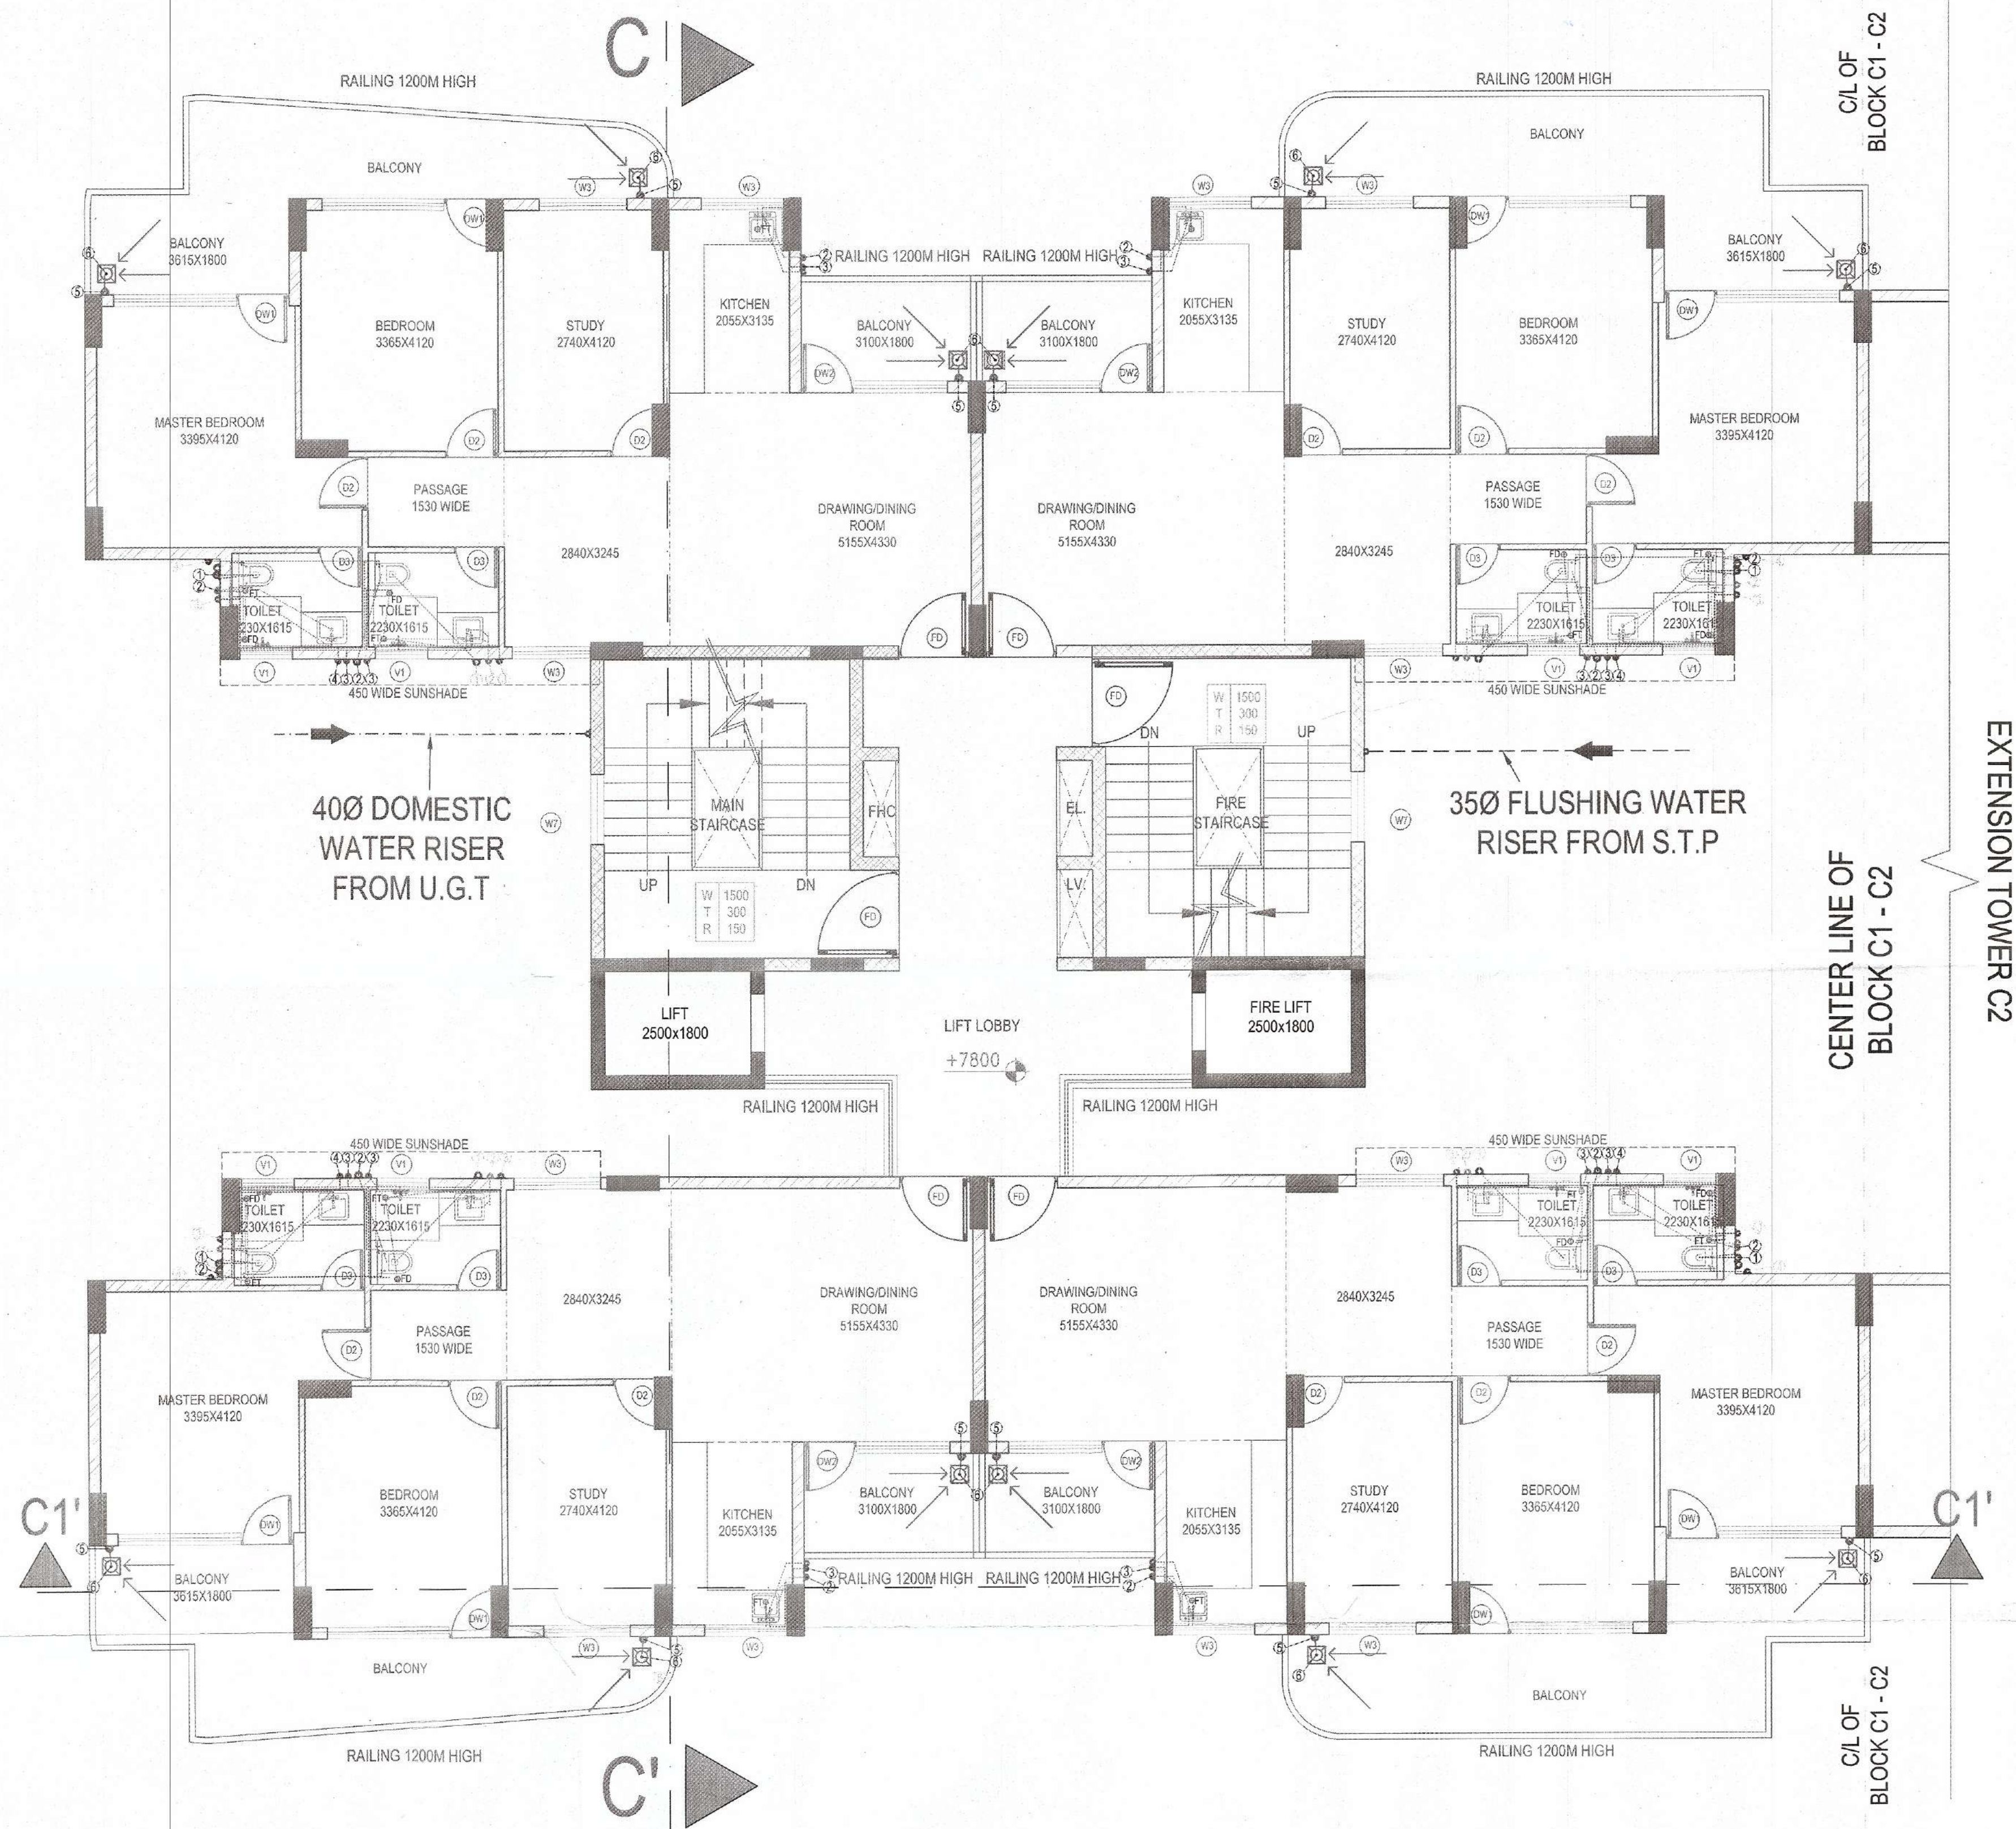

FLOOR PLAN	
TOWER	C1/C2
FLOOR	2ND-18TH (TYPICAL)

Plans have been checked and found in order as per Public Health Services point of view.

EE(WS) GMDA
EE(Drainage) GMDA
EE(Nodal Officer) Infra-II, GMDA
EE(Infra-II) GMDA

PLUMBING LEGEND:-	
①	110 ØD UPVC SOIL PIPE
②	110 ØD UPVC WASTE PIPE
③	35Ø CPVC DWS DN.TAKE PIPE
④	35Ø CPVC FWS DN.TAKE PIPE
⑤	150 ØD UPVC RAIN WATER
⑥	KHURRA 450x450mm
⑦	40Ø DWS RISER PIPE
⑧	35Ø FWS RISER PIPE
⑨	110Ø WASTE PIPE
⑩	110Ø SOIL PIPE
⑪	110Ø RAIN WATER PIPE
⑫	FLOOR TRAP
⑬	FLOOR DRAIN
⑭	FLOOR CLEAN OUT
⑮	FLOOR CLEAN OUT PLUG
⑯	CUTOUT SIZE-150x150mm

Member B.P.A.C.
Member B.P.A.C.
Member B.P.A.C.
Member B.P.A.C.

ATP(HQ)
NARINDER KUMAR JD(HQ)

JD.
P.A.
A.T.P.

SANCTIONED
TO BE READ WITH THIS OFFICE
MEMO NO.:
DATED :

PROJECT:
PROPOSED BUILDING PLAN OF
GROUP HOUSING COLONY
OVER AN AREA MEASURING
4.1875 ACRES UNDER TOD
POLICY (LICENCE NO 97 OF
2021 DATED 12.11.2021)
IN SECTOR 103, GURUGRAM.
DEVELOPED BY SUNITA KUMARI
W/o SH.ASHOK KUMAR &
OTHERS IN COLLABORATION
WITH M/s AVIANA GREEN
ESTATES PVT. LTD.

SHEET TITLE:
TOWER - C1/C2
TYPICAL FLOOR PLAN
PLUMBING LAYOUT

MEP CONSULTANT:
V.S. KURUJA & ASSOCIATES PVT. LTD.
CONSULTING ENGINEERS
105-A, GAUTAM NAGAR
NEW DELHI-110049 PH:28521075/76
EMAIL: info@vskurujas.com

ARCHITECT:
ARCHITECTS AND DESIGNERS
AE STUDIO
an architectural design studio

A-4, GREEN PARK EXT.
NEW DELHI-110016 PH:011-4782039
E-Mail: info@aesstudio.in, Web: www.aesstudio.in

DATE SEPTEMBER 2022

SCALE 1:100

NORTH

34 SHEET SIZE A2

CLIENT SIGNATURE

ARCHITECT SIGNATURE

Director

For AVIANA GREENESTATES PVT. LTD.

Sandeep Tandon
Architect
CA/97/21634