



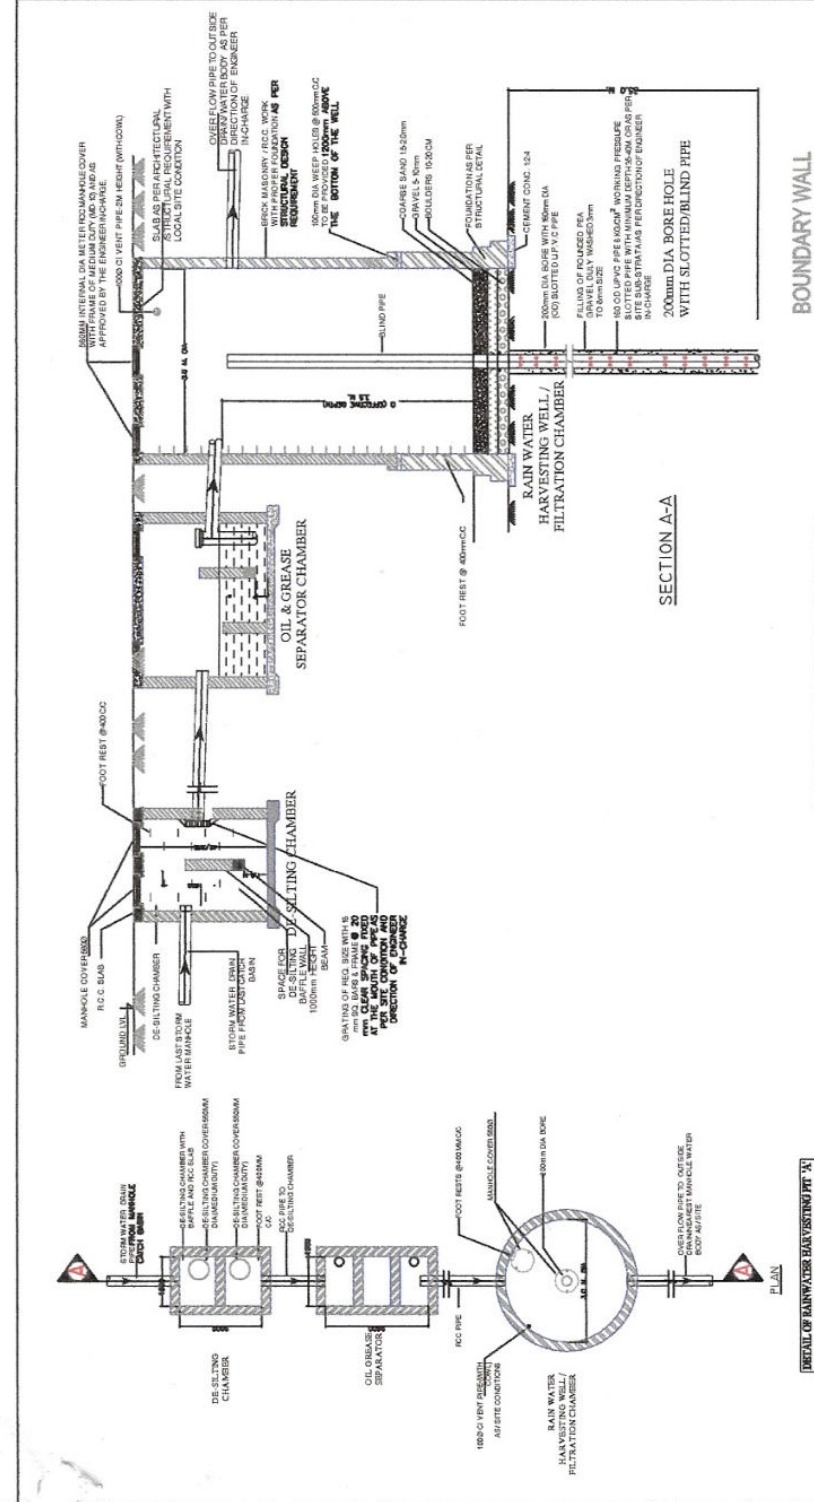


LEGEND :-		STORM WATER	SYMBOL
(1)	4000 RCC STORM WATER PIPE (SLOPE: 1:300)		
(2)	STORM WATER MANHOLE SIZE: (9000 & 12000)		
(3)	RAIN WATER HARVESTING & DE-SILTING CHAMBER		

SIZE OF MANHOLE WITH
REFERENCE TO DEPTH

DEPTH	SIZE OF M.H.
0.90m TO 1.65m	900mm DIA
1.65m TO 2.30m	1200mm DIA
2.30m TO 9.00m	1500mm DIA
9.00m TO 14.00m	1800mm DIA

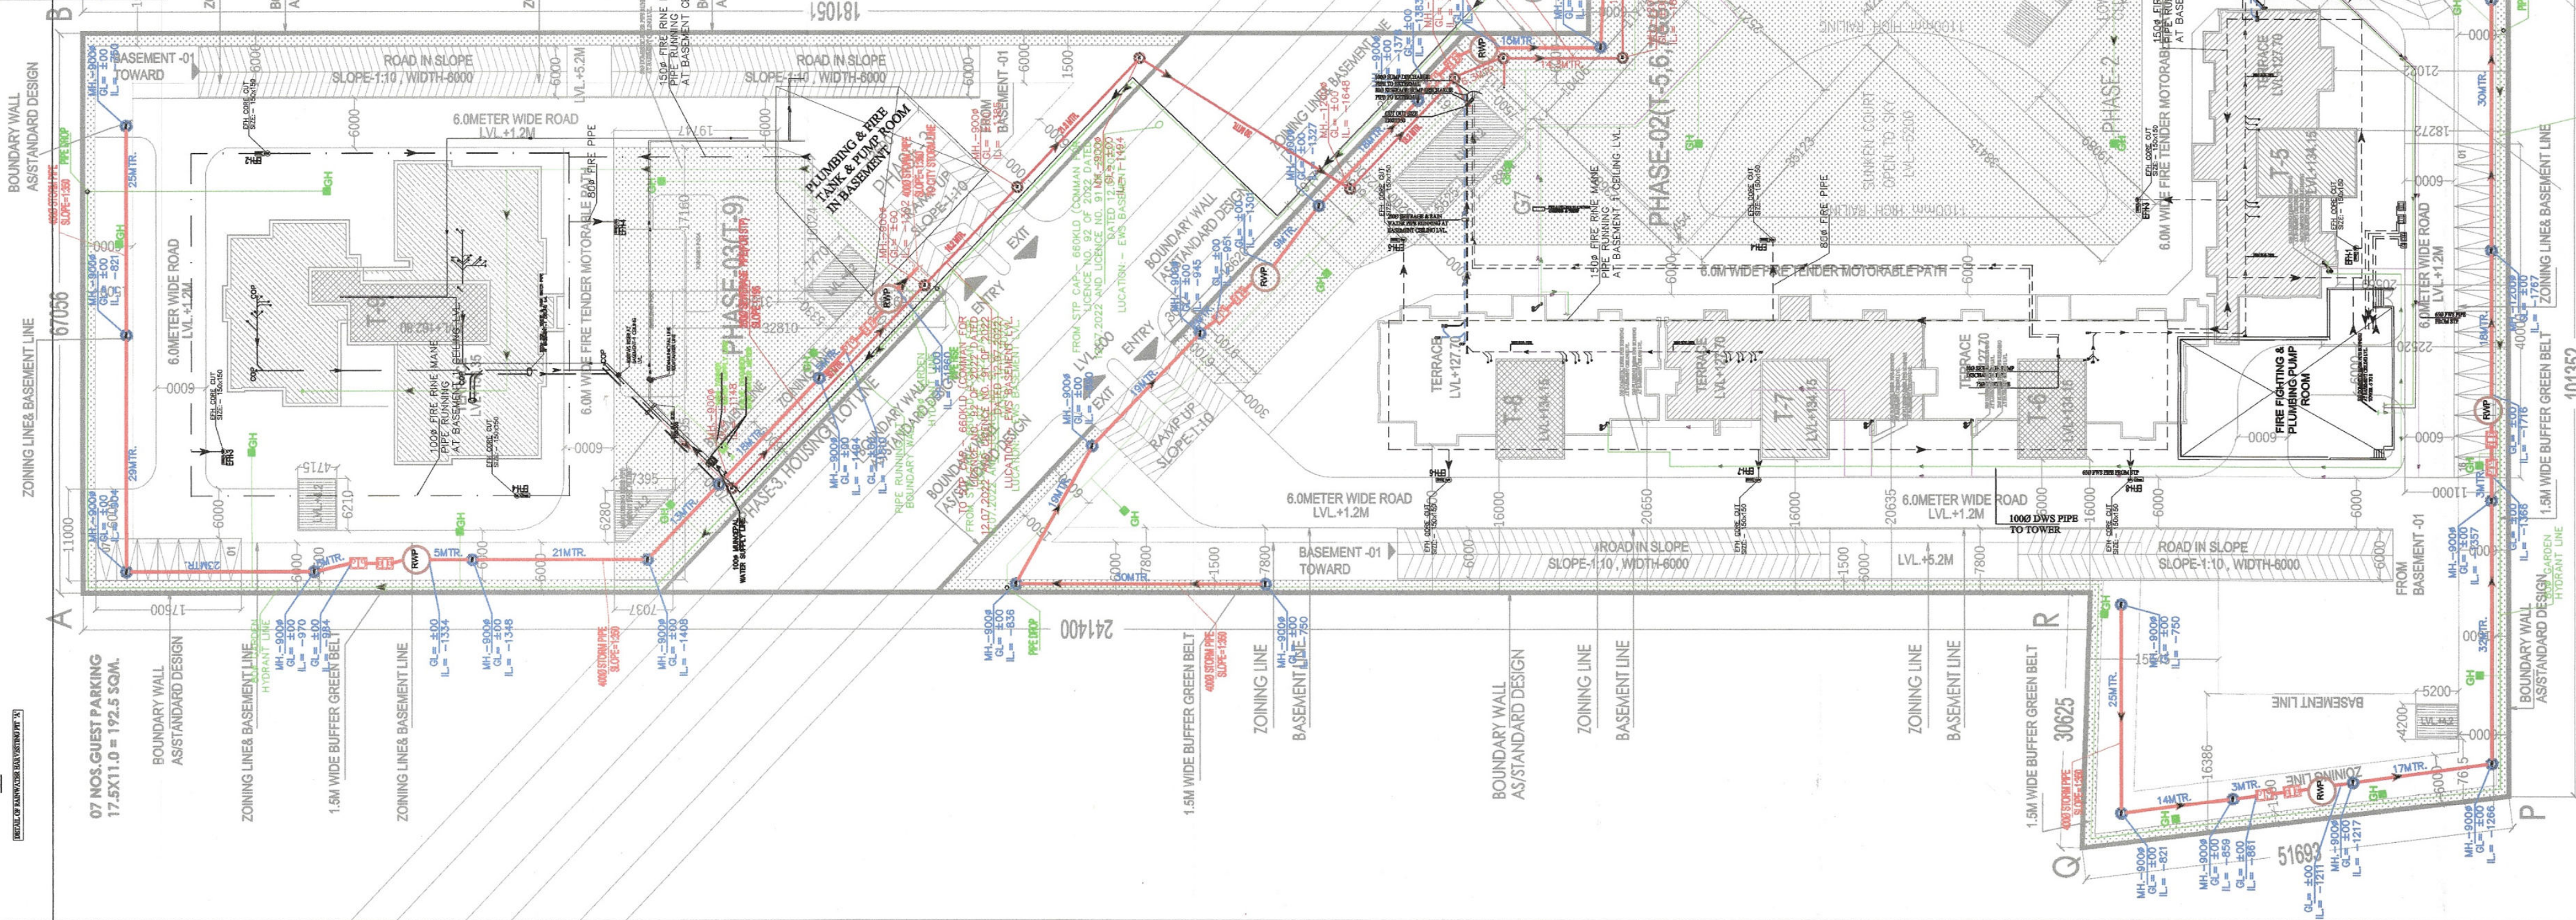

SITE PLAN

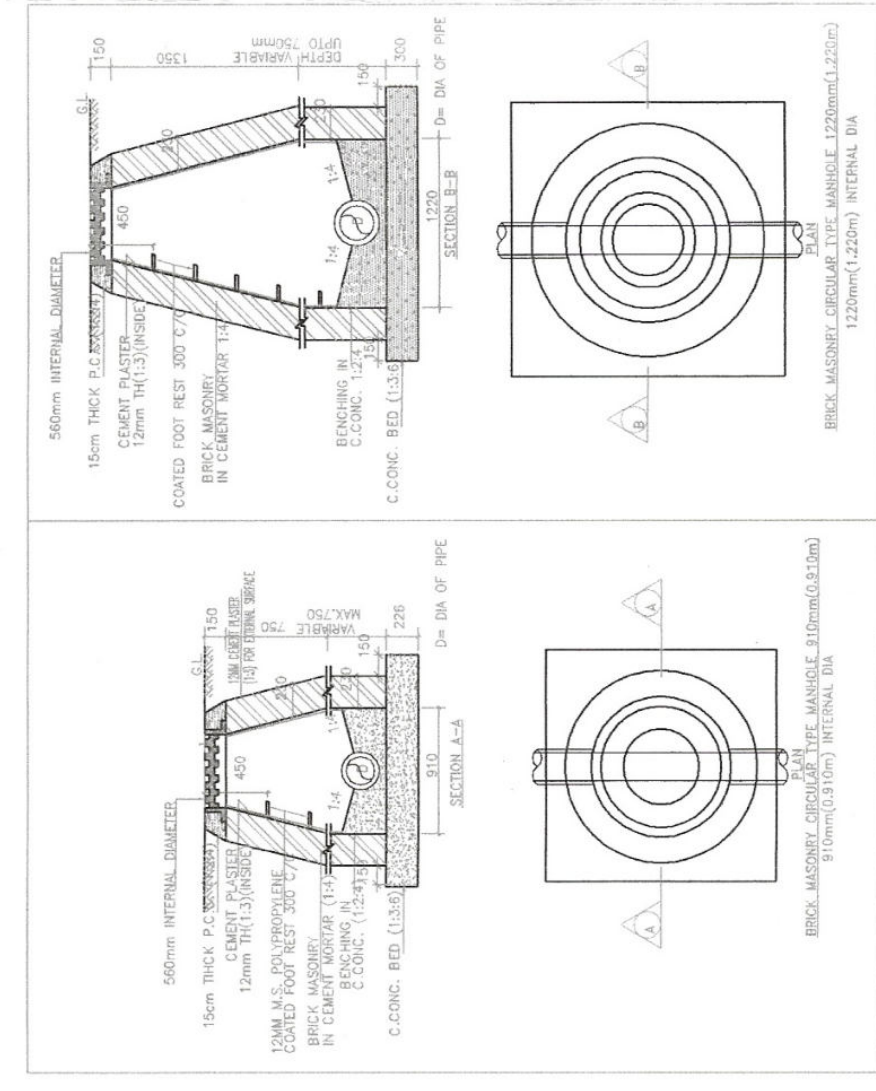

NOTE: ALL DIMENSIONS ARE IN MM

SERVICES CONSULTANTS:
SANELAC
CONSULTANTS PVT LTD.
HEAD OFFICE:
PARAS KUTIR, C-38 A, KALKAJI, NEW DELHI-110019,
TEL: 26435759, 26427616, FAX: 011-26478166,
E-mail: sanelac@vsnl.com
sanelac@airtelbroadband.in
BRANCH OFFICE:
* PUNE

PROJECT:-
PROPOSED BUILDING PLAN OF GROUP
HOUSING AREA MEASURING 5.785 ACRES
UNDER TOD POLICY DATED
09.02.2016 (LICENCE NO. 92 OF 2022
DATED 12.07.2022) AND GROUP HOUSING
COLONY AREA MEASURING 6.175 ACRES
(LICENCE NO. 91 OF 2022 DATED
12.07.2022) IN SECTOR- 76, GURUGRAM
BEING DEVELOPED BY WHITELAND
CORPORATION PVT.LTD

ARCHITECT :-
VIKAS AHLWAT ARCHITECTS
ARCHITECTURE, INTERIORS, PLANNING
Unit No 303 Niteek Time Center, Suncliff Sector-54 Golf Course Road Gurugram
O - 0124-4284293 M- 0-9899159485 Mail :- ar.vikas.ahlawat@gmail.com



OWNERS SIGNATURE:- **ARCHITECT SIGNATURE:-**

For WhiteLand Corporation Private Limited
At: VIKAS AHLWAT
C4237625293
Authorised Signatory

DRAWING TITLE:
CORDENATED SITE PLAN
SECTOR-1, 2 & 3

DATE:- DEC-2022
SCALE:- 1:550(A1)
SHEET NO. WL-SOPL-BP-PL-PF-SP-001

S.NO.	DESCRIPTION	SYMBOL
1	GARDEN HYDRANT	GH
2	GARDEN HYDRANT LINE	→
3	FLUSHING WATER SUPPLY FOR OHT TANK	→
4	100Ø TANKER LINE	→
5	100Ø MUNCEPAL LINE	→
6	WATER METER	NOW.M

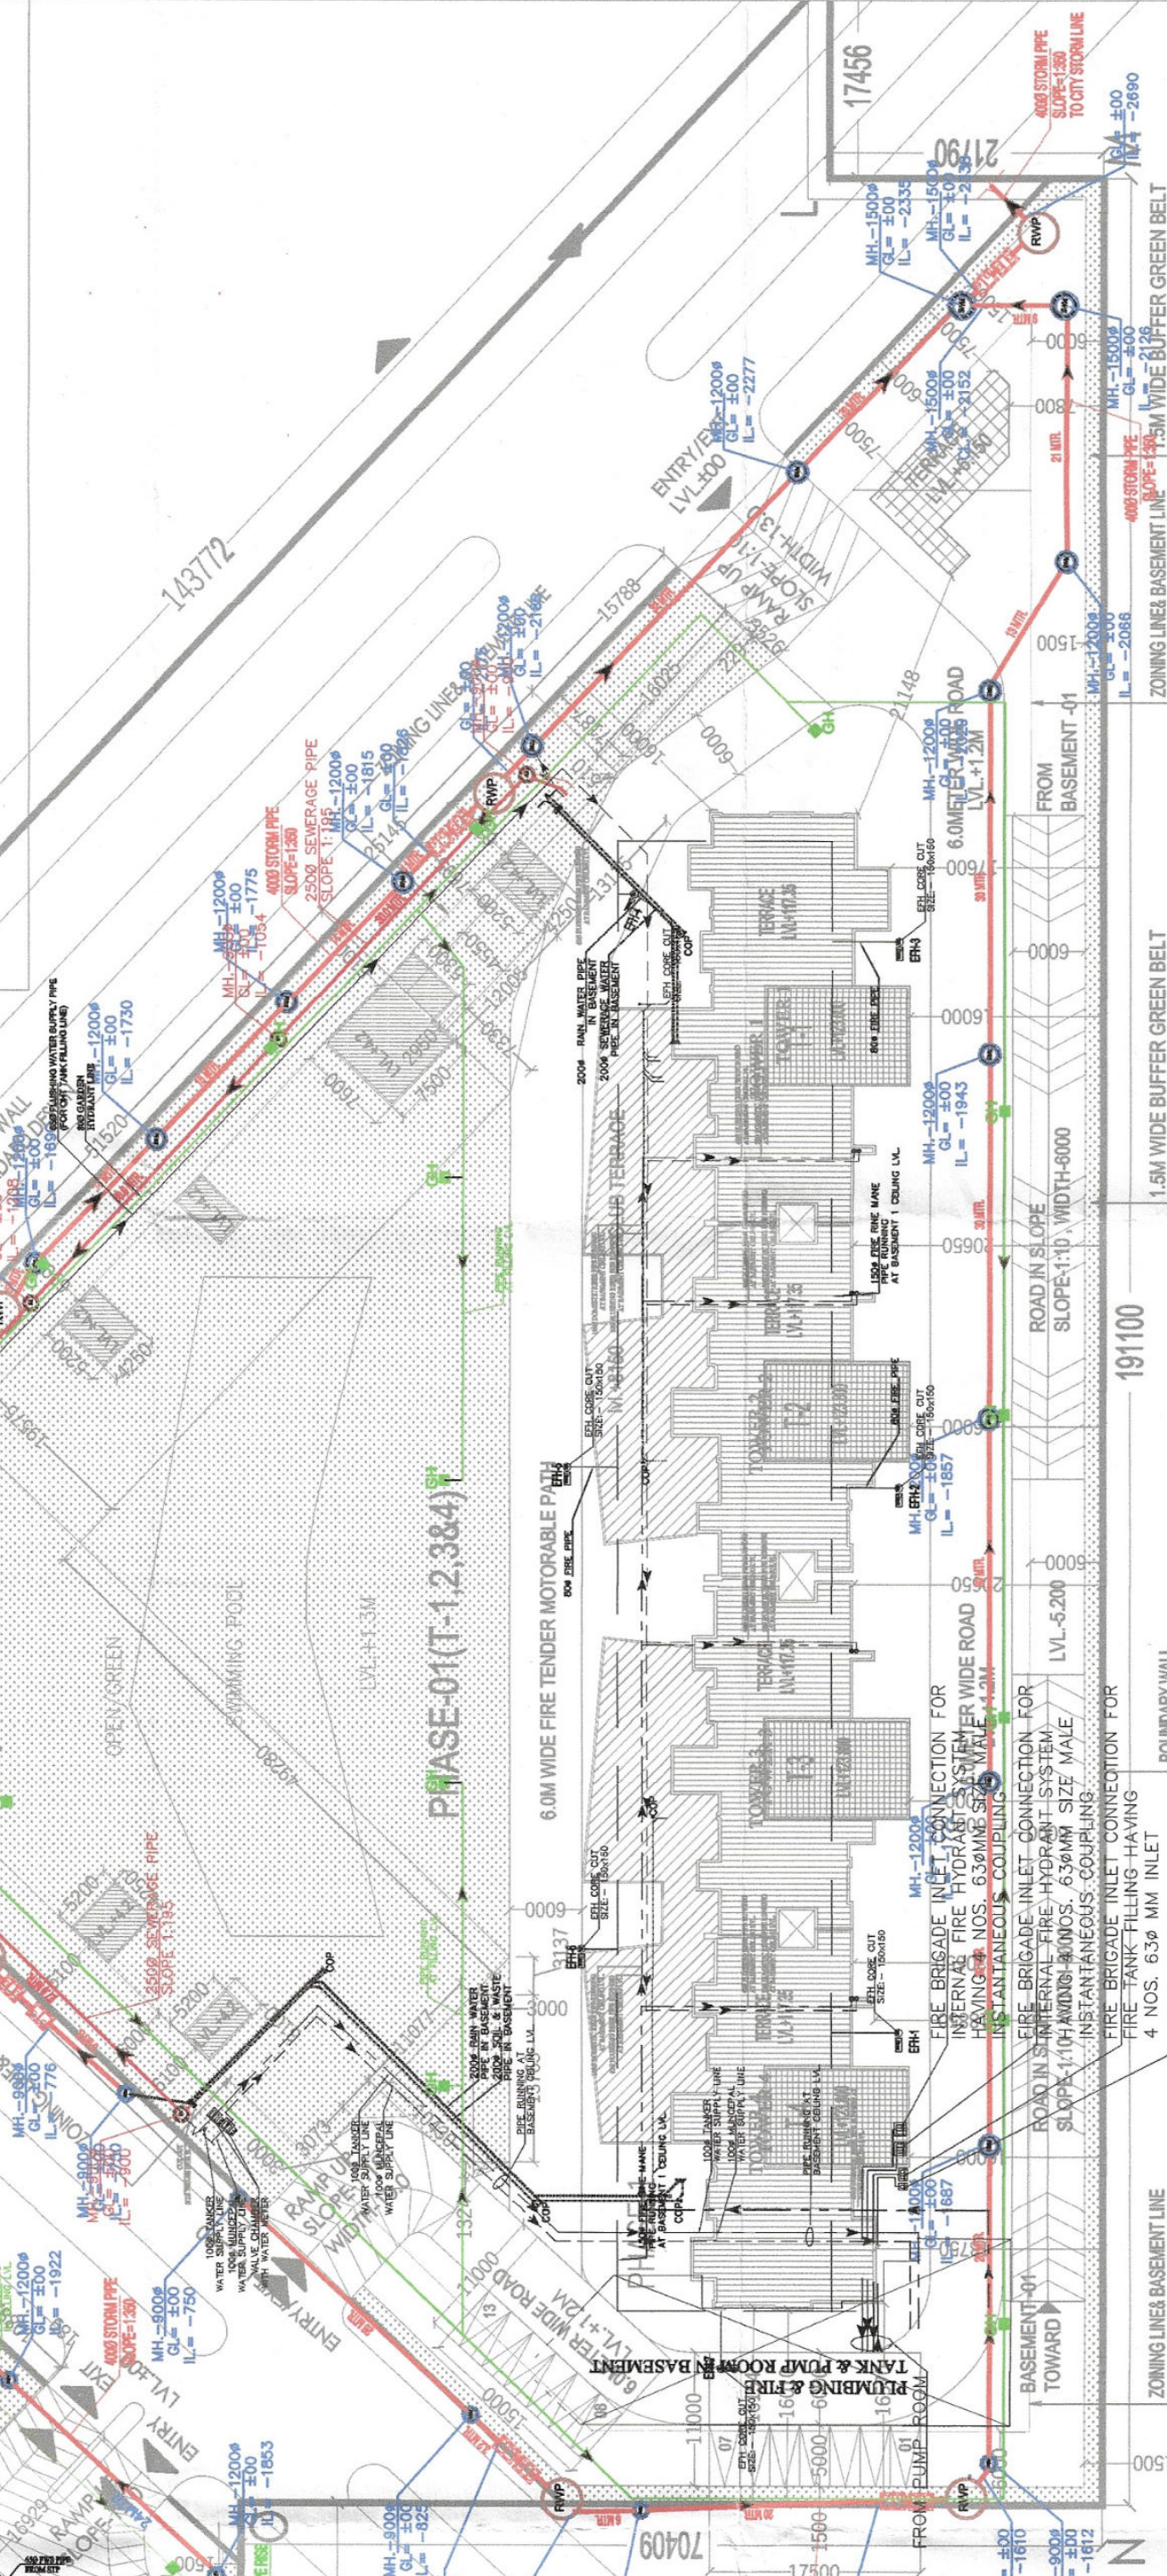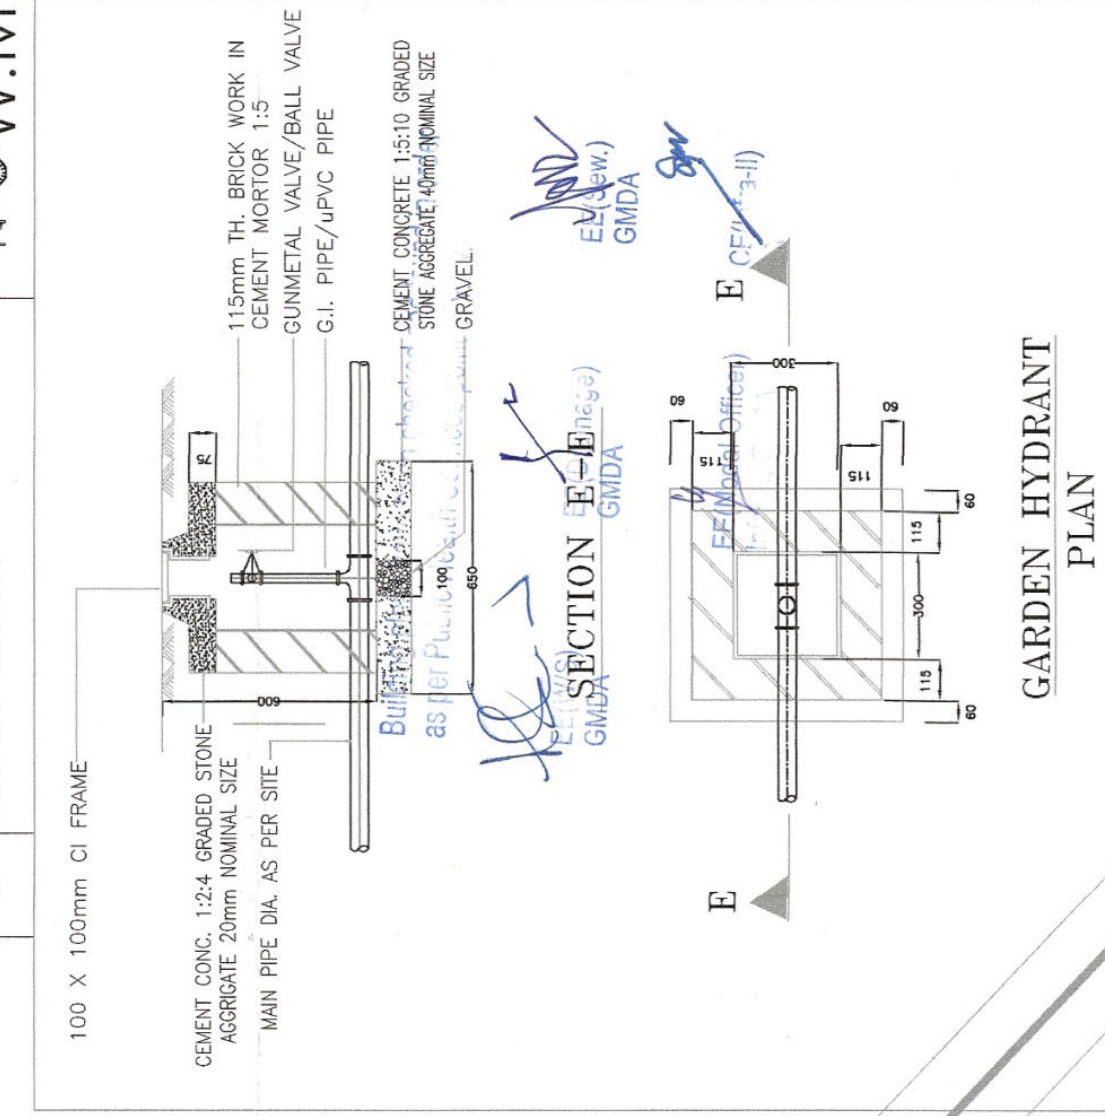

SITE PLAN

Sanctioned
To be read with this office
No. 100/2022
Dated: 10/12/2022

Rajiv Arora Basni
JD(HO)

Sanctioned
To be read with this office
No. 100/2022
Dated: 10/12/2022