
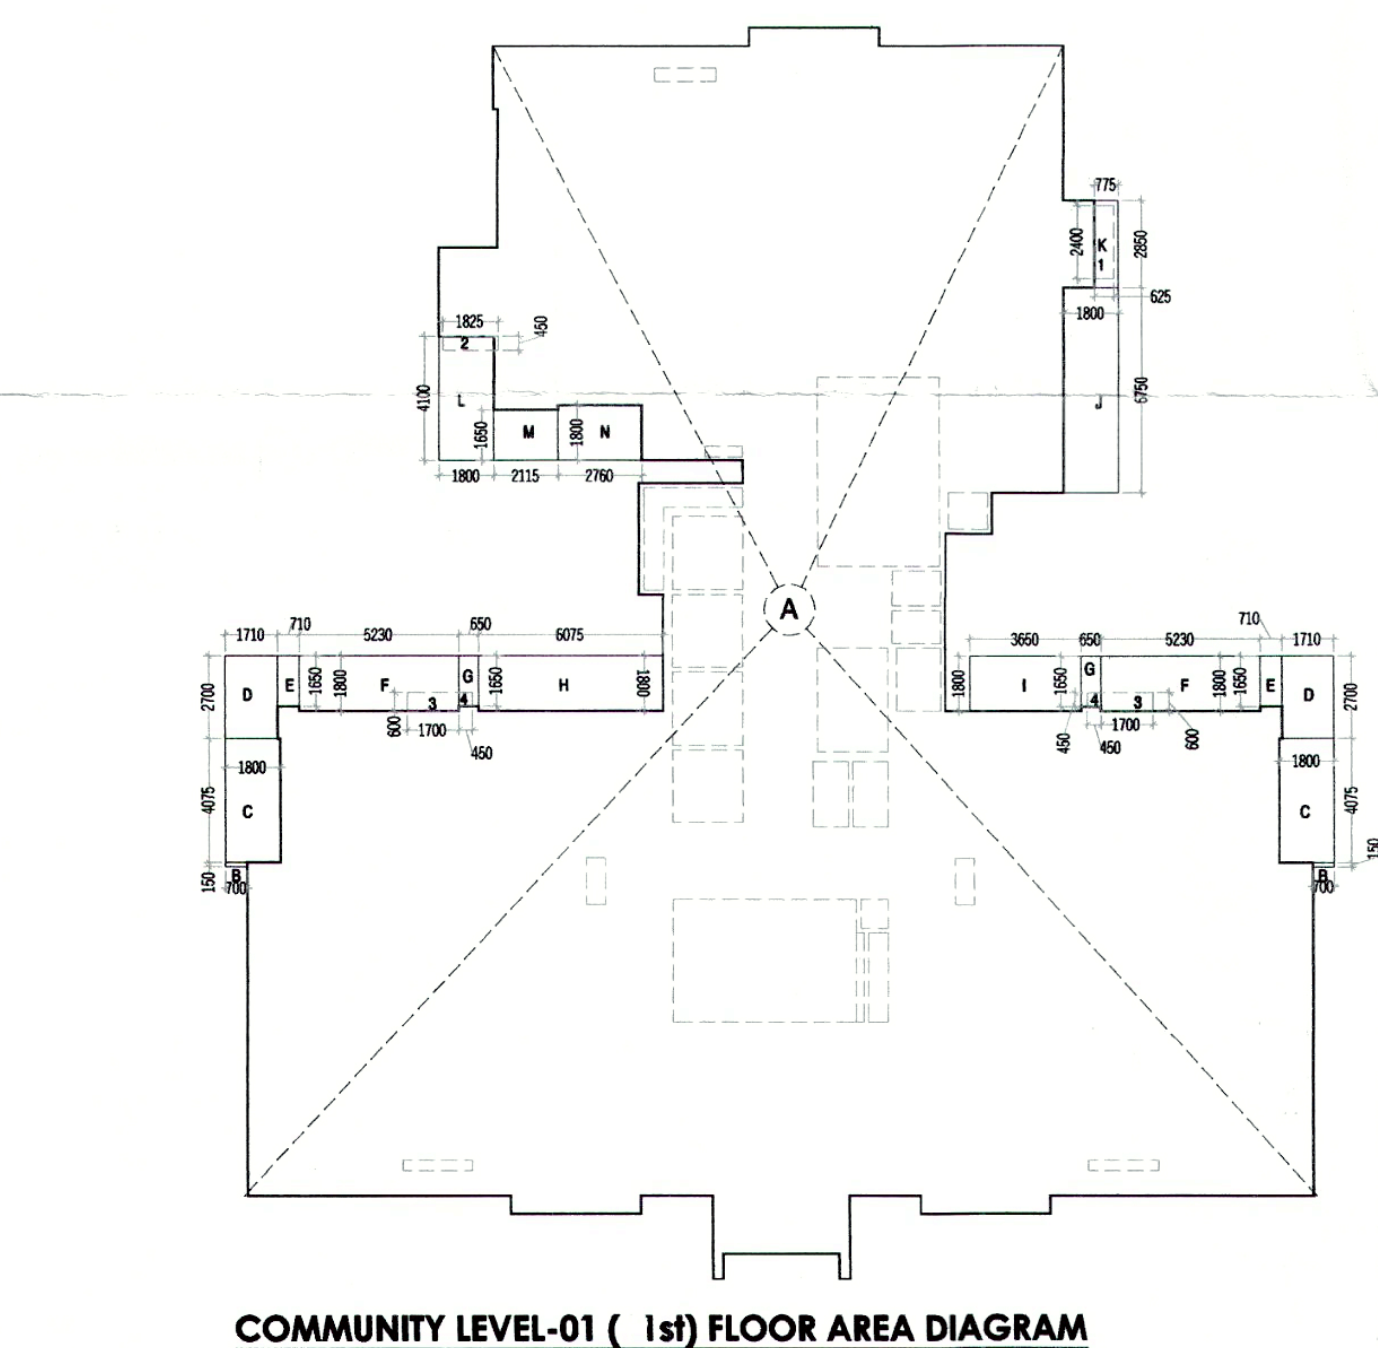
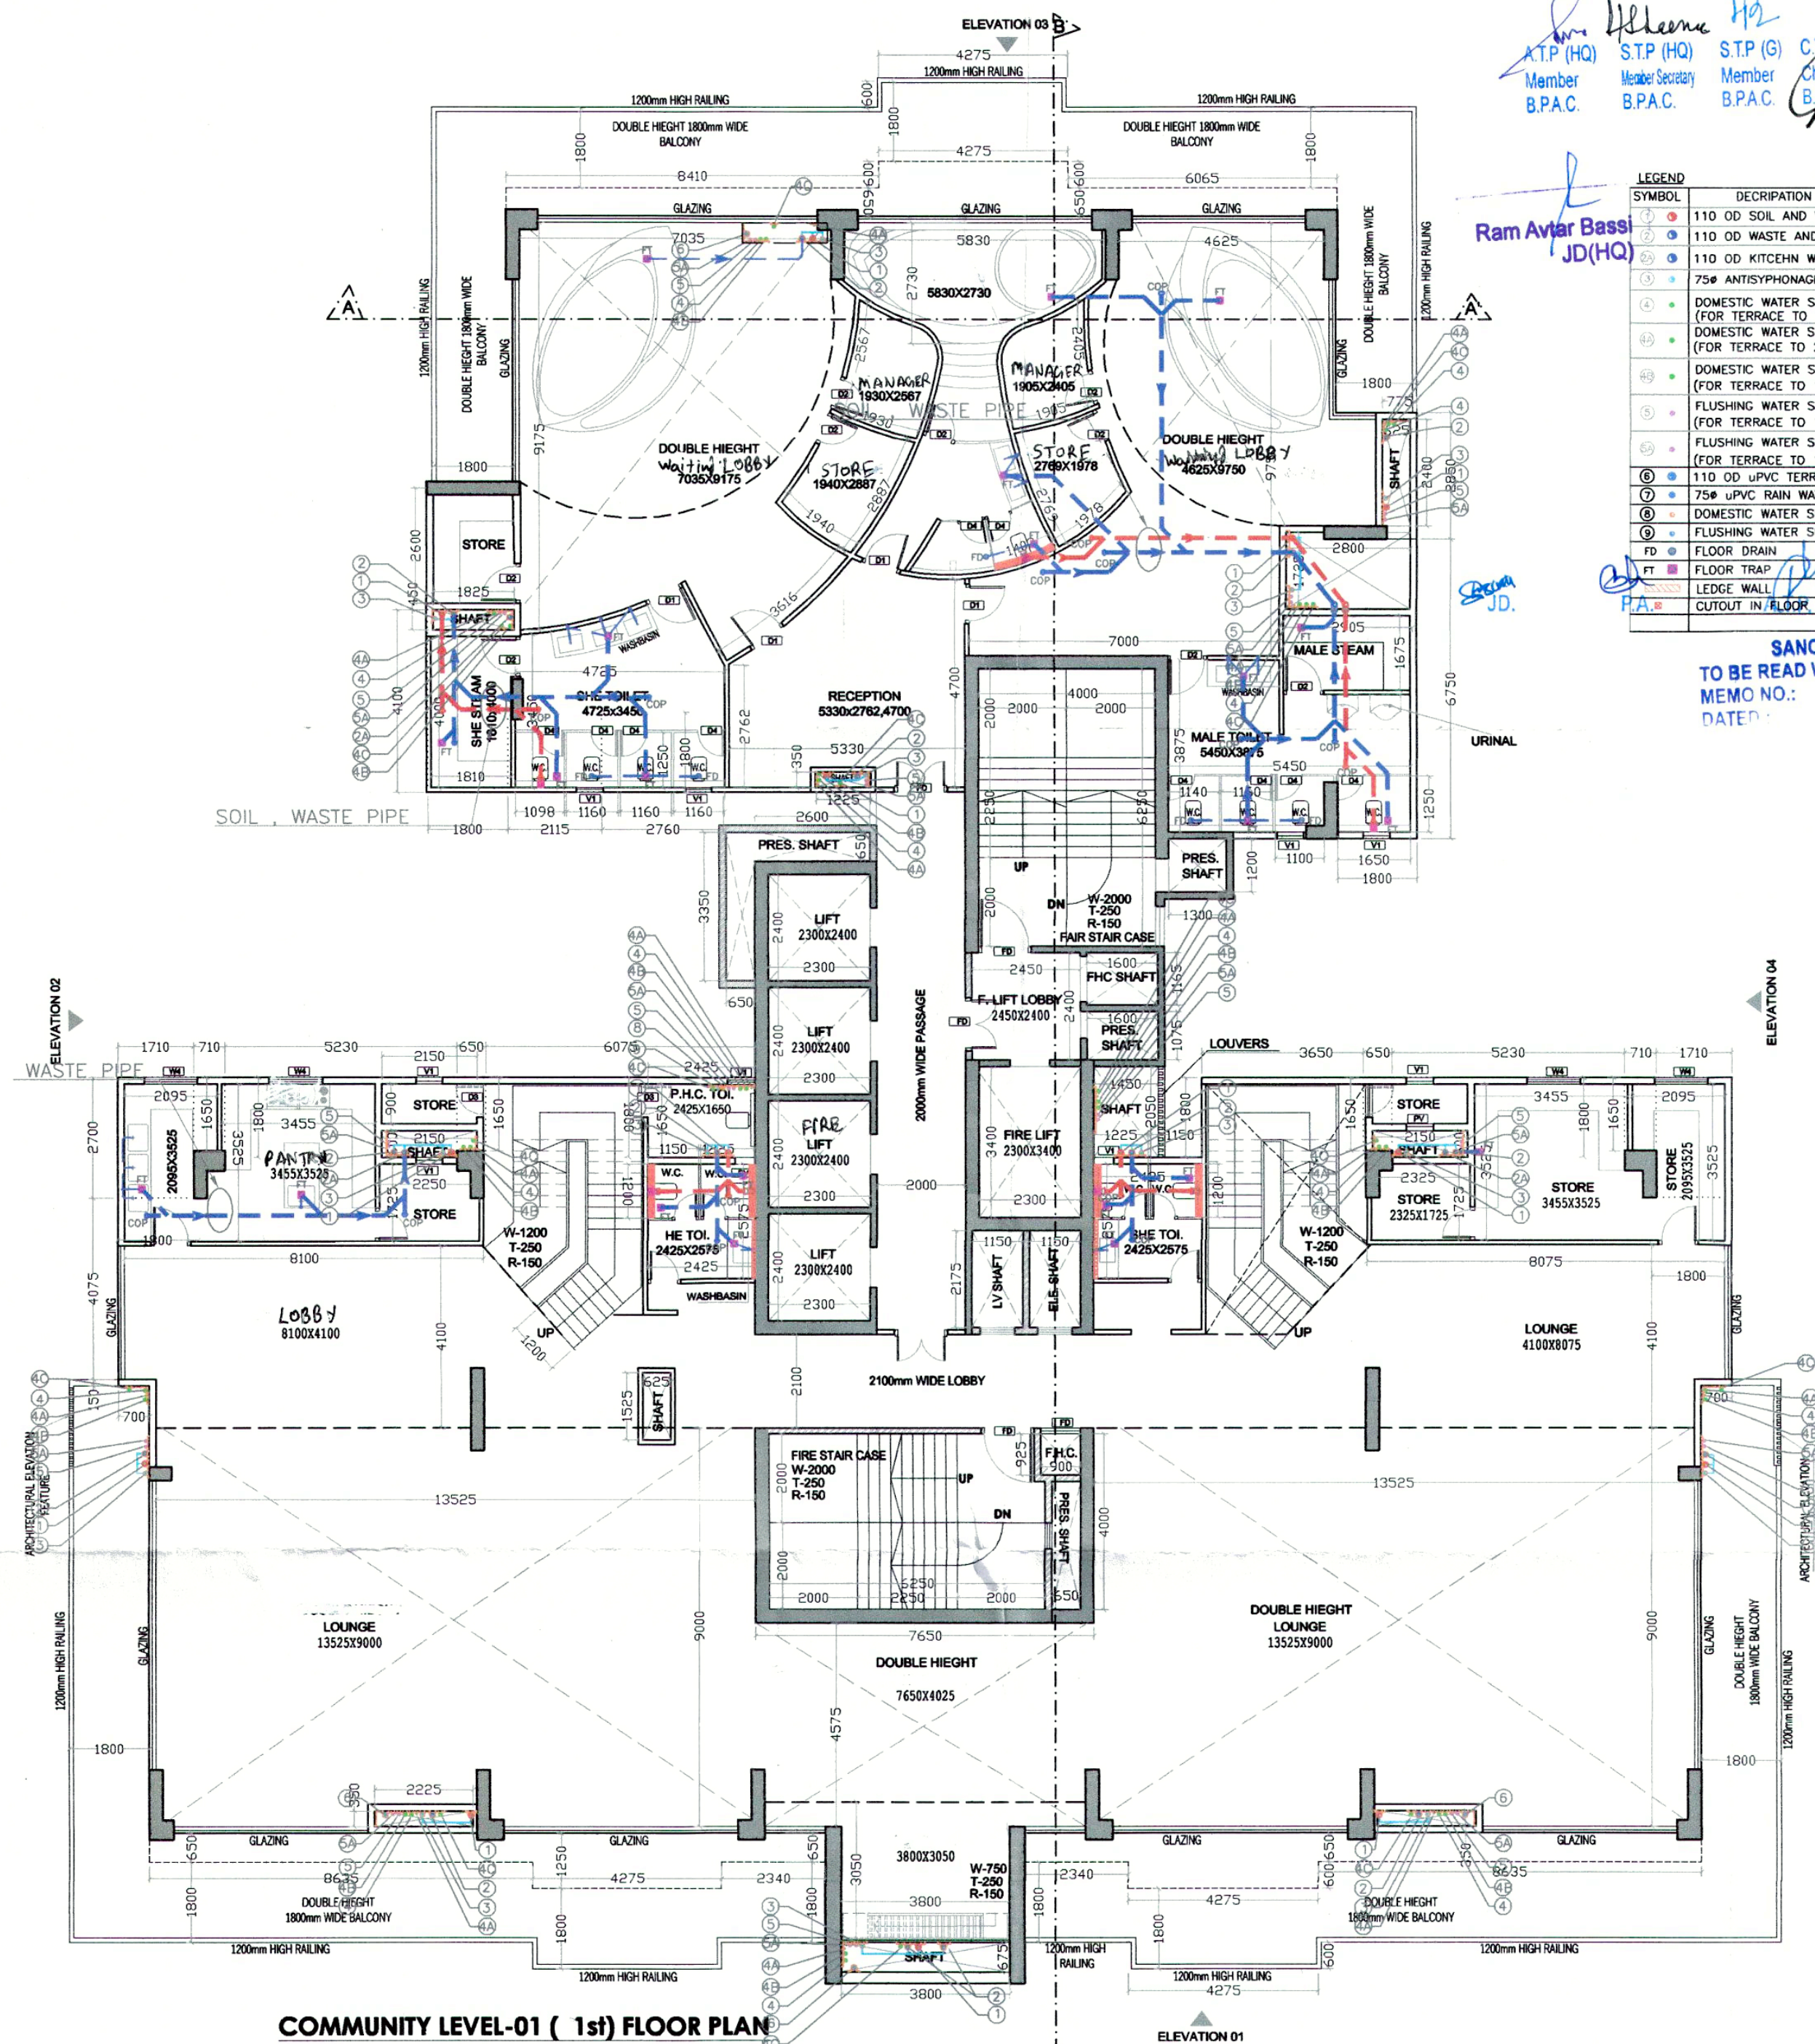


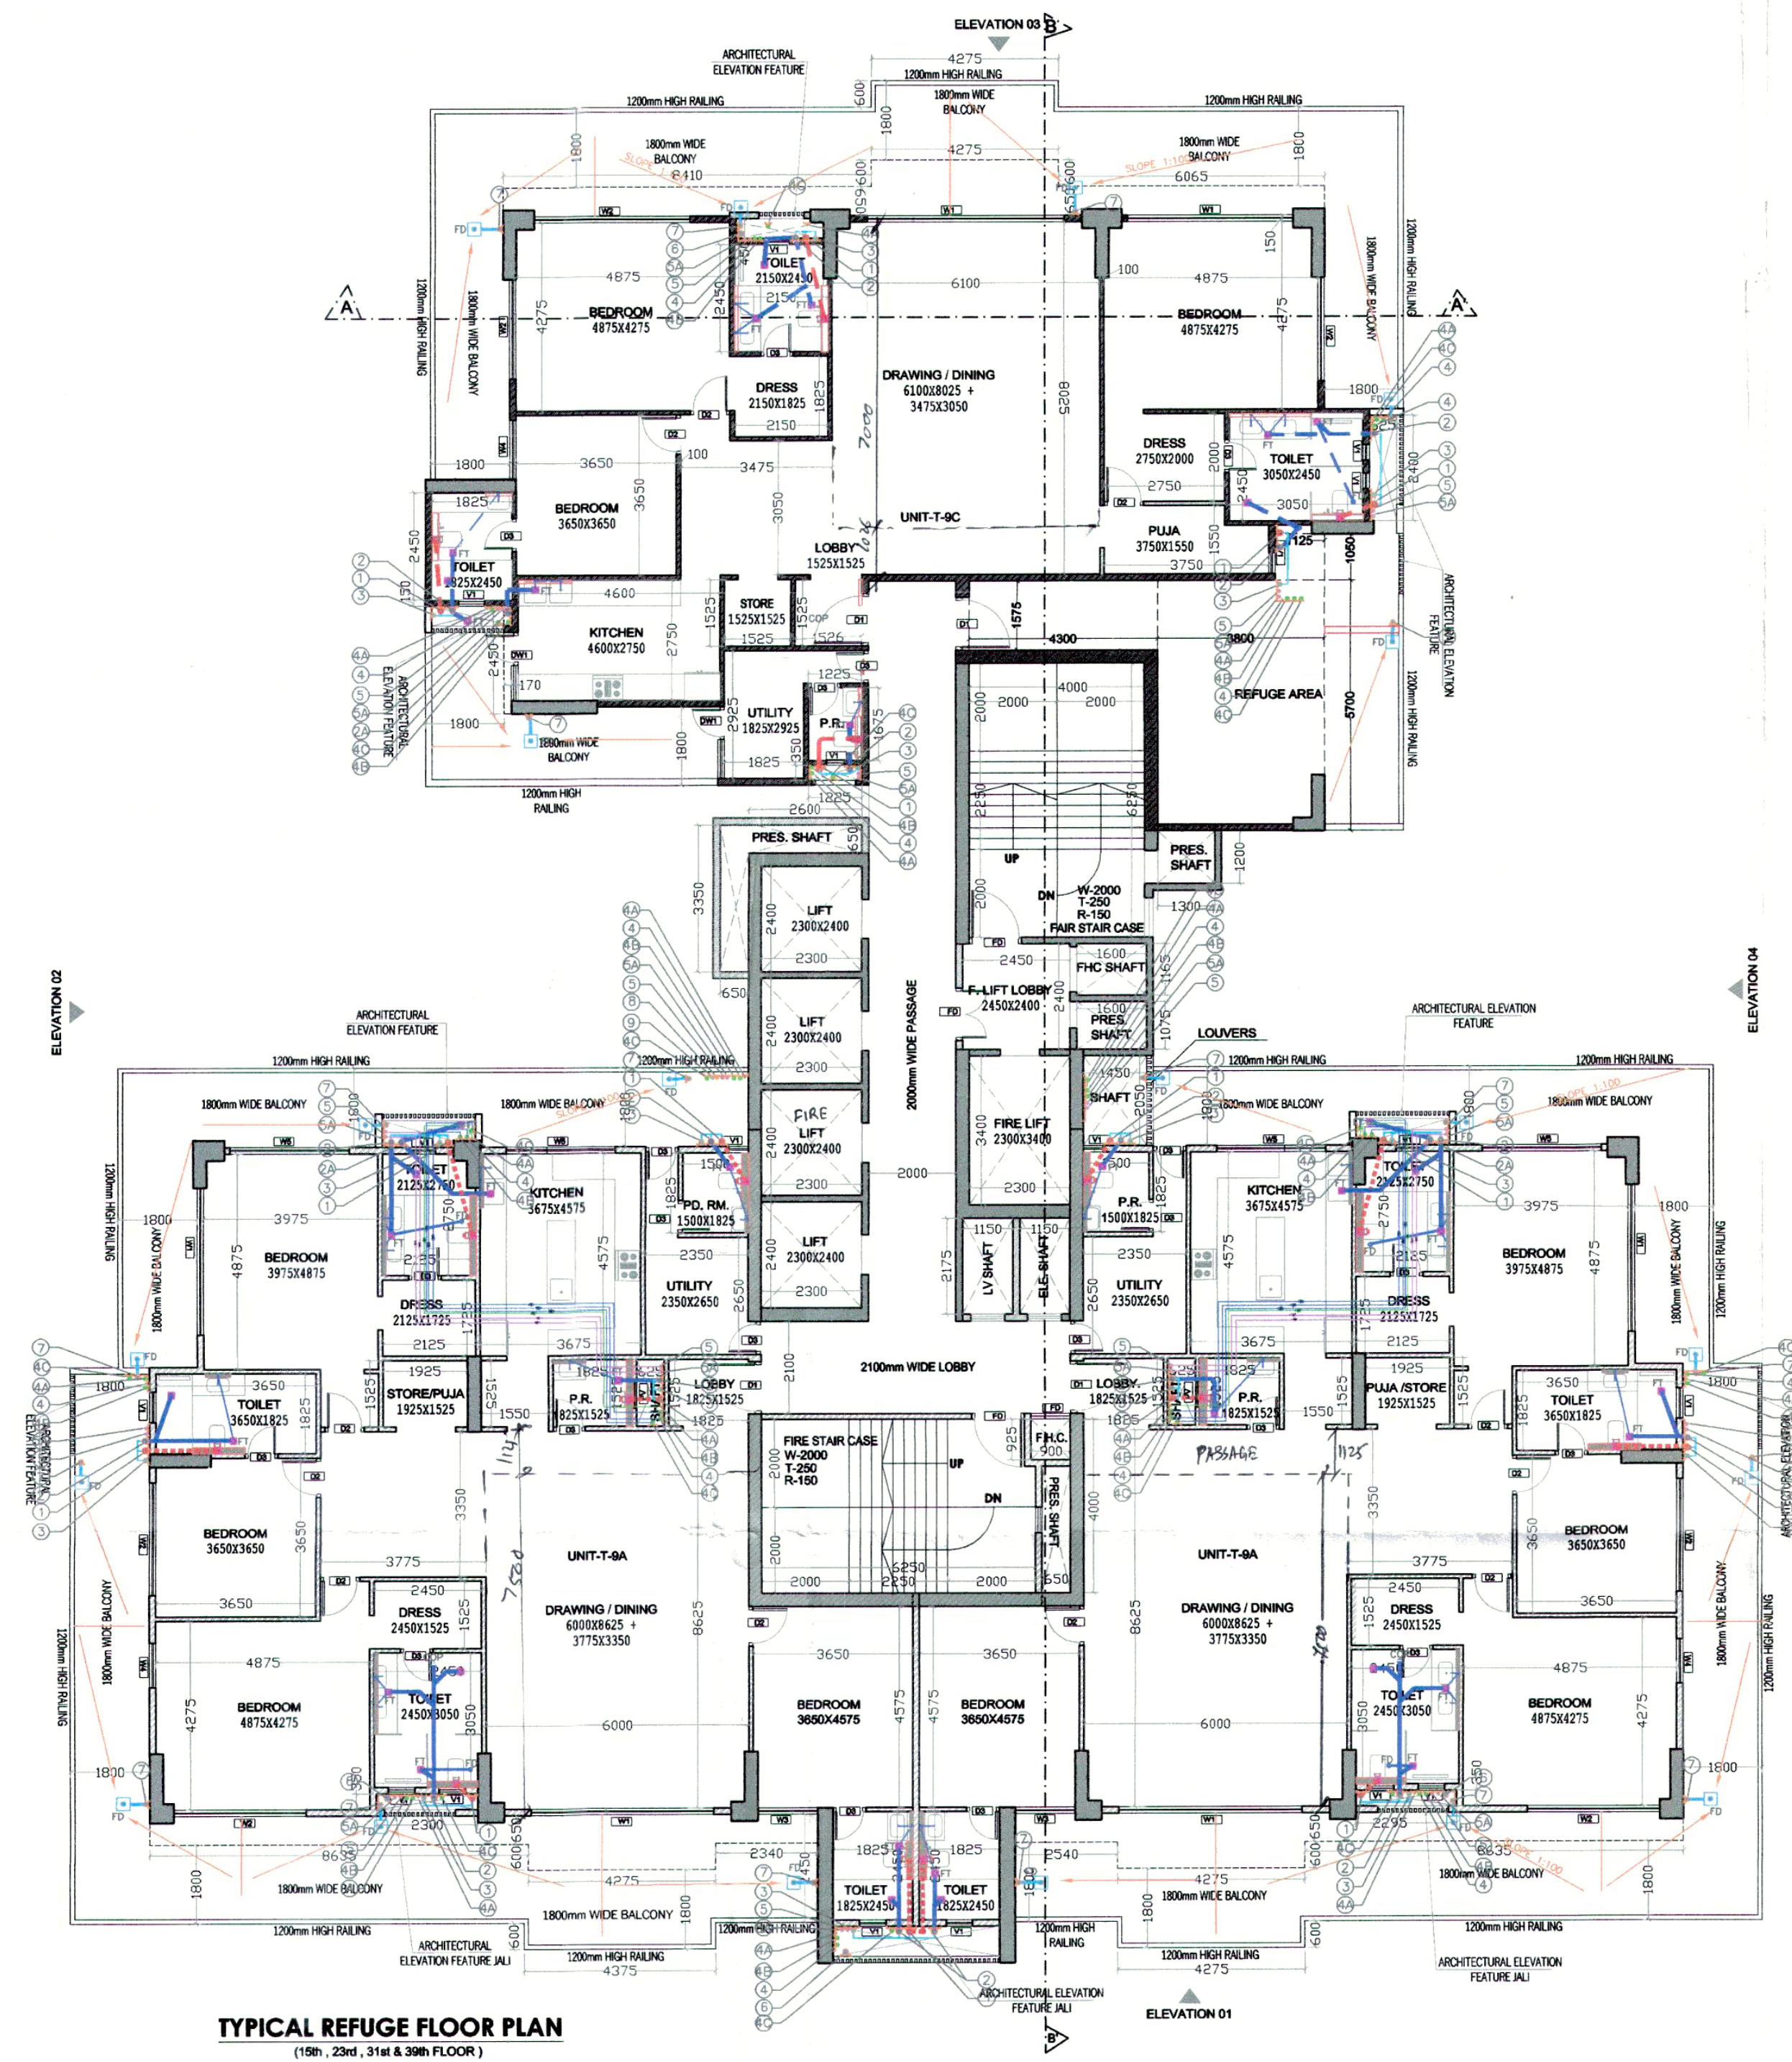

S.N.O.	NO.	PREFIX	BREATH	LENGTH	AREA
TOTAL ADDITION					890.528
TOTAL SUBTRACTIONS					4.766
TOTAL COMMUNITY LEVEL-01 FLOOR AREA					885.762

LEGEND

• 110 OD SOIL AND VENT PIPE
• 110 OD WASTE AND VENT PIPE
• 110 OD KITCHEN WASTE AND VENT PIPE
• 75mm ANTISIPHONAGE PIPE
• DOMESTIC WATER SUPPLY DN. TAKE PIPE (FOR TERRACE TO 1st FLOOR)
• DOMESTIC WATER SUPPLY DN. TAKE PIPE (FOR TERRACE TO 28th FLOOR) PRESSURE SUPPLY
• DOMESTIC WATER SUPPLY DN. TAKE PIPE (FOR TERRACE TO 14th FLOOR)
• FLUSHING WATER SUPPLY DN. TAKE PIPE (FOR TERRACE TO 1st FLOOR)
• FLUSHING WATER SUPPLY DN. TAKE PIPE (FOR TERRACE TO 16th FLOOR)
• 110 OD UPVC TERRACE RAIN WATER PIPE
• 75mm UPVC RAIN WATER PIPE (BALCONY)
• DOMESTIC WATER SUPPLY RISER
• FLUSHING WATER SUPPLY RISER
• FLOOR DRAIN
• FLOOR TRAP
• LEDGE WALL
• C/OUT IN FLOOR

Sanctioned
MEMO NO.:
DATE: / /

NO.	SIZE	BILL LEVEL	UNIT LVL	REMARK
D0	1200 X 2450	00 MM	2450 MM	SINGLE SHUTTER FIRE RATED DOOR
D1	1500 X 1550	00 MM	2450 MM	SINGLE SHUTTER FIRE RATED DOOR
D2	1200 X 2450	00 MM	2450 MM	SINGLE SHUTTER FLUSHED DOOR
D3	900 X 2450	00 MM	2450 MM	SINGLE SHUTTER FLUSHED DOOR
D4	750 X 2450	00 MM	2450 MM	SINGLE SHUTTER FLUSHED DOOR
D5	750 X 2450	00 MM	2450 MM	DOUBLE SHUTTER FLUSHED DOOR
S01	900 X 2450	00 MM	2450 MM	DOUBLE SHUTTER FIRE RATED DOOR
S01A	900 X 2450	00 MM	2450 MM	DOUBLE SHUTTER LOADED DOOR
S02	1800 X 2450	00 MM	2450 MM	FOUR SHUTTER FIRE RATED DOOR
S03	450 X 2450	00 MM	2450 MM	SINGLE SHUTTER FIRE RATED DOOR
S04	1200 X 2450	00 MM	2450 MM	DOUBLE SHUTTER LOADED DOOR
S05	600 X 2450	00 MM	2450 MM	SINGLE SHUTTER FIRE RATED DOOR
S06	750 X 2450	00 MM	2450 MM	SINGLE SHUTTER OPENABLE WINDOW
V4	750 X 2450	00 MM	2450 MM	SINGLE SHUTTER LOADED DOOR
W0	1250 X 1550	900 MM	2450 MM	LOADED WINDOW
W0A	900 X 1550	900 MM	2450 MM	LOADED WINDOW
W1	3500 X 2450	00 MM	2450 MM	6 PANEL SLIDING-FOLDING WINDOW
W1A	5500 X 2450	00 MM	2450 MM	6 PANEL FIXED WINDOW
W2	3070 X 2450	00 MM	2450 MM	4 TRACK SLIDING WINDOW
W2A	3070 X 2450	00 MM	2450 MM	4 TRACK BOTTOM FIXED SLIDING WINDOW
W3	3050 X 2450	00 MM	2450 MM	3 TRACK SLIDING WINDOW
W4	1075 X 1400	1550 MM	2450 MM	TWO SHUTTER OPENABLE WINDOW
W5	1795 X 2450	00 MM	2450 MM	3 TRACK SLIDING WINDOW
W5A	2125 X 2450	00 MM	2450 MM	3 TRACK BOTTOM FIXED SLIDING WINDOW
W6	1225 X 2450	00 MM	2450 MM	SINGLE SHUTTER OPENABLE WINDOW
W6A	1225 X 2450	00 MM	2450 MM	SINGLE SHUTTER OPENABLE WINDOW
W7	3800 X 2450	00 MM	2450 MM	6 TRACK SLIDING WINDOW
W8	1755 X 1400	1050 MM	2450 MM	2 TRACK SLIDING WINDOW / OPENABLE
W8A	1525 X 1400	1050 MM	2450 MM	2 TRACK SLIDING WINDOW / OPENABLE
W9	1375 X 2450	00 MM	2450 MM	2 TRACK SLIDING WINDOW / OPENABLE
W9A	875 X 2450	00 MM	2450 MM	SINGLE SHUTTER OPENABLE WINDOW
W10	3350 X 2450	00 MM	2450 MM	4 TRACK SLIDING WINDOW
W10A	3350 X 2450	00 MM	2450 MM	4 TRACK FIXED WINDOW
W11	3800 X 2450	00 MM	2450 MM	4 TRACK SLIDING WINDOW
W11A	3800 X 2450	00 MM	2450 MM	4 TRACK FIXED WINDOW
W12	1800 X 2450	00 MM	2450 MM	2 TRACK SLIDING WINDOW
W13	2250 X 2450	00 MM	2450 MM	3 PANEL FIXED WINDOW
V1	600 X 1250	1200 MM	2450 MM	LOADED WINDOW
V2	450 X 1250	1200 MM	2450 MM	LOADED WINDOW
V3	510 X 1250	1200 MM	2450 MM	LOADED WINDOW
V1A	750 X 2000	450 MM	2450 MM	LOADED ACCESSIBLE DOOR / WINDOW

- NOTES:**
- FD-01, FD-02, ARE 2HR FIRE RATED
 - ALL INTERNAL AND EXTERNAL WALLS ARE R.C.C.
- STRUCTURAL MEMBER**
- NON STRUCTURAL MEMBER**
- ALL INTERNAL WALLS ARE OF 100mm AND EXTERNAL WALLS
 - 150mm NON STRUCTURAL
 - P.R. ARE ARTIFICIALLY UT AND MECHANICALLY VENTILATED.
 - P.R. = POWER ROOM
 - AREA UNDER COMMUNITY AT T-09 IS FULLY SPRINKLED ARTIFICIALLY UT AND MECHANICALLY VENTILATED.

ARCHITECT:
VIKAS AHLAWAT ARCHITECTS
ARCHITECTURE, INTERIORS, PLANNING
Unit No. 303, Nitya Time Center, Sushruti Sector-54, Golf Course Road, Gurgaon
C-0124-4284293 M- 04699158486 Mail - ar.vikas.ahlawat@gmail.com

MEP CONSULTANT:
SANELAC CONSULTANTS PVT. LTD.
C-64/2, Okhla Industrial Area, Phase II, New Delhi, Delhi Tel. 011 40503959
110020.

STRUCTURAL CONSULTANT:
VITECH CONSULTANTS
CONSULTANT ENGINEERS & PROJECT MANAGERS
C-35, Pampash Enclave, Great Kallash, New Delhi-1100148.
Tel. 43141516, Fax. 26296767 Email - vitech@vitechconsultants.com

CLIENT:
WHITELAND
M/s. Whiteland Corporation Private Limited.

DESIGN CONSULTANT:
Architect Hafeez Contractor
29 Bank Street, Fort, Mumbai 400 023 Tel : 2286 1820

PROJECT:-
PROPOSED BUILDING PLAN FOR GROUP HOUSING COLONY FOR AN AREA MEASURING 5.785 ACRES UNDER T O D POLICY DATED 09.02.2016(LICENCE NO. 92 OF 2022 DATED 12.07.2022) IN SECTOR- 76, GURUGRAM (G.M.U.C.) BEING DEVELOPED BY WHITELAND CORPORATION PVT. LTD.

OWNERS SIGNATURE:- **ARCHITECT SIGNATURE:-**

(Signatures)

DRAWING TITLE:
FLOOR PLAN & AREA CALCULATION (TOWER-09)

DATE:- NOV-2022 **N** **SHEET NO.**
SCALE:- 1:100 (A1) **↑** **T-9-P-2**