

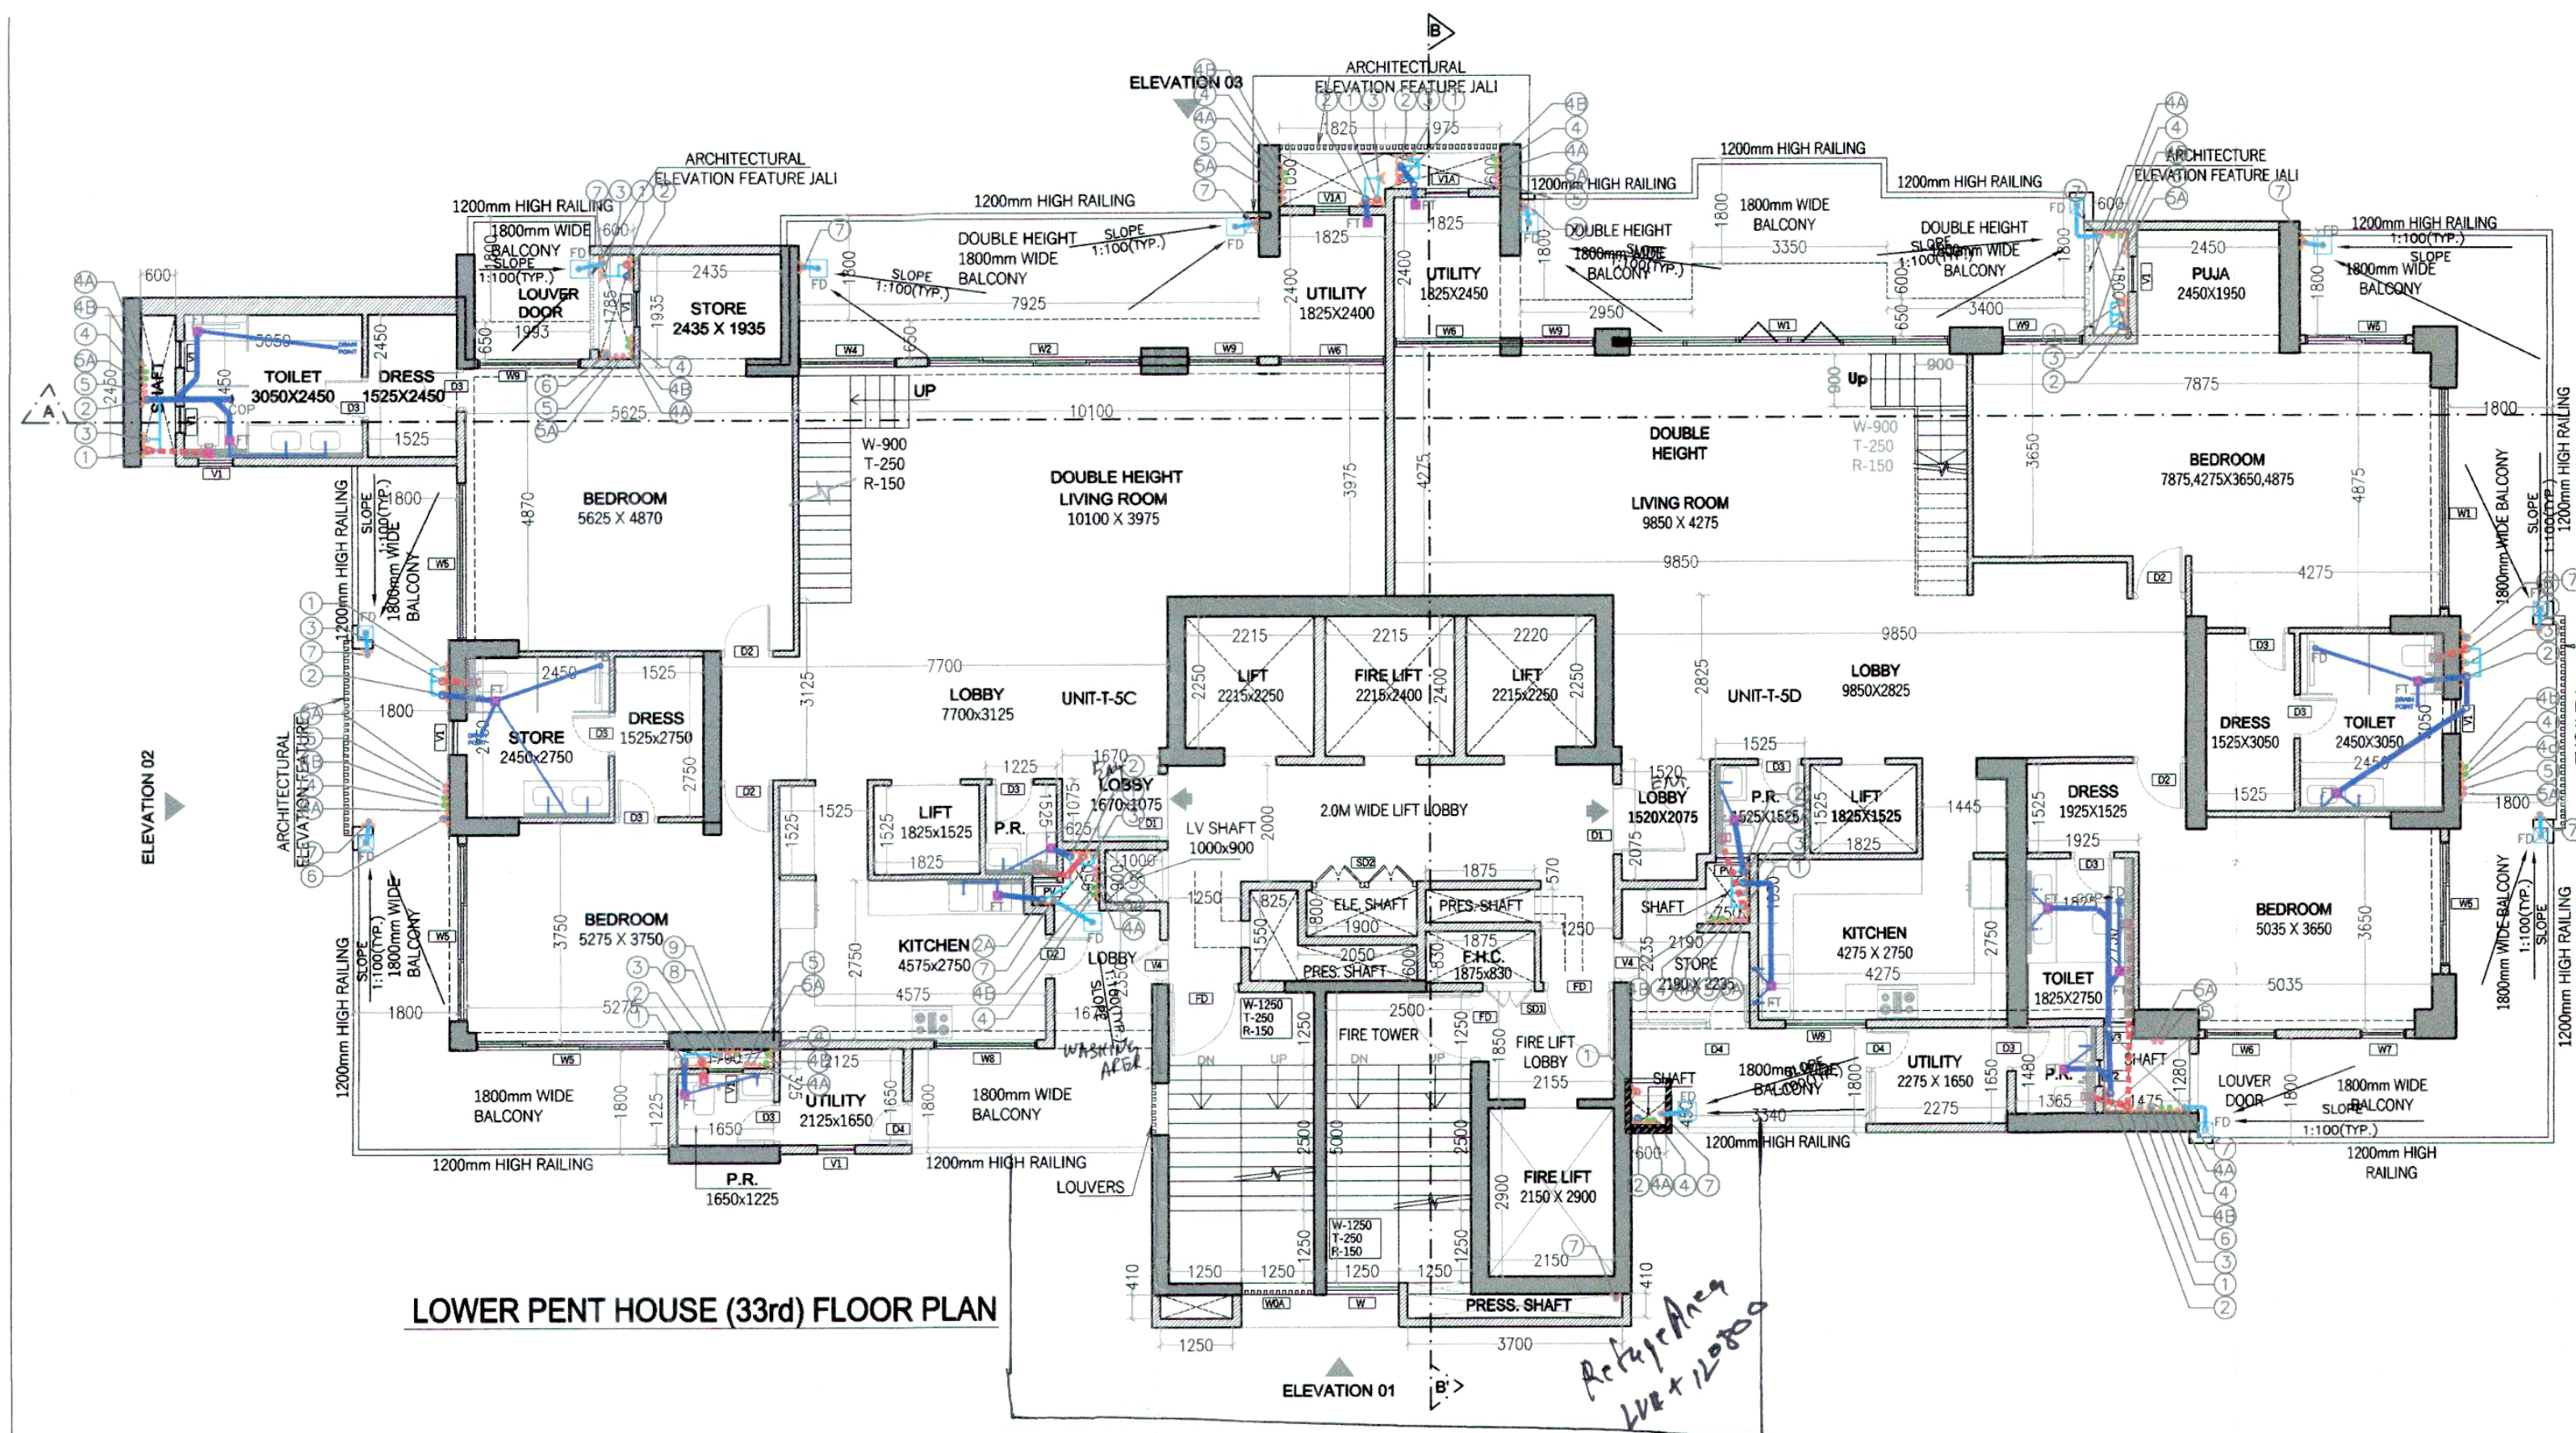


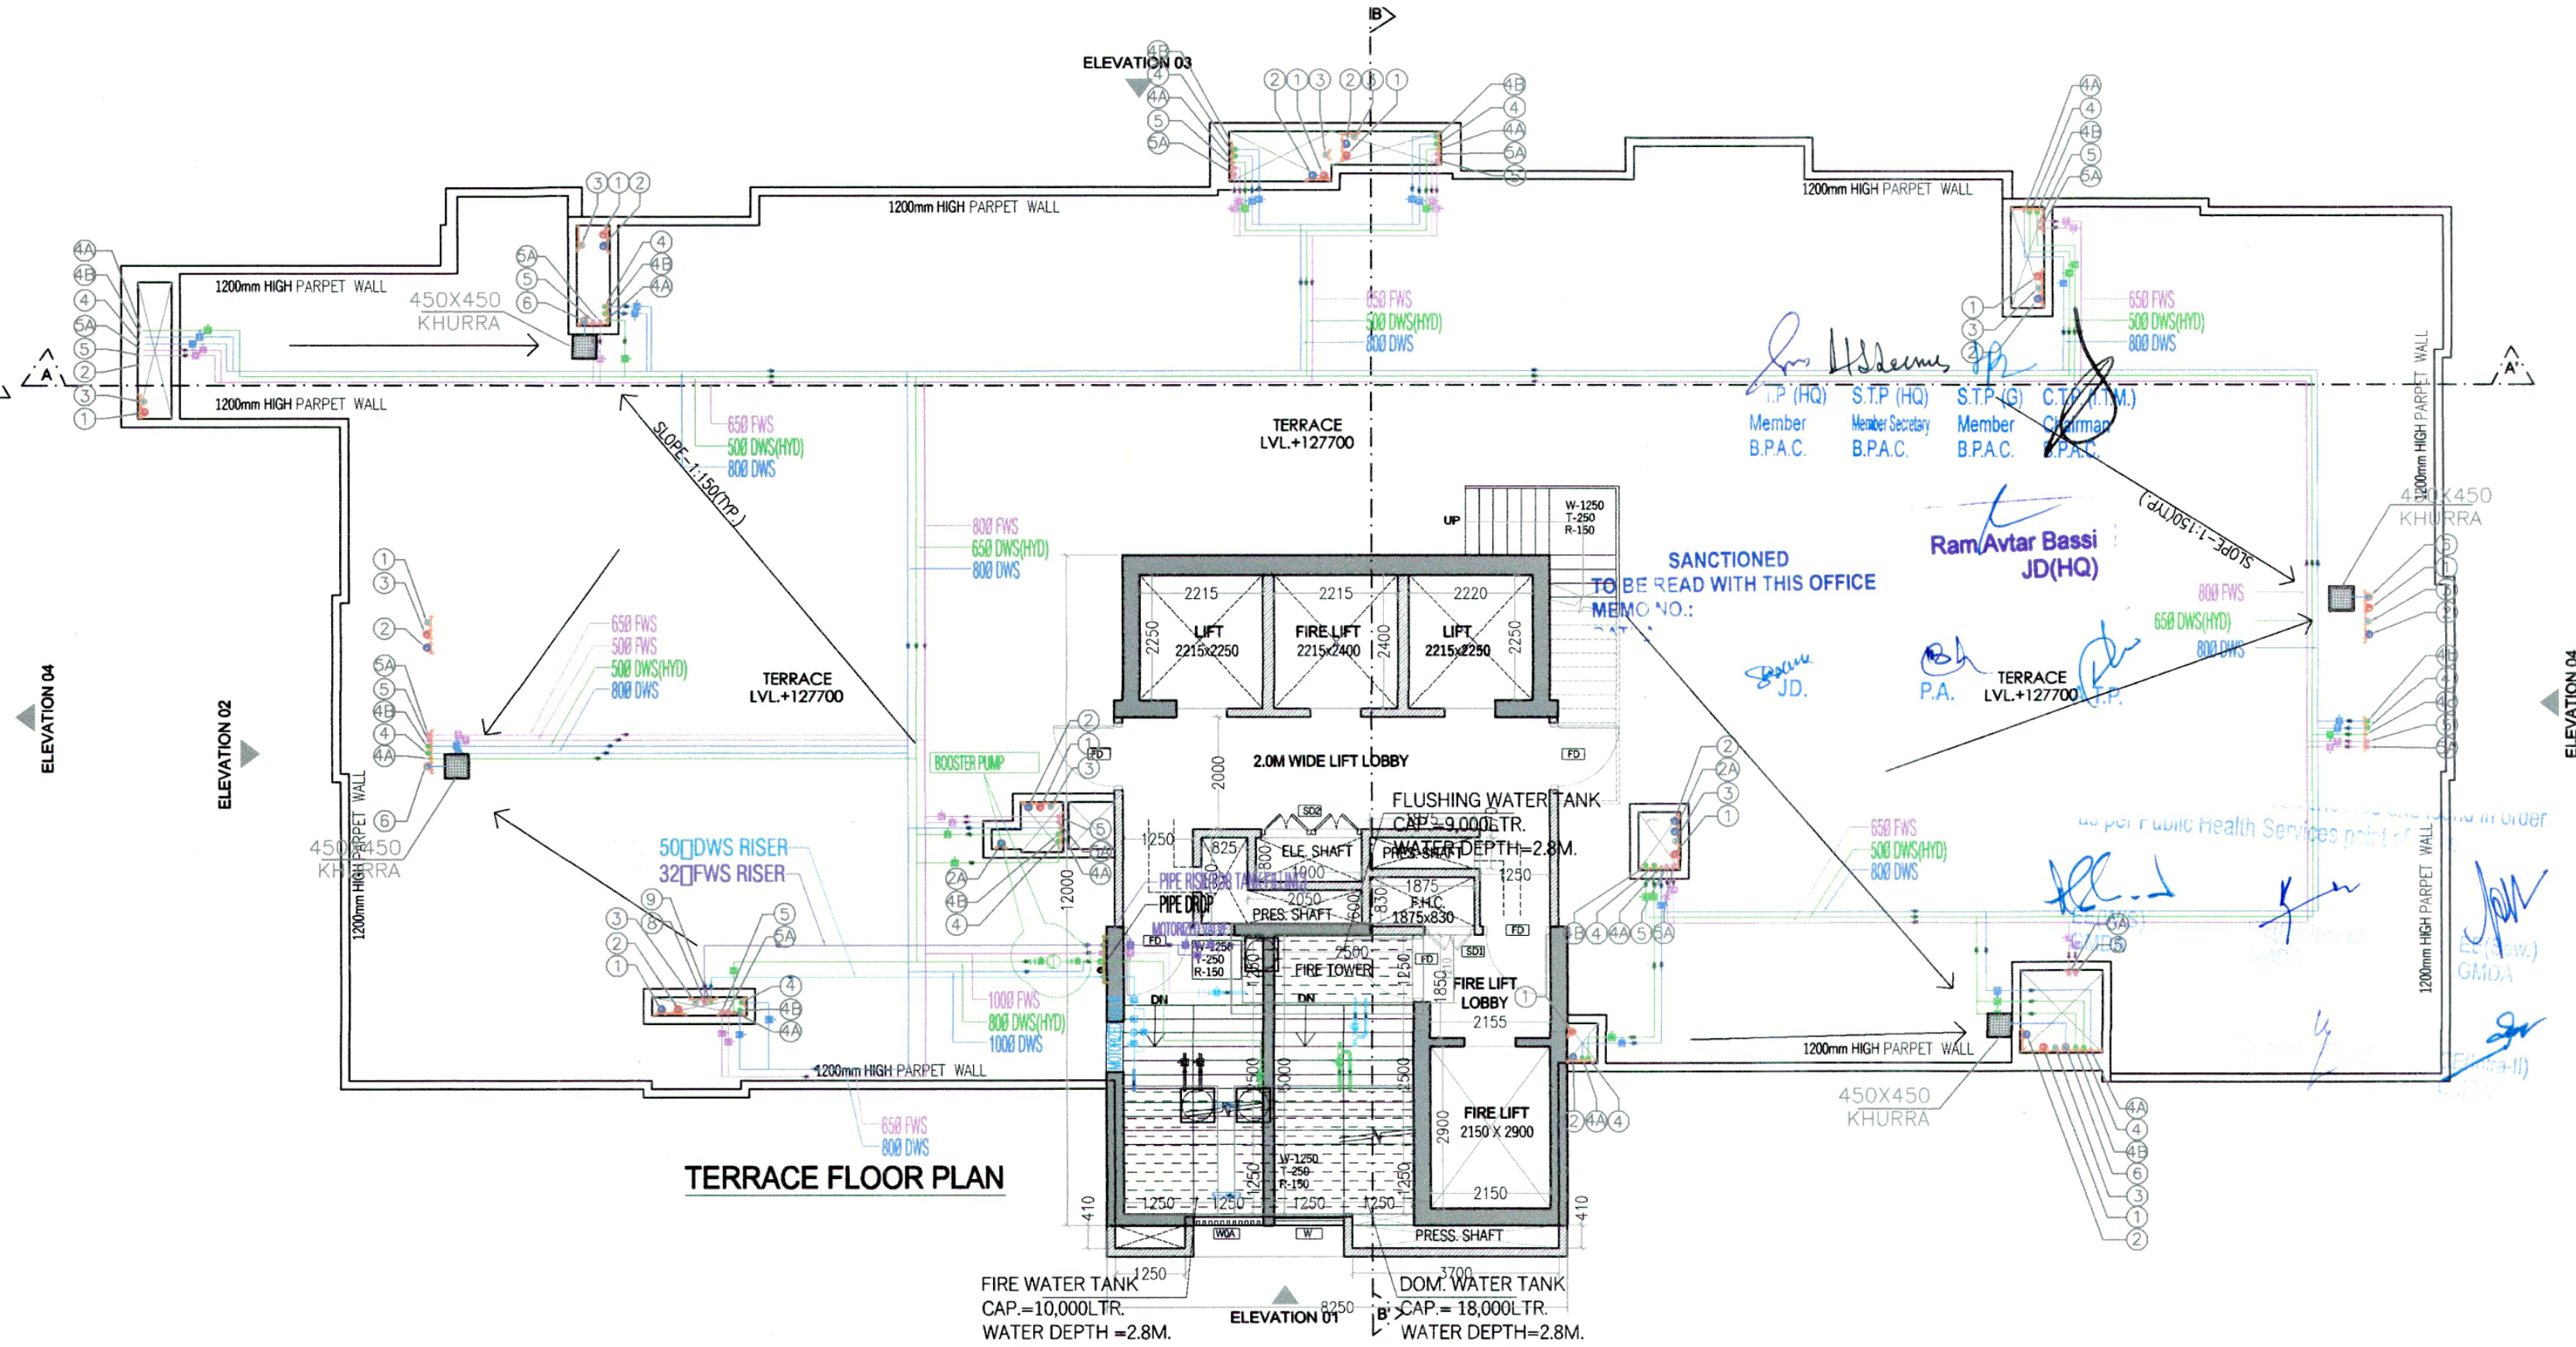

LOWER PENT HOUSE FLOOR AREA (TOWER-05)					
S.N.O.	NO.	PREFIX	BREATH	LENGTH	AREA
1	1	1	0	0	0.000
TOTAL ADDITION					460.471
SUBTRACTION					0.000
TOTAL SUBTRACTIONS					0.000
TOTAL LOWER PENT HOUSE FLOOR AREA					460.471

SYMBOL	DESCRIPTION
1	110 OD SOIL AND VENT PIPE
2	110 OD WASTE AND VENT PIPE
3	110 OD KITCHEN WASTE AND VENT PIPE
4	75# ANTISIPHONAGE PIPE
5	DOMESTIC WATER SUPPLY DN. TAKE PIPE (FOR TERRACE TO 1st FLOOR)
6	DOMESTIC WATER SUPPLY DN. TAKE PIPE (FOR TERRACE TO 28th FLOOR/PRESSURE SUPPLY)
7	DOMESTIC WATER SUPPLY DN. TAKE PIPE FOR (FOR TERRACE TO 14th FLOOR)
8	FLUSHING WATER SUPPLY DN. TAKE PIPE (FOR TERRACE TO 1st FLOOR)
9	FLUSHING WATER SUPPLY DN. TAKE PIPE (FOR TERRACE TO 16th FLOOR)
10	110 OD UPVC TERRACE RAIN WATER PIPE
11	75# UPVC RAIN WATER PIPE (BALCONY)
12	DOMESTIC WATER SUPPLY RISER
13	FLUSHING WATER SUPPLY RISER
FD	FLOOR DRAIN
FT	FLOOR TRAP
---	LEDGE WALL
---	CUTOUT IN FLOOR

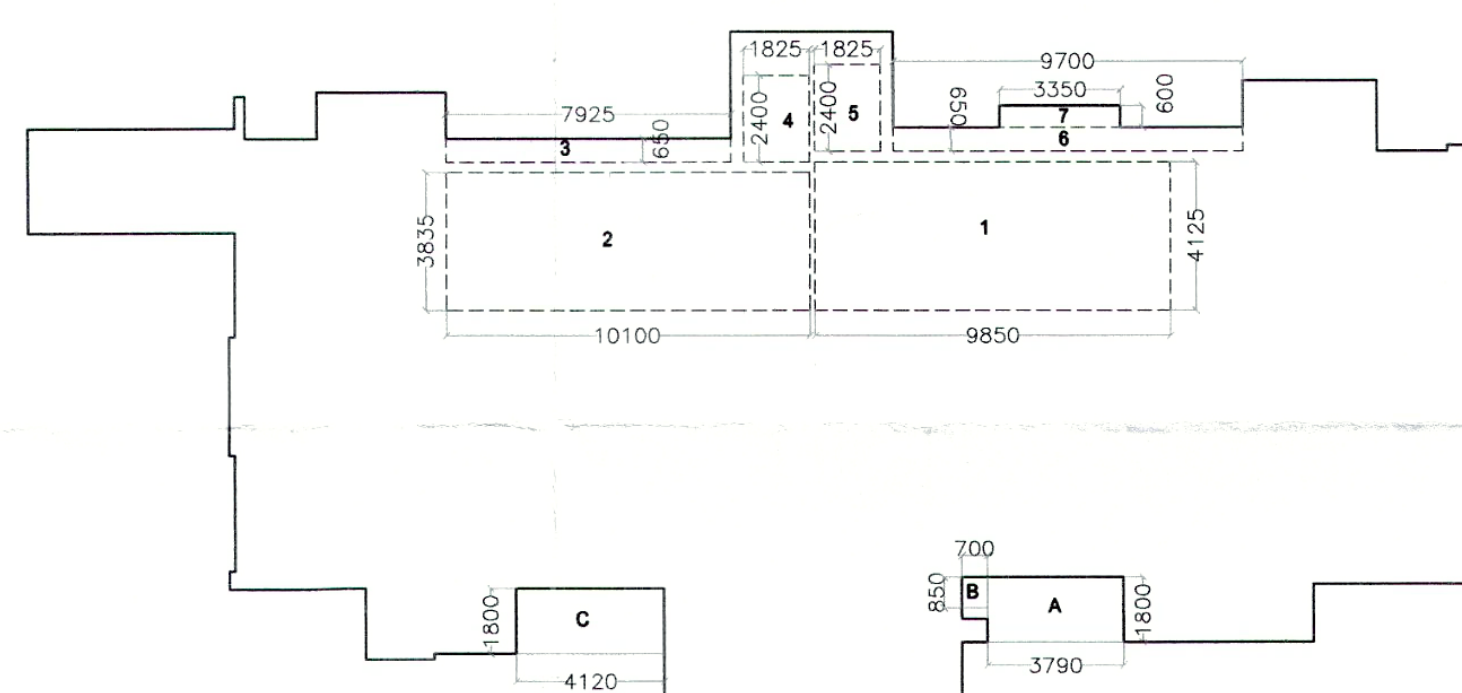

UPPER PENT HOUSE FLOOR AREA (TOWER-05)					
S.N.O.	NO.	PREFIX	BREATH	LENGTH	AREA
1	1	1	0.700	1.800	1.260
2	1	1	0.700	0.850	0.595
3	1	1	4.120	1.800	7.416
TOTAL ADDITION					475.304
SUBTRACTION					0.000
TOTAL SUBTRACTIONS					0.000
TOTAL UPPER PENT-HOUSE AREA					475.304

TOTAL F.A.R. TOWER-05			
FLOOR/TITLE	NOS.	TYPICAL FL.	TOTAL FAR
GROUND FL.	29	228.638	228.638
TYPICAL FL.	29	460.471	13353.659
REFUGEE FL. (15, 238.31)	3	460.471	1381.413
U.P.H. (34TH)	1	373.713	373.713
TOTAL			

TOTAL BUILT-UP (TOWER-05)		AREA
TOTAL F.A.R. (TOWER-05)		15,797.894
AREA UNDER STILT		337.253
STAIRCASE AREA (2.5X5.0X2X34)		850.000
MUMTY AREA		100.980
REFUGEE TERRACE AREA (THREE FL.)		138.839
TOTAL BUILT UP AREA (T-05)		17,224.966

- NOTES:-
- 1. F.D.01, F.D.02 ARE 2HR FIRE RATED
 - 2. ALL INTERNAL AND EXTERNAL WALLS ARE R.C.C.
 - 3. STRUCTURAL MEMBER
 - 4. NON STRUCTURAL MEMBER
 - 5. ALL INTERNAL WALLS ARE OF 100mm AND EXTERNAL WALLS 150mm THICK STRUCTURAL
 - 6. W.C. ARE ARTIFICIALLY LIT AND MECHANICALLY VENTILATED.
 - 7. P.R. = POWER ROOM

ARCHITECT:
VIKAS AHLAWAT ARCHITECTS
 ARCHITECTURE, INTERIORS, PLANNING
 Unit No.303 Nihon Time Center, Sanjay Sector-54 Golf Course Road, Gurugram
 O:- 0124-4284250 M:- 0-9699158499 Mail:- ar.vikas.ahlawat@gmail.com

MEP CONSULTANT:
SANILAC CONSULTANTS PVT. LTD.
 C-64/2, Okhla Industrial Area, Phase II, New Delhi, Delhi
 Tel. 011 43033959 110020.

STRUCTURAL CONSULTANT:
VINTECH CONSULTANTS
 CONSULTANT ENGINEERS & PROJECT MANAGERS
 C-35, Pampoh Enclave, Great Kalash-II, New Delhi-110048.
 Tel. 43141516, Fax. 26296767 Email:-vintech@vintechconsultants.com

CLIENT:
WHITELAND
 M/s. Whiteland Corporation Private Limited.

DESIGN CONSULTANT:
Architect Hafeez Contractor
 29 Bank Street, Fort, Mumbai 400 023 Tel:- 2286 1920



PROJECT:-
PROPOSED BUILDING PLAN FOR GROUP HOUSING COLONY AN AREA MEASURING 5.785 ACRES UNDER TOD POLICY DATED 09.02.2016 (LICENCE NO. 92 OF 2022 DATED 12.07.2022) IN SECTOR- 76, GURUGRAM (G.M.U.C.) BEING DEVELOPED BY WHITELAND CORPORATION PVT. LTD.

OWNERS SIGNATURE:- ARCHITECT SIGNATURE:-

DATE:- NOV-2022
 SCALE:- 1:100 (A1)

DRAWING TITLE:
FLOOR PLAN & AREA CALCULATION (TOWER-05)

SHEET NO.
 T- 5 - P - 2

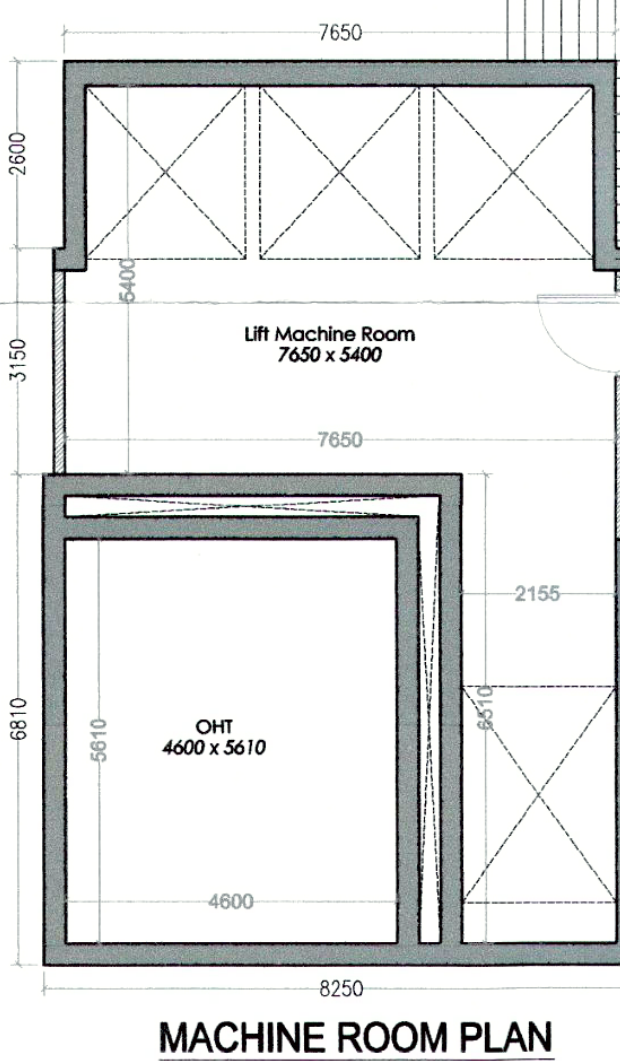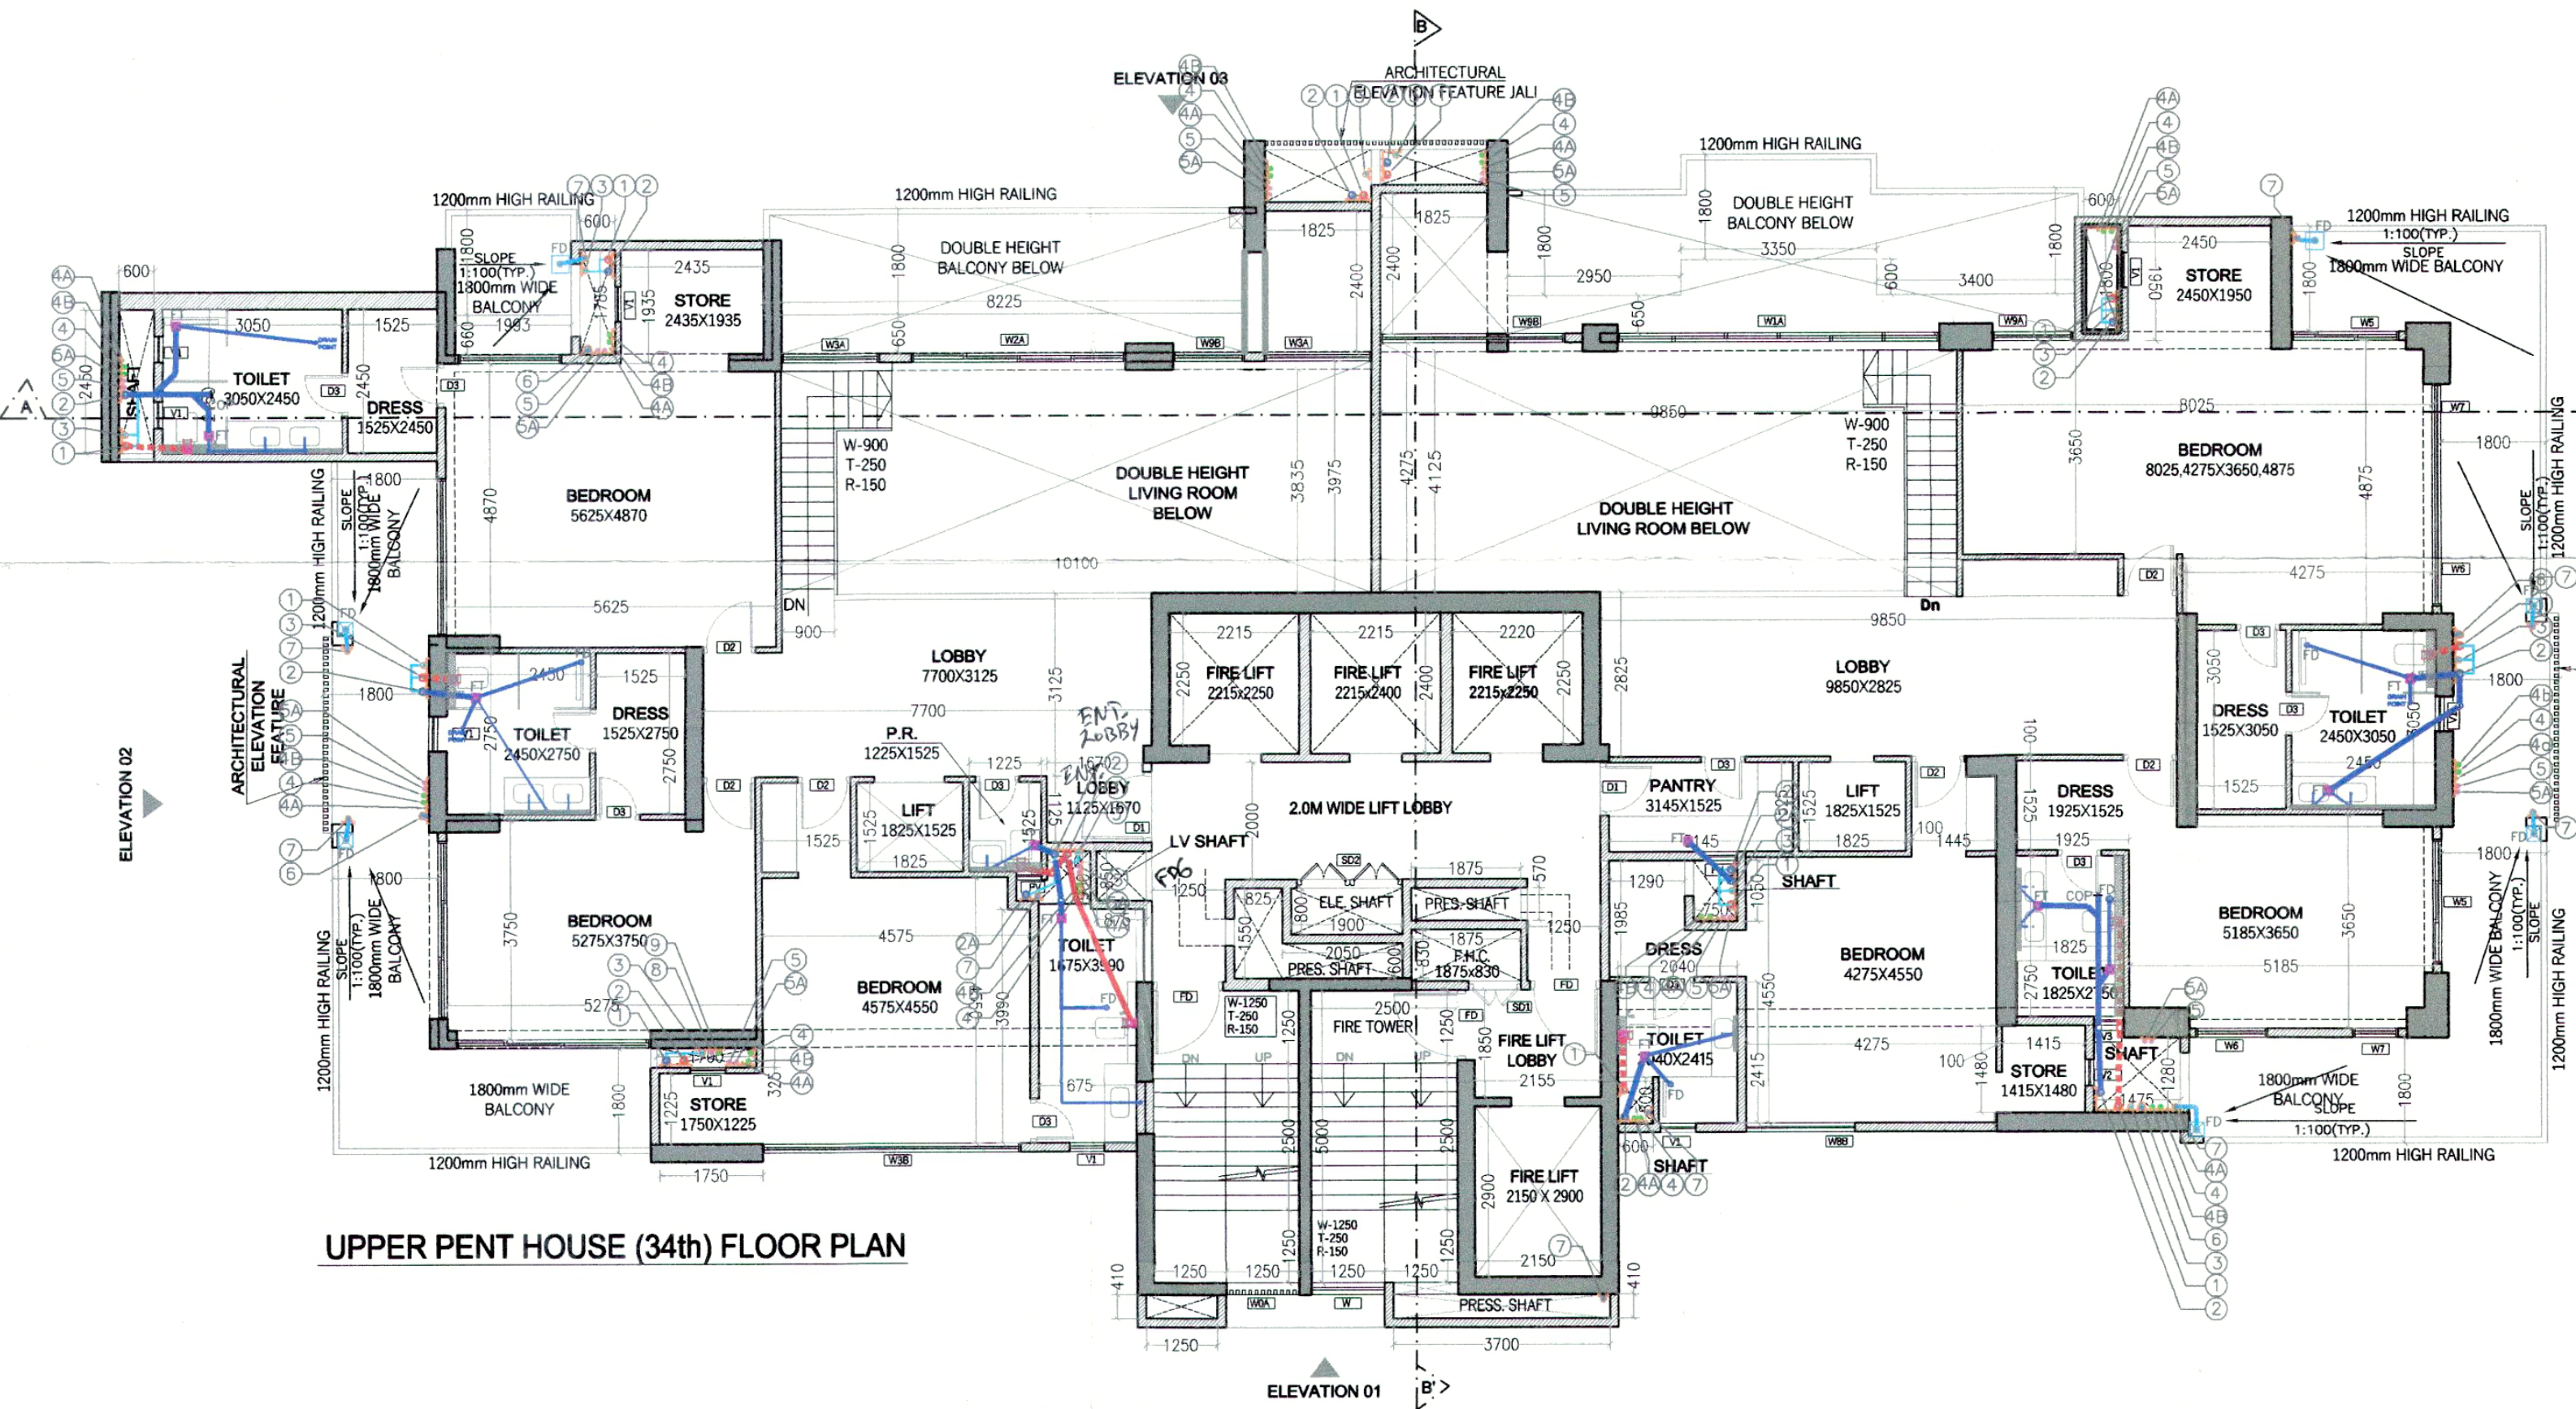

MUMTY AREA (TOWER-05)					
S.N.O.	NO.	PREFIX	BREATH	LENGTH	AREA
1	1	1	8.250	5.910	48.758
2	1	1	7.950	4.050	32.198
3	1	1	7.650	2.600	19.890
4	1	1	0.150	0.900	0.135
TOTAL ADDITION					100.980
SUBTRACTIONS					0.000
TOTAL SUBTRACTIONS					0.000
TOTAL MUMTY AREA					100.980

MUMTY / MACHINE ROOM AREA DIAGRAM