
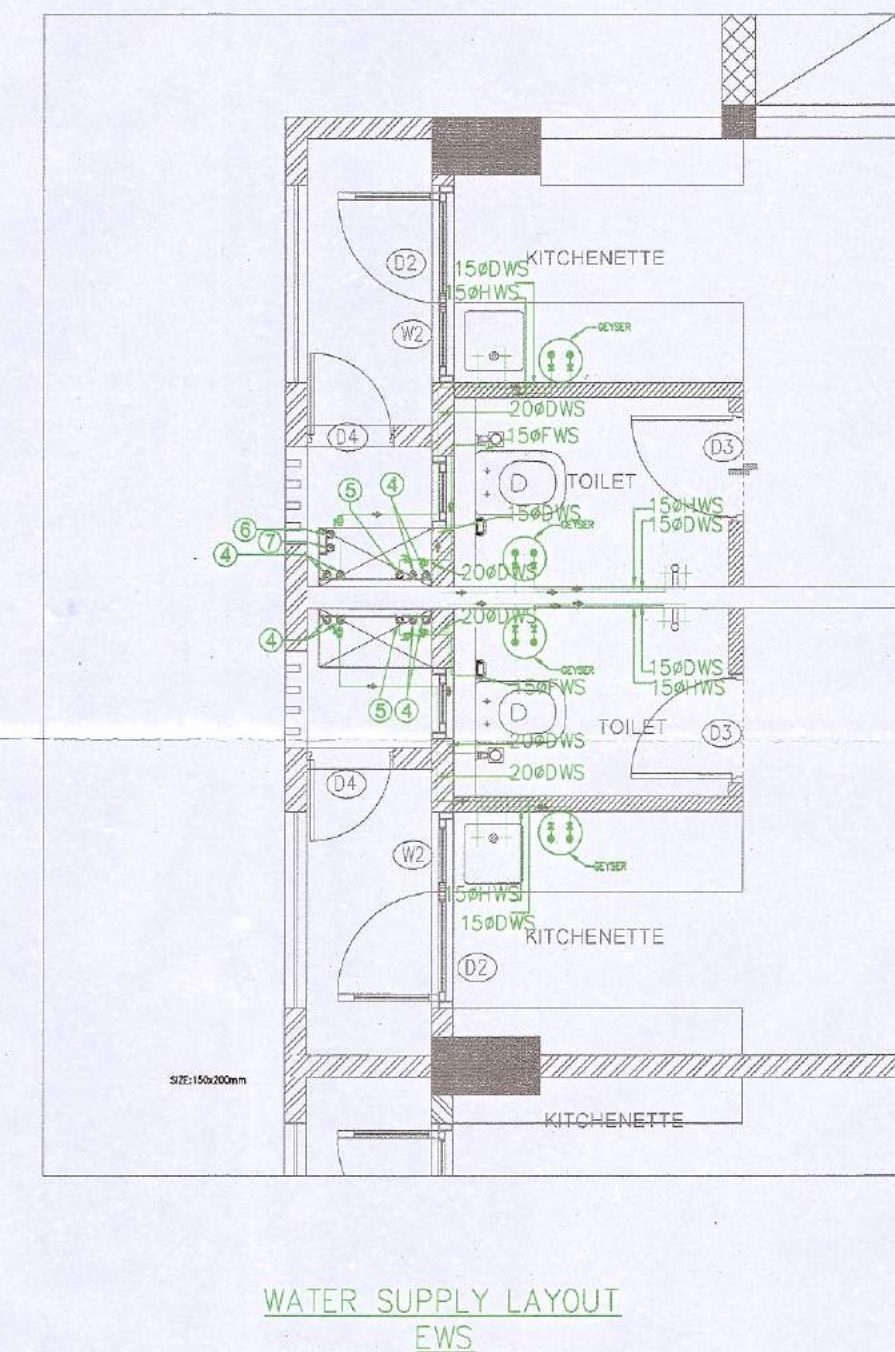
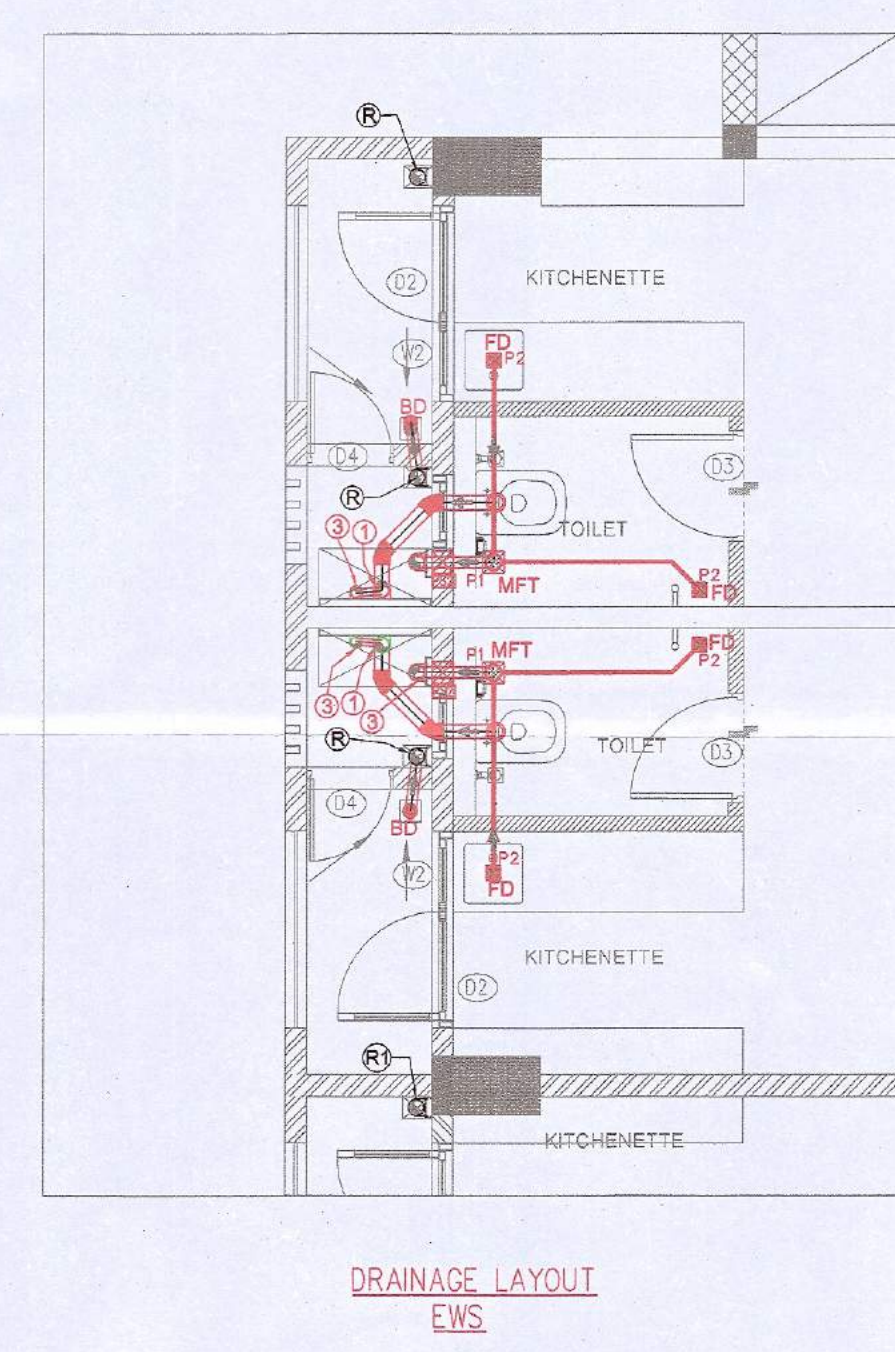
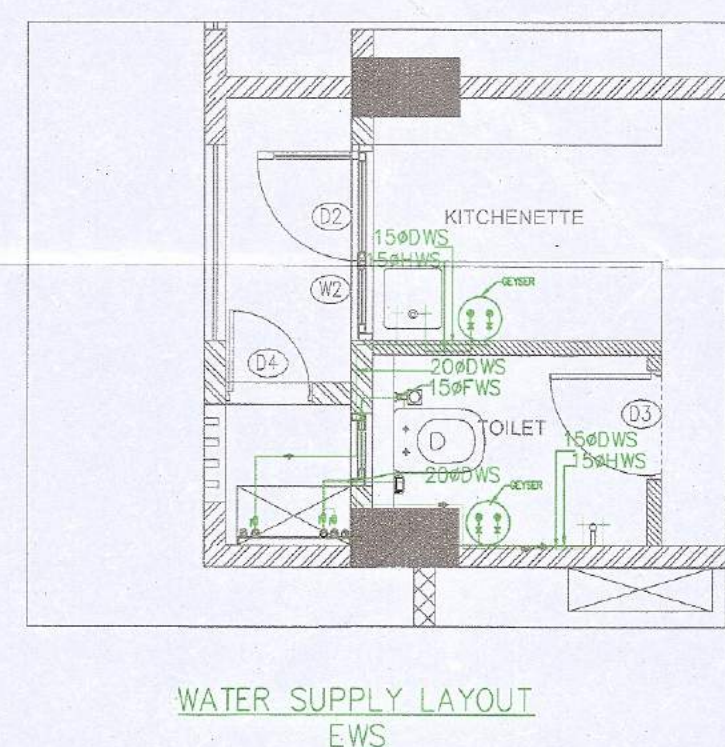
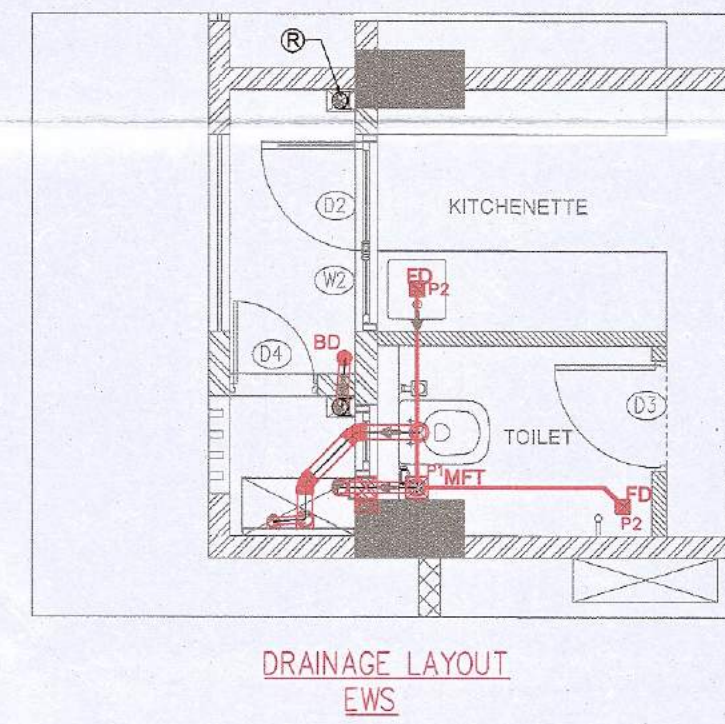
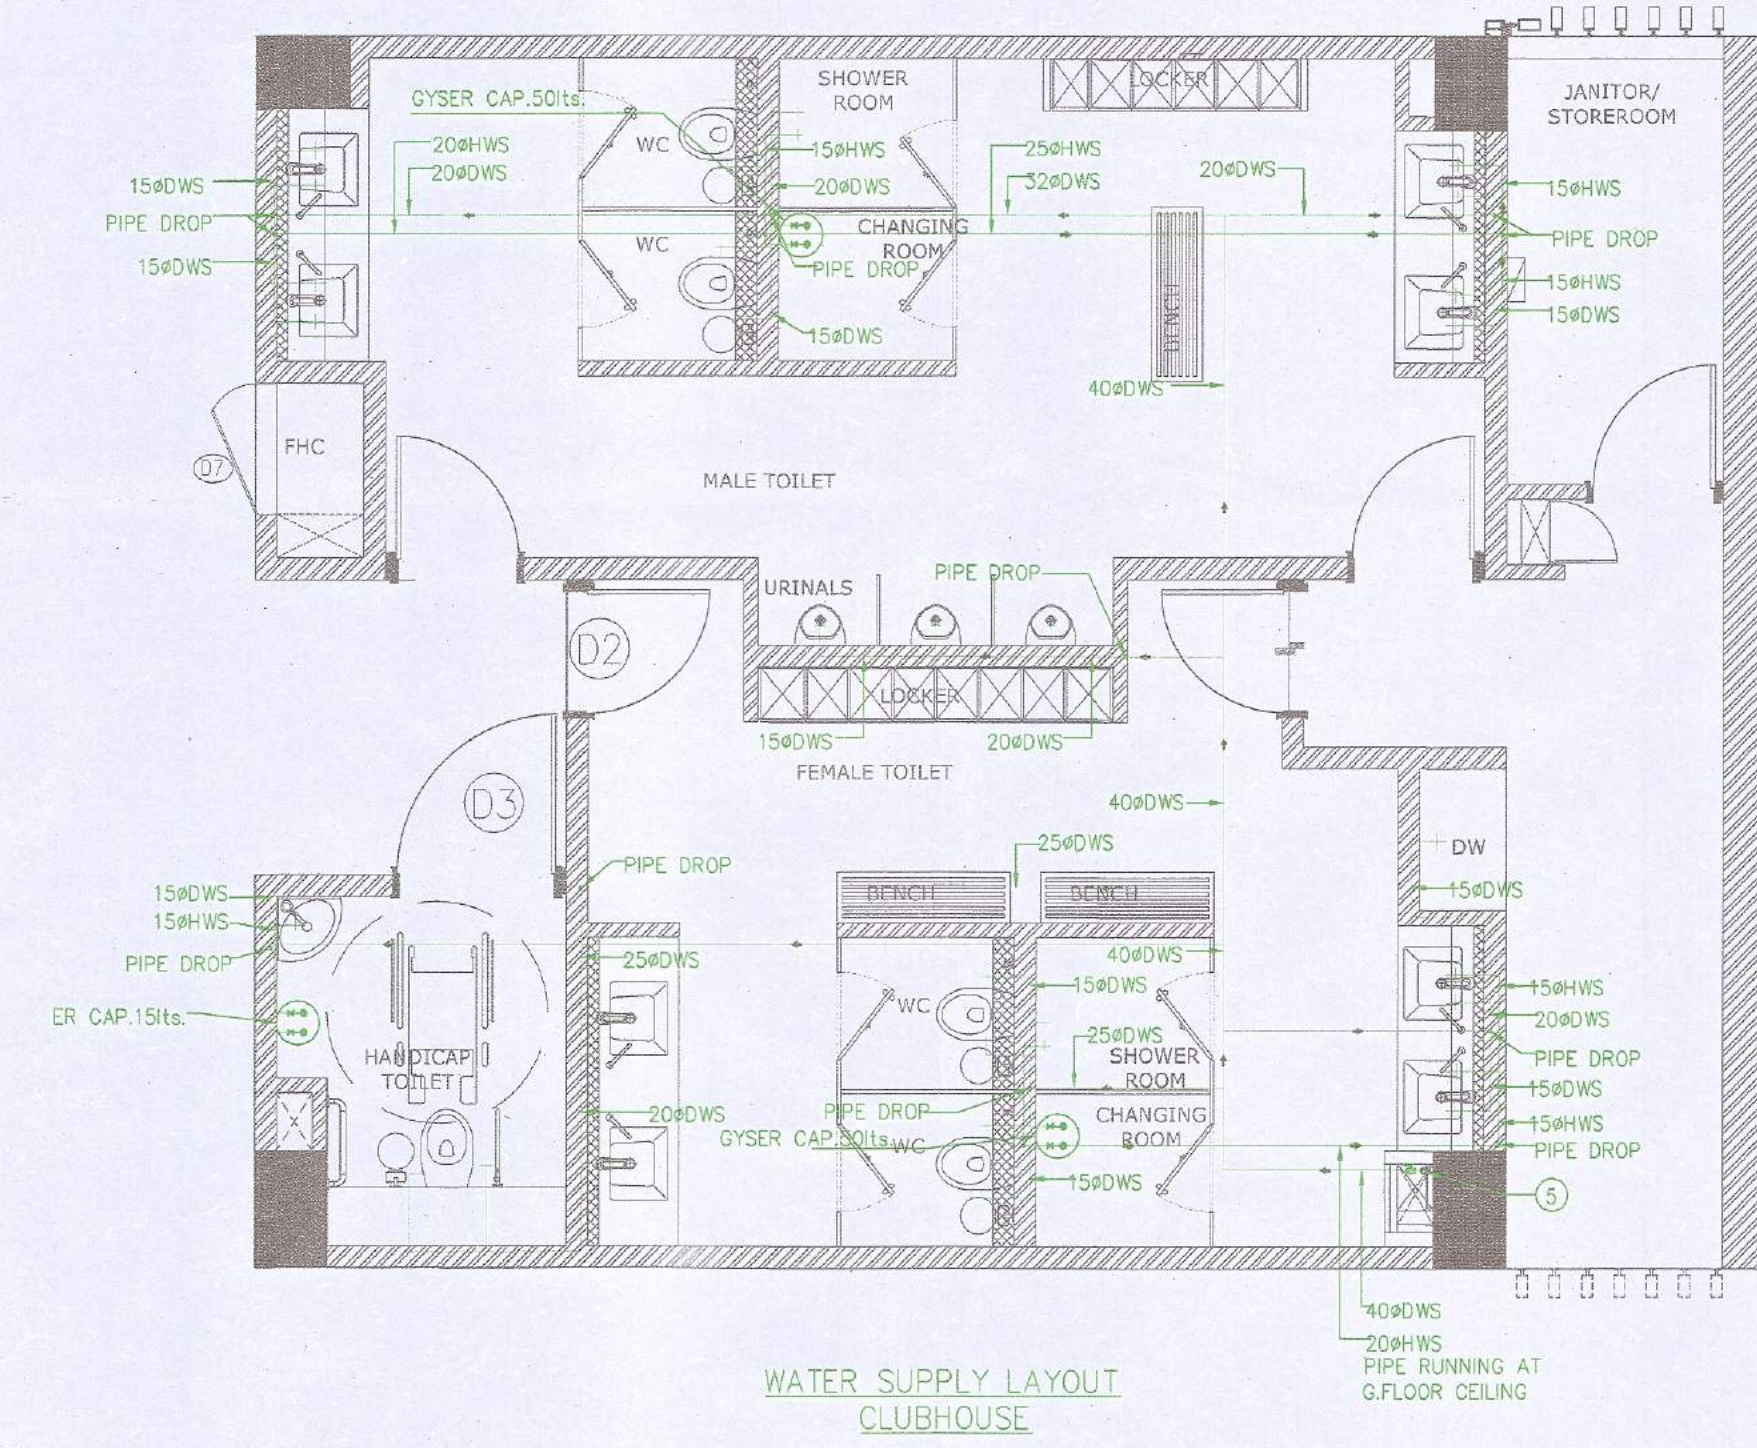


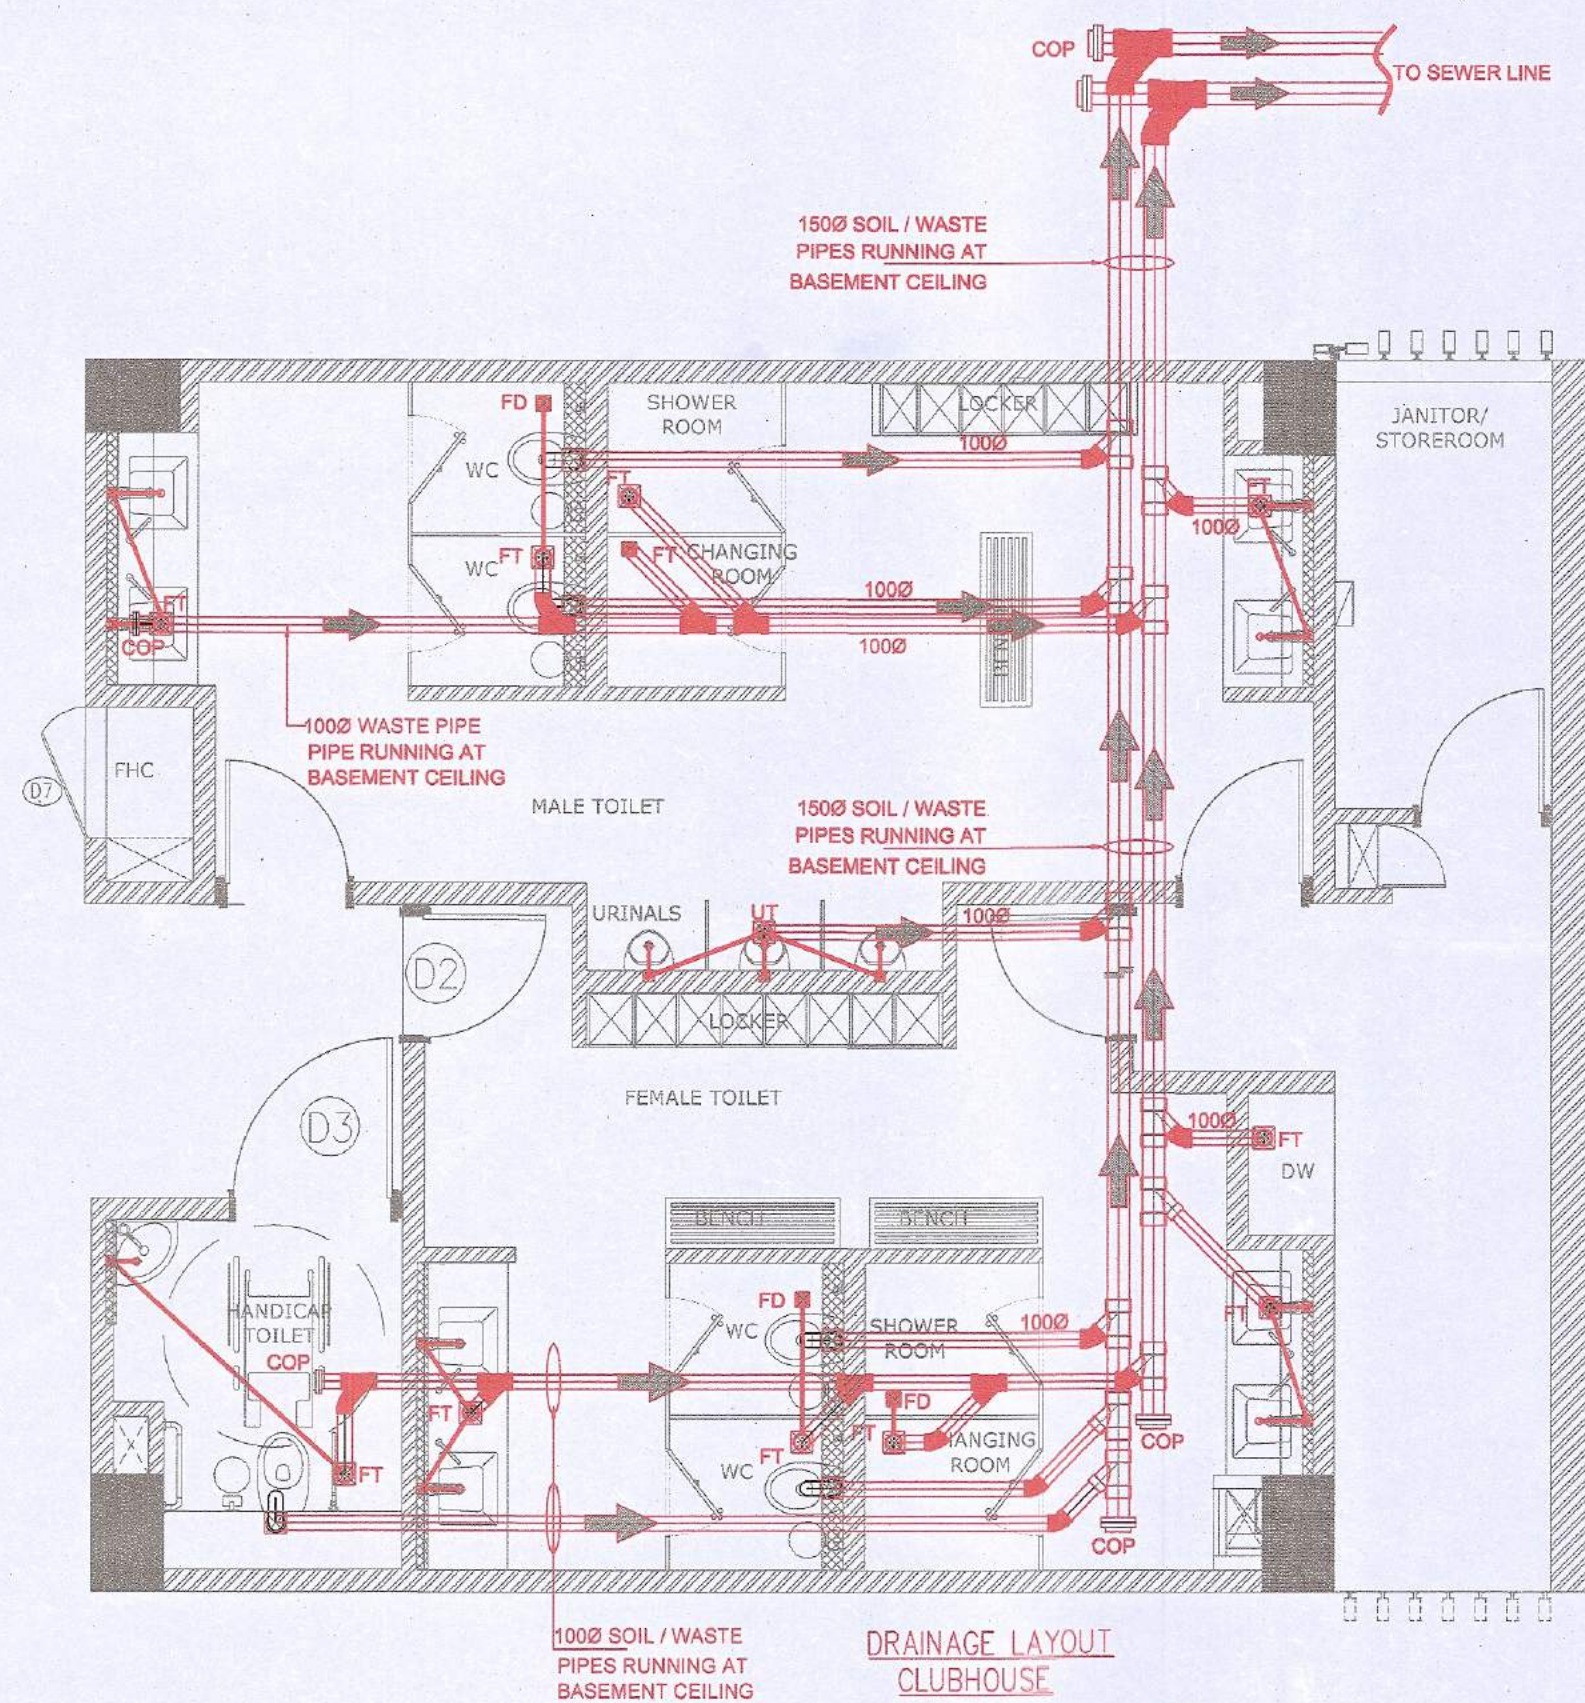

PLUMBING LEGEND:-

1	110 OD SOIL PIPE	1
2	110 OD WASTE PIPE	1
3	75 OD ANTI VENT PIPE	1
4	DOMESTIC WATER SUPPLY PIPE	1
5	FLUSHING WATER SUPPLY PIPE	1
6	DOMESTIC WATER RISER PIPE TO OHT	1
7	FLUSHING WATER RISER PIPE TO OHT	1
R	110 OD RAIN WATER PIPE	1
R1	160 OD RAIN WATER PIPE	1
FT	FLOOR TRAP CUTOUT	1
FD	FLOOR DRAIN	1
BD	BALCONY DRAIN	1
MFT	MULTY FLOOR TRAP	1

PIPE CONNECTION DIA :-

WC TO STACK	110 OD UPVC SOIL PIPE
WASH BASIN TO FT	40 OD UPVC WASTE PIPE
MFT TO STACK	75 OD UPVC WASTE PIPE
FD TO MFT	63 OD UPVC WASTE PIPE
SINK TO MFT	50 OD UPVC WASTE PIPE

PIPE SLOPE TABLE :-

160 OD SOIL & WASTE PIPE	SLOPE- 1:100
110 OD SOIL & WASTE PIPE	SLOPE- 1:70

NOTE:-
SEWER & STORM LEVEL REFER SITE PLAN

S.N. LEGENDS:-

01	SEWER MANHOLE 900X800	1
02	CATCH BASIN WITHOUT GRATING (450X450)	1
03	GULL TRAP 300X300	1

PLUMBING LEGEND:-

1	110 OD SOIL PIPE	1
2	110 OD WASTE PIPE	1
3	75 OD ANTI VENT PIPE	1
4	DOMESTIC WATER SUPPLY PIPE DN.	1
5	DOMESTIC WATER RISER PIPE TO OHT	1
R	100 OD RAIN WATER PIPE	1
R1	160 OD RAIN WATER PIPE	1
FT	FLOOR TRAP	1
FD	FLOOR DRAIN	1
BD	BALCONY DRAIN	1
MFT	MULTY FLOOR TRAP	1

PIPE CONNECTION DIA :-

WC TO TO STACK	110 OD UPVC SOIL PIPE
URINAL BASIN TO UT	50 OD UPVC SOIL PIPE
UT TO STACK	110 OD UPVC SOIL PIPE
WASH BASIN TO FT	40 OD UPVC WASTE PIPE
FT TO STACK	110 OD UPVC WASTE PIPE
FD TO FT	63 OD UPVC WASTE PIPE
SINK TO FT	50 OD UPVC WASTE PIPE

PIPE SLOPE TABLE :-

160 OD SOIL & WASTE PIPE	SLOPE- 1:100
110 OD SOIL & WASTE PIPE	SLOPE- 1:70

PLUMBING LEGEND:-

DWS	DOMESTIC WATER SUPPLY
DWR	DOMESTIC WATER RISER
HWS	HOT WATER SUPPLY
BY 45°	UP TO 400 BALL VALVE / ABOVE 400 BUTTERFLY VALVE

PLUMBING LEGEND CUTOUTS IN TOILET :-

1.	150X150 IN SLAB FOR FT/WC	1
2.	100X100 IN SLAB FOR FD	1
3.	75X75 IN SLAB FOR WASH BASIN	1

Checked and found ok for Public Health
(Internal) Service only subject to comments in
in forwarding letter No 97492.Du.88.15-2023

Superintending Engineer (HQ)
for Chief Engineer
HSVP, Chhokula
Solemnly
Member

Note :-
1. BUILDING WILL BE DESIGNED
(STRUCTURES)
AS PER RELEVANT IS CODES FOR EARTH
QUAKE RESISTANCE.

SANCTIONED
TO BE READ WITH THIS OFFICE
MEMO NO. 22966
DATED: 12-07-2023

LEGEND:-

Architect (HQ)
Member
B.P.A.C.
ATP (HQ)
Ram Avtar Bhatti
AD
PA
ATP

PROJECT:-

PROPOSED GROUP HOUSING SITE MEASURING
9.53 ACRES IN RESIDENTIAL PLOTTED COLONY
MEASURING 177.86 ACRES LICENSE NO. 10 OF
2009 DATED DT 21.05.2009 LICENSE NO. 113 OF
2011 DATED 22.12.2011 & LICENSE NO. 117 OF
2022 DATED 23.08.2022 IN SECTOR 65 &
62, GURUGRAM BEING DEVELOPED BY ACTIVE
PROMOTERS AND OTHERS IN COLLABORATION
WITH EMAAR INDIA LTD (FORMERLY KNOWN AS
EMAAR MGF LAND LTD)

ARCHITECT:-

DSP DESIGN ASSOCIATES PVT. LTD.
Architects & Interior Designers

8th Floor, Overhead House, Shiv Sagar
Enclave, Dr. Ambedkar Road, Opposite
Nehru Centre, Vasant Kunj, New Delhi - 110025
Tel: +91 22 4910 1000
Web: www.dspdesigns.com

MUMBAI • BANGALURU • PUNE • NEW DELHI • HYDERABAD

Associate Architects

RSMS ARCHITECTS

RSMS ARCHITECTS PVT. LTD.
69, Nora Niwas, Bhawani Kunj
(Behind D2), Vasant Kunj,
New Delhi-110070.
Tel.: 011-26898616, 26898617
www.rsms-arch.com

OWNER'S SEAL
& SIGNATURE

ARCHITECT'S SEAL
& SIGNATURE

FOR DSP

Manmeet Singh Belli
Architect (B.Arch, IITK)
CA/2003/00546

FEB.-2023

Scale : 1:50

Drawing Title:-

Drawing No:-

COMMUNITY BUILDING & EWS
TOILET DETAIL

TD-01