



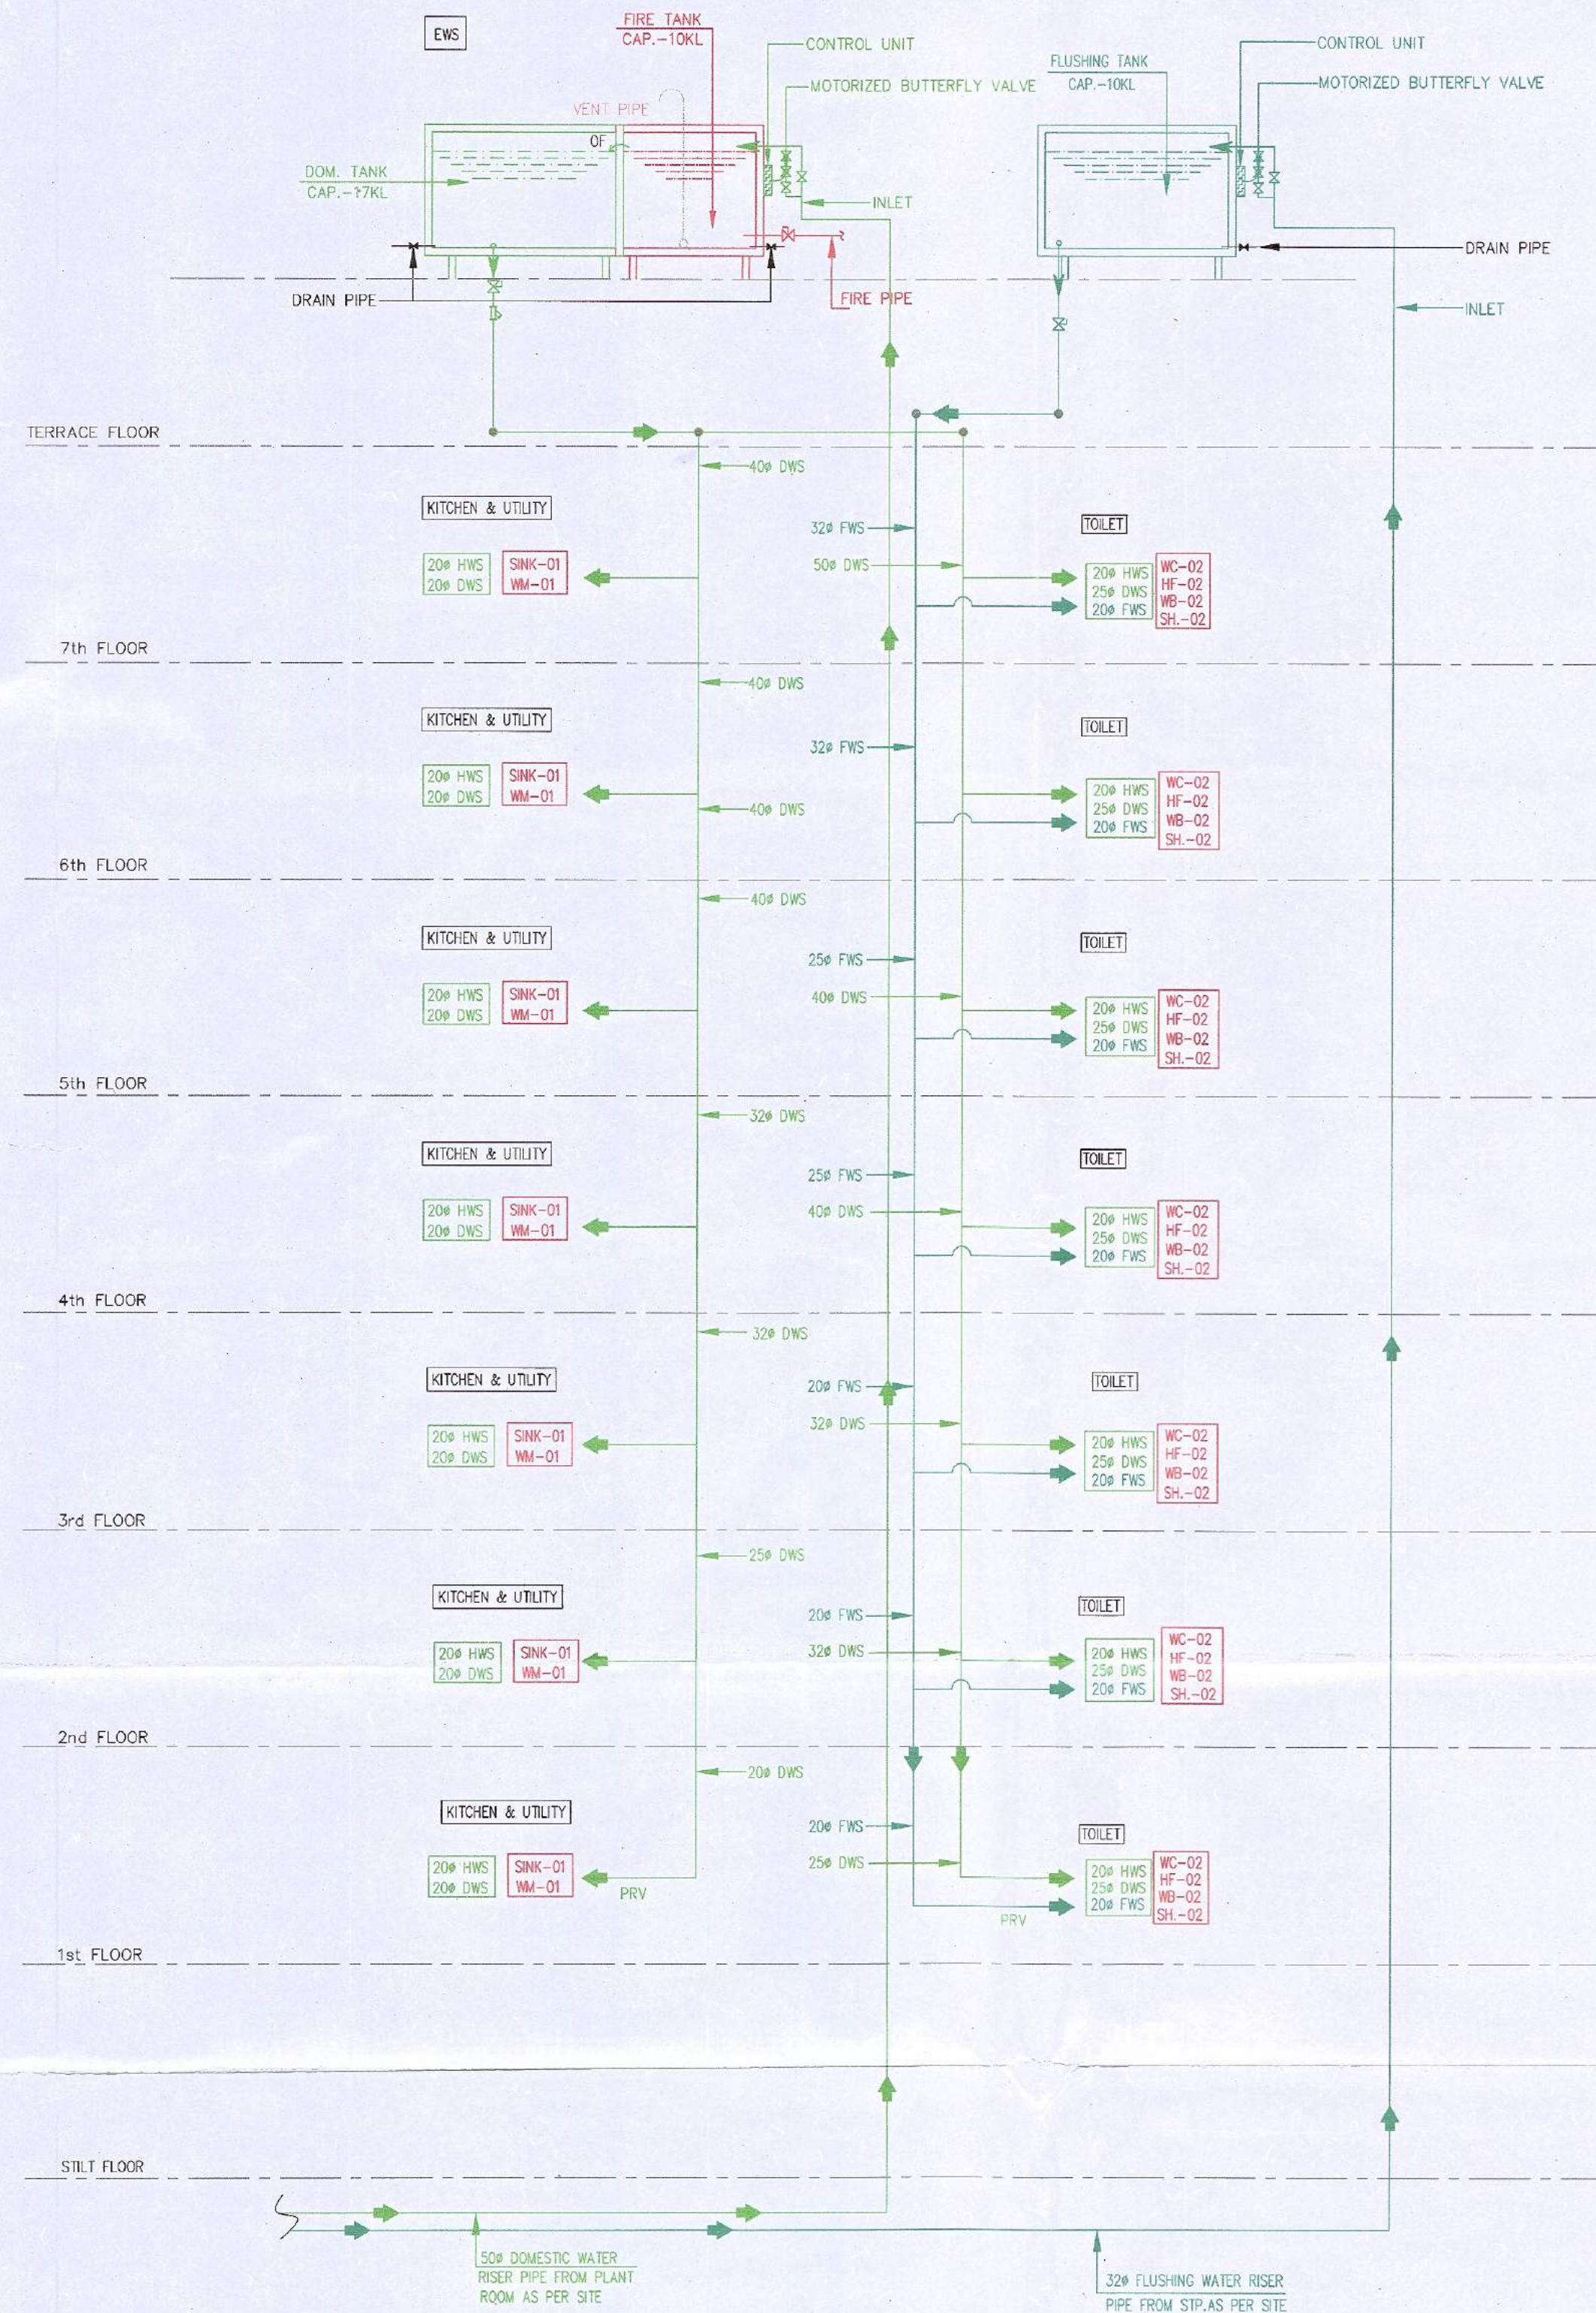

PLUMBING LEGENDS:-

DWS	DOMESTIC WATER SUPPLY
FWS	FLUSHING WATER SUPPLY
DWR	DOMESTIC WATER RISER
FWR	FLUSHING WATER RISER
HWS	HOT WATER SUPPLY
BWS	DOMESTIC WATER SUPPLY FOR BOOSTER PUMP
BV	UP TO 40# BALL VALVE / ABOVE 40# BUTTERFLY VALVE
PRV	PRESSURE RELIEF VALVE
G	GEYSER
BFV	BUTTERFLY VALVE
NRV	NON-RETURN VALVE

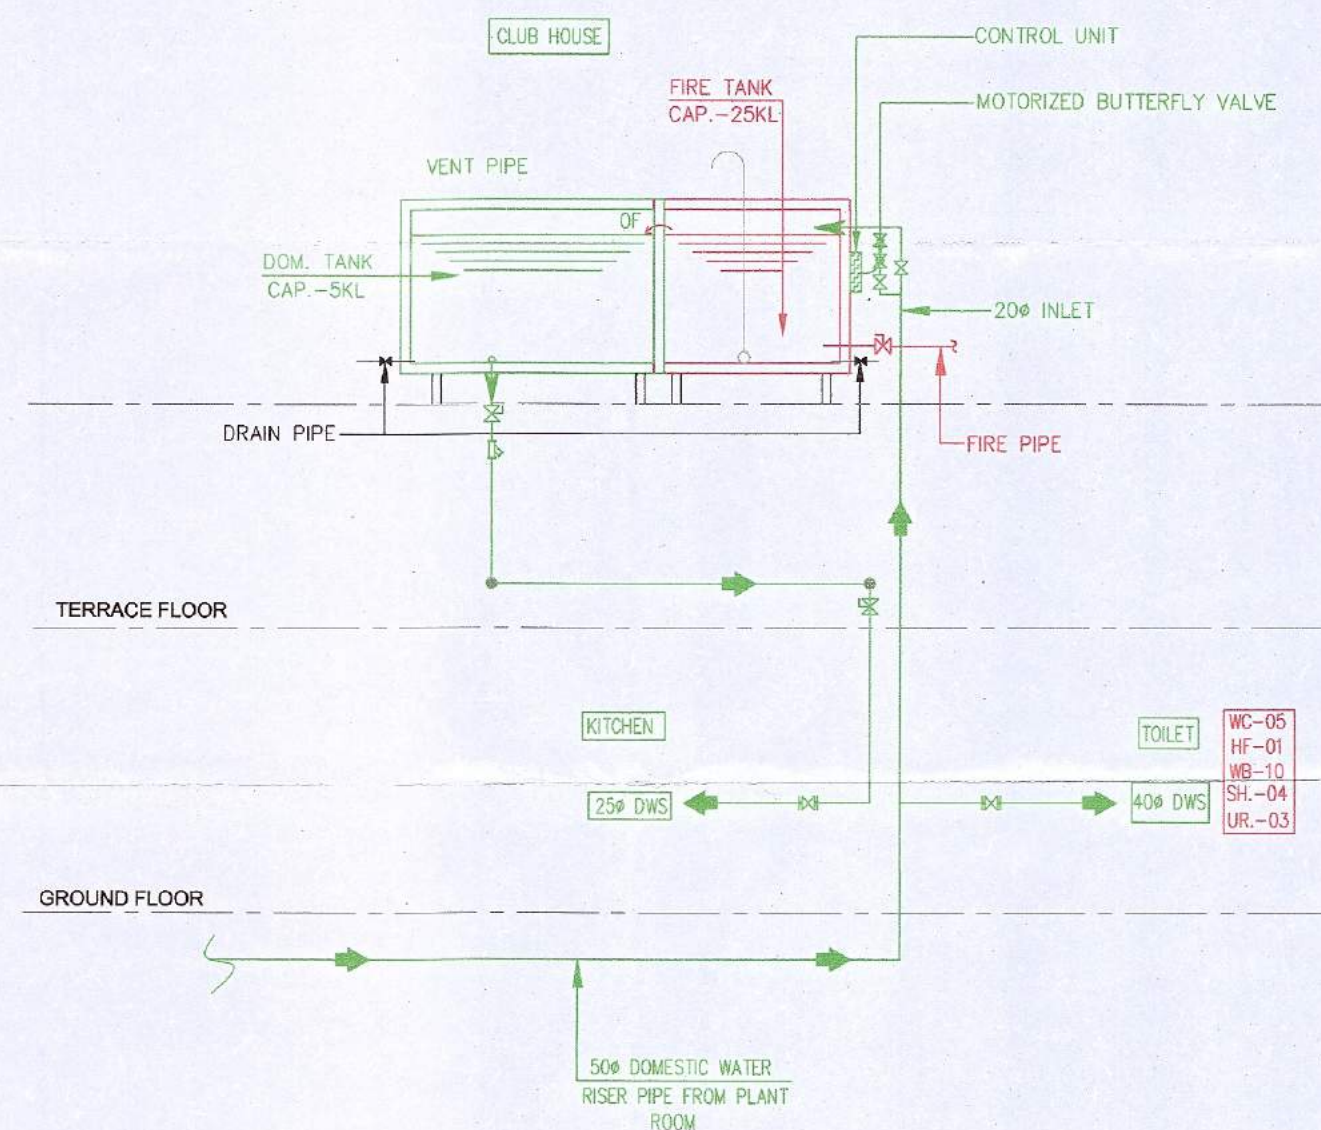

Checked and found ok for Public Health
(Internal) Service only subject to comments in
in forwarding letter No. 77490...D.V. 2-5-2023

Superintending Engineer (HQ)
for Chief Engineer-I
H.S. Panchkula
Solw-2) mem

SANCTIONED
TO BE READ WITH THIS OFFICE
MEMO NO.: 22966
DATED: 12-07-2023

Architect (HQ) D.T.P. (HQ) S.T.P. (HQ) S.T.P. (G) T.P. (M)
Member Member Member Chairman
B.P.A.C. B.P.A.C. B.P.A.C. B.P.A.C.
ATP (HQ) Ram Avtar Bassi
AD PA APD JD (HQ)

PROJECT:-

PROPOSED GROUP HOUSING SITE MEASURING 9.53 ACRES IN RESIDENTIAL PLOTTED COLONY MEASURING 177.86 ACRES (LICENSE NO. 10 OF 2009 DATED 22.12.2011 & LICENSE NO. 117 OF 2011 DATED 23.08.2022) IN SECTOR 85 & 62, GURUGRAM BEING DEVELOPED BY ACTIVE PROMOTERS AND OTHERS IN COLLABORATION WITH EMAAR INDIA LTD (FORMERLY KNOWN AS EMAAR MGF LAND LTD)

ARCHITECT:-

DSP DSP DESIGN ASSOCIATES PVT. LTD.
Architects & Interior Designers

4th Floor, Deshbandh House, Shiv Sagar Estate, Dr. Ambedkar Road, Opposite Metro Centre, Vasant Vihar, New Delhi-110025
Tel: +91 22 4815 1800
Web: www.dspdesign.co.in

Associate Architects

RISMS ARCHITECTS

RSMS ARCHITECTS PVT. LTD.
69, Nora Niwas, Bhawani Kunj (Behind D2), Vasant Kunj, New Delhi-110070.
Tel.: 011-26898616, 26898617
www.rsms-arch.com

OWNER'S SEAL & SIGNATURE



ARCHITECT'S SEAL & SIGNATURE

FOR DSP
Manmeet Singh Bala
Architect (B.Arch, MCAI)
CA/2003/30548

FEB.-2023. Scale: 1:100

Drawing Title:-

SCHEMATIC DIAGRAM (EWS & CLUB)

Drawing No:-

SLD-05