
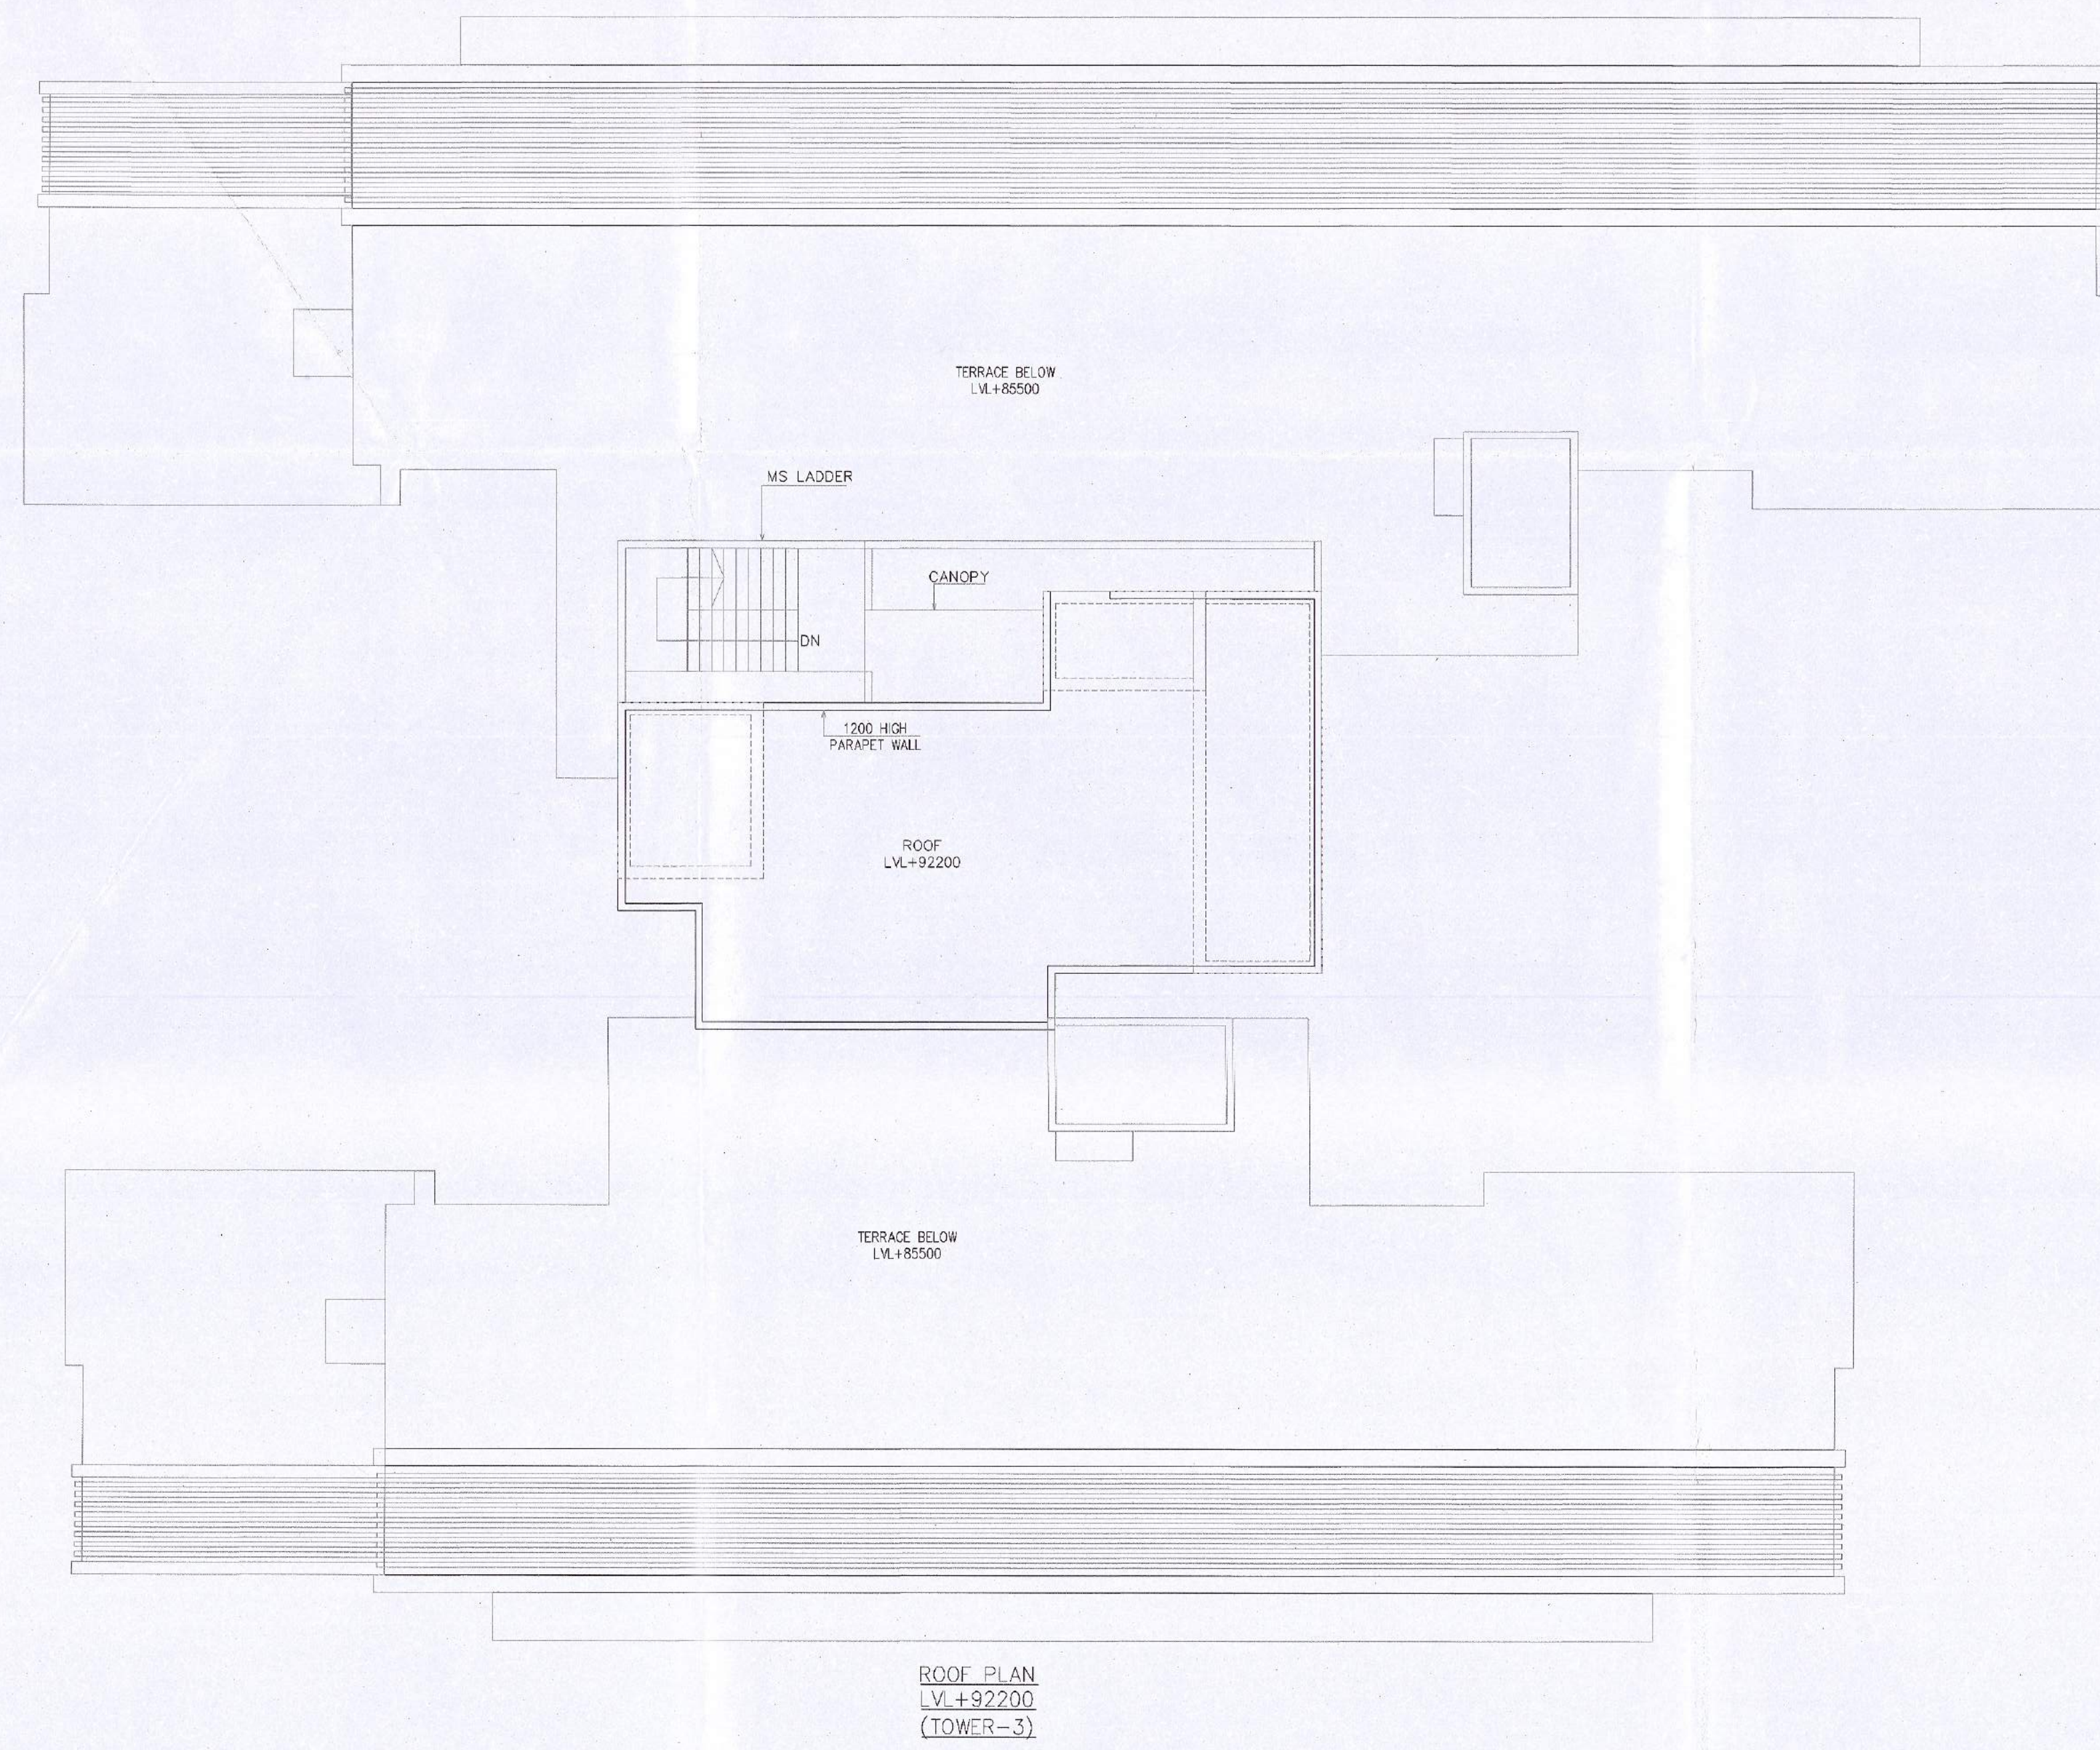
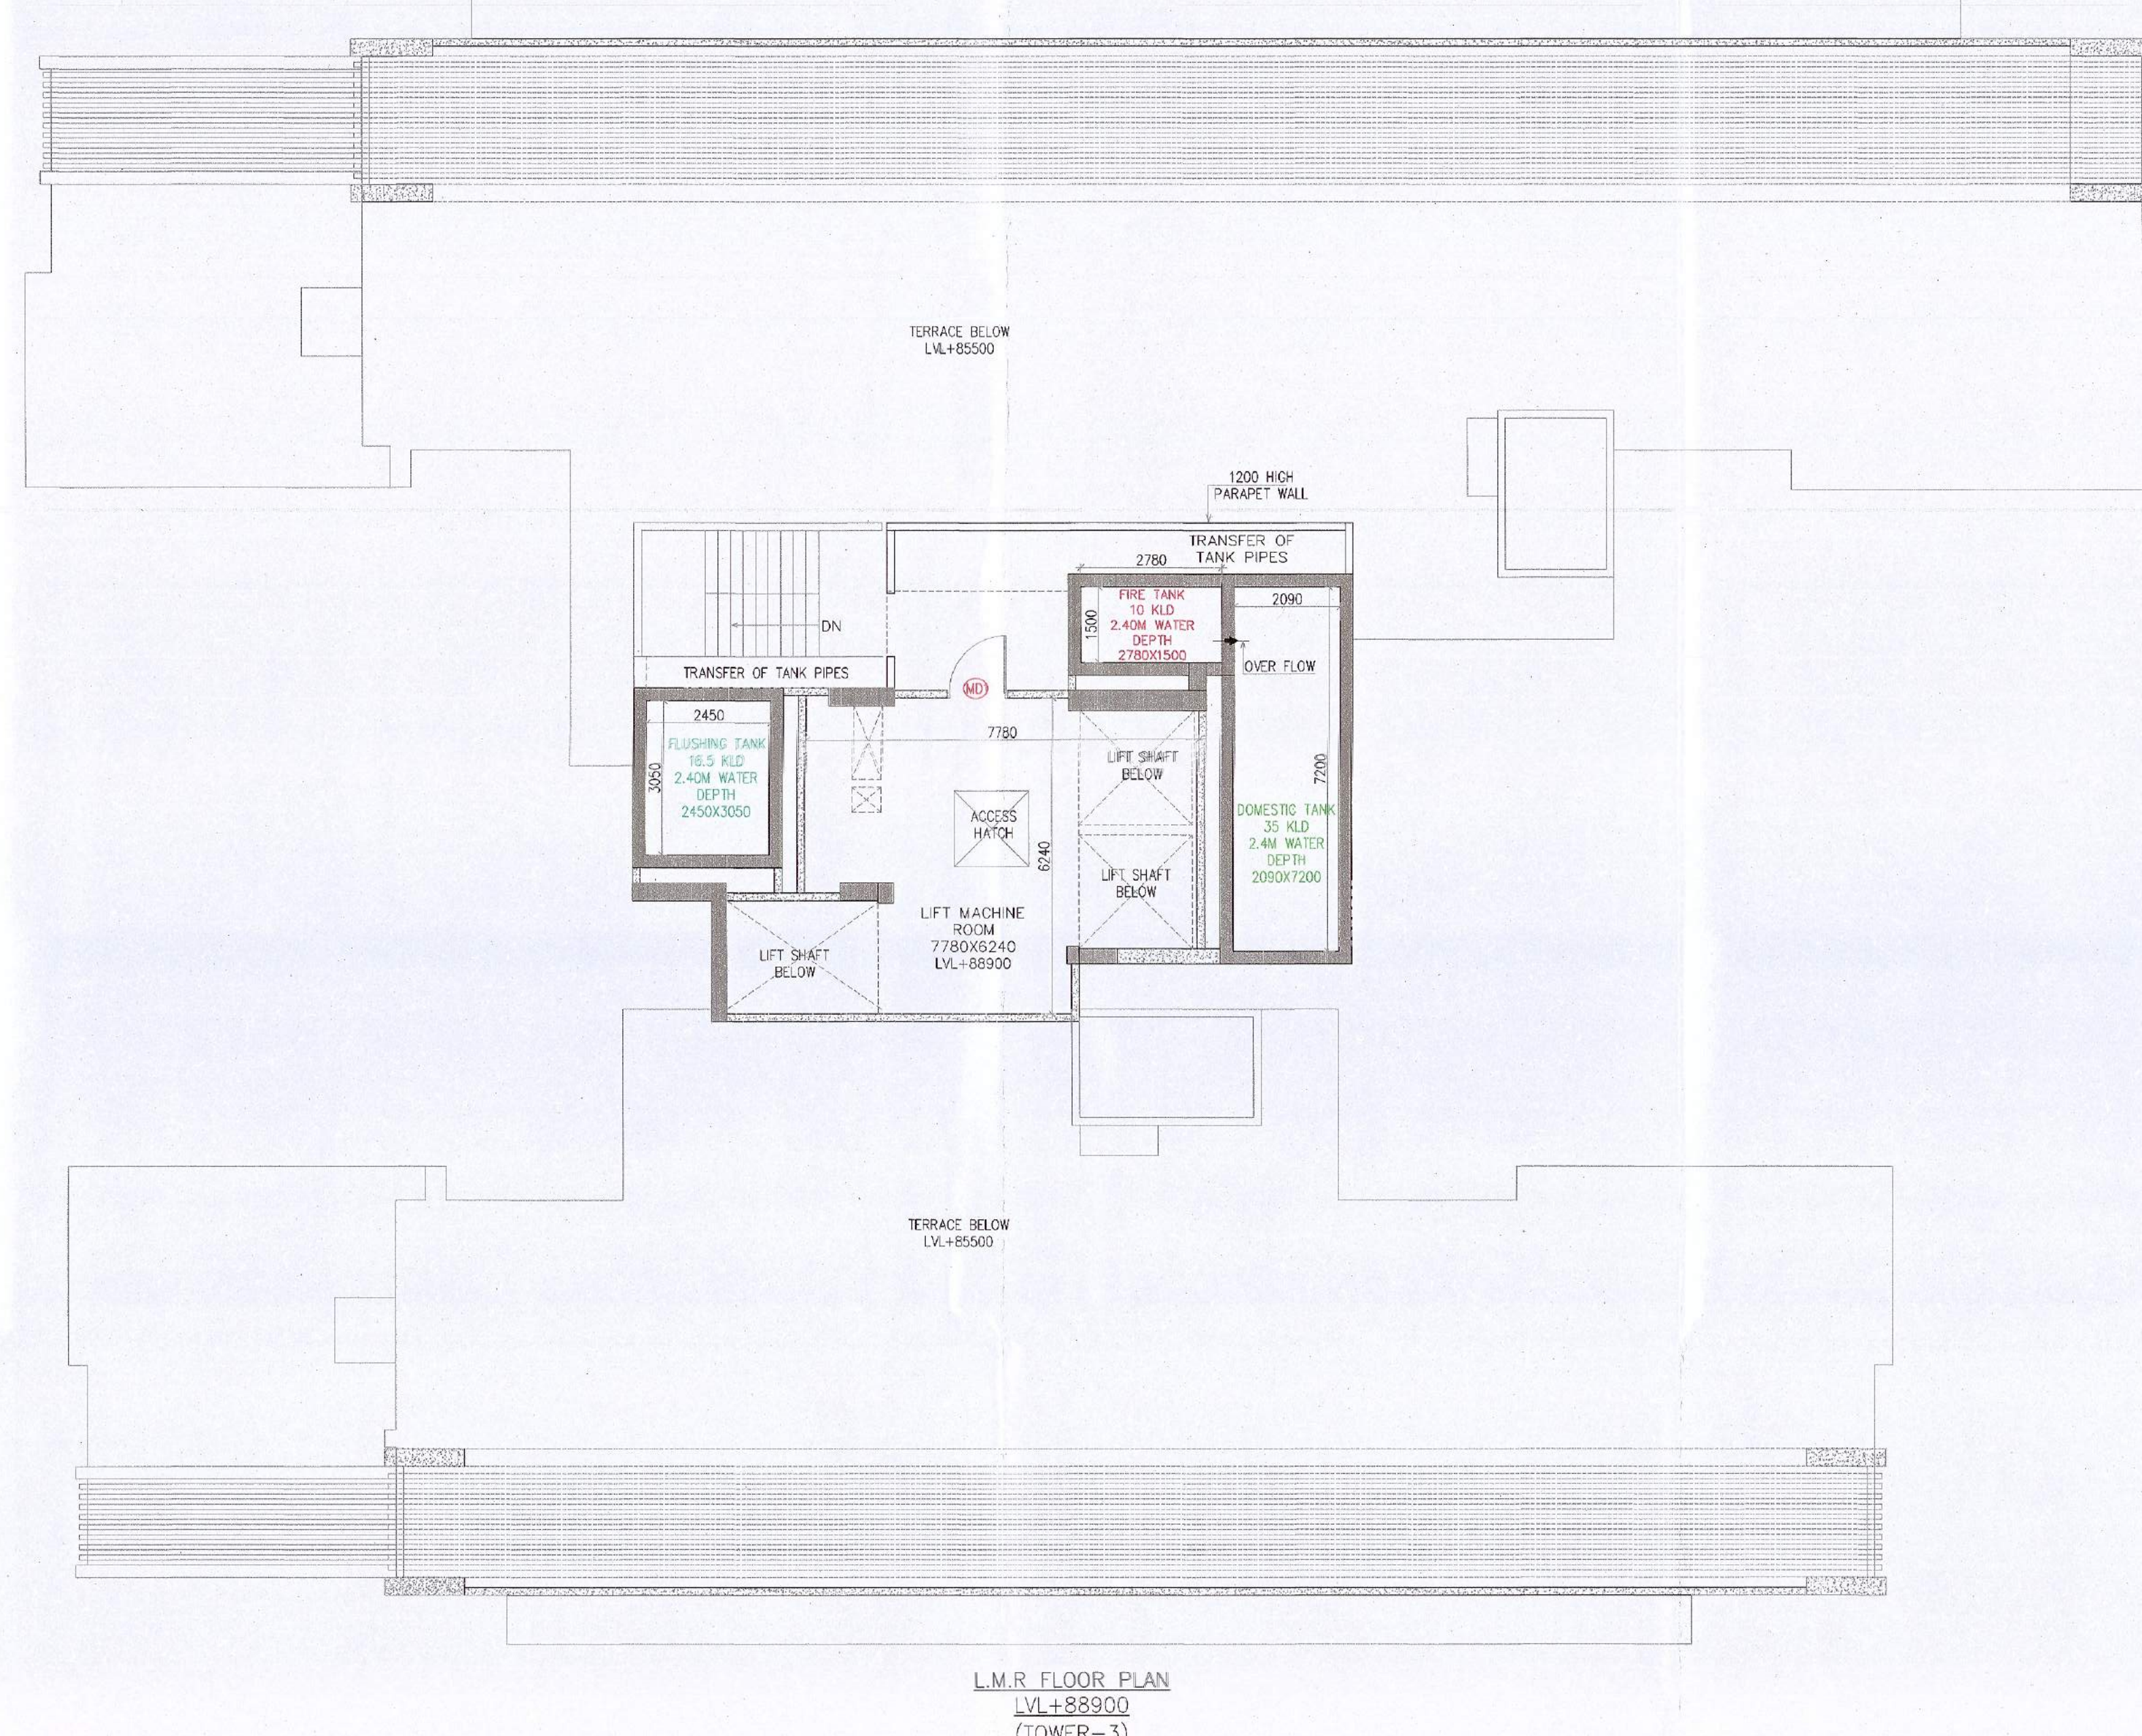


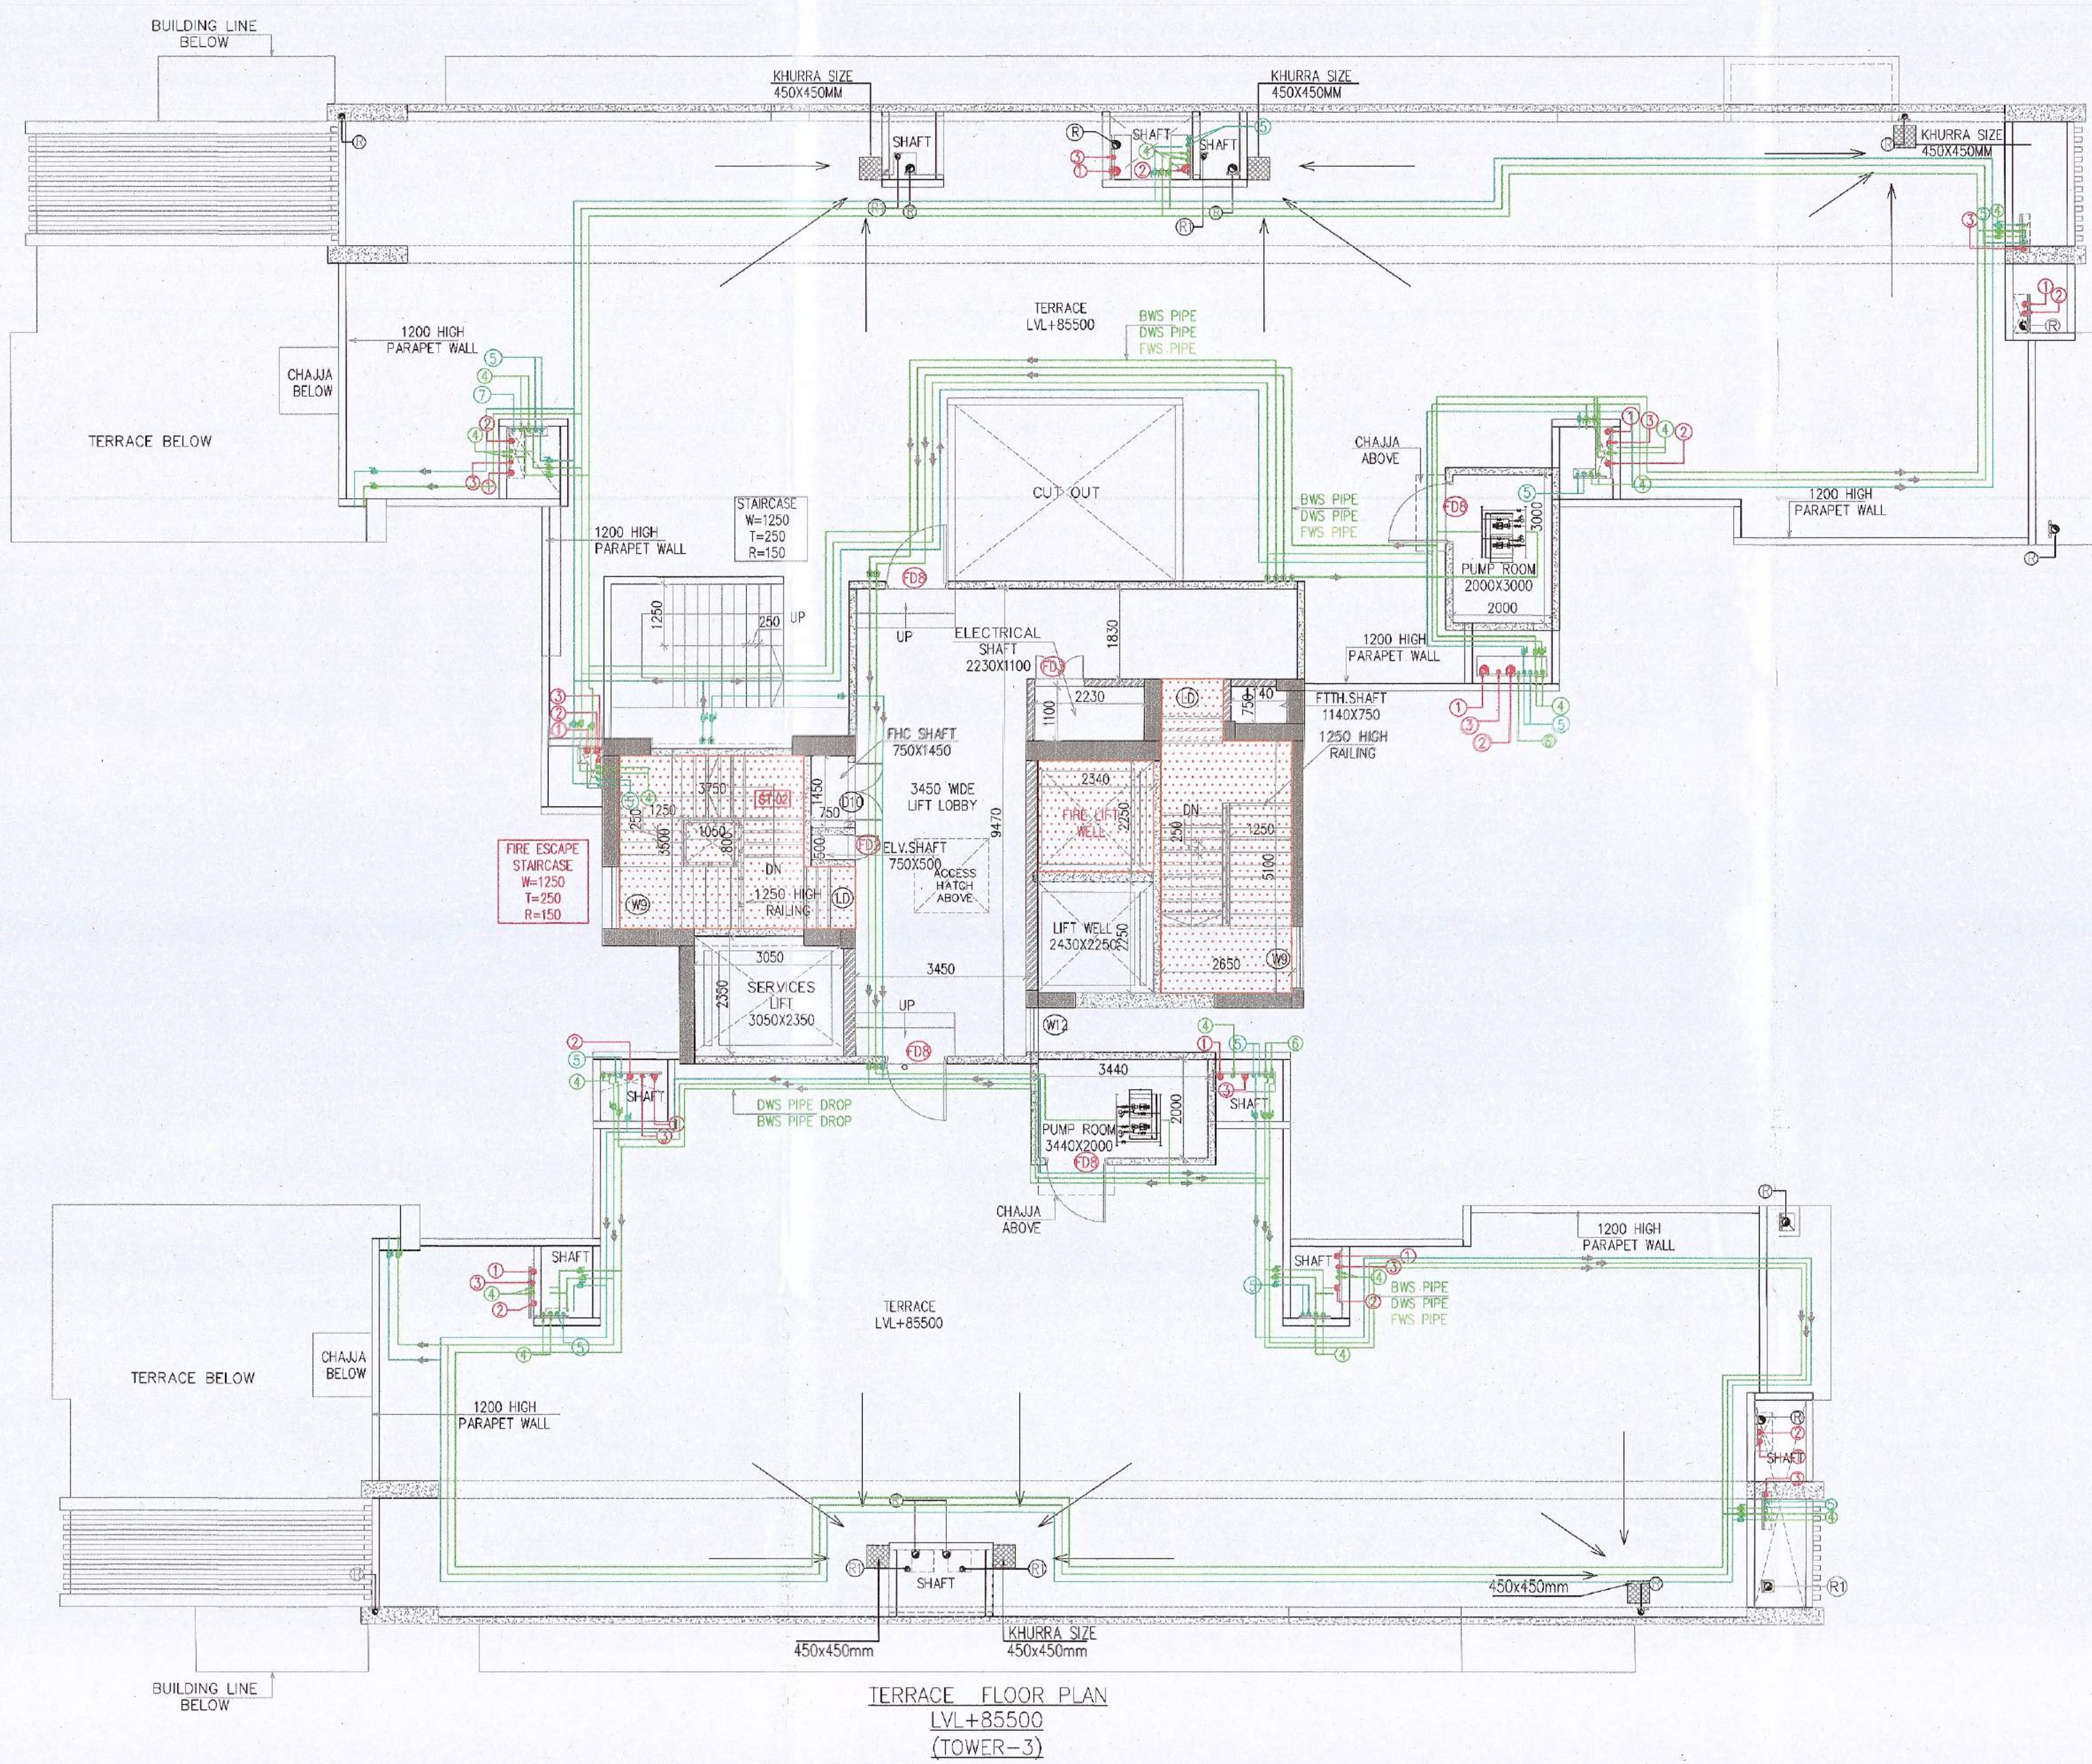

Door Schedule (Terrace)					
Type	Mark	Opening Width	Height	SI Height	Head Height
TD-8		1250	2130	50	2180
TD-3		1050	2130	230	2360
TD-2		500	2130	230	2360
TD-10		1200	2130	230	2360
TD-11		800	2130	230	2360

Window Schedule (Terrace)					
Type	Mark	Opening Width	Height	SI Height	Head Height
W-9		1250	1530	845	2375
W-13		1000	1180	1180	2365

Door Schedule (L.M.R.)					
Type	Mark	Opening Width	Height	SI Height	Head Height
MD-1		1250	2365	0	2365

PLUMBING LEGEND:-	
1	110 OD SOL PIPE
2	110 OD WASTE PIPE
3	75 OD AIR VENT PIPE
4	DOMESTIC WATER SUPPLY PIPE
5	FLUSHING WATER SUPPLY PIPE
6	DOMESTIC WATER RESER PIPE TO OUT
7	FLUSHING WATER RESER PIPE TO OUT
8	110 OD RAIN WATER PIPE
R1	160 OD RAIN WATER PIPE
FT	FLOOR TRAP OUTLET
FD	FLOOR DRAIN
BD	BALCONY DRAIN
MT	MULTI FLOOR TRAP

PLUMBING LEGEND:-	
DWS	DOMESTIC WATER SUPPLY
FWS	FLUSHING WATER SUPPLY
DWR	DOMESTIC WATER RESER
FWR	FLUSHING WATER RESER
HWS	HOT WATER SUPPLY
BWS	DOMESTIC WATER SUPPLY FOR BOOSTER PUMP
BY	UP TO 400 BALL VALVE / ABOVE 400 BUTTERFLY VALVE

Checked and found ok for Public Health (Sanitary) Service only subject to comments in forwarding letter No. 773410, Dv. 66-05-2023

For Civil Engineer (Sanitary) Member BPAC

SACTIONED TO BE READ WITH THIS OFFICE MEMO NO: 22966 DATED: 12-07-2023

For Civil Engineer (Sanitary) Member BPAC

OWNER'S SEAL & SIGNATURE

ARCHITECT'S SEAL & SIGNATURE

FOR DSP

Mammet Singh Bhat

FEB.-2023. Scale : 1:100 EMD-62

Drawing Title:- TERRACE, L.M.R FLOOR & ROOF PLAN (TOWER-3)

Drawing No:- T3-03

Note :-

- BUILDING WILL BE DESIGNED (STRUCTURES) AS PER RELEVANT IS CODES FOR EARTH QUAKE RESISTANCE.
- BUILDING IS HAS AUTOMATIC SPRINKLER SYSTEM ON ALL FLOORS.

LEGEND:-

PROJECT:-

PROPOSED GROUP HOUSING SITE MEASURING 9.53 ACRES IN RESIDENTIAL PLOTTED COLONY MEASURING 177.86 ACRES/LICENSE NO. 10 OF 2009 DATED DT.21.05.2009, LICENSE NO. 113 OF 2011 DATED 22.12.2011 & LICENSE NO. 117 OF 2022 DATED 23.08.2022) IN SECTOR 65 & 62, GURUGRAM BEING DEVELOPED BY ACTIVE PROMOTERS AND OTHERS IN COLLABORATION WITH EMAAR INDIA LTD (FORMERLY KNOWN AS EMAAR MGF LAND LTD)

ARCHITECT:

DSP DSP DESIGN ASSOCIATES PVT. LTD. Architects & Interior Designers

6th Floor, Convent House, Shiv Dagar Estate, D-Annex, Besant Road, Opposite Nehru Centre, West, Mumbai - 400 018. Tel: 181 22 4915 1800. Web: www.dspdesign.co.in

MUMBAI • BENGALURU • PUNE • NEW DELHI • HYDERABAD

Associate Architects

RISIMIS ARCHITECTS

RSMS ARCHITECTS PVT. LTD. 69, Nore Niwas, Bhawani Kunj (Behind D2), Vasant Kunj, New Delhi-110070. Tel.: 011-26898616, 26898617 www.rsms-arch.com