



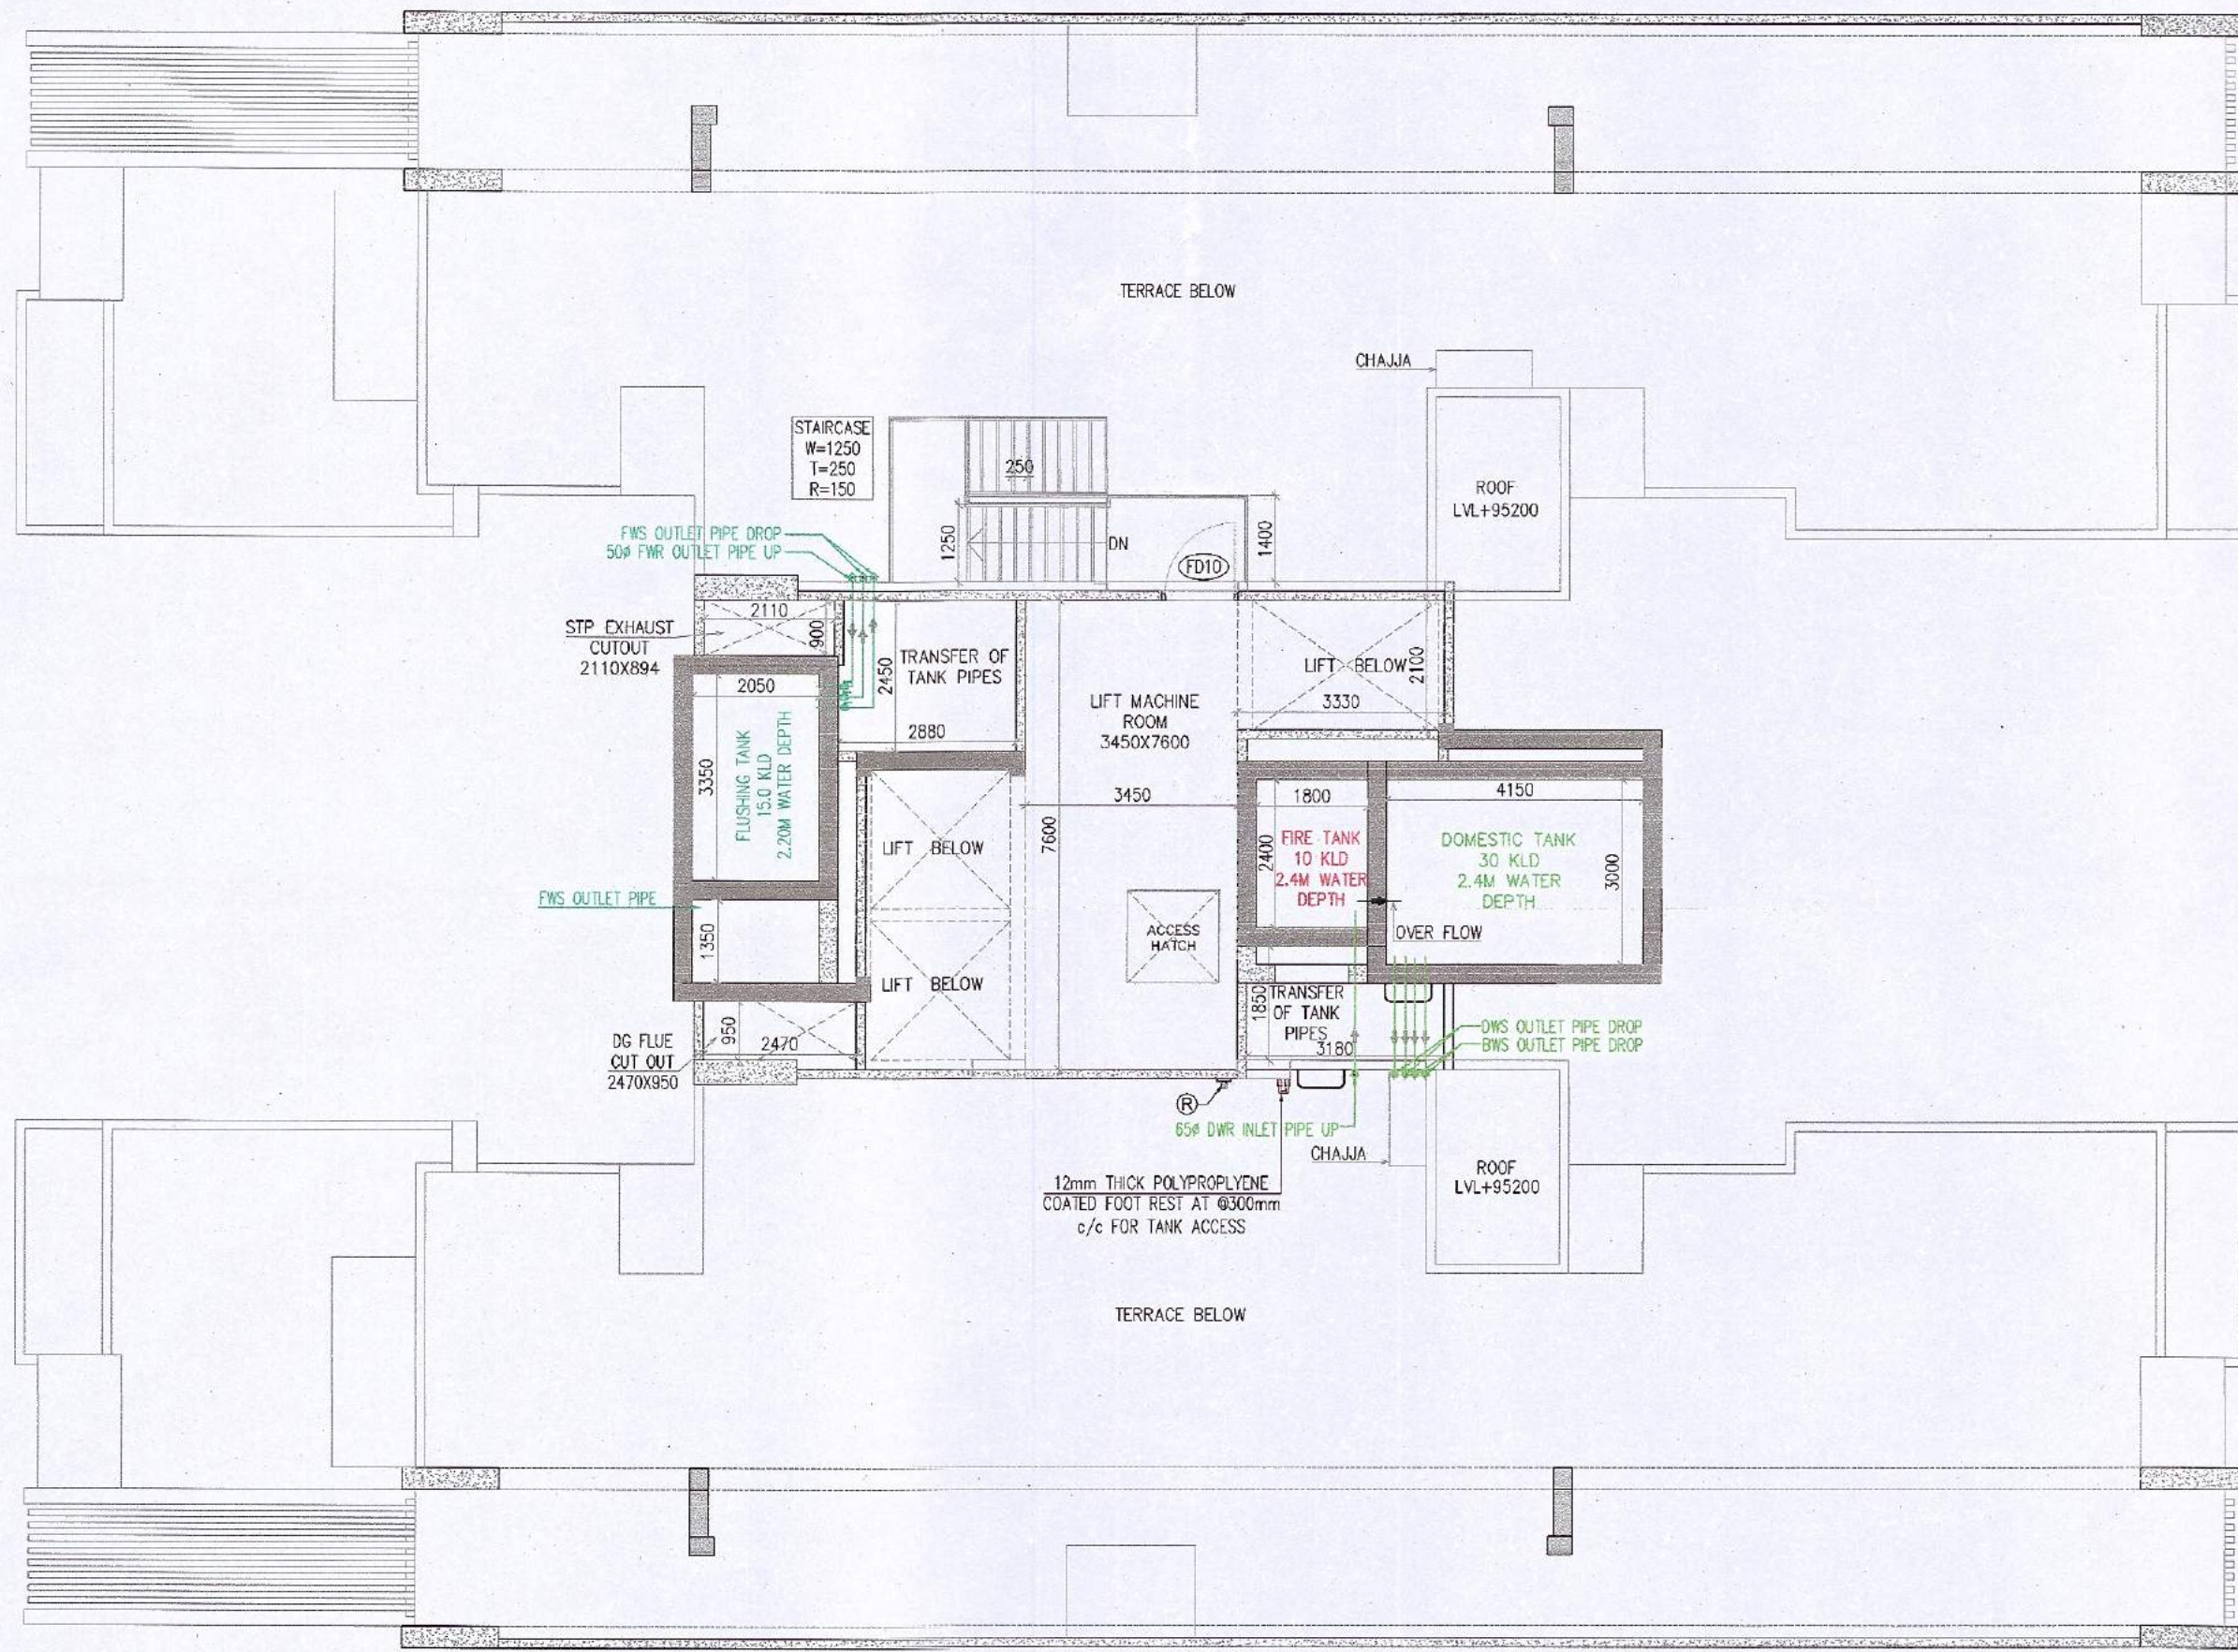

LIFT MACHINE ROOM PLAN  
(TOWER-2) LVL+94050  
(TOWER-4) LVL+95100

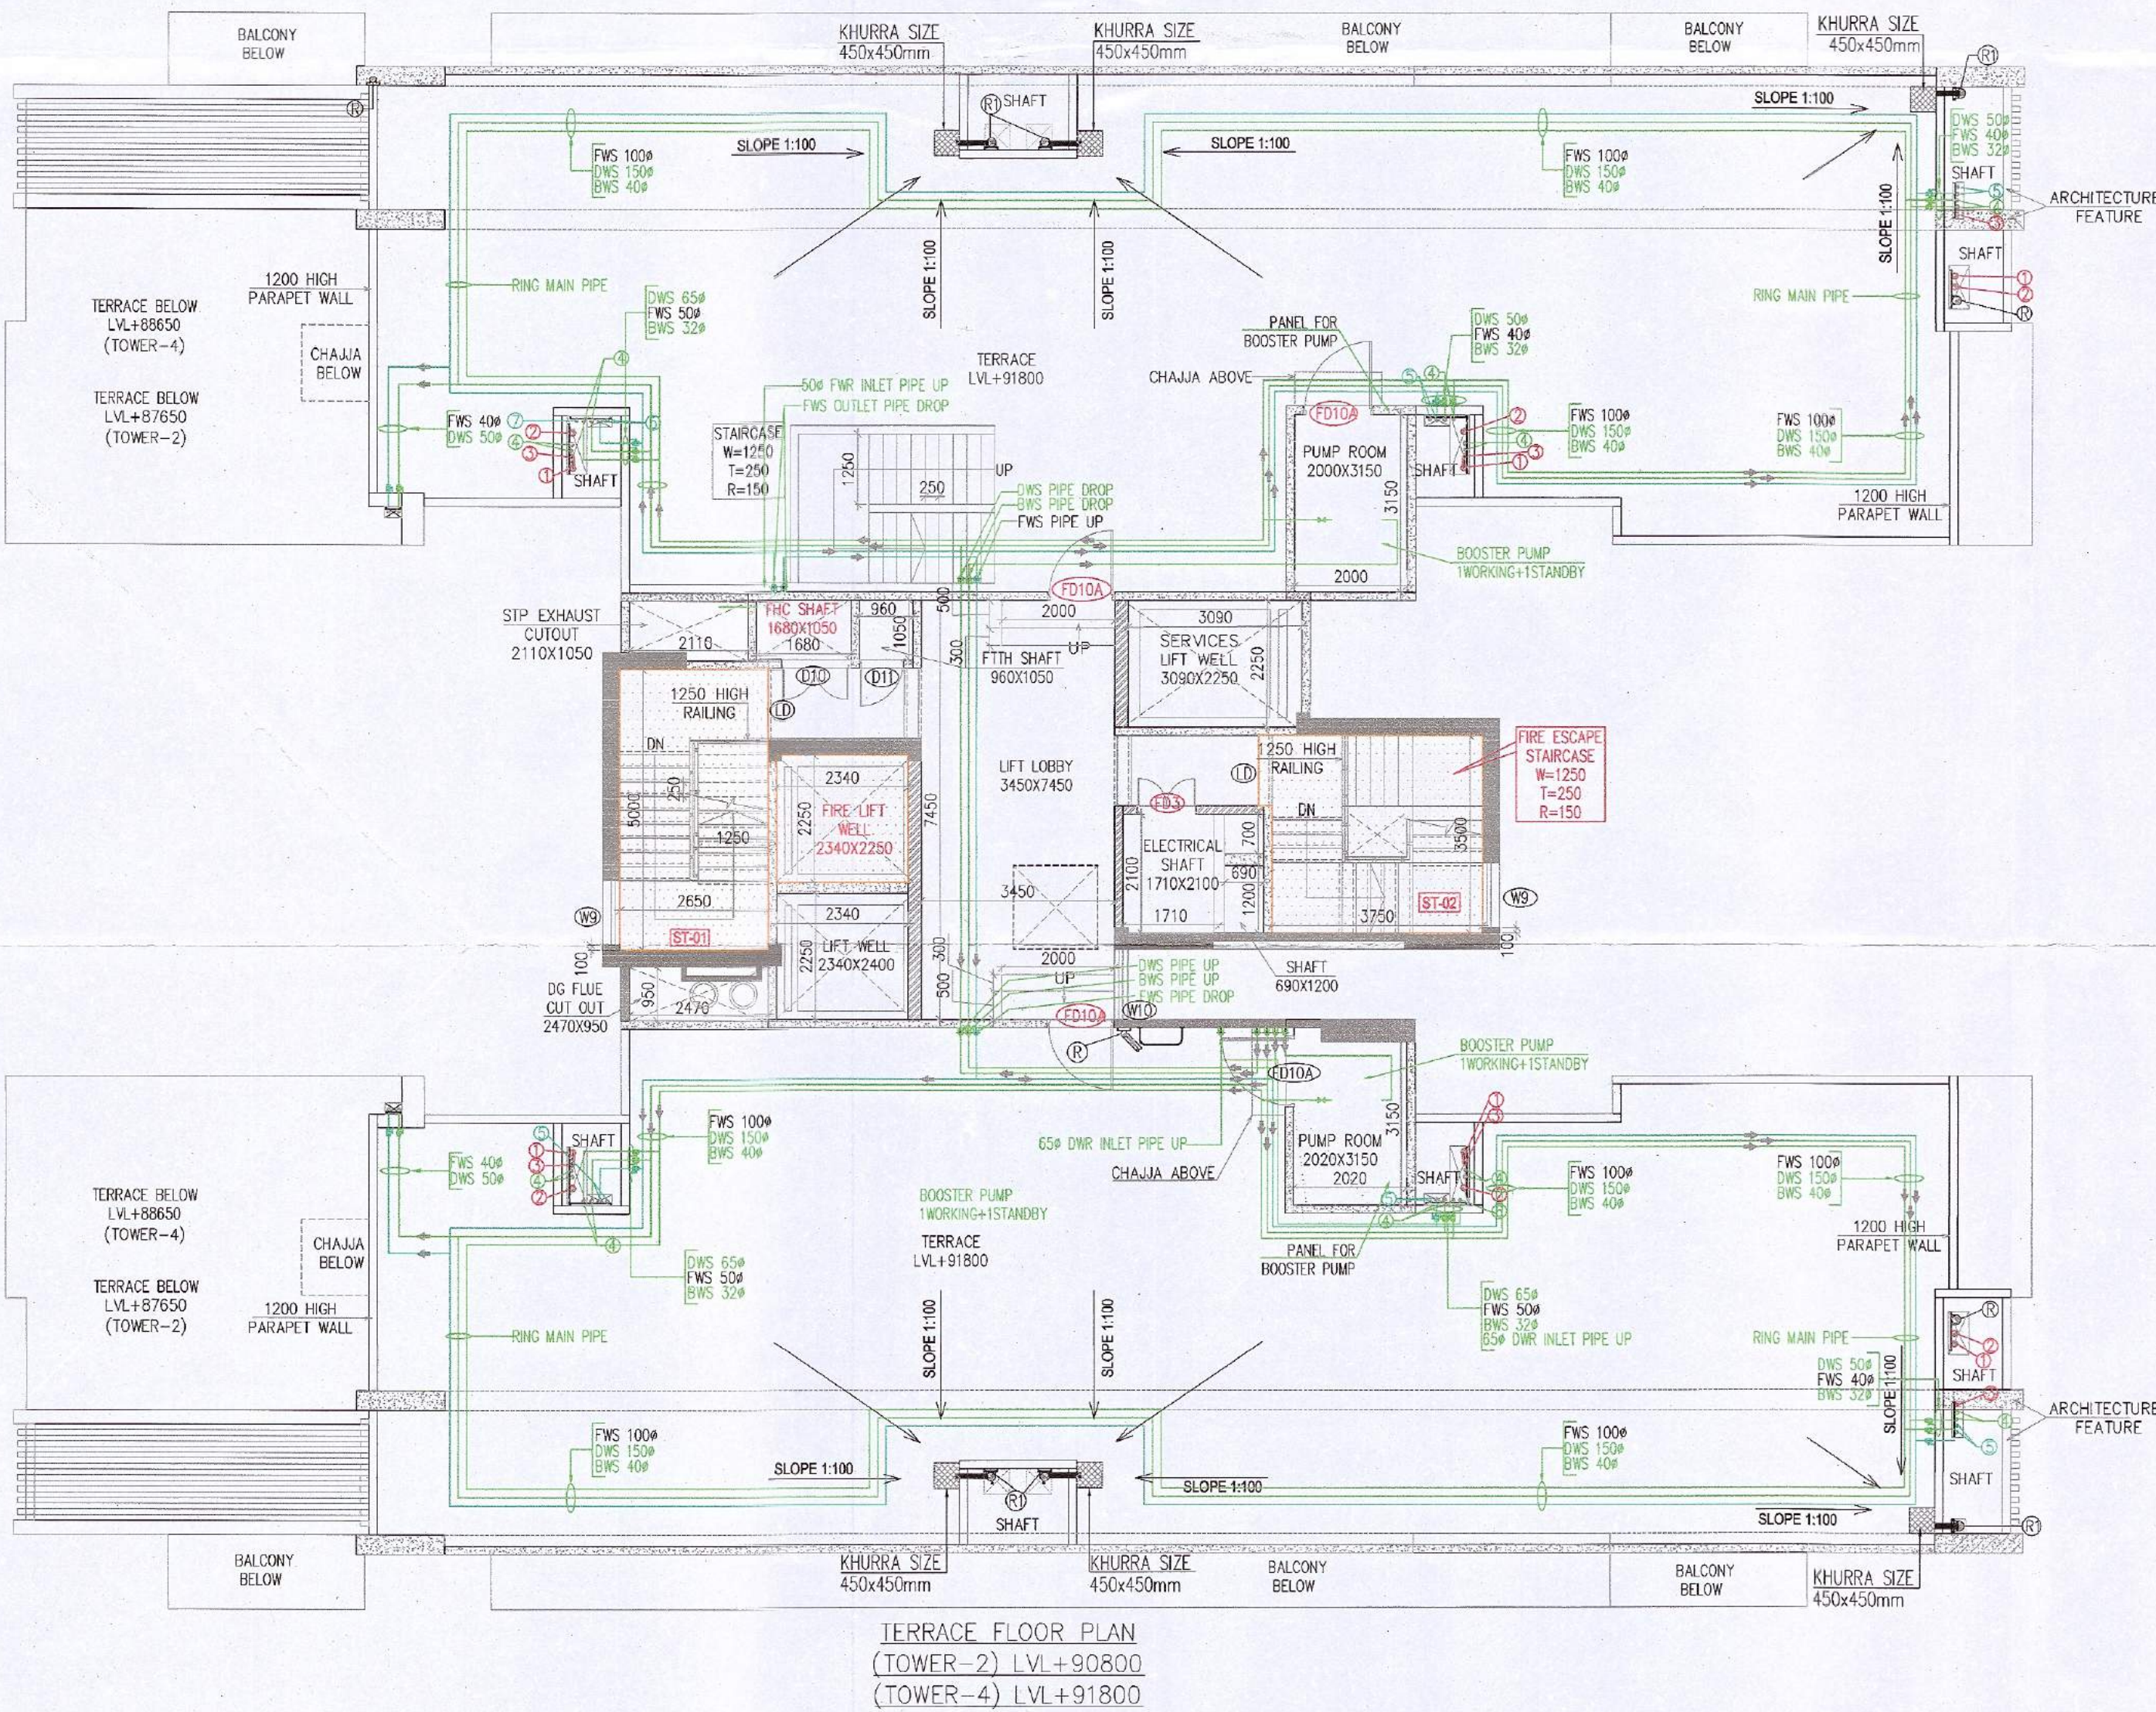

TERRACE FLOOR PLAN  
(TOWER-2) LVL+90800  
(TOWER-4) LVL+91800

PLUMBING LEGEND:-

|     |                                  |  |
|-----|----------------------------------|--|
| 1   | 110 OD SOIL PIPE                 |  |
| 2   | 110 OD WASTE PIPE                |  |
| 3   | 75 OD ANTI VENT PIPE             |  |
| 4   | DOMESTIC WATER SUPPLY PIPE       |  |
| 5   | FLUSHING WATER SUPPLY PIPE       |  |
| 6   | DOMESTIC WATER RISER PIPE TO OHT |  |
| 7   | FLUSHING WATER RISER PIPE TO OHT |  |
| R   | 110 OD RAIN WATER PIPE           |  |
| R1  | 160 OD RAIN WATER PIPE           |  |
| FT  | FLOOR TRAP CUTOUT                |  |
| FD  | FLOOR DRAIN                      |  |
| BD  | BALCONY DRAIN                    |  |
| MFT | MULTY FLOOR TRAP                 |  |

PIPE CONNECTION DIA :-

|                    |                        |
|--------------------|------------------------|
| WC TO TO STACK     | 110 OD uPVC SOIL PIPE  |
| URINAL BASIN TO UT | 50 OD uPVC SOIL PIPE   |
| UT TO STACK        | 110 OD uPVC SOIL PIPE  |
| WASH BASIN TO FT   | 40 OD uPVC WASTE PIPE  |
| FT TO STACK        | 110 OD uPVC WASTE PIPE |
| FD TO FT           | 63 OD uPVC WASTE PIPE  |
| SINK TO FT         | 50 OD uPVC WASTE PIPE  |

PIPE SLOPE TABLE :-

|                          |              |
|--------------------------|--------------|
| 160 OD SOIL & WASTE PIPE | SLOPE- 1:100 |
| 110 OD SOIL & WASTE PIPE | SLOPE- 1:70  |

PLUMBING LEGEND:-

|     |                                                  |
|-----|--------------------------------------------------|
| DWS | DOMESTIC WATER SUPPLY                            |
| FWS | FLUSHING WATER SUPPLY                            |
| DWR | DOMESTIC WATER RISER                             |
| FWR | FLUSHING WATER RISER                             |
| BWS | DOMESTIC WATER SUPPLY FOR BOOSTER PUMP           |
| BV  | UP TO 40# BALL VALVE / ABOVE 40# BUTTERFLY VALVE |

Door Schedule (Terrace)


| Type Mark | OPENING Width | Height | Sill Height | Head Height | Location                          | Description                |
|-----------|---------------|--------|-------------|-------------|-----------------------------------|----------------------------|
| FD-10A    | 1250          | 2130   | 50          | 2180        | TERRACE LOBBY & TERRACE PUMP ROOM | FIRE DOOR (2HR FIRE RATED) |
| FD-3      | 1050          | 2130   | 235         | 2365        | ELECTRICAL SHAFT                  | FIRE DOOR (2HR FIRE RATED) |
| D-10      | 1200          | 2130   | 235         | 2365        | FTH SHAFT                         | METAL DOOR                 |
| D-11      | 800           | 2130   | 235         | 2365        | FTH SHAFT                         | METAL DOOR                 |

Window Schedule (Terrace)

| Type Mark | OPENING Width | Height | Sill Height | Head Height | Location   | Description               |
|-----------|---------------|--------|-------------|-------------|------------|---------------------------|
| W-09      | 1250          | 1530   | 845         | 2375        | STAIRCASE  | ALUMINIUM LOUVERED WINDOW |
| W-10      | 1250          | 1180   | 1185        | 2365        | LIFT LOBBY | ALUMINIUM LOUVERED WINDOW |

Door Schedule (Lift)

| Type Mark | OPENING Width | Height | Sill Height | Head Height | Location  | Description   |
|-----------|---------------|--------|-------------|-------------|-----------|---------------|
| FD-10     | 1250          | 2365   | 0           | 2365        | STAIRCASE | LOUVERED DOOR |

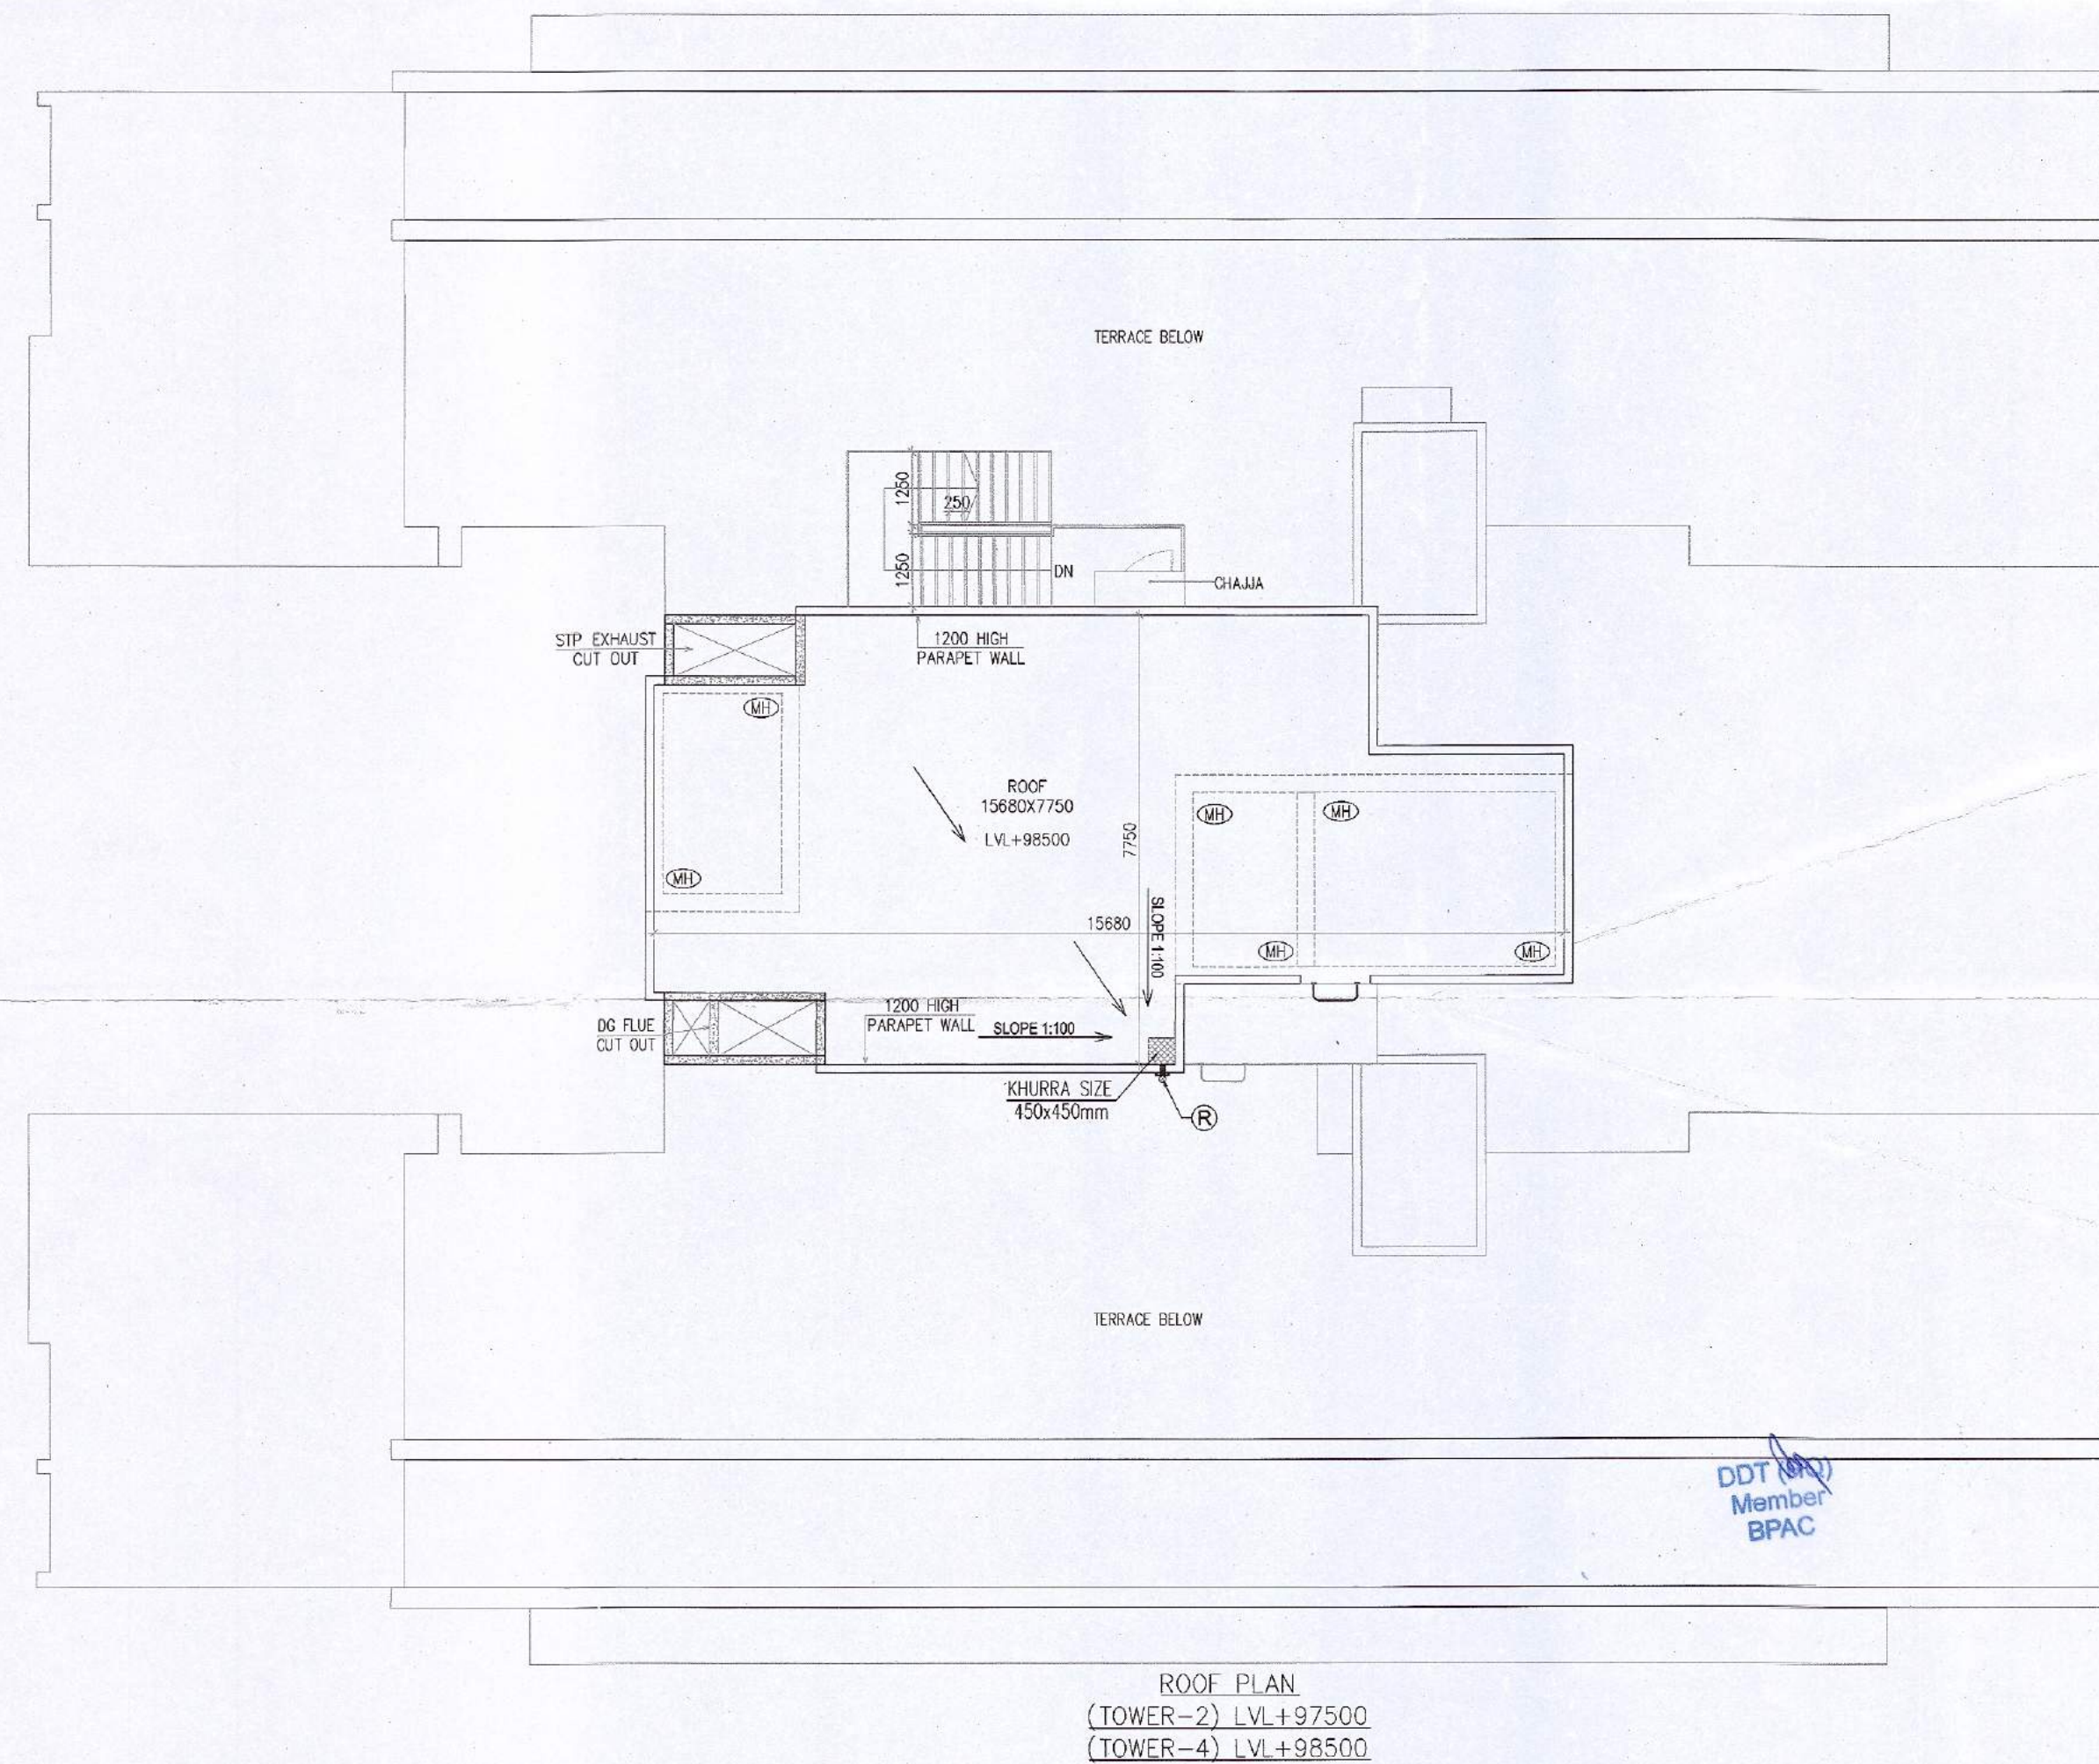

ROOF PLAN  
(TOWER-2) LVL+97500  
(TOWER-4) LVL+98500

Checked and found ok for Public Health  
(Internal) Service only subject to comments in  
in forwarding letter No. 97710.DV.06-05-2023

SANCTIONED  
TO BE READ WITH THIS OFFICE  
MEMO NO.: 22966  
DATED: 12-07-2023

Superintendent Engineer (HQ)  
for Chief Engineer-I  
H. Panigrahi  
M. A. S. Panigrahi

Architect (HQ) B.P.A.C. Member  
S.T.P. (HQ) B.P.A.C. Member Secretary  
S.T.P. (G) B.P.A.C. Member  
S.T.P. (G) B.P.A.C. Chairman  
Ram Avtar Bassi JD(HQ)  
AD PA ATP

Note :-

1. BUILDING WILL BE DESIGNED  
(STRUCTURES)  
AS PER RELEVANT IS CODES FOR EARTH  
QUAKE RESISTANCE.

LEGEND:-

PROJECT:-

PROPOSED GROUP HOUSING SITE MEASURING  
9.53 ACRES IN RESIDENTIAL PLOTTED COLONY  
MEASURING 177.88 ACRES/LICENCE NO. 10 OF  
2009 DATED DT.21.05.2009/LICENCE NO. 113 OF  
2011 DATED 22.12.2011 & LICENSE NO. 117 OF  
2022 DATED 23.08.2022) IN SECTOR 65 &  
62, GURUGRAM BEING DEVELOPED BY ACTIVE  
PROMOTERS AND OTHERS IN COLLABORATION  
WITH EMAAR INDIA LTD (FORMERLY KNOWN AS  
EMAAR MGF LAND LTD)

ARCHITECT:-

DSP DESIGN ASSOCIATES PVT. LTD.  
Architects & Interior Designers

8th Floor, Overland House, B-10, Sector 65, Gurgaon, Haryana, India  
Tel: +91 22 4915 1800  
Web: www.dspsdesigns.com

MUMBAI • BENGALURU • PUNE • NEW DELHI • HYDERABAD

Associate Architects

RSMS ARCHITECTS

RSMS ARCHITECTS PVT. LTD.  
69, Nara Niwas Bhawan Kunj  
(Behind D2), Vasant Kunj,  
New Delhi-110070.  
Tel.: 011-26898616, 26898617  
www.rsms-arch.com

OWNER'S SEAL  
& SIGNATURE

ARCHITECT'S SEAL  
& SIGNATURE

FOR DSP

Manmeet Singh Ball  
Architect (B.Arch, MCA)  
CA2003/00545

FEB-2023

Scale: 1:100

Drawing Title:-

TERRACE PLAN,  
L.M.R FLOOR & ROOF PLAN  
(TOWER 4)

Drawing No:-

T2-03