


IN PRINCIPLE APPROVED NIDE
STP(6) MEMO NO. 1656 DT. 9/3/23.
FINALE APPROVAL GRANTED
NIDE STP(6) MEMO NO. 3004
DT. 01/05/23.

- NOTES:
- ALL LIFTS SHALL HAVE 100% POWER BACK-UP.
 - ALL ELECTRICAL INSTALLATIONS SHALL BE AS PER PROVISION OF NBC.
 - FIRE-FIGHTING / SAFETY PROVISIONS WILL BE AS PER RELEVANT NBC PROVISIONS.
 - BASEMENT AREA SHALL HAVE MECHANICALLY VENTILATED AS PER RELEVANT CODE.
 - ALL TOILETS ARE VENTILATED AS PER HARYANA BUILDING CODE 2017.
 - BUILDING HAS AUTOMATIC SPRINKLER SYSTEM WHEREVER REQUIRED BY NBC.
 - BUILDING WILL BE DESIGNED (STRUCTURES) AS PER RELEVANT I.S. CODES FOR EARTHQUAKE RESISTANCE.
 - SOLAR PANELS OF REQUIRED CAPACITY SHALL BE PROVIDED ON ROOF TOP AS PER HAREDA / ZONING NORMS.
 - ALL HANDICAP RAMPS WITH RAILING.

SCHEDULE OF OPENING (DOORS)

S.NO.	D/W NO.	WIDTH (mm)	CILL (mm)	UNIT (mm)
1	GD1	1200	-	2450
2	GD2	2400	-	2450
3	D1	1200	-	2450
4	D2	1050	-	2450
5	D3	900	-	2450
6	D5	955	-	2450
7	D6	1200	-	2450
8	FD1 2HR FIRE RATING	2000	-	2450

- LEGEND:-
- 100# SOIL & VENT PIPE
 - 100# WASTE & VENT PIPE
 - 100# WASTE & VENT PIPE FOR AHU
 - 100# WASTE & VENT PIPE FOR RESTAURANT
 - 100# ANTISIPHONAGE VENT PIPE
 - DOMESTIC WATER SUPPLY
 - DWS ON TAKE PIPE(DOMESTIC) FOR 5th FLOOR
 - FLUSHING WATER SUPPLY
 - 100# RAIN WATER PIPE
 - 100# RAIN WATER PIPE
 - 100# RAIN WATER PIPE
 - 150# FIRE PIPE
 - 80# DRAIN PIPE

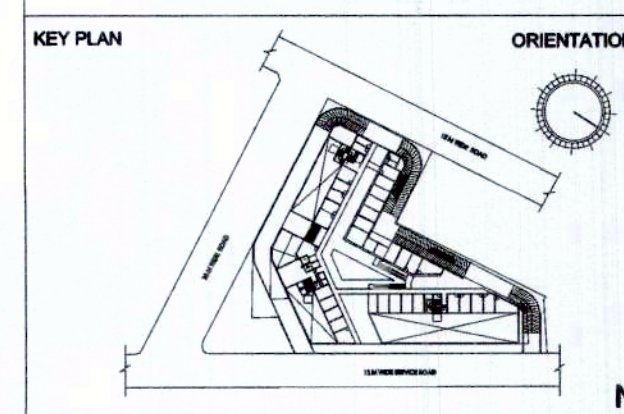

MEP CONSULTANT:
ENVIRONS BUILDING SERVICES
CONSULTANTS
A-14 (Basement), Shivalik,
New Delhi - 110017
Ph : 011 - 41765684
E-mail : environsconsultants@gmail.com

PRINCIPAL ARCHITECT:

ARCOP ASSOCIATES PVT. LTD. ARCOP
A-15, Pamposh Enclave, Greater
Kailash-I, New Delhi-110048

PROJECT:-
REVISED BUILDING PLANS OF COMMERCIAL
SITE-1 ADMEASURING 1.482 ACRES FALLING IN
THE RESIDENTIAL PLOTTED COLONY OF 107.919
ACRES (LICENCE NO 97 OF 2010 DATED
18.11.2010, LICENCE NO 41 OF 2011 DATED
03.05.2011) AT SECTOR-66, GURUGRAM BEING
DEVELOPED BY ELAN CITY LLP

ELAN CITY LLP

Authorised Signatory


ASHU, CA2007M0332
ARCOP Associates Pvt. Ltd.
Plot No. 36B, Sec- 32, Gurgaon-122003

OWNER/AUTH. SIGNATURE

ARCHITECT'S SIGNATURE

DRAWING TITLE
TERRACE & ROOF PLAN

DRAWING NO. A1-24 SCALE :- 1:200

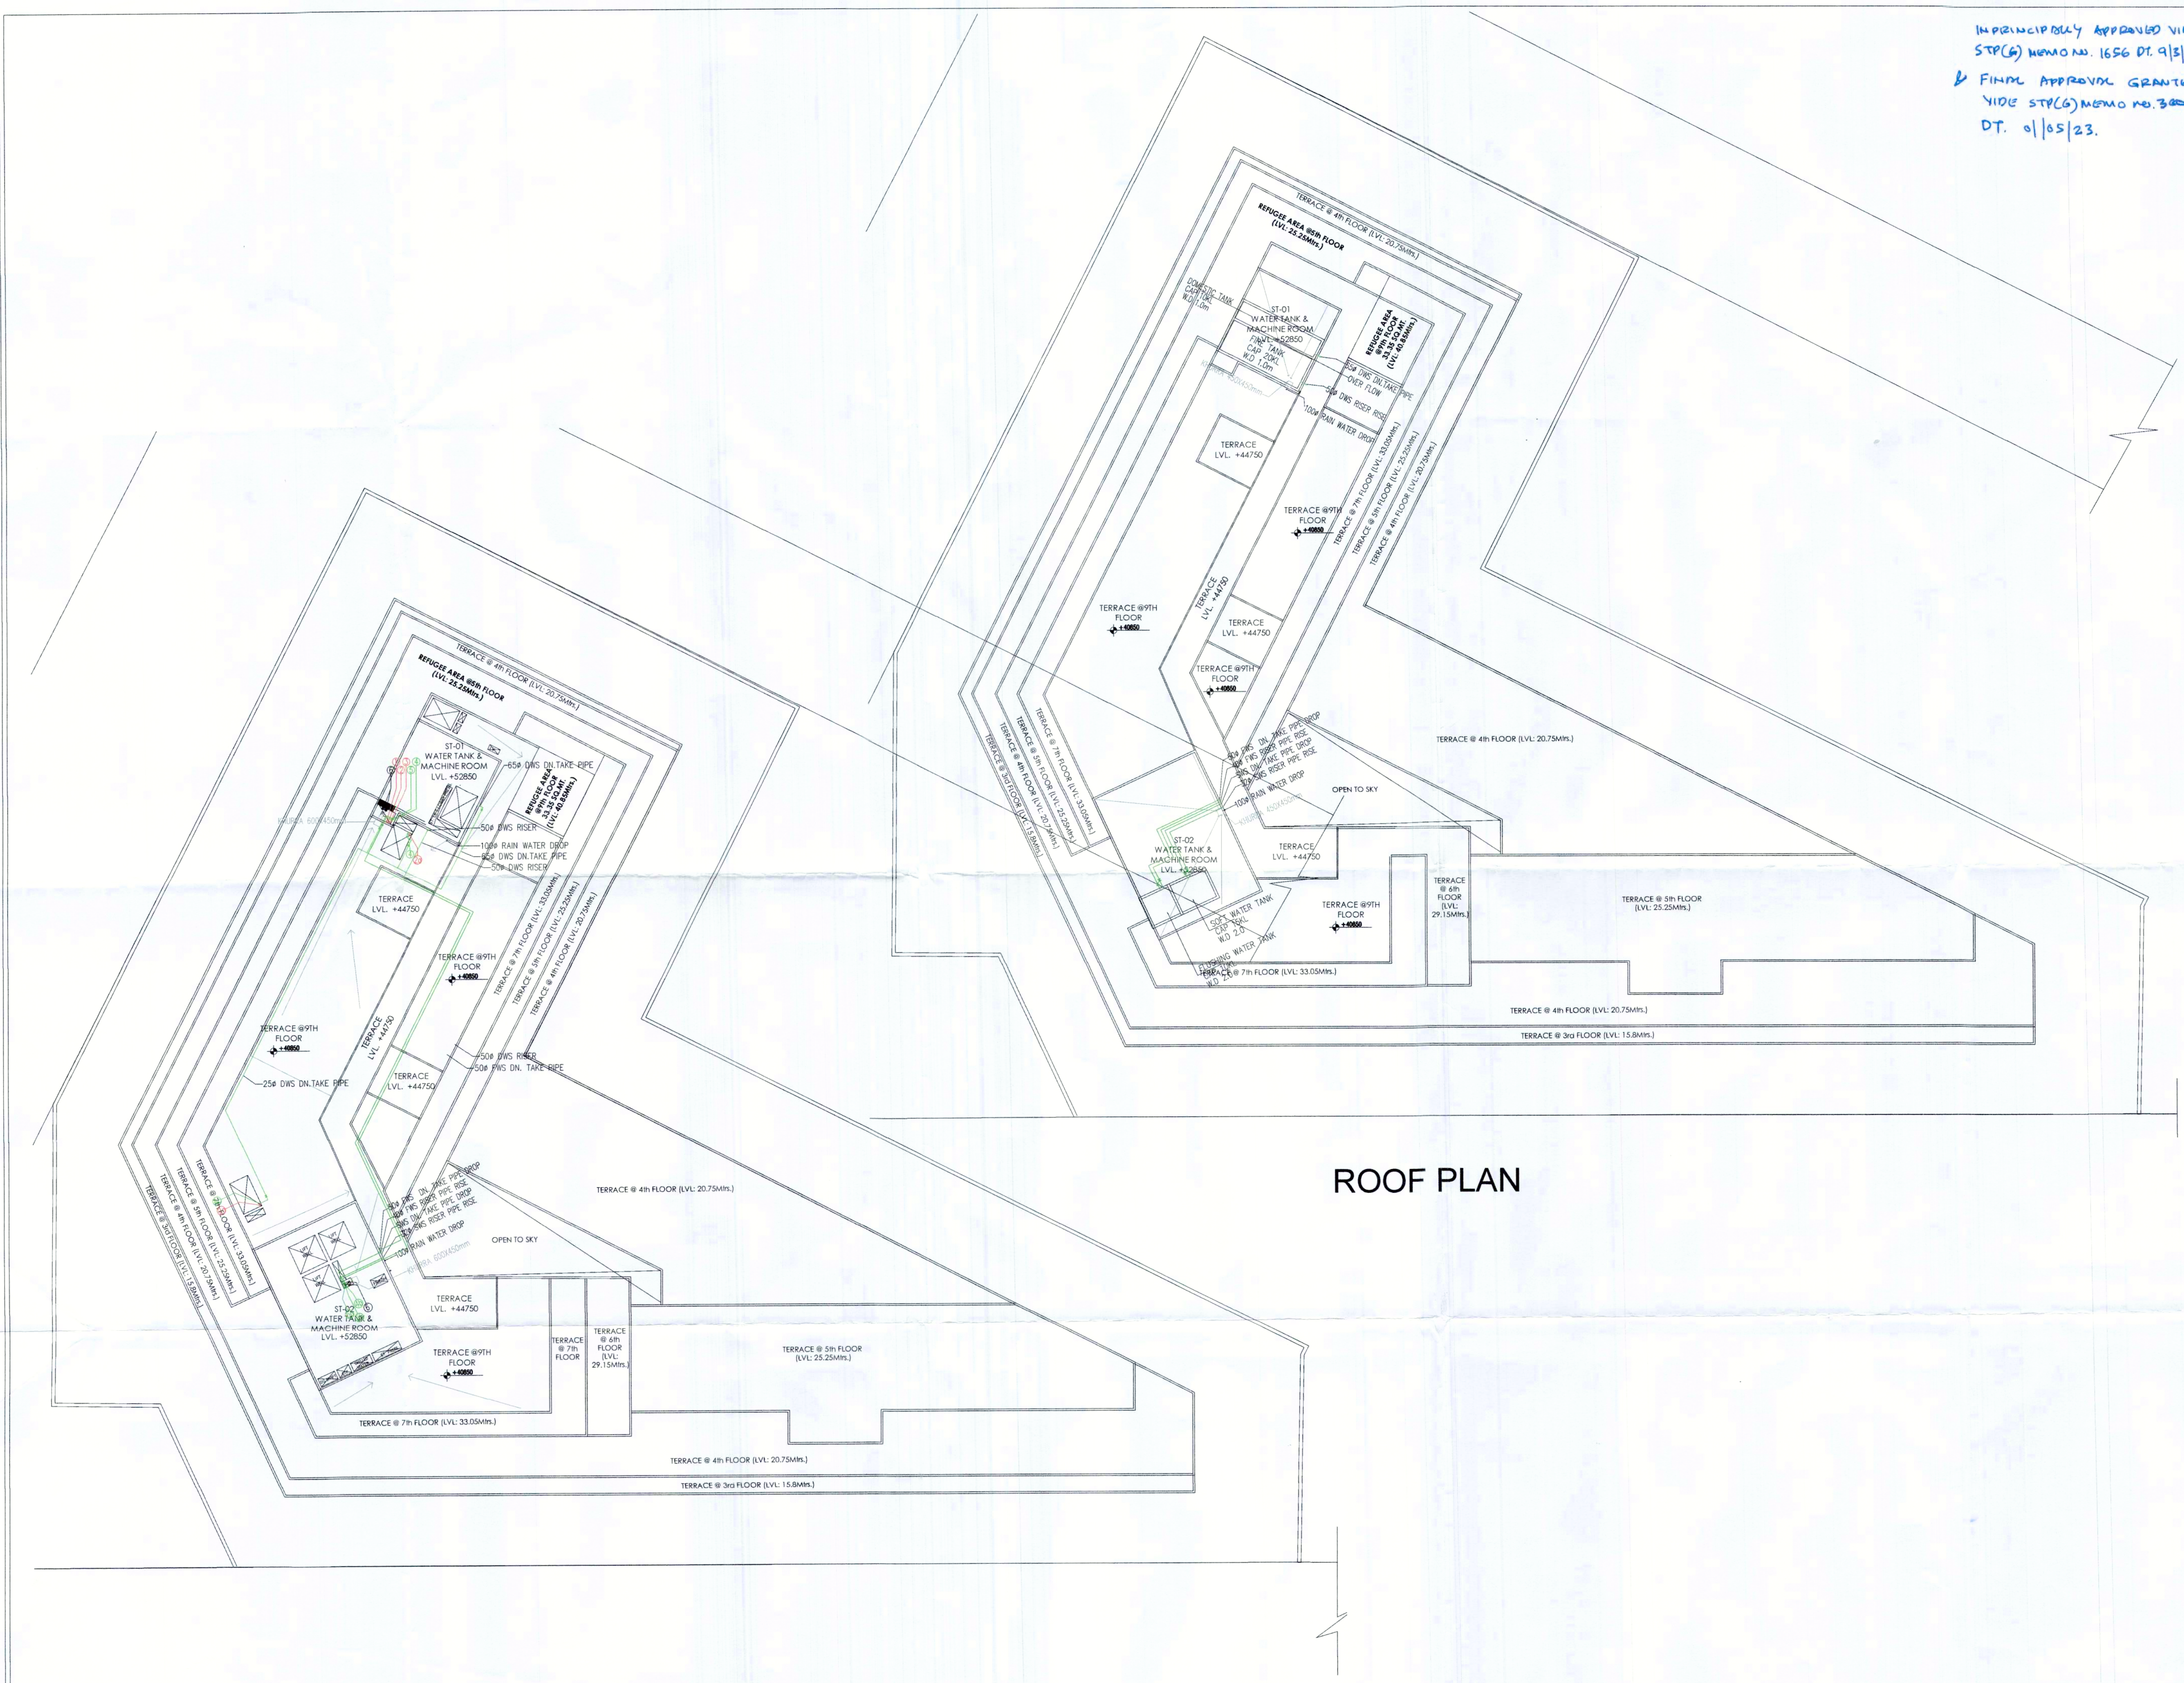

TERRACE FLOOR PLAN