


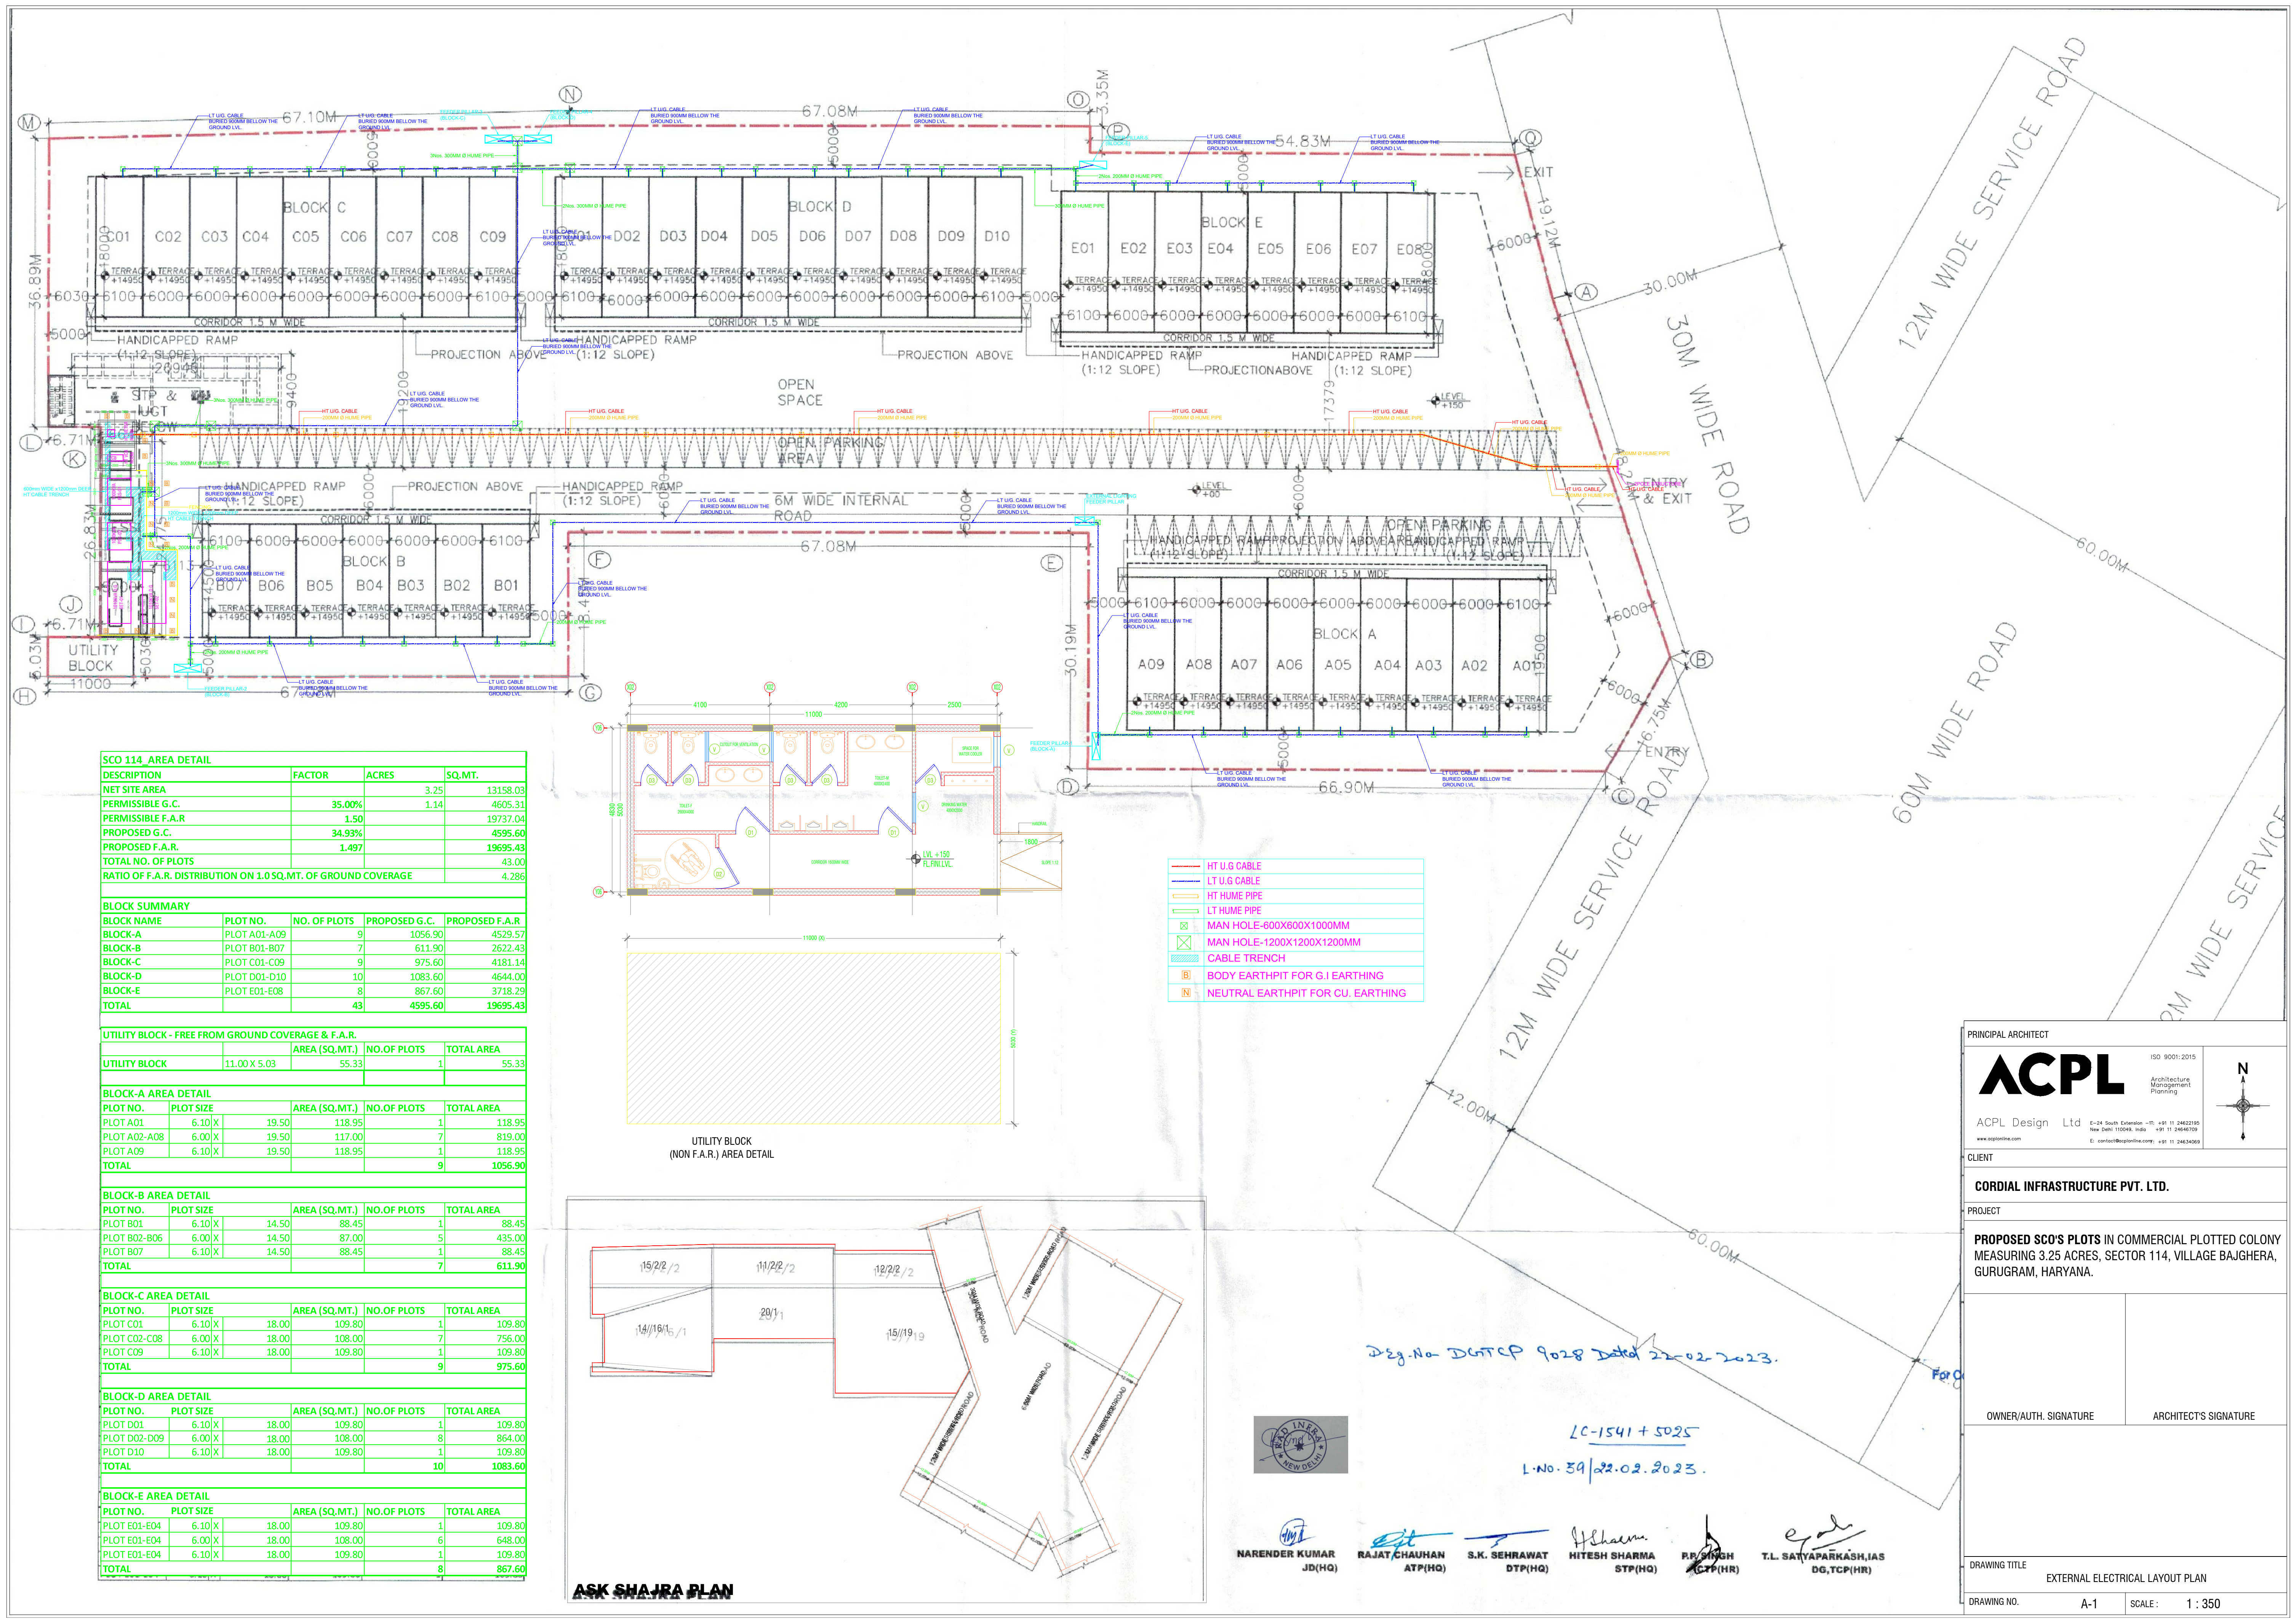

SCO 114 AREA DETAIL			
DESCRIPTION	FACTOR	ACRES	SQ.MT.
NET SITE AREA		3.25	13158.03
PERMISSIBLE G.C.	35.00%	1.14	4605.31
PERMISSIBLE F.A.R.	1.50		19737.04
PROPOSED G.C.	34.93%		4595.60
PROPOSED F.A.R.	1.497		19695.43
TOTAL NO. OF PLOTS			43.00
RATIO OF F.A.R. DISTRIBUTION ON 1.0 SQ.MT. OF GROUND COVERAGE			4.286

BLOCK SUMMARY				
BLOCK NAME	PLOT NO.	NO. OF PLOTS	PROPOSED G.C.	PROPOSED F.A.R.
BLOCK-A	PLOT A01-A09	9	1056.90	4529.57
BLOCK-B	PLOT B01-B07	7	611.90	2622.43
BLOCK-C	PLOT C01-C09	9	975.60	4181.14
BLOCK-D	PLOT D01-D10	10	1083.60	4644.00
BLOCK-E	PLOT E01-E08	8	867.60	3718.29
TOTAL		43	4595.60	19695.43

UTILITY BLOCK - FREE FROM GROUND COVERAGE & F.A.R.			
UTILITY BLOCK	AREA (SQ.MT.)	NO. OF PLOTS	TOTAL AREA
11.00 X 5.03	55.33	1	55.33


BLOCK-A AREA DETAIL				
PLOT NO.	PLOT SIZE	AREA (SQ.MT.)	NO. OF PLOTS	TOTAL AREA
PLOT A01	6.10 X	19.50	1	118.95
PLOT A02-A08	6.00 X	19.50	7	819.00
PLOT A09	6.10 X	19.50	1	118.95
TOTAL			9	1056.90

BLOCK-B AREA DETAIL				
PLOT NO.	PLOT SIZE	AREA (SQ.MT.)	NO. OF PLOTS	TOTAL AREA
PLOT B01	6.10 X	14.50	1	88.45
PLOT B02-B06	6.00 X	14.50	5	435.00
PLOT B07	6.10 X	14.50	1	88.45
TOTAL			7	611.90


BLOCK-C AREA DETAIL				
PLOT NO.	PLOT SIZE	AREA (SQ.MT.)	NO. OF PLOTS	TOTAL AREA
PLOT C01	6.10 X	18.00	1	109.80
PLOT C02-C08	6.00 X	18.00	7	756.00
PLOT C09	6.10 X	18.00	1	109.80
TOTAL			9	975.60

BLOCK-D AREA DETAIL				
PLOT NO.	PLOT SIZE	AREA (SQ.MT.)	NO. OF PLOTS	TOTAL AREA
PLOT D01	6.10 X	18.00	1	109.80
PLOT D02-D09	6.00 X	18.00	8	864.00
PLOT D10	6.10 X	18.00	1	109.80
TOTAL			10	1083.60

BLOCK-E AREA DETAIL				
PLOT NO.	PLOT SIZE	AREA (SQ.MT.)	NO. OF PLOTS	TOTAL AREA
PLOT E01-E04	6.10 X	18.00	1	109.80
PLOT E01-E04	6.00 X	18.00	6	648.00
PLOT E01-E04	6.10 X	18.00	1	109.80
TOTAL			8	867.60

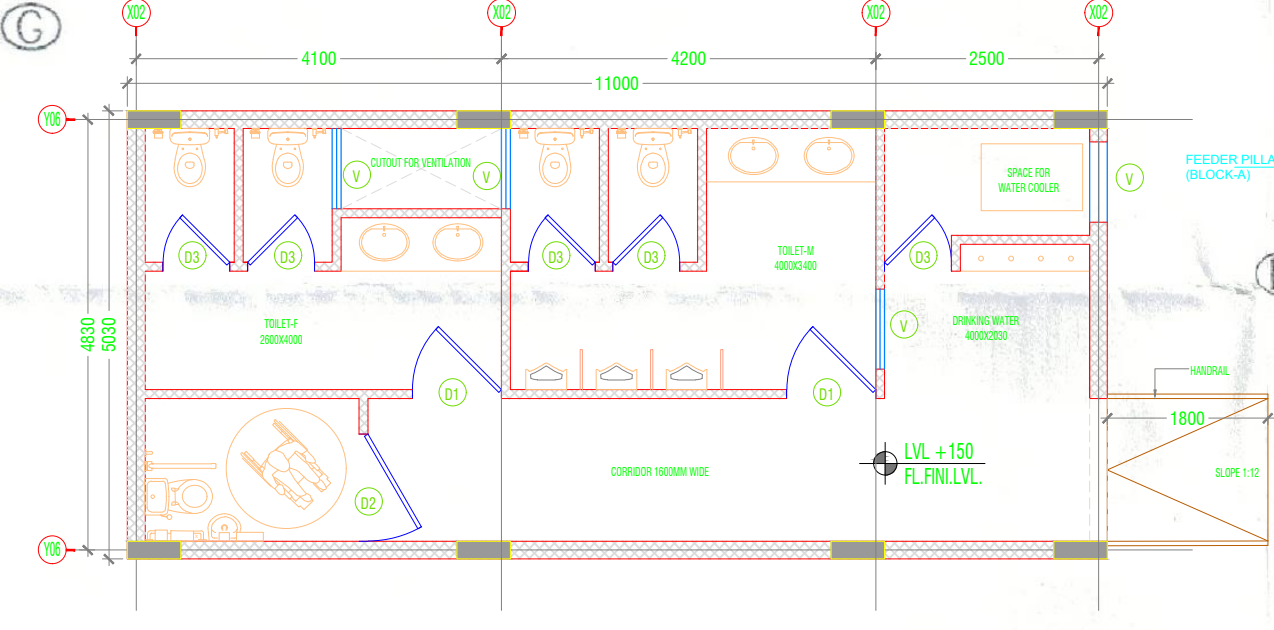

UTILITY BLOCK (NON F.A.R.) AREA DETAIL

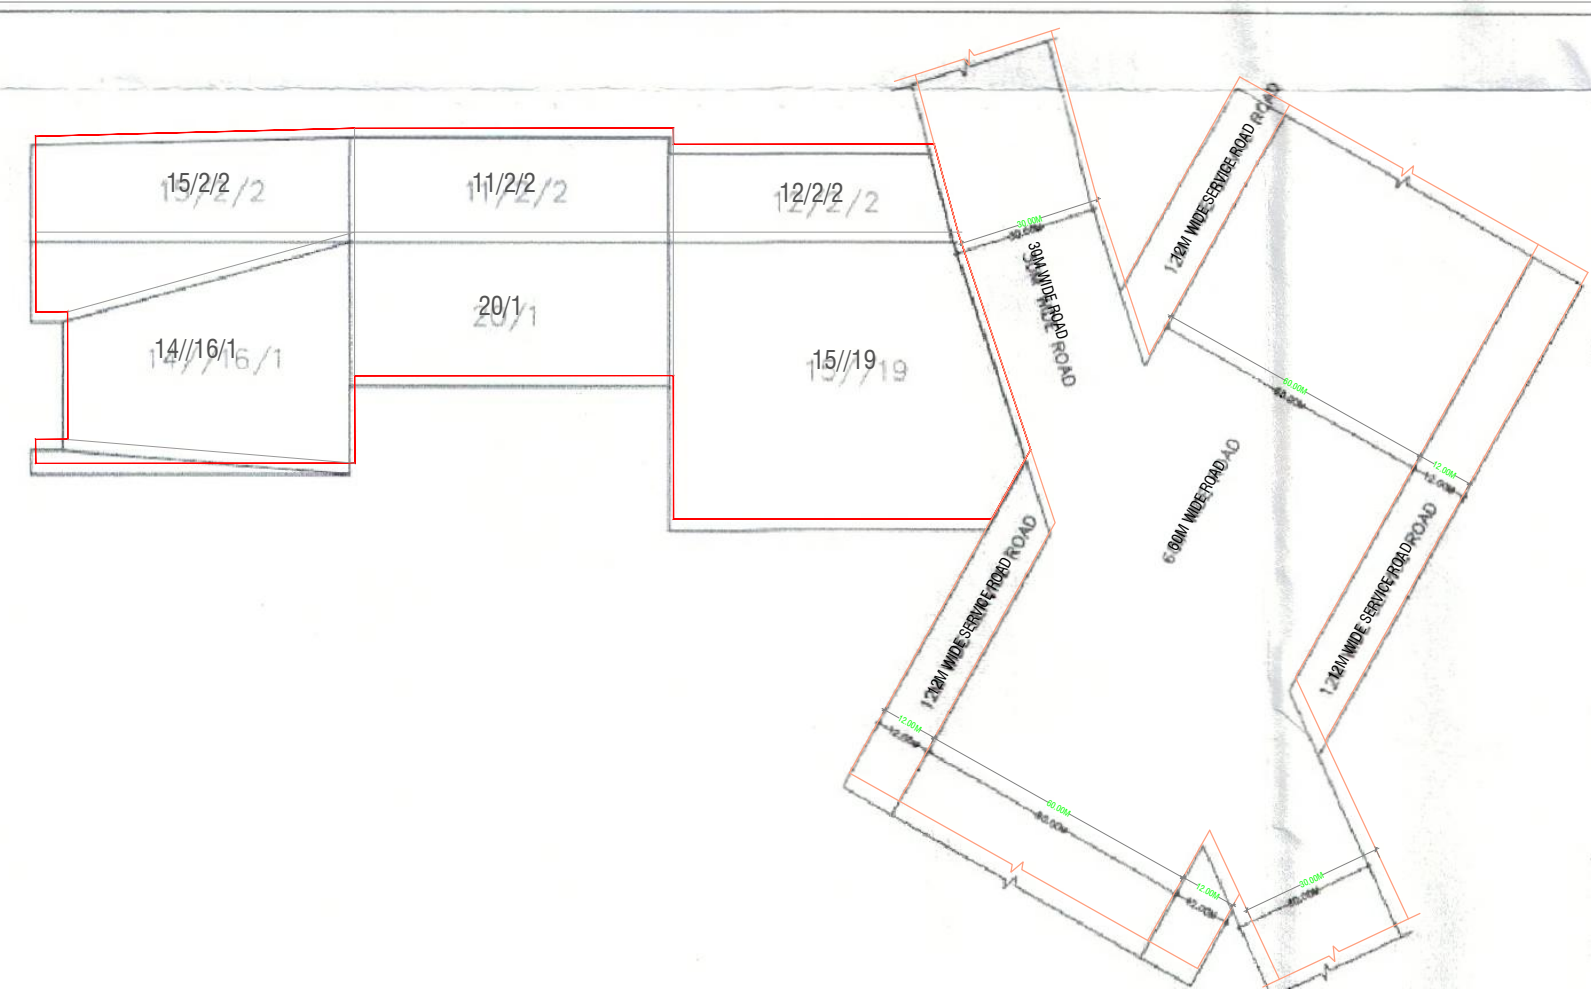

ASK SHAJRA PLAN

- HT U.G CABLE
- LT U.G CABLE
- HT HUME PIPE
- LT HUME PIPE
- MAN HOLE-600X600X1000MM
- MAN HOLE-1200X1200X1200MM
- CABLE TRENCH
- BODY EARTH PIT FOR G.I. EARTHING
- NEUTRAL EARTH PIT FOR CU. EARTHING

Deg.No DGTCP 9028 Dated 22.02.2023.

LC-1541 + 5025

L.No. 59/22.02.2023.



NARENDER KUMAR JD(HQ) RAJAT CHAUHAN ATP(HQ) S.K. SEHRAWAT DTP(HQ) HITESH SHARMA STP(HQ) P.P. SINGH DTP(HR) T.L. SATYAPARKASH, IAS DG, TCP(HR)

PRINCIPAL ARCHITECT

ACPL

ACPL Design Ltd

C-24 South Extension -II, +91 11 26823195
New Delhi 110049, India +91 11 26846709
E: contact@acplonline.com +91 11 24634089

ISO 9001:2015
Architecture
Management
Planning

CLIENT

CORDIAL INFRASTRUCTURE PVT. LTD.

PROJECT

PROPOSED SCO'S PLOTS IN COMMERCIAL PLOTTED COLONY
MEASURING 3.25 ACRES, SECTOR 114, VILLAGE BAJGHARA,
GURUGRAM, HARYANA.

OWNER/AUTH. SIGNATURE

ARCHITECT'S SIGNATURE

DRAWING TITLE

EXTERNAL ELECTRICAL LAYOUT PLAN

DRAWING NO.

A-1

SCALE:

1 : 350