


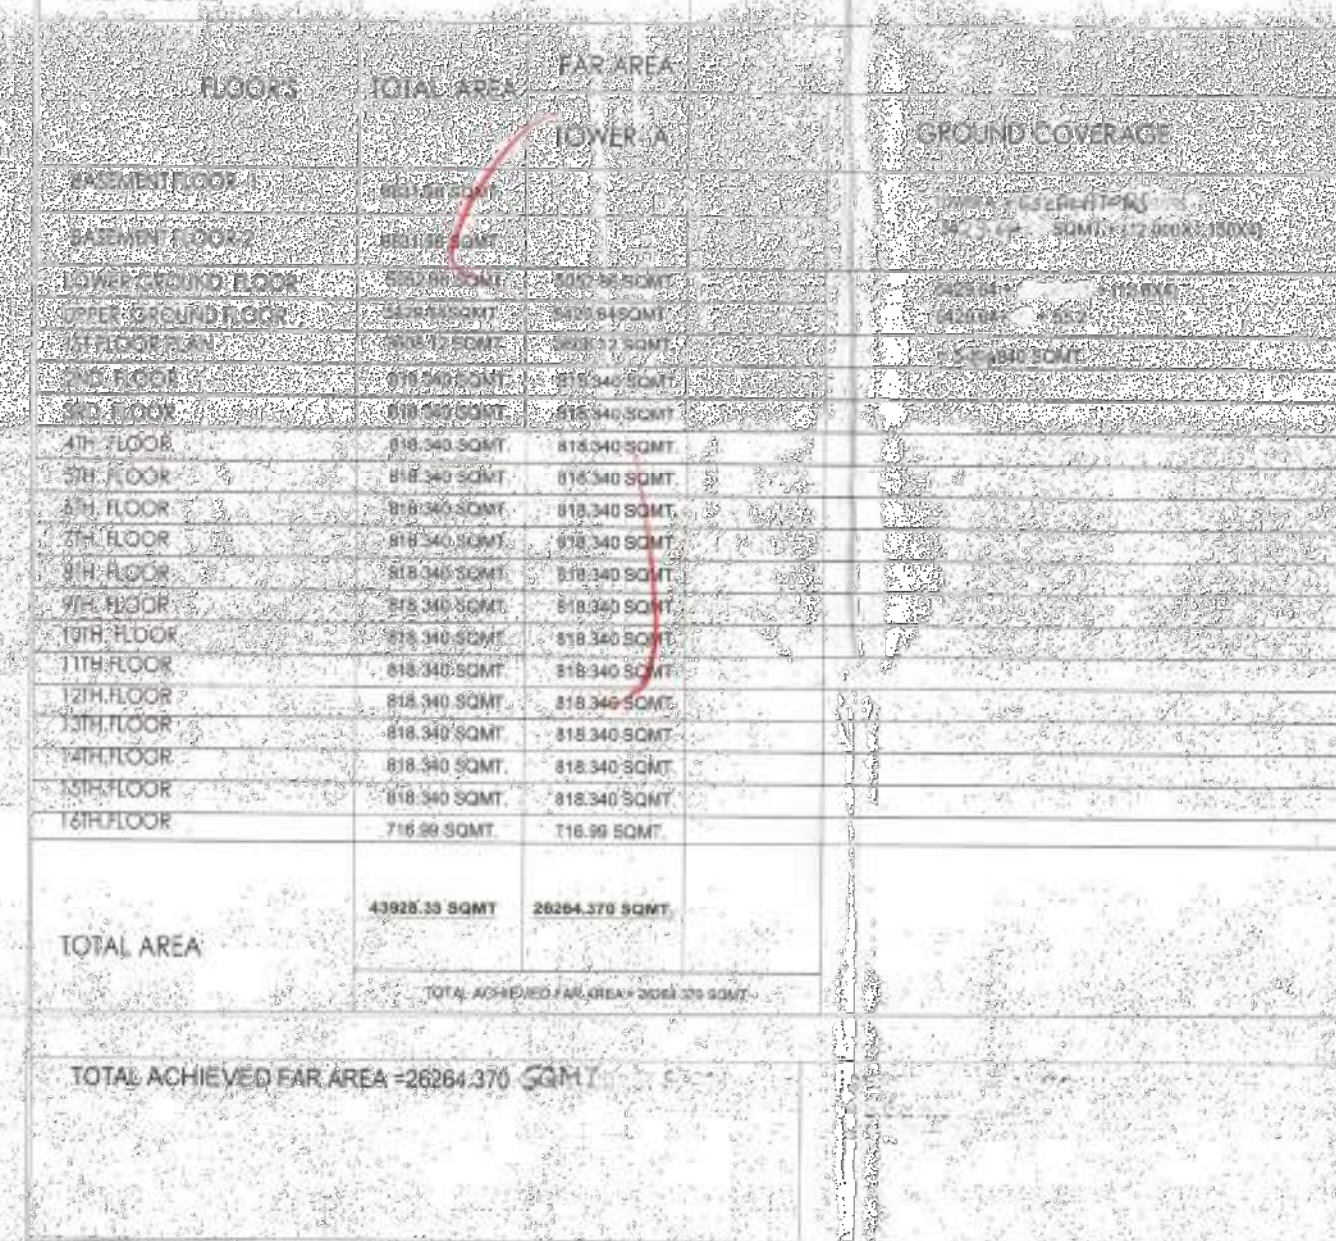

SANITATION REQUIREMENT SHEET		Female toilet		Male toilet	
		Provided	Required	Provided	Required
L Ground floor	WC	13	13.1	12	11.88
Area-4956.139	Wash basin	8	7.88	12	11.88
M-207, F-197	Urinals			12	11.88
U.G.Ground floor	WC	15	14.5	14	13.12
Area-5477.40	Wash basin	9	8.72	14	13.12
M-328, F-218	Urinals			16	13.12
First floor	WC	11	10.33	10	9.32
Area-3884.575	Wash basin	7	6.2	10	9.32
M-233, F-188	Urinals			10	9.32
Typical floor	WC	3	2.13	2	1.96
Area-174.15	Wash basin	2	1.42	2	1.96
M-49, F-32	Urinals			2	1.96
Screened floor	WC	1	1	1	1
Area-350	Wash basin	1	1	1	1
M-21, F-11	Urinals			1	1

400 ϕ MM REC. PIPE
150 MM ϕ FIRE RING
WATER SUPPLY FROM
HQA MAIN (150MM)
SEWER OVERHEAD TO
HQA MAIN (200MM)
EXTERNAL FIRE HYDRANT

SEWAGE PLAN

SOLAR WATER HEATING SYSTEM
The Cost of Solar Water Heating System is per item specified by HSEI, Ltd. and shall be made operational in 1997 according to the following performance criteria:

RAIN WATER PAVING/STORM
That the rain water collecting system shall be installed as per Central Ground Water Authority norms/Haryana Govt. notification as applicable.

BOUNDARY WALL /GATE AND GATE POSTS/HEDGES AND FENCES:
Such boundary wall, railing or their combination, hedges or fences along with gates and gate posts shall be constructed as per design approved by DTPP, Haryana. In addition to the gate/wall or additional wall/gate post maintaining 1200 hours work may be required in the front boundary wall.

EARTHQUAKE
The Blandin Earthquake occurred on 22 September 1931, NE-

SPRINGER
In the future, following the Springer system, it will be possible to
use FOR, REFS and EXTENDED commands to manage a journal. **Page 113**

AIR CONDITIONING AND VENTILATION
The design will include heating and ventilation systems for all spaces.

GENERAL:

- a) The work of the Institute will be governed by Article 42 of the Rules, 1961.
- b) The Institute will be subject to all the buildings that conform to the National Building Code Act No. 47 of 1961 and rules framed thereunder.
- c) The Institute will be subject to all the concurrent Campus filing for general lighting as well as Campus lighting.

OWNER'S SIGN _____

ARCHITECTS SIGN *ON RAUTV GASKPH*

DFA CONSULTANTS PVT. LTD
C-10, SECTOR 3,
NOIDA - 201301

STRUCTURAL CONSULTANT

ESCOM CONSULTANTS PVT. LTD.
C-10, SECTOR 3,
NOIDA - 201301

PROJECT

PROPOSED BUILDING PLAN OF COMMERCIAL COLONY
3.7187 ACRES (LICENCE NO 24 OF 2011 DATED 24-03-2011)
IN SECTOR-109, GURGAON MANESAR URBAN COMPLE
BEING DEVELOPED BY M/S ANJUM ASSOCIATES PVT.
OTHERS

SITE PLAN

Scale 1:250

Date 10/10/2014

SHEET. NO.	DRG. NO.	
------------	----------	--

JOB NO.	A-01
---------	------

SEWAGE LINE

SCHEDULE OF OPENINGS			
NAME	SIZE	LVL	CL
R1	3000x2400	2400	-
D1	1200x2400	2400	-
D2	1000x2400	2400	-
D	1500x2400	2400	-
DW1	9000x2400	2400	300
DG2	3050x2400	2400	-
W	AS/ DETAIL	-	-

SITE PLAN

TYPICAL BOUNDARY WALL DETAIL