

D.T.P. (HQ)
Member Secretary
B.P.C.

S.T.P. (G)
Member
B.P.C.

Friedrich
Chairman
B.P.C.

AD
JD
B.P.
ATP

SEC
A

WC = 4 NOS.
WB = 2 NOS.
U = 2-2 NOS.

WC = 8 NOS.
WB = 2 NOS.

SEC
A

SCHEDULE OF OPENINGS

NAME	SIZE	L.LVL.	C.LVL.
R1	3000x2400	2400	-
D1	1200x2400	2400	-
D2	1000x2400	2400	-
D	1500x2400	2400	-
DW1	9080x2400	2400	300
DG2	3050x2400	2400	-
W	AS/ DETAIL	-	-

SOLAR WATER HEATING SYSTEM:
The use of Solar Water Heating System as per norms specified by HAREDA and shall be made operational in each building block before applying for an occupation certificate.

RAIN WATER HARVESTING:
That the rain water harvesting system shall be provided as per Central Ground Water Authority norms/Haryana Govt. notification as applicable.

BOUNDARY WALL/ GATE AND GATE POSTS HEDGES AND FENCES:
Such Boundary wall, railings or their combination, hedges or fences along with gates and gate posts shall be constructed as per design approved by DTP/Haryana. In addition to the gateposts an additional wider gate not exceeding 1.25 meters width may be allowed in the front boundary wall.

EARTH QUAKE:
The Building is Earth Quake resistance as per norms specified by NBC.

SPRINKLER:
In the entire building the sprinkler system shall be installed as per NBC norms and provision contains irrelevant is code.

AIR CONDITIONING AND VENTILATION:
The building will be Air conditioned and Mechanically Ventilated.

GENERAL:
a) The width of the corridor would be governed by Rule 82 of the Rules, 1985.
b) The W.C and urinals provided in the buildings shall conform to the National Building Code/Act No.41 of 1983 and rules framed there under.
c) That the applicant shall use only Compact Fluorescent Lamps fitting for internal lighting as well as Campus Lighting.

OWNER'S SIGN.
ANJUM & ASSOCIATES ESTATES PVT. LTD.
Authorised Signatory

ARCHITECTS SIGN
RAJIV GANDHI
ARCHITECT
No. CA/91/1385

DFA CONSULTANTS PVT. LTD
C-10, SECTOR 3,
NOIDA - 201301

STRUCTURAL CONSULTANT
ESCOM CONSULTANTS PVT. LTD.
C-10, SECTOR 3,
NOIDA - 201301

PROJECT
PROPOSED BUILDING PLAN OF COMMERCIAL COLONY MEASURING 3.7187 ACRES (LICENCE NO 24 OF 2011 DATED 24-03-2011) IN SECTOR-109, GURGAON MANESAR URBAN COMPLEX, BEING DEVELOPED BY M/S ANJUM ASSOCIATES PVT. LTD. AND OTHERS

DRAWING TITLE
FIRST FLOOR PLAN

Scale 1:200

Date


SHEET. NO. DRG. NO.

JOB. NO. A-06

Checked and found ok for Public Health
(Internal service only subject to comments in form)
Letter No. SE(HQ) 22.07/13
Superintending Engineer (HQ)
HUDA, Panchkula.

1ST FLOOR PLAN

- ① = 100φ RWP
- ② = 100φ RVP
- ③ = TSφ ASP
- ④ = 100φ RWP
- ⑤ = DW RISER
- ⑥ = FW RISER
- ⑦ = DW SUPPLY
- ⑧ = FW SUPPLY

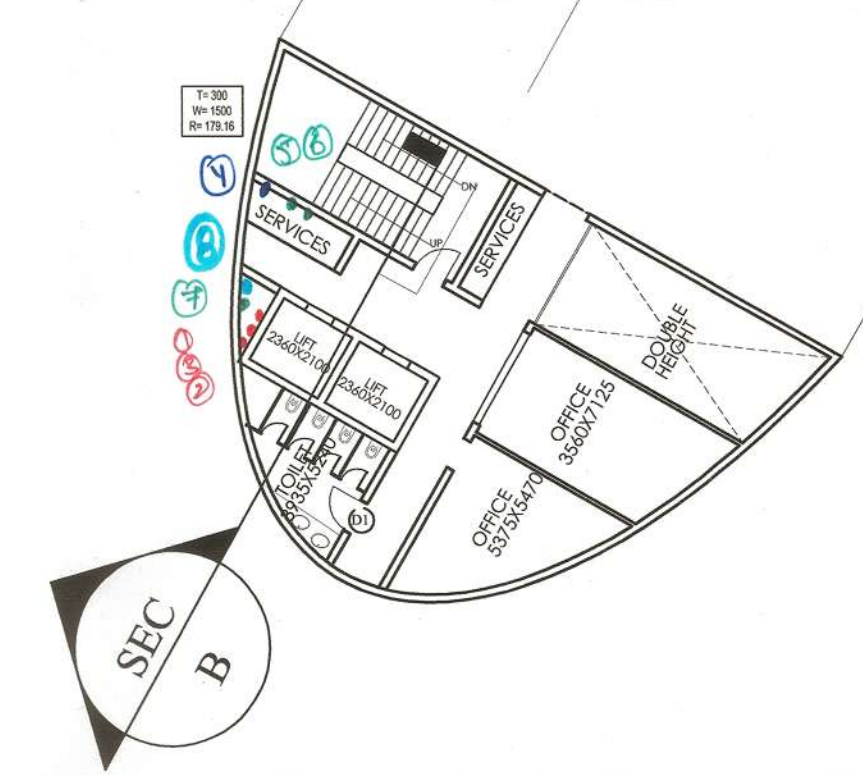

TERRACE

LVL. +4600

DOUBLE HEIGHT AREA

SEC
B