


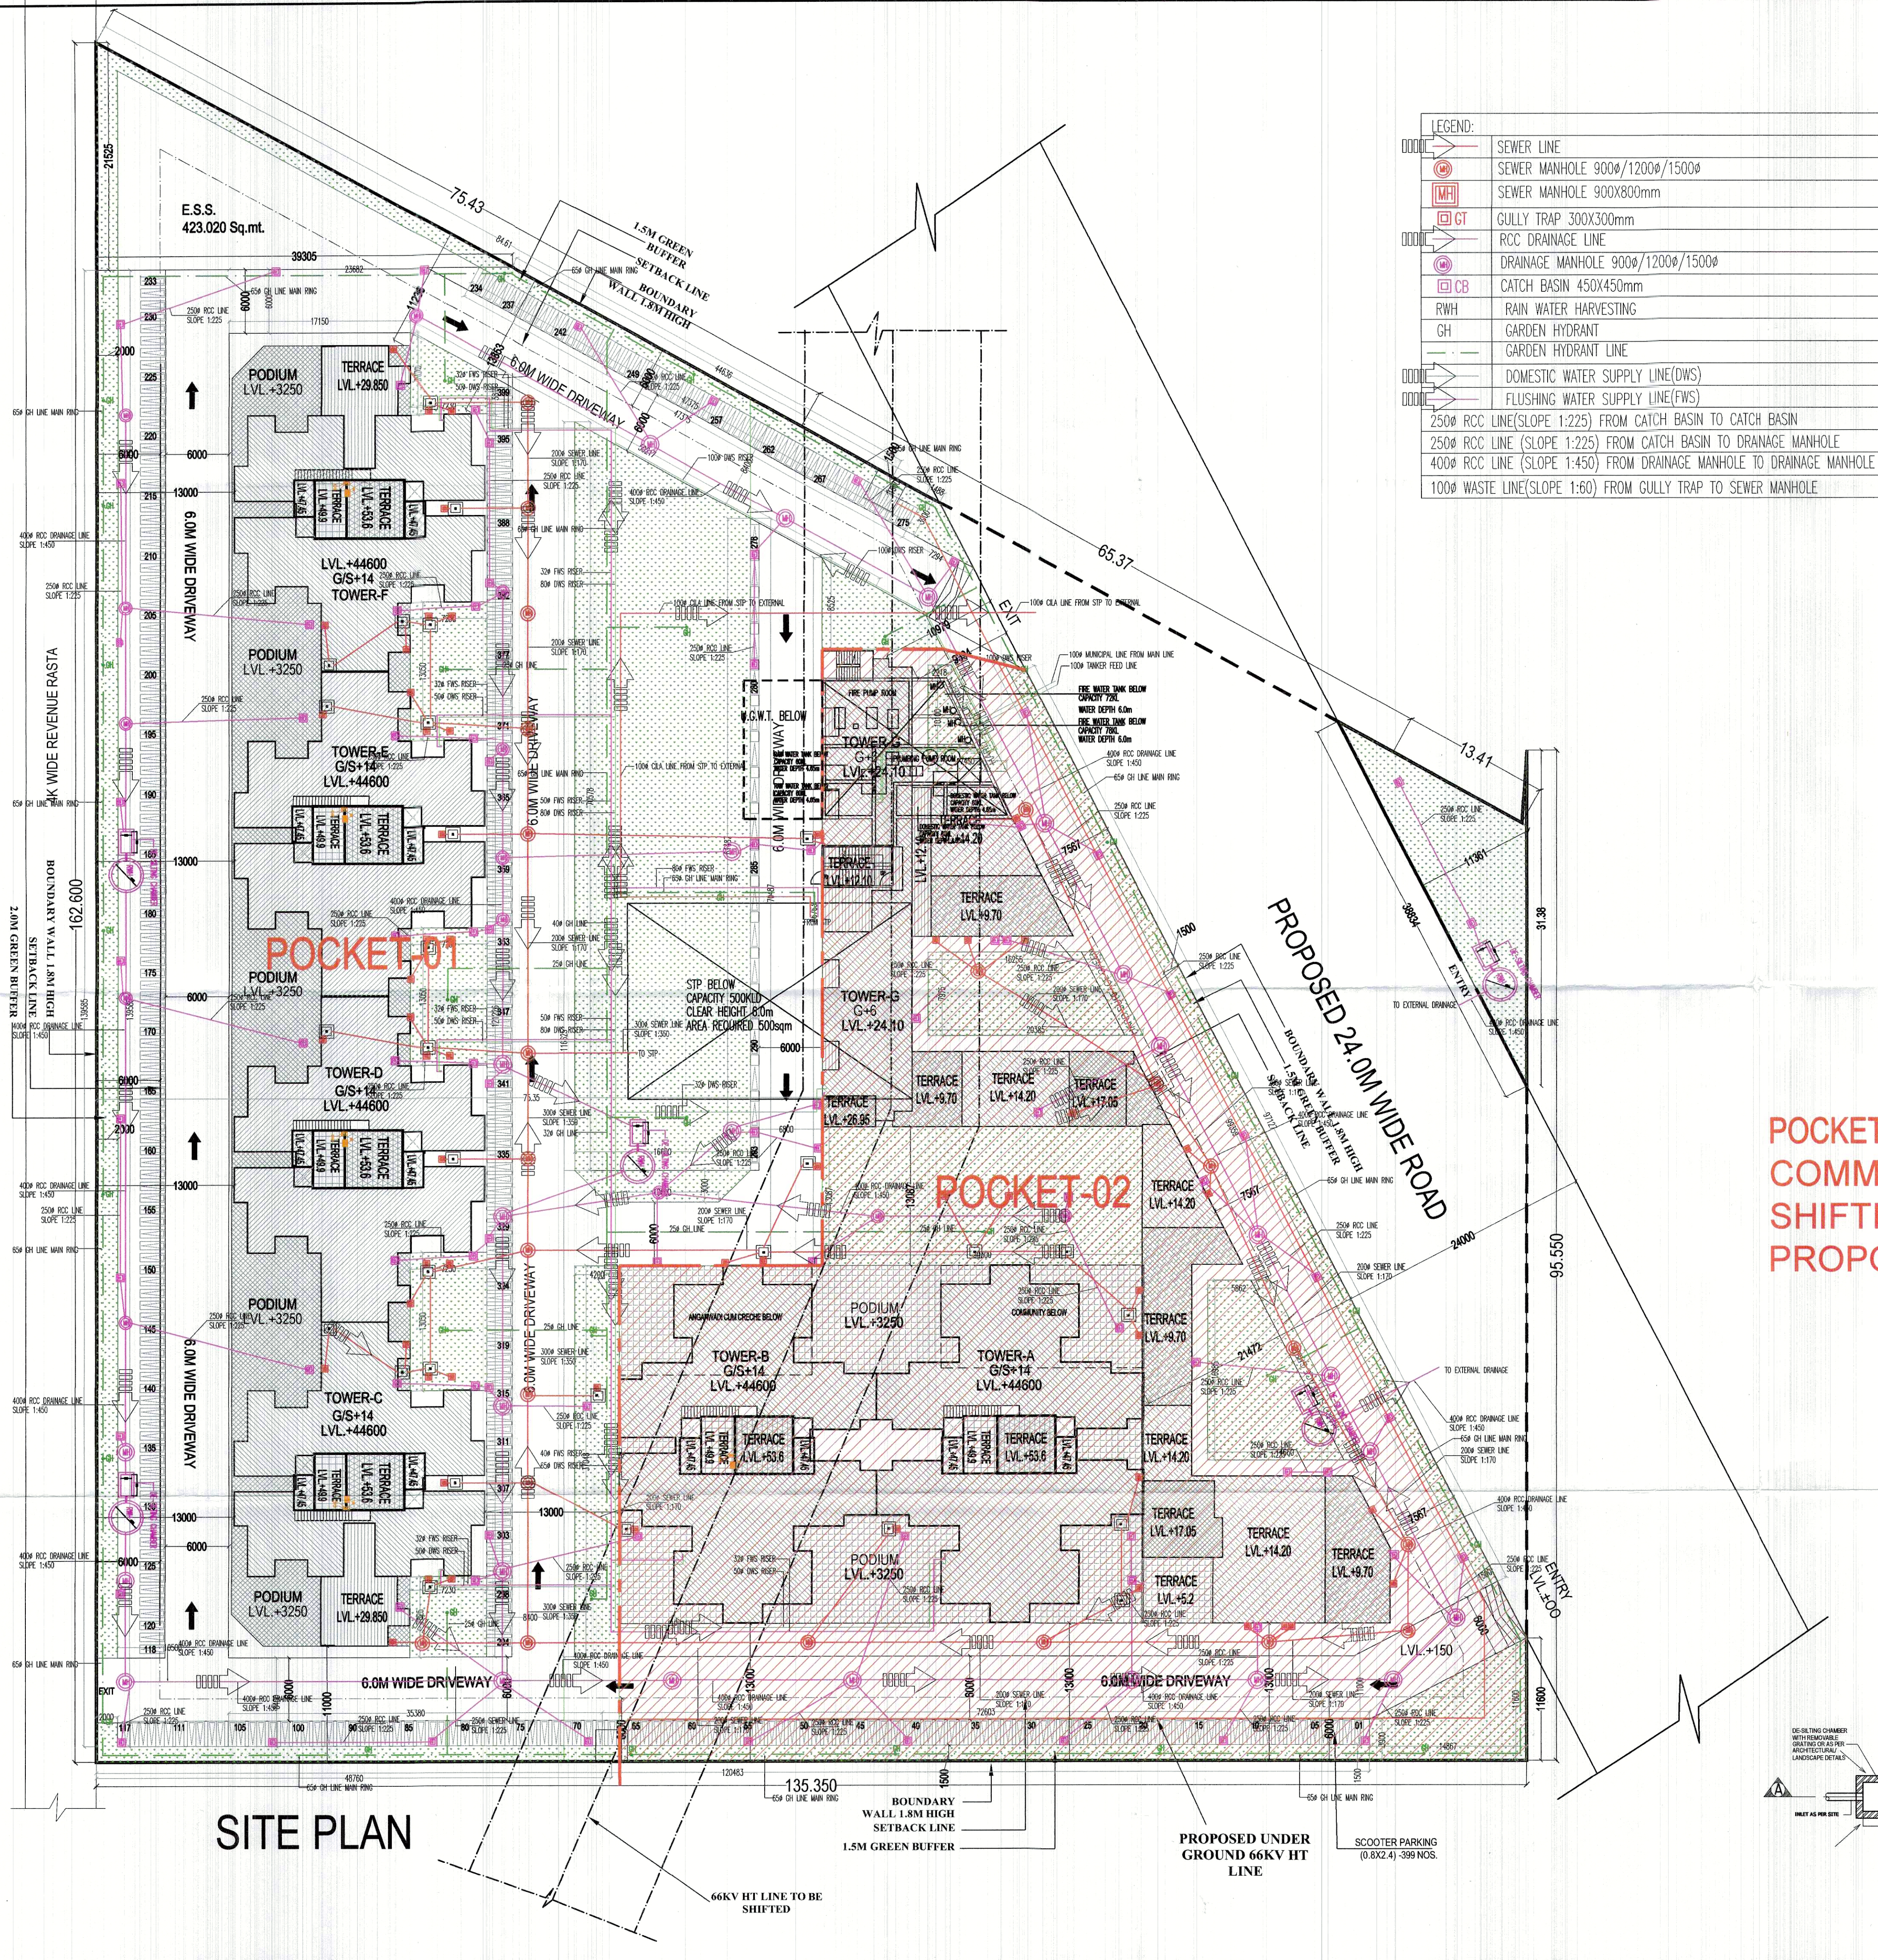

LEGEND:	
SEWER LINE	
SEWER MANHOLE 900x1200x1500	
SEWER MANHOLE 300x300mm	
GULLY TRAP 300x300mm	
RCC DRAINAGE LINE	
DRAINAGE MANHOLE 900x1200x1500	
CATCH BASIN 450x450mm	
RWH RAIN WATER HARVESTING	
GH GARDEN HYDRANT	
GARDEN HYDRANT LINE	
DOMESTIC WATER SUPPLY LINE(DWS)	
FLUSHING WATER SUPPLY LINE(FWS)	
250# RCC LINE(SLOPE 1:225) FROM CATCH BASIN TO CATCH BASIN	
250# RCC LINE(SLOPE 1:225) FROM CATCH BASIN TO DRAINAGE MANHOLE	
400# RCC LINE(SLOPE 1:450) FROM DRAINAGE MANHOLE TO DRAINAGE MANHOLE	
100# WASTE LINE(SLOPE 1:60) FROM GULLY TRAP TO SEWER MANHOLE	

Checked and found ok for Public Health
(Internal) Service only subject to comments in
in forwarding letter No.DU.....

Superintending Engineer(HQ)
for Chief Engineer-I
HSVP, A.P.
Rajesh Dutt
JD(HQ)

ATP(HQ) S.T.P(HQ) S.T.P(HQ) S.T.P(HQ)
Member B.P.A.C. Member B.P.A.C. Member B.P.A.C. Member B.P.A.C.

DDA
Member
B.P.A.C.

SANCTIONED
TO BE READ WITH THIS OFFICE
MEMO NO: 21997
DATED: 07/07/23

POCKET-02 = TOWER A,B , G &
COMMERCIAL WILL BE FREEZED UNTIL
SHIFTING OF 66 KV HT LINE AS
PROPOSED IN THE PLAN

- NOTES:-
1. ALL SCOOTER PARKING PROPOSED ARE 0.8MT X 2.5MT IN SIZE
 2. BUFFER GREEN FOR 1.5M WIDE ACCORDING TO N.G.T. GUIDELINES
 3. BOUNDARY WALL & GATE AS PER STANDARD DESIGN
 4. TOWER B & G WILL BE CONSTRUCTED AFTER SHIFTING OF 66 KV HT LINE AS PROPOSED IN THE PLAN

PROJECT:-
PROPOSED BUILDING PLAN FOR
AFFORDABLE GROUP HOUSING
COLONY OVER AN AREA MEASURING
4.25 ACRES (LICENSE NO. 32 OF 2023
DATED 14/02/2023) IN SECTOR-99A,
GURUGRAM BEING DEVELOPED BY
SH. JAGDISH CHANDER S/O RAM
SWAROOP IN COLLABORATION WITH
DISHITA INFRA PVT.LTD.

ARCHITECT:-
VIKAS AHLAWAT ARCHITECTS
ARCHITECTURE, INTERIORS, PLANNING

Unit No 303 Ninex Time Center, Suncity Sector-54 Golf Course Road Gurgaon
G - 1224-4264265 M - 9-889155445 Mail - ar.vikas.ahlawat@gmail.com

OWNERS SIGNATURE:- ARCHITECT SIGNATURE:-

For DISHITA INFRA PVT. LTD.

Authorised Signatory Ar. VIKAS AHLAWAT
CA/2013/59929

DRAWING TITLE:
SITE PLAN

DATE:- FEB-2021
SCALE:- 1:275 (A0)

SHEET NO.
SP-002

