



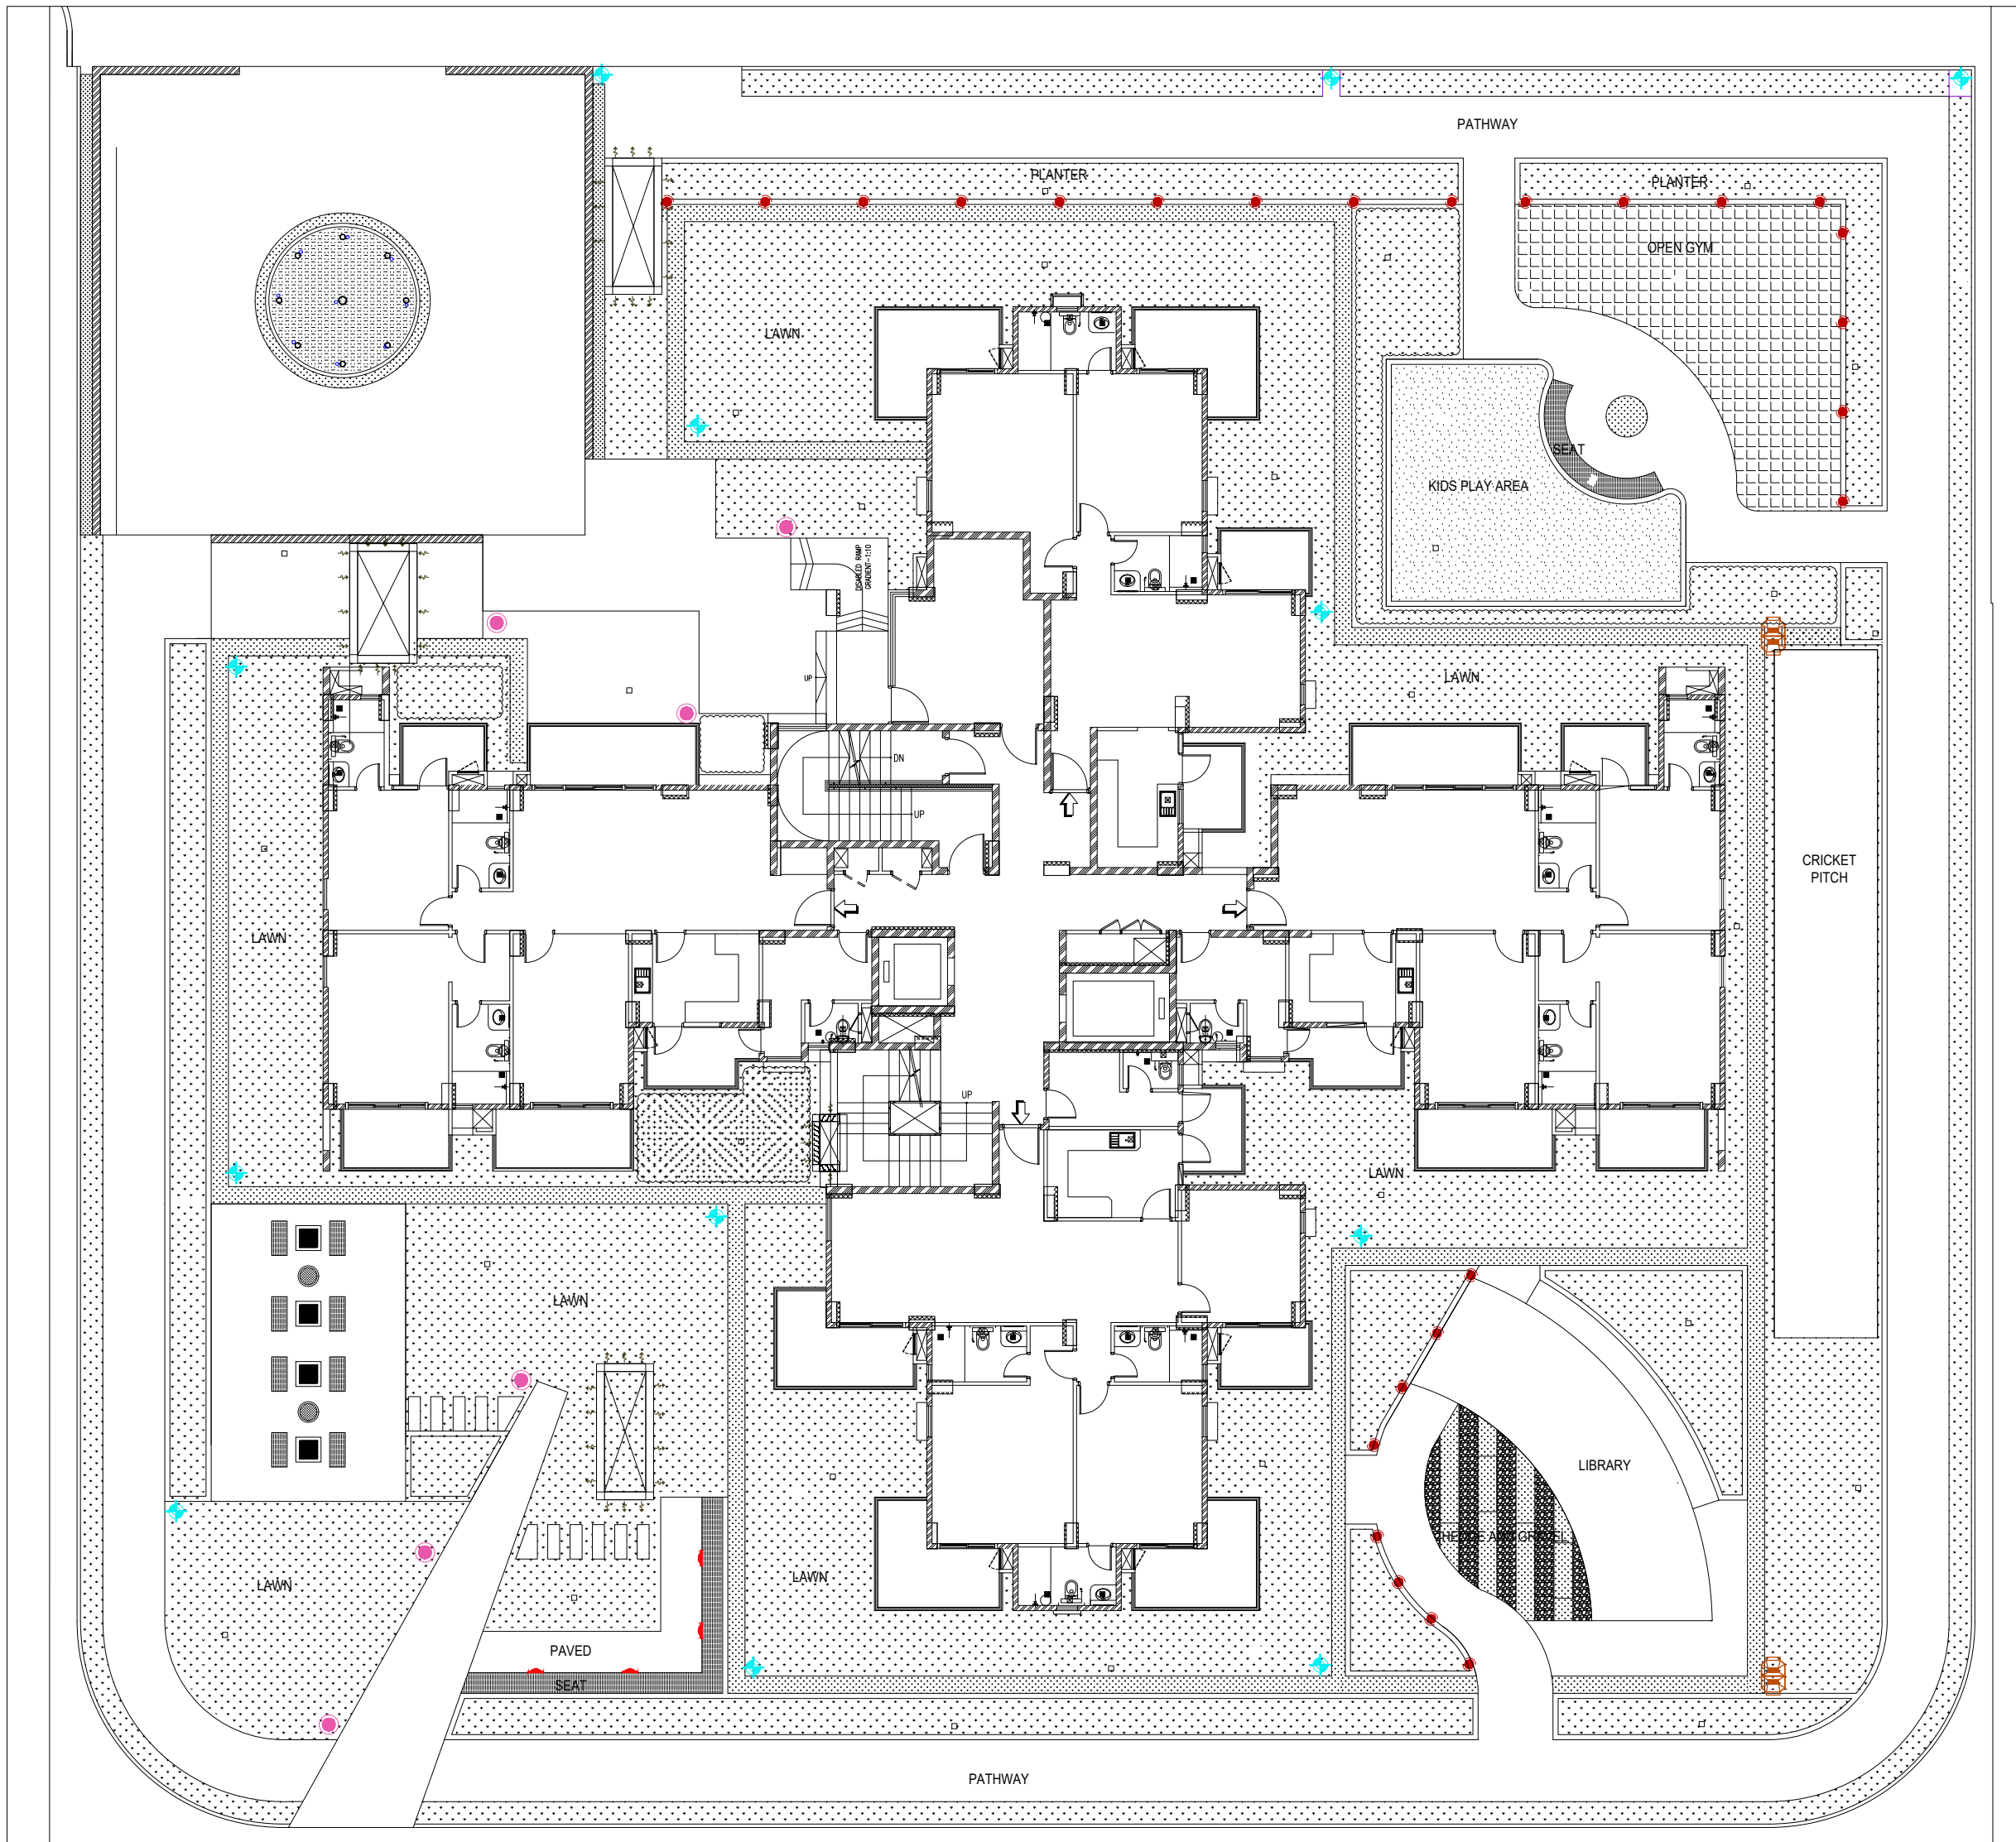

TOWER - G
SCALE 1:150

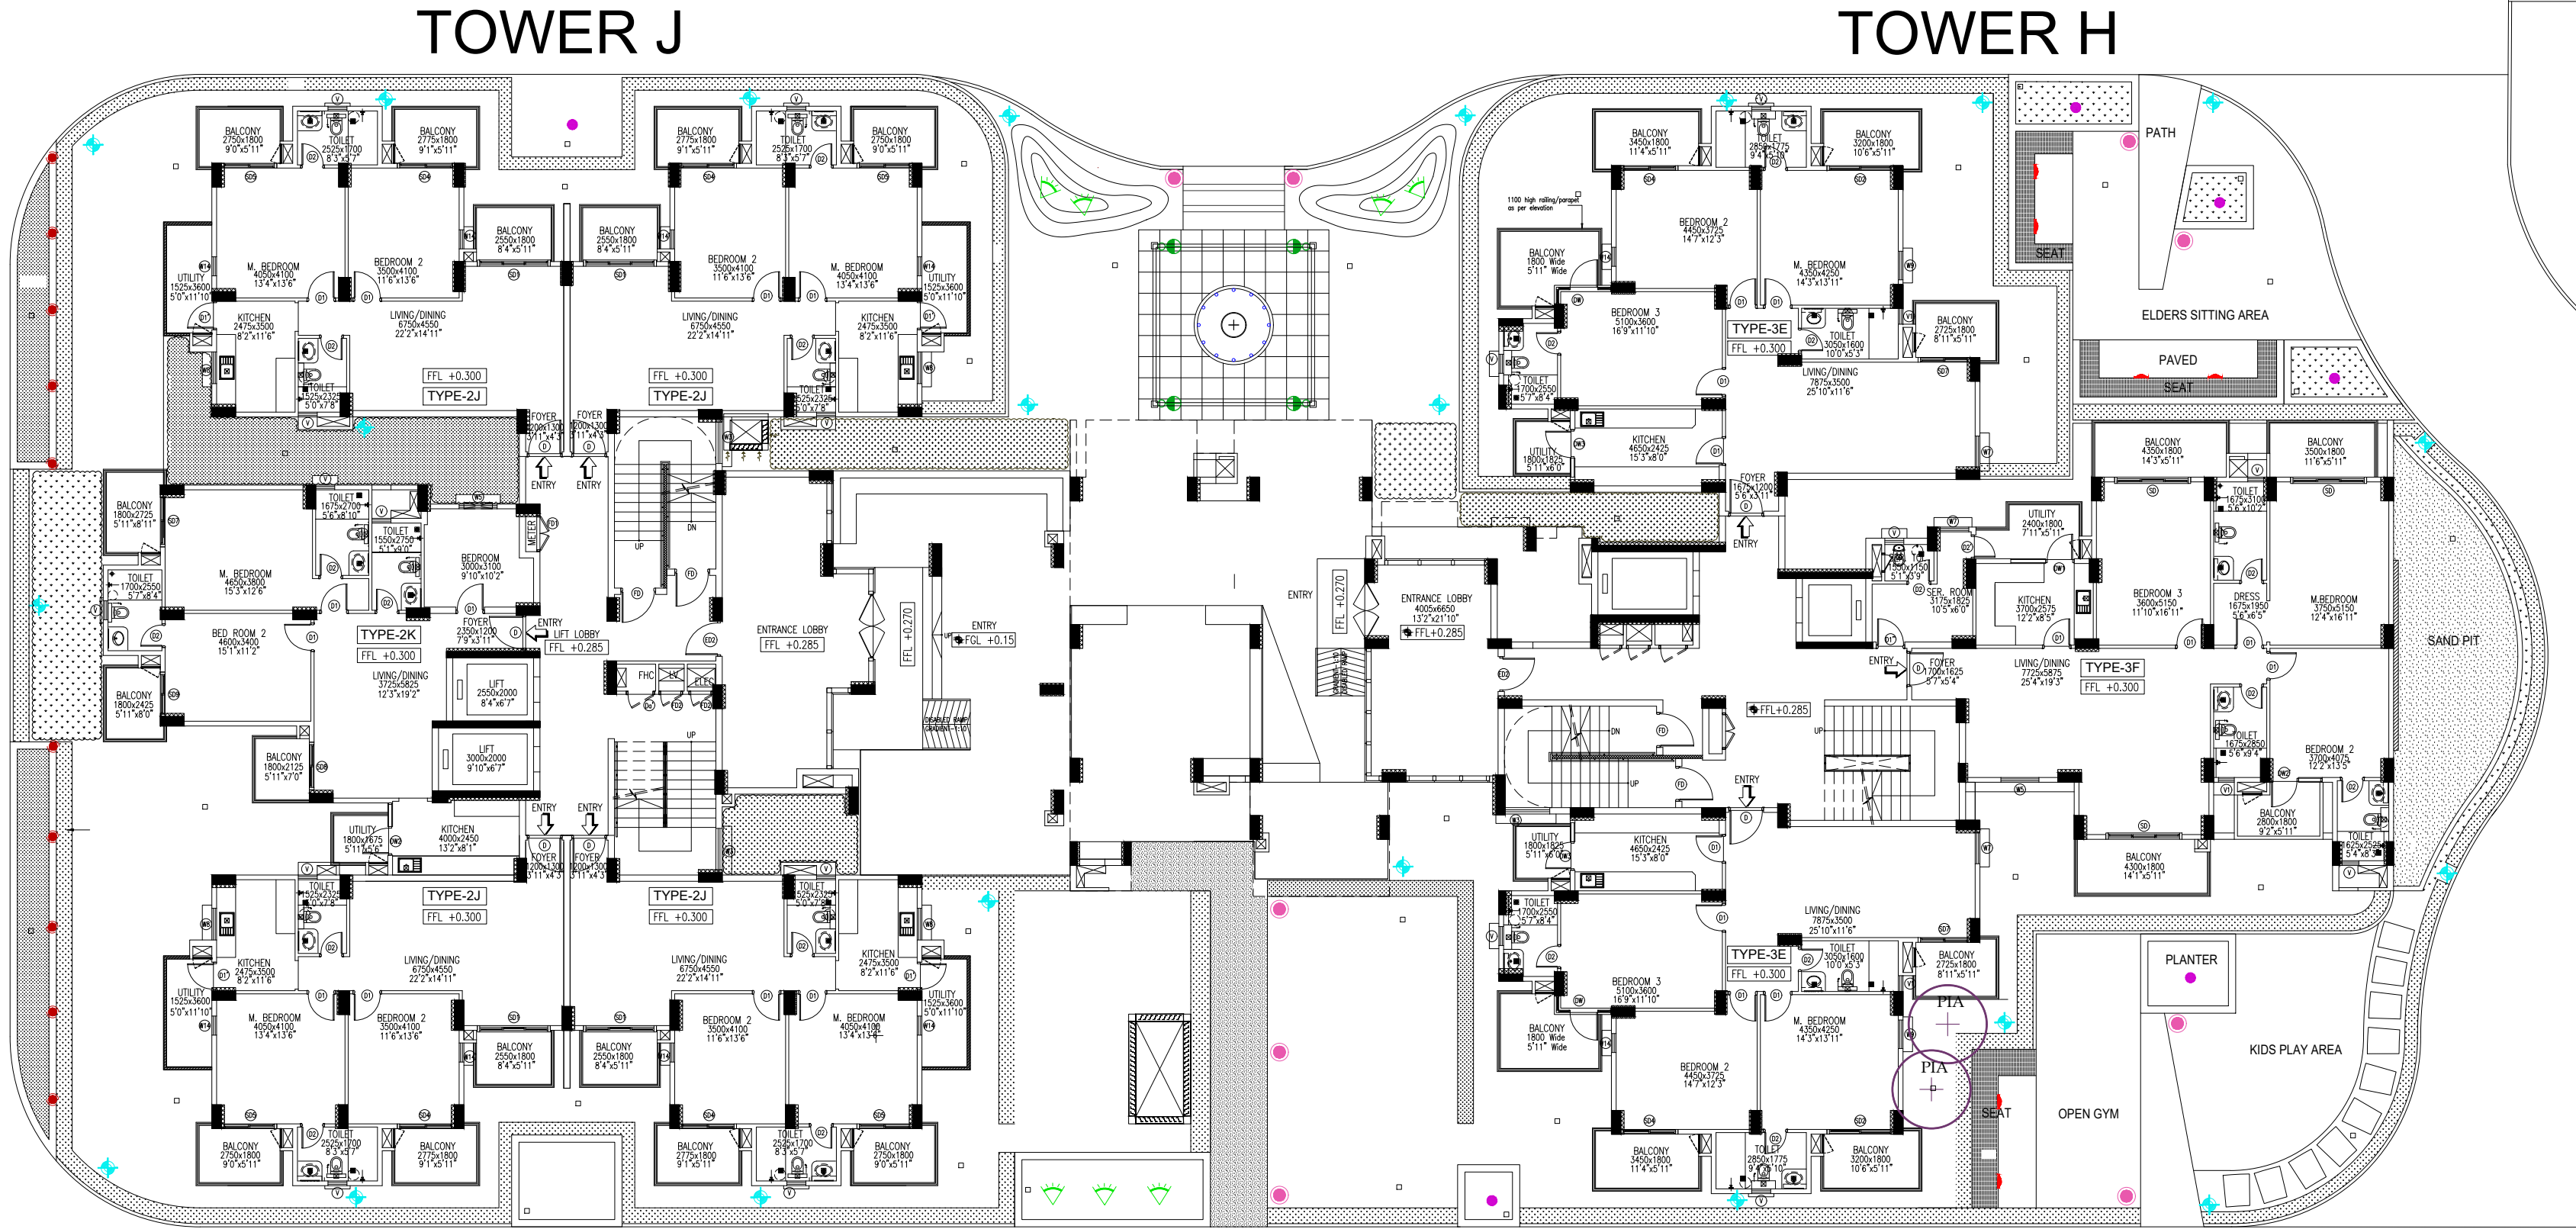


TOWER -J AND TOWER- H
SCALE 1:150

EXTERNAL LIGHTING LEGEND

SYM.	NAME	DISCRIPTION	NO.
1	POLE LIGHT	27 W LED, POLE HIGHT 3.0 MT	36
2	SPIKE LIGHT	7 W LED	10
3	FOOT LIGHT	3 W LED	12
4	UNDER WATER LIGHT	WATTAGE AS/PLUMBING	24
5	LOW BOLLARD	9 W LED (250-400 MM HIGH)	38
6	BOLLARD	9 W LED (800-1000 MM HIGH)	18
7	PLAY FIELD LIGHTS	250 W LED (2 LIGHTS ON EACH POLE)	8
8	UP & DOWN LIGHT	18 W LED	6
9	UP LIGHTER		10

KEY PLAN

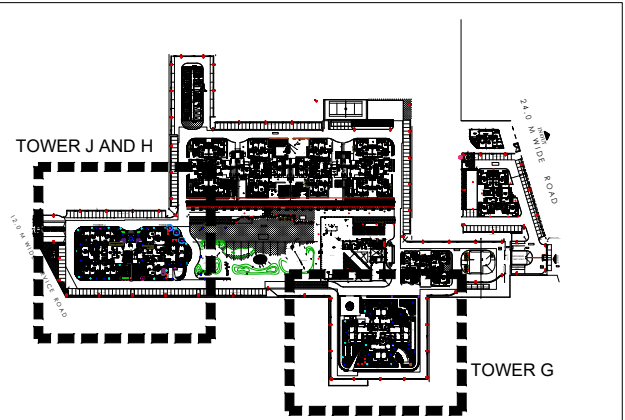

THIS DRG IS THE PROPERTY OF IPDM SERVICES (INDIA) PVT. LTD. AND SHALL NOT BE COPIED, PRODUCED OR USED FOR THE PURPOSE OTHER THAN WHICH IT HAS BEEN ISSUED.

NOTES:
1. ALL THE DIMENSIONS ARE IN MM UNLESS NOTED OTHERWISE
2. FOLLOW WRITTEN DIMENSIONS ONLY, DO NOT SCALE THE DRG.
3. ANY DISCREPENCY FOUND IN THE DRG SHALL BE BROUGHT TO THE NOTICE OF ARCHITECT IMMEDIATELY.
4. READ THIS DRG WITH ALL RELEVANT STR/ ELEC/ PLUMB DRG AND SPECIFICATIONS OF THE CONTRACT.

Drawing Released For

DESIGN DEVELOPMENT

TENDER

GPC

PROJECT

DATE

NOS.

DESCRIPTION

REVISIONS

GODREJ 101

SHEET TITLE
LIGHTING LAYOUT
TOWER - J, H AND G

ARCHITECTS:

SCALE: 1:150@ A2
DRG. NO.: LS-GOJ-15
DATE: July 2023

LANDSCAPE ARCHITECTS:
IPDM SERVICES (INDIA) PVT. LTD.
B-3/22, RAJOURI GARDEN, NEW DELHI-110027, INDIA
Mob.: 9953303203, 9287372273
e-mail: ipdm@ipdm.in