

STORM LAYOUT
Plan

This is to certify that the project will be constructed on MIVAN (Aurum Formwork) construction technology which is more economical & stable design strategy and same is as per National Building Code S-456:2000. Section 32.1 & 32.2 whereas Minimum Thickness of all walls shall be 100 mm in RCC.


DDVT
MEMBER
BPAC

S.T.P (HQ) S.T.P (S) S.T.P (H)
Member Secretary
BPAC

ATP(HQ)
Architect

Sanctuary
MEMO NO.:
DATED:

Ram Nar Bassi
JD(HQ)

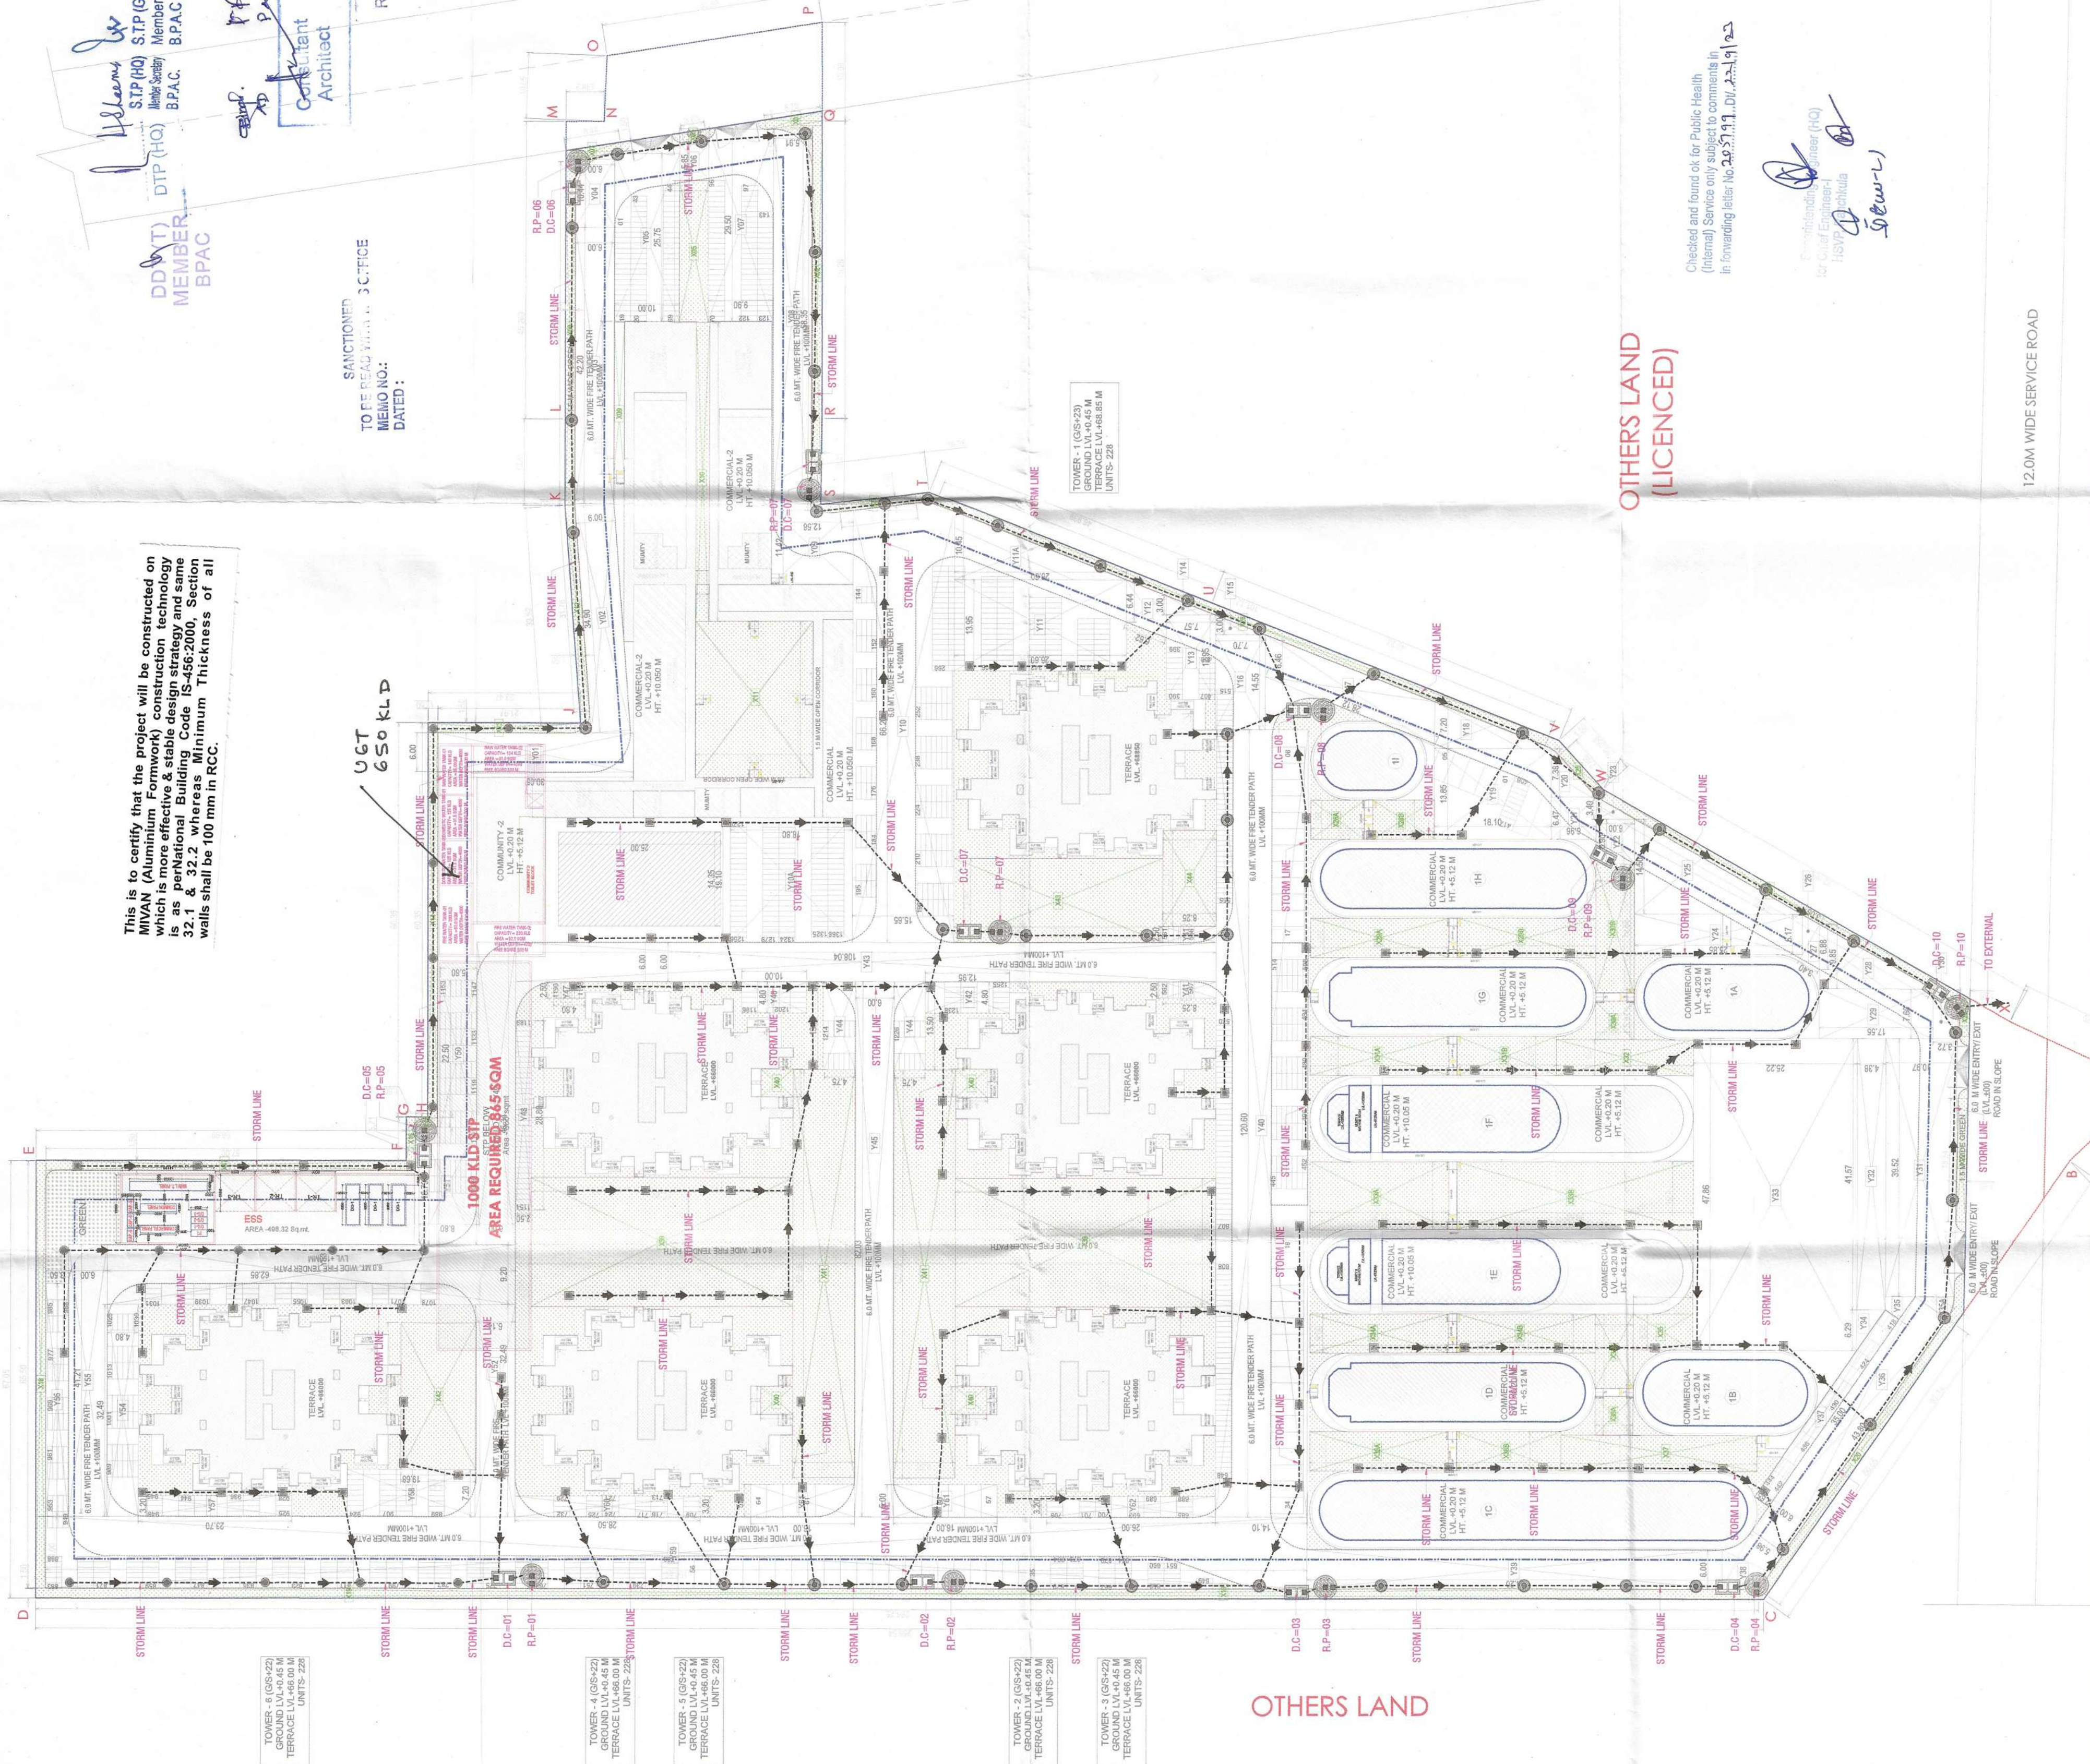

PLUMBING & FIRE SERVICES LEGEND :	
	SEWER MANHOLE WITH 500MM S.R.C. MANHOLE COVER
	STORM WATER MANHOLE WITH 500MM S.R.C. PERFORATED MANHOLE COVER
	CATCH BASIN (450 x 450) MM WITH PERFORATED MANHOLE COVER
	CATCH BASIN (600 x 600) MM WITH PERFORATED MANHOLE COVER
	STORM WATER MANHOLE (600 x 600) MM WITH PERFORATED MANHOLE COVER
	SEWER MANHOLE (600 x 600) MM
	SEWER MANHOLE (800 x 800) MM
	GULLY TRAP (300 x 300) MM
	EXTERNAL SW SEWER LINE (DA AS / DESIGN CHART)
	EXTERNAL RCC STORM WATER LINE (DA AS / DESIGN CHART)
	1500 DI MUNICIPAL WATER SUPPLY LINE
	8 DOMESTIC WATER SUPPLY LINE
	6 FLUSHING WATER SUPPLY LINE
	HDPE GARDEN IRRIGATION WATER SUPPLY LINE
	GARDEN HYDRANT WITH CHAMBER (300x300) MM
	R.P.
	D.C.
	4 WAY FIRE BRIGADE INLET CONNECTION FOR FIRE TANK PIPE DIA 1500
	2 WAY FIRE BRIGADE WITHDRAWAL CONNECTION FROM FIRE TANK PIPE DIA 1500

PROJECT TITLE
PROPOSED BUILDING PLANS OF AFFORDABLE GROUP HOUSING COLONY OVER AN AREA MEASURING 9.90625 ACRES (LICENSE NO. 131 OF 2023 DATED 23.06.2023) JIN REVENUE ESTATE OF VILLAGE MOHAMMADPUR GUJAR AND SOHNA, SECTOR-35, DISTRICT GURUGRAM, BEING DEVELOPED BY TATVASTU REALTY PRIVATE LIMITED (FORMERLY KNOWN AS SEDULOUS REALTECH PVT. LTD.)

LC-4982

OWNERS SIGNATURE

ARCHITECT'S SIGNATURE

DRAWING TITLE

EXTERNAL SITE PLAN
STORM LAYOUT

ARCHITECT	GANGA REALTY - DESIGN TEAM	NORTH
DATE	NOVEMBER, 2022	DWG. NO.
SCALE	1:550	P-102
DEALT	DA	CHECKED
	NKM	