


60 M WIDE SECTOR ROAD

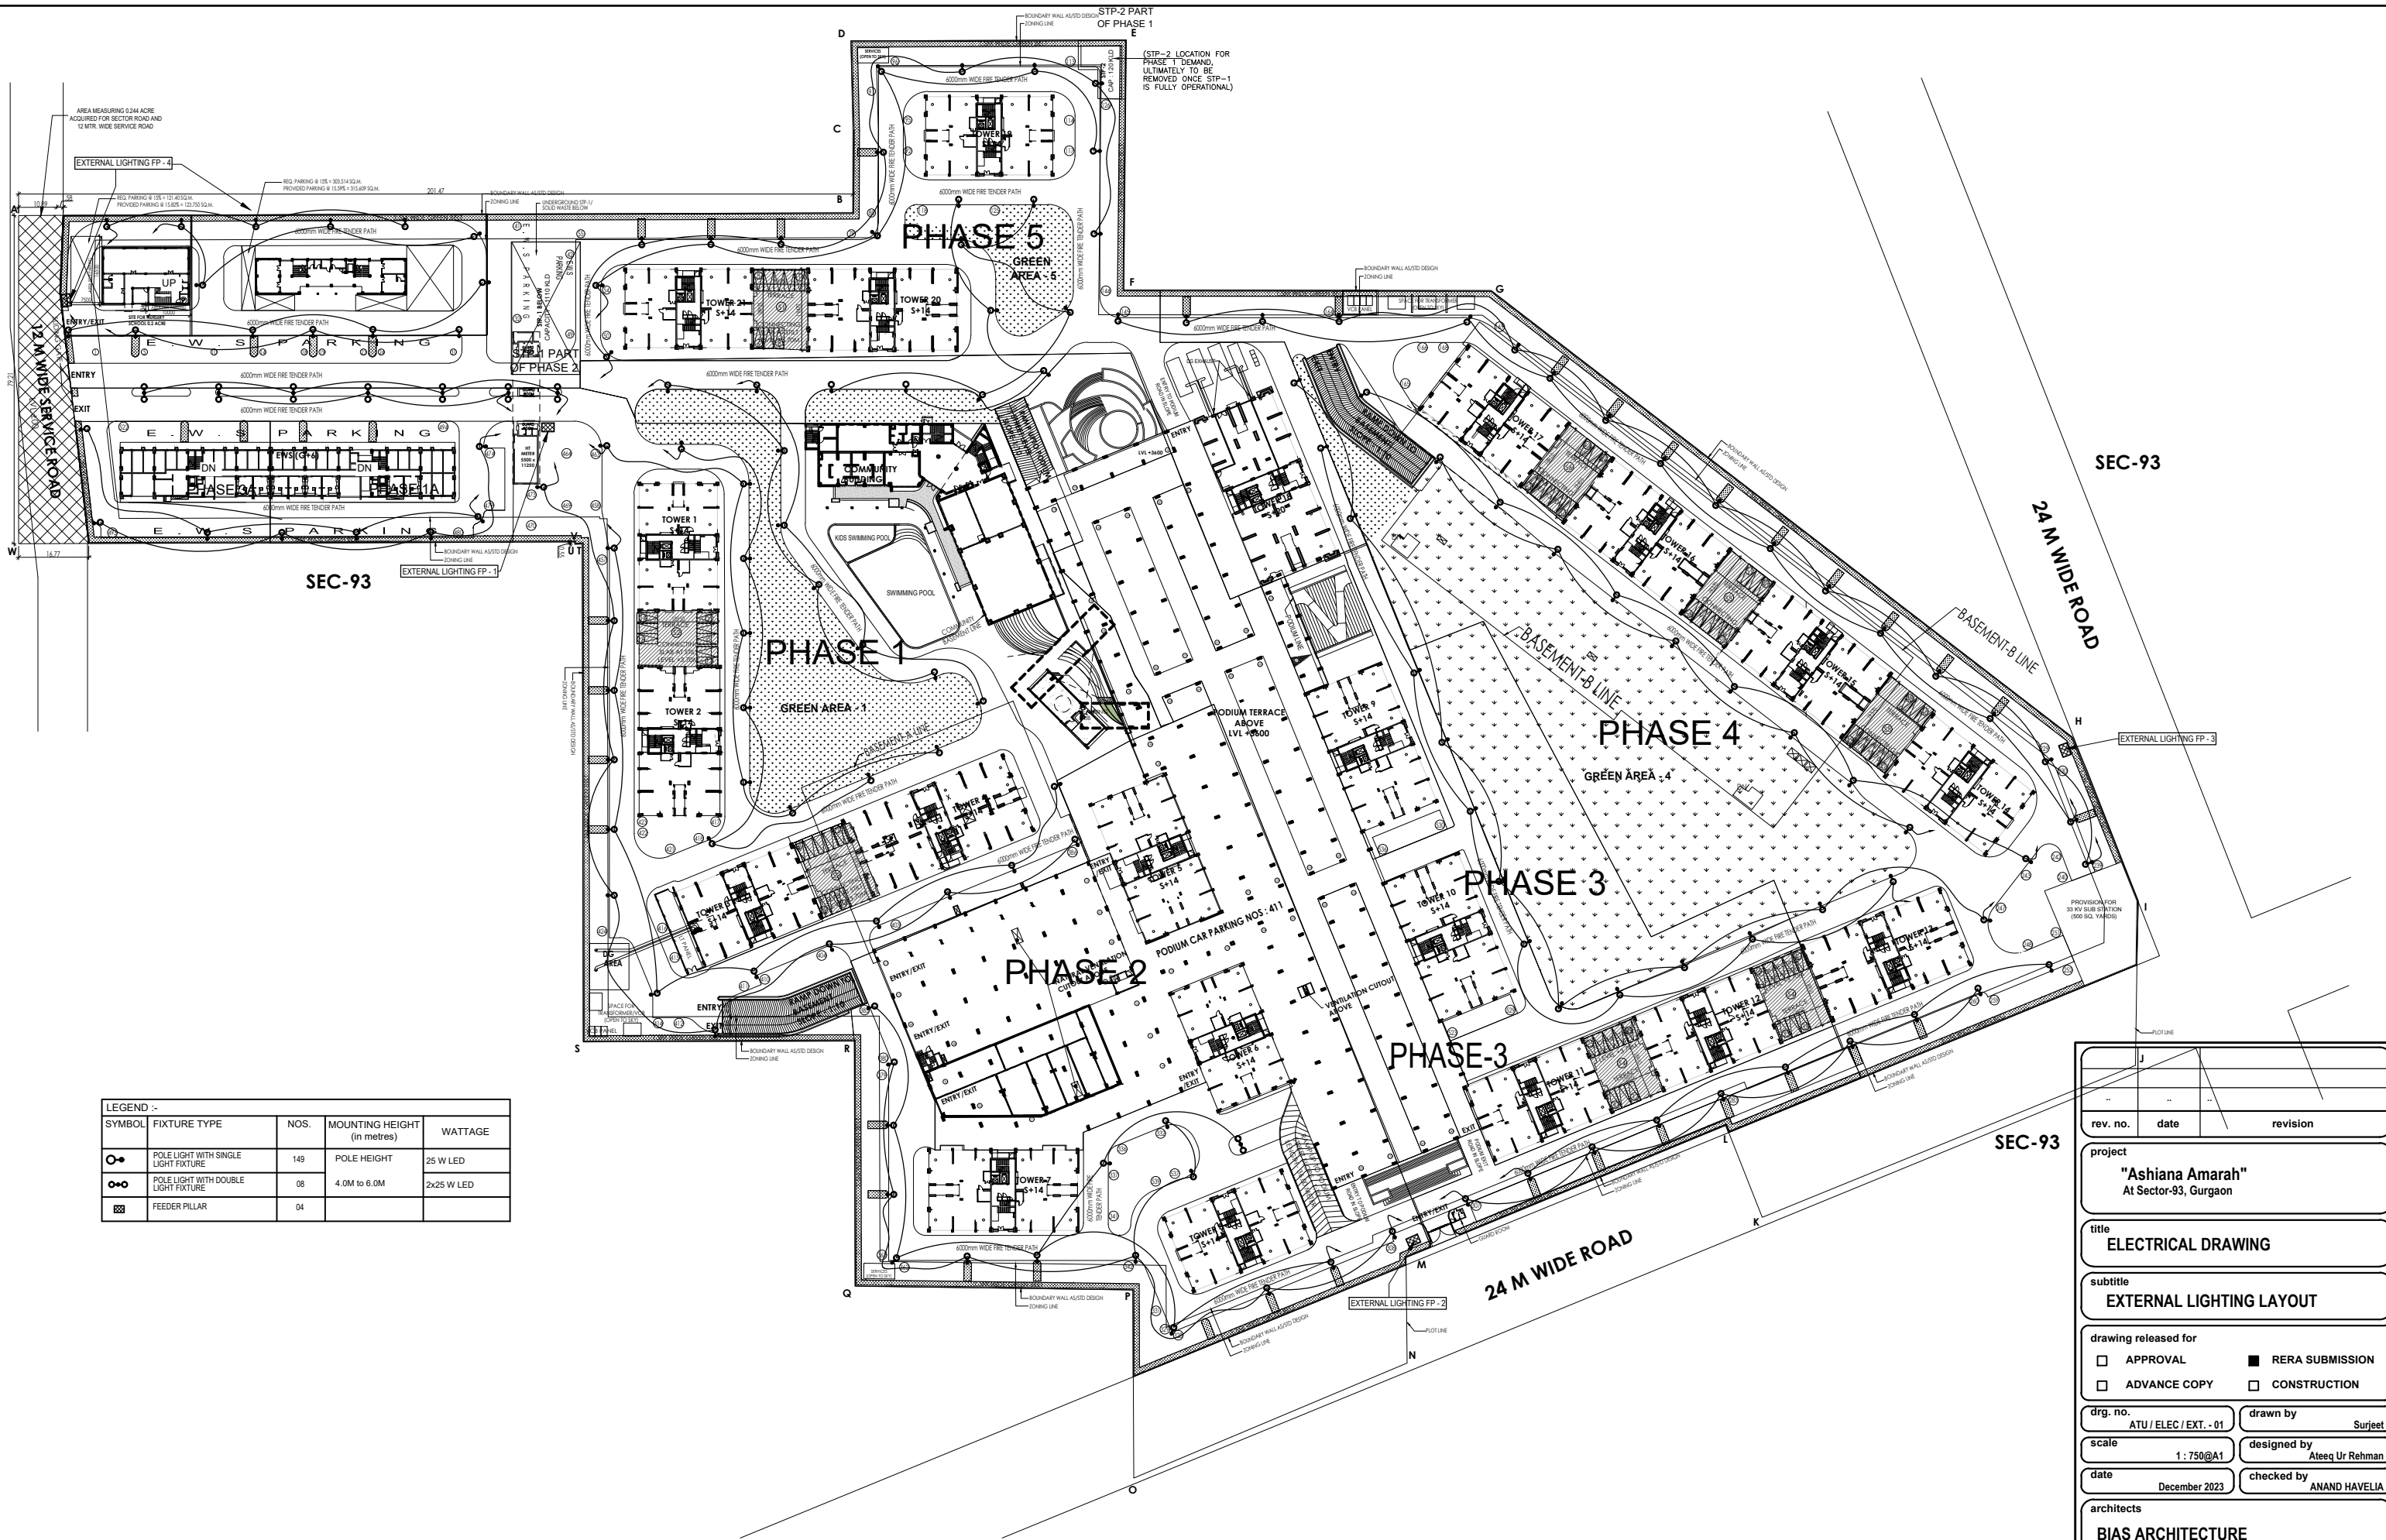

LEGEND :-				
SYMBOL	FIXTURE TYPE	NOS.	MOUNTING HEIGHT (in metres)	WATTAGE
	POLE LIGHT WITH SINGLE LIGHT FIXTURE	149	POLE HEIGHT	25 W LED
	POLE LIGHT WITH DOUBLE LIGHT FIXTURE	08	4.0M to 6.0M	2x25 W LED
	FEEDER PILLAR	04		

rev. no.	date	revision

project

"Ashiana Amarah"
At Sector-93, Gurgaon

title

ELECTRICAL DRAWING

subtitle

EXTERNAL LIGHTING LAYOUT

drawing released for

☐ APPROVAL

☒ RERA SUBMISSION

☐ ADVANCE COPY

☐ CONSTRUCTION

drg. no.

ATU / ELEC / EXT. - 01

drawn by

Surjeet

scale

1 : 750@A1

designed by

Ateeq Ur Rehman

date

December 2023

checked by

ANAND HAVELIA

architects

BIAS ARCHITECTURE
502, Tower No. 12, Commonwealth Games Village, New Delhi 110 092, India
t : +91 11 2121 1603/606 www.biasarchitecture.com

services consultant

Consummate Engineering Services (P) Ltd.
Noida Office : B - 67, Sector - 67, Noida - 201 301
Tel : (0120) 2303500 (24 Lines)
Lik. Office : R 006, Rohitas Plumeria, Gomti Nagar, Lucknow
e mail : mail@cespl.in, website : www.cespl.in