



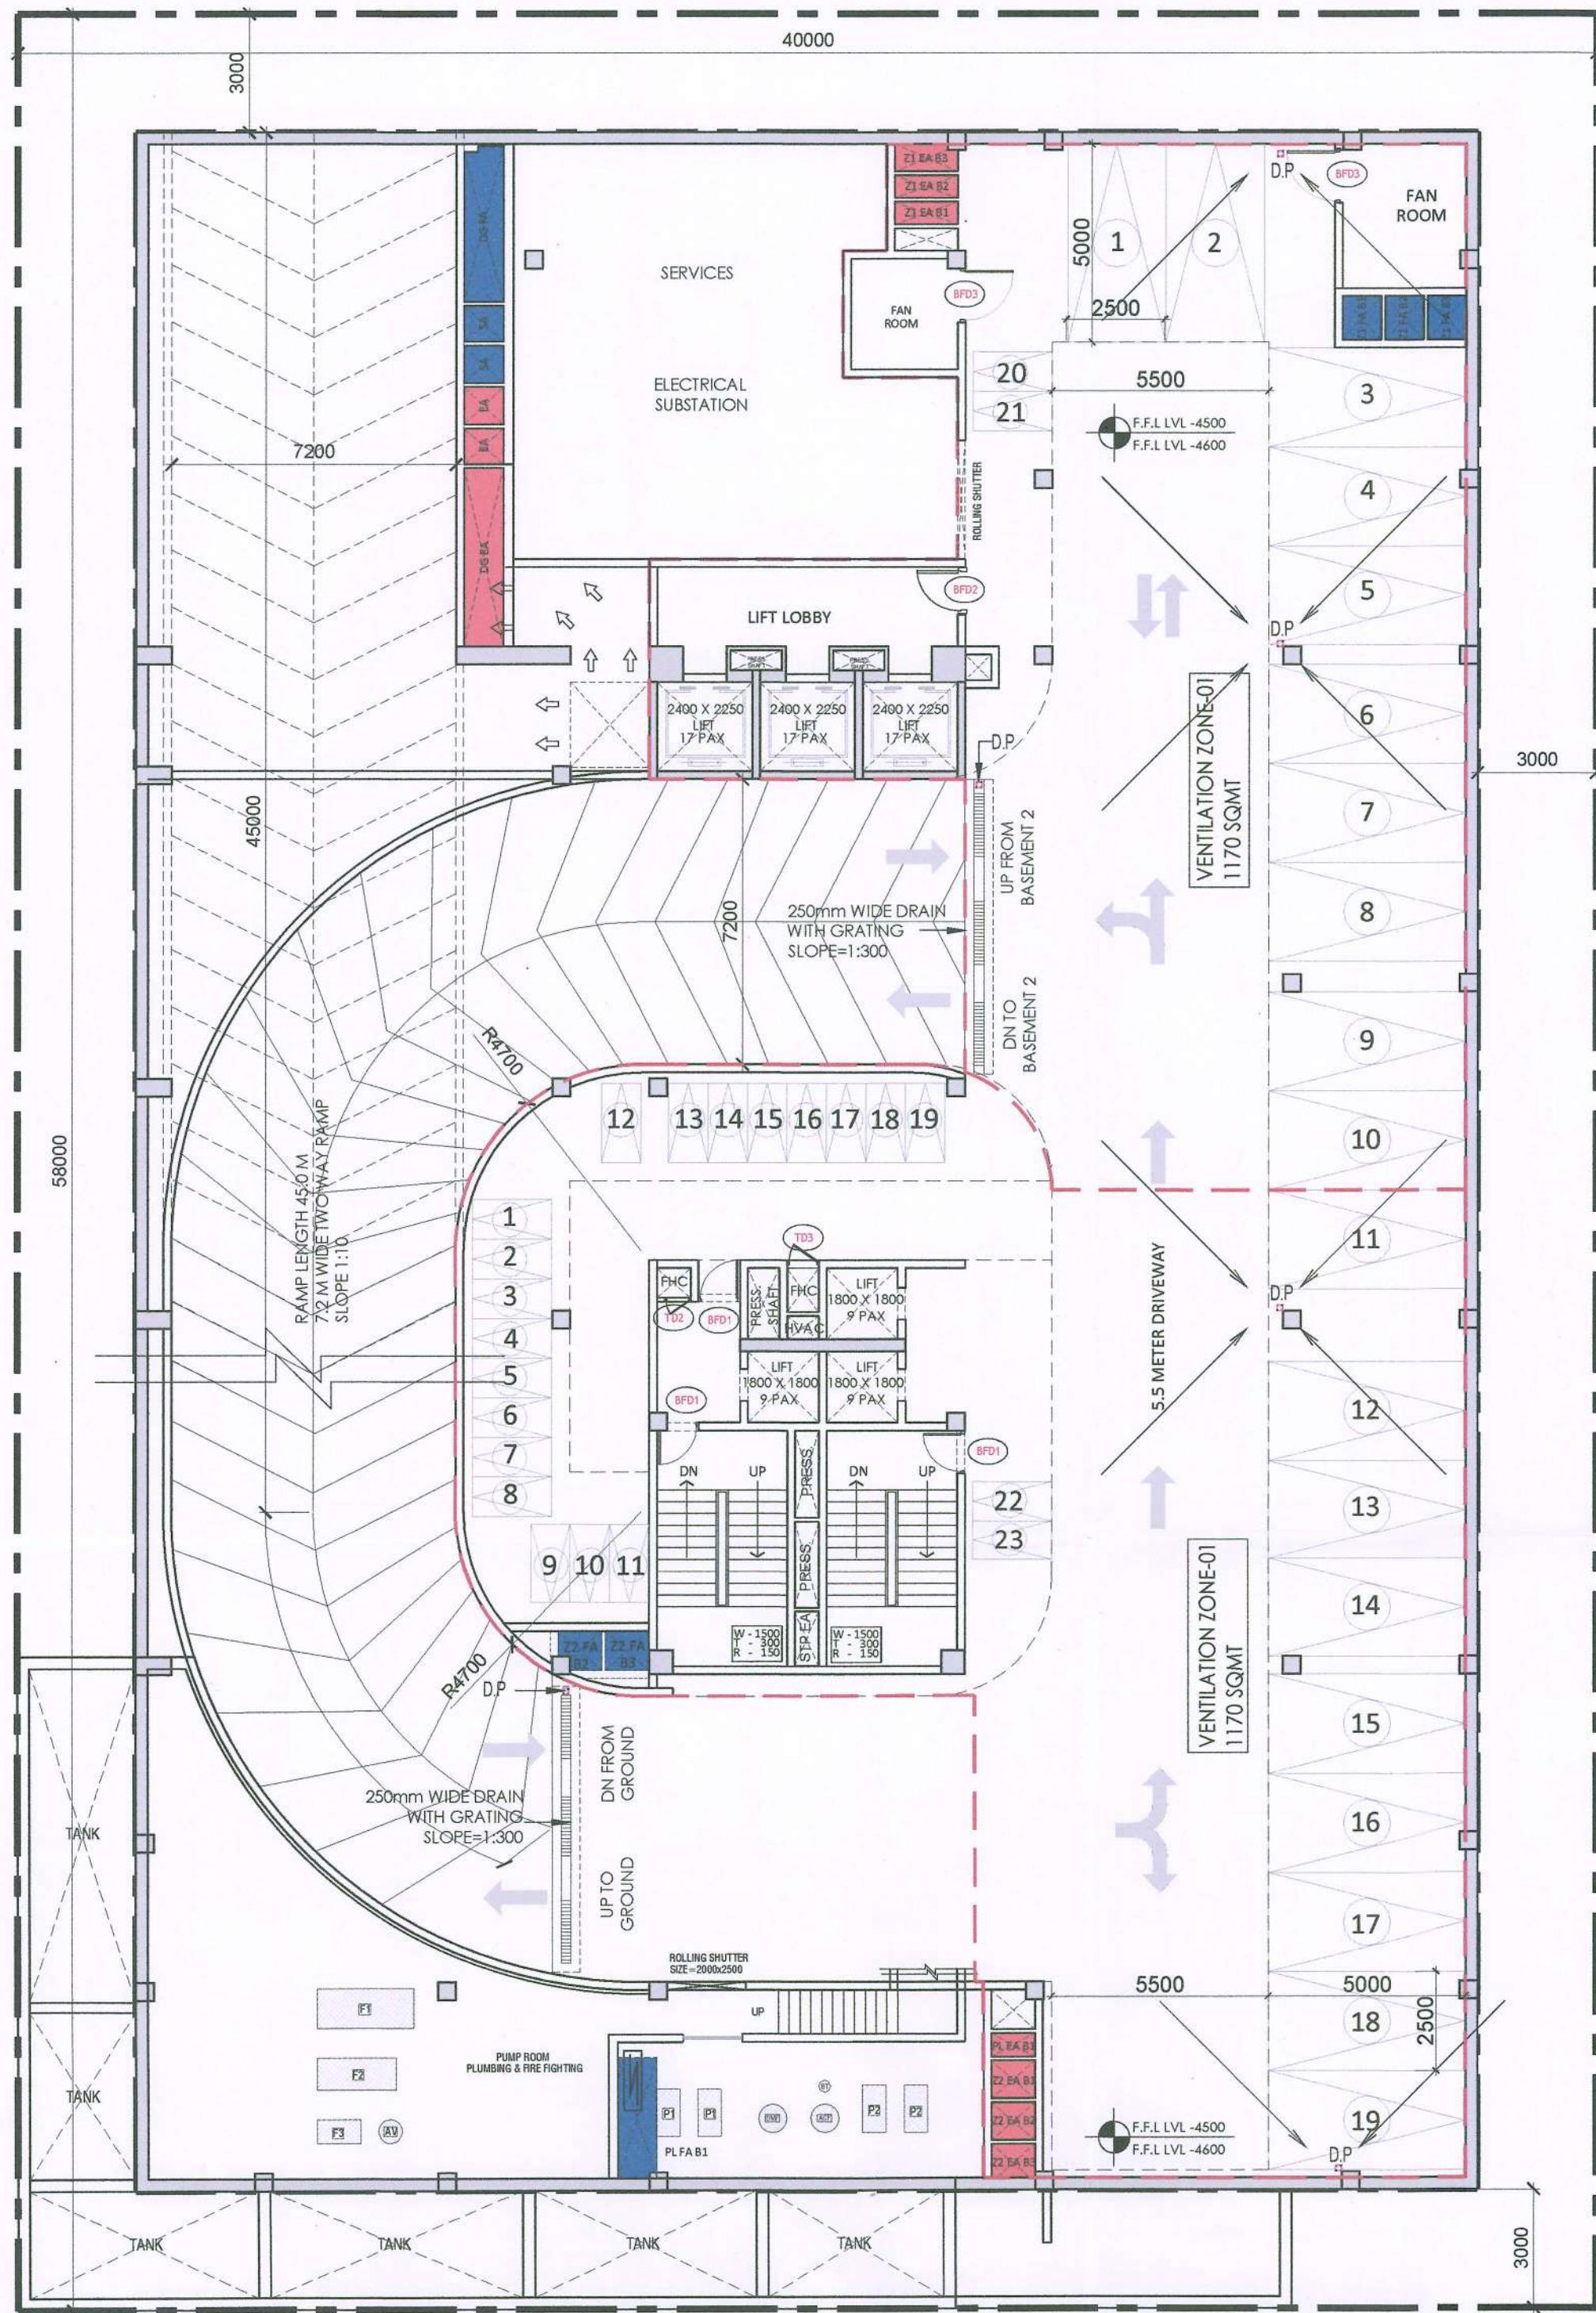

BASEMENT 1
SCALE 1: 150

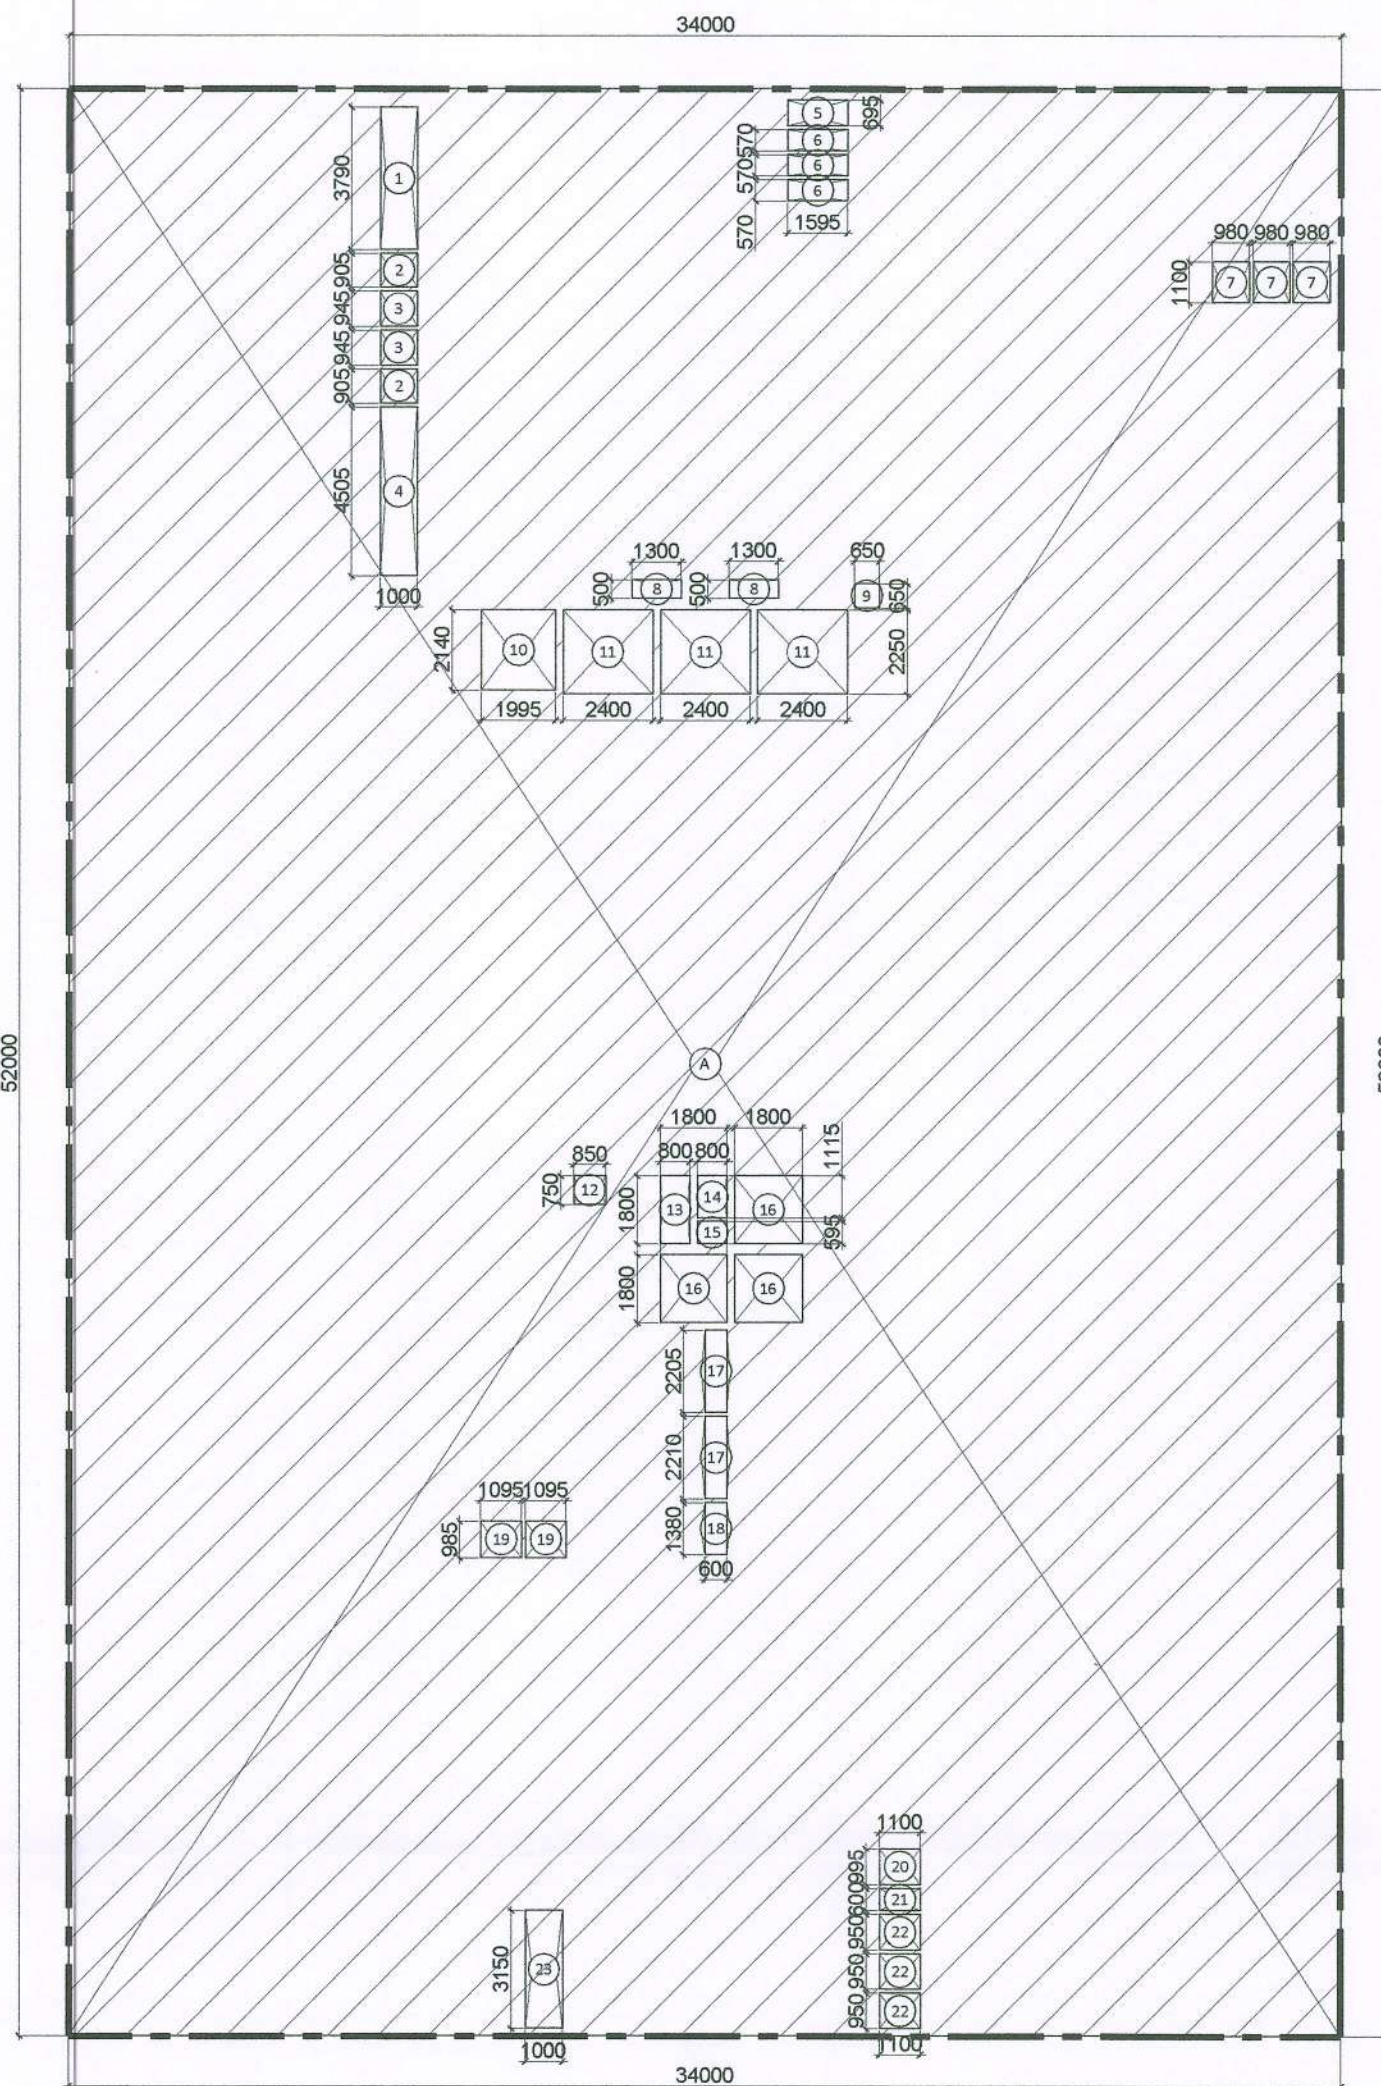

BUILTUP AREA DIAGRAM
SCALE 1:200

BASEMENT 1 BUILT UP AREA CALCULATION				
ADDITION				
LEGEND	WIDTH (MM)	LENGTH (MM)	NOS.	AREAS (M ² .SQ)
A	3400	5200	1	1768.00
TOTAL AREA (A)				1768.00
SUBTRACTIONS				
AREA (RECTANGLE)				
LEGEND	WIDTH (MM)	LENGTH (MM)	NOS.	AREAS (M ² .SQ)
1	1000	3750	1	3.75
2	1000	505	2	1.01
3	1000	945	2	1.89
4	1000	4505	1	4.51
5	1095	695	1	1.11
6	1095	570	3	2.73
7	980	1100	3	3.23
8	1300	500	2	1.30
9	650	650	1	0.42
10	1095	2140	1	4.27
11	2400	2250	3	16.20
12	850	720	1	0.61
13	800	1800	1	1.44
14	800	1115	1	0.89
15	800	595	3	1.43
16	1300	1800	2	6.48
17	600	2205	2	2.65
18	600	1380	1	0.83
19	1095	985	2	2.16
20	1100	995	1	1.09
21	1100	600	1	0.66
22	1100	650	3	2.15
23	1000	3150	1	3.15
TOTAL AREA (B)				64.81
BUILT UP AREA BASEMENT 1 (A - B = C)				1703.19
BASEMENT 1 SERVICE AREA CALCULATION				
ADDITION				
LEGEND	WIDTH (MM)	LENGTH (MM)	NOS.	AREAS (M ² .SQ)
A	8000	10500	1	84.00
B	3340	5150	1	17.20
C	AS SHAPE		1	272.45
D	AS SHAPE		1	15.30
E	AS SHAPE		1	50.52
F	AS SHAPE		1	2.38
G	AS SHAPE		1	138.51
H	1500	4950	1	7.43
TOTAL SERVICE AREA (D)				588.19

BASEMENT 1				
SLNO.	TAG.	Rough Opening		REMARKS
		Width	Height	
FIRE DOOR SCHEDULE				
1	8FD1	1300	2450	Staircase
2	8FD2	1200	2450	Lift lobby
3	8FD3	1350	2450	Fan room
SERVICE DOOR SCHEDULE				
1	TD1	1150	2450	SERVICE
2	TD2	800	2450	FHC SERVICE
3	TD3	650	2450	FHC SERVICE


PARKING					
A.	ON SURFACE	2 NOS. HANDICAP PARKING			
B.	IN BASEMENT	125 CARS			
BASEMENT PARKING CALCULATION					
BASEMENT LVL	BUILT UP	SERVICES	AREA FOR PARKING	ACTUAL NO. OF CARS	
				PARKING SLOTS	TOTAL NO.
BASEMENT 1	1703.19	588.19	1115.00	19 DOUBLE STACK	38
BASEMENT 2	1560.27	551.33	1008.94	19 DOUBLE STACK	38
BASEMENT 3	1725.65	541.31	1184.34	22 DOUBLE STACK	44
				5 SINGLE CARS	5
TOTAL	4989.11	1680.83	3308.28		125
TOTAL(A+B)					127

LEGEND	
	FRESH AIR CUTOUT
	EXHAUST CUTOUT
	VENTILATION ZONE

LEGEND FOR FIRE EQUIPMENTS	
F1	COMMON DIESEL ENGINE PUMP
F2	ELECTRICAL HYDRANT PUMP
F3	ELECTRICAL HYDRANT JOCKEY PUMP
F4	ELECTRICAL SPRINKLER PUMP
F5	ELECTRICAL SPRINKLER JOCKEY PUMP


LEGEND FOR FIRE EQUIPMENTS	
P1	DUAL MEDIA FILTER FEED / S.T.P MAKE-UP PUMPS
P2	DOMESTIC WATER TRANSFER PUMPS
DMF	DUAL MEDIA FILTER
ACF	ACTIVATED CARBON FILTER
BT	BRINE TANK

PLUMBING LEGEND	
(A)	1000 G.I DRAIN PIPE
G.L.	GROUND LEVEL
F.F.L.	FINISHED FLOOR LEVEL
T.O.S.	TOP OF SLAB
T.O.W.	TOP OF WATER
T.O.C.	TOP OF CUTOUT
D.P.	DRAIN POINT

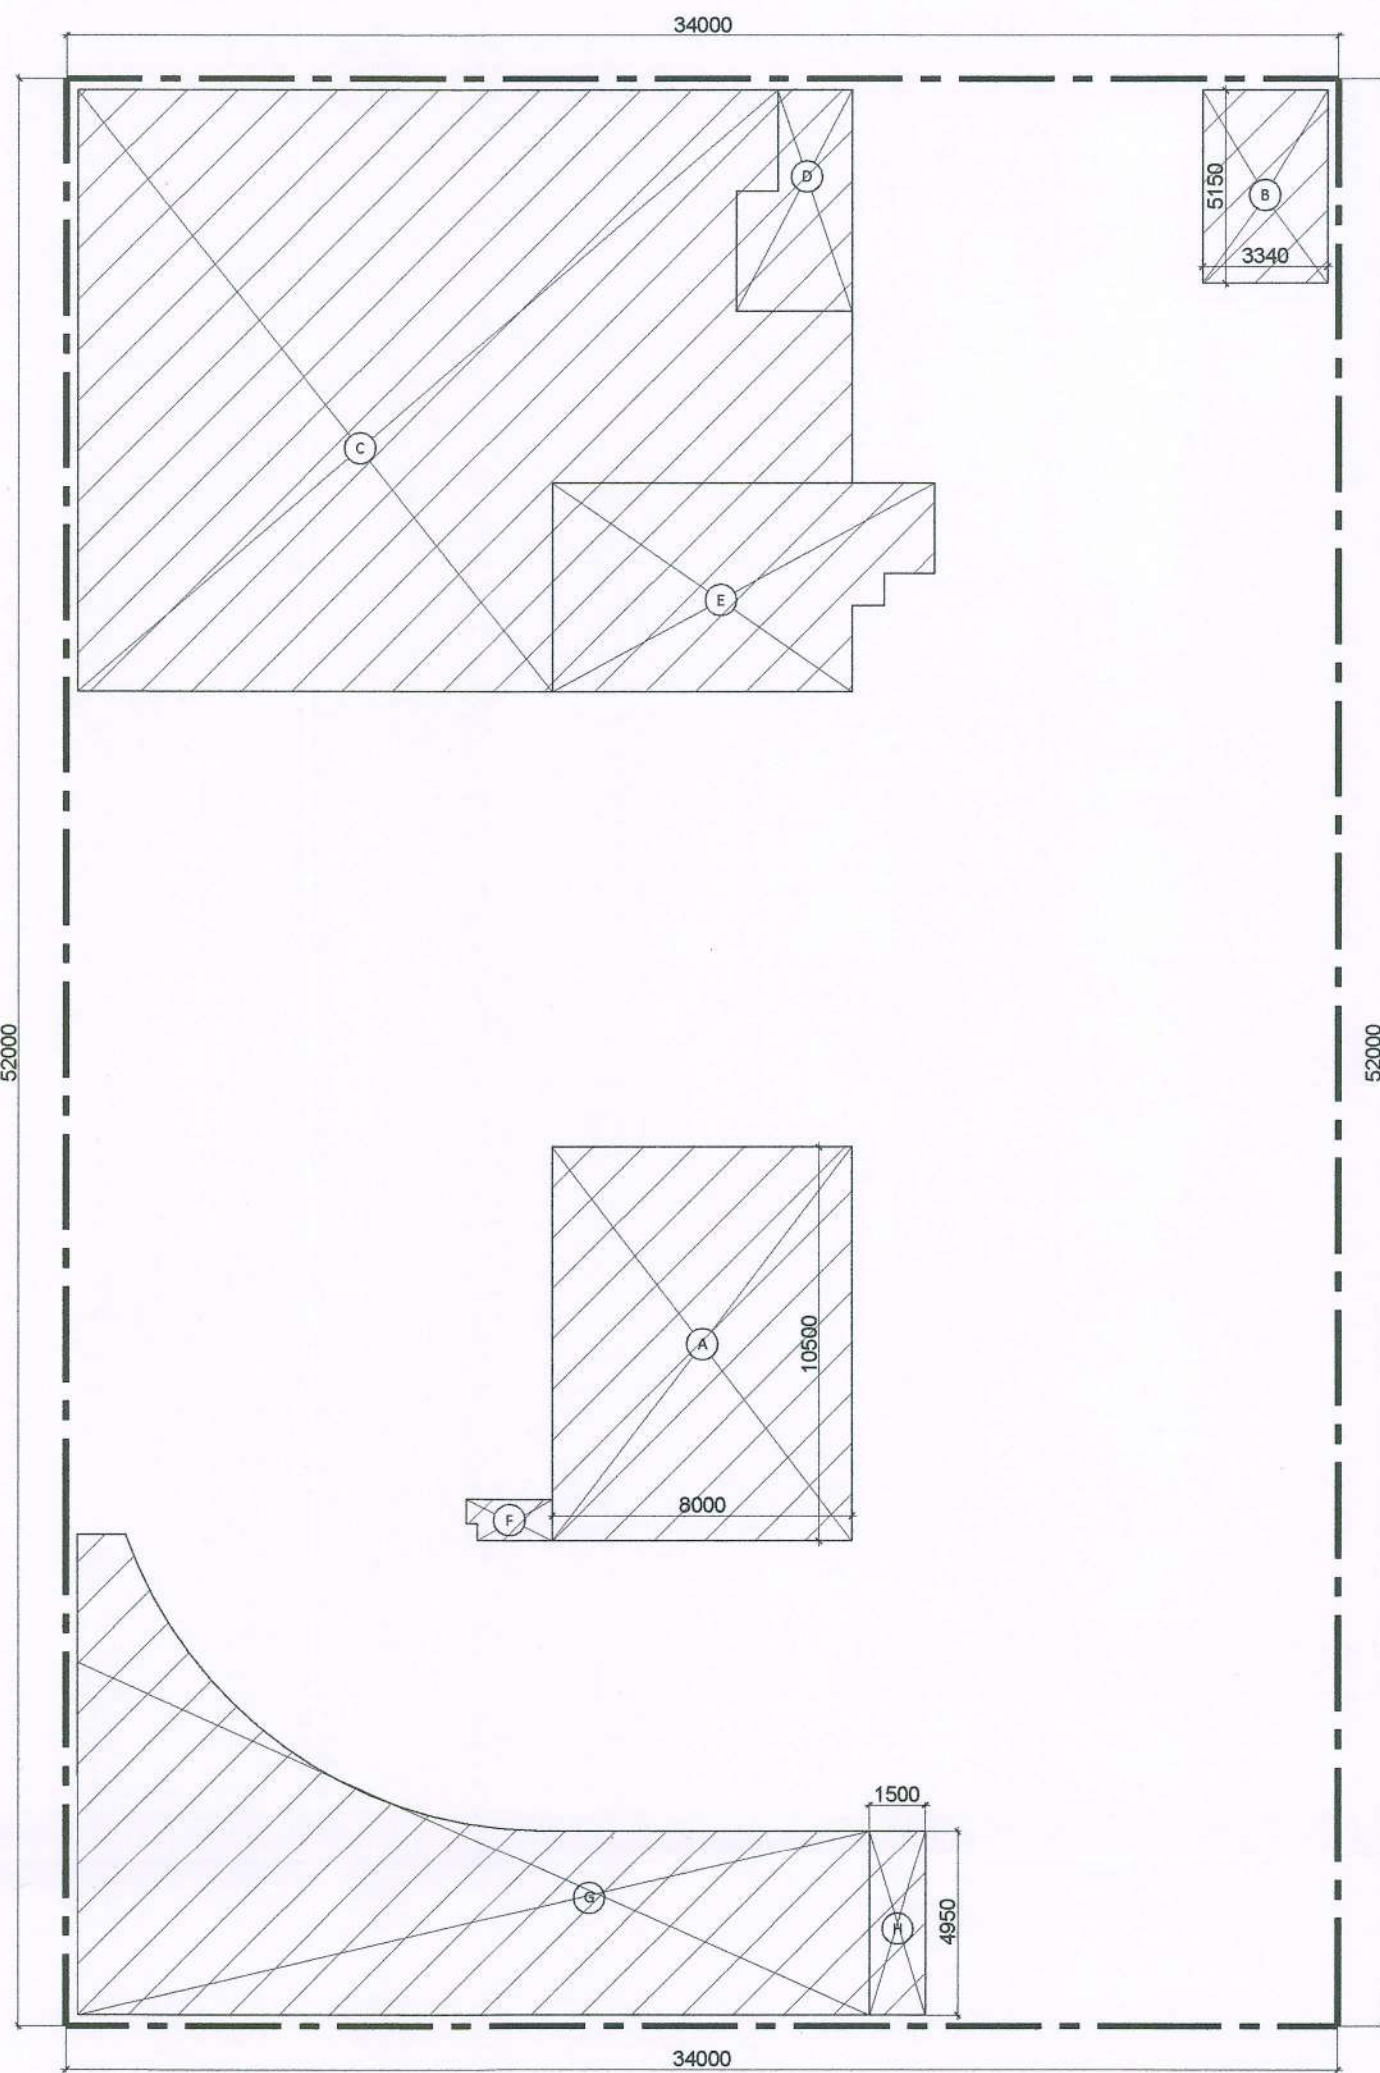

SERVICE AREA DIAGRAM
SCALE 1:200

Authority Signatory
SANCTIONED
Valid For Five Years
Sub. To Condition of Allotment Letter
For ESTATE OFFICER
HSVP GURUGRAM

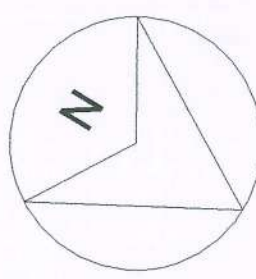


OWNER SIGN
ARCHITECT SIGN
For ESSEL INFRA LLP
A. VIRENRA GOYAL
CA/2019/114662
H.No. 77/2, Patel Nagar, Gurugram


Clients:
ESSEL INFRA LLP
Project Title :
COMMERCIAL COMPLEX SITE C1 IN SHOPPING CENTRE
SECTOR -43, GURUGRAM

Drawing Title :
SUBMISSION DRAWINGS
BASEMENT 1 FLOOR PLAN

Scale :
Date : MAY-2023
Drawn By : S.G
Checked By : A.S
Sheet Size : A1
Drawing No :
CP_BA-01

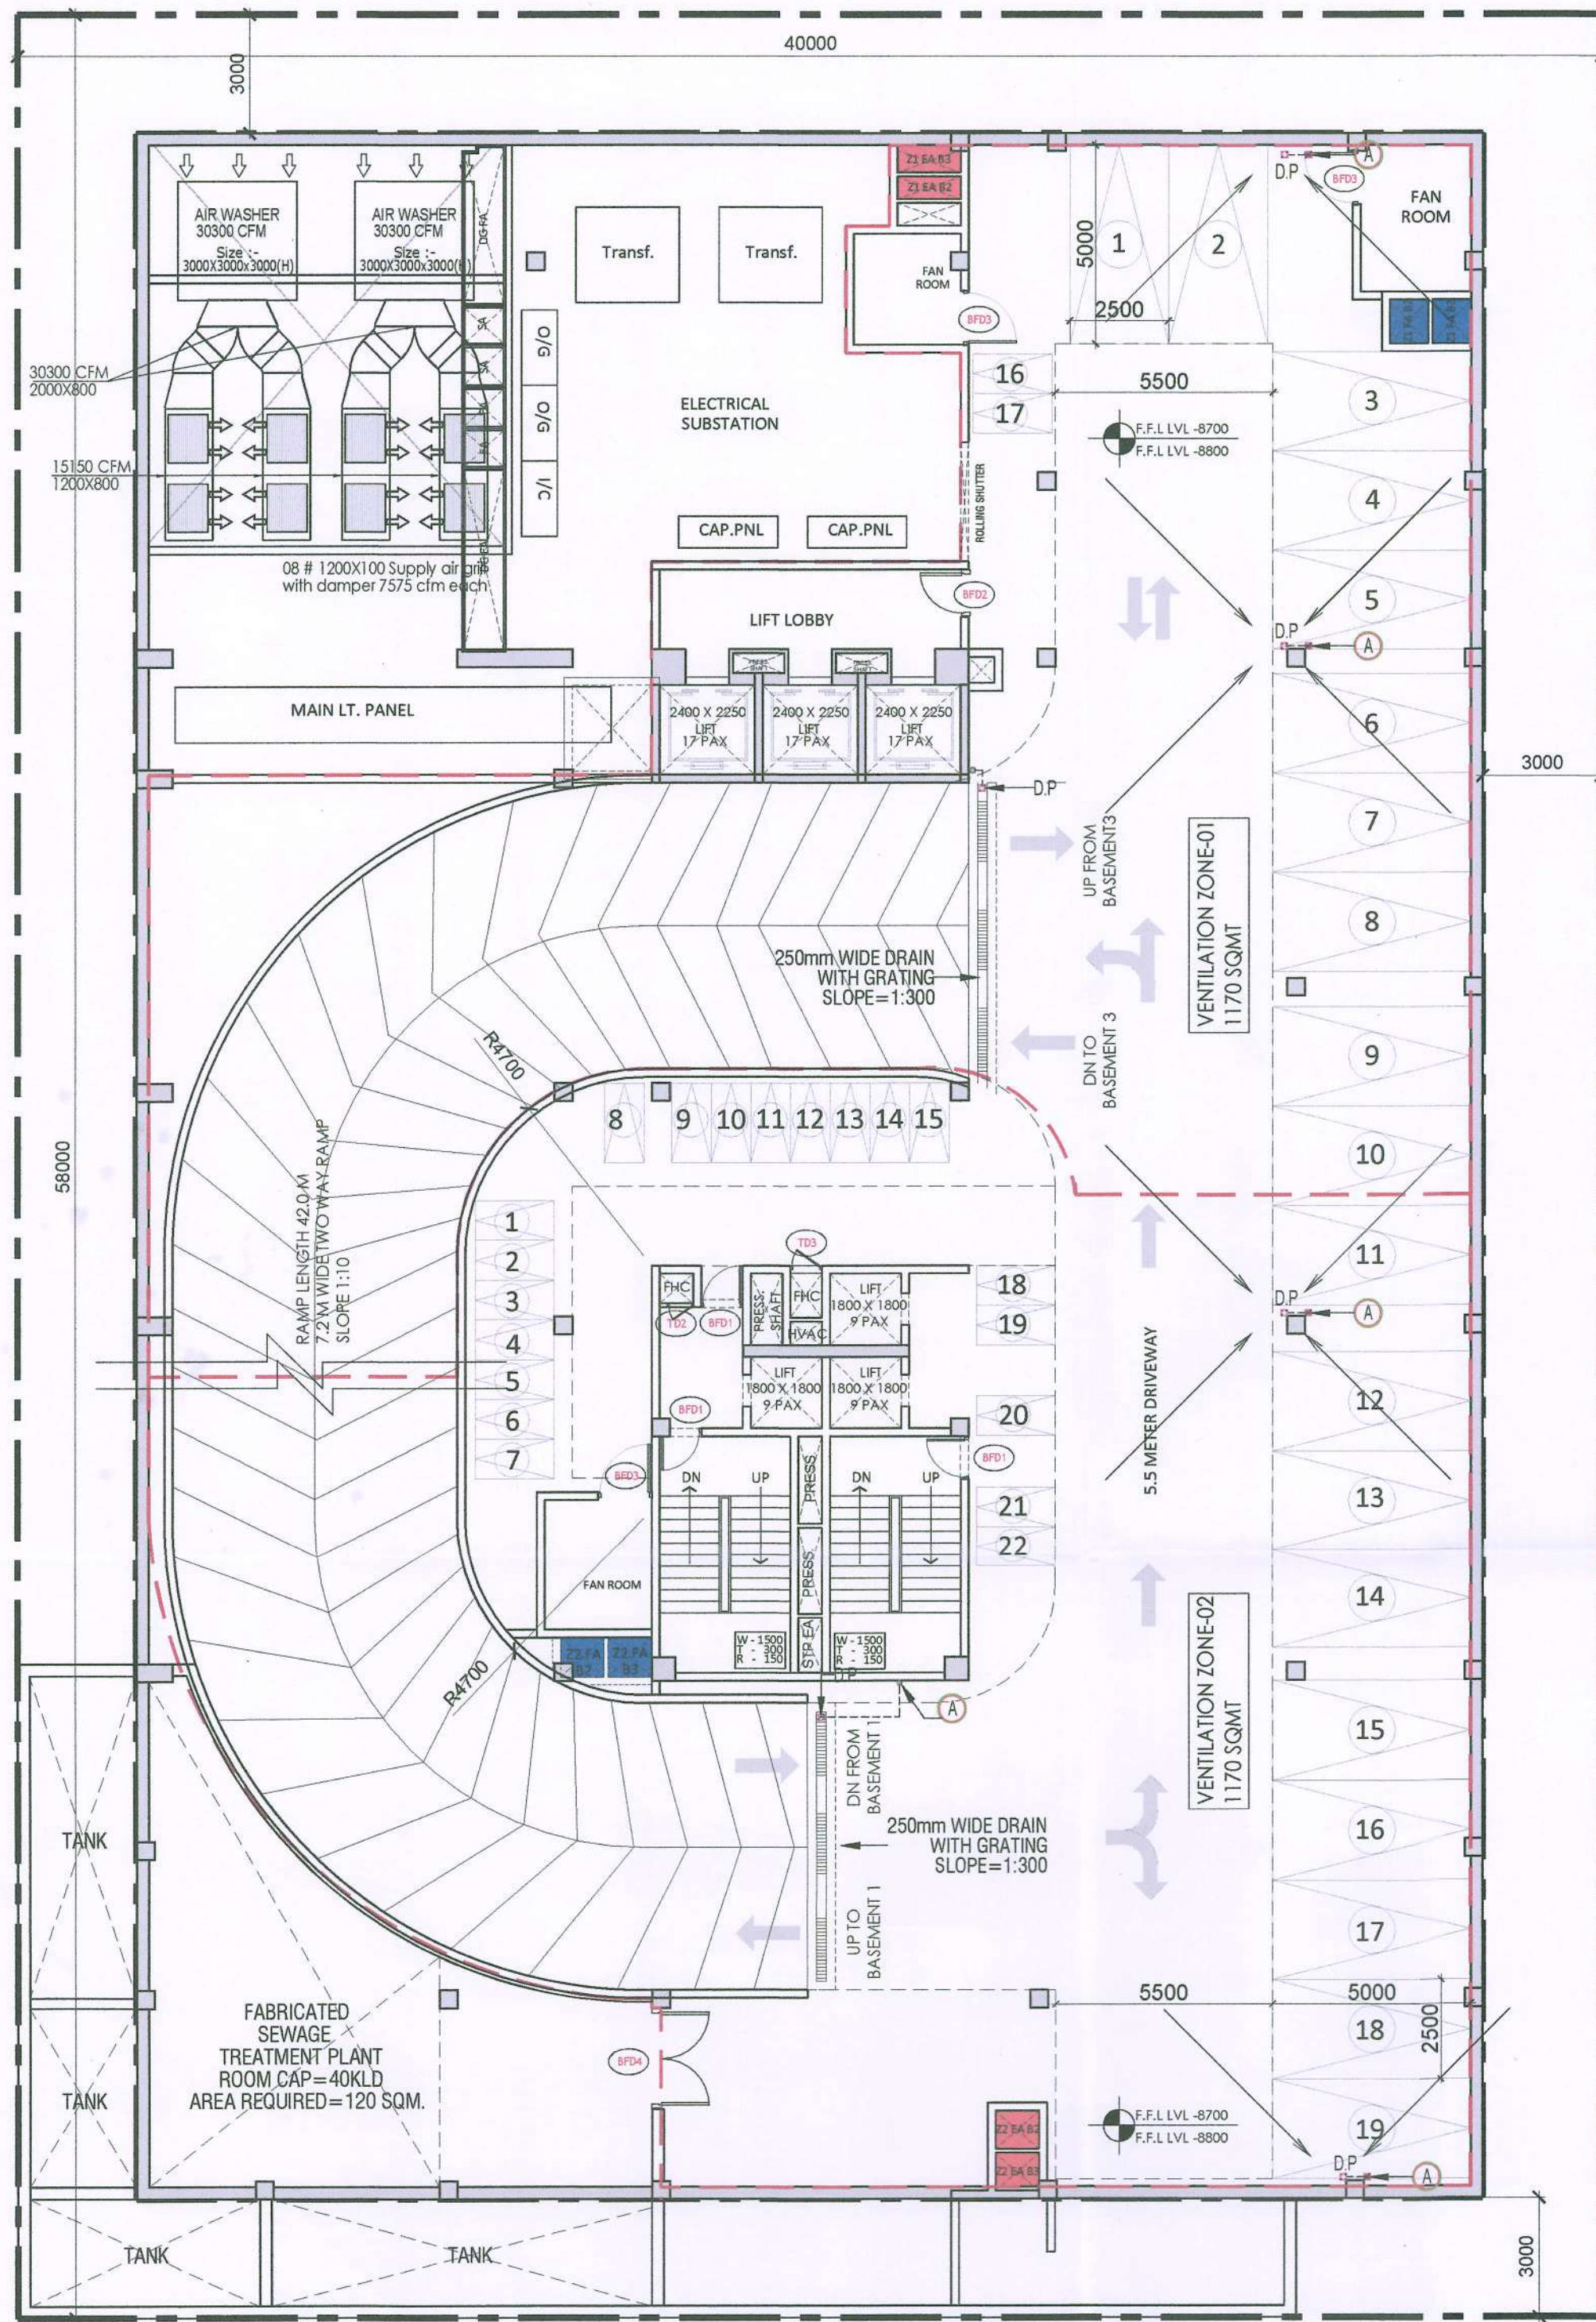


BASEMENT 2
SCALE 1: 150

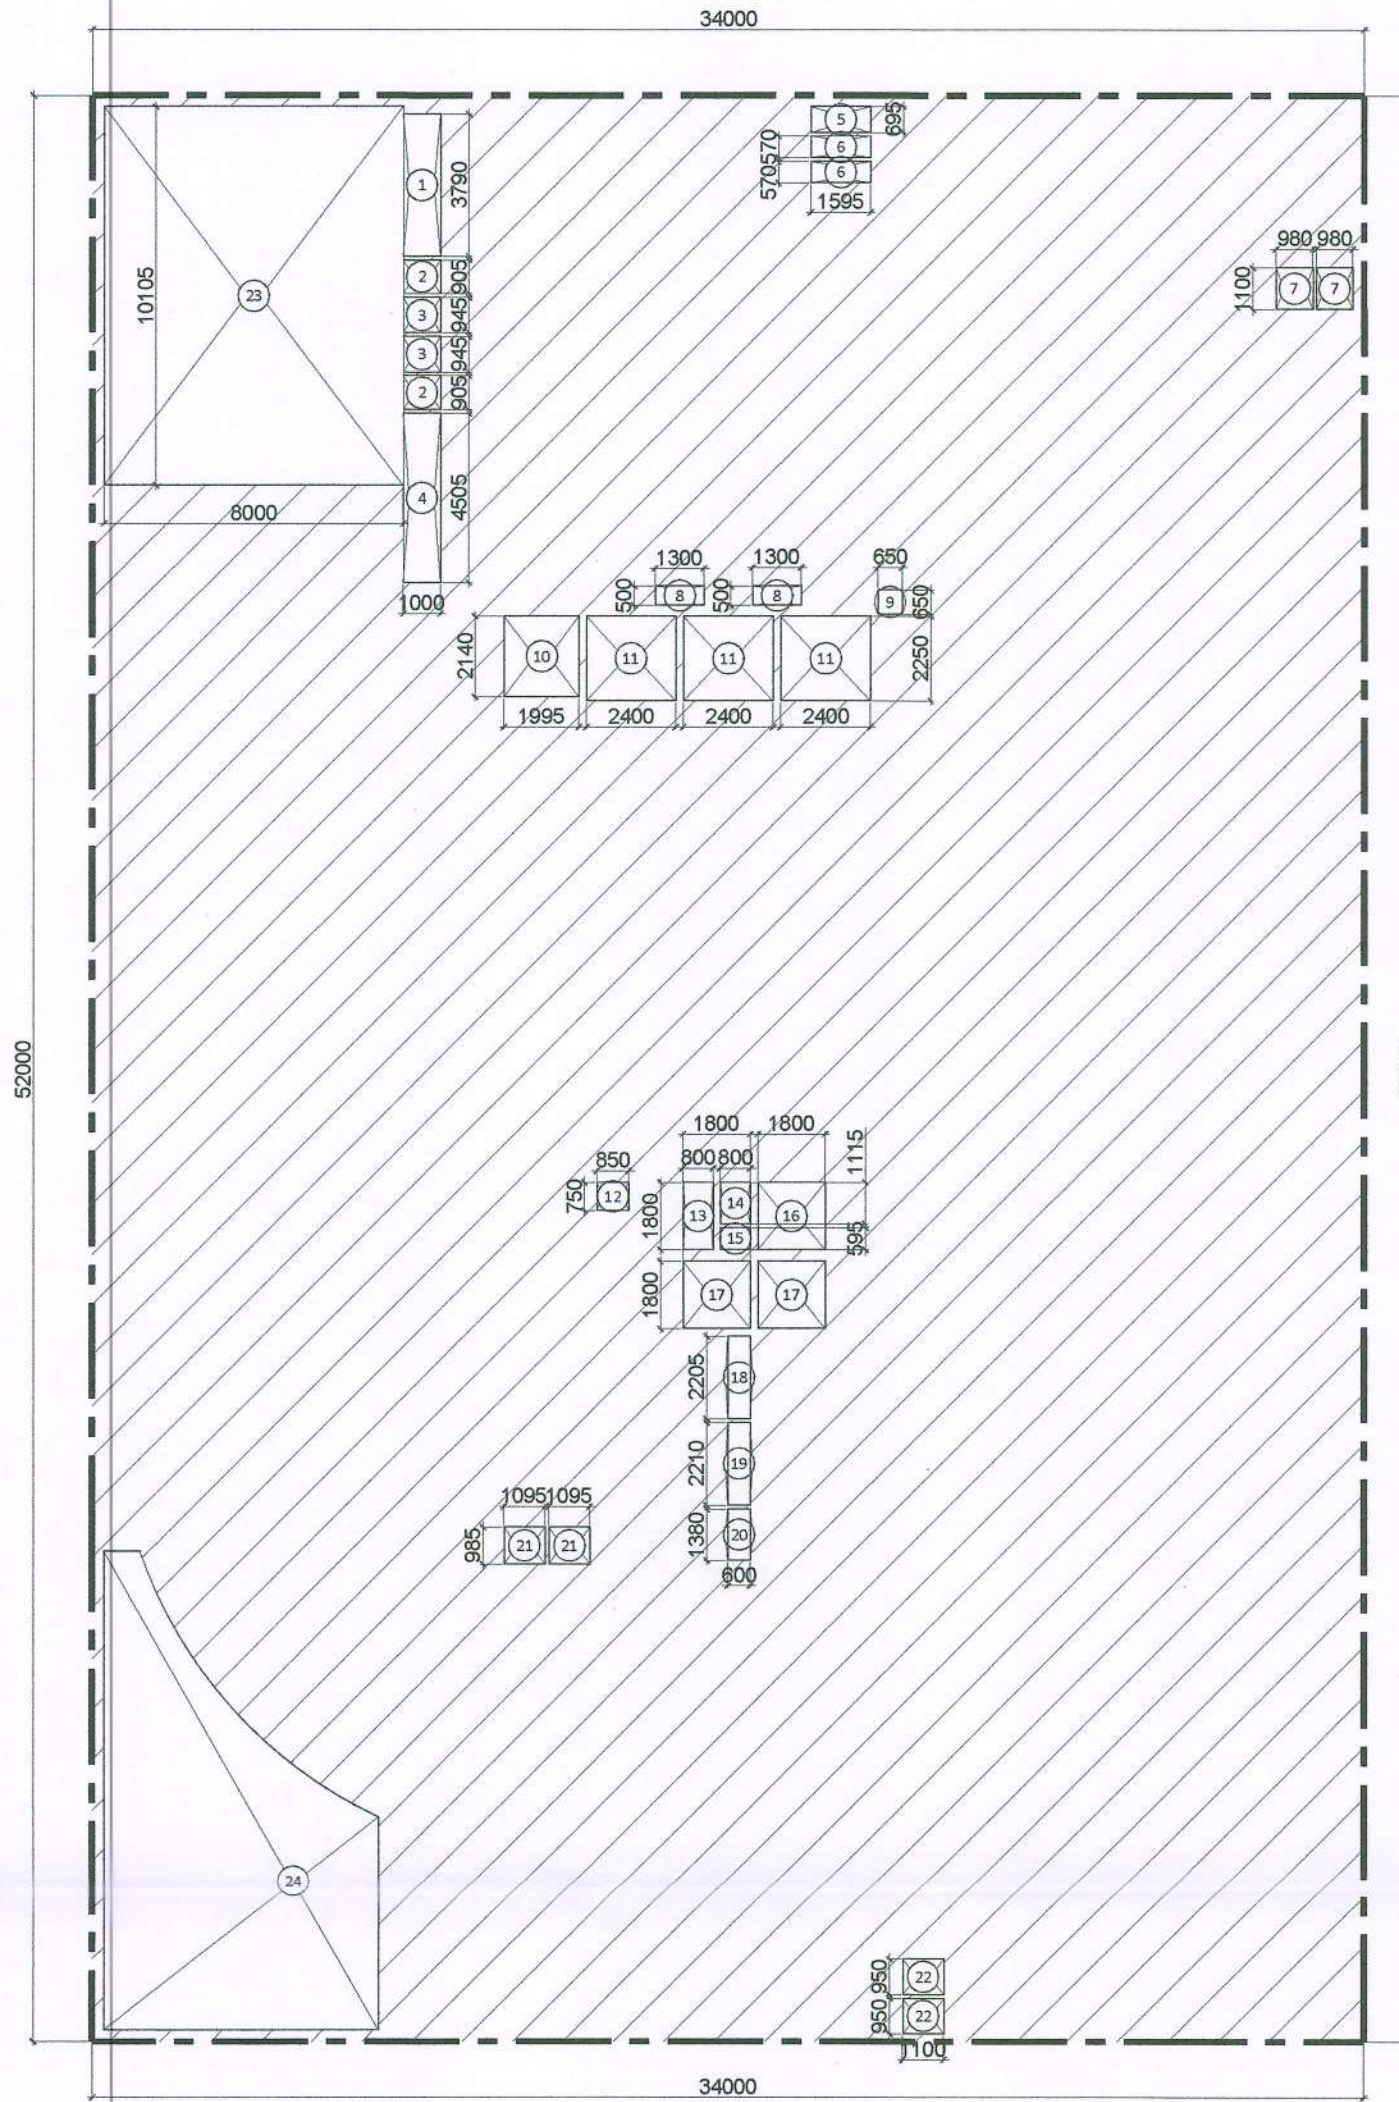

BUILTUP AREA DIAGRAM
SCALE 1:200

BASEMENT 2 BUILT UP AREA CALCULATION				
ADDITION				
LEGEND	WIDTH(MM)	LENGTH(MM)	NOS.	AREAS (MTS.SQ)
A	3000	10500	1	1768.00
TOTAL AREA (A)				1768.00
SUBTRACTIONS				
AREA (RECTANGLE)				
LEGEND	WIDTH(MM)	LENGTH(MM)	NOS.	AREAS (MTS.SQ)
1	1000	3750	1	3.75
2	3000	905	2	5.41
3	3000	945	2	5.67
4	3000	4505	1	13.51
5	1595	695	1	1.11
6	1595	570	2	1.82
7	1100	980	2	2.16
8	1300	500	2	1.30
9	650	650	1	0.42
10	1995	2140	1	4.27
11	2000	2250	3	14.25
12	850	750	1	0.64
13	800	1800	1	1.44
14	800	1115	1	0.89
15	800	595	3	1.43
16	1800	1800	1	3.24
17	1800	1800	2	6.48
18	600	2205	1	1.33
19	600	2210	1	1.33
20	600	1380	1	0.83
21	3095	985	2	6.16
22	1100	950	2	2.09
23	8000	10105	1	80.84
24	AS SHAPE			65.78
TOTAL AREA (B)				207.73
BUILT UP AREA BASEMENT 2 (A - B = C)				1560.27


BASEMENT 2 SERVICE AREA CALCULATION				
ADDITION				
LEGEND	WIDTH(MM)	LENGTH(MM)	NOS.	AREAS (MTS.SQ)
A	8000	10500	1	84.00
B	AS SHAPE			273.82
C	AS SHAPE			13.96
D	AS SHAPE			14.64
E	AS SHAPE			50.52
F	AS SHAPE			12.89
G	AS SHAPE			96.70
H	1500	2200	1	3.30
TOTAL SERVICE AREA (D)				551.33

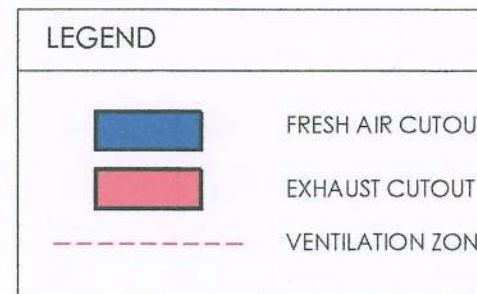

LEGEND FOR FIRE EQUIPMENTS	
F1	COMMON DIESEL ENGINE PUMP
F2	ELECTRICAL HYDRANT PUMP
F3	ELECTRICAL HYDRANT JOCKEY PUMP
F4	ELECTRICAL SPRINKLER PUMP
F5	ELECTRICAL SPRINKLER JOCKEY PUMP

LEGEND FOR FIRE EQUIPMENTS	
P1	DUAL MEDIA FILTER FEED / S.T.P MAKE-UP PUMPS
P2	DOMESTIC WATER TRANSFER PUMPS
DMF	DUAL MEDIA FILTER
ACF	ACTIVATED CARBON FILTER
BT	BRINE TANK

PLUMBING LEGEND	
(A)	1000 G.I DRAIN PIPE
G.L.	GROUND LEVEL
F.F.L.	FINISHED FLOOR LEVEL
T.O.S.	TOP OF SLAB
T.O.W.	TOP OF WATER
T.O.C.	TOP OF CUTOUT
D.P.	DRAIN POINT

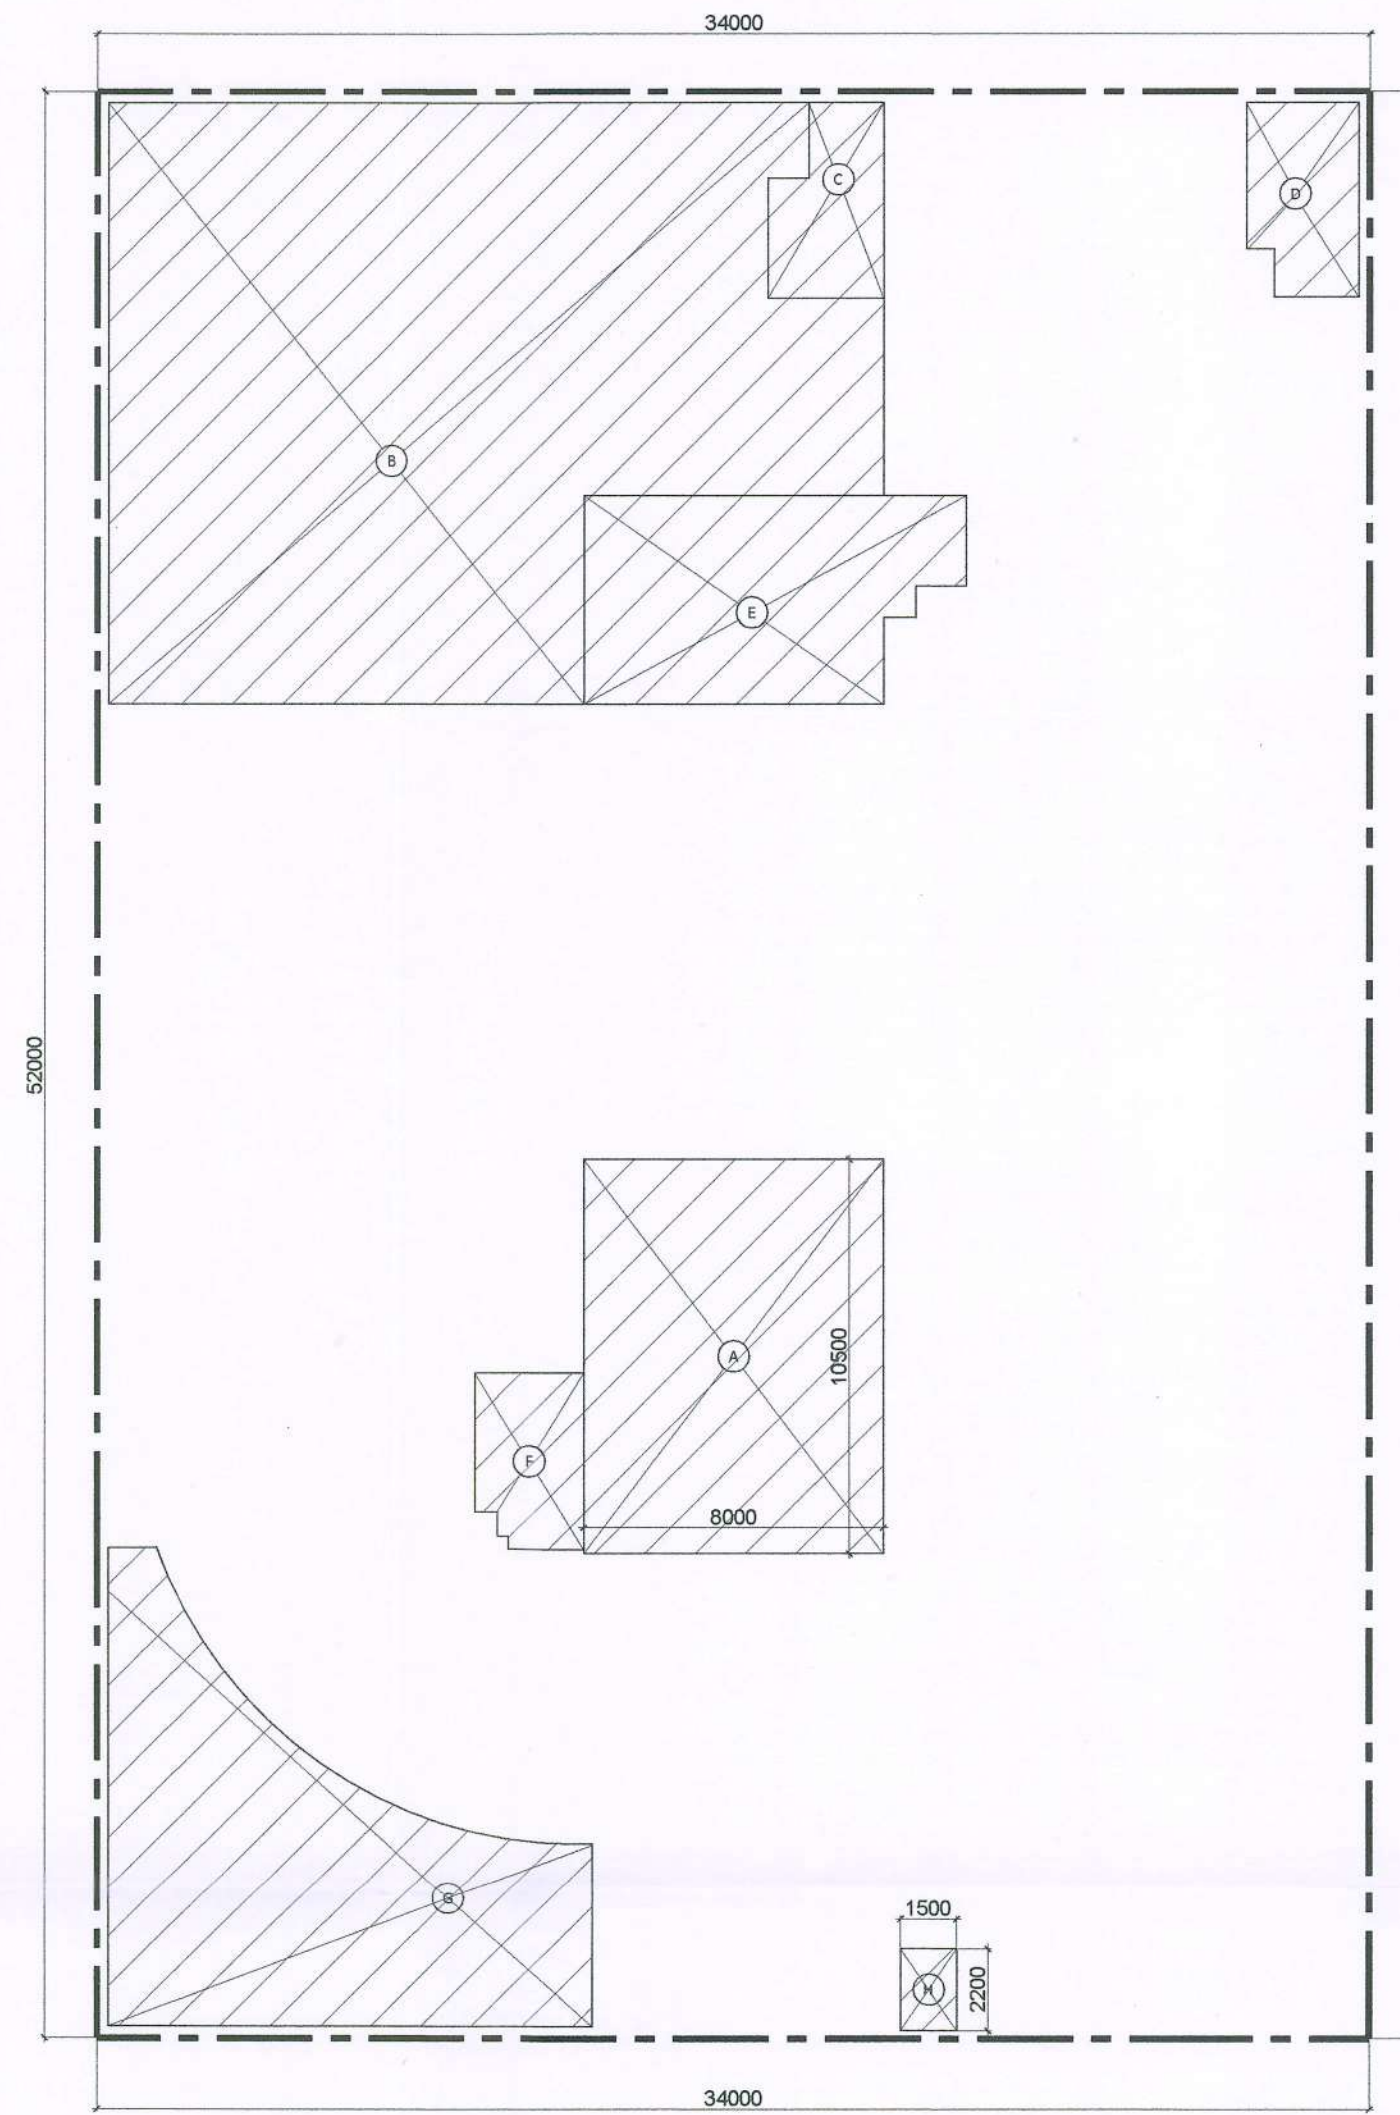


SERVICE AREA DIAGRAM
SCALE 1:200

PARKING					
A.	ON SURFACE	2 NOS. HANDICAP PARKING			
B.	IN BASEMENT	125 CARS			
BASEMENT PARKING CALCULATION					
BASEMENT LVL	BUILT UP	SERVICES	AREA FOR PARKING	ACTUAL NO. OF CARS	
				PARKING SLOTS	TOTAL NO.
BASEMENT 1	1703.19	588.19	1115.00	19 DOUBLE STACK	38
BASEMENT 2	1560.27	551.33	1008.94	19 DOUBLE STACK	38
BASEMENT 3	1725.65	541.31	1184.34	22 DOUBLE STACK	44
TOTAL	4989.11	1680.83	3308.28	5 SINGLE CARS	5
					125
TOTAL(A+B)					127

Authority Signatory : **SANCTIONED**
Valid For Five Years
Sub. To Condition of Allotment Letter
For ESTATE OFFICER
HSVP GURUGRAM

SANCTIONED
Valid For Five Years
Sub. To Condition of Allotment Letter
For ESTATE OFFICER
HSVP GURUGRAM

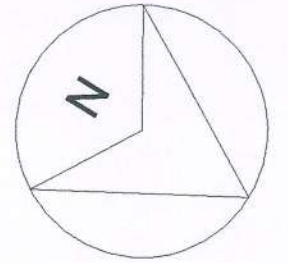

OWNER SIGN ARCHITECT SIGN

For ESSEL INFRA LLP
Designated Partner/Auth. Sign
A. VIKRAM GOYAL
CA/2017-18
Gurugram

Clients:
ESSEL INFRA LLP


Project Title :
COMMERCIAL COMPLEX SITE C1 IN SHOPPING CENTRE
SECTOR -43, GURUGRAM .

Drawing Title :
SUBMISSION DRAWINGS


BASEMENT 2 FLOOR PLAN

Scale :
Date : MAY-2023
Drawn By : S.G
Checked By : A.S
Sheet Size : A1


Drawing No :
CP_BA-02

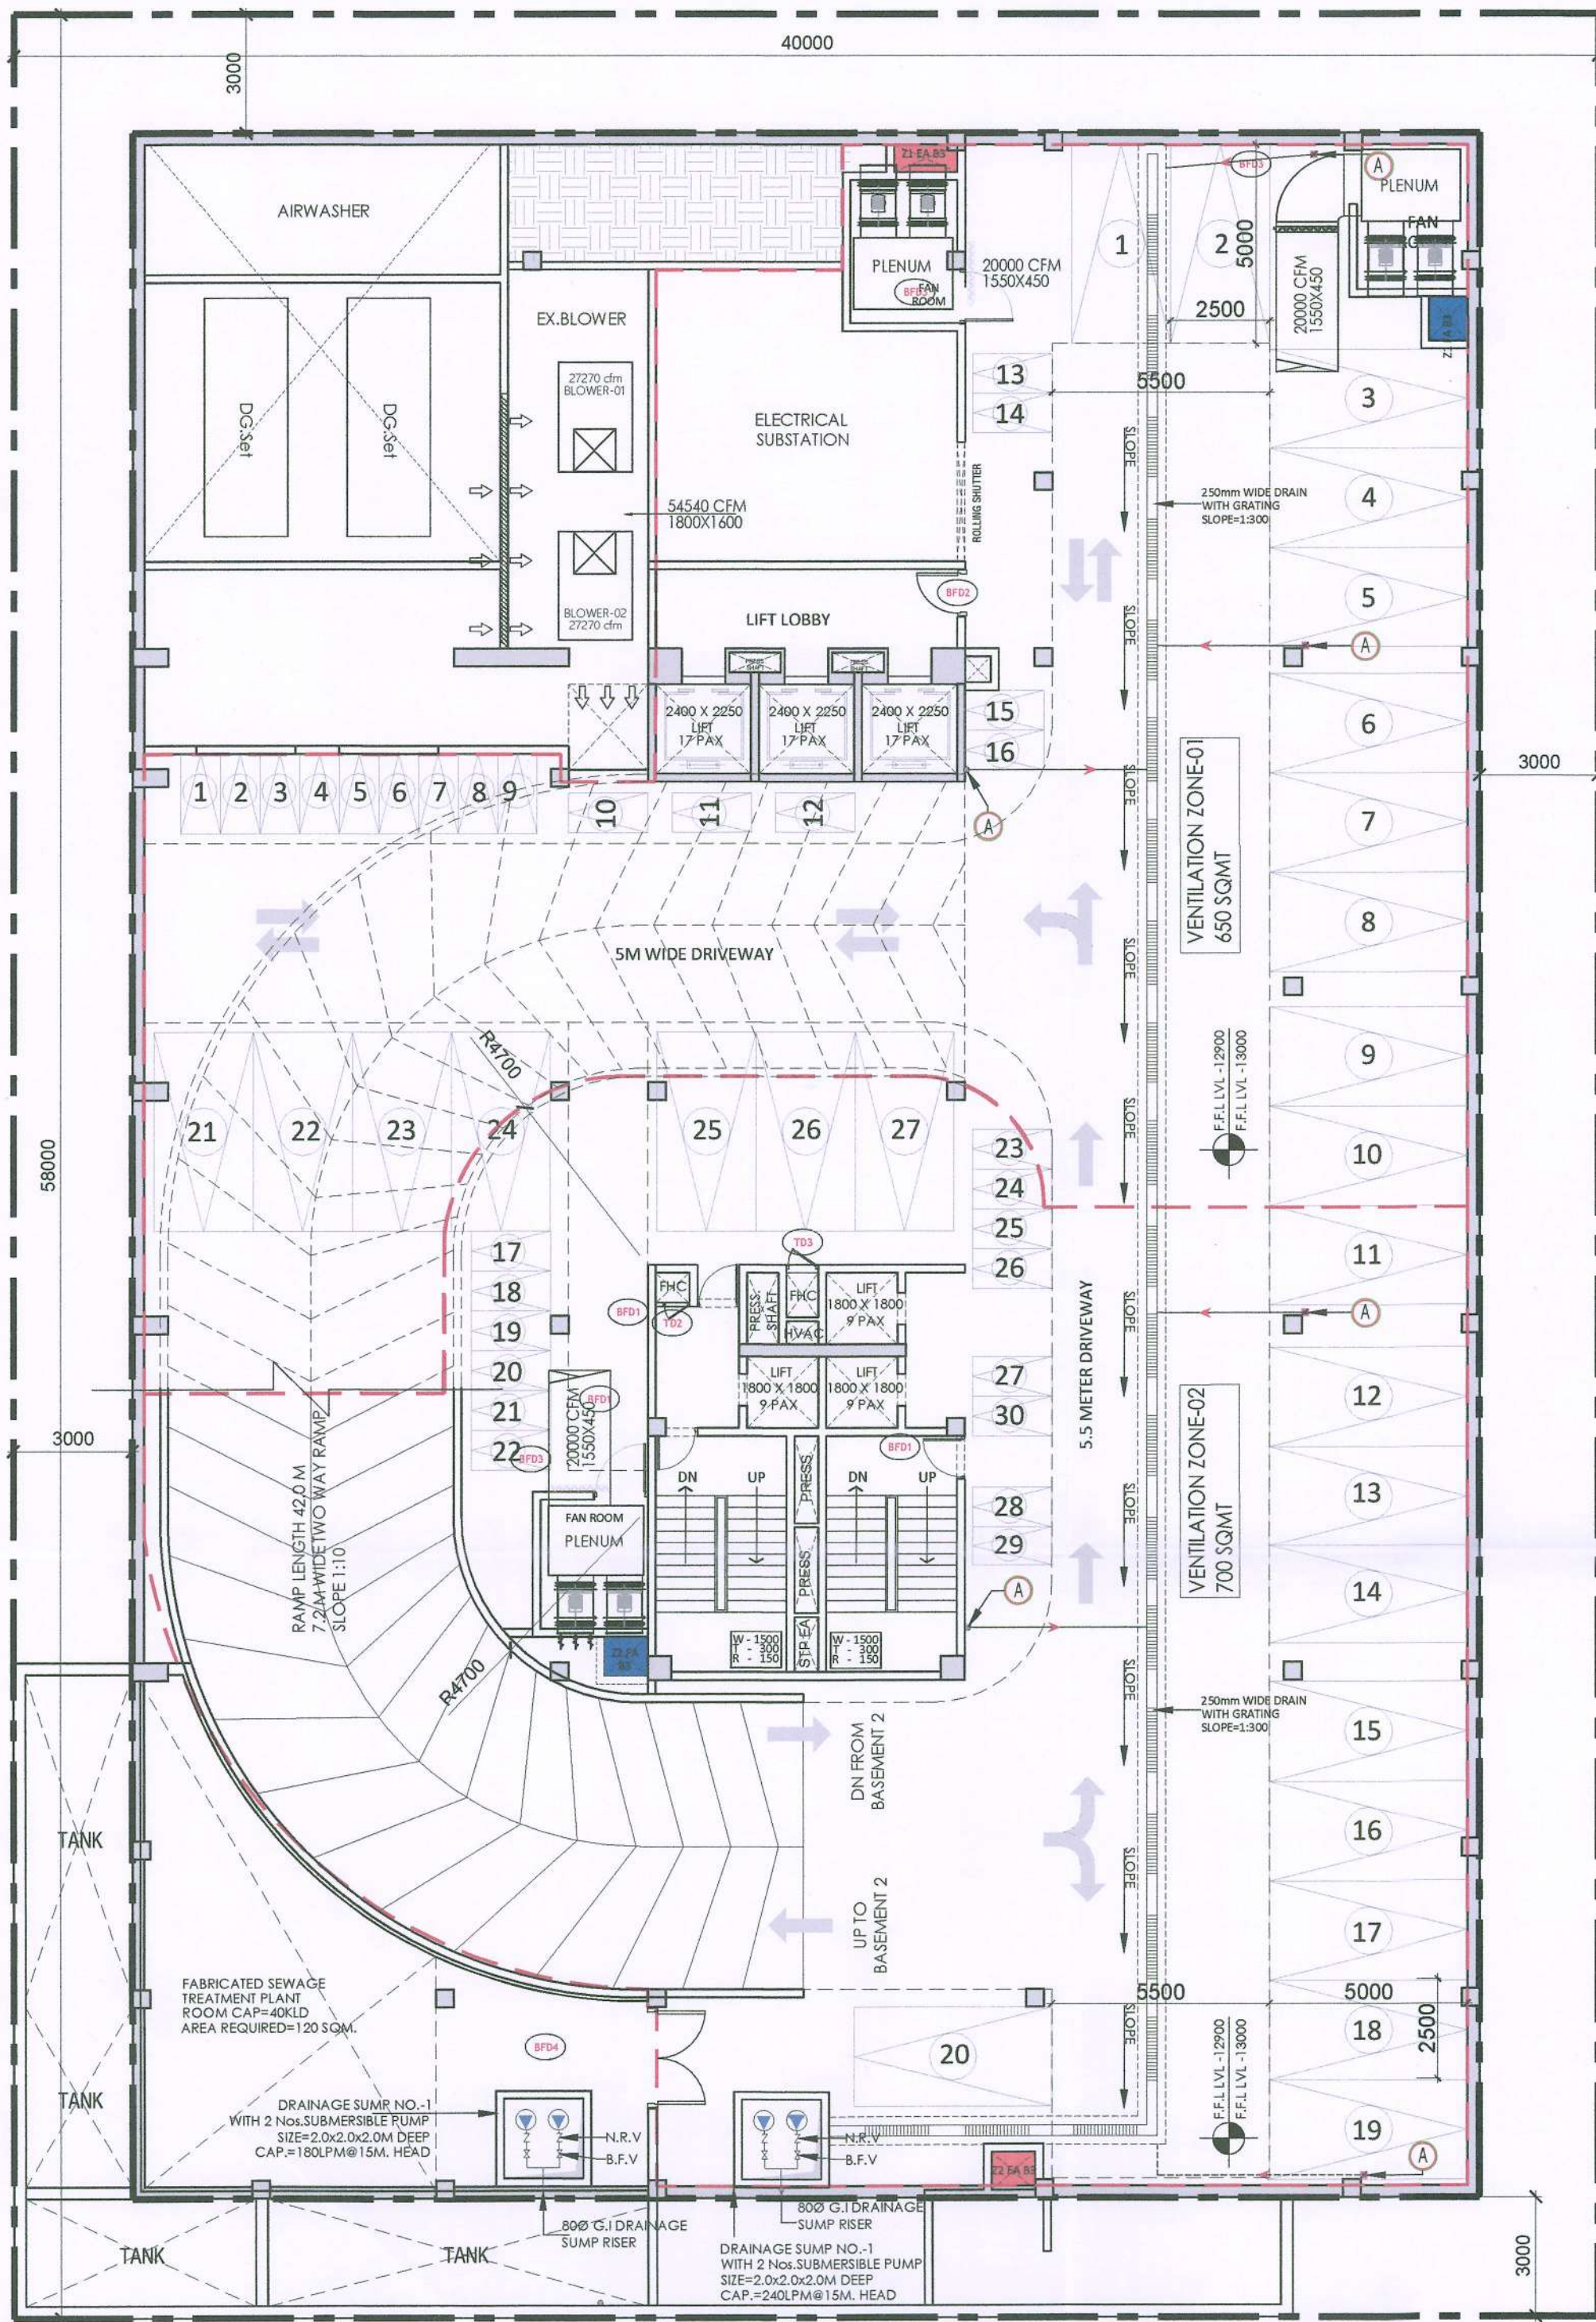

BASEMENT 3
SCALE 1: 150

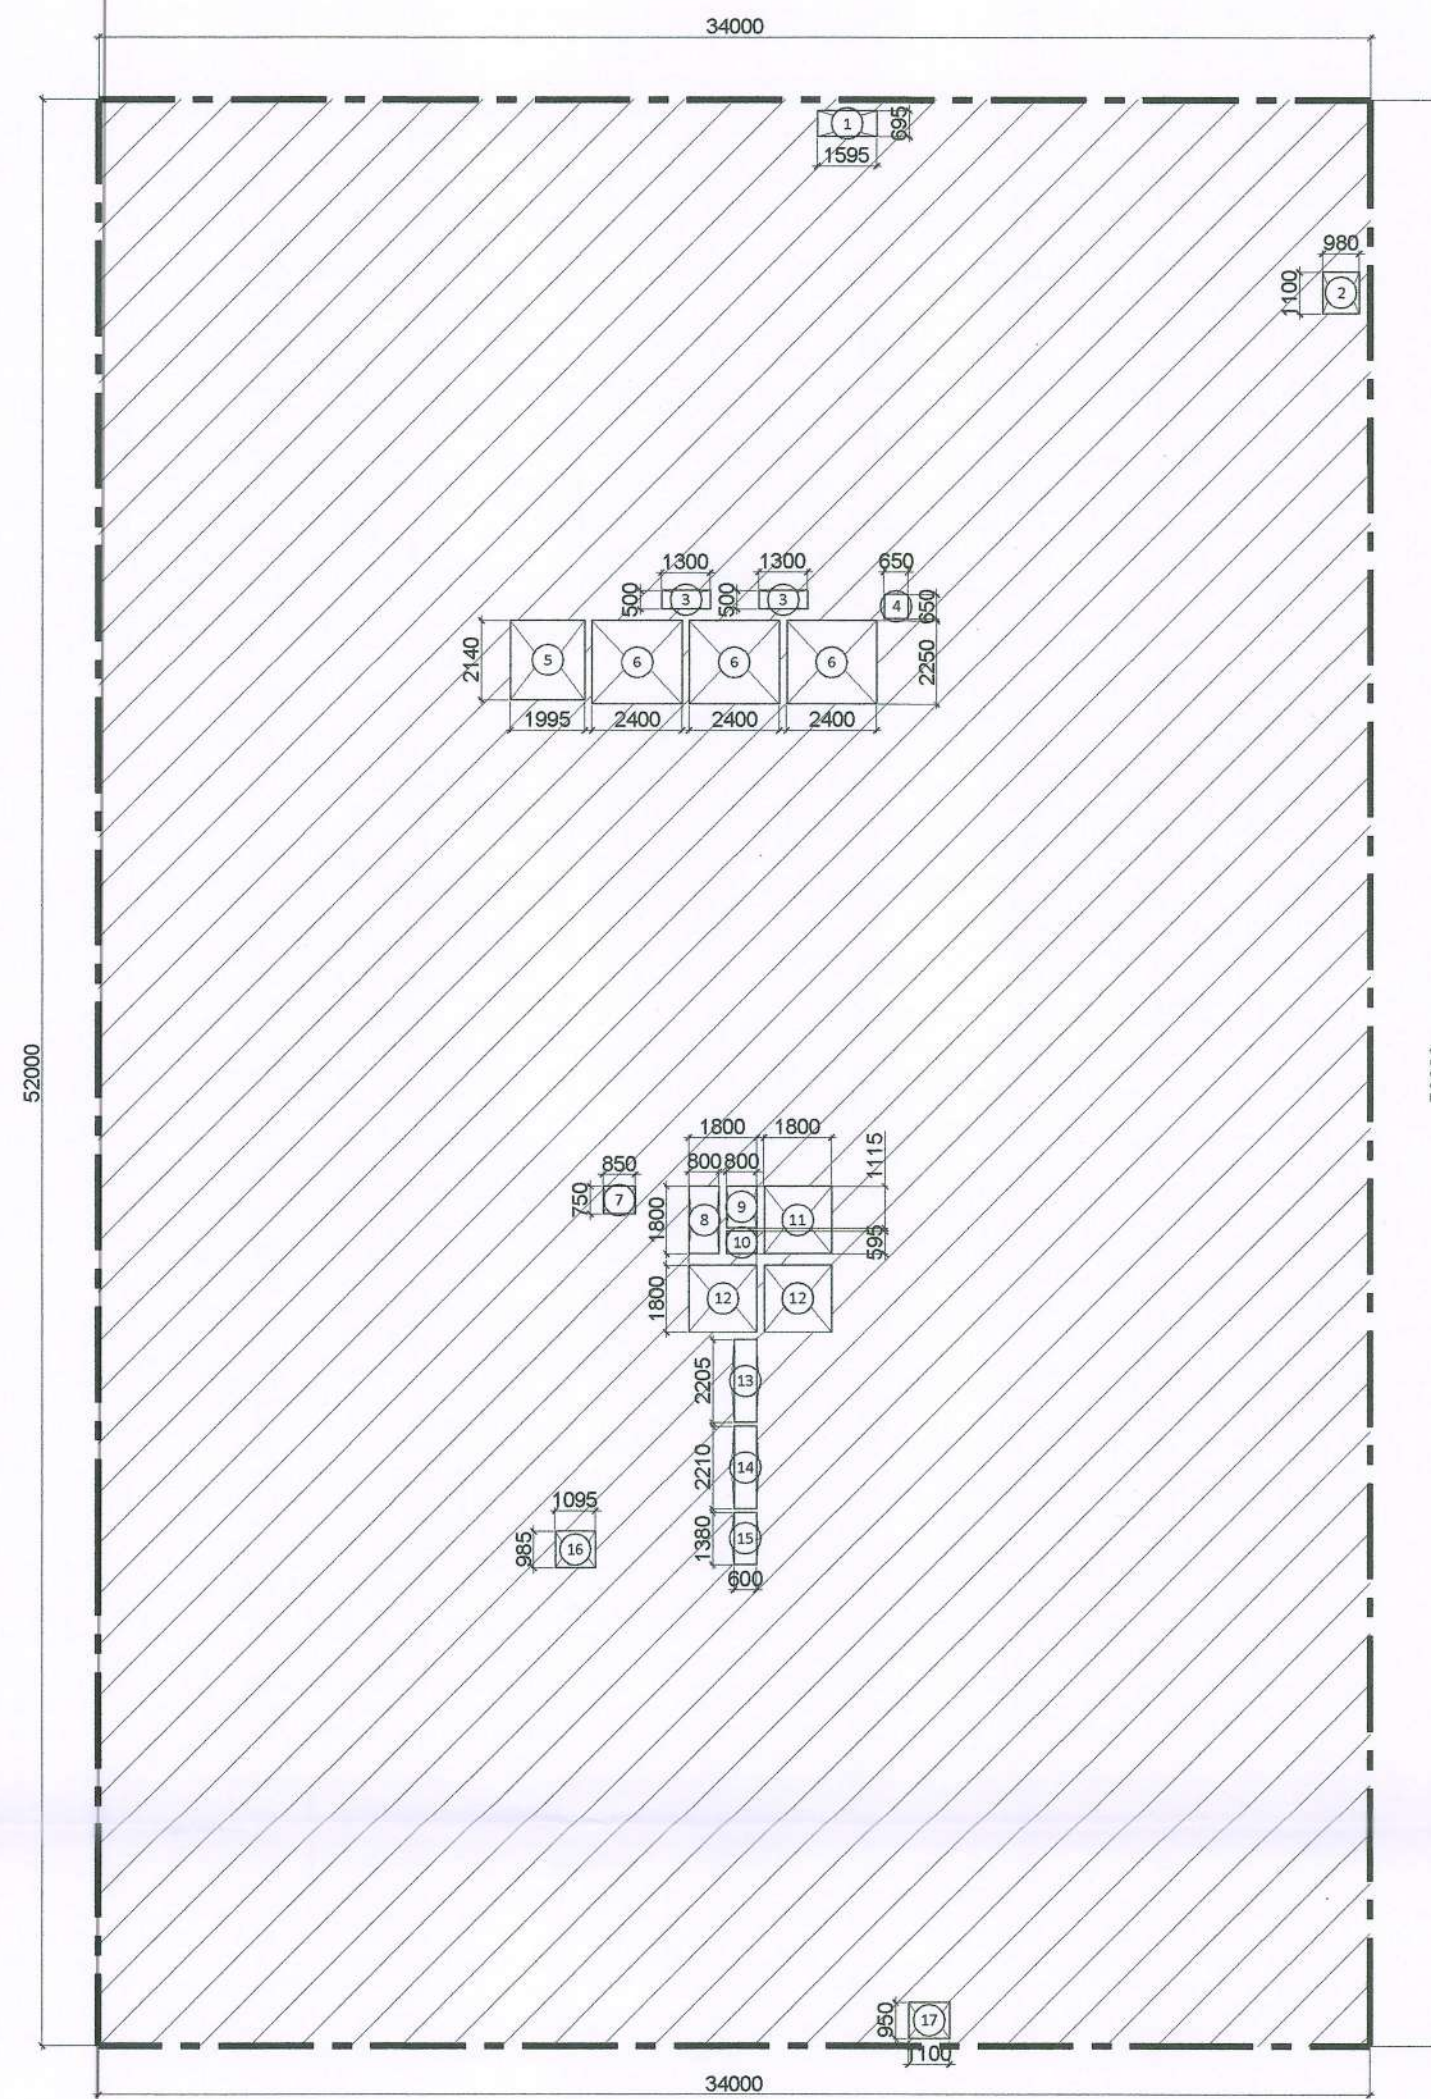

BUILTUP AREA DIAGRAM
SCALE 1:200

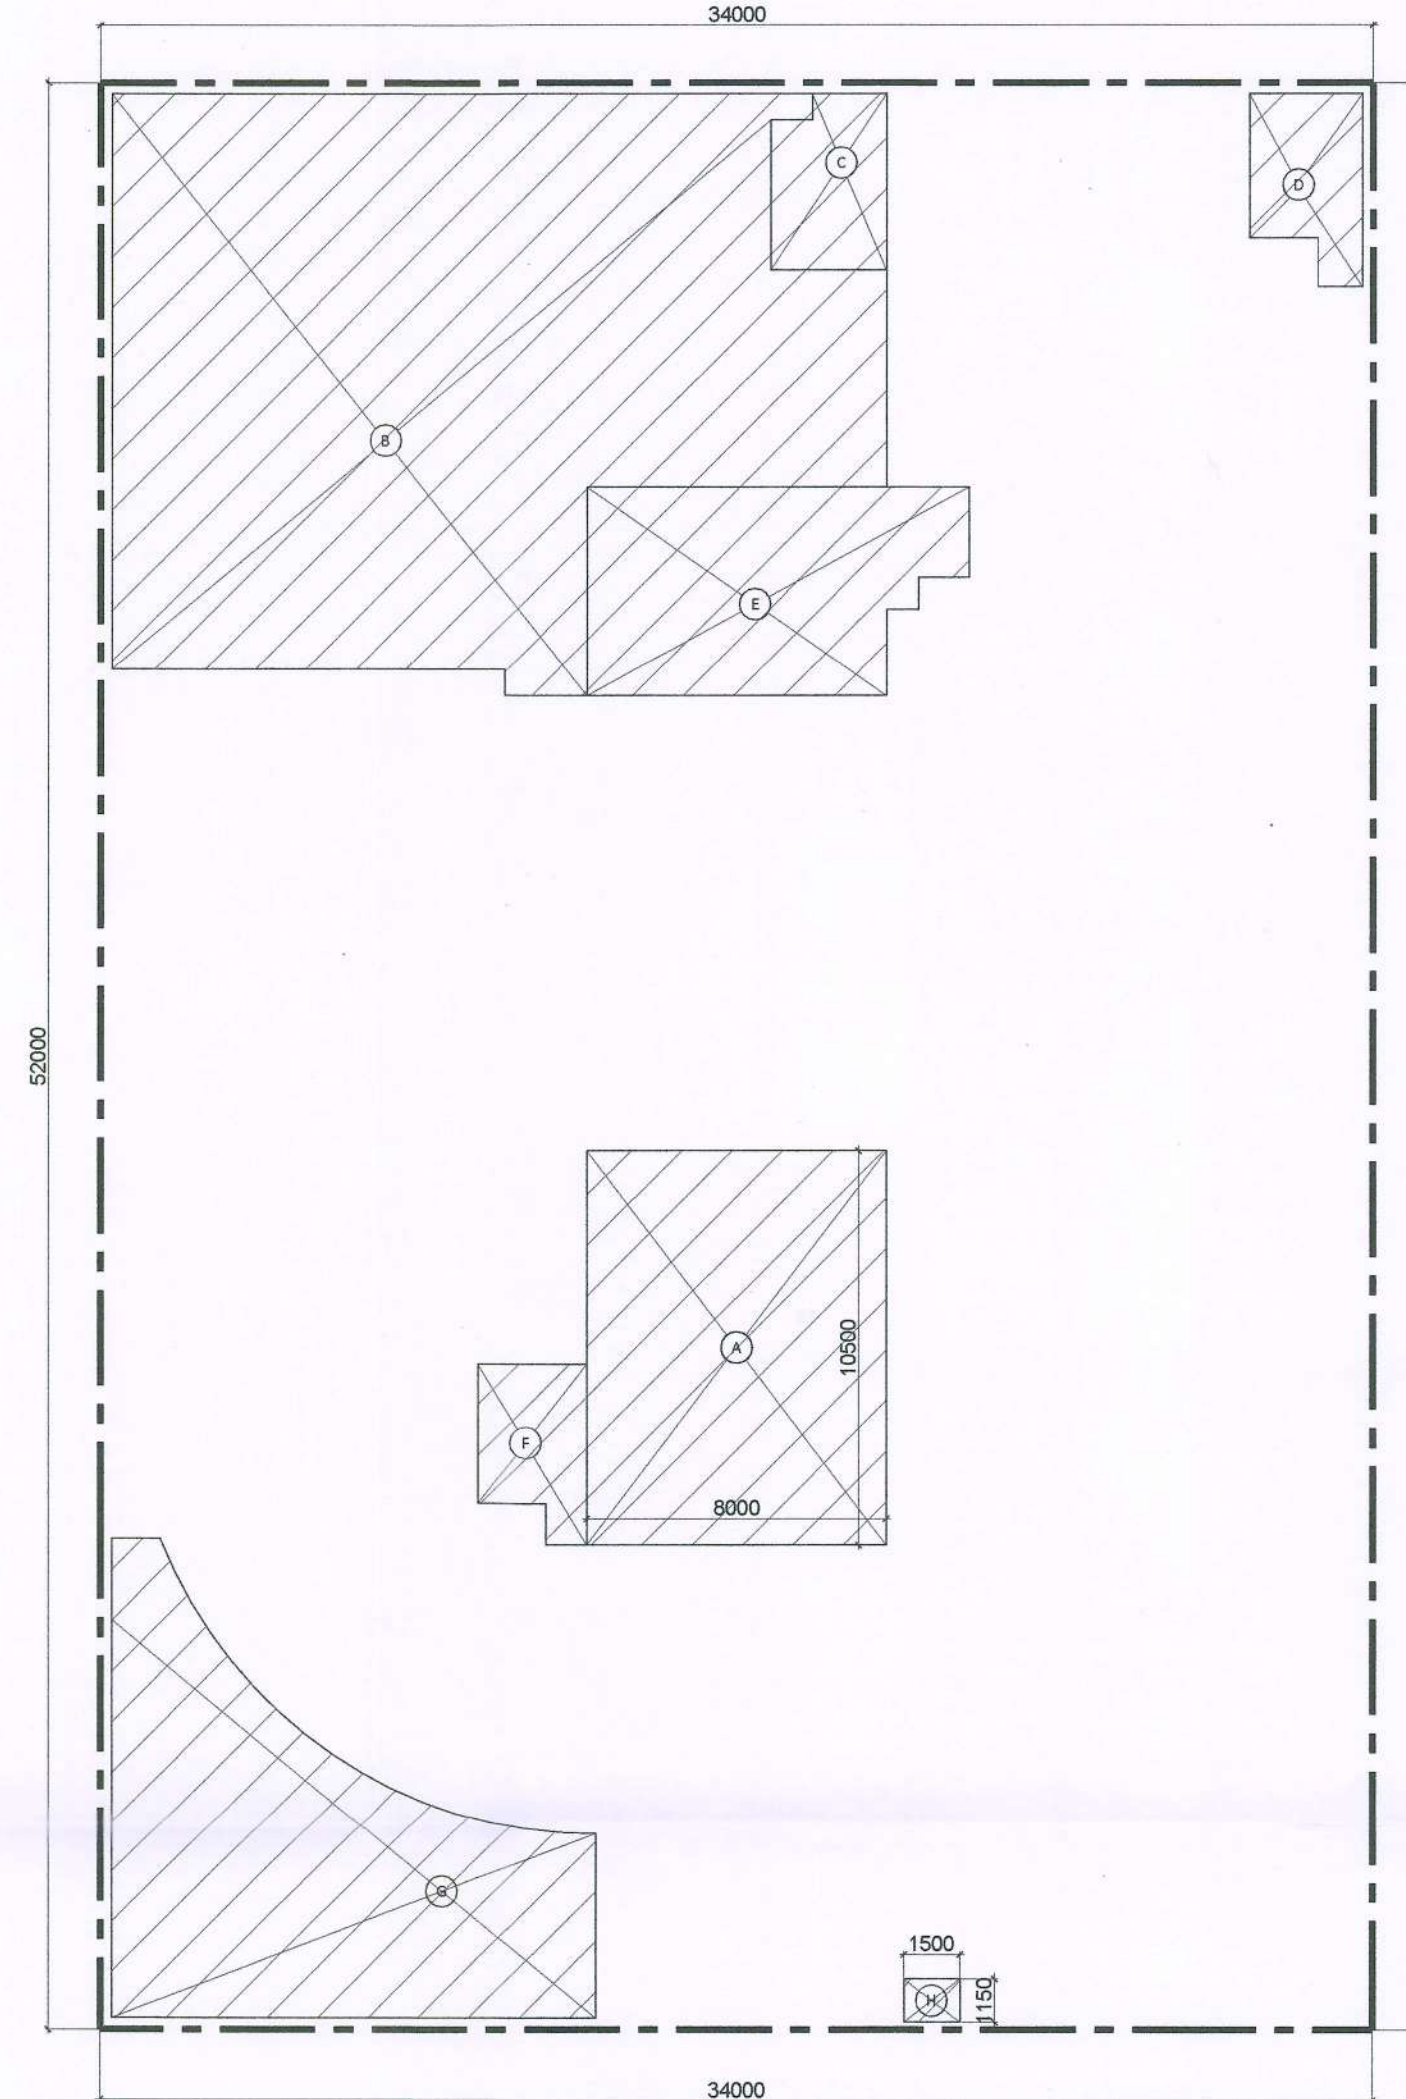

SERVICE AREA DIAGRAM
SCALE 1:200

PARKING					
A.	ON SURFACE	2 NOS. HANDICAP PARKING			
B.	IN BASEMENT	125 CARS			
BASEMENT PARKING CALCULATION					
BASEMENT LVL	BUILT UP	SERVICES	AREA FOR PARKING	ACTUAL NO. OF CARS	
				PARKING SLOTS	TOTAL NO.
BASEMENT 1	1703.19	588.19	1115.00	19 DOUBLE STACK	38
BASEMENT 2	1560.27	551.33	1008.94	19 DOUBLE STACK	38
BASEMENT 3	1725.65	541.31	1184.34	22 DOUBLE STACK	44
				5 SINGLE CARS	5
TOTAL	4989.11	1680.83	3308.28		125
TOTAL(A+B)					127

LEGEND	
	FRESH AIR CUTOFF
	EXHAUST CUTOFF
	VENTILATION ZONE


LEGEND FOR FIRE EQUIPMENTS	
F1	COMMON DIESEL ENGINE PUMP
F2	ELECTRICAL HYDRANT PUMP
F3	ELECTRICAL HYDRANT JOCKEY PUMP
F4	ELECTRICAL SPRINKLER PUMP
F5	ELECTRICAL SPRINKLER JOCKEY PUMP

LEGEND FOR FIRE EQUIPMENTS	
P1	DUAL MEDIA FILTER FEED / S.T.P MAKE-UP PUMPS
P2	DOMESTIC WATER TRANSFER PUMPS
DMF	DUAL MEDIA FILTER
ACF	ACTIVATED CARBON FILTER
BT	BRINE TANK

PLUMBING LEGEND	
Ø	1000 G.I DRAIN PIPE
G.L	GROUND LEVEL
F.F.L	FINISHED FLOOR LEVEL
T.O.S	TOP OF SLAB
T.O.W	TOP OF WATER
T.O.C	TOP OF CUTOFF
D.P	DRAIN POINT

Authority Signatory
SANCTIONED
Valid For Five Years
Sub. To Condition of Allotment Letter
For ESTATE OFFICER
HSVP GURUGRAM

SANCTIONED
Valid For Five Years
Sub. To Condition of Allotment Letter
For ESTATE OFFICER
HSVP GURUGRAM

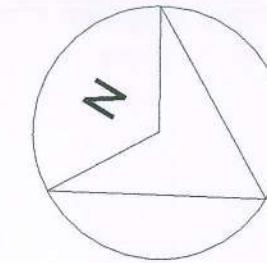

OWNER SIGN
ARCHITECT SIGN
For ESSEL INFRA LLP
Designated Partner/ Auth. Sign.
A. VIREMRA GOYAL
CA/2019/114662
H.No. 7507, Patel Nagar, Gurugram

Clients:
ESSEL INFRA LLP
Project Title :
COMMERCIAL COMPLEX SITE C1 IN SHOPPING CENTRE
SECTOR -43, GURUGRAM .

Drawing Title :
SUBMISSION DRAWINGS
BASEMENT 3 FLOOR PLAN

Scale :
Date : MAY-2023
Drawn By : S.G
Checked By : A.S
Sheet Size : A1
Drawing No :
CP_BA-03