

DOOR/WINDOW SCHEDULE				
S. NO.	TYPE	WIDTH (MM)	HEIGHT (MM)	UNITS
1	D1	1800	450	2700
2	D2	1500	450	2700
3	D3	1200	450	2700
4	D4	900	450	2700
5	D5	750	450	2700
6	DW1	2400	450	2700
7	DW2	3400	450	2700
8	DW3	1200	450	2700
9	DW4	3005	450	2700
10	DW5	1500	450	2700
11	FD	800	450	2700
12	GD1	1800	450	2700
13	G1	800	450	2700
14	VW1	2000	400	2700
15	V2	2400	400	2700
16	V3	1350	400	2700
17	V4	1500	400	2700
18	V5	900	400	2700
19	V2	800	1500	2700
20	V3	800	1500	2700
21	V4	1700	1500	2700
22	V5	3555	1500	2700

NOTE: UNITS ARE IN MM / SERVICE

* D3 & FD - 2 HR FIRE RATED

OP - CREMABLE PANEL @ 10 MM

PLUMBING LEGEND


- 100 MM Ø SOIL & VENT PIPE
- 100 MM Ø WASTE & VENT PIPE
- 75 MM Ø ANTISIPHONAGE PIPE
- 100 MM Ø RAIN WATER PIPE
- DOMESTIC WATER SUPPLY RISER
- FLUSHING WATER SUPPLY RISER
- DOMESTIC WATER DWTAKE
- FLUSHING WATER DWTAKE

NOTE: ALL INTERNAL / EXTERNAL WALL OF RC WITH 150 MM THICKNESS


3 BHK RESIDENTIAL				
7th FLOOR RESIDENTIAL - (A1')				
NAME	WIDTH (MM)	HEIGHT (MM)	FORMULA	NO. S
1	3450	7550	LXB	1
2	3600	13000	LXB	1
3	3905	11800	LXB	1
4	3405	500	LXB	1
4a	AS/SIZE (R-500)	500	$\pi r^2/4$	1
5	6555	7680	LXB	1
6	2555	705	LXB	1
7	2560	1900	LXB	1
8	4135	15690	LXB	1
TOTAL AREA (A1')				243.696

7th FLOOR LESS AREA - (L1) DETAIL (SHAFTS & STAIRCASE)				
NAME	WIDTH (MM)	HEIGHT (MM)	FORMULA	NO. S
C1	1450	750	LXB	1
C2	955	1100	LXB	1
C3	2005	2200	LXB	2
C4	1800	650	LXB	1
C6	3955	5100	LXB	1
C6a	3955	3550	LXB	1
C7	1955	3800	LXB	1
C8	595	3800	LXB	1
C9	2435	1990	LXB	1
C10	3405	420	LXB	1
C11	AS/SIZE (R-420)	420	$\pi r^2/4$	1
C12	2650	520	LXB	1
C13	1175	120	LXB	1
TOTAL AREA - (L1')				62.928
TOTAL AREA - (A1' - L1') = F1'				180.768


7th FLOOR BALCONY AREA DETAIL - (B1')				
NAME	WIDTH (MM)	HEIGHT (MM)	FORMULA	NO. S
S1	6100	1800	LXB	1
S2	AS/SIZE	1800	LXB	1
S3	1230	1750	LXB	1
S4	AS/SIZE	1800	LXB	1
S5	4000	1800	LXB	1
S6	2555	1800	LXB	1
S8	8530	1800	LXB	1
S9	1525	1200	LXB	1
S10	AS/SIZE	1800	LXB	1
S11	3995	1800	LXB	1
TOTAL AREA (B1')				53.160
TOTAL BALCONY AREA OF 7th FLOOR				53.160

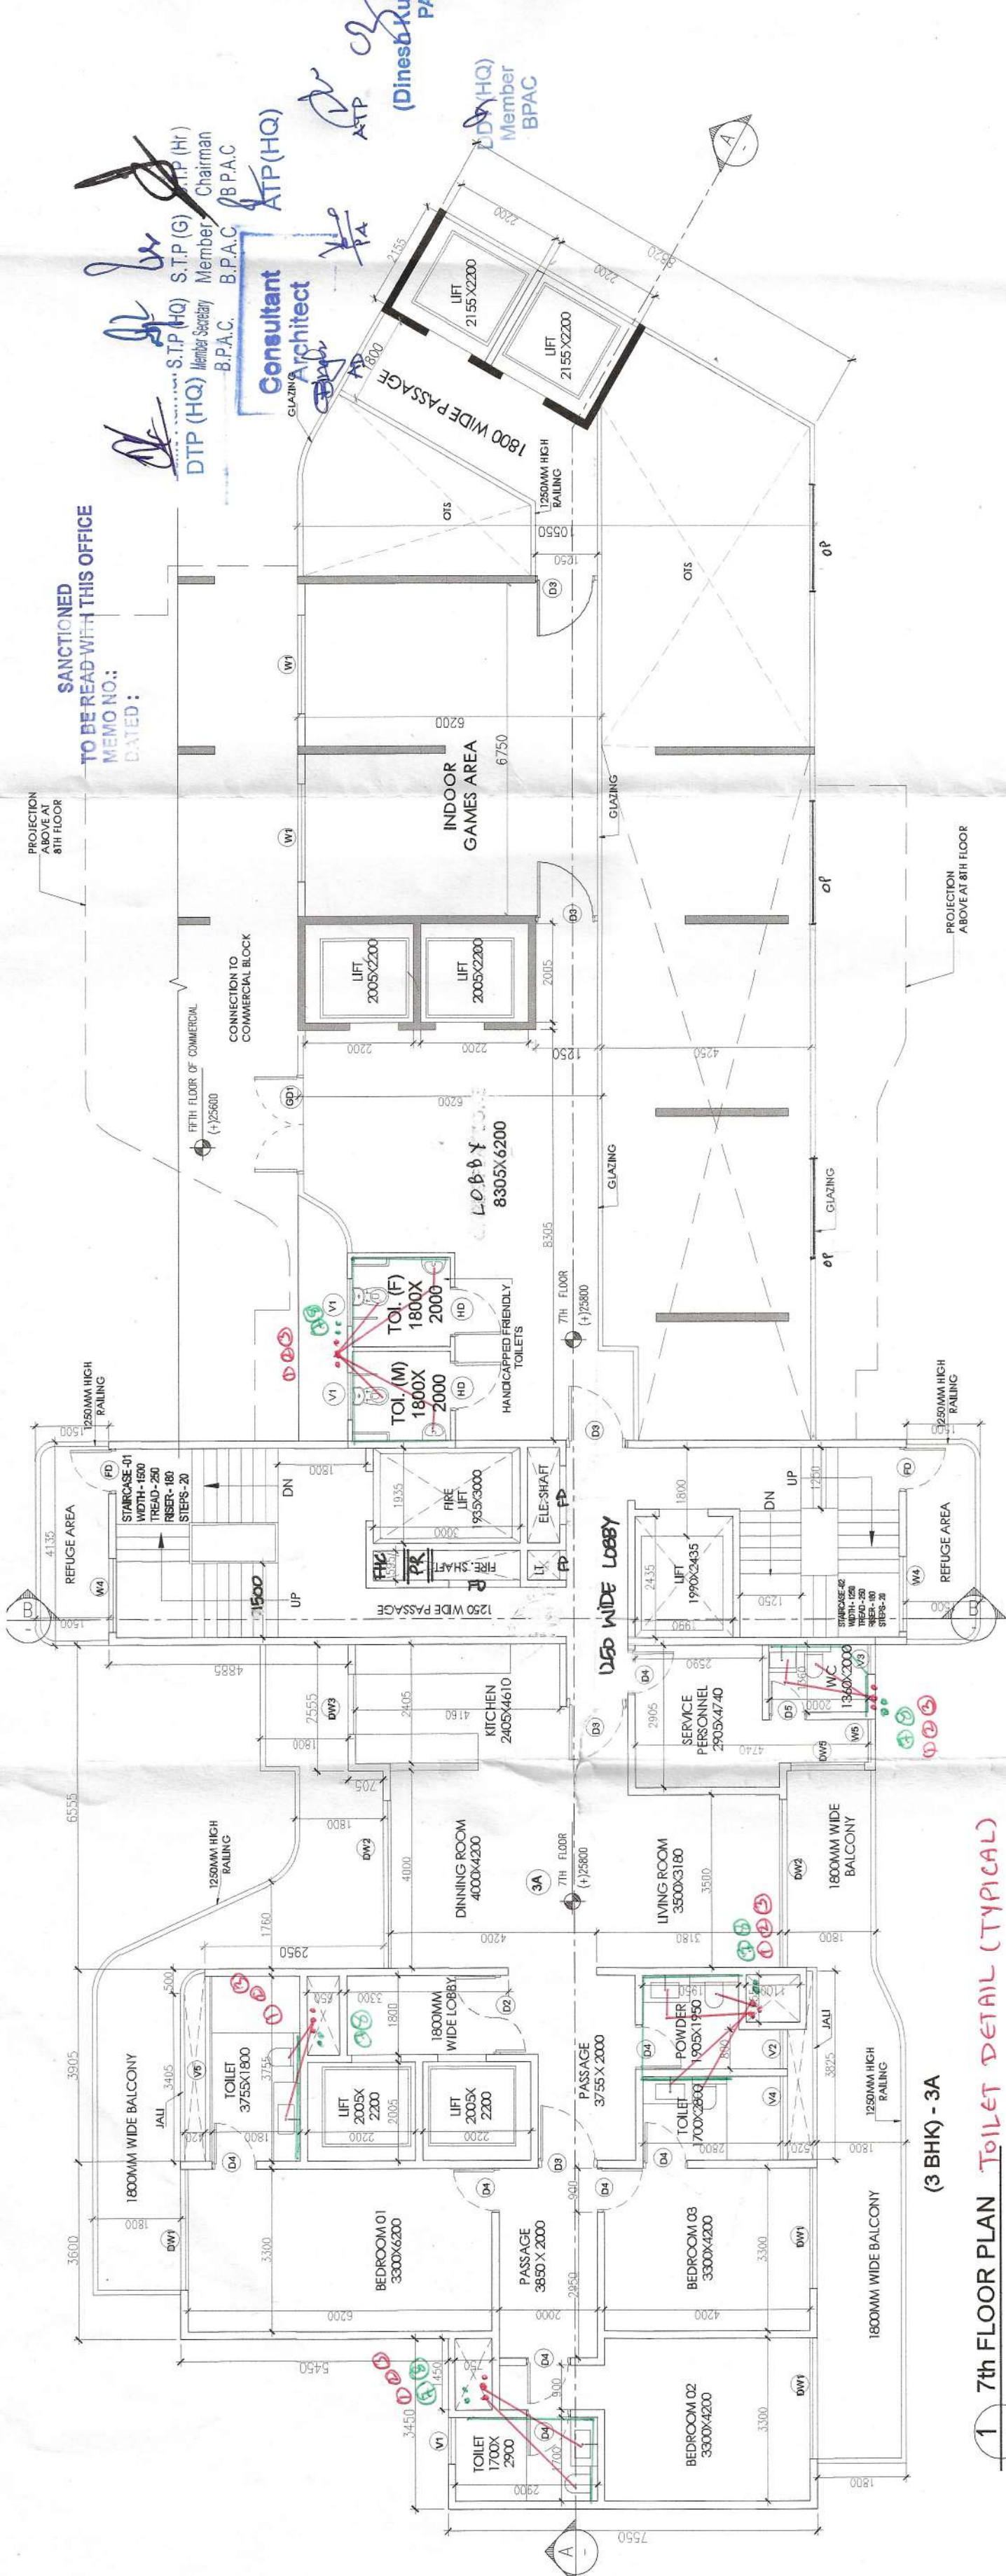

7th FLOOR PLAN (TYPICAL) RESIDENCE - CLUB

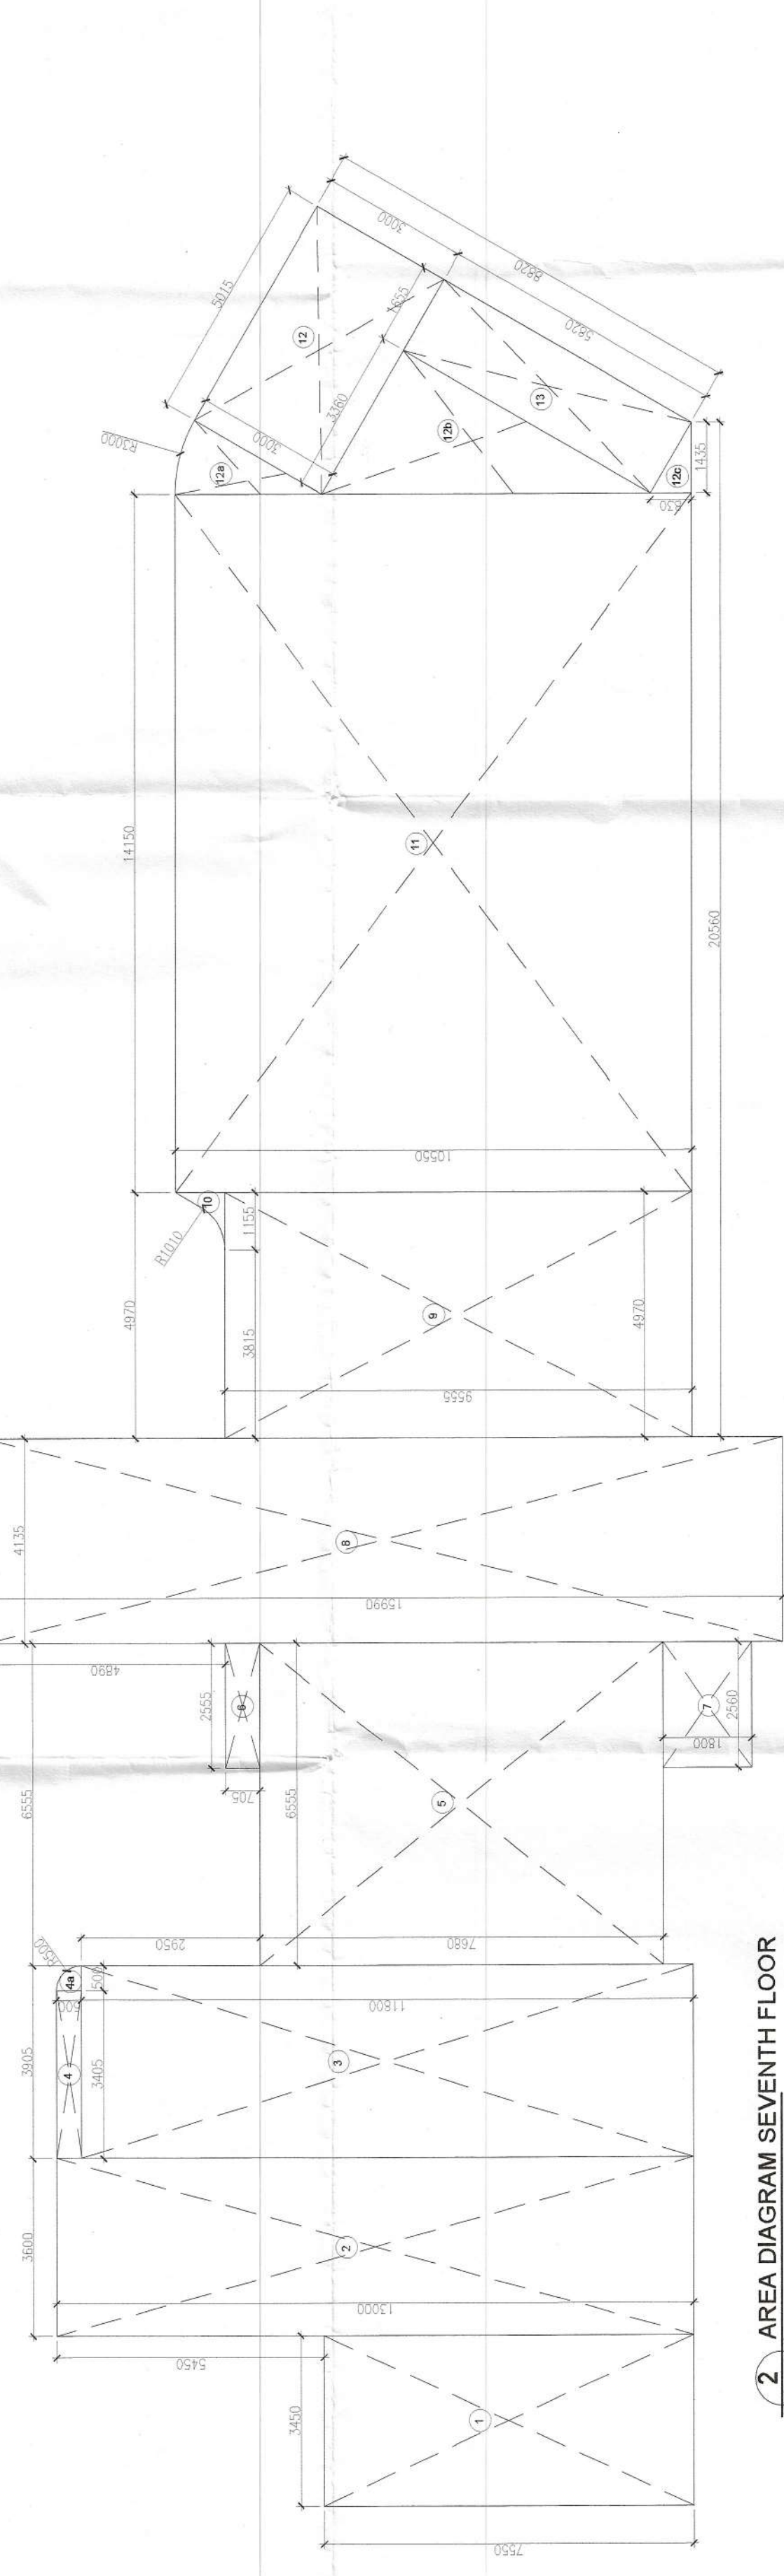

2 AREA DIAGRAM SEVENTH FLOOR

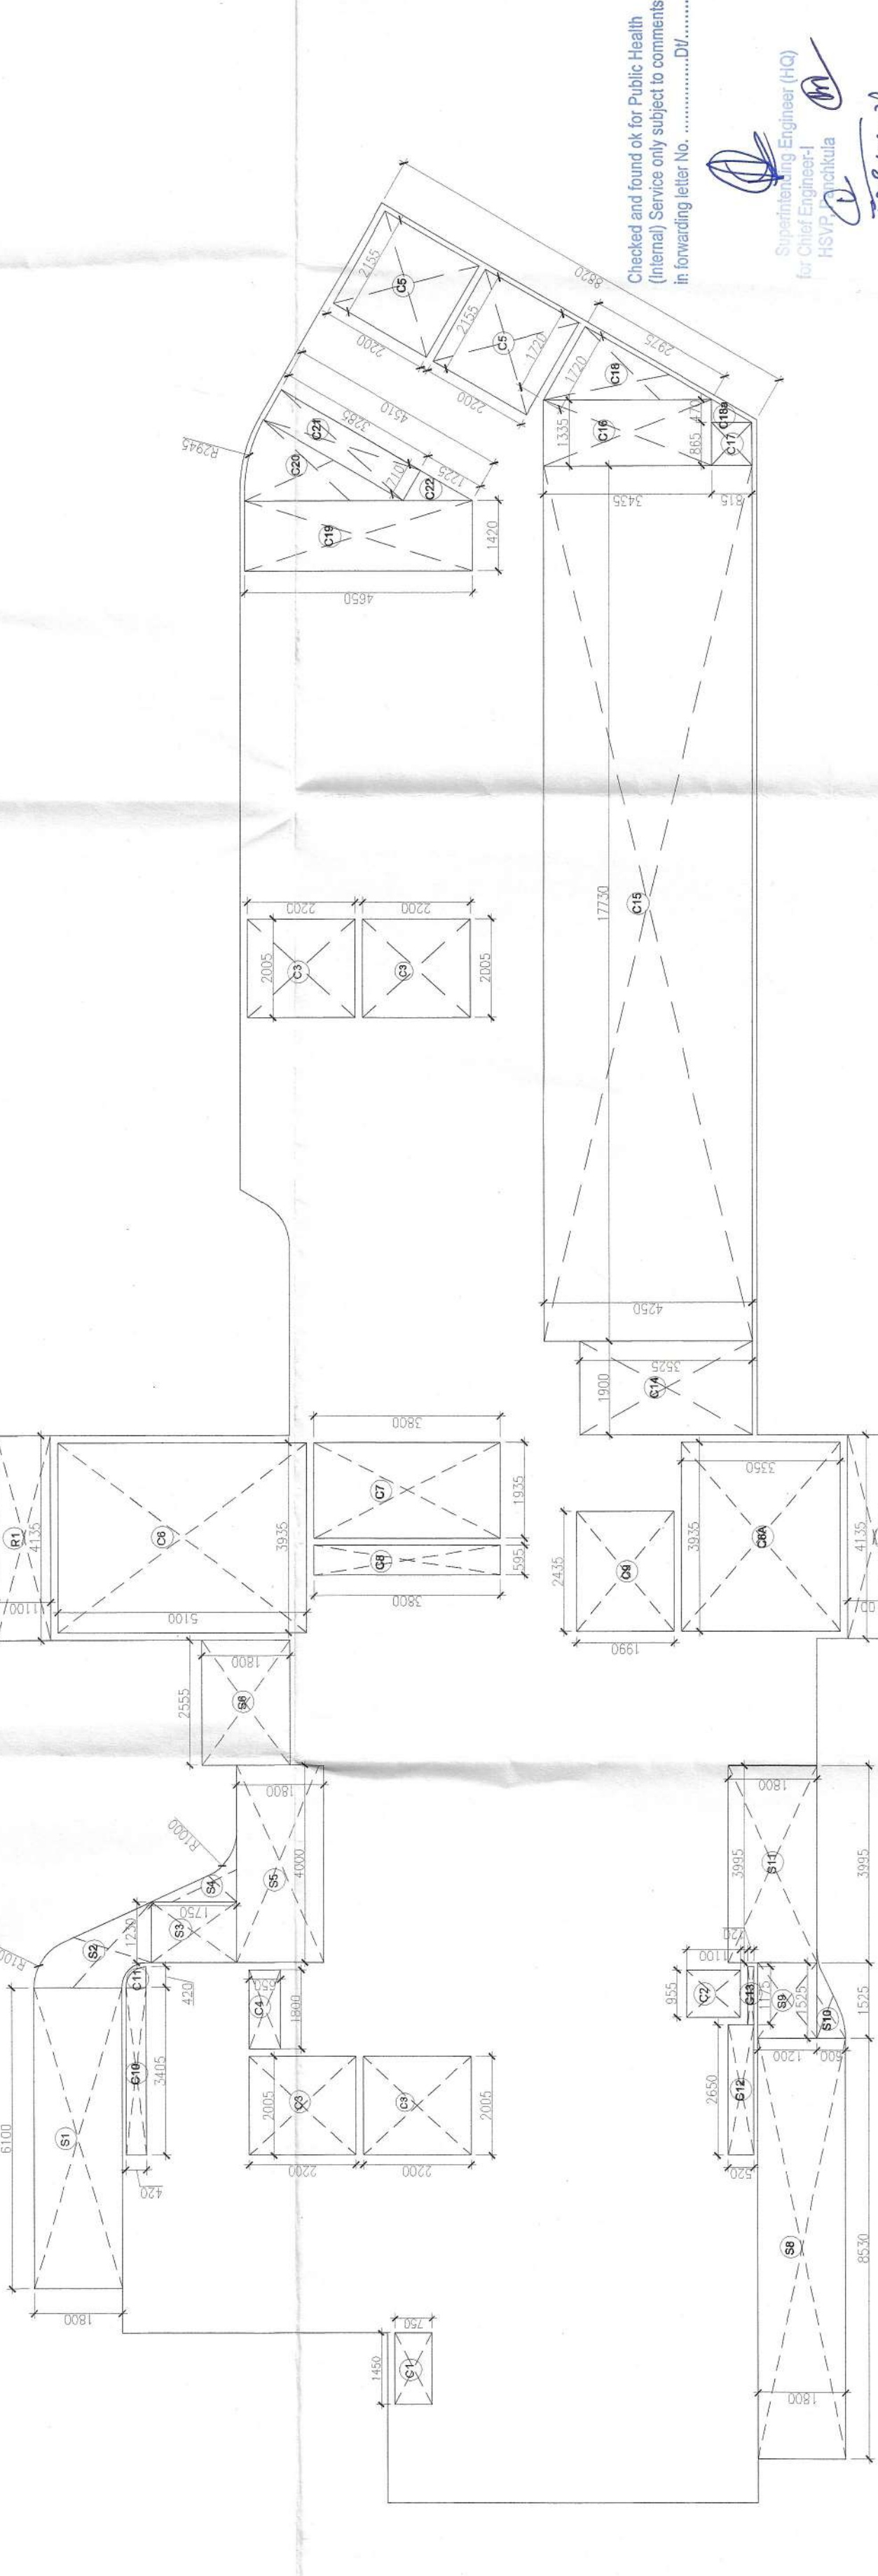

3 LESS AREA DETAIL SEVENTH FLOOR

PROPOSED BUILDING PLANS FOR MIXED LAND USE COLONY (70% RESIDENTIAL COMPONENT & 30% COMMERCIAL COMPONENT) UNDER TRANSIT ORIENTED DEVELOPMENT POLICY (TOD) FOR THE AREA MEASURING 8.34375 ACRES (LICENSE NO. 127 OF 2023 DATED 16/06/2023) IN SECTOR-84, GURUGRAM MANASAR URBAN COMPLEX BEING DEVELOPED BY GANGA GLOBAL HOMES PVT. LTD.

IC - 4946/IE(SB)/2023/19420

OWNERS SIGNATURE

ARCHITECT'S SIGNATURE

ARCHITECT

DRAWING TITLE

TOWER-1 (TOWER 4 IS MIRROR OF TOWER-1) SEVENTH FLOOR

ARCHITECT

GANGA REALTY - DESIGN TEAM

GANGA REALTY

Villu Town, Golf Course Road

Gurgaon, Haryana

DATE

SEPT. 2023

SCALE

NTS

DEALT

AG

CHECKED

DA

S-203