




NOTE :- ALL INTERIOR EXTERIOR WALL WITH 150 MM THICKNESS

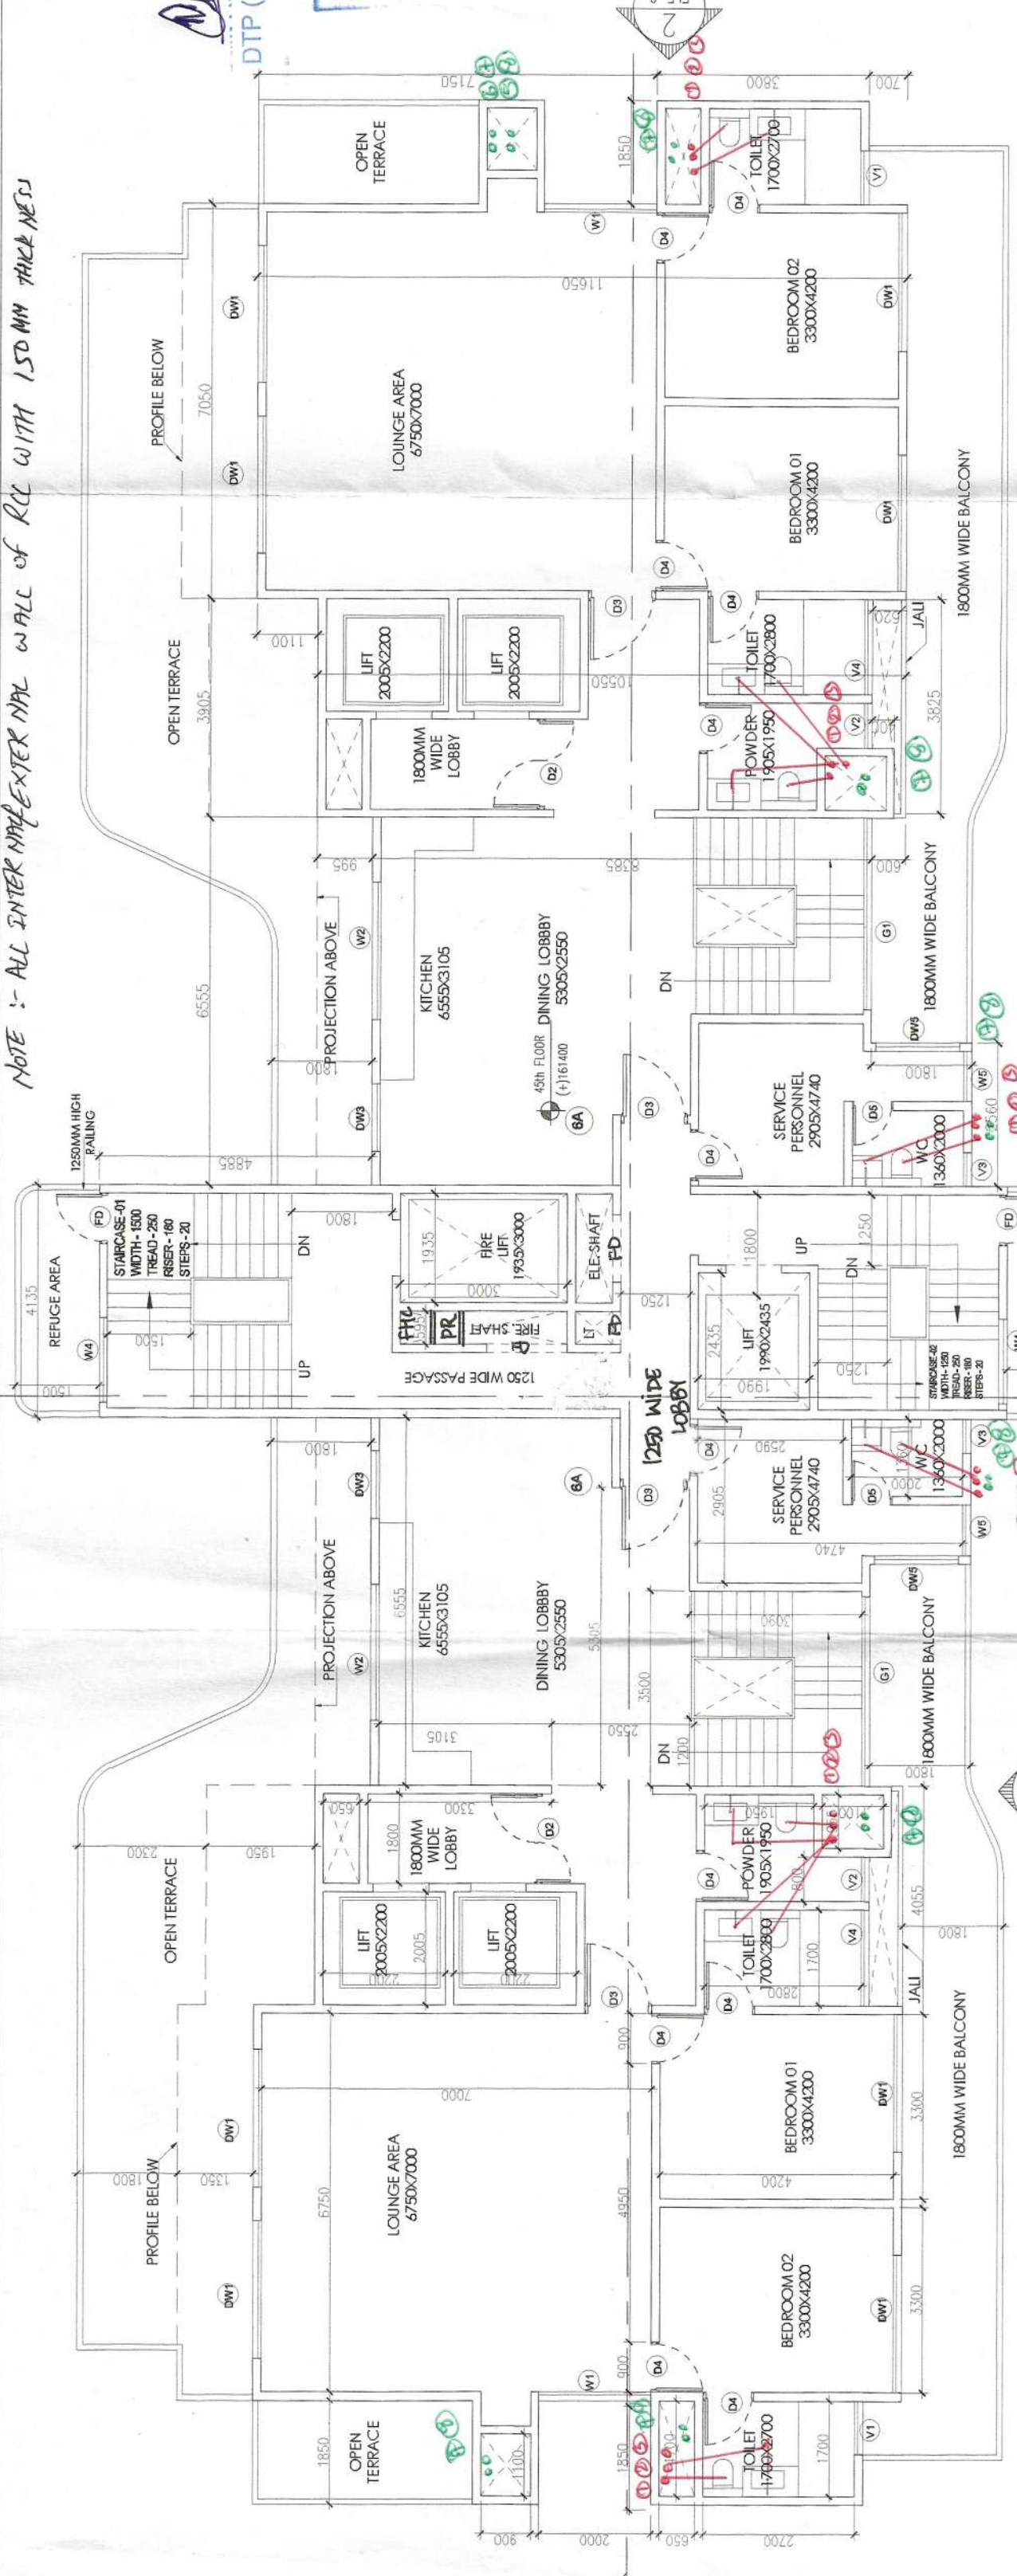

1. 45th FLOOR PLAN (TYPICAL) TOILET DETAIL (TYPICAL)

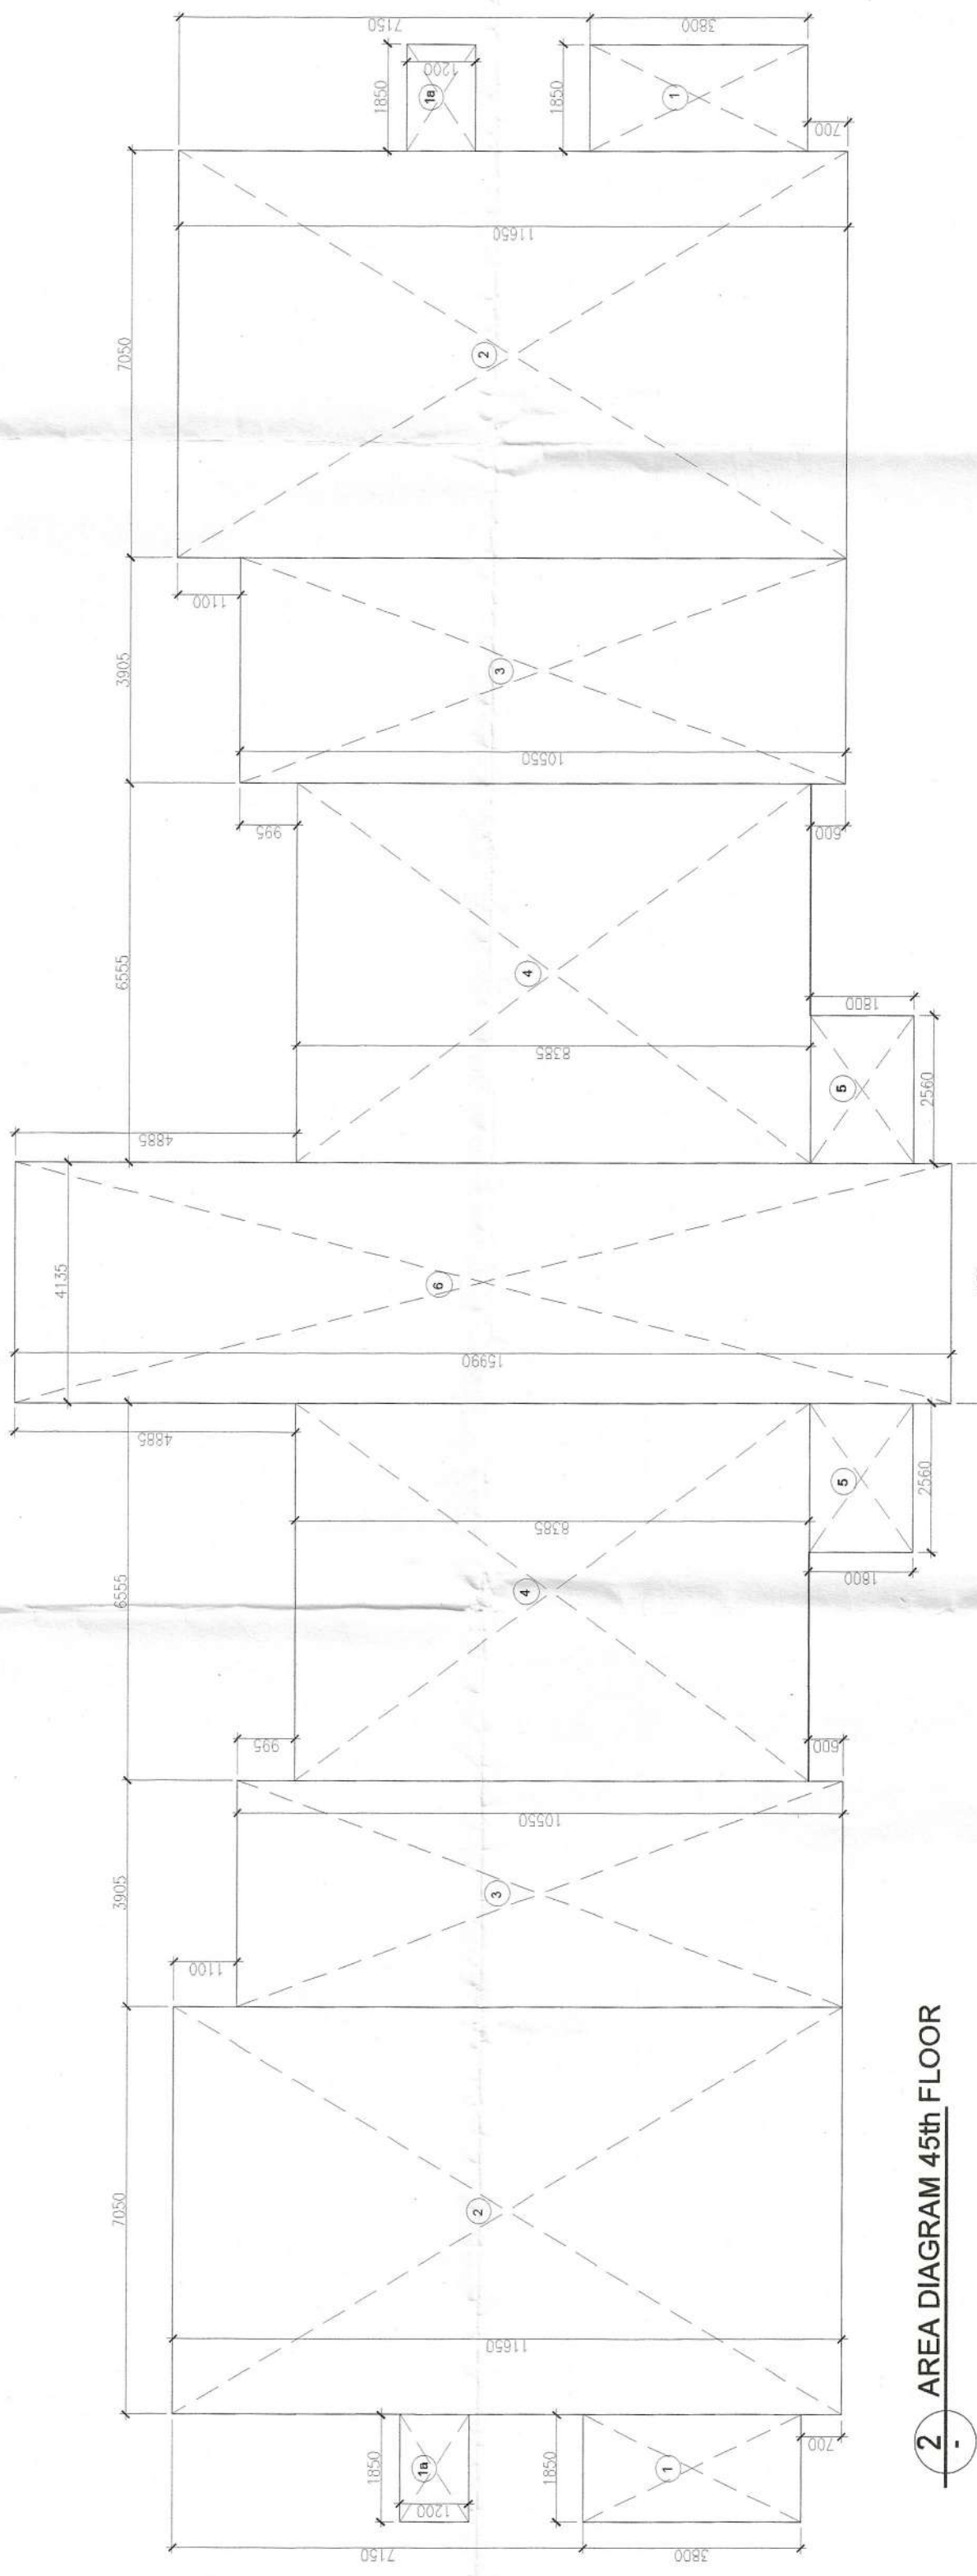

2. AREA DIAGRAM 45th FLOOR

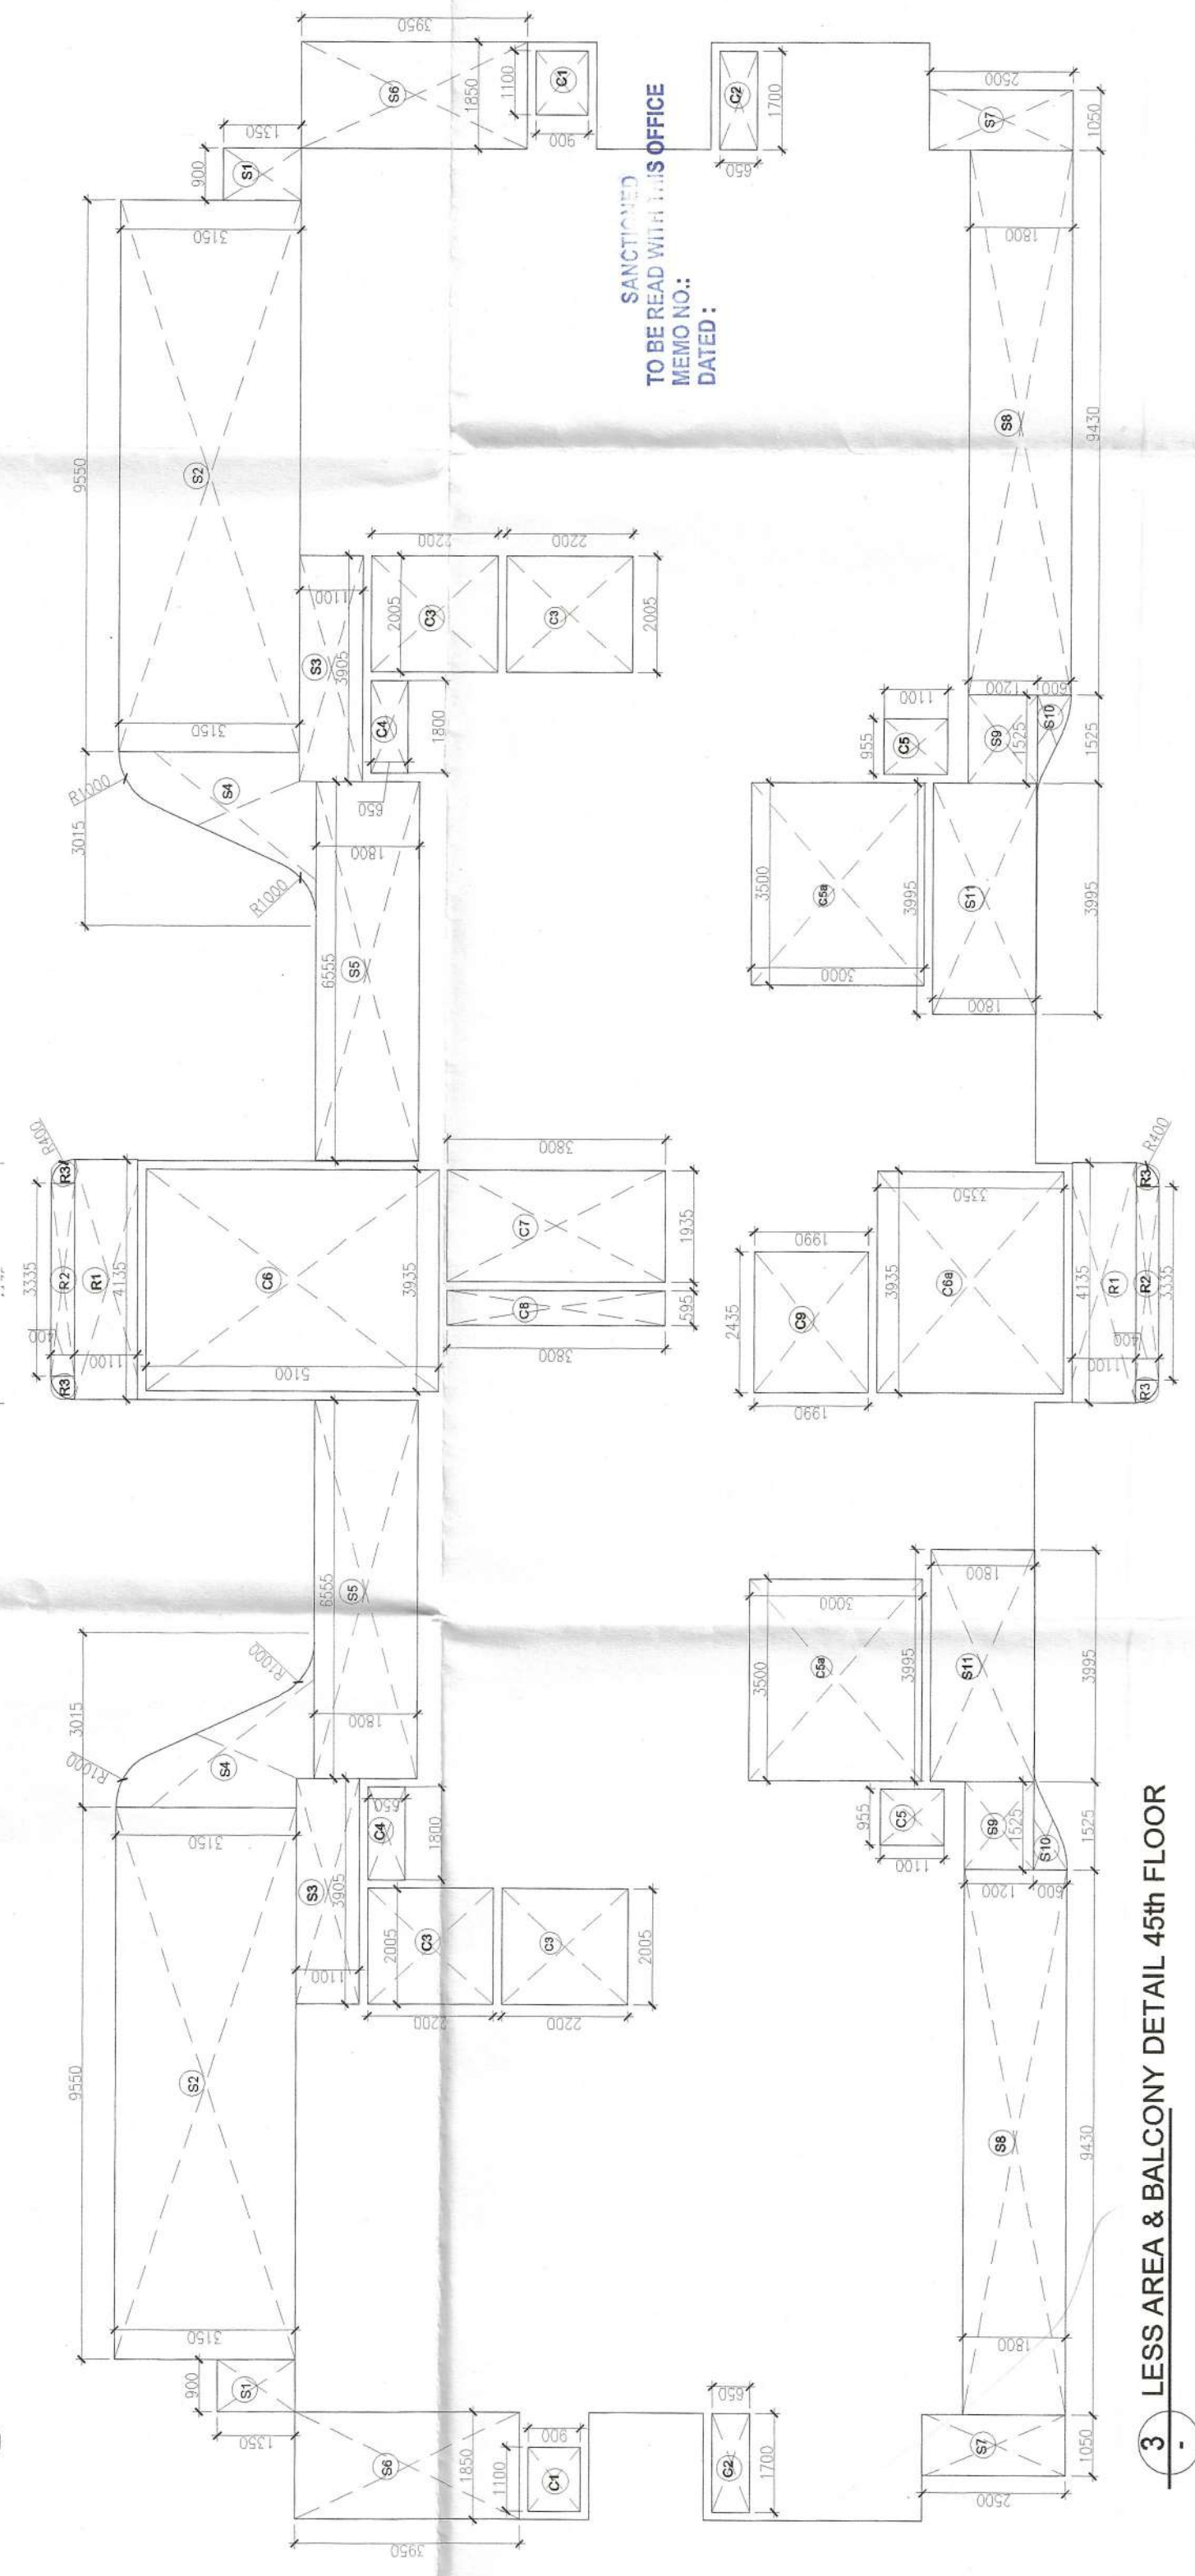


3. LESS AREA & BALCONY DETAIL 45th FLOOR

NAME	WIDTH (MM)	HEIGHT (MM)	FORMULA	NO.s	AREA (SQ M)
1	2410	1800	LXB	1	4338
2	2410	1500	LXB	1	3615
3	2410	1500	LXB	1	3615
4	750	1500	LXB	1	1125
TOTAL AREA					12723

Checked and found ok for Public Health (Internal) Services only subject to comments in forwarding letter No.

Signature of Engineer (H.O.)
for Chief Engineer
HSPV
30.06.2023

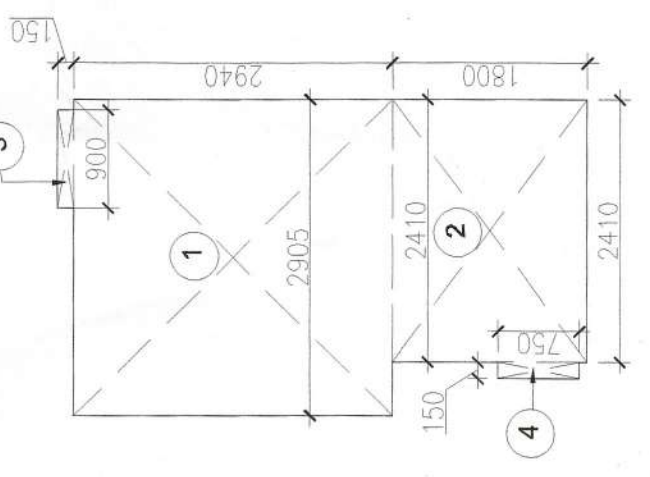

4. SERVICE PERSONNEL AREA

- PLUMBING LEGEND
- 100 MM Ø SOIL VENT PIPE
 - 100 MM Ø WASTE & VENT PIPE
 - 75 MM Ø ANTISIPHONAGE PIPE
 - RAIN WATER PIPE DM TAKE
 - DOMESTIC WATER SUPPLY RISER
 - FLUSHING WATER SUPPLY RISER
 - DOMESTIC WATER SUPPLY DNTAKE
 - FLUSHING WATER SUPPLY DNTAKE

S. No.	TYPE	WIDTH (MM)	HEIGHT (MM)	FORMULA	NO.s	AREA (SQ M)
1	D1	1000	±0.0	LXB	2	14.060
2	D2	1000	±0.0	LXB	2	14.060
3	D3	1000	±0.0	LXB	2	14.060
4	D4	900	±0.0	LXB	2	12.960
5	D5	750	±0.0	LXB	2	11.250
6	DW1	2450	±0.0	LXB	2	9.216
7	DW2	3400	±0.0	LXB	1	66.119
8	DW3	1200	±0.0	LXB	2	2.400
9	DW4	1500	±0.0	LXB	2	3.000
10	FD	900	±0.0	LXB	2	1.800
11	GT1	1800	±0.0	LXB	2	3.600
12	GT2	3400	±0.0	LXB	1	68.000
13	W1	2000	±0.0	LXB	2	4.000
14	W2	2450	±0.0	LXB	2	9.216
15	W4	1500	±0.0	LXB	2	3.000
16	W5	900	±0.0	LXB	2	1.800
17	V1	950	±0.0	LXB	2	1.900
18	V2	800	±0.0	LXB	2	1.600
19	V3	800	±0.0	LXB	2	1.600
20	V4	1700	±0.0	LXB	2	3.400
21	V5	3750	±0.0	LXB	1	7.500

NOTE :- INTER LEVEL OF 18m / SERVICE FLOOR WILL BE 1750mm

DO NOT SCALE - 4th FLOOR

PROPOSED BUILDING PLANS FOR MIXED LAND USE COLONY (70% RESIDENTIAL COMPONENT & 30% COMMERCIAL COMPONENT) UNDER TRANSIT ORIENTED DEVELOPMENT POLICY (TOD) FOR THE AREA MEASURING 8.34375 ACRES (LICENSE NO. 127 OF 2023 DATED 16/06/2023) IN SECTOR-94, GURUGRAM MANESAR URBAN COMPLEX BEING DEVELOPED BY GANGA GLOBAL HOMES PVT.LTD.

LC - 4946/1E(SB)/2023/19420



OWNERS SIGNATURE

ARCHITECT'S SIGNATURE

Avanika Vishishth
CA/2018/167670

DRAWING TITLE

TOWER - 2
(TOWER - 3 IS MIRROR OF TOWER - 2)
45th FLOOR PLAN & AREA DIAGRAM

ARCHITECT	NORTH		
GANGA REALTY - DESIGN TEAM			
GANGA REALTY			
Villla Tower, Golf Course Road			
Gurgaon, Haryana			
DATE	SEPT. 2023	AG	
SCALE	1:100	DA	
CHECKED			