



NOTE - ALL INTERNAL/EXTERNAL WALL OF RCC WITH 150 MM THICKNESS

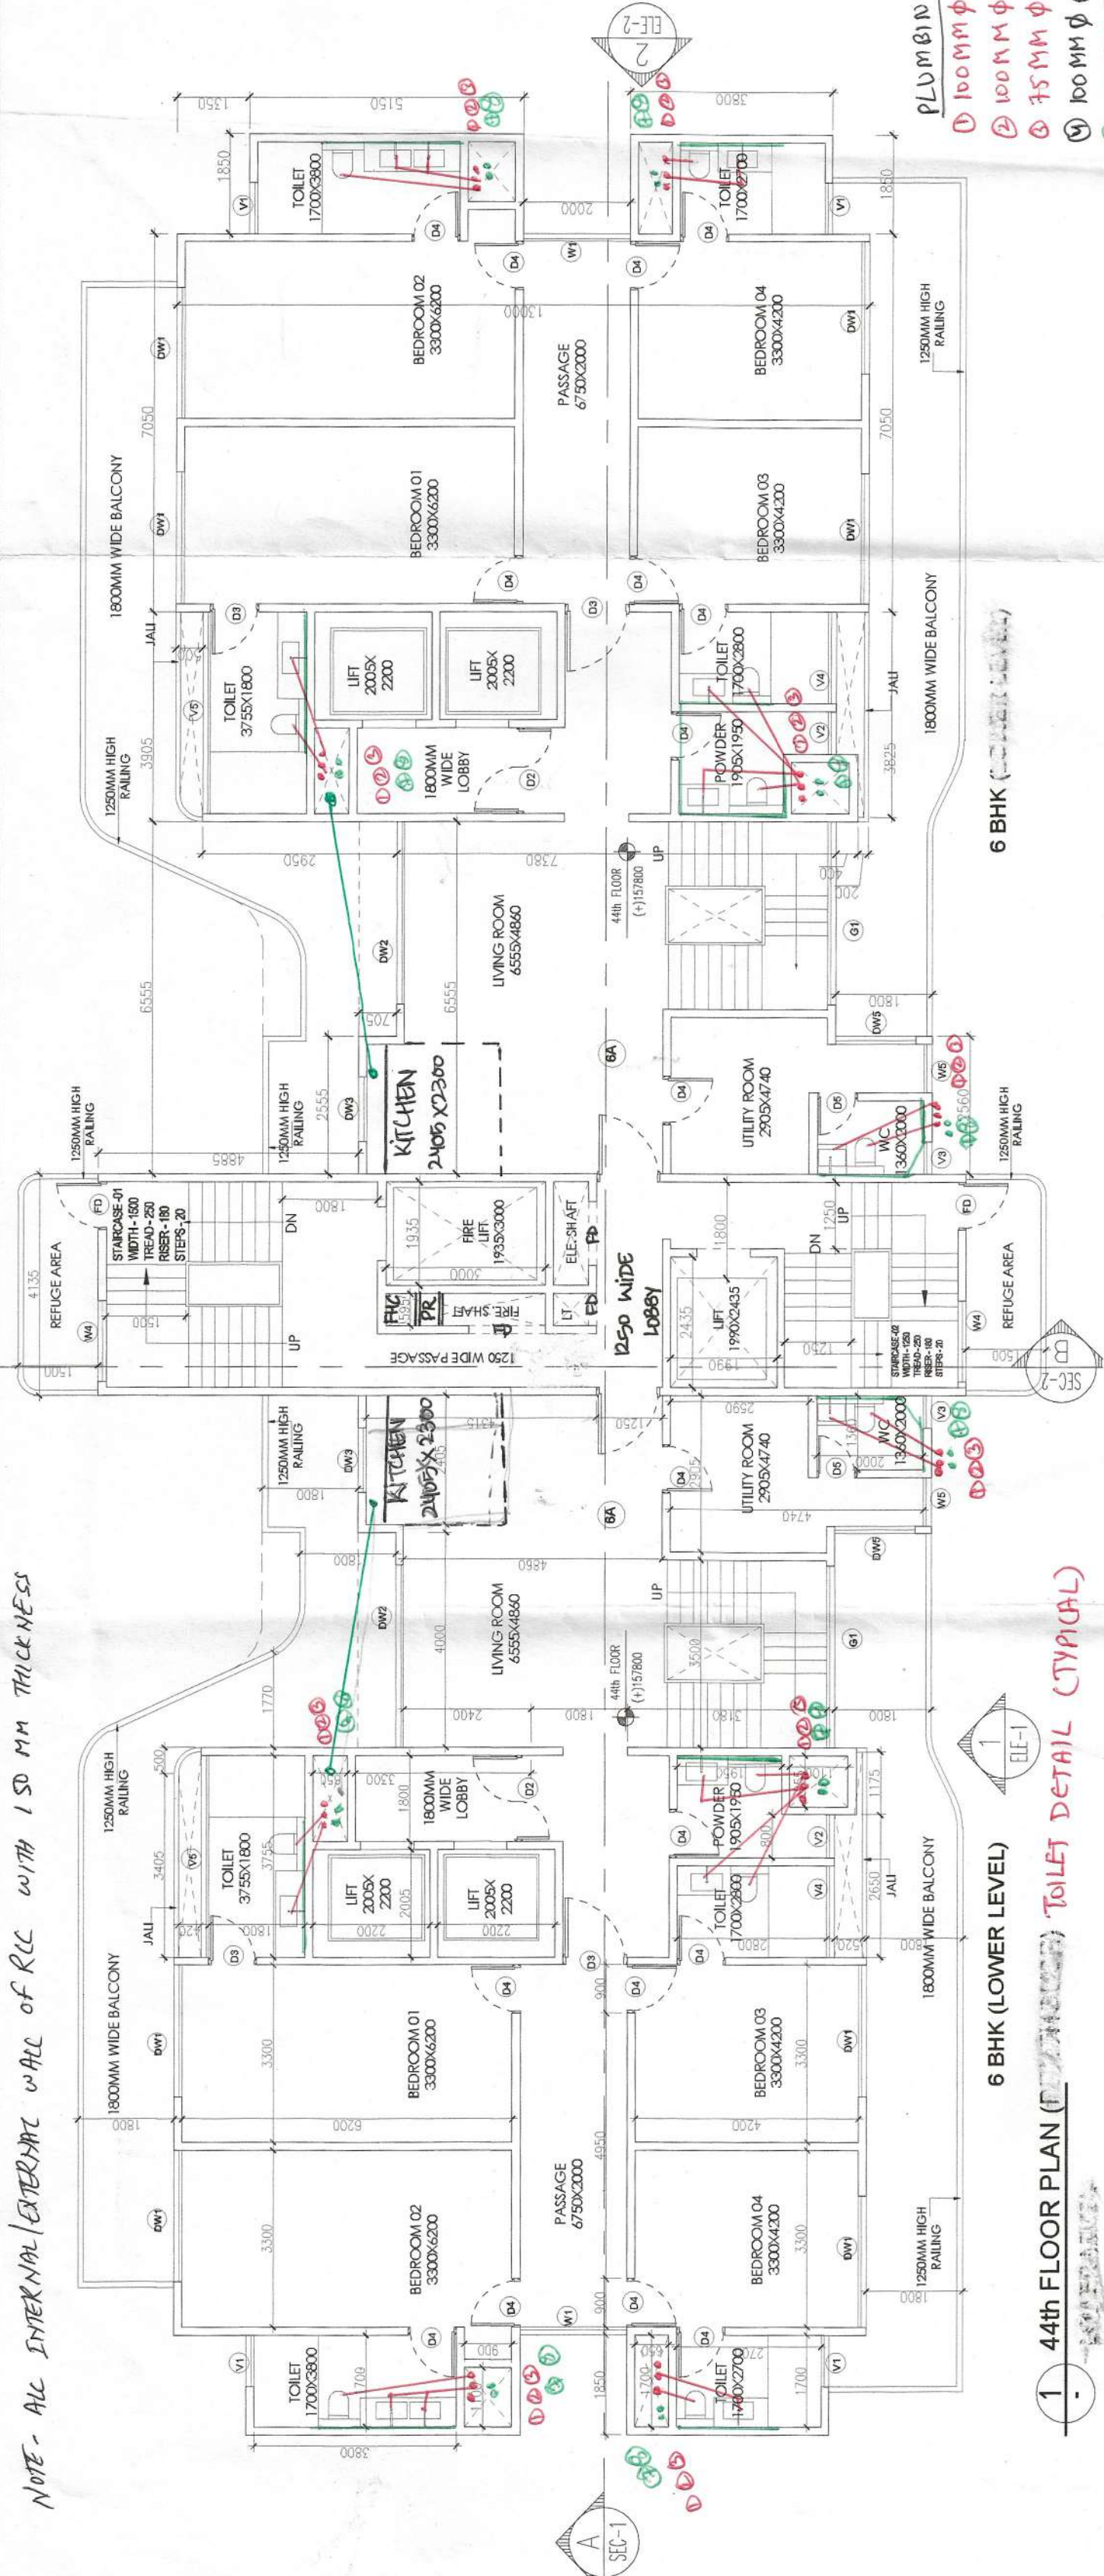


- PLUMBING LEGEND
- 100MM Ø SOIL & VENT PIPE
 - 100MM Ø WASTE & VENT PIPE
 - 75MM Ø ANTISIPHONAGE PIPE
 - 60MM Ø RAIN WATER PIPE DMTAKE
 - DOMESTIC WATER SUPPLY RISER
 - FLUSHING WATER SUPPLY RISER
 - DOMESTIC WATER SUPPLY DMTAKE
 - FLUSHING WATER SUPPLY DMTAKE

3D 44th FLOOR PLAN (TYPICAL) TOILET DETAIL (TYPICAL)

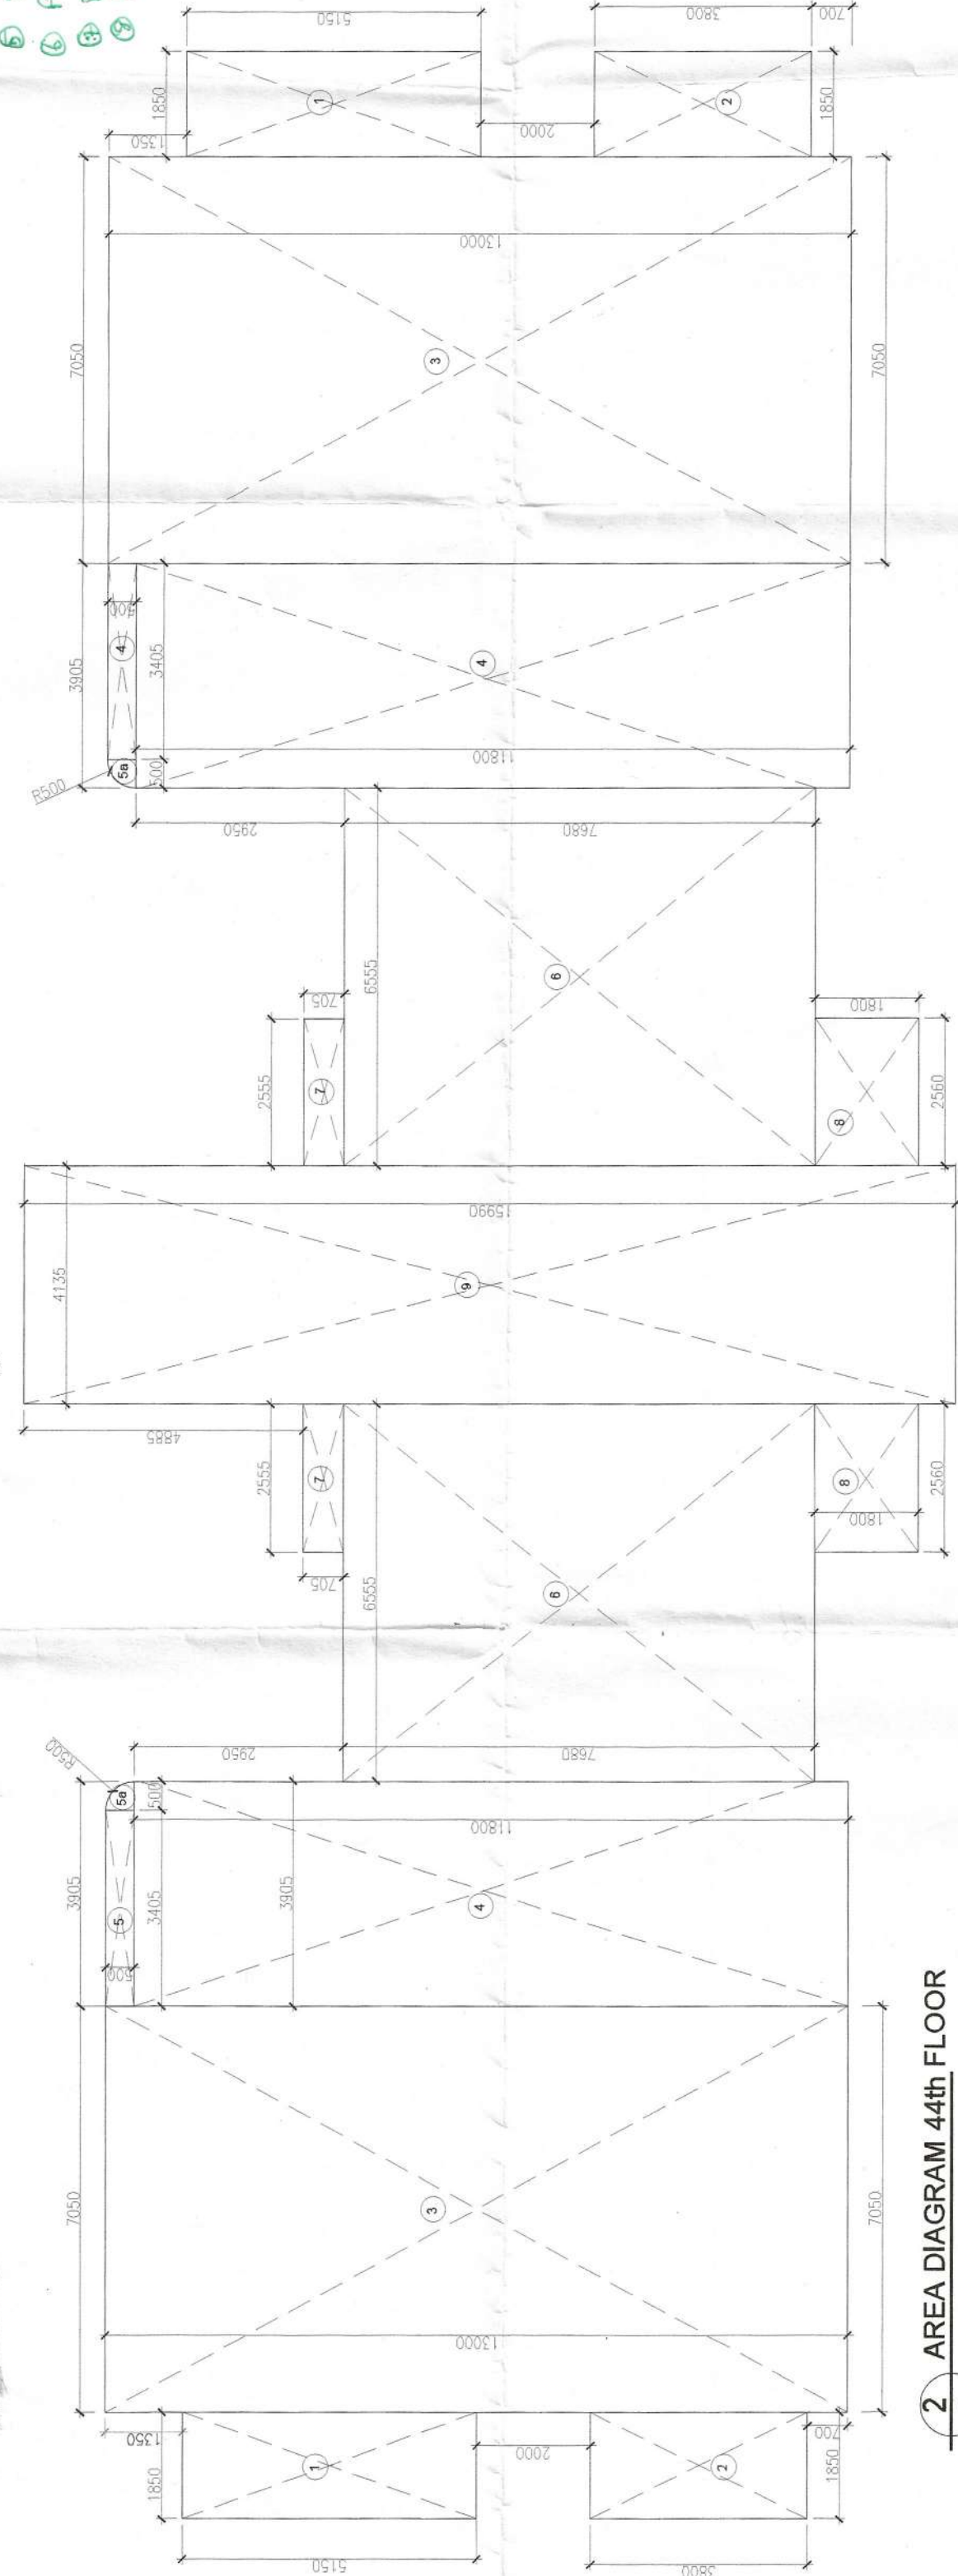

2D AREA DIAGRAM 44th FLOOR

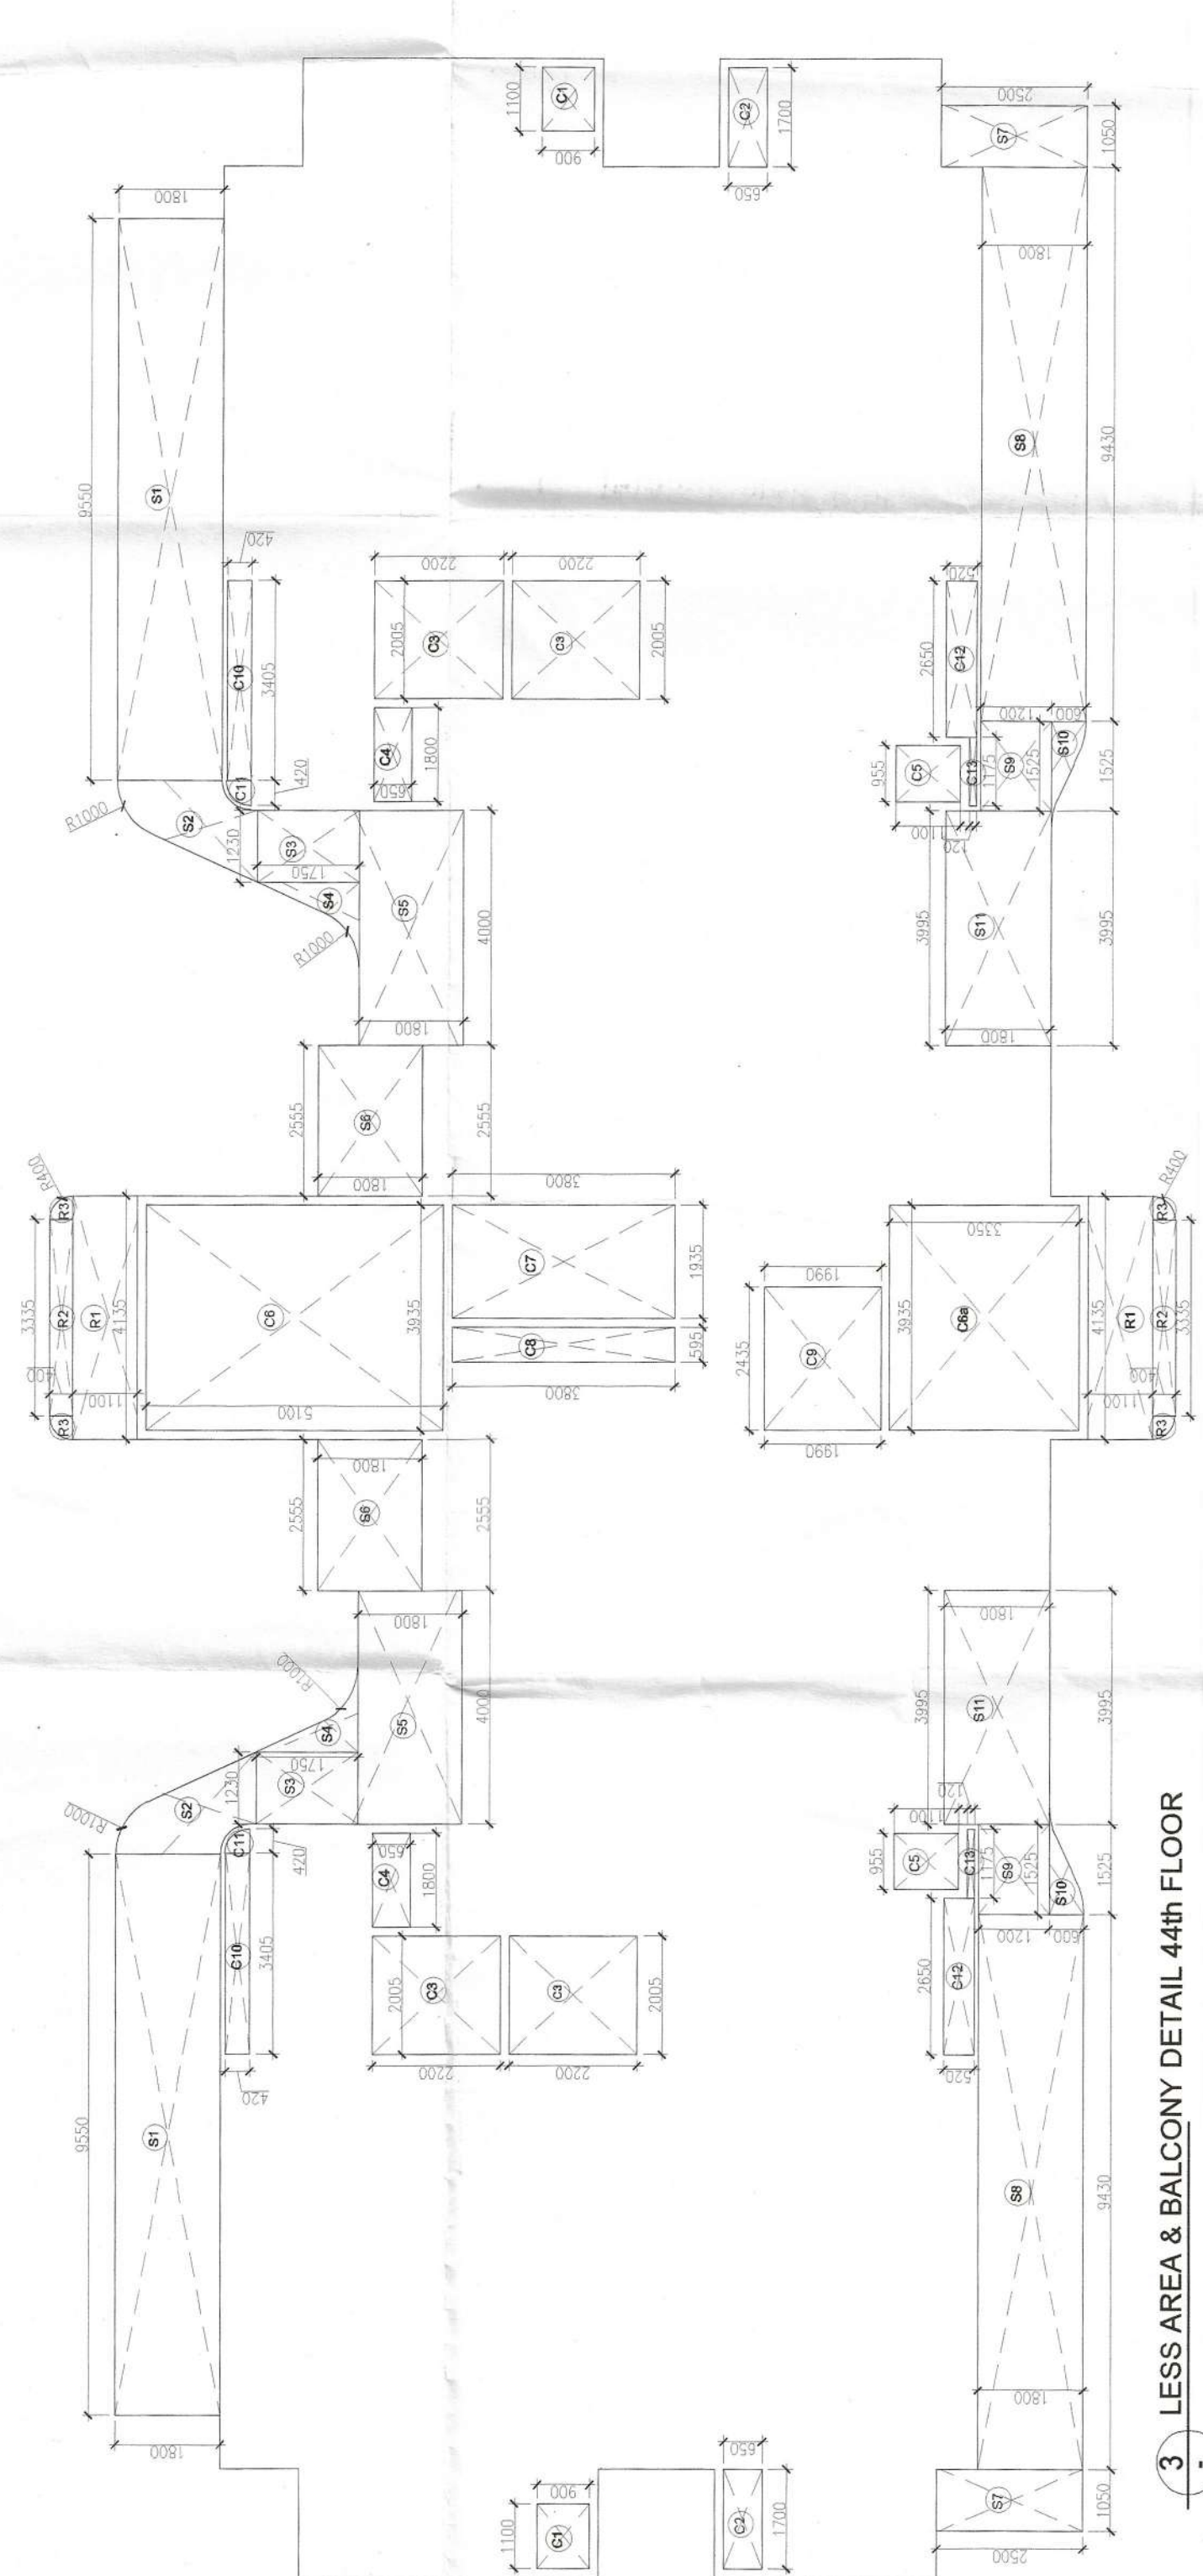

3D LESS AREA & BALCONY DETAIL 44th FLOOR

DOOR/WINDOW SCHEDULE					
S. No.	TYPE	WIDTH (MM)	HEIGHT (MM)	UNTEL (MM)	HEIGHT (MM)
1	D1	1800	2100	2100	2100
2	D2	1800	2100	2100	2100
3	D3	1200	2100	2100	2100
4	D4	900	2100	2100	2100
5	D5	750	2100	2100	2100
6	DW1	2450	2100	2100	2100
7	DW2	3400	2100	2100	2100
8	DW3	1200	2100	2100	2100
9	DW5	1500	2100	2100	2100
10	FD	900	2100	2100	2100
11	G21	1800	2100	2100	2100
12	G1	3400	2100	2100	2100
13	W1	2000	2100	2100	2100
14	W2	2450	2100	2100	2100
15	W4	1500	2100	2100	2100
16	W5	900	2100	2100	2100
17	V1	850	2100	2100	2100
18	V2	800	2100	2100	2100
19	V3	600	2100	2100	2100
20	V4	1700	2100	2100	2100
21	V5	3750	2100	2100	2100

* 15 & 16 - 1/4" FIRE RATED

PROPOSED BUILDING PLANS FOR MIXED LAND USE COLONY (70% RESIDENTIAL COMPONENT & 30% COMMERCIAL COMPONENT) UNDER TRANSFORMED DEVELOPMENT POLICY (TDP) FOR THE AREA MEASURING 8.9475 ACRES (LICENSE NO. 127 OF 2023 DATED 16/06/2023) IN SECTOR-54, GURUGRAM, MANESAR URBAN COMPLEX BEING DEVELOPED BY GANGA GLOBAL HOMES PVT. LTD.

LC - 4946/JE(SB)/2023/19420

OWNERS SIGNATURE



ARCHITECT'S SIGNATURE

Avanika Vishish
CA/2019/1670

DRAWING TITLE

TOWER - 2
(TOWER - 3 IS MIRROR OF TOWER - 2)
44th FLOOR PLAN & AREA DIAGRAM

ARCHITECT
GANGA REALTY
Gurgaon, Haryana

NORTH



DATE
SEPT. 2023

SCALE
1:100

DEALT
AG

CHECKED
DA

S - 216