

REFUGE AREA DETAIL (R)				
NAME	WIDTH (MM)	HEIGHT (MM)	FORMULA	NO.s
R1	4135	X	LXB	1
R2	3335	X	LXB	1
R3		AS/IZE (R-400)	$\pi r^2/4$	2
TOTAL AREA - (RA)				6.134

8th, 12th, & 14th -15, 17th-23rd, 25th -31st, 33rd - 39th, 41th-43th FLOOR	2	33	404.824
--	---	----	---------

TO BE READ WITH THIS OFFICE MEMO NO.:

DATE: 10/09/2023

DD (HQ) Member BPAC

(Dinesh Kumar) PA(HQ)

DOOR/WINDOW SCHEDULE				
S. No.	TYPE	WIDTH (MM)	HEIGHT (MM)	LEVEL (MM)
1	D1	1800	2700	+2700
2	D2	1800	2700	+2700
3	D3	1200	2700	+2700
4	D4	900	2700	+2700
5	D5	750	2700	+2700
6	DW1	2400	2700	+2700
7	DW2	3400	2700	+2700
8	DW3	1200	2700	+2700
9	DW5	1500	2700	+2700
10	FD	900	2700	+2700
11	GD1	1800	2700	+2700
12	G1	3400	2700	+2700
13	W1	2000	1800	+2700
14	W2	2400	1800	+2700
15	W4	1500	1800	+2700
16	W5	900	1800	+2700
17	V1	900	1800	+2700
18	V2	800	1800	+2700
19	V3	800	1800	+2700
20	V4	700	1800	+2700
21	V5	375	1800	+2700
NOTE - UNIL LEVEL OF 18th SERVICE FLOOR WILL BE 1750mm				

D3 & FD - 4th FIRE RATED

PROPOSED BUILDING PLANS FOR MIXED LAND USE COLONY (70% RESIDENTIAL COMPONENT & 30% COMMERCIAL COMPONENT) UNDER TRANSIT ORIENTED DEVELOPMENT POLICY (TOD) FOR THE AREA MEASURING 8.34375 ACRES (LICENSE NO. 127 OF 2023 DATED 16/06/2023) IN SECTOR-84, GURUGRAM MANESAR URBAN COMPLEX BEING DEVELOPED BY GANGA GLOBAL HOMES PVT.LTD.

LC - 4946/IE(SB)/2023/19420



OWNERS SIGNATURE

ARCHITECT'S SIGNATURE

Avanika Vashishth
CA/2019/151670

DRAWING TITLE

TOWER - 2
(TOWER - 3 IS MIRROR OF TOWER - 2)

TYPICAL FLOOR PLAN & AREA DIAGRAM
(8th-12th, 14th-16th, 18th-23rd, 25th-31st, 33rd-39th, 41st-43rd)


ARCHITECT

GANGA REALTY - DESIGN TEAM
GANGA REALTY
Villu Tower, Golf Course Road
Gurgaon, Haryana



DATE	SEPT. 2023
SCALE	1:100
DEALT	AG
CHECKED	DA

S - 214

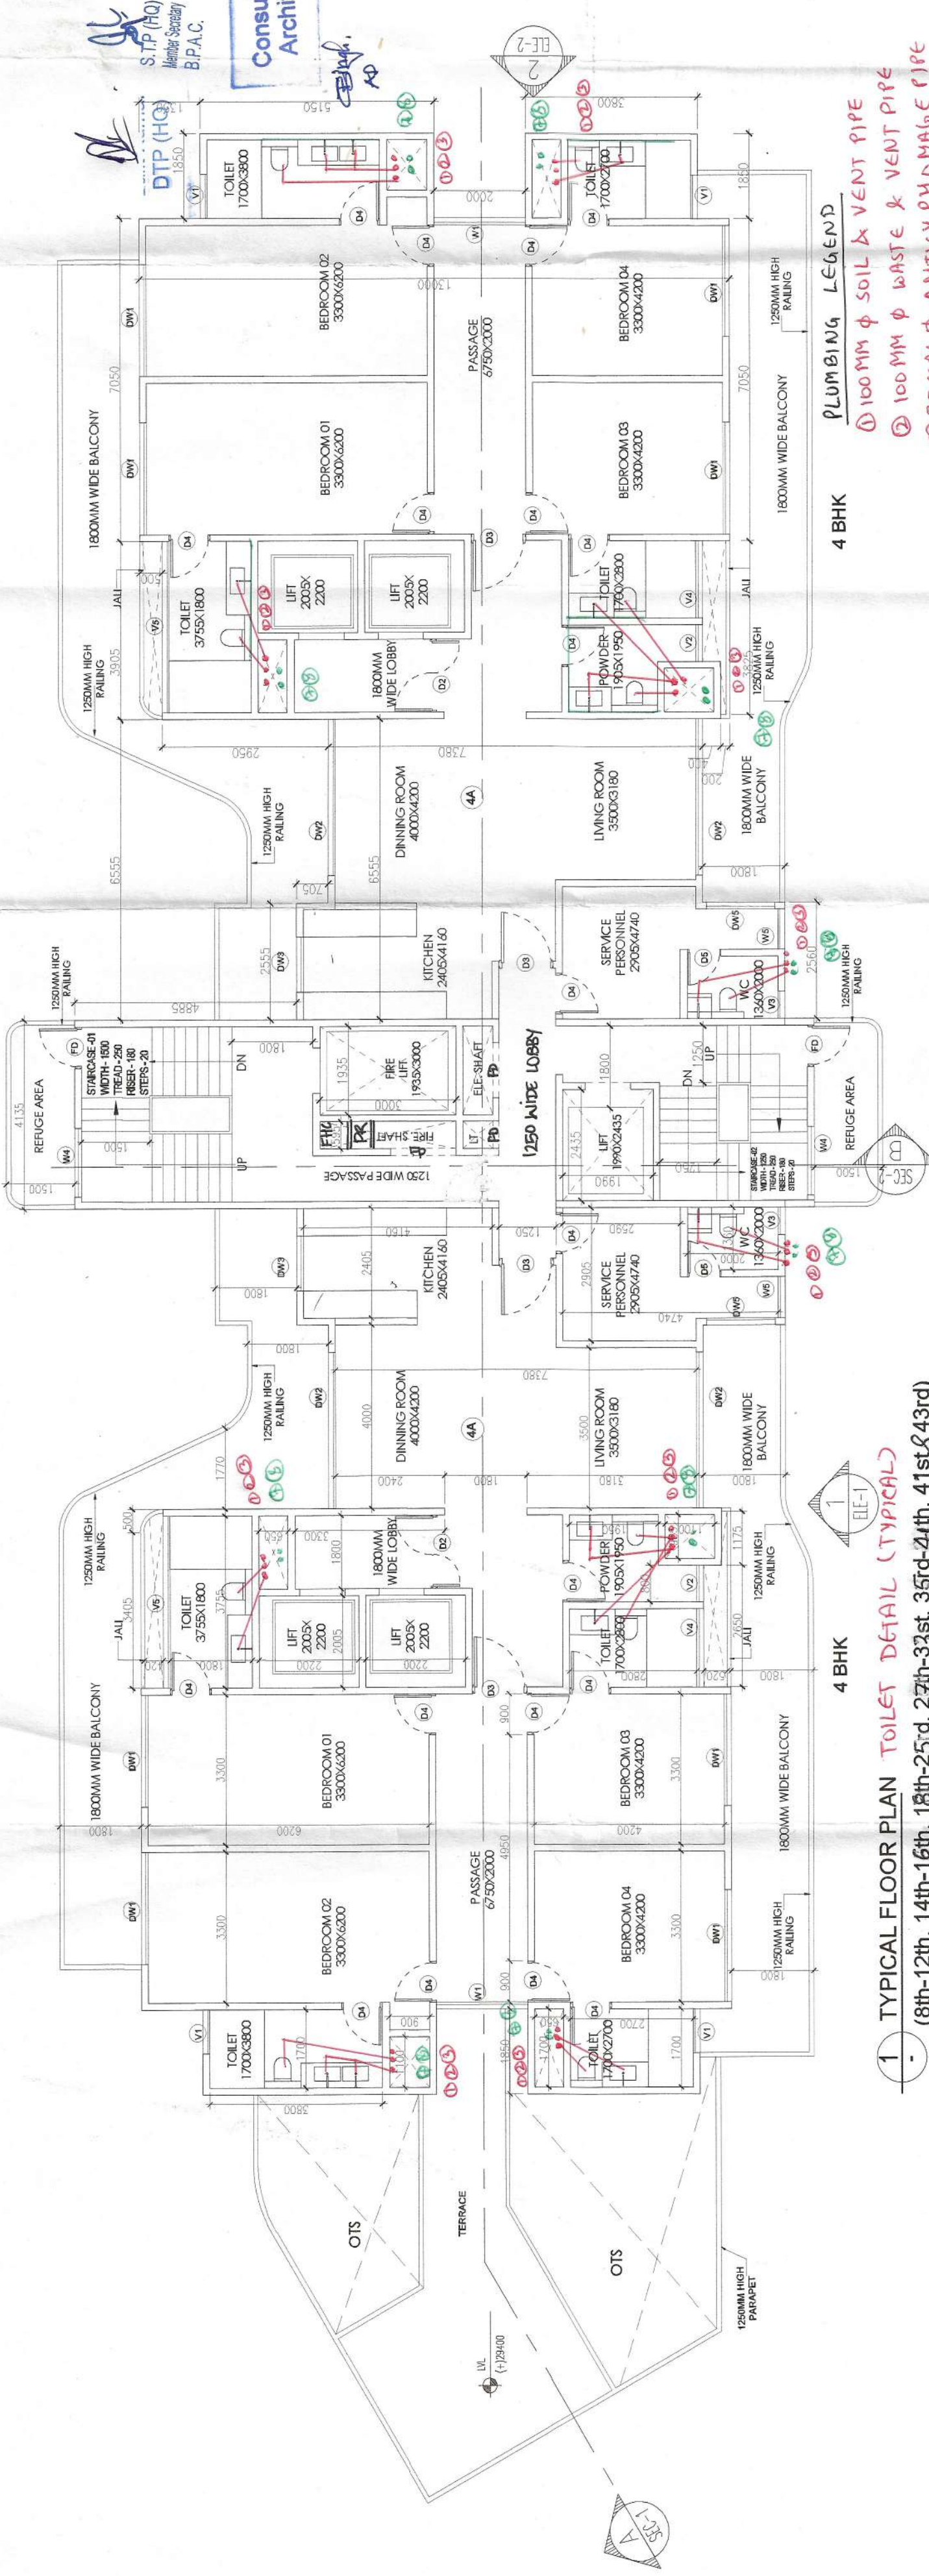


PLUMBING LEGEND


- 100mm ϕ SOIL & VENT PIPE
- 100mm ϕ WASTE & VENT PIPE
- 75mm ϕ ANTI-SIPHONAGE PIPE
- 100mm ϕ RAIN WATER PIPE DRAINAGE
- DOMESTIC WATER SUPPLY RISER
- FLUSHING WATER SUPPLY RISER
- DOMESTIC WATER SUPPLY DRAINAGE
- FLUSHING WATER SUPPLY DRAINAGE

4 BHK

1. TYPICAL FLOOR PLAN TOILET DETAIL (TYPICAL)
(8th-12th, 14th-16th, 18th-23rd, 25th-31st, 33rd-39th, 41st-43rd)

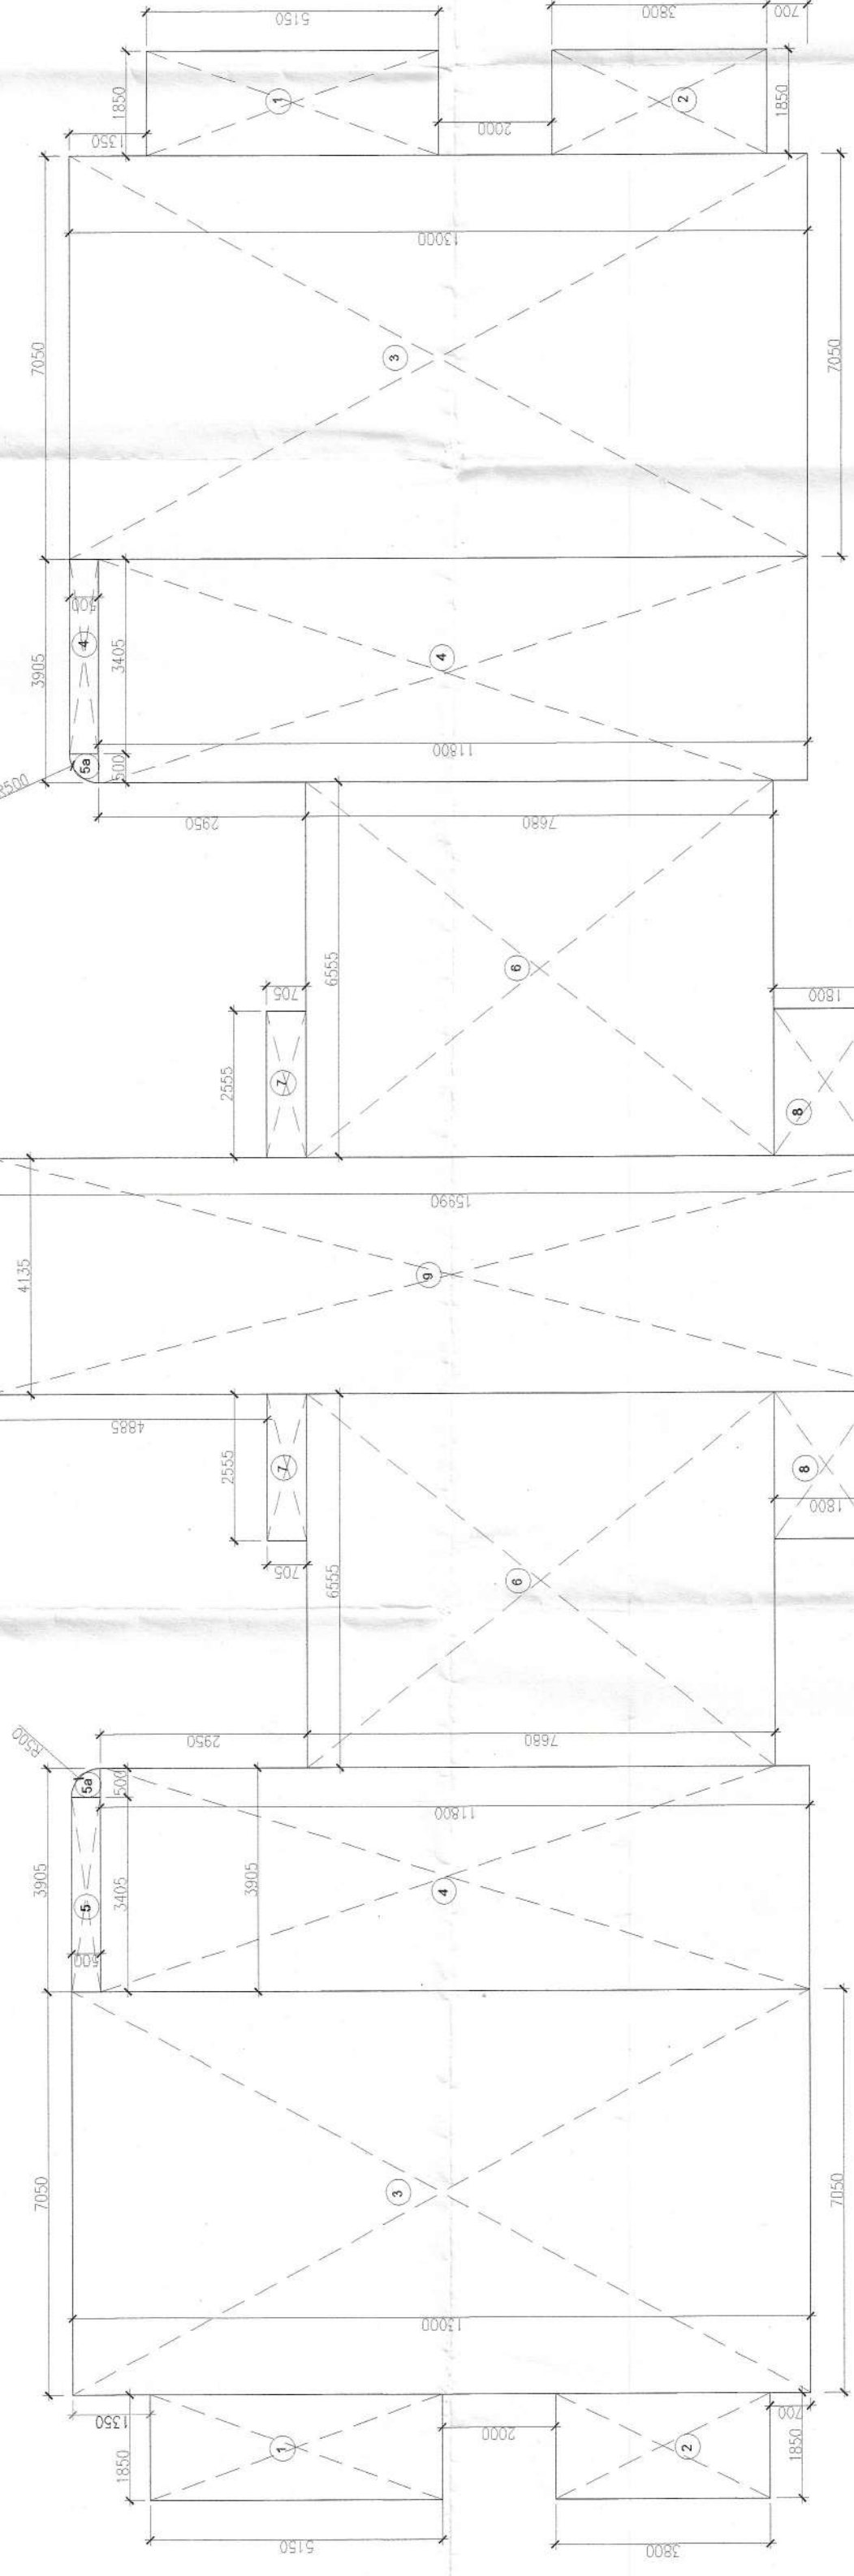

2. AREA DIAGRAM TYPICAL
(8th-12th, 14th-16th, 18th-23rd, 25th-31st, 33rd-39th, 41st-43rd)

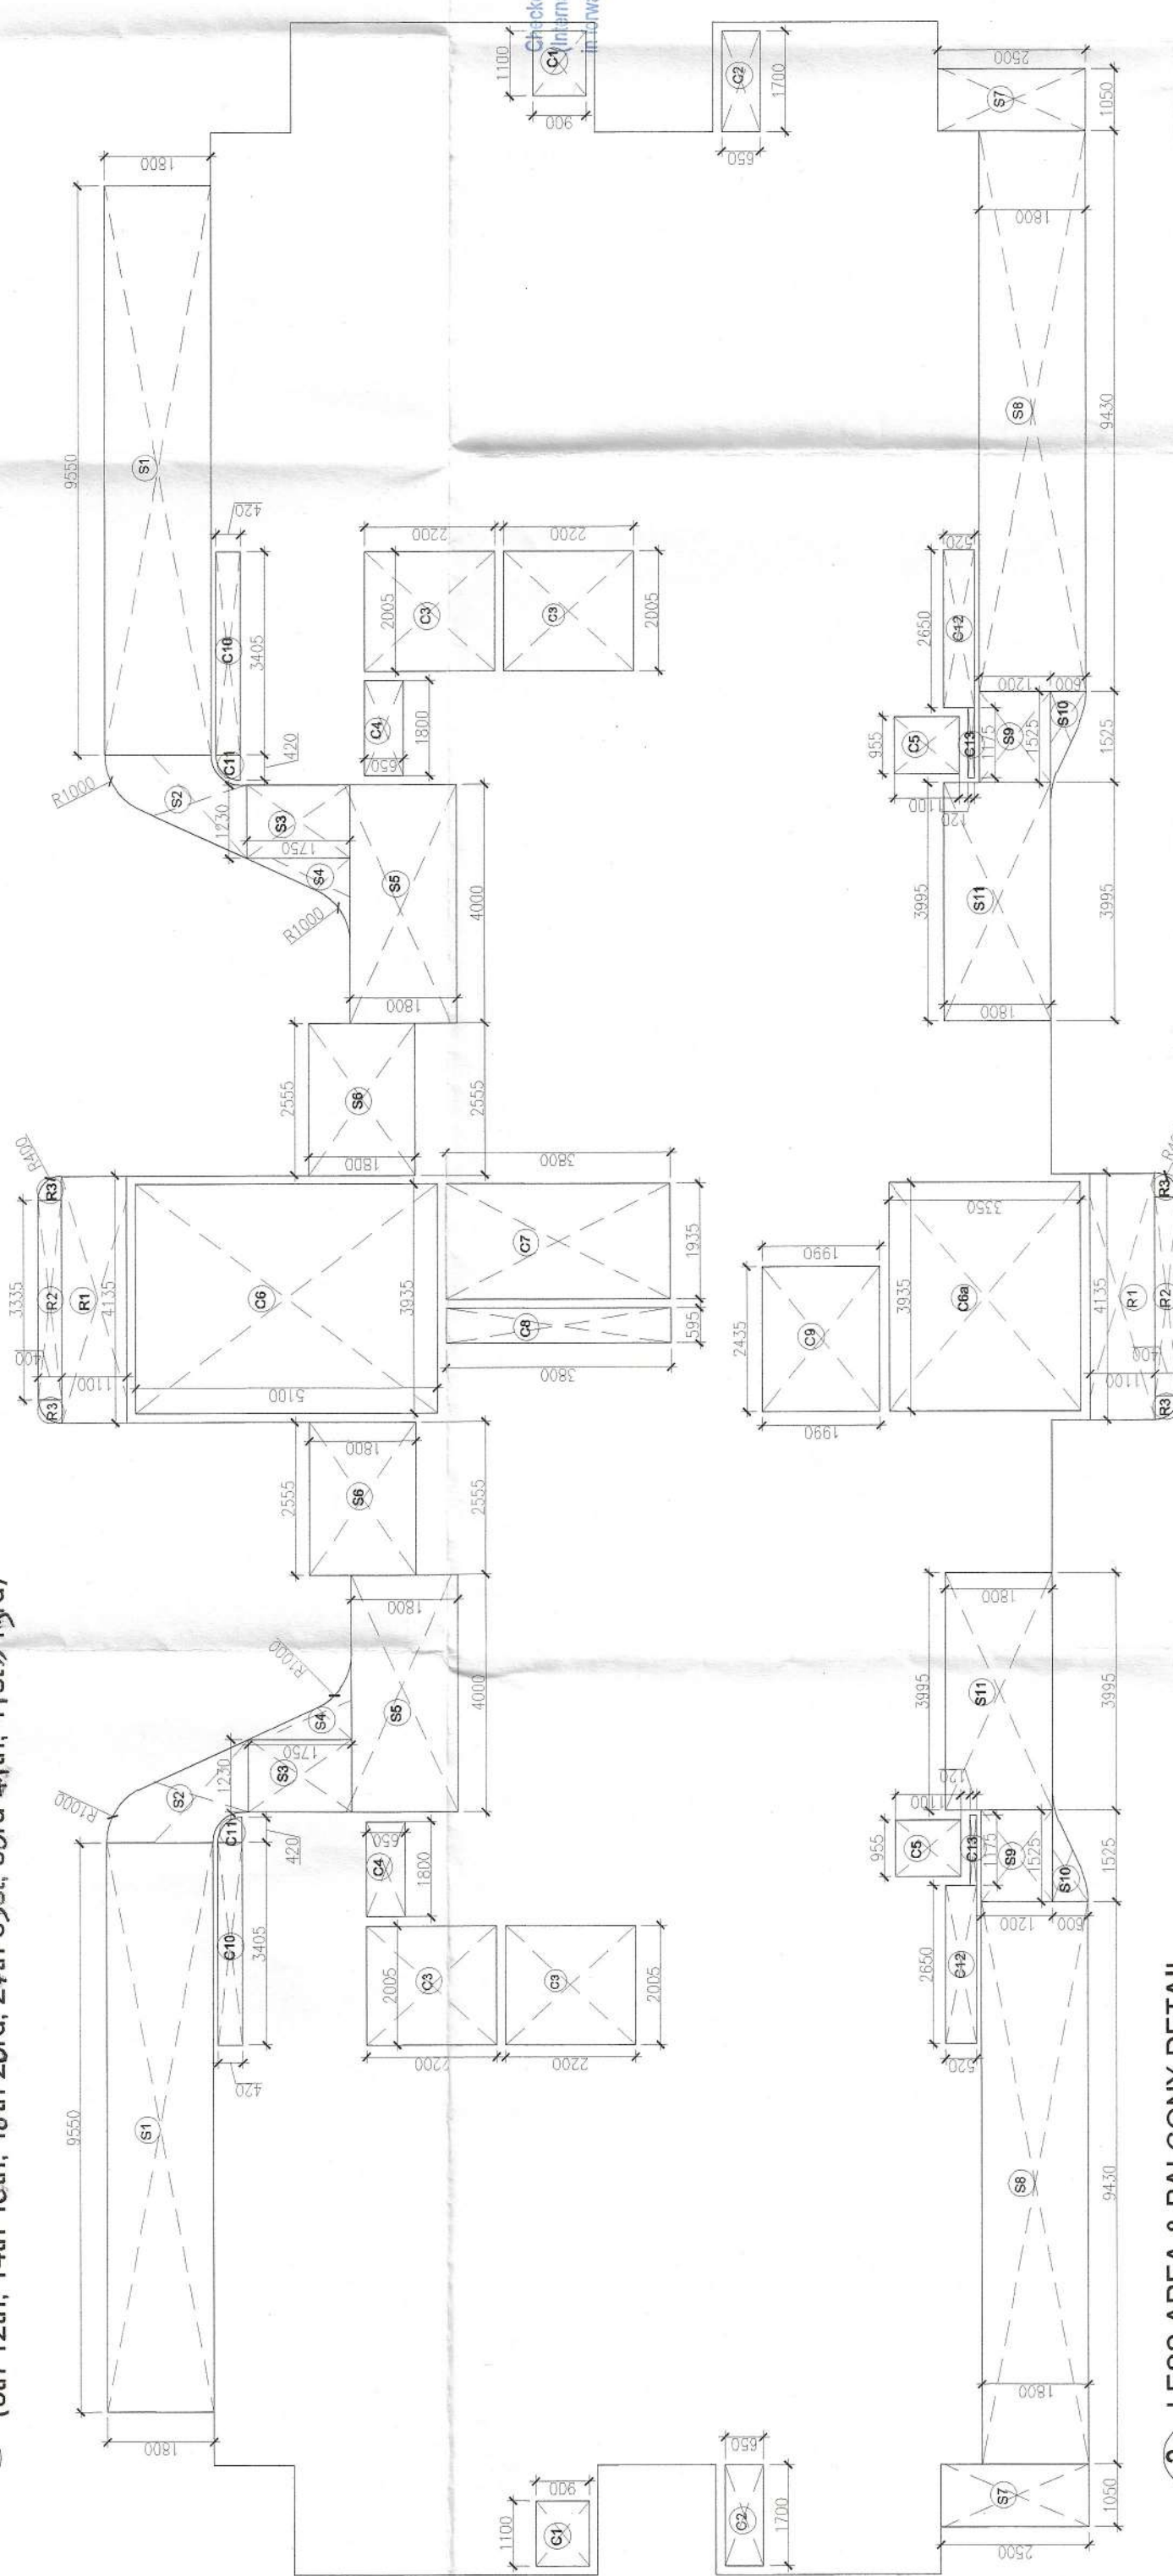

3. LESS AREA & BALCONY DETAIL
(8th-12th, 14th-16th, 18th-23rd, 25th-31st, 33rd-39th, 41st-43rd)

Checked and found ok for Public Health
(Signature) Services only subject to comments in
the forwarding letter. Date: 10/09/2023

Sanjay Kumar Engineer (HQ)
for Chief Engineer-1
HSRP Panchkula

Signature