


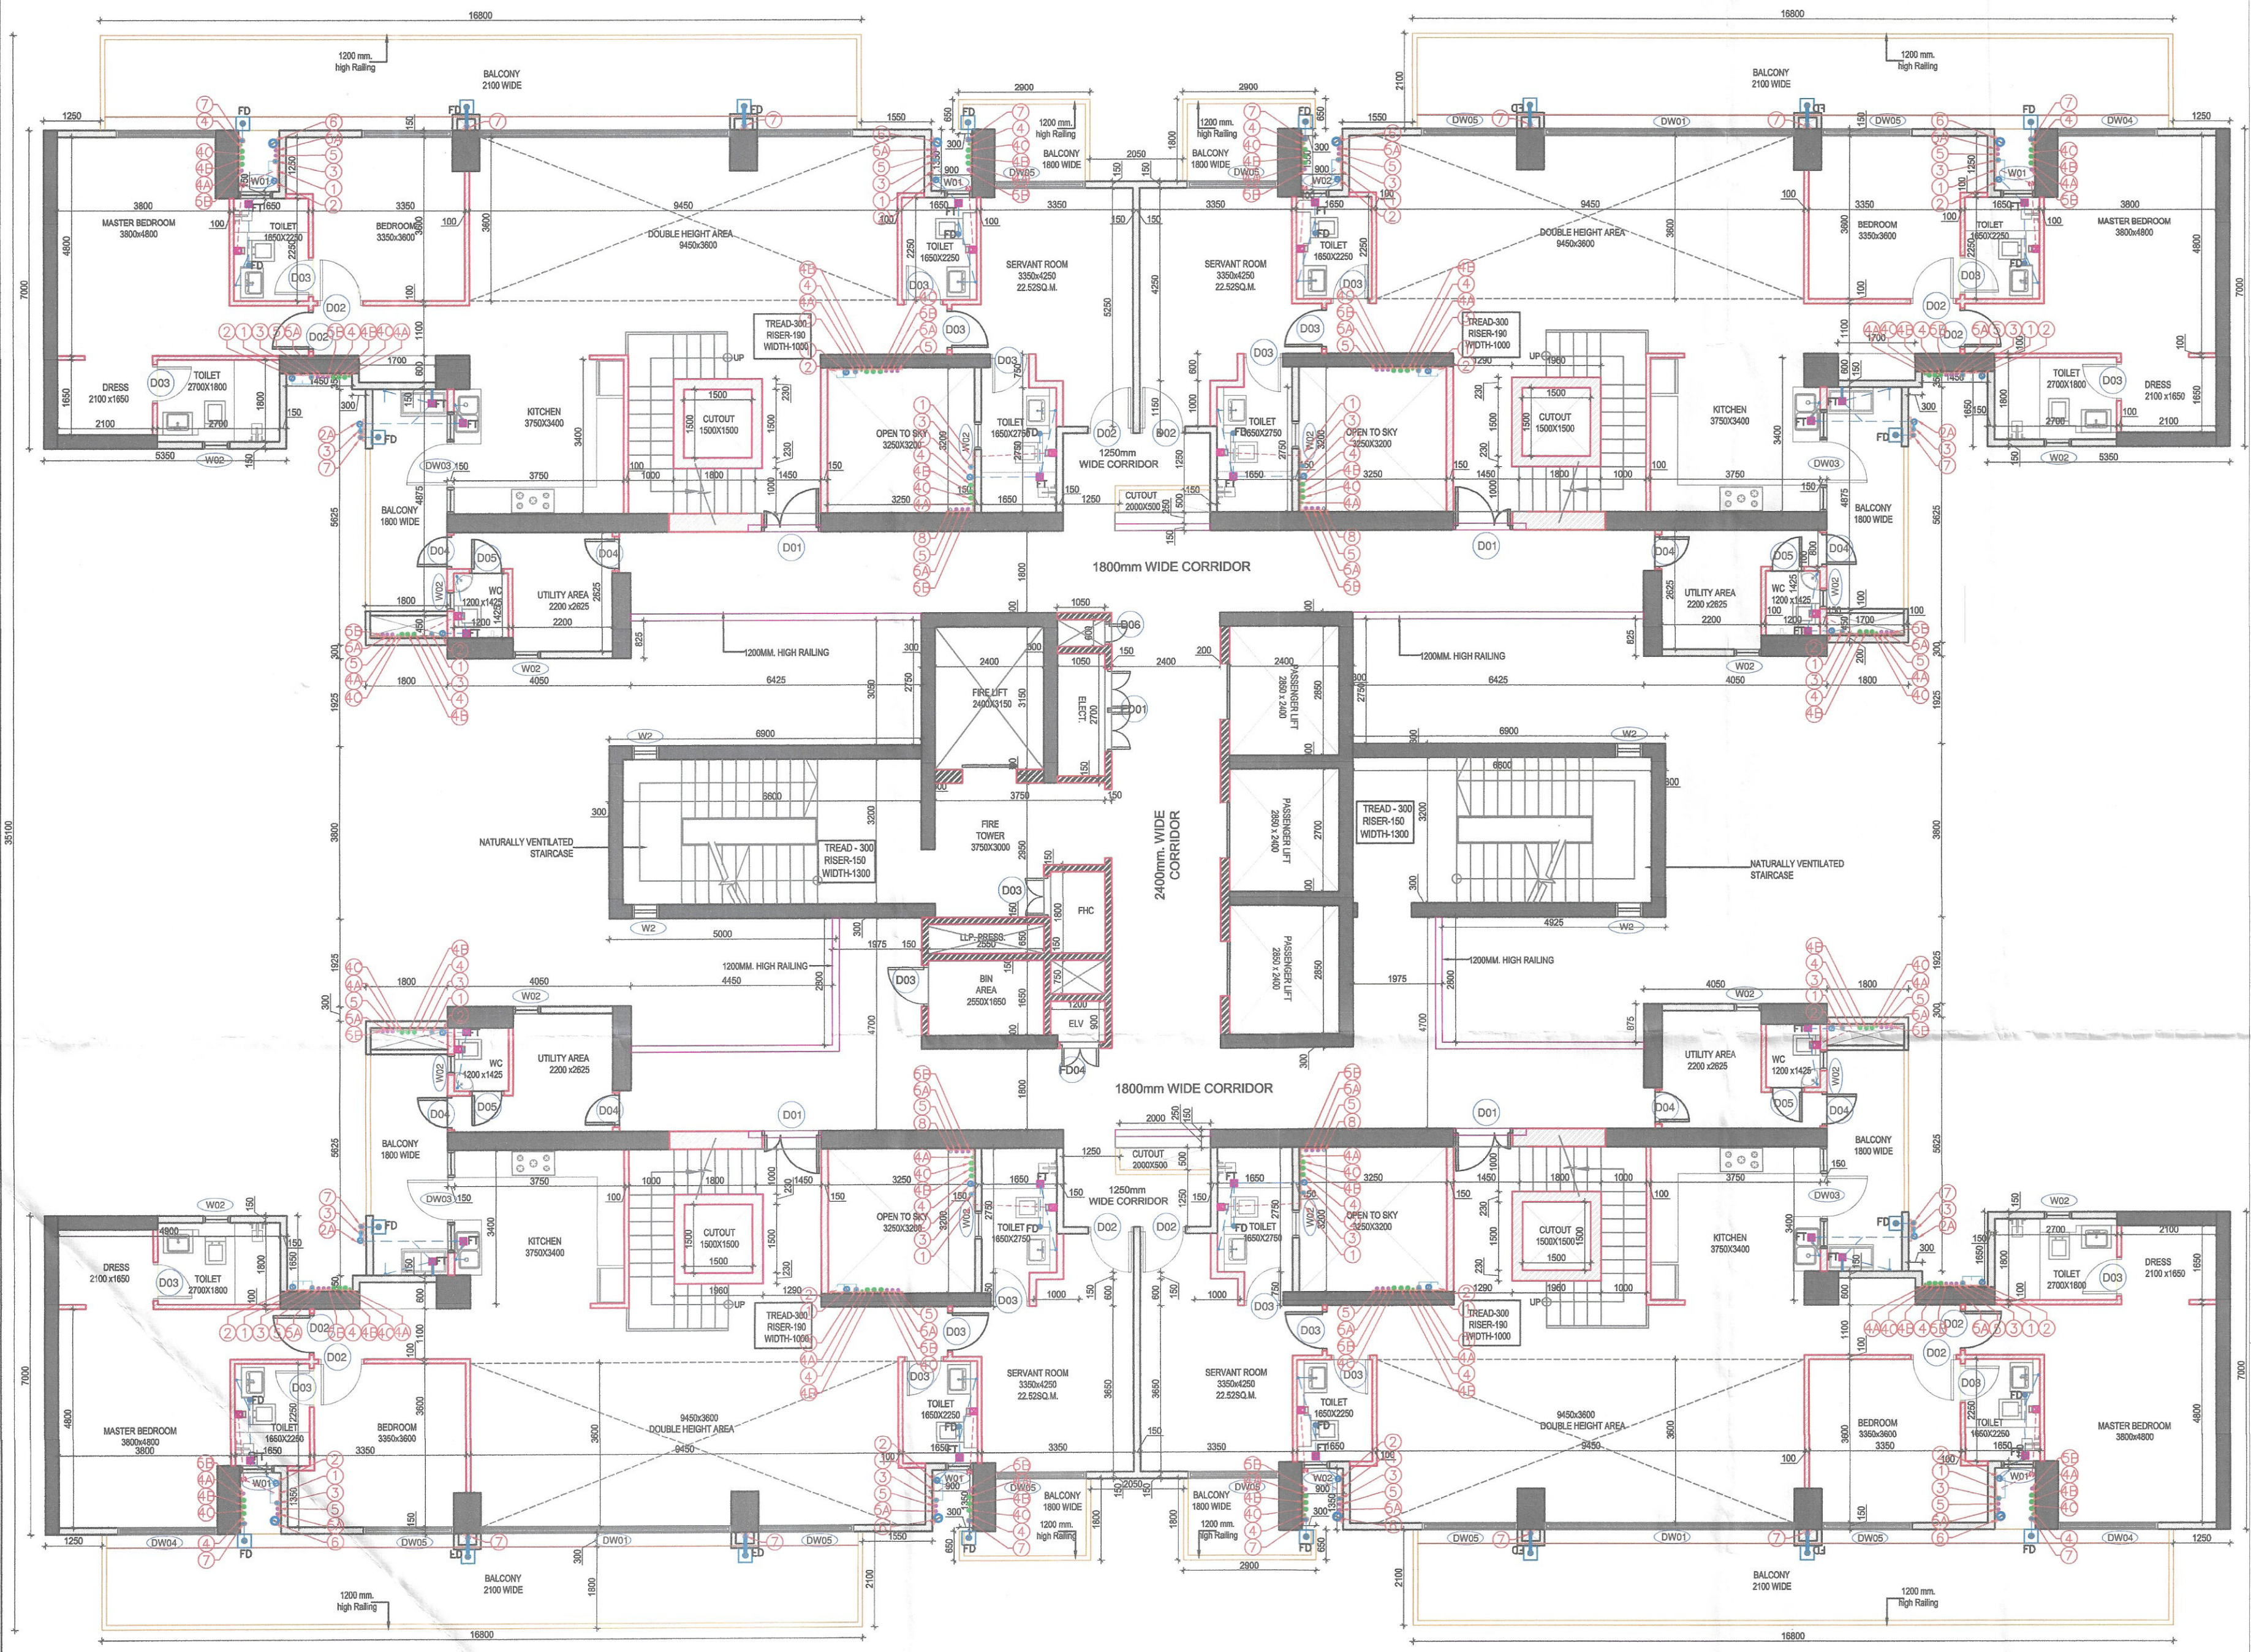

1 TOWER-05 39TH LOWER PENT HOUSE LEVEL PLAN
Scale: 1:100

2 TOWER-08 32ND LOWER PENT HOUSE LEVEL PLAN
Scale: 1:100

DOOR - WINDOW SCHEDULE- TOWER					
INTERNAL DOORS					
DOOR TAG	LEVEL (FROM FFL)				FIRE RATED (HRS.)
	WIDTH	HEIGHT	CILL	LINTEL	
D01	1300	2100	±00	2100	1HR
D02	1000	2100	±00	2100	
D03	900	2100	±00	2100	2HRS
D04	800	2100	±00	2100	1HR
D05	750	2100	±00	2100	
D06	500	2100	±00	2100	
FD01	1800	2100	±00	2100	2HRS
FD02	1500	2100	100	2100	2HRS
FD03	1200	2100	100	2100	2HRS
FD04	900	2100	±00	2100	2HRS
EXTERNAL DOORS					
DW01	5000	2350	100	2450	
DW03	2250	2350	100	2450	
DW04	2200	2350	±00	2450	
DW05	2000	2350	±00	2450	
WINDOWS					
W0	750	1300	1200	2450	
W01	600	1300	1200	2450	
W02	600	1350	150	1500	
W03	1950	1300	100	2450	

WALL LEGEND	
	R.C.C LOAD BEARING WALL / COLUMN
	R.C.C NON LOAD BEARING WALL
	BLOCK WALL

Checked and found ok for Public Health
(Internal) Service only subject to comments in
in forwarding letter No. 252394 DU 24/11/23

Superintending Engineer (HQ)
for Chief Engineer-I
HSVP, Panchkula

Member
B.P.A.C.

Sign & Stamp

DTP (HQ)

S.T.P (HQ)

Member Secretary

S.T.P (G)

Member

S.T.P (Hr.)

Chairman

Consultant

Architect

DTP (HQ)

NOTE:- ALL TOILETS ARE MECHANICALLY VENTILATED WITH 100% POWER BACKUP

SANCTIONED TO BE READ WITH THIS OFFICE

MEMO NO.: DATED :

LEGEND

SYMBOL

DESCRIPTION

1

110 OD SOIL AND VENT PIPE

2

110 OD WASTE AND VENT PIPE

3

110 OD KITCHEN WASTE AND VENT PIPE

4

75# ANTISYPHONAGE PIPE

5

DOMESTIC WATER SUPPLY DN. TAKE PIPE

6

DOMESTIC WATER SUPPLY DN. TAKE PIPE FOR TOP FIVE FLOORS (PRESSURE SUPPLY)

7

DOMESTIC WATER SUPPLY DN. TAKE PIPE

8

DOMESTIC WATER SUPPLY DN. TAKE PIPE

9

FLUSHING WATER SUPPLY DN. TAKE PIPE

10

FLUSHING WATER SUPPLY DN. TAKE PIPE

11

FLUSHING WATER SUPPLY DN. TAKE PIPE

12

160 OD uPVC TERRACE RAIN WATER PIPE

13

75# uPVC RAIN WATER PIPE (BALCONY)

14

DOMESTIC WATER SUPPLY RISER

15

FLUSHING WATER SUPPLY RISER

FD

FLOOR DRAIN

FT

FLOOR TRAP

LEDGE WALL

■

CUTOUT IN FLOOR

LEGEND

SOIL WASTE PIPE

WASTE WATER PIPE

BALCONY DRAIN PIPE

REFUGE FLOOR LEVELS

15TH FLOOR LEVEL : +81.75 MT.

DESIGN FORUM INTERNATIONAL

ARCHITECTURE • URBAN DESIGN • TOWN PLANNING

K-47, KAILASH COLONY NEW DELHI-48

PHONE: 011 - 46556600 FAX : 46556601

PROJECT NAME & ADDRESS

PROPOSED GROUP HOUSING DEVELOPMENT AT VILLAGE GADAUJI KALAN, SECTOR 37 D GURUGRAM BEING DEVELOPED BY SIGNATURE GLOBAL BUSSINESS PARK PVT. LTD. AT SECTOR - 37 D, AREA - 16.65625 ACRE. LICENCE NO. -230 OF 2023 DATED 02/11/2023

CLIENT NAME & ADDRESS

SIGNATURE GLOBAL BUSSINESS PARK PVT. LTD. 114, SECTOR-44, GURUGRAM HARYANA- 122002

ARCHITECT'S SIGN & STAMP

CLIENT'S SIGN & STAMP

DRAWING TITLE

TOWER-05 &-08

PENTHOUSE LOWER LEVEL FLOOR PLAN

SCALE

DRAWING NO.

NORTH

1:100 ON A1

DATE

18.11.2023

T5-004