


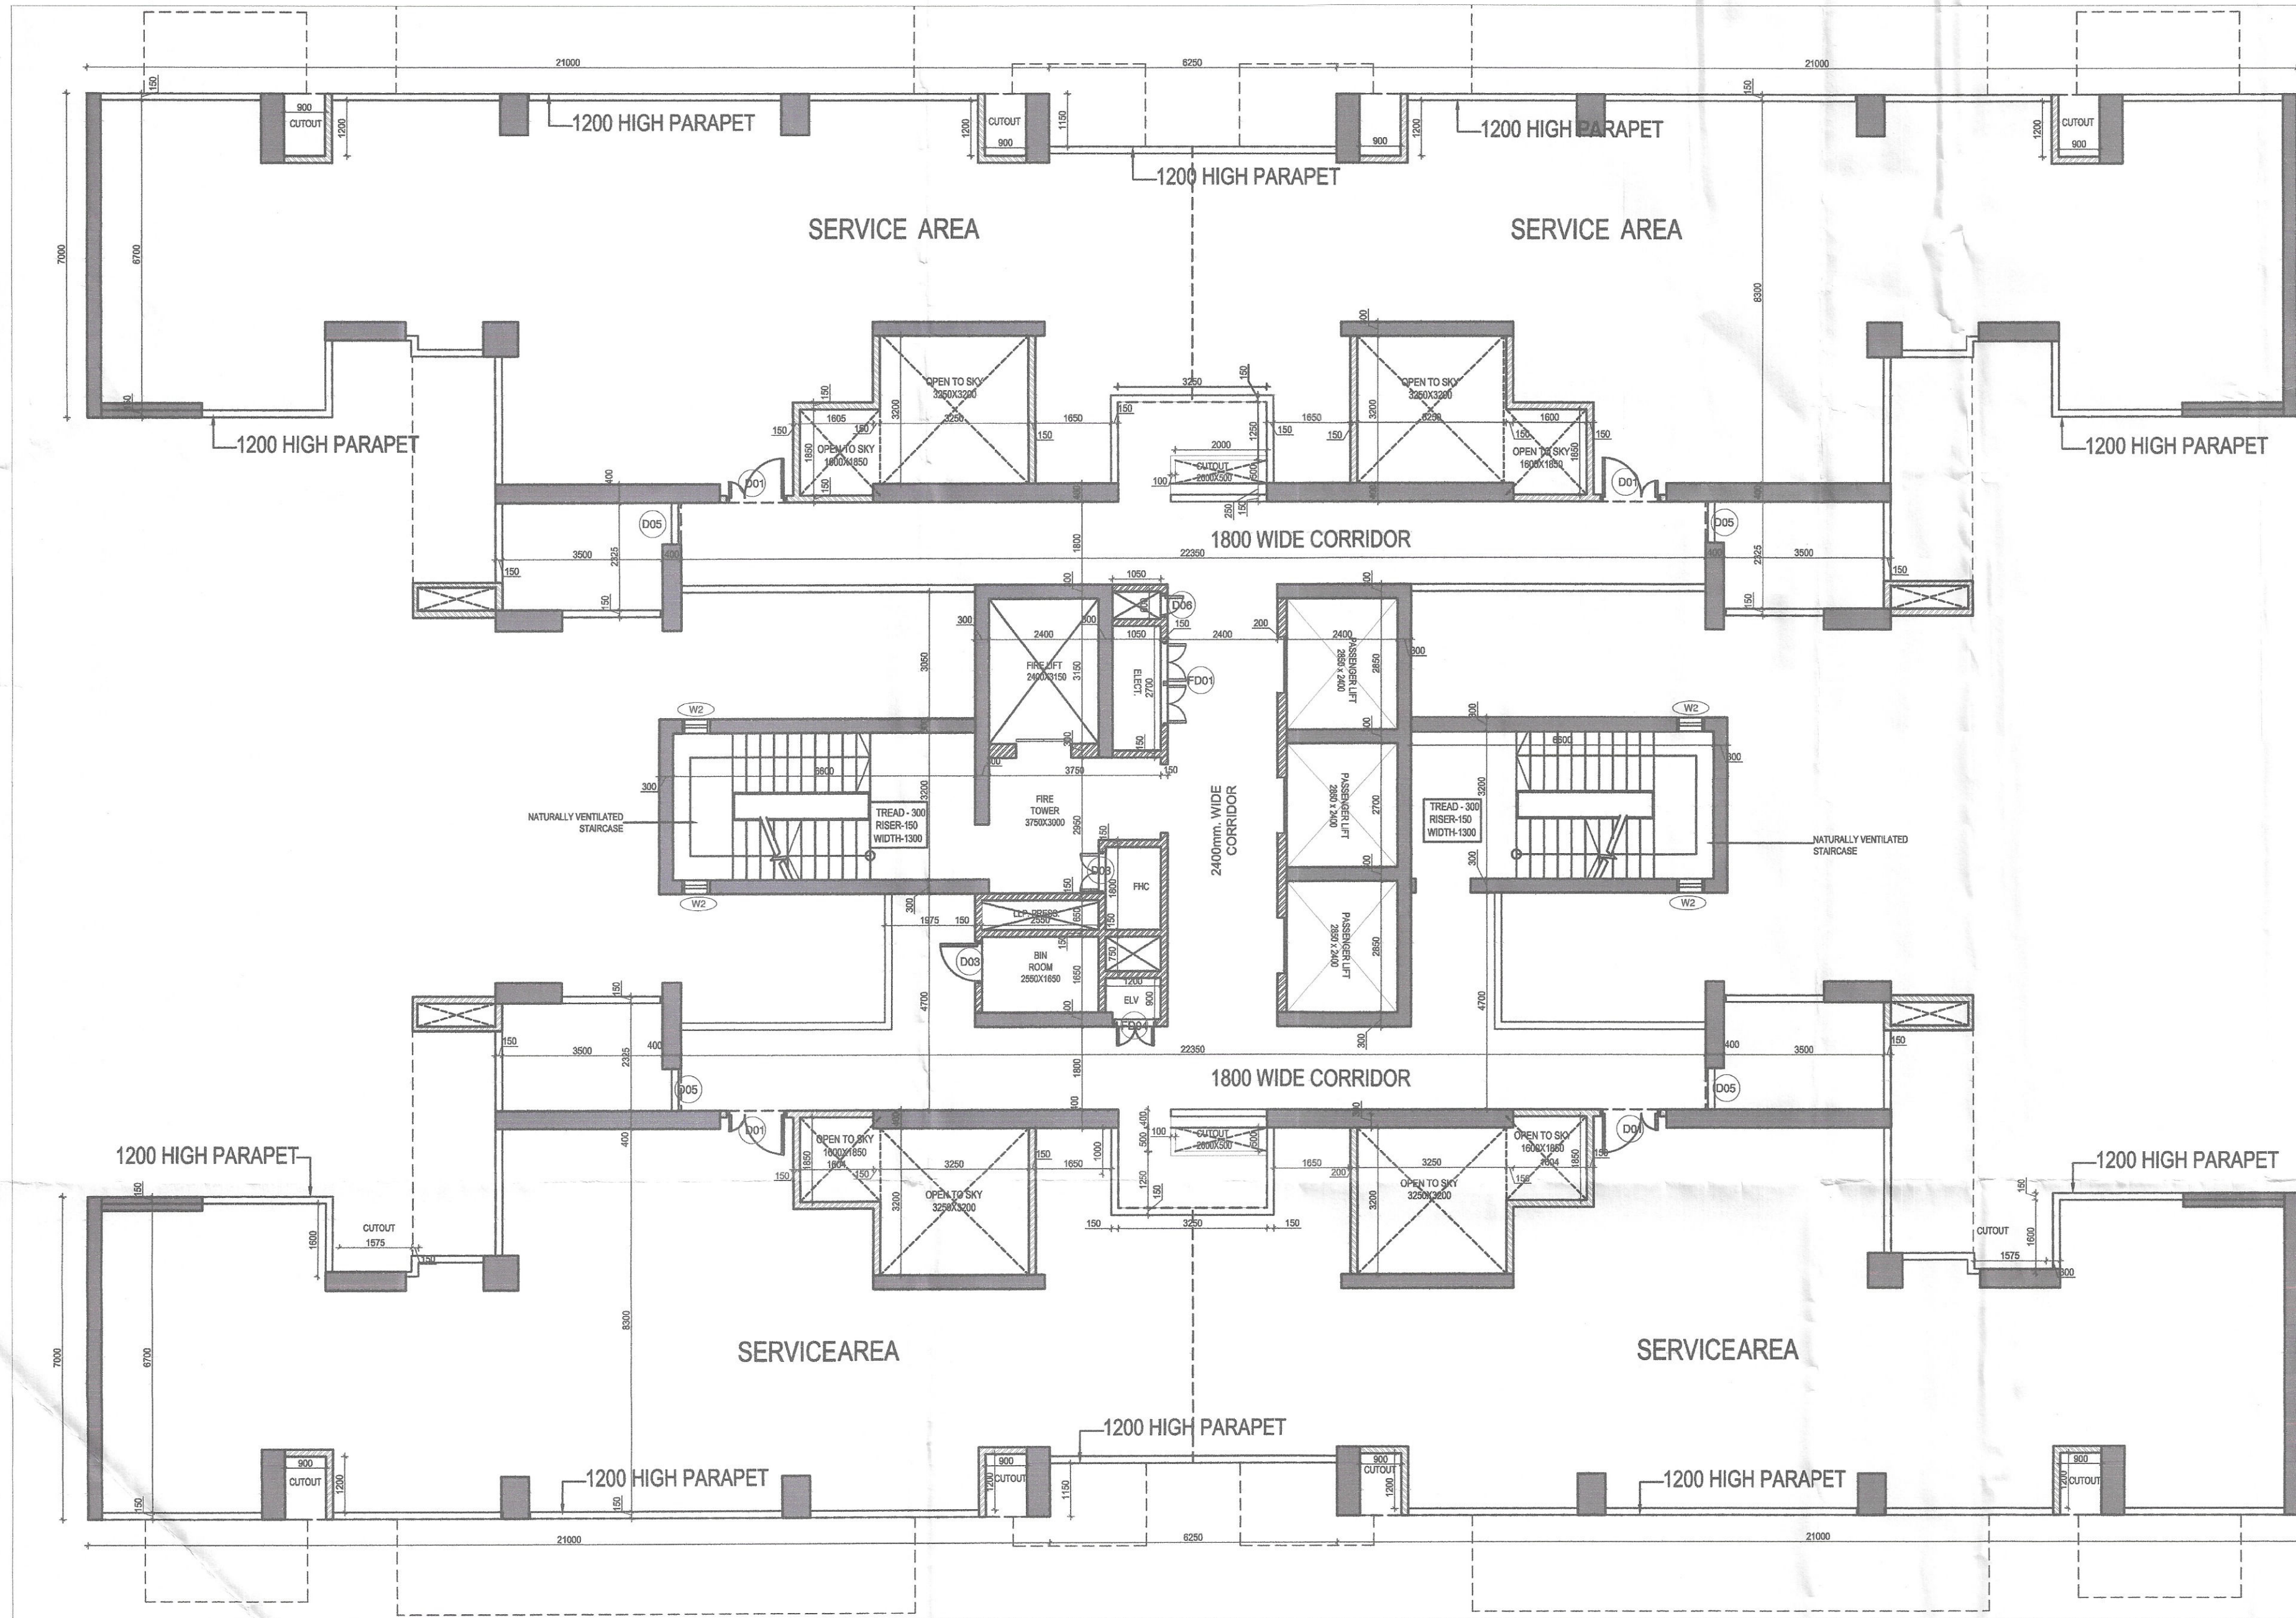

1 SERVICE FLOOR PLAN
Scale: 1:100

LEGEND

- SOIL WASTE PIPE
- WASTE WATER PIPE
- BALCONY DRAIN PIPE

LEGEND

SYMBOL	DESCRIPTION
①	110 OD SOIL AND VENT PIPE
②	110 OD WASTE AND VENT PIPE
③	110 OD KITCHEN WASTE AND VENT PIPE
④	75Ø ANTISYPHONAGE PIPE
⑤	DOMESTIC WATER SUPPLY DN. TAKE PIPE
⑥	DOMESTIC WATER SUPPLY DN. TAKE PIPE FOR TOP FIVE FLOORS (PRESSURE SUPPLY)
⑦	DOMESTIC WATER SUPPLY DN. TAKE PIPE
⑧	FLUSHING WATER SUPPLY DN. TAKE PIPE
⑨	FLUSHING WATER SUPPLY DN. TAKE PIPE
⑩	FLUSHING WATER SUPPLY DN. TAKE PIPE
⑪	FLUSHING WATER SUPPLY DN. TAKE PIPE
⑫	160 OD uPVC TERRACE RAIN WATER PIPE
⑬	75Ø uPVC RAIN WATER PIPE (BALCONY)
⑭	DOMESTIC WATER SUPPLY RISER
⑮	FLUSHING WATER SUPPLY RISER
FD	FLOOR DRAIN
FT	FLOOR TRAP
LEDGE WALL	LEDGE WALL
CUTOUT IN FLOOR	CUTOUT IN FLOOR

Checked and found ok for Public Health
(Internal) Service only subject to comments in
in forwarding letter No. 258394.DV.24/11/23

Superintending Engineer (HQ)
for Chief Engineer
HSVA

DOOR - WINDOW SCHEDULE - TOWER

INTERNAL DOORS

DOOR TAG	WIDTH	HEIGHT	CILL	LINTEL	FIRE RATED (HRS.)
D01	1300	2100	±00	2100	1HR
D02	1000	2100	±00	2100	
D03	900	2100	±00	2100	2HRS
D04	800	2100	±00	2100	1HR
D05	750	2100	±00	2100	
D06	500	2100	±00	2100	
FD01	1800	2100	±00	2100	2HRS
FD02	1500	2100	100	2100	2HRS
FD03	1200	2100	100	2100	2HRS
FD04	900	2100	±00	2100	2HRS

EXTERNAL DOORS

DW01	5000	2350	100	2450	
DW03	2250	2350	100	2450	
DW04	2200	2350	±00	2450	
DW05	2000	2350	±00	2450	

WINDOWS

W0	750	1300	1200	2450	
W01	600	1300	1200	2450	
W02	600	1350	150	1500	
W03	1950	1300	100	2450	

Sign & Stamp

DTP (HQ) S.T.P (HQ) S.T.P (G) S.T.P (Hr.)
Member Secretary Member Chairman
B.P.A.C. B.P.A.C. B.P.A.C.

Consultant Architect DTP (HQ)
(Dinesh Kumar) PA(HQ)

SANCTIONED
TO BE READ WITH THIS OFFICE
MEMO NO.:
DATED:

WALL LEGEND

- R.C.C LOAD BEARING WALL / COLUMN
- R.C.C NON LOAD BEARING WALL
- BLOCK WALL



DESIGN FORUM
INTERNATIONAL
ARCHITECTURE • URBAN DESIGN • TOWN PLANNING

K-47, KATLASH COLONY NEW DELHI-48
PHONE: 011 - 46556600 FAX : 46556601

PROJECT NAME & ADDRESS

PROPOSED GROUP HOUSING DEVELOPMENT AT
VILLAGE GADAUJI KALAN, SECTOR 37 D GURUGRAM
BEING DEVELOPED BY SIGNATURE GLOBAL BUSSINESS
PARK PVT. LTD. AT SECTOR - 37 D, AREA - 16.65625
ACRE. LICENCE NO. -230 OF 2023 DATED 02/11/2023

CLIENT NAME & ADDRESS

SIGNATURE GLOBAL BUSSINESS PARK PVT. LTD.
114, SECTOR-44, GURUGRAM HARYANA- 122002

ARCHITECT'S SIGN & STAMP

CLIENT'S SIGN & STAMP

MANISH KUMAR
CA/2008/42027

Signature Global Business Park Pvt. Ltd.

DRAWING TITLE

SERVICE FLOOR PLAN
TOWER -05 & 08

SCALE 1:100 ON A1
DATE 18.11.2023
DRAWING NO. T5-01
NORTH