


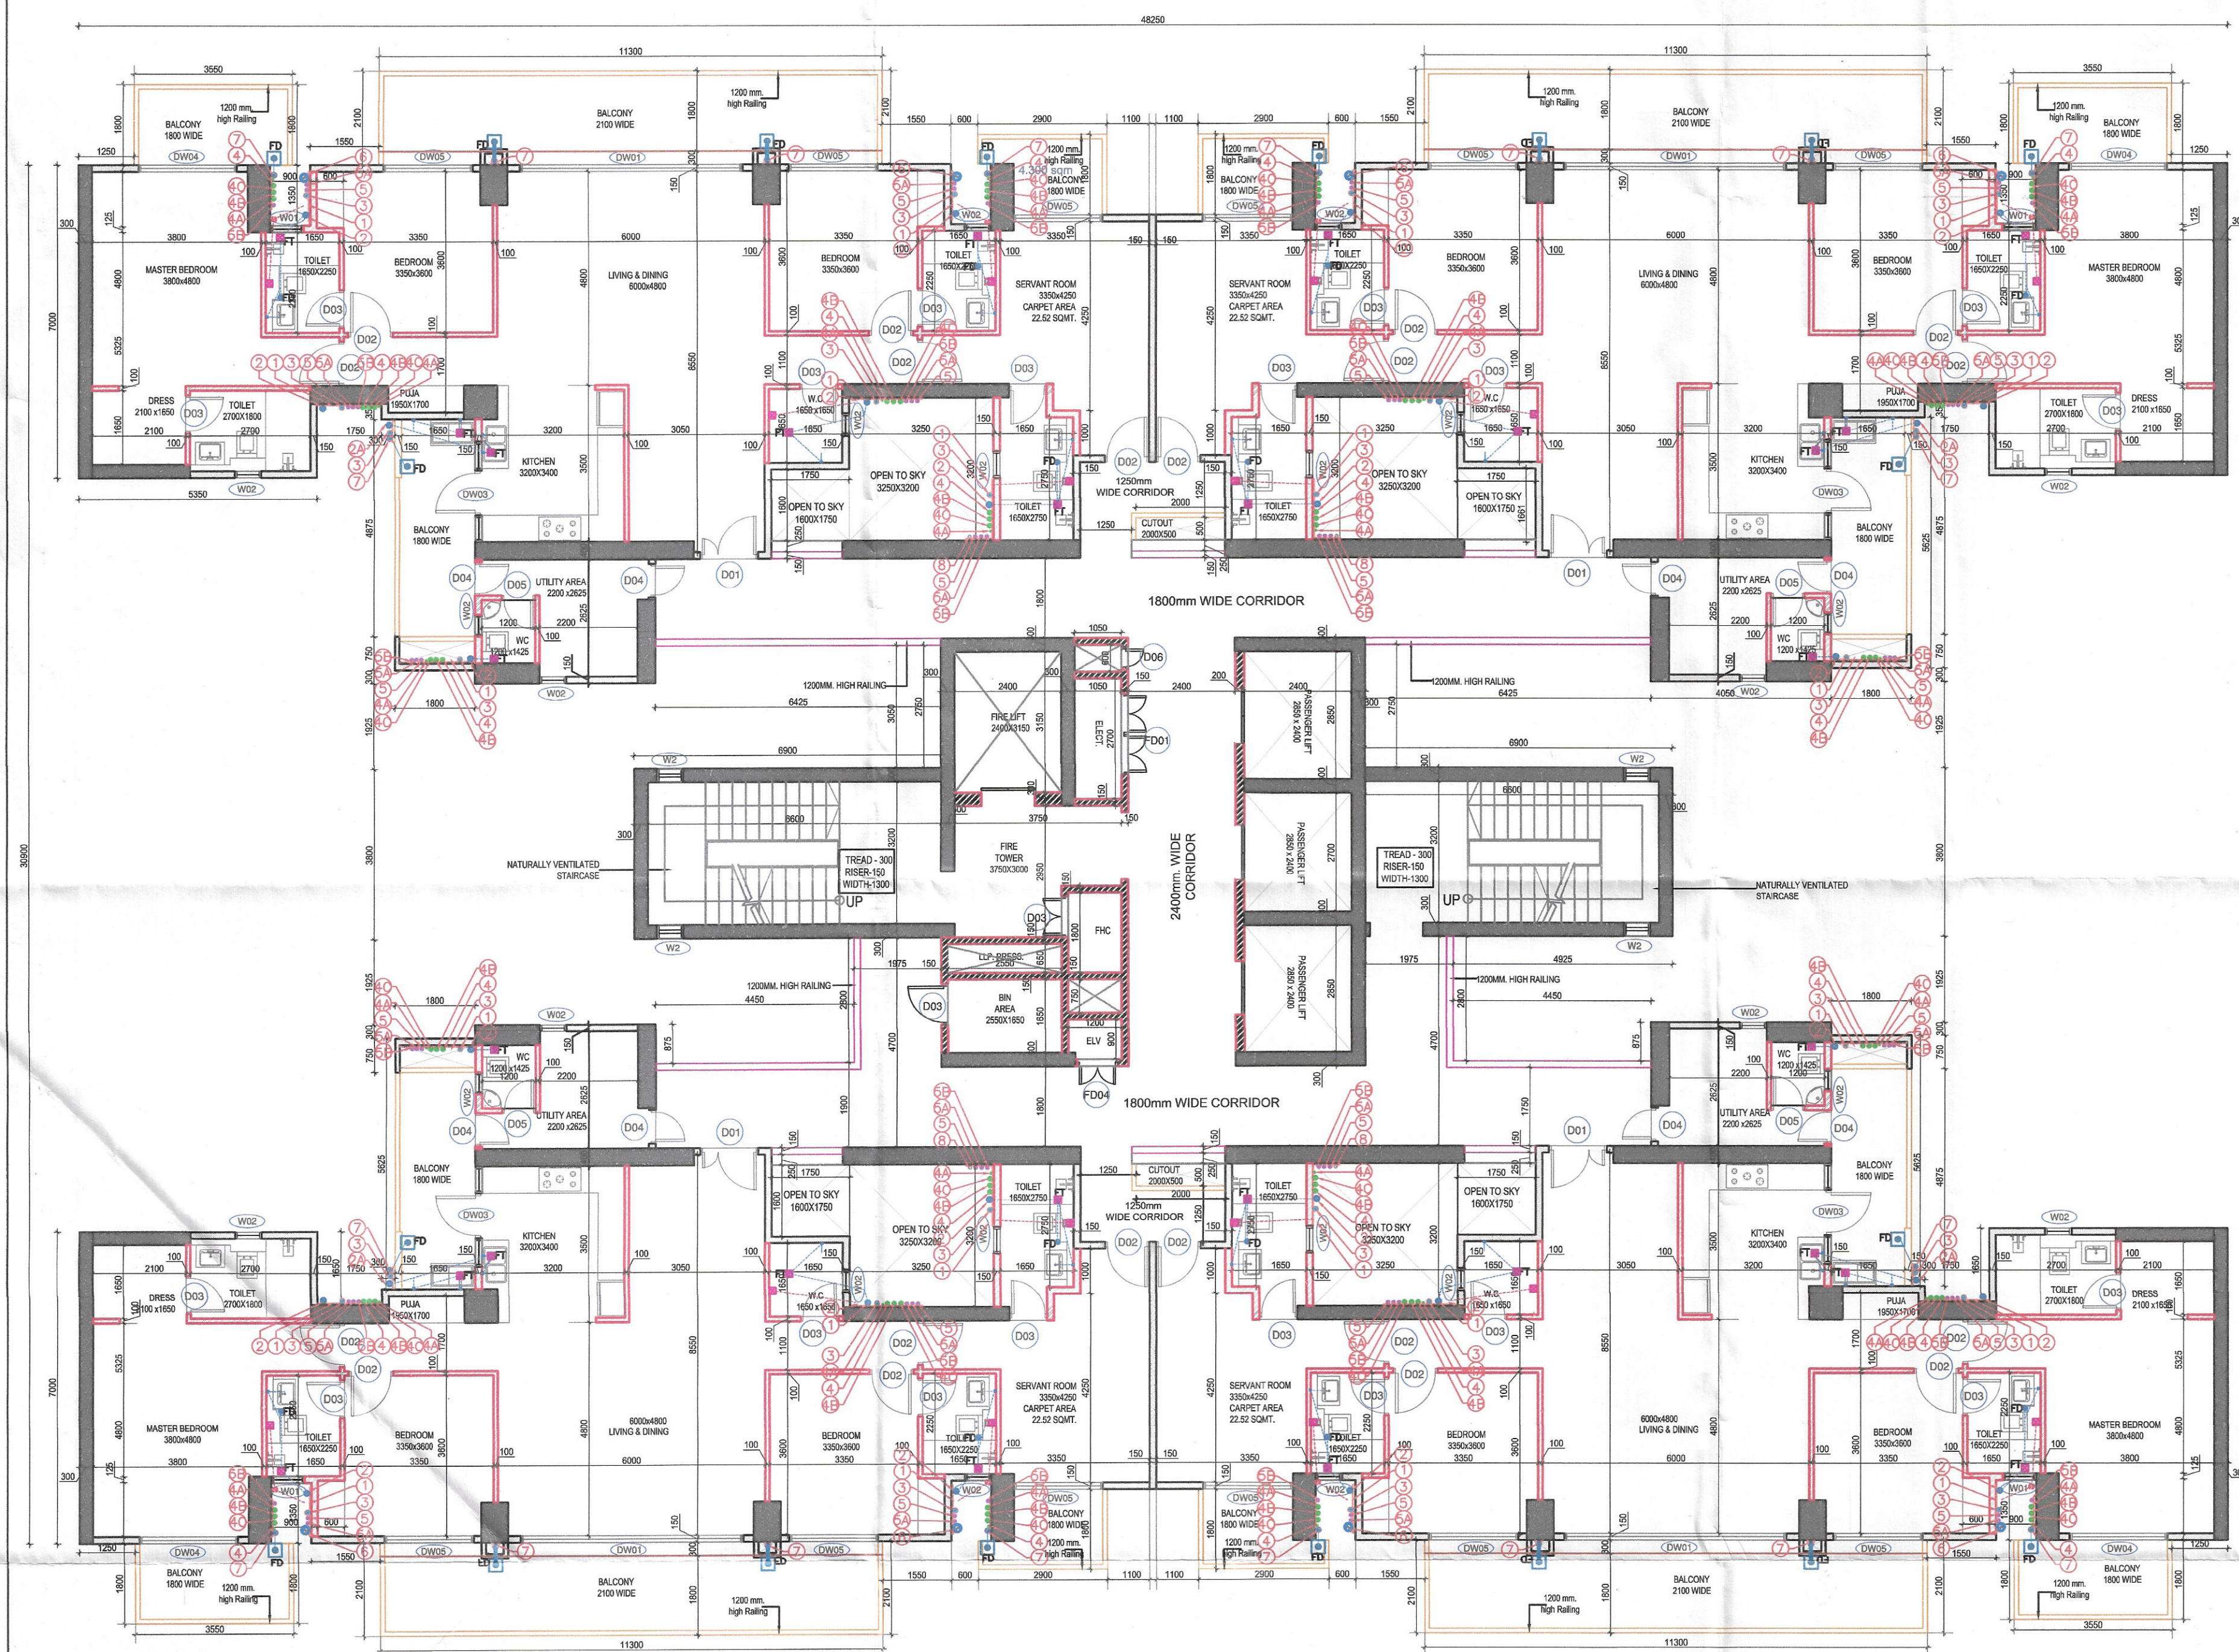

- 1
- TOWER-05 TYPICAL FLOOR PLAN (FROM TYPICAL 2ND TO 14TH ,16TH TO 23RD & 25TH TO 32ND & 34TH TO 38TH)
Scale: 1:100
- 2
- TOWER-08 TYPICAL FLOOR PLAN (FROM TYPICAL 2ND TO 14TH ,16TH TO 23RD & 25TH TO 31st)
Scale: 1:100

Checked and found ok for Public Health
(Internal) Service only subject to comments in
in forwarding letter No. 25234...DW.24/11/23

Superintending Engineer (HQ)
for Chief Engineer-I
HSVP, Panchkula

DOOR - WINDOW SCHEDULE- TOWER					
INTERNAL DOORS					
DOOR TAG	LEVEL (FROM FFL)				
	WIDTH	HEIGHT	CILL	LINTEL	FIRE RATED (HRS.)
D01	1300	2100	±00	2100	1HR
D02	1000	2100	±00	2100	
D03	900	2100	±00	2100	2HRS
D04	800	2100	±00	2100	1HR
D05	750	2100	±00	2100	
D06	500	2100	±00	2100	
FD01	1800	2100	±00	2100	2HRS
FD02	1500	2100	100	2100	2HRS
FD03	1200	2100	100	2100	2HRS
FD04	900	2100	±00	2100	2HRS
EXTERNAL DOORS					
DW01	5000	2350	100	2450	
DW03	2250	2350	100	2450	
DW04	2200	2350	±00	2450	
DW05	2000	2350	±00	2450	
WINDOWS					
W0	750	1300	1200	2450	
W01	600	1300	1200	2450	
W02	600	1350	150	1500	
W03	1950	1300	100	2450	

WALL LEGEND

R.C.C LOAD BEARING WALL / COLUMN

R.C.C NON LOAD BEARING WALL

BLOCK WALL

43

43

Sign & Stamp

DTP (HQ)

S.T.P (HQ)
Member Secretary
B.P.A.C.

S.T.P (G)
Member
B.P.A.C.

CHAIR (Hr.)
Chairman
B.P.A.C.

Consultant
Architect

DTP (HQ)

NOTE:- ALL TOILETS ARE MECHANICALLY
VENTILATED WITH 100% POWER BACKUP
(Dinesh Kumar)
PA(HQ)

LEGEND

SYMBOL

DESCRIPTION

1

110 OD SOIL AND VENT PIPE

2

110 OD WASTE AND VENT PIPE

3

110 OD KITCHEN WASTE AND VENT PIPE

4

75# ANTISYPHONAGE PIPE

5

DOMESTIC WATER SUPPLY DN. TAKE PIPE

6

DOMESTIC WATER SUPPLY DN. TAKE PIPE FOR
TOP FIVE FLOORS (PRESSURE SUPPLY)

7

DOMESTIC WATER SUPPLY DN. TAKE PIPE

8

DOMESTIC WATER SUPPLY DN. TAKE PIPE

9

FLUSHING WATER SUPPLY DN. TAKE PIPE

10

FLUSHING WATER SUPPLY DN. TAKE PIPE

11

160 OD UPVC TERRACE RAIN WATER PIPE

12

75# UPVC RAIN WATER PIPE (BALCONY)

13

DOMESTIC WATER SUPPLY RISER

14

FLUSHING WATER SUPPLY RISER

FD

FLOOR DRAIN

FT

FLOOR TRAP

EDGE WALL

■

CUTOUT IN FLOOR

LEGEND

SOIL WASTE PIPE

WASTE WATER PIPE

BALCONY DRAIN PIPE

REFUGE FLOOR LEVELS

14TH FLOOR LEVEL : +61.76 MT.

DESIGN FORUM
INTERNATIONAL
ARCHITECTURE • URBAN DESIGN • TOWN PLANNING
K-47, KAILASH COLONY NEW DELHI-48
PHONE: 011 - 46556600 FAX : 46556601
PROJECT NAME & ADDRESS
PROPOSED GROUP HOUSING DEVELOPMENT AT
VILLAGE GADAUJI KALAN, SECTOR 37 D GURUGRAM
BEING DEVELOPED BY SIGNATURE GLOBAL BUSSINESS
PARK PVT. LTD. AT SECTOR - 37 D, AREA - 16.65625
ACRE. LICENCE NO. -230 OF 2023 DATED 02/11/2023
CLIENT NAME & ADDRESS
SIGNATURE GLOBAL BUSSINESS PARK PVT. LTD.
114, SECTOR-44, GURUGRAM HARYANA- 122002
ARCHITECT'S SIGN & STAMP
CLIENT'S SIGN & STAMP
DRAWING TITLE
TOWER-05 & 08
TYPICAL FLOOR PLAN
SCALE
1:100 ON A1
DATE
07.10.2023
DRAWING NO.
T5-02
NORTH