


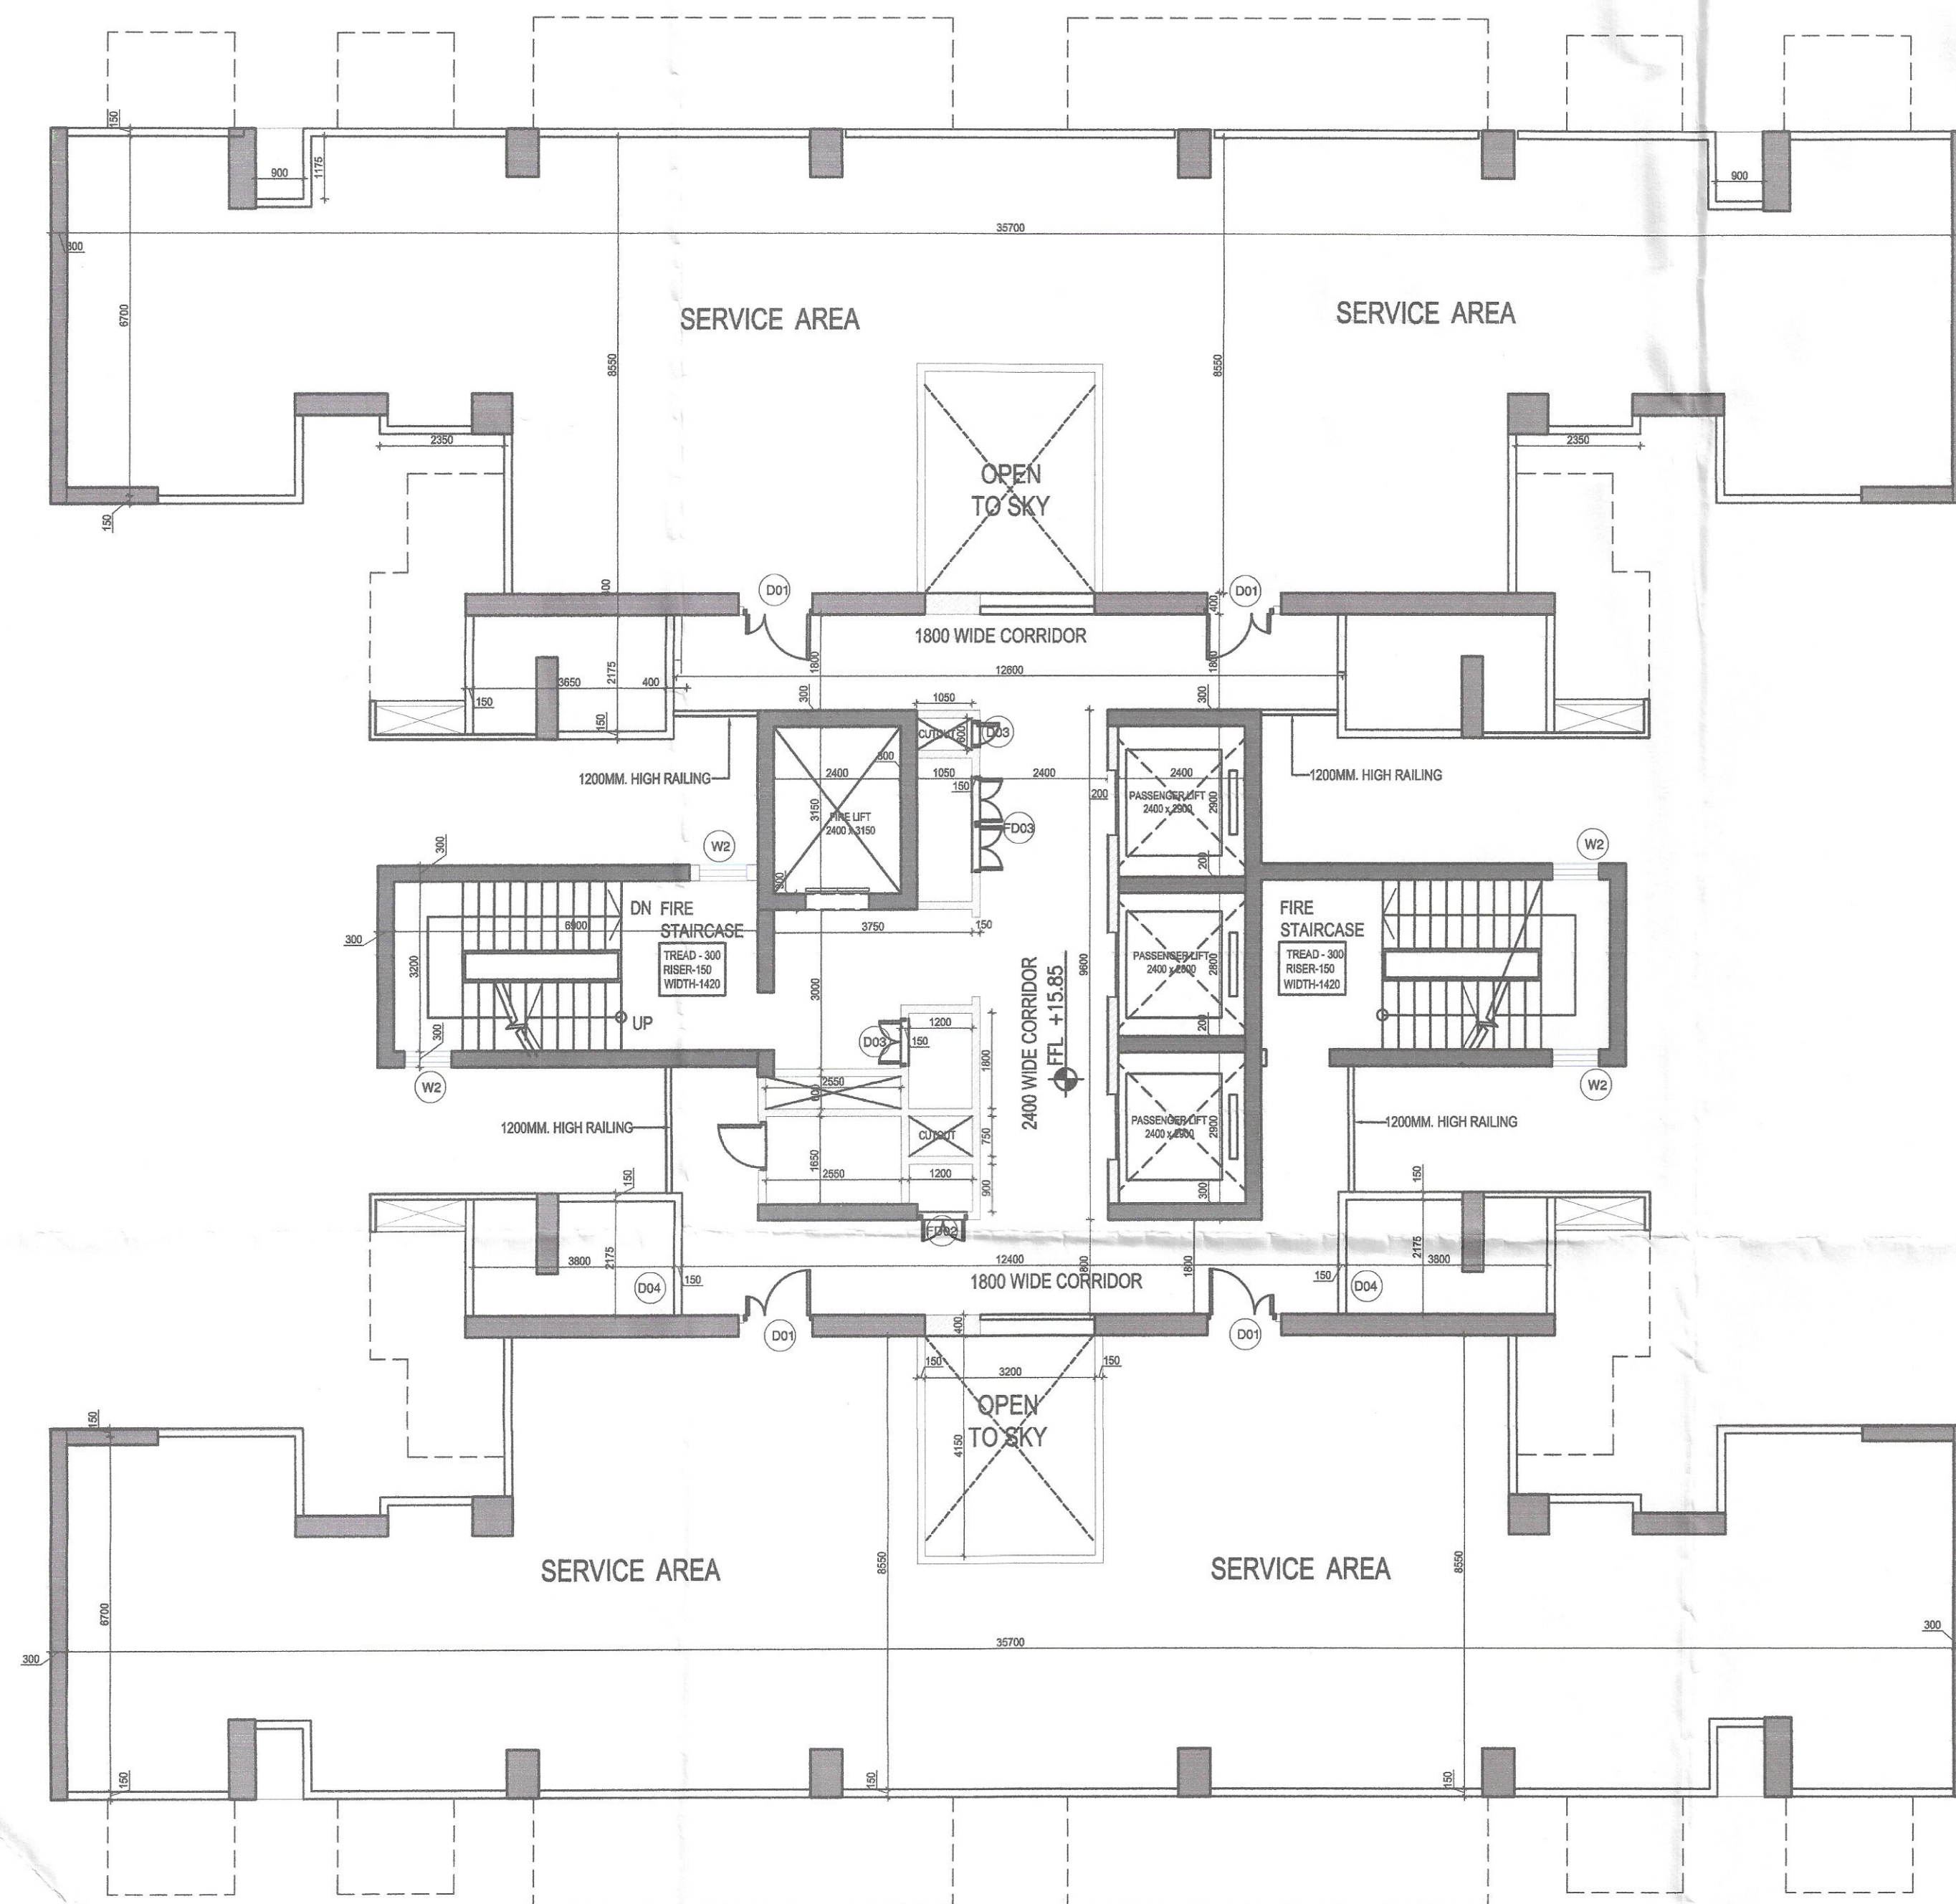

1 SERVICE FLOOR PLAN
Scale: 1:100

DOOR - WINDOW SCHEDULE- TOWER

INTERNAL DOORS

SANCTIONED
TO BE READ WITH THIS OFFICE
MEMO NO.:
DATED:

DOOR TAG	LEVEL (FROM FFL.)				FIRE RATED (HRS.)
	WIDTH	HEIGHT	CILL	LINTEL	
D01	1300	2100	±00	2100	1HR
D02	1000	2100	±00	2100	
D03	900	2100	±00	2100	2HRS
D04	800	2100	±00	2100	1HR
D05	750	2100	±00	2100	
D06	500	2100	±00	2100	
FD01	1800	2100	±00	2100	2HRS
FD02	1500	2100	100	2100	2HRS
FD03	1200	2100	100	2100	2HRS
FD04	900	2100	±00	2100	2HRS

EXTERNAL DOORS

DW01	5000	2350	100	2450	
DW03	2250	2350	100	2450	
DW04	2200	2350	±00	2450	
DW05	2000	2350	±00	2450	

WINDOWS

W0	750	1300	1200	2450	
W01	600	1300	1200	2450	
W02	600	1350	150	1500	
W03	1950	1300	100	2450	

WALL LEGEND

- R.C.C LOAD BEARING WALL / COLUMN
- R.C.C NON LOAD BEARING WALL
- BLOCK WALL

Checked and found ok for Public Health
(Internal) Service only subject to comments in
in forwarding letter No. 23394/24/11/23

Superintending Engineer (HQ)
for Chief Engineer-I
HSVP, Panchkula

53

DTP (HQ) S.T.P (HQ) S.T.P (G) S.T.P (Pr.)
Member Secretary Member Chairman
B.P.A.C. B.P.A.C. B.P.A.C.

Consultant
Architect
AD PA

DTP (HQ)
(Dinesh Kumar) PA (HQ)

SYMBOL	DESCRIPTION
①	110 OD SOIL AND VENT PIPE
②	110 OD WASTE AND VENT PIPE
③	110 OD KITCHEN WASTE AND VENT PIPE
④	75# ANTISYPHONAGE PIPE
⑤	DOMESTIC WATER SUPPLY DN. TAKE PIPE
⑥	DOMESTIC WATER SUPPLY DN. TAKE PIPE FOR TOP FIVE FLOORS (PRESSURE SUPPLY)
⑦	DOMESTIC WATER SUPPLY DN. TAKE PIPE
⑧	DOMESTIC WATER SUPPLY DN. TAKE PIPE
⑨	FLUSHING WATER SUPPLY DN. TAKE PIPE
⑩	FLUSHING WATER SUPPLY DN. TAKE PIPE
⑪	FLUSHING WATER SUPPLY DN. TAKE PIPE
⑫	160 OD uPVC TERRACE RAIN WATER PIPE
⑬	75# uPVC RAIN WATER PIPE (BALCONY)
⑭	DOMESTIC WATER SUPPLY RISER
⑮	FLUSHING WATER SUPPLY RISER
FD	FLOOR DRAIN
FT	FLOOR TRAP
---	LEDGE WALL
■	CUTOUT IN FLOOR

LEGEND	
---	SOIL WASTE PIPE
---	WASTE WATER PIPE
---	BALCONY DRAIN PIPE

DESIGN FORUM INTERNATIONAL
ARCHITECTURE • URBAN DESIGN • TOWN PLANNING

K-47, KAILASH COLONY NEW DELHI-48
PHONE: 011 - 46556600 FAX: 46556601
PROJECT NAME & ADDRESS

PROPOSED GROUP HOUSING DEVELOPMENT AT VILLAGE GADALI KALAN, SECTOR 37 D GURUGRAM BEING DEVELOPED BY SIGNATURE GLOBAL BUSSINESS PARK PVT. LTD. AT SECTOR - 37 D, AREA - 16.65625 ACRE. LICENCE NO. - 230 OF DATED 02/11/2023

CLIENT NAME & ADDRESS

SIGNATURE GLOBAL BUSSINESS PARK PVT. LTD.
114, SECTOR-44, GURUGRAM HARYANA- 122002

ARCHITECT'S SIGN & STAMP CLIENT'S SIGN & STAMP

MANISH KUMAR
CA/2008/42027

Signature Global Business Park Pvt. Ltd.

DRAWING TITLE	SCALE 1:100 ON A1	DRAWING NO.	NORTH
SERVICE FLOOR PLAN	NTS.	T2-01	↑
DATE	18-11-2023		