


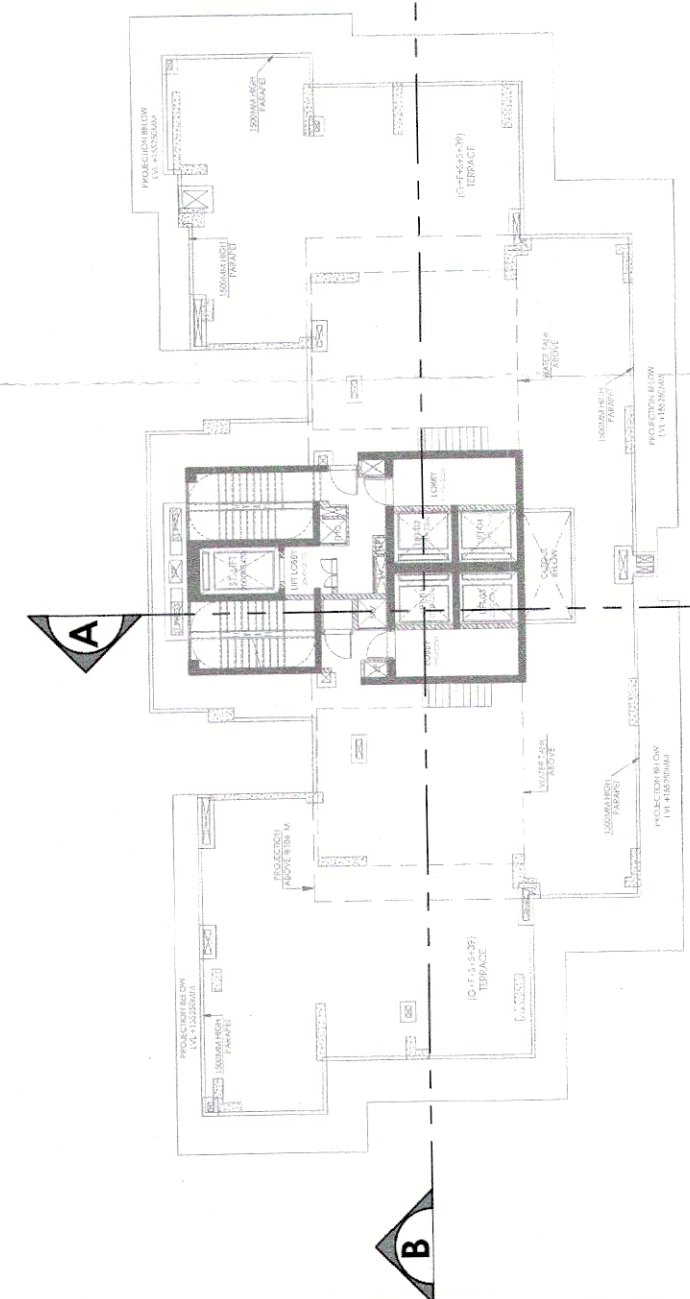

KEY PLAN

1. VRF system is being provided.
2. Full DDC power back up is being provided.
3. Toilet are mechanical exhaust.
4. All lifts shall have 100% power back-up.
5. All electrical installations shall be as per provision of nbc.
6. Fire Fighting/safety provisions will be as per relevant nbc provisions.
7. Basement area shall have mechanically ventilated as per relevant code.
8. All toilets are ventilated as per maharaja building code 2017.
9. Building has automatic sprinkler system wherever required by nbc.
10. Building will be designed (structures) as per relevant code and earthquake resistance.
11. Solar panels of required capacity shall be provided on roof top as per hared/tazoning norms.
12. All handpump pumps with holding tank.
13. As/ds/have 1 hour fire rated entrance door.
14. All fire fighting installations shall be as per provision of nbc.
15. The rainwater harvesting system shall be provided as per central ground water quality norms.

ORACLES
LANDSCAPE DESIGN, PLANNING &
CONSERVATION
G 98, Kalkaji, New Delhi 110 019
+91 11 2648 1630 | +91 9560005480

Email: suneet@oracleslandscape.in
Web: www.oracleslandscape.in/oracles-profile.pdf

STRUCTURAL CONSULTANT :

 **PERCEPTIVE IDEAS**
CONSULTING ENGINEERS
C-486, GROUND FLOOR,
C.R. PARK, NEW DELHI - 110019
P:011-40455638/39 E:info@perceptiveideas.org
PERCEPTIVE IDEAS CONSULTING ENGINEERS PVT. LTD.

MEP:
PARADISE CONSULTANTS
PLOT NO. 129, POCKET-2, BASEMENT
JASOLA VIHAR, NEW DELHI-110025
PH : 011- 46132800, 41030619
E-mail: mep@paradiseconsultants.com

ARCHITECTS: **ARCO**
Arcop Associates Pvt. Ltd.
Plot- 36b, Sec-32, Gurgaon-122001
Ph: 26242050, 26242169

PROJECT TITLE:
PROPOSED BUILDING PLANS OF GROUP
HOUSING COLONY OVER AN AREA
MEASURING 4.5875 ACRES(LICENCE NO.75 OF
2022 DATED 15.06.2022) FALLING IN THE
REVENUE ESTATE OF VILLAGE, GWAL PAHARI,
SECTOR-2, GWAL PAHARI, GURUGRAM BEING
DEVELOPED BY KVELL INFRASTRUCTURE LLP.

ARCHITECT'S SIGNATURE
Ashu, Architect
Council of Architecture
Registration No.: CA/2007/40332

CLIENT'S SIGNATURE
KVELL INFRASTRUCTURE LLP
John Aron
Auth. Sign./Designated Partner

DRAWING TITLE
TOWER SECTION BB'

Job No.	Drawing No.	
Drawn RISHIKA	Checked ASHU	GP-AR-S-202
Date 29-08-2023	Scale 1:250	Revisions

[illegible]

DDT/HQ
Member
BPAC