

SANCTIONED
TO BE READ WITH THIS OFFICE
MEMO NO.: ZP-1835/JD(RA)/2024/1287
DATED: 11.01.2024

S.T.P(HQ) S.T.P(G) C.T(Hr.)
Member Member Chairman
B.P.A.C. B.P.A.C. B.P.A.C.

Consultant Architect
ATP(HQ)

JD. PA. A.T.P.

Block 1
Ram Arka Base
JD(HQ)

KEY PLAN

- NOTES:-
1. VEV System is being provided.
 2. Full DG power back up is being provided.
 3. Toilets are mechanical ventilated.
 4. All lifts shall have 100% power back-up.
 5. All electrical installations shall be as per provision of NBC.
 6. Fire-lighting/safety provisions will be as per relevant NBC provisions.
 7. Basement area shall have mechanically ventilated as per relevant code.
 8. All toilets are ventilated as per Haryana building code 2017.
 9. Building has automatic fire alarm system wherever required by NBC.
 10. Building will be designed (structures) as per relevant IS codes for earthquake resistance.
 11. Solar panels of required capacity shall be provided on roof top as per hareda/zoning norms.
 12. All handicap ramps with railing.
 13. All a/s have 1 hour fire rated entrance door.
 14. All fire fighting installations shall be as per provision of NBC.
 15. The rainwater harvesting system shall be provided as per central ground water auth. norms.

LANDSCAPE:
ORACLES
LANDSCAPE DESIGN, PLANNING & CONSERVATION
G-18, Kirti, New Delhi 110 019
+91 11 2648 1630 +91 9560005480
Email: sunee@oracleslandscape.in
Web: www.oracleslandscape.in/oracles-profile.pdf

STRUCTURAL CONSULTANT:
PERCEPTIVE IDEAS
CONSULTING ENGINEERS
C-486, GROUND FLOOR,
C.R. PARK, NEW DELHI - 110019
P:011-4655638/39 E:info@perceptiveideas.org
PERCEPTIVE IDEAS CONSULTING ENGINEERS PVT. LTD.

MEP:
PARADISE CONSULTANTS
Plot No. 12, POCKET-2, BASMENDI
JASOLA VIHAR, NEW DELHI-110025
PH: 011-4613280/1 41030419
E-mail: mep@paradiseconsultants.com

ARCHITECTS:
ARCOP
Arcop Associates Pvt. Ltd.
Plot-36b, Sec-32, Gurgaon-122001
Ph: 26240350, 262-2189

PROJECT TITLE
PROPOSED BUILDING PLANS OF GROUP
HOUSING COLONY OVER AN AREA
MEASURING 4.5875 ACRES(LICENCE NO.75 OF
2022 DATED 15.06.2022) FALLING IN THE
REVENUE ESTATE OF VILLAGE, GWAL PAHARI,
SECTOR-2, GWAL PAHARI, GURUGRAM BEING
DEVELOPED BY KVEL INFRASTRUCTURE LLP.


ARCHITECT'S SIGNATURE
Asha, Architect
Council of Architects
Registration No.: CA/2007/10332

CLIENT'S SIGNATURE
KVEL INFRASTRUCTURE LLP
Auth. Sign./Designated Partner

DRAWING TITLE
ELEVATION 4

Job No.	Drawing No.
Drawn RISHIKA	Checked ASHU
Date 29-08-2023	Revisions

ELEVATION-04 (SCALE 1:250)

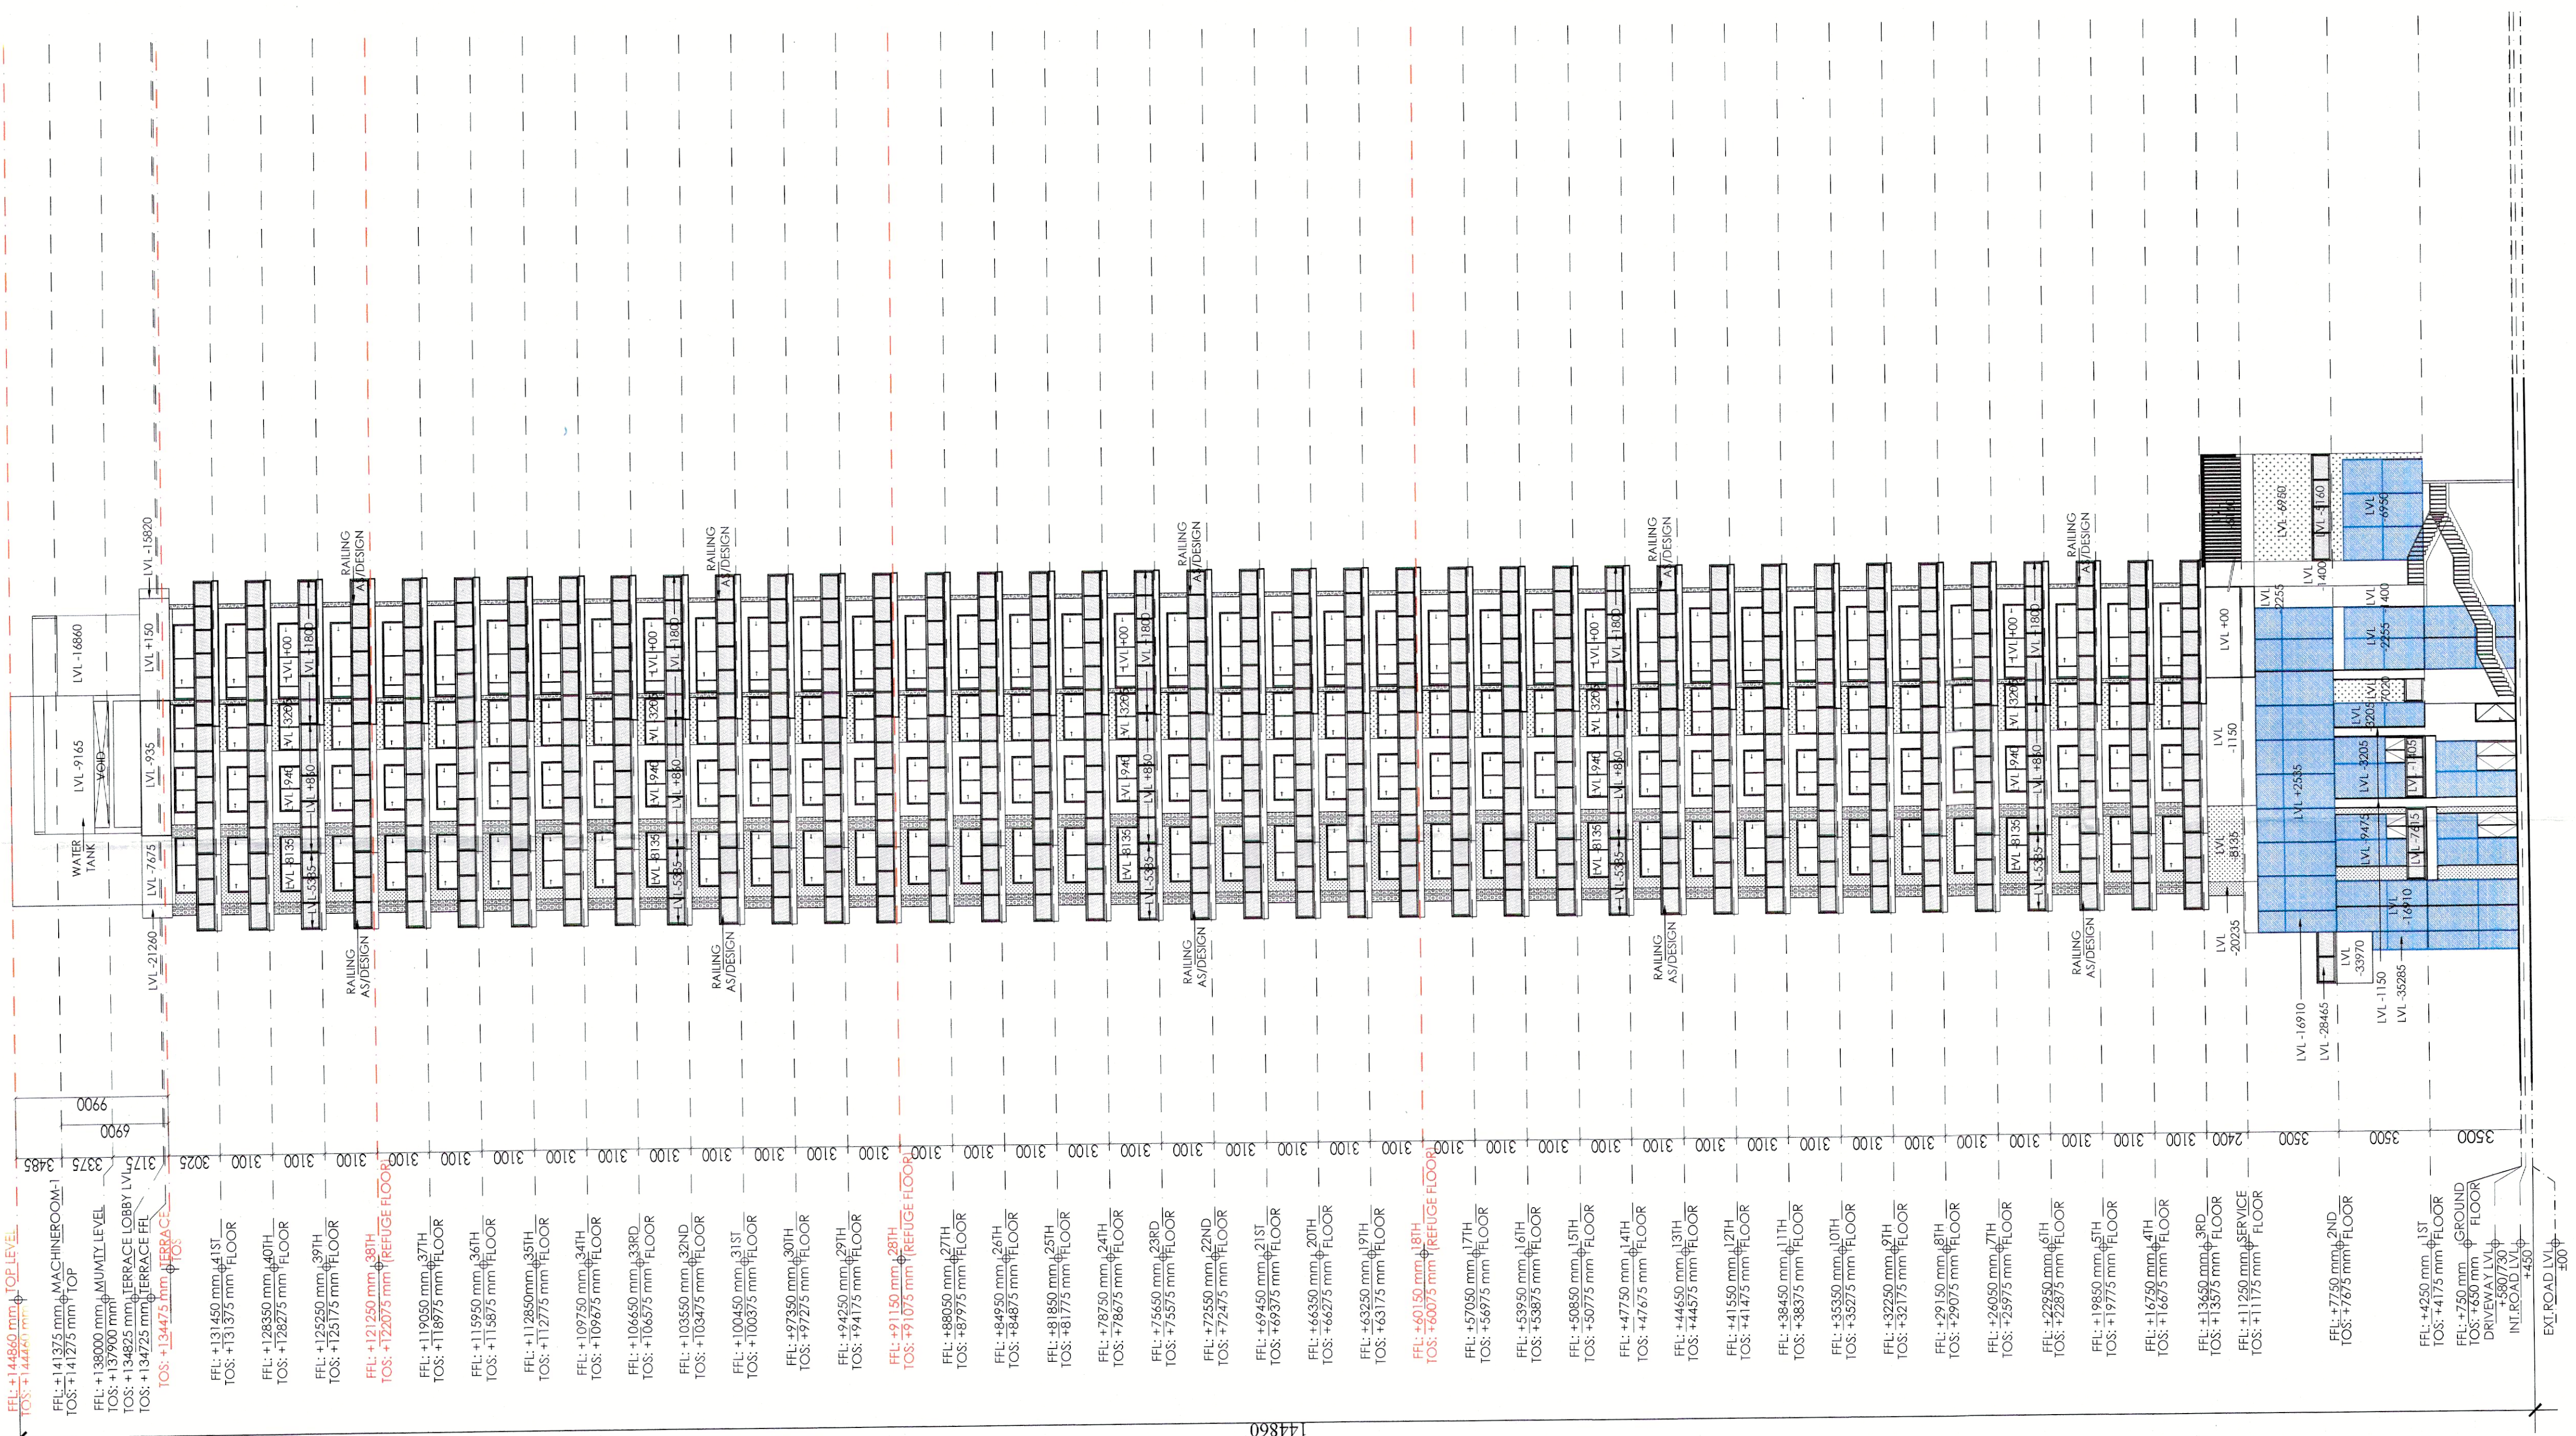

FEL: +14860 mm, 1ST FLOOR
TOS: +14457 mm, 1ST FLOOR
FEL: +14125 mm, 1ST FLOOR
TOS: +14125 mm, 1ST FLOOR
FEL: +13800 mm, 1ST FLOOR
TOS: +13800 mm, 1ST FLOOR
FEL: +13425 mm, 1ST FLOOR
TOS: +13425 mm, 1ST FLOOR
FEL: +13100 mm, 1ST FLOOR
TOS: +13100 mm, 1ST FLOOR
FEL: +12750 mm, 1ST FLOOR
TOS: +12750 mm, 1ST FLOOR
FEL: +12400 mm, 1ST FLOOR
TOS: +12400 mm, 1ST FLOOR
FEL: +12050 mm, 1ST FLOOR
TOS: +12050 mm, 1ST FLOOR
FEL: +11700 mm, 1ST FLOOR
TOS: +11700 mm, 1ST FLOOR
FEL: +11350 mm, 1ST FLOOR
TOS: +11350 mm, 1ST FLOOR
FEL: +11000 mm, 1ST FLOOR
TOS: +11000 mm, 1ST FLOOR
FEL: +10650 mm, 1ST FLOOR
TOS: +10650 mm, 1ST FLOOR
FEL: +10300 mm, 1ST FLOOR
TOS: +10300 mm, 1ST FLOOR
FEL: +9950 mm, 1ST FLOOR
TOS: +9950 mm, 1ST FLOOR
FEL: +9600 mm, 1ST FLOOR
TOS: +9600 mm, 1ST FLOOR
FEL: +9250 mm, 1ST FLOOR
TOS: +9250 mm, 1ST FLOOR
FEL: +8900 mm, 1ST FLOOR
TOS: +8900 mm, 1ST FLOOR
FEL: +8550 mm, 1ST FLOOR
TOS: +8550 mm, 1ST FLOOR
FEL: +8200 mm, 1ST FLOOR
TOS: +8200 mm, 1ST FLOOR
FEL: +7850 mm, 1ST FLOOR
TOS: +7850 mm, 1ST FLOOR
FEL: +7500 mm, 1ST FLOOR
TOS: +7500 mm, 1ST FLOOR
FEL: +7150 mm, 1ST FLOOR
TOS: +7150 mm, 1ST FLOOR
FEL: +6800 mm, 1ST FLOOR
TOS: +6800 mm, 1ST FLOOR
FEL: +6450 mm, 1ST FLOOR
TOS: +6450 mm, 1ST FLOOR
FEL: +6100 mm, 1ST FLOOR
TOS: +6100 mm, 1ST FLOOR
FEL: +5750 mm, 1ST FLOOR
TOS: +5750 mm, 1ST FLOOR
FEL: +5400 mm, 1ST FLOOR
TOS: +5400 mm, 1ST FLOOR
FEL: +5050 mm, 1ST FLOOR
TOS: +5050 mm, 1ST FLOOR
FEL: +4700 mm, 1ST FLOOR
TOS: +4700 mm, 1ST FLOOR
FEL: +4350 mm, 1ST FLOOR
TOS: +4350 mm, 1ST FLOOR
FEL: +4000 mm, 1ST FLOOR
TOS: +4000 mm, 1ST FLOOR
FEL: +3650 mm, 1ST FLOOR
TOS: +3650 mm, 1ST FLOOR
FEL: +3300 mm, 1ST FLOOR
TOS: +3300 mm, 1ST FLOOR
FEL: +2950 mm, 1ST FLOOR
TOS: +2950 mm, 1ST FLOOR
FEL: +2600 mm, 1ST FLOOR
TOS: +2600 mm, 1ST FLOOR
FEL: +2250 mm, 1ST FLOOR
TOS: +2250 mm, 1ST FLOOR
FEL: +1900 mm, 1ST FLOOR
TOS: +1900 mm, 1ST FLOOR
FEL: +1550 mm, 1ST FLOOR
TOS: +1550 mm, 1ST FLOOR
FEL: +1200 mm, 1ST FLOOR
TOS: +1200 mm, 1ST FLOOR
FEL: +850 mm, 1ST FLOOR
TOS: +850 mm, 1ST FLOOR
FEL: +500 mm, 1ST FLOOR
TOS: +500 mm, 1ST FLOOR
FEL: +150 mm, 1ST FLOOR
TOS: +150 mm, 1ST FLOOR
FEL: -200 mm, 1ST FLOOR
TOS: -200 mm, 1ST FLOOR
FEL: -550 mm, 1ST FLOOR
TOS: -550 mm, 1ST FLOOR
FEL: -900 mm, 1ST FLOOR
TOS: -900 mm, 1ST FLOOR
FEL: -1250 mm, 1ST FLOOR
TOS: -1250 mm, 1ST FLOOR
FEL: -1600 mm, 1ST FLOOR
TOS: -1600 mm, 1ST FLOOR
FEL: -1950 mm, 1ST FLOOR
TOS: -1950 mm, 1ST FLOOR
FEL: -2300 mm, 1ST FLOOR
TOS: -2300 mm, 1ST FLOOR
FEL: -2650 mm, 1ST FLOOR
TOS: -2650 mm, 1ST FLOOR
FEL: -3000 mm, 1ST FLOOR
TOS: -3000 mm, 1ST FLOOR
FEL: -3350 mm, 1ST FLOOR
TOS: -3350 mm, 1ST FLOOR
FEL: -3700 mm, 1ST FLOOR
TOS: -3700 mm, 1ST FLOOR
FEL: -4050 mm, 1ST FLOOR
TOS: -4050 mm, 1ST FLOOR
FEL: -4400 mm, 1ST FLOOR
TOS: -4400 mm, 1ST FLOOR
FEL: -4750 mm, 1ST FLOOR
TOS: -4750 mm, 1ST FLOOR
FEL: -5100 mm, 1ST FLOOR
TOS: -5100 mm, 1ST FLOOR
FEL: -5450 mm, 1ST FLOOR
TOS: -5450 mm, 1ST FLOOR
FEL: -5800 mm, 1ST FLOOR
TOS: -5800 mm, 1ST FLOOR
FEL: -6150 mm, 1ST FLOOR
TOS: -6150 mm, 1ST FLOOR
FEL: -6500 mm, 1ST FLOOR
TOS: -6500 mm, 1ST FLOOR
FEL: -6850 mm, 1ST FLOOR
TOS: -6850 mm, 1ST FLOOR
FEL: -7200 mm, 1ST FLOOR
TOS: -7200 mm, 1ST FLOOR
FEL: -7550 mm, 1ST FLOOR
TOS: -7550 mm, 1ST FLOOR
FEL: -7900 mm, 1ST FLOOR
TOS: -7900 mm, 1ST FLOOR
FEL: -8250 mm, 1ST FLOOR
TOS: -8250 mm, 1ST FLOOR
FEL: -8600 mm, 1ST FLOOR
TOS: -8600 mm, 1ST FLOOR
FEL: -8950 mm, 1ST FLOOR
TOS: -8950 mm, 1ST FLOOR
FEL: -9300 mm, 1ST FLOOR
TOS: -9300 mm, 1ST FLOOR
FEL: -9650 mm, 1ST FLOOR
TOS: -9650 mm, 1ST FLOOR
FEL: -10000 mm, 1ST FLOOR
TOS: -10000 mm, 1ST FLOOR
FEL: -10350 mm, 1ST FLOOR
TOS: -10350 mm, 1ST FLOOR
FEL: -10700 mm, 1ST FLOOR
TOS: -10700 mm, 1ST FLOOR
FEL: -11050 mm, 1ST FLOOR
TOS: -11050 mm, 1ST FLOOR
FEL: -11400 mm, 1ST FLOOR
TOS: -11400 mm, 1ST FLOOR
FEL: -11750 mm, 1ST FLOOR
TOS: -11750 mm, 1ST FLOOR
FEL: -12100 mm, 1ST FLOOR
TOS: -12100 mm, 1ST FLOOR
FEL: -12450 mm, 1ST FLOOR
TOS: -12450 mm, 1ST FLOOR
FEL: -12800 mm, 1ST FLOOR
TOS: -12800 mm, 1ST FLOOR
FEL: -13150 mm, 1ST FLOOR
TOS: -13150 mm, 1ST FLOOR
FEL: -13500 mm, 1ST FLOOR
TOS: -13500 mm, 1ST FLOOR
FEL: -13850 mm, 1ST FLOOR
TOS: -13850 mm, 1ST FLOOR
FEL: -14200 mm, 1ST FLOOR
TOS: -14200 mm, 1ST FLOOR
FEL: -14550 mm, 1ST FLOOR
TOS: -14550 mm, 1ST FLOOR
FEL: -14900 mm, 1ST FLOOR
TOS: -14900 mm, 1ST FLOOR
FEL: -15250 mm, 1ST FLOOR
TOS: -15250 mm, 1ST FLOOR
FEL: -15600 mm, 1ST FLOOR
TOS: -15600 mm, 1ST FLOOR
FEL: -15950 mm, 1ST FLOOR
TOS: -15950 mm, 1ST FLOOR
FEL: -16300 mm, 1ST FLOOR
TOS: -16300 mm, 1ST FLOOR
FEL: -16650 mm, 1ST FLOOR
TOS: -16650 mm, 1ST FLOOR
FEL: -17000 mm, 1ST FLOOR
TOS: -17000 mm, 1ST FLOOR
FEL: -17350 mm, 1ST FLOOR
TOS: -17350 mm, 1ST FLOOR
FEL: -17700 mm, 1ST FLOOR
TOS: -17700 mm, 1ST FLOOR
FEL: -18050 mm, 1ST FLOOR
TOS: -18050 mm, 1ST FLOOR
FEL: -18400 mm, 1ST FLOOR
TOS: -18400 mm, 1ST FLOOR
FEL: -18750 mm, 1ST FLOOR
TOS: -18750 mm, 1ST FLOOR
FEL: -19100 mm, 1ST FLOOR
TOS: -19100 mm, 1ST FLOOR
FEL: -19450 mm, 1ST FLOOR
TOS: -19450 mm, 1ST FLOOR
FEL: -19800 mm, 1ST FLOOR
TOS: -19800 mm, 1ST FLOOR
FEL: -20150 mm, 1ST FLOOR
TOS: -20150 mm, 1ST FLOOR
FEL: -20500 mm, 1ST FLOOR
TOS: -20500 mm, 1ST FLOOR
FEL: -20850 mm, 1ST FLOOR
TOS: -20850 mm, 1ST FLOOR
FEL: -21200 mm, 1ST FLOOR
TOS: -21200 mm, 1ST FLOOR
FEL: -21550 mm, 1ST FLOOR
TOS: -21550 mm, 1ST FLOOR
FEL: -21900 mm, 1ST FLOOR
TOS: -21900 mm, 1ST FLOOR
FEL: -22250 mm, 1ST FLOOR
TOS: -22250 mm, 1ST FLOOR
FEL: -22600 mm, 1ST FLOOR
TOS: -22600 mm, 1ST FLOOR
FEL: -22950 mm, 1ST FLOOR
TOS: -22950 mm, 1ST FLOOR
FEL: -23300 mm, 1ST FLOOR
TOS: -23300 mm, 1ST FLOOR
FEL: -23650 mm, 1ST FLOOR
TOS: -23650 mm, 1ST FLOOR
FEL: -24000 mm, 1ST FLOOR
TOS: -24000 mm, 1ST FLOOR
FEL: -24350 mm, 1ST FLOOR
TOS: -24350 mm, 1ST FLOOR
FEL: -24700 mm, 1ST FLOOR
TOS: -24700 mm, 1ST FLOOR
FEL: -25050 mm, 1ST FLOOR
TOS: -25050 mm, 1ST FLOOR
FEL: -25400 mm, 1ST FLOOR
TOS: -25400 mm, 1ST FLOOR
FEL: -25750 mm, 1ST FLOOR
TOS: -25750 mm, 1ST FLOOR
FEL: -26100 mm, 1ST FLOOR
TOS: -26100 mm, 1ST FLOOR
FEL: -26450 mm, 1ST FLOOR
TOS: -26450 mm, 1ST FLOOR
FEL: -26800 mm, 1ST FLOOR
TOS: -26800 mm, 1ST FLOOR
FEL: -27150 mm, 1ST FLOOR
TOS: -27150 mm, 1ST FLOOR
FEL: -27500 mm, 1ST FLOOR
TOS: -27500 mm, 1ST FLOOR
FEL: -27850 mm, 1ST FLOOR
TOS: -27850 mm, 1ST FLOOR
FEL: -28200 mm, 1ST FLOOR
TOS: -28200 mm, 1ST FLOOR
FEL: -28550 mm, 1ST FLOOR
TOS: -28550 mm, 1ST FLOOR
FEL: -28900 mm, 1ST FLOOR
TOS: -28900 mm, 1ST FLOOR
FEL: -29250 mm, 1ST FLOOR
TOS: -29250 mm, 1ST FLOOR
FEL: -29600 mm, 1ST FLOOR
TOS: -29600 mm, 1ST FLOOR
FEL: -29950 mm, 1ST FLOOR
TOS: -29950 mm, 1ST FLOOR
FEL: -30300 mm, 1ST FLOOR
TOS: -30300 mm, 1ST FLOOR
FEL: -30650 mm, 1ST FLOOR
TOS: -30650 mm, 1ST FLOOR
FEL: -31000 mm, 1ST FLOOR
TOS: -31000 mm, 1ST FLOOR
FEL: -31350 mm, 1ST FLOOR
TOS: -31350 mm, 1ST FLOOR
FEL: -31700 mm, 1ST FLOOR
TOS: -31700 mm, 1ST FLOOR
FEL: -32050 mm, 1ST FLOOR
TOS: -32050 mm, 1ST FLOOR
FEL: -32400 mm, 1ST FLOOR
TOS: -32400 mm, 1ST FLOOR
FEL: -32750 mm, 1ST FLOOR
TOS: -32750 mm, 1ST FLOOR
FEL: -33100 mm, 1ST FLOOR
TOS: -33100 mm, 1ST FLOOR
FEL: -33450 mm, 1ST FLOOR
TOS: -33450 mm, 1ST FLOOR
FEL: -33800 mm, 1ST FLOOR
TOS: -33800 mm, 1ST FLOOR
FEL: -34150 mm, 1ST FLOOR
TOS: -34150 mm, 1ST FLOOR
FEL: -34500 mm, 1ST FLOOR
TOS: -34500 mm, 1ST FLOOR
FEL: -34850 mm, 1ST FLOOR
TOS: -34850 mm, 1ST FLOOR
FEL: -35200 mm, 1ST FLOOR
TOS: -35200 mm, 1ST FLOOR
FEL: -35550 mm, 1ST FLOOR
TOS: -35550 mm, 1ST FLOOR
FEL: -35900 mm, 1ST FLOOR
TOS: -35900 mm, 1ST FLOOR
FEL: -36250 mm, 1ST FLOOR
TOS: -36250 mm, 1ST FLOOR
FEL: -36600 mm, 1ST FLOOR
TOS: -36600 mm, 1ST FLOOR
FEL: -36950 mm, 1ST FLOOR
TOS: -36950 mm, 1ST FLOOR
FEL: -37300 mm, 1ST FLOOR
TOS: -37300 mm, 1ST FLOOR
FEL: -37650 mm, 1ST FLOOR
TOS: -37650 mm, 1ST FLOOR
FEL: -38000 mm, 1ST FLOOR
TOS: -38000 mm, 1ST FLOOR
FEL: -38350 mm, 1ST FLOOR
TOS: -38350 mm, 1ST FLOOR
FEL: -38700 mm, 1ST FLOOR
TOS: -38700 mm, 1ST FLOOR
FEL: -39050 mm, 1ST FLOOR
TOS: -39050 mm, 1ST FLOOR
FEL: -39400 mm, 1ST FLOOR
TOS: -39400 mm, 1ST FLOOR
FEL: -39750 mm, 1ST FLOOR
TOS: -39750 mm, 1ST FLOOR
FEL: -40100 mm, 1ST FLOOR
TOS: -40100 mm, 1ST FLOOR
FEL: -40450 mm, 1ST FLOOR
TOS: -40450 mm, 1ST FLOOR
FEL: -40800 mm, 1ST FLOOR
TOS: -40800 mm, 1ST FLOOR
FEL: -41150 mm, 1ST FLOOR
TOS: -41150 mm, 1ST FLOOR
FEL: -41500 mm, 1ST FLOOR
TOS: -41500 mm, 1ST FLOOR
FEL: -41850 mm, 1ST FLOOR
TOS: -41850 mm, 1ST FLOOR
FEL: -42200 mm, 1ST FLOOR
TOS: -42200 mm, 1ST FLOOR
FEL: -42550 mm, 1ST FLOOR
TOS: -42550 mm, 1ST FLOOR
FEL: -42900 mm, 1ST FLOOR
TOS: -42900 mm, 1ST FLOOR
FEL: -43250 mm, 1ST FLOOR
TOS: -43250 mm, 1ST FLOOR
FEL: -43600 mm, 1ST FLOOR
TOS: -43600 mm, 1ST FLOOR
FEL: -43950 mm, 1ST FLOOR
TOS: -43950 mm, 1ST FLOOR
FEL: -44300 mm, 1ST FLOOR
TOS: -44300 mm, 1ST FLOOR
FEL: -44650 mm, 1ST FLOOR
TOS: -44650 mm, 1ST FLOOR
FEL: -45000 mm, 1ST FLOOR
TOS: -45000 mm, 1ST FLOOR
FEL: -45350 mm, 1ST FLOOR
TOS: -45350 mm, 1ST FLOOR
FEL: -45700 mm, 1ST FLOOR
TOS: -45700 mm, 1ST FLOOR
FEL: -46050 mm, 1ST FLOOR
TOS: -46050 mm, 1ST FLOOR
FEL: -46400 mm, 1ST FLOOR
TOS: -46400 mm, 1ST FLOOR
FEL: -46750 mm, 1ST FLOOR
TOS: -46750 mm, 1ST FLOOR
FEL: -47100 mm, 1ST FLOOR
TOS: -47100 mm, 1ST FLOOR
FEL: -47450 mm, 1ST FLOOR
TOS: -47450 mm, 1ST FLOOR
FEL: -47800 mm, 1ST FLOOR
TOS: -47800 mm, 1ST FLOOR
FEL: -48150 mm, 1ST FLOOR
TOS: -48150 mm, 1ST FLOOR
FEL: -48500 mm, 1ST FLOOR
TOS: -48500 mm, 1ST FLOOR
FEL: -48850 mm, 1ST FLOOR
TOS: -48850 mm, 1ST FLOOR
FEL: -49200 mm, 1ST FLOOR
TOS: -49200 mm, 1ST FLOOR
FEL: -49550 mm, 1ST FLOOR
TOS: -49550 mm, 1ST FLOOR
FEL: -49900 mm, 1ST FLOOR
TOS: -49900 mm, 1ST FLOOR
FEL: -50250 mm, 1ST FLOOR
TOS: -50250 mm, 1ST FLOOR
FEL: -50600 mm, 1ST FLOOR
TOS: -50600 mm, 1ST FLOOR
FEL: -50950 mm, 1ST FLOOR
TOS: -50950 mm, 1ST FLOOR
FEL: -51300 mm, 1ST FLOOR
TOS: -51300 mm, 1ST FLOOR
FEL: -51650 mm, 1ST FLOOR
TOS: -51650 mm, 1ST FLOOR
FEL: -52000 mm, 1ST FLOOR
TOS: -52000 mm, 1ST FLOOR
FEL: -52350 mm, 1ST FLOOR
TOS: -52350 mm, 1ST FLOOR
FEL: -52700 mm, 1ST FLOOR
TOS: -52700 mm, 1ST FLOOR
FEL: -53050 mm, 1ST FLOOR
TOS: -53050 mm, 1ST FLOOR
FEL: -53400 mm, 1ST FLOOR
TOS: -53400 mm, 1ST FLOOR
FEL: -53750 mm, 1ST FLOOR
TOS: -53750 mm, 1ST FLOOR
FEL: -54100 mm, 1ST FLOOR
TOS: -54100 mm, 1ST FLOOR
FEL: -54450 mm, 1ST FLOOR
TOS: -54450 mm, 1ST FLOOR
FEL: -54800 mm, 1ST FLOOR
TOS: -54800 mm, 1ST FLOOR
FEL: -55150 mm, 1ST FLOOR
TOS: -55150 mm, 1ST FLOOR
FEL: -55500 mm, 1ST FLOOR
TOS: -55500 mm, 1ST FLOOR
FEL: -55850 mm, 1ST FLOOR
TOS: -55850 mm, 1ST FLOOR
FEL: -56200 mm, 1ST FLOOR
TOS: -56200 mm, 1ST FLOOR
FEL: -56550 mm, 1ST FLOOR
TOS: -56550 mm, 1ST FLOOR
FEL: -56900 mm, 1ST FLOOR
TOS: -56900 mm, 1ST FLOOR
FEL: -57250 mm, 1ST FLOOR
TOS: -57250 mm, 1ST FLOOR
FEL: -57600 mm, 1ST FLOOR
TOS: -57600 mm, 1ST FLOOR
FEL: -57950 mm, 1ST FLOOR
TOS: -57950 mm, 1ST FLOOR
FEL: -58300 mm, 1ST FLOOR
TOS: -58300 mm, 1ST FLOOR
FEL: -58650 mm, 1ST FLOOR
TOS: -58650 mm, 1ST FLOOR
FEL: -59000 mm, 1ST FLOOR
TOS: -59000 mm, 1ST FLOOR
FEL: -59350 mm, 1ST FLOOR
TOS: -59350 mm, 1ST FLOOR
FEL: -59700 mm, 1ST FLOOR
TOS: -59700 mm, 1ST FLOOR
FEL: -60050 mm, 1ST FLOOR
TOS: -60050 mm, 1ST FLOOR
FEL: -60400 mm, 1ST FLOOR
TOS: -60400 mm, 1ST FLOOR
FEL: -60750 mm, 1ST FLOOR
TOS: -60750 mm, 1ST FLOOR
FEL: -61100 mm, 1ST FLOOR
TOS: -61100 mm, 1ST FLOOR
FEL: -61450 mm, 1ST FLOOR
TOS: -61450 mm, 1ST FLOOR
FEL: -61800 mm, 1ST FLOOR
TOS: -61800 mm, 1ST FLOOR
FEL: -62150 mm, 1ST FLOOR
TOS: -62150 mm, 1ST FLOOR
FEL: -62500 mm, 1ST FLOOR
TOS: -62500 mm, 1ST FLOOR
FEL: -62850 mm, 1ST FLOOR
TOS: -62850 mm, 1ST FLOOR
FEL: -63200 mm, 1ST FLOOR
TOS: -63200 mm, 1ST FLOOR
FEL: -63550 mm, 1ST FLOOR
TOS: -63550 mm, 1ST FLOOR
FEL: -63900 mm, 1ST FLOOR
TOS: -63900 mm, 1ST FLOOR
FEL: -64250 mm, 1ST FLOOR
TOS: -64250 mm, 1ST FLOOR
FEL: -64600 mm, 1ST FLOOR
TOS: -64600 mm, 1ST FLOOR
FEL: -64950 mm, 1ST FLOOR
TOS: -64950 mm, 1ST FLOOR
FEL: -65300 mm, 1ST FLOOR
TOS: -65300 mm, 1ST FLOOR
FEL: -65650 mm, 1ST FLOOR
TOS: -65650 mm, 1ST FLOOR
FEL: -66000 mm, 1ST FLOOR
TOS: -66000 mm, 1ST FLOOR
FEL: -66350 mm, 1ST FLOOR
TOS: -66350 mm, 1ST FLOOR
FEL: -66700 mm, 1ST FLOOR
TOS: -66700 mm, 1ST FLOOR
FEL: -67050 mm, 1ST FLOOR
TOS: -67050 mm, 1ST FLOOR
FEL: -67400 mm, 1ST FLOOR
TOS: -67400 mm, 1ST FLOOR
FEL: -67750 mm, 1ST FLOOR
TOS: -67750 mm, 1ST FLOOR
FEL: -68100 mm, 1ST FLOOR
TOS: -68100 mm, 1ST FLOOR
FEL: -68450 mm, 1ST FLOOR
TOS: -68450 mm, 1ST FLOOR
FEL: -68800 mm, 1ST FLOOR
TOS: -68800 mm, 1ST FLOOR
FEL: -69150 mm, 1ST FLOOR
TOS: -69150 mm, 1ST FLOOR
FEL: -69500 mm, 1ST FLOOR
TOS: -69500 mm, 1ST FLOOR
FEL: -69850 mm, 1ST FLOOR
TOS: -69850 mm, 1ST FLOOR
FEL: -70200 mm, 1ST FLOOR
TOS: -70200 mm, 1ST FLOOR
FEL: -70550 mm, 1ST FLOOR
TOS: -70550 mm, 1ST FLOOR
FEL: -70900 mm, 1ST FLOOR
TOS: -70900 mm, 1ST FLOOR
FEL: -71250 mm, 1ST FLOOR
TOS: -71250 mm, 1ST FLOOR
FEL: -71600 mm, 1ST FLOOR
TOS: -71600 mm, 1ST FLOOR
FEL: -71950 mm, 1ST FLOOR
TOS: -71950 mm, 1ST FLOOR
FEL: -72300 mm, 1ST FLOOR
TOS: -72300 mm, 1ST FLOOR
FEL: -72650 mm, 1ST FLOOR
TOS: -72650 mm, 1ST FLOOR
FEL: -73000 mm, 1ST FLOOR
TOS: -73000 mm, 1ST FLOOR
FEL: -73350 mm, 1ST FLOOR
TOS: -73350 mm, 1ST FLOOR
FEL: -73700 mm, 1ST FLOOR
TOS: -73700 mm, 1ST FLOOR
FEL: -74050 mm, 1ST FLOOR
TOS: -74050 mm, 1ST FLOOR
FEL: -74400 mm, 1ST FLOOR
TOS: -74400 mm, 1ST FLOOR
FEL: -74750 mm, 1ST FLOOR
TOS: -74750 mm, 1ST FLOOR
FEL: -75100 mm, 1ST FLOOR
TOS: -75100 mm, 1ST FLOOR
FEL: -75450 mm, 1ST FLOOR
TOS: -75450 mm, 1ST FLOOR
FEL: -75800 mm, 1ST FLOOR
TOS: -75800 mm, 1ST FLOOR
FEL: -76150 mm, 1ST FLOOR
TOS: -76150 mm, 1ST FLOOR
FEL: -76500 mm, 1ST FLOOR
TOS: -76500 mm, 1ST FLOOR
FEL: -76850 mm, 1ST FLOOR
TOS: -76850 mm, 1ST FLOOR
FEL: -77200 mm, 1ST FLOOR
TOS: -77200 mm, 1ST FLOOR
FEL: -77550 mm, 1ST FLOOR
TOS: -77550 mm, 1ST FLOOR
FEL: -77900 mm, 1ST FLOOR
TOS: -77900 mm, 1ST FLOOR
FEL: -78250 mm, 1ST FLOOR
TOS: -78250 mm, 1ST FLOOR
FEL: -78600 mm, 1ST FLOOR
TOS: -78600 mm, 1ST FLOOR
FEL: -78950 mm, 1ST FLOOR
TOS: -78950 mm, 1ST FLOOR
FEL: -79300 mm, 1ST FLOOR
TOS: -79300 mm, 1ST FLOOR
FEL: -79650 mm, 1ST FLOOR
TOS: -79650 mm, 1ST FLOOR
FEL: -80000 mm, 1ST FLOOR
TOS: -80000 mm, 1ST FLOOR
FEL: -80350 mm, 1ST FLOOR
TOS: -80350 mm, 1ST FLOOR
FEL: -80700 mm, 1ST FLOOR
TOS: -80700 mm, 1ST FLOOR
FEL: -81050 mm, 1ST FLOOR
TOS: -81050 mm, 1ST FLOOR
FEL: -81400 mm, 1ST FLOOR
TOS: -81400 mm, 1ST FLOOR
FEL: -81750 mm, 1ST FLOOR
TOS: -81750 mm, 1ST FLOOR
FEL: -82100 mm, 1ST FLOOR
TOS: -82100 mm, 1ST FLOOR
FEL: -82450 mm, 1ST FLOOR
TOS: -82450 mm, 1ST FLOOR
FEL: -82800 mm, 1ST FLOOR
TOS: -82800 mm, 1ST FLOOR
FEL: -83150 mm, 1ST FLOOR
TOS: -83150 mm, 1ST FLOOR
FEL: -83500 mm, 1ST FLOOR
TOS: -83500 mm, 1ST FLOOR
FEL: -83850 mm, 1ST FLOOR
TOS: -83850 mm, 1ST FLOOR
FEL: -84200 mm, 1ST FLOOR
TOS: -84200 mm, 1ST FLOOR
FEL: -84550 mm, 1ST FLOOR
TOS: -84550 mm, 1ST FLOOR
FEL: -84900 mm, 1ST FLOOR
TOS: -84900 mm, 1ST FLOOR
FEL: -85250 mm, 1ST FLOOR
TOS: -85250 mm, 1ST FLOOR
FEL: -85600 mm, 1ST FLOOR
TOS: -85600 mm, 1ST FLOOR
FEL: -85950 mm, 1ST FLOOR
TOS: -85950 mm, 1ST FLOOR
FEL: -86300 mm, 1ST FLOOR
TOS: -86300 mm, 1ST FLOOR
FEL: -86650 mm, 1ST FLOOR
TOS: -86650 mm, 1ST FLOOR
FEL: -87000 mm, 1ST FLOOR
TOS: -87000 mm, 1ST FLOOR
FEL: -87350 mm, 1ST FLOOR
TOS: -87350 mm, 1ST FLOOR
FEL: -87700 mm, 1ST FLOOR
TOS: -87700 mm, 1ST FLOOR
FEL: -88050 mm, 1ST FLOOR
TOS: -88050 mm, 1ST FLOOR
FEL: -88400 mm, 1ST FLOOR
TOS: -88400 mm, 1ST FLOOR
FEL: -88750 mm, 1ST FLOOR
TOS: -88750 mm, 1ST FLOOR
FEL: -89100 mm, 1ST FLOOR
TOS: -89100 mm, 1ST FLOOR
FEL: -89450 mm, 1ST FLOOR