


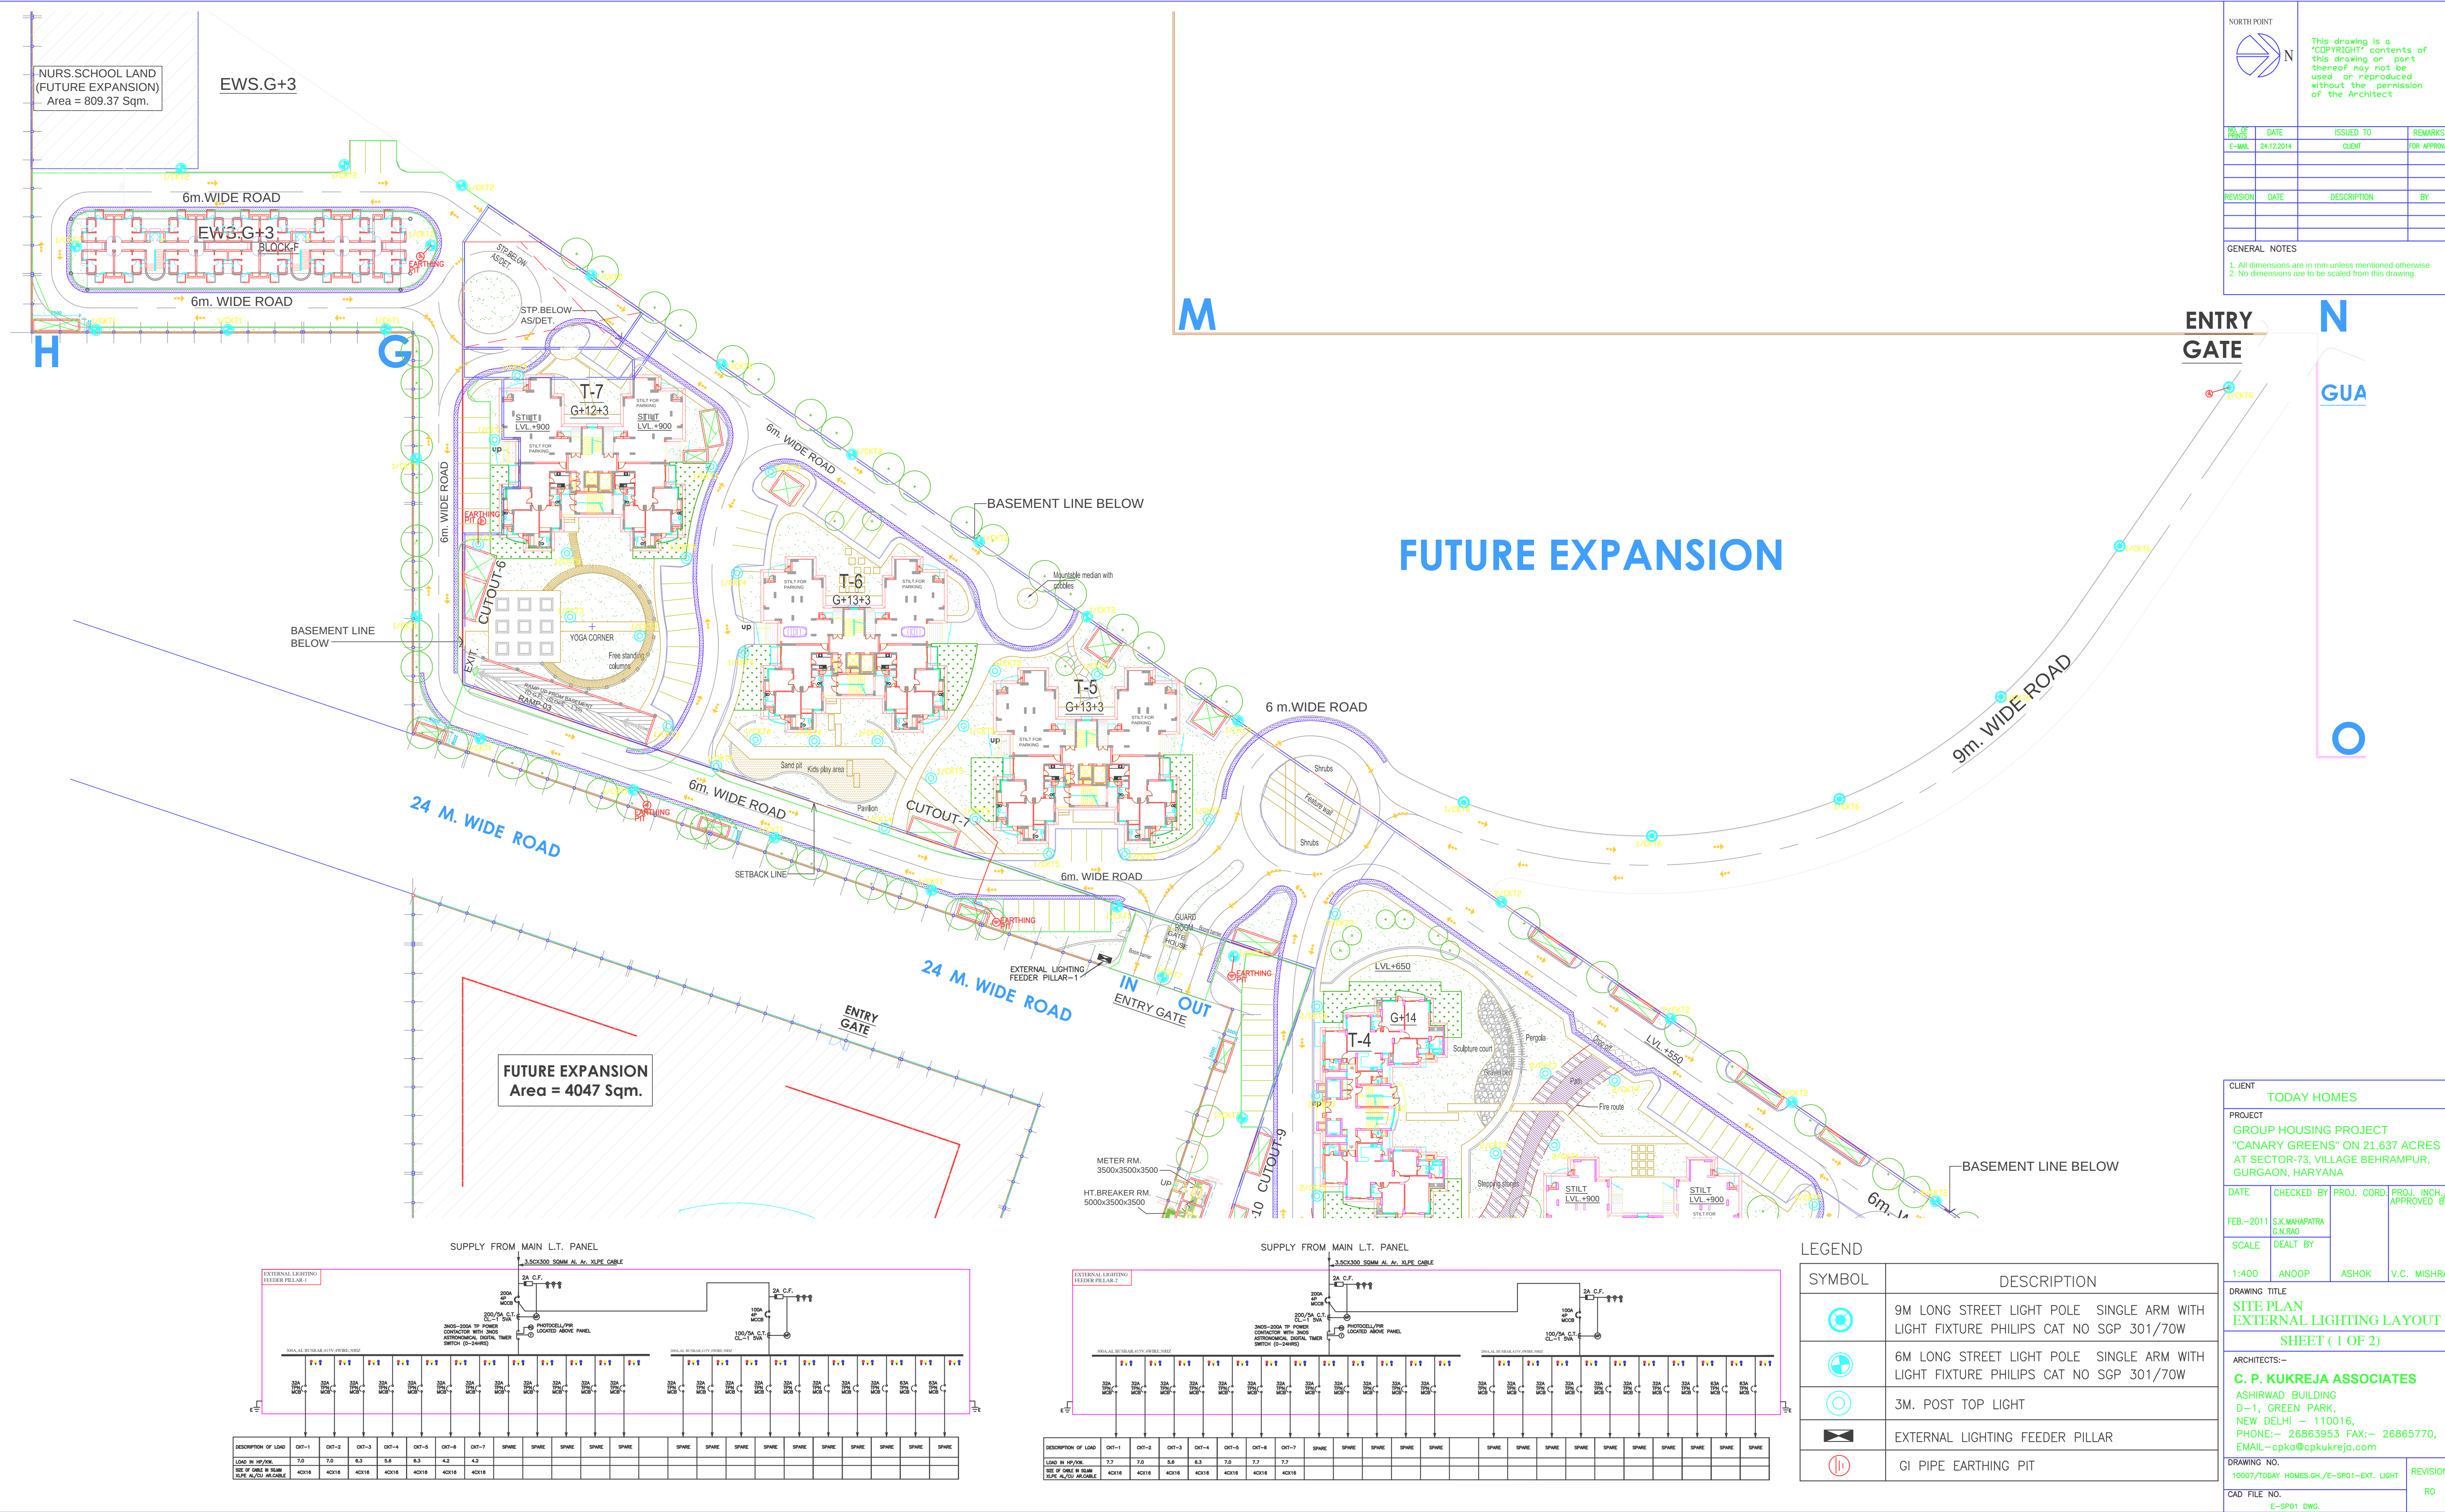

NORTH POINT		This drawing is a "COPYRIGHT" contents of this drawing or part thereof may not be used or reproduced without the permission of the Architect.	
NO. OF SHEETS	DATE	ISSUED TO	REMARKS
E-MAIL	24.12.2014	CLIENT	FOR APPROVAL
REVISION	DATE	DESCRIPTION	BY
GENERAL NOTES			
1. All dimensions are in mm unless mentioned otherwise			
2. No dimensions are to be scaled from this drawing.			

CLIENT			
TODAY HOMES			
PROJECT			
GROUP HOUSING PROJECT "CANARY GREENS" ON 21.637 ACRES AT SECTOR-73, VILLAGE BEHRAMPUR, GURGAON, HARYANA			
DATE	CHECKED BY	PROJ. CORD.	PROJ. INCH./APPROVED BY
FEB-2011	S.K. MAHAPATRA	G.M. RAO	
SCALE	DEALT BY		
1:400	ANOO	ASHOK	V.C. MISHRA
DRAWING TITLE			
SITE PLAN EXTERNAL LIGHTING LAYOUT SHEET (1 OF 2)			
ARCHITECTS:-			
C. P. KUKREJA ASSOCIATES			
ASHIRWAD BUILDING D-1, GREEN PARK, NEW DELHI - 110016, PHONE:- 26863953 FAX:- 26865770, EMAIL:- cpka@cpkukreja.com			
DRAWING NO.	10007/TODAY HOMES.GH/E-SP01-EXT. LIGHT		REVISION
CAD FILE NO.	E-SP01 DWG.		R0