


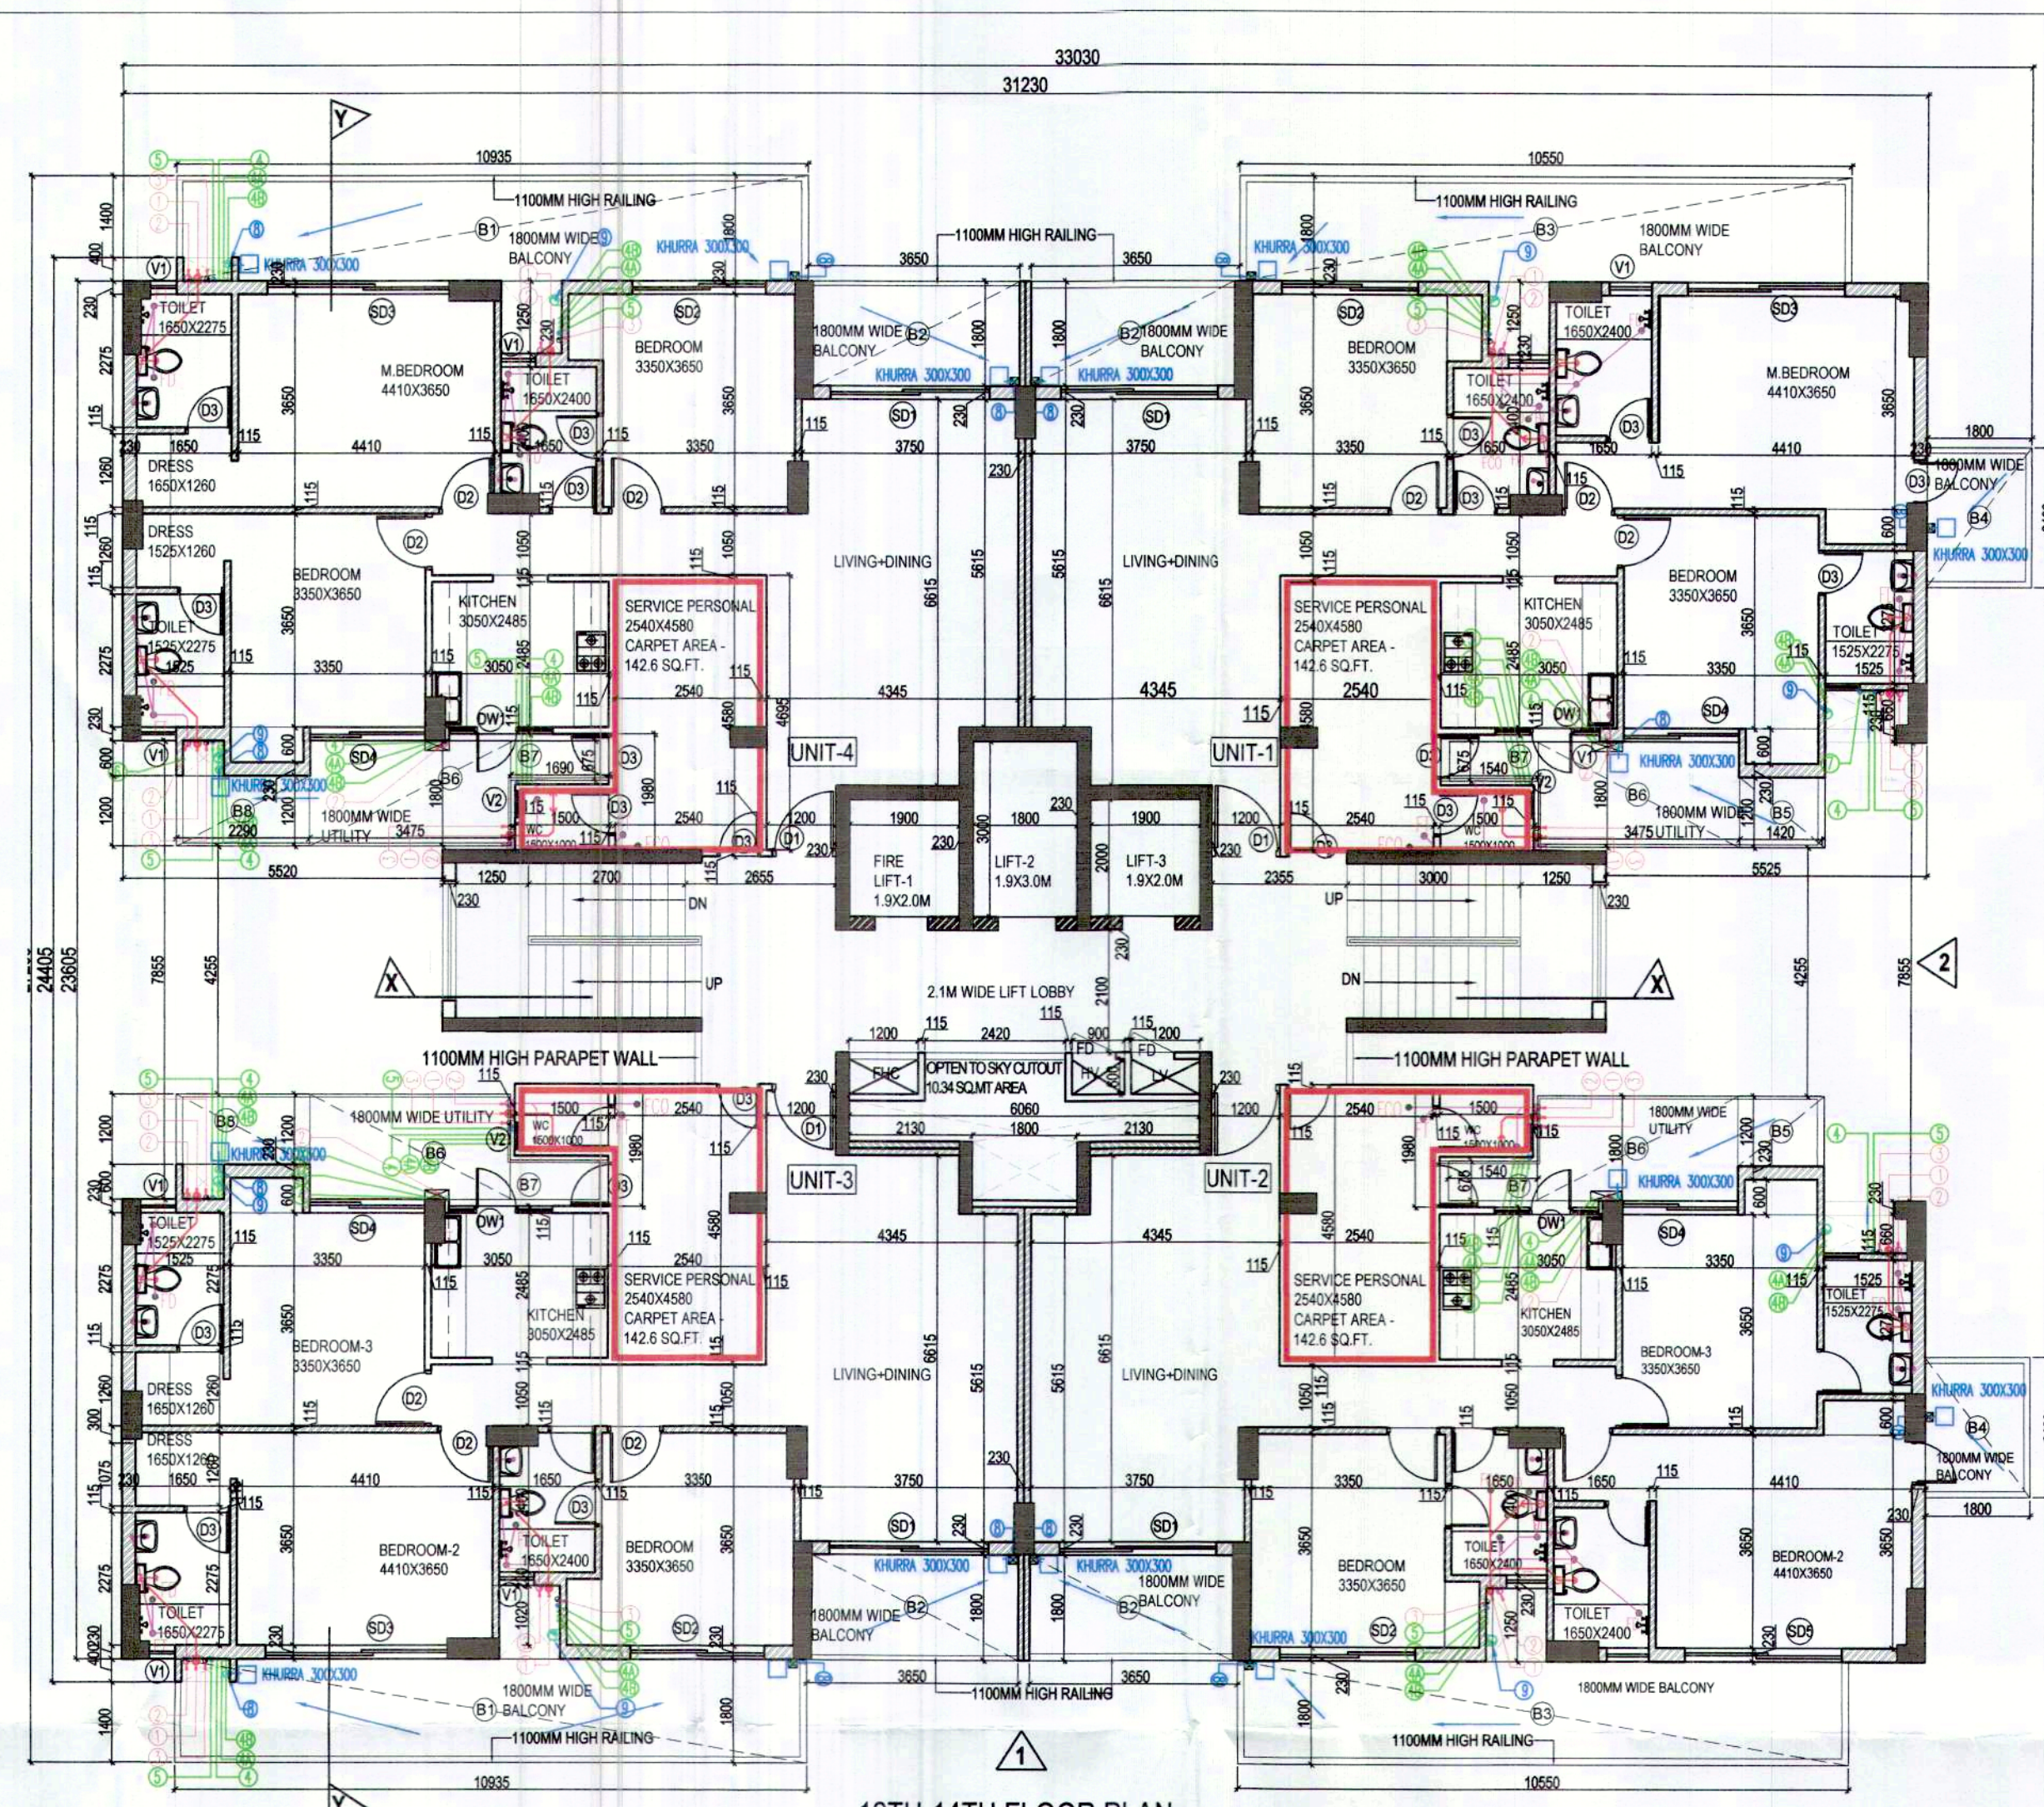


DOOR WINDOW SCHEDULE (TYPICAL FLOOR)						
TYPE	OPENING		CEILING HEIGHT	LIMIT HEIGHT	LIMIT	REMARKS
	WIDTH	HEIGHT				
D1	1100	2150	00	2150		ENTRY TO ALL UNITS
D2	950	2150	00	2150		ALL BEDROOMS
D3	750	2150	00	2150		ALL TOILETS
SD1	2750	2150	00	2150		ALL MORNING
SD2	2350	2150	00	2150		BEDROOM-1 (ALL UNIT)
SD3	3400	2150	00	2150		BEDROOM-2 (UNIT 1&2)
SD4	1715	2150	00	2150		BEDROOM-3 (ALL UNITS)
SD5	2700	2150	00	2150		BEDROOM-2 (UNIT 3&4)
DW1	1940(330+750)	2150	1050(W)			KITCHEN
V1	600	1050	1100	2150		TOILET
V2	450	1050	1100	2150		SERVANT TOILET
FD	900	2150	00	2150		SERVICE SHAFTS

LEGEND FOR PLUMBING	
①	110 OD SMR PVC SOIL & VENT PIPE
②	75 OD SMR PVC WASTE & VENT PIPE
③	110 OD SMR PVC VENT PIPE
④	DOMESTIC WATER SUPPLY 15TH.TO 14TH. FLOOR
⑤	DOMESTIC WATER SUPPLY 13TH.TO 6TH. FLOOR
⑥	DOMESTIC WATER SUPPLY 5TH.TO GROUND FLOOR
⑦	FLUSHING WATER SUPPLY
⑧	D.W.S RISER PIPE
⑨	F.W.S RISER PIPE
⑩	110 OD uPVC RAIN WATER PIPE (FOR BALCONY)
⑪	160 OD uPVC RAIN WATER PIPE (FOR TERRACE)

FT	FLOOR TRAP
FD	FLOOR DRAIN
UT	URINAL TRAP


PLUMBING NOTE:-

- * WASH BASIN TO FLOOR TRAP 50 OD uPVC WASTE PIPE
- * FLOOR DRAIN TO FLOOR TRAP 63 OD uPVC WASTE PIPE
- * FLOOR TRAP TO VERTICAL WASTE STACK 110 OD WASTE PIPE
- * W.C. TO VERTICAL SOIL STACK 110 OD SOIL PIPE

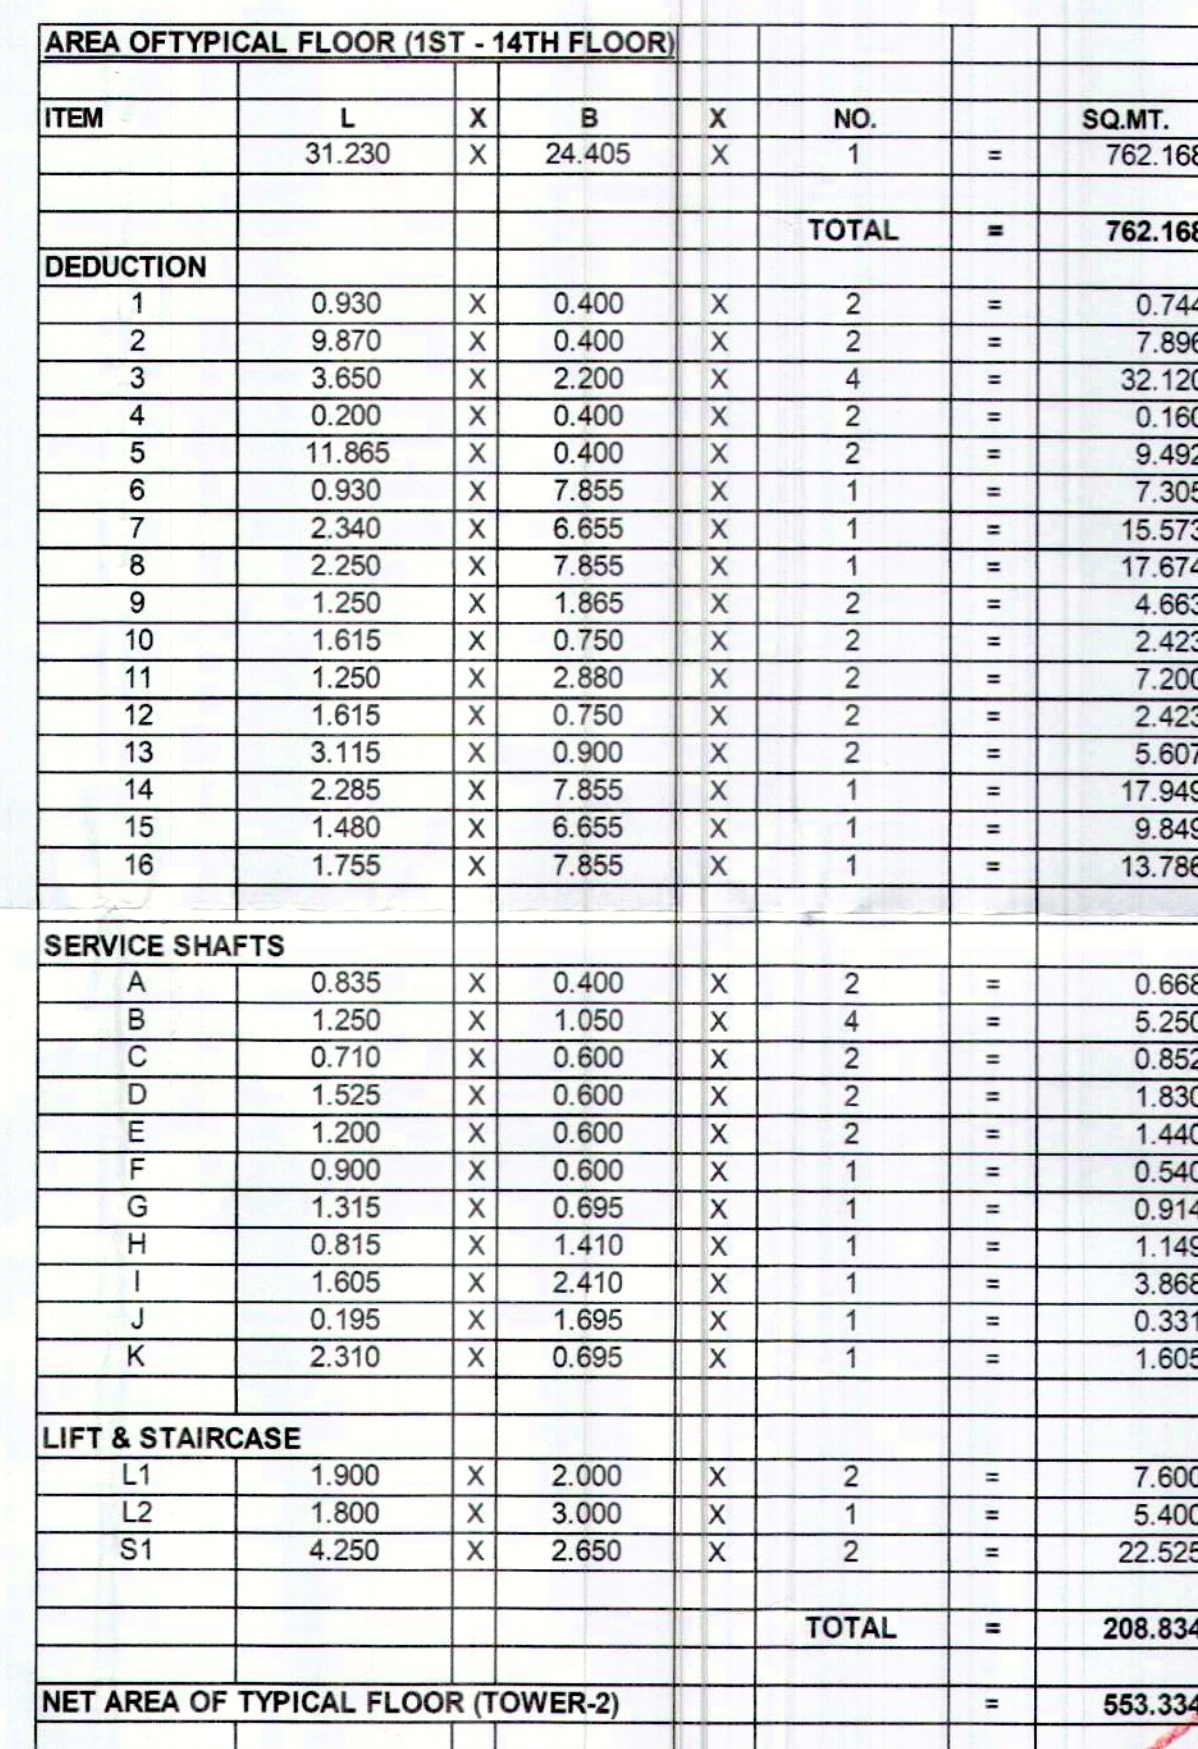

BALCONY AREA DETAIL -TYPICAL FLOOR							
ITEM	L	X	B	X	NO.		SQ.MT.
B1	10.935	X	1.800	X	2	=	39.36
B2	3.650	X	1.800	X	4	=	26.28
B3	10.550	X	1.800	X	2	=	37.98
B4	1.800	X	2.400	X	2	=	8.64
B5	1.420	X	1.200	X	2	=	3.40
B6	3.700	X	1.800	X	4	=	26.64
B7	1.315	X	0.800	X	4	=	4.20
B8	2.290	X	1.200	X	2	=	5.49
					TOTAL	=	152.01
TYPICAL FLOOR BALCONY AREA							= 152.01

SERVICE PERSONAL AREA DETAIL								
ITEM	L	X	B	X	NO.		SQ.MT.	
S1	2.540	X	3.580	X	1	=	9.090	
S2	4.155	X	1.000	X	1	=	4.155	
					TOTAL	=	13.245	
TOTAL AREA OF SERVICE PERSONAL AREA (SQ.MT.)							=	13.245
TOTAL AREA OF SERVICE PERSONAL AREA (SQ.FT.)								142.604

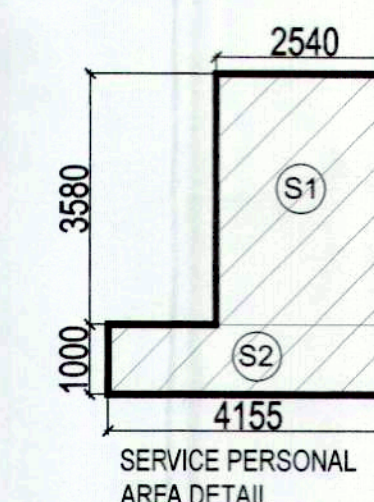

SANCTIONED
TO BE READ WITH THIS OFFICE
MEMO NO.:
DATED :


 DTP (HQ)


 S.T.P (HQ)
 Member Secretary
 B.P.A.C.


 S.T.P (G)
 Member
 B.P.A.C.


 S.P.A.C.


 AD


 PA


 AT


 B.P.A.C.



 Consultant
 Architect


 ATP(H)

DDT (HQ)
 Member
 R.H.A.

(Dinesh Kumar
PA(HQ

Architects & STRUCTURE CONSULTANT

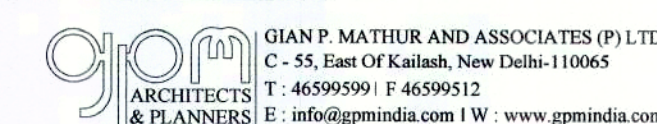

MEP CONSULTANT



B-50, Basement, Soami Nagar
New Delhi-110017
Tel No: 011-49848197 & 49849205
Email: info@vconsulting.co.in

Client

Client
M/s Summit Terracraft Pvt Ltd.
G-3, Aditya Commercial Complex
Plot No. 7, Preet Vihar, Delhi-110092

Project Code	GH/AMEYA/22/218
--------------	-----------------

Project Title	APPROVAL OF BUILDING PLAN OF GROUP HOUSING COLONY (UNDER LEFT OVER POCKET POLICY) (LICENSE NO. 77 OF 2023 DATED 11.04.2023) OVER AN AREA MEASURING 2.44687 ACRES IN SECTOR-15 II GURUGRAM BEING DEVELOPED BY SUMMITT TERRACRAFT PVT.LTD.
---------------	--

Drawing Title

TYPICAL FLOOR PLAN WITH AREA DETAIL (TOWER-2)

Status: SUBMISSION DRAWING

OWNER'S SIGN	ARCHITECT'S SIGN
--------------	------------------

A. P. Mathur
Authorised Signatory

GIAN P. MATHUR
ARCHITECT
B. Arch., M.C.A. I.I.A.
CA No. 80/5769

Date: AUG'23	Scale: 1:100	Drawing No. 08
-----------------	-----------------	-------------------