


1. BUILDING WILL BE DESIGNED (STRUCTURES) AS PER RELEVANT IS CODES FOR EARTH QUAKE RESISTANCE.
2. BUILDING HAS AUTOMATIC SPRINKLER SYSTEM ON ALL FLOORS.
3. CLUB AND RETAIL ARE ARTIFICIALLY LIGHTED MECHANICALLY VENTILATED & AIRCONDITIONED WITH 100% POWER BACKUP.
4. TOILETS ARE ARTIFICIALLY LIGHTED, MECHANICALLY VENTILATED & HAVE 100% POWER BACKUP.(TOWER-A & B)

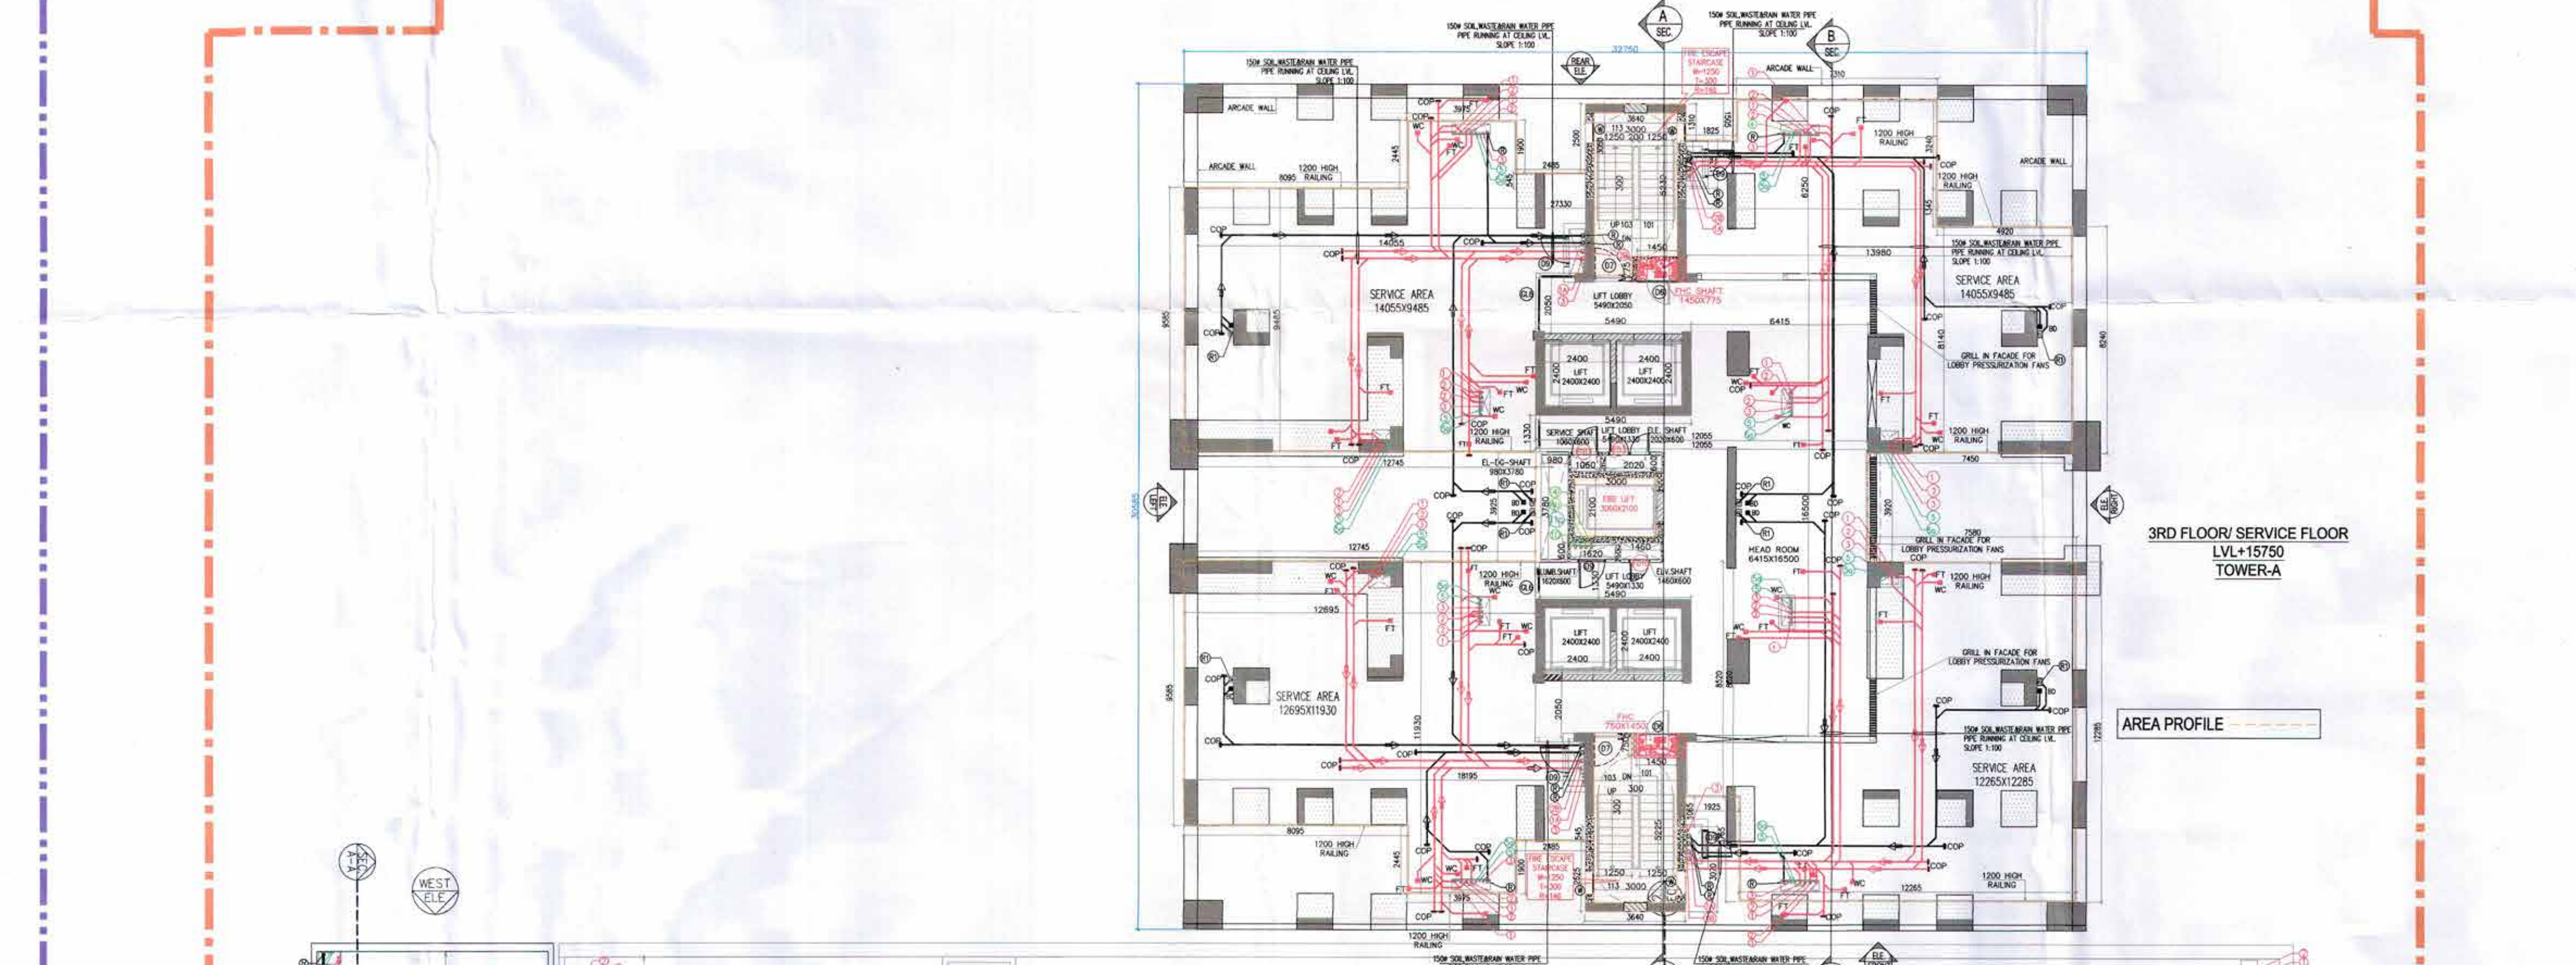

Associate Architects

RSMS
ARCHITECTS

RSMS ARCHITECTS PVT. LTD.
69, Nora Niwas Bhowani Kunj
(Behind D2), Vasant Kunj,
New Delhi-110070.
Tel.: 011-26898616, 26898617
www.rsms-arch.com

Checked and found to be for Public Health
(Internal) Correct way subject to comments in
in forwarding letter No. 12/26/22 Dtr 24-mb-2-3

[Signature]
Superintendent Engineer (H/C)
for Civil Engineering
NHSVP Division
[Signature] [Signature]
IDF (wrt)

[Signature]
Maha
BPA

ARCHITECT'S SEAL & SIGNATURE 	OWNER'S SEAL & SIGNATURE 
---	---

AUGUST-2023.	Scale : 1:150	
Drawing Title:-		Drawing No:
3RD FLOOR PLAN		Q-04

3RD FLOOR PLAN 0-04