

Note :-

- BUILDING WILL BE DESIGNED (STRUCTURES) AS PER RELEVANT IS CODES FOR EARTH QUAKE RESISTANCE.
- BUILDING HAS AUTOMATIC SPRINKLER SYSTEM ON ALL FLOORS.
- CLUB AND RETAIL ARE ARTIFICIALLY LIGHTED MECHANICALLY VENTILATED & AIR CONDITIONED WITH 100% POWER BACKUP.
- TOILETS ARE ARTIFICIALLY LIGHTED, MECHANICALLY VENTILATED & HAVE 100% POWER BACKUP.(TOWER-A & B)

LEGEND:-

PROJECT:-

PROPOSED GROUP HOUSING COLONY UNDER TOD POLICY (MIX LAND USE 78% RESIDENTIAL + 22% COMMERCIAL) ON AN AREA MEASURING 4.84375 ACRES (LICENCE NO.114 OF 2023 DATED 2/06/2023) IN SECTOR-42 GURUGRAM MANESAR URBAN COMPLEX BEING DEVELOPED BY MRS. NEERU DEVI WOLATE SH. NARESH CHAND JAIN AND OTHER IN COLLABORATION WITH CONSCIENT INFRASTRUCTURE PVT LTD.

Associate Architects



RMS ARCHITECTS PVT. LTD.
69, Nara Niwas Bhawani Kunj
(Behind D2), Vasant Kunj,
New Delhi-110070.
Tel: 011-26898616, 26898617
www.rmsim-arch.com

(Signature)
Architect
RMS ARCHITECTS
69, Nara Niwas Bhawani Kunj
New Delhi-110070

(Signature)
Owner's Seal & Signature
RMS ARCHITECTS

ARCHITECT'S SEAL & SIGNATURE



AUGUST-2023. Scale : 1:100
Drawing Title :-

9TH & 41ST FLOOR ROOF PLAN
MUMTY AREA CALCULATION
(TOWER-B)

TB-C-04



PIPE CONNECTION DIA :-

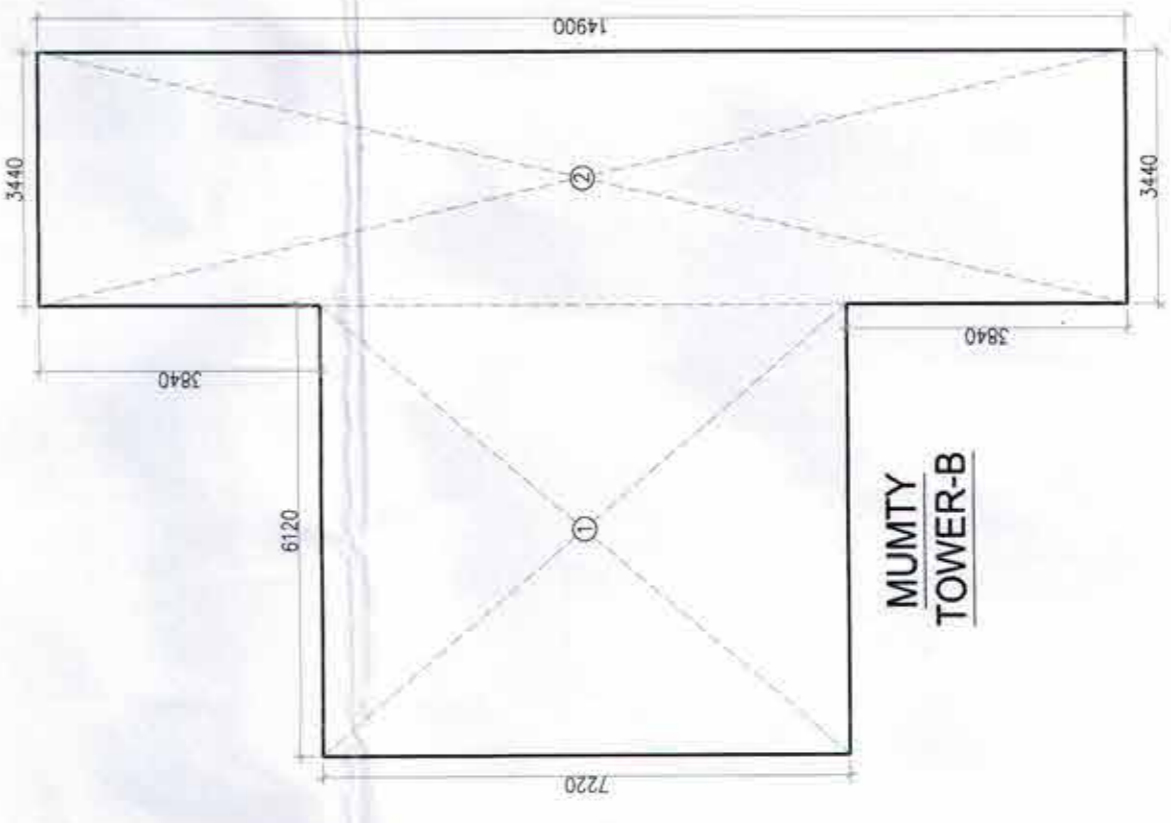
WC TO STACK	1000 SOIL PIPE
SHW TO MT	400 WASTE PIPE
FD TO MT	500 WASTE PIPE
WASH BASH TO UT	300 WASTE PIPE
MT TO STACK	1000 WASTE PIPE

PLUMBING LEGEND-

S.NO	ABBREVIATION	SYMBOL	DESCRIPTION
1	WP	---	1000 WASTE PIPE
2	WP	---	400/500 WASTE PIPE
3	SP	---	1000 SOIL PIPE
4	SP	---	500 SOIL PIPE
5	UT	---	URINAL TRAP
6	FT	---	FLOOR TRAP
7	FD	---	FLOOR DRAIN
8	ARROW	---	SLOPE ARROW


PLUMBING LEGEND- (CONTINUED)

S.NO	SYMBOL	DESCRIPTION
1	---	SOIL PIPE
2	---	WASTE PIPE
3	---	ANTI-VEGET PIPE
4	---	PLUMBING WATER SUPPLY PIPE (WASTEL DOWN DOWN)
5	---	DOMESTIC WATER SUPPLY BRANCH PIPE
6	---	PLUMBING WATER SUPPLY BRANCH PIPE
7	---	DOMESTIC WATER SUPPLY (TOP THREE FLOOR)
8	---	DOMESTIC WATER SUPPLY FOR TOWER-B
9	---	PLUMBING WATER SUPPLY FOR TOWER-B
10	---	PLUMBING WATER SUPPLY FOR TOWER-B
11	---	PLUMBING WATER SUPPLY FOR TOWER-B
100	---	PLUMBING WATER SUPPLY FOR TOWER-B



MUMTY AREA FOR FAR AREA (TOWER-B)

FOOTPRINT	NO. OF FOOTPRINTS	AREA	TOTAL
1	1	9120.00	9120.00
2	1	9120.00	9120.00
3	1	9120.00	9120.00
100	1	9120.00	9120.00

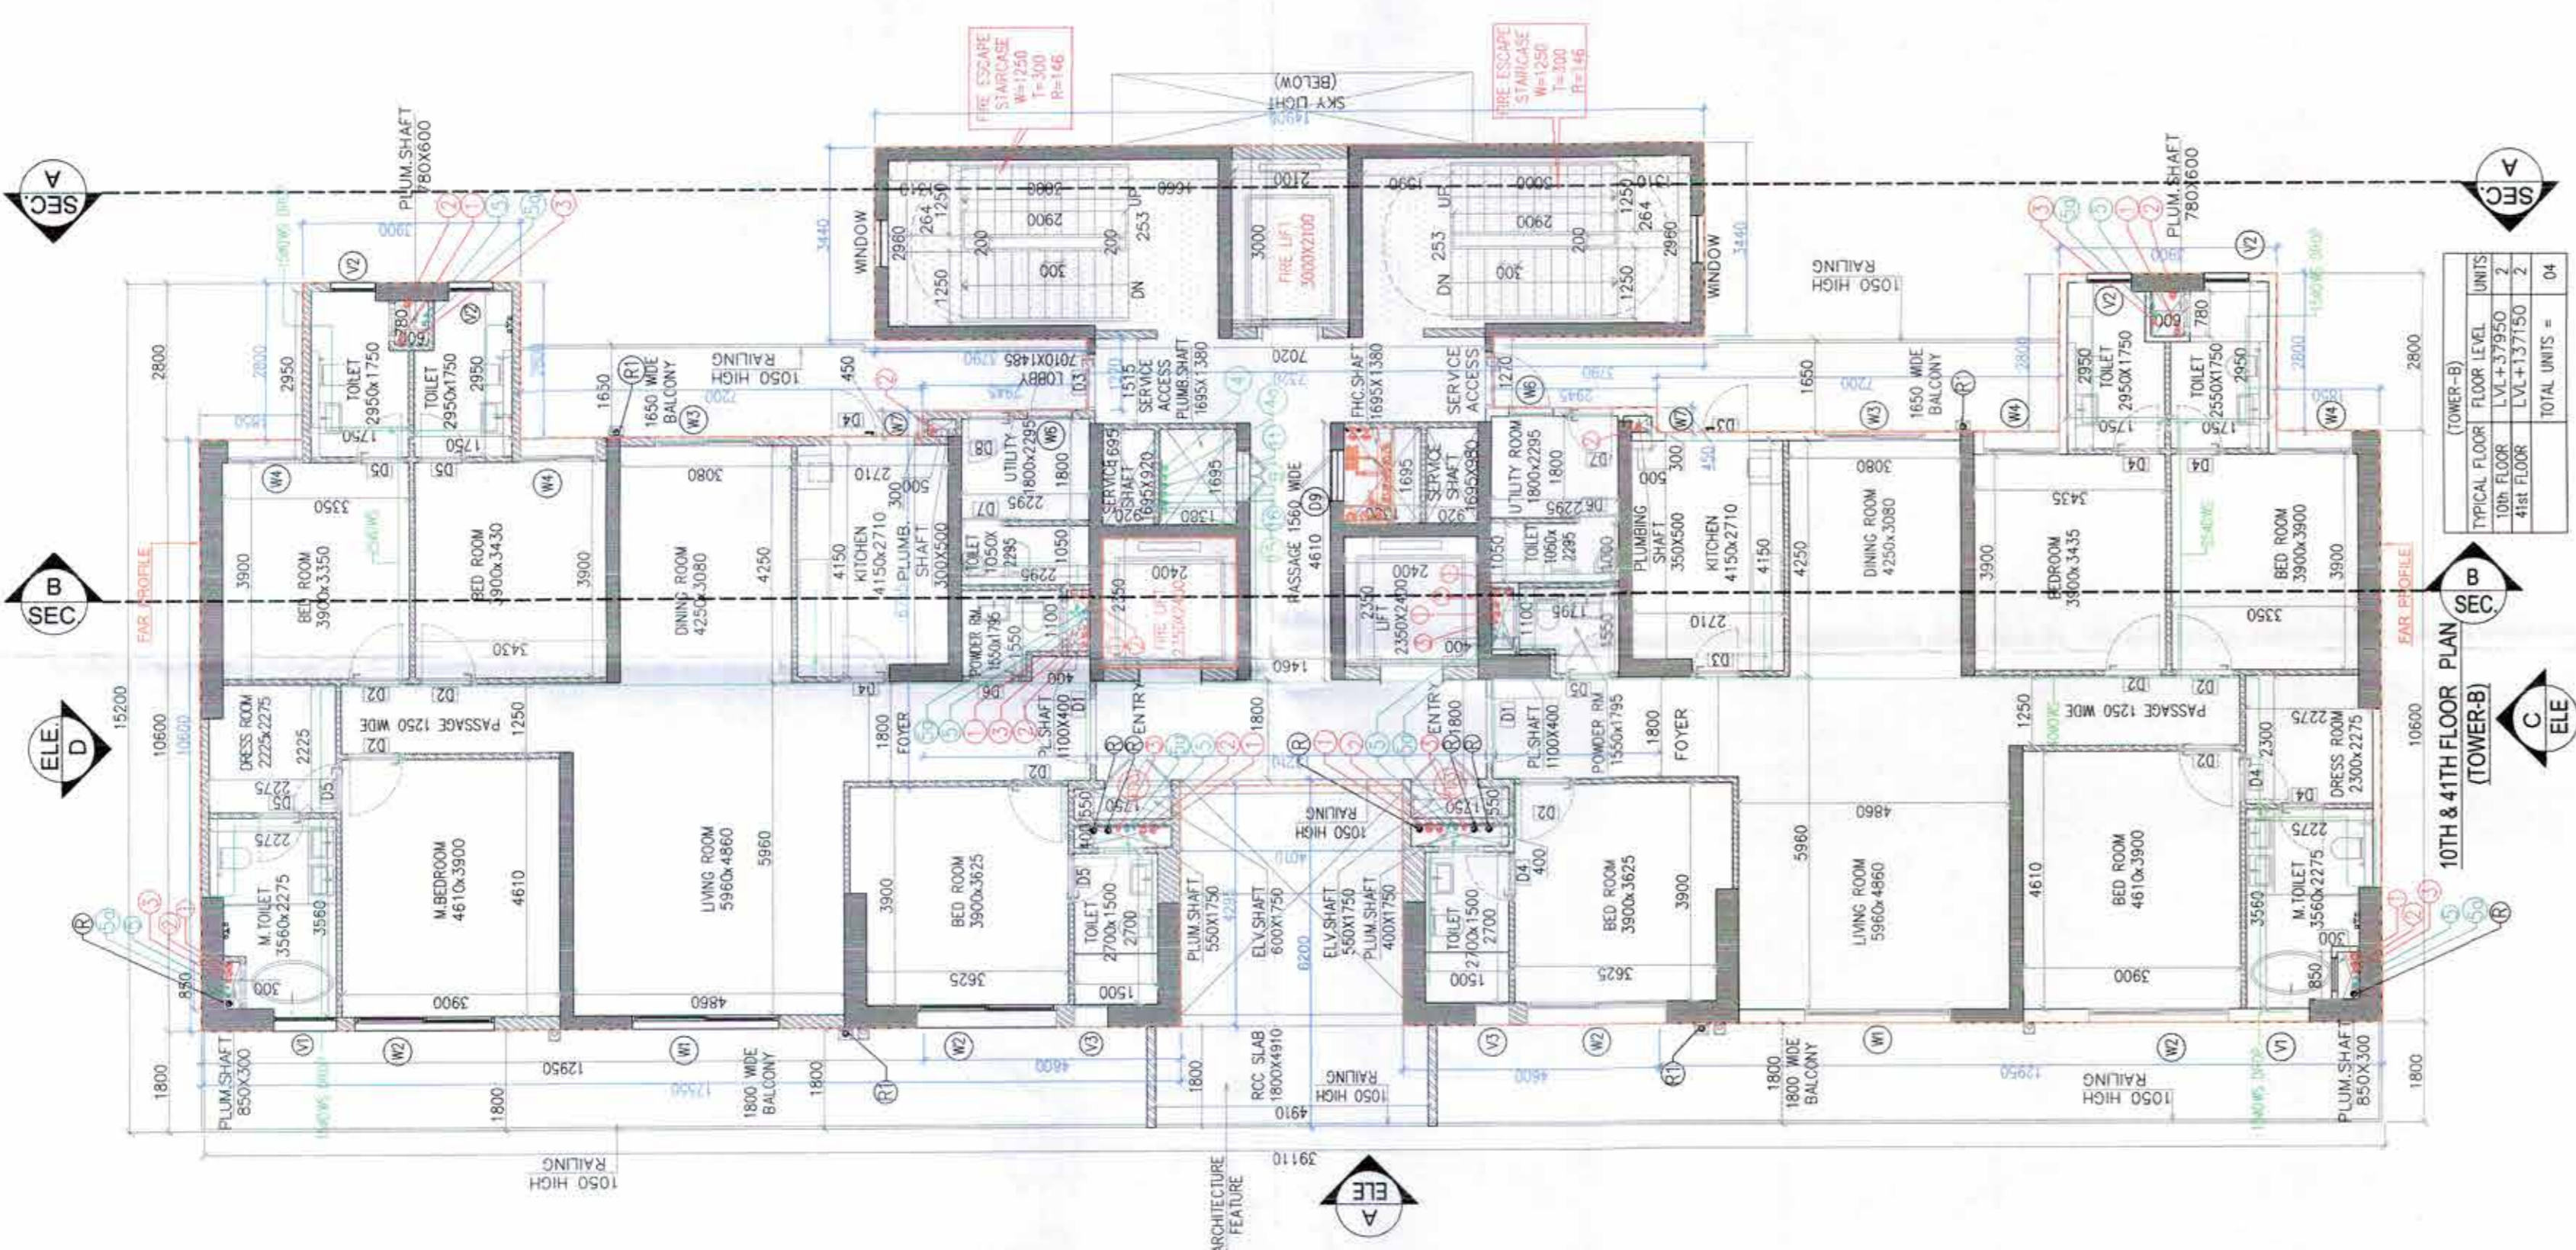

DOOR SCHEDULE (ALL DIMENSIONS ARE IN MM)

DOOR NO.	ROOM NAME	DOOR TYPE	DOOR SIZE	DOOR WEIGHT
01
02
03
85	