

Note :-

1. BUILDING WILL BE DESIGNED (STRUCTURES) AS PER RELEVANT IS CODES FOR EARTH QUAKE RESISTANCE.
2. BUILDING HAS AUTOMATIC SPRINKLER SYSTEM ON ALL FLOORS.
3. CLUB AND RETAIL ARE ARTIFICIALLY LIGHTED MECHANICALLY VENTILATED & AIRCONDITIONED WITH 100% POWER BACKUP.
4. TOILETS ARE ARTIFICIALLY LIGHTED, MECHANICALLY VENTILATED & HAVE 100% POWER BACKUP(TOWER-A & B)

LEGEND:-

PROJECT:-

PROPOSED GROUP HOUSING COLONY UNDER TOD POLICY (MIX LAND USE 78% RESIDENTIAL + 22 % COMMERCIAL) ON AN AREA MEASURING 4.84375 ACRES (LICENCE NO.114 OF 2023 DATED 2/06/2023) IN SECTOR-42 GURUGRAM MANESAR URBAN COMPLEX BEING DEVELOPED BY MRS. NERU DEVI W/O LATE SH. NARESH CHAND JAIN AND OTHER IN COLLABORATION WITH CONSCIENT INFRASTRUCTURE PVT LTD.

Associate Architects

RISIMIS ARCHITECTS

RMS ARCHITECTS PVT. LTD.
69 Nara Niwas Bhawani Kunj
(Behind D2), Vasanti Kunj,
New Delhi-110070
Tel: 011-26898616, 26898617
www.rsimis-arch.com

[Signatures and stamps of architects and clients]

ARCHITECT'S SEAL & SIGNATURE

OWNER'S SEAL & SIGNATURE

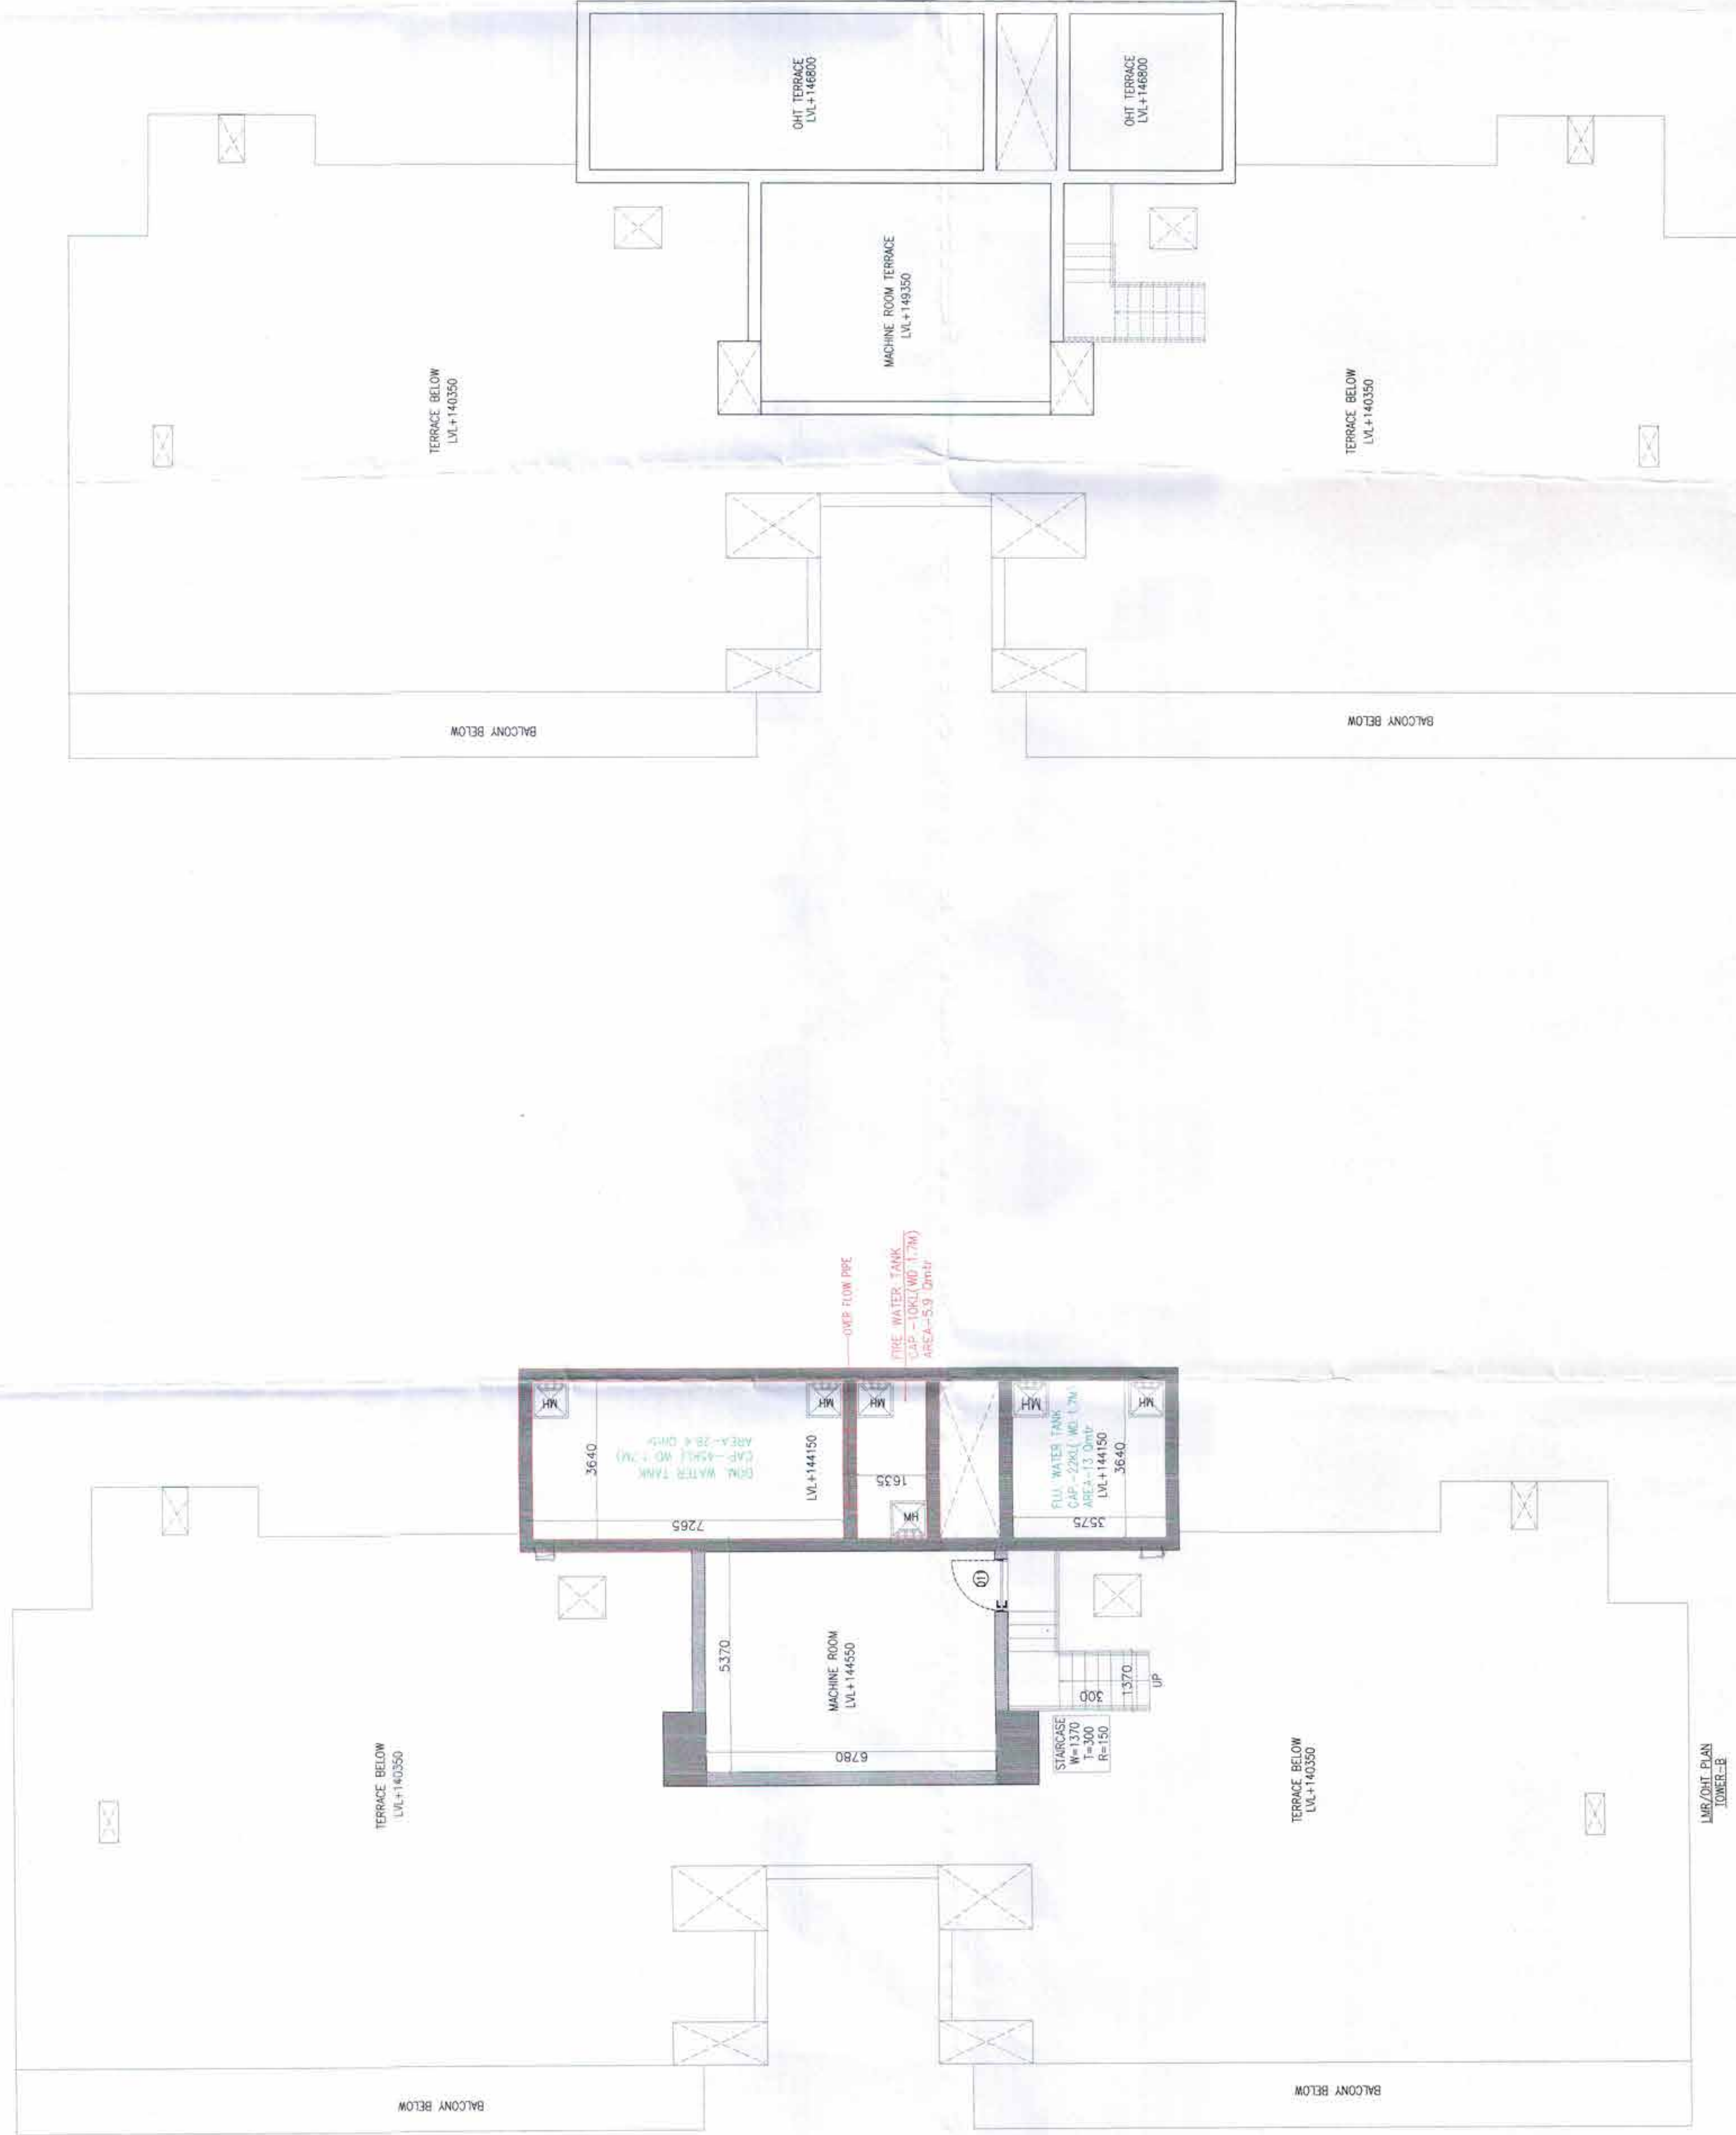
AUGUST-2023. Scale : 1:100

Drawing Title:-

9TH & 4TH FLOOR ROOF PLAN
MUMTY AREA CALCULATION
(TOWER-B)

Drawing No:-

TB-C-04



PIPE CONNECTION DIA :-


NO. TO STACK	1000 SOIL PIPE
NO. TO MT	400 WASTE PIPE
NO. TO MT	500 WASTE PIPE
WASH BASIN TO MT	300 WASTE PIPE
MT TO STAIRS	1000 WASTE PIPE

PLUMBING LEGEND:-

S.NO	ABBREVIATION	SYMBOL	DESCRIPTION
1	WP	—	1000 WASTE PIPE
2	WP	—	40/500 WASTE PIPE
3	SP	—	1000 SOIL PIPE
4	SP	—	500 SOIL PIPE
5	UT	—	URINAL TRAP
6	FT	—	FLOOR TRAP
7	FD	—	FLOOR DRAIN
8	ARROW	↔	SLOPE ARROW

PLUMBING LEGEND:-

S.NO	SYMBOL	DESCRIPTION
1	●	SOIL PIPE
2	●	WASTE PIPE
3	●	ANTI VENT PIPE
4	●	FLUSHING WATER SUPPLY PIPE (MASTER DOWN COME)
5	●	FLUSHING WATER SUPPLY PIPE (BRANCH)
6	●	FLUSHING WATER SUPPLY PIPE (TOP THREE FLOORS)
7	●	FLUSHING WATER SUPPLY PIPE (TOP THREE FLOORS)
8	●	FLUSHING WATER SUPPLY PIPE (TOP THREE FLOORS)
100	●	FLUSHING WATER SUPPLY PIPE (TOP THREE FLOORS)

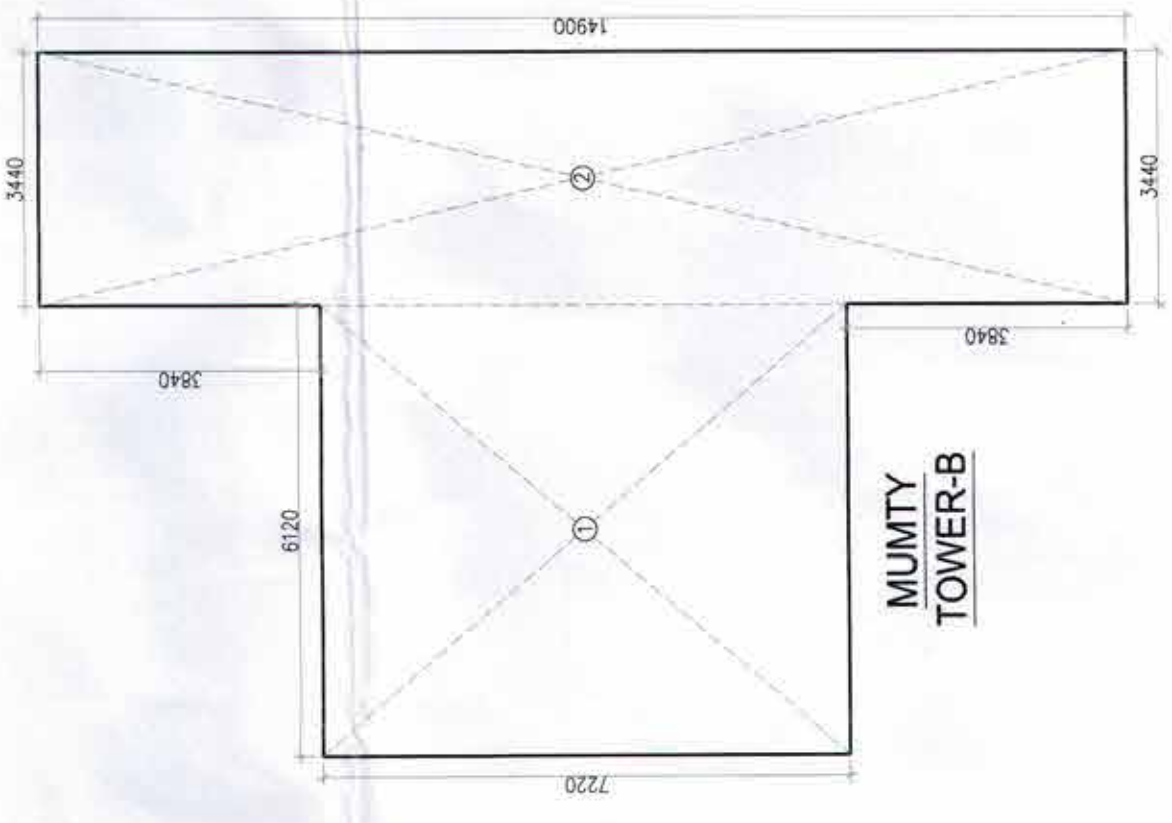

MUMTY AREA FOR AREA (TOWER-B)

POCKET NO.	NO. OF POCKETS	AREA	PERCENT	AREA
1	1	1.00	1.00	1.00
2	1	1.00	1.00	1.00
3	1	1.00	1.00	1.00
100	1	1.00	1.00	1.00

DOOR SCHEDULE (ALL DIMENSIONS ARE IN METERS)						
NO.	DOOR NAME	DOOR TYPE	DOOR SIZE	DOOR WEIGHT	DOOR MATERIAL	DOOR FINISH
01	DOOR 001	DOOR	2.10 x 2.10	1.00	DOOR	DOOR
02	DOOR 002	DOOR	2.10 x 2.10	1.00	DOOR	DOOR
03	DOOR 003	DOOR	2.10 x 2.10	1.00	DOOR	DOOR
04	DOOR 004	DOOR	2.10 x 2.10	1.00	DOOR	DOOR
05	DOOR 005	DOOR	2.10 x 2.10	1.00	DOOR	DOOR
06	DOOR 006	DOOR	2.10 x 2.10	1.00	DOOR	DOOR
07	DOOR 007	DOOR	2.10 x 2.10	1.00	DOOR	DOOR
08	DOOR 008	DOOR	2.10 x 2.10	1.00	DOOR	DOOR
09	DOOR 009	DOOR	2.10 x 2.10	1.00	DOOR	DOOR
10	DOOR 010	DOOR	2.10 x 2.10	1.00	DOOR	DOOR
11	DOOR 011	DOOR	2.10 x 2.10	1.00	DOOR	DOOR
12	DOOR 012	DOOR	2.10 x 2.10	1.00	DOOR	DOOR
13	DOOR 013	DOOR	2.10 x 2.10	1.00	DOOR	DOOR
14	DOOR 014	DOOR	2.10 x 2.10	1.00	DOOR	DOOR
15	DOOR 015	DOOR	2.10 x 2.10	1.00	DOOR	DOOR
16	DOOR 016	DOOR	2.10 x 2.10	1.00	DOOR	DOOR
17	DOOR 017	DOOR	2.10 x 2.10	1.00	DOOR	DOOR
18	DOOR 018	DOOR	2.10 x 2.10	1.00	DOOR	DOOR
19	DOOR 019	DOOR	2.10 x 2.10	1.00	DOOR	DOOR
20	DOOR 020	DOOR	2.10 x 2.10	1.00	DOOR	DOOR
21	DOOR 021	DOOR	2.10 x 2.10	1.00	DOOR	DOOR
22	DOOR 022	DOOR	2.10 x 2.10	1.00	DOOR	DOOR
23	DOOR 023	DOOR	2.10 x 2.10	1.00	DOOR	DOOR
24	DOOR 024	DOOR	2.10 x 2.10	1.00	DOOR	DOOR
25	DOOR 025	DOOR	2.10 x 2.10	1.00	DOOR	DOOR
26	DOOR 026	DOOR	2.10 x 2.10	1.00	DOOR	DOOR
27	DOOR 027	DOOR	2.10 x 2.10	1.00	DOOR	DOOR
28	DOOR 028	DOOR	2.10 x 2.10	1.00	DOOR	DOOR
29	DOOR 029	DOOR	2.10 x 2.10	1.00	DOOR	DOOR
30	DOOR 030	DOOR	2.10 x 2.10	1.00	DOOR	DOOR
31	DOOR 031	DOOR	2.10 x 2.10	1.00	DOOR	DOOR
32	DOOR 032	DOOR	2.10 x 2.10	1.00	DOOR	DOOR
33	DOOR 033	DOOR	2.10 x 2.10	1.00	DOOR	DOOR
34	DOOR 034	DOOR	2.10 x 2.10	1.00	DOOR	DOOR
35	DOOR 035	DOOR	2.10 x 2.10	1.00	DOOR	DOOR
36	DOOR 036	DOOR	2.10 x 2.10	1.00	DOOR	DOOR
37	DOOR 037	DOOR	2.10 x 2.10	1.00	DOOR	DOOR
38	DOOR 038	DOOR	2.10 x 2.10	1.00	DOOR	DOOR
39	DOOR 039	DOOR	2.10 x 2.10	1.00	DOOR	DOOR
40	DOOR 040	DOOR	2.10 x 2.10	1.00	DOOR	DOOR
41	DOOR 041	DOOR	2.10 x 2.10	1.00	DOOR	DOOR
42	DOOR 042	DOOR	2.10 x 2.10	1.00	DOOR	DOOR
43	DOOR 043	DOOR	2.10 x 2.10	1.00	DOOR	DOOR
44	DOOR 044	DOOR	2.10 x 2.10	1.00	DOOR	DOOR
45	DOOR 045	DOOR	2.10 x 2.10	1.00	DOOR	DOOR