


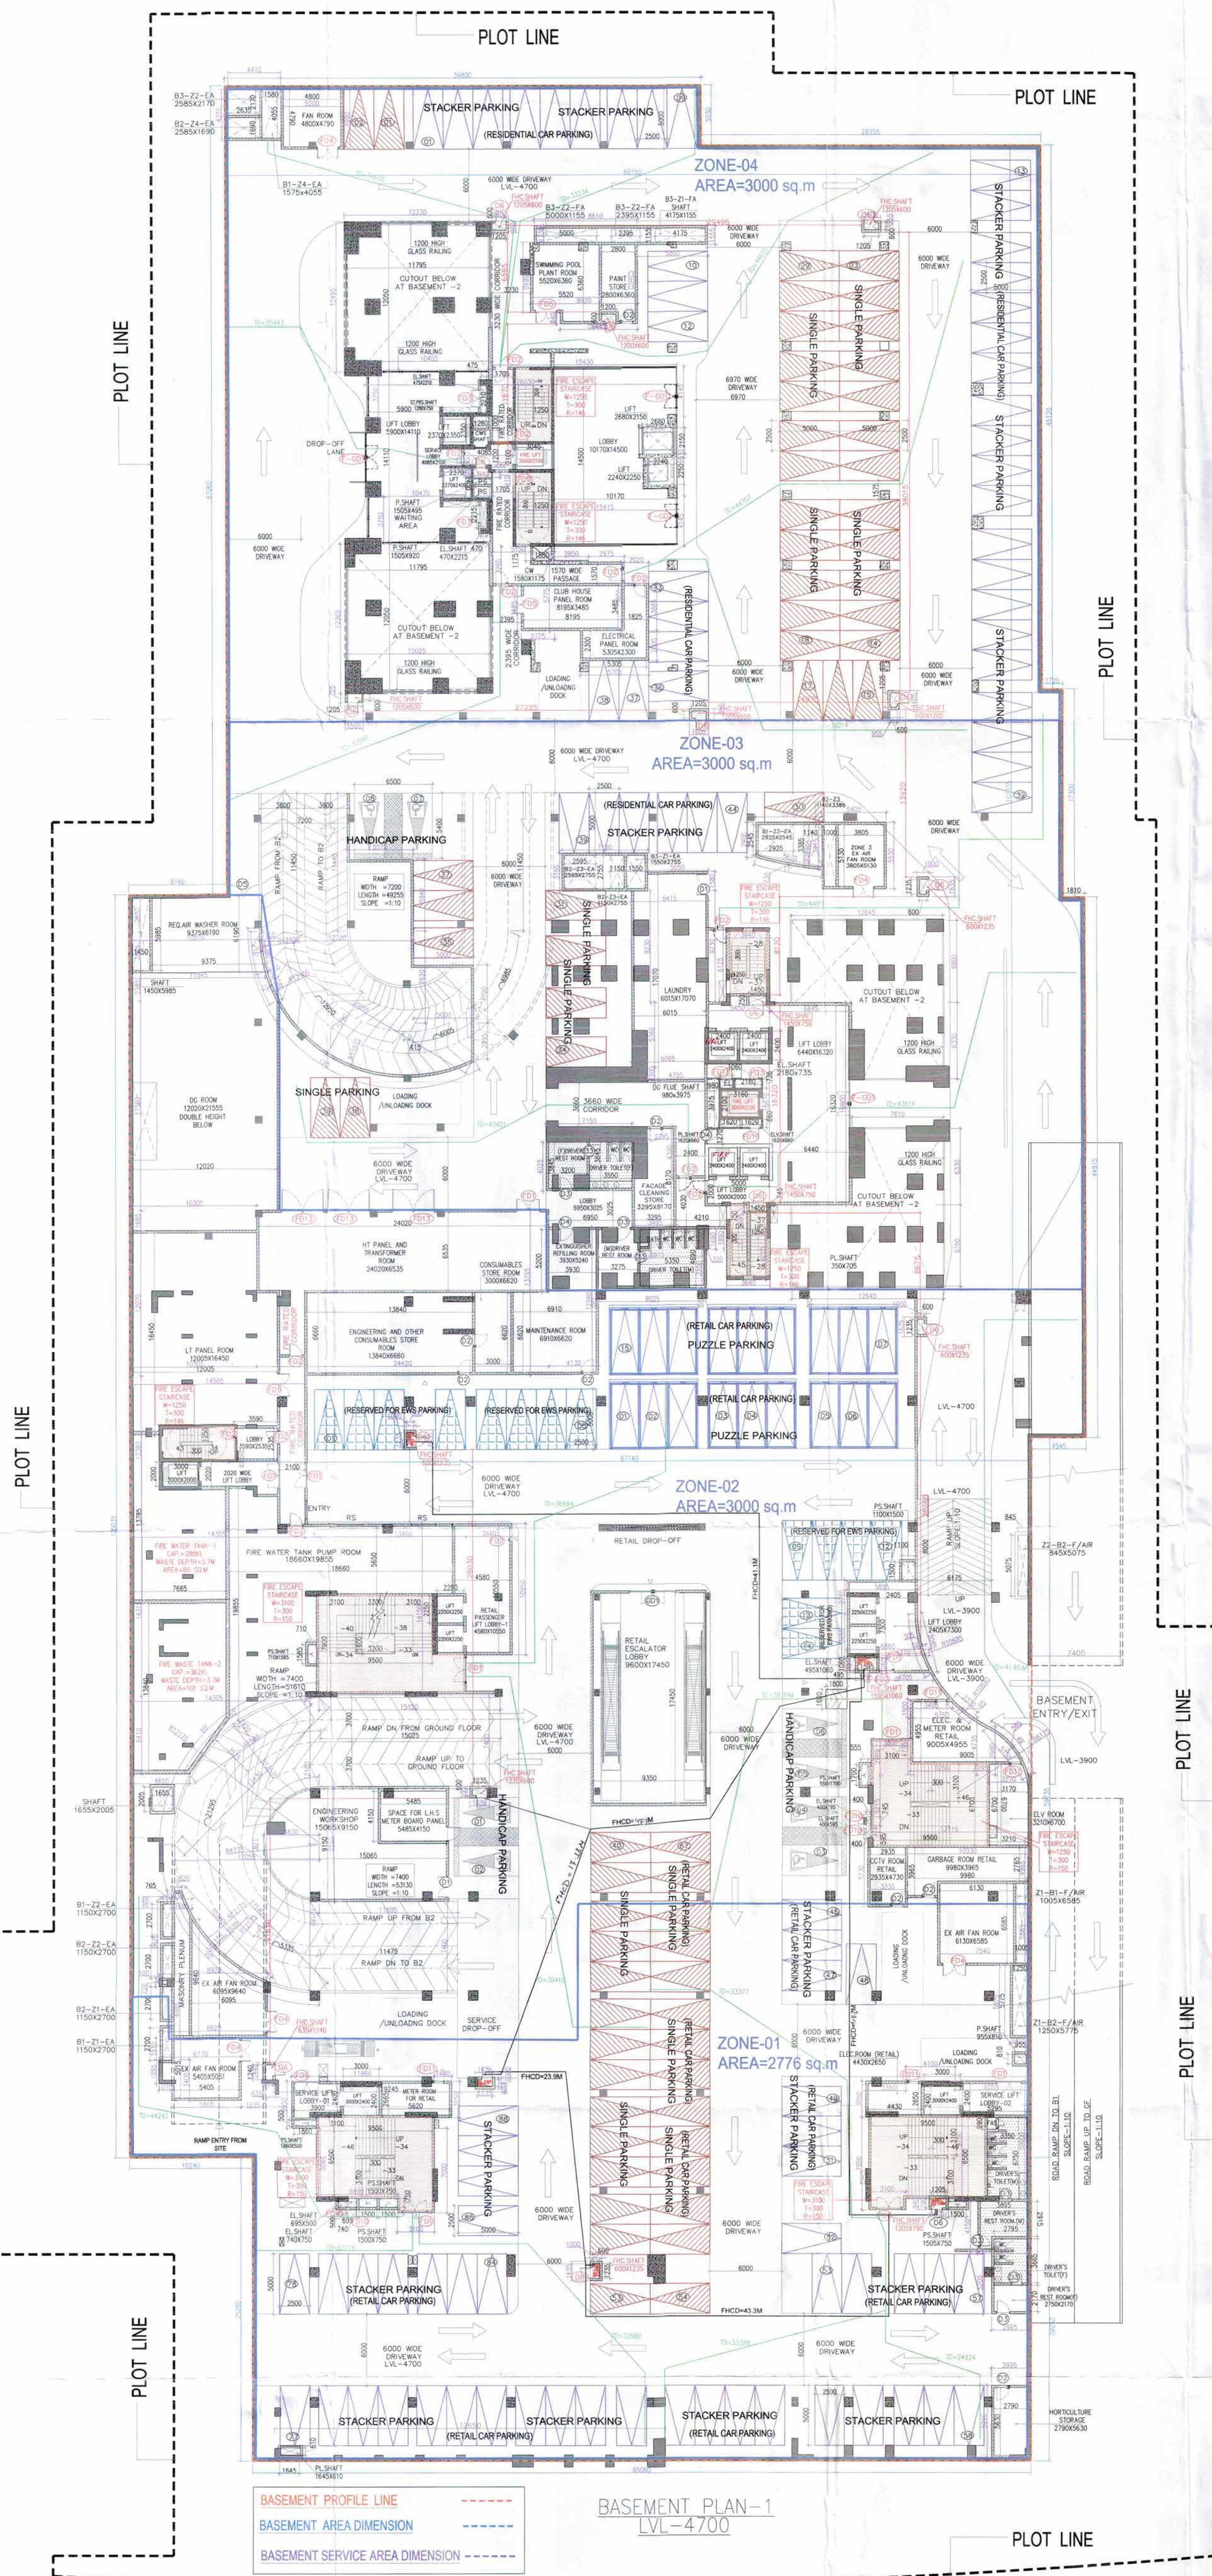

LEGEND

NO.	ROOM NAME	LOCATION	AREA	NO.	ROOM NAME	LOCATION	AREA
F-001	LOBBY	ENTRANCE	2500	01	2nd FLY	2nd FLY	2500
F01	STAIRCASE	2500	02	2nd FLY	2nd FLY	2500	2500
F02	STAIRCASE	1100	03	2nd FLY	2nd FLY	2500	2500
F03	STAIRCASE	1400	04	2nd FLY	2nd FLY	2500	2500
F04	STAIRCASE	1400	05	2nd FLY	2nd FLY	2500	2500
F05	STAIRCASE	1400	06	2nd FLY	2nd FLY	2500	2500
F99	STAIRCASE	1400	100	2nd FLY	2nd FLY	2500	2500

BASEMENT-1 (RESIDENTIAL CAR PARKING)

NO.	ROOM NAME	LOCATION	AREA
1	SINGLE PARKING	39	39
2	STACKER PARKING	44X2	88
3	HANDICAP PARKING	02	02
4	EWS PARKING	14	14
5	TOTAL RESIDENTIAL CAR PARKING	143	143

BASEMENT-1 (RETAIL CAR PARKING)

NO.	ROOM NAME	LOCATION	AREA
1	SINGLE PARKING	28	28
2	STACKER PARKING	44X2	88
3	PUZZLE PARKING	15X2	30
4	HANDICAP PARKING	06	06
5	TOTAL RETAIL CAR PARKING	152	152
6	GRAND TOTAL RESIDENTIAL+RETAIL CAR PARKING (143 + 152)	295	295

NO. OF CAR ACHEIVABLE OF BASEMENT-01 = 8746.885 / 32 = 273.34 EGS
OR SAY = 273 EGS
TOTAL PROPOSED CAR PARKING = 295 CARS

- Note :-
- BUILDING WILL BE DESIGNED (STRUCTURES) AS PER RELEVANT IS CODES FOR EARTH QUAKE RESISTANCE.
 - BUILDING HAS AUTOMATIC SPRINKLER SYSTEM ON ALL FLOORS.
 - CLUB AND RETAIL ARE ARTIFICIALLY LIGHTED MECHANICALLY VENTILATED & AIRCONDITIONED WITH 100% POWER BACKUP.
 - TOILETS ARE ARTIFICIALLY LIGHTED, MECHANICALLY VENTILATED & HAVE 100% POWER BACKUP.(TOWER-A & B)

LEGEND:-

PROJECT:-

PROPOSED GROUP HOUSING COLONY UNDER TOD POLICY (MIX LAND USE 78% RESIDENTIAL + 22 % COMMERCIAL) ON AN AREA MEASURING 4.84375 ACRES (LICENCE NO.114 OF 2023 DATED 2/06/2023) IN SECTOR-62, GURUGRAM MANESAR URBAN COMPLEX BEING DEVELOPED BY MRS. NEERU DEVI W/O LATE SH. NARESH CHAND JAIN AND OTHER IN COLLABORATION WITH CONSCIENT INFRASTRUCTURE PVT LTD.

Associate Architects

RMS ARCHITECTS

RMS ARCHITECTS PVT. LTD.
69,Nora Niwas Bhawani Kunj
(Behind D2), Vasant Kunj,
New Delhi-110070.
Tel.: 011-26898616,26898617
www.rsms-arch.com

Checked and Approved for Public Use
(Personal Seal) Stamp to be given
in following cases: 18312, Dt. 24-08-23

TO BE READ WITH THIS OFFICE
MEMO NO. 36752
DATED: 31-10-2023

PLUMBING LEGEND-

S.NO.	SYMBOL	DISCRPTION
1	SOIL PIPE	SOIL PIPE
2	WASTE PIPE	WASTE PIPE
3	ANTI VENT PIPE	ANTI VENT PIPE
4	DOMESTIC WATER SUPPLY PIPE (MASTER DOWN COMER)	DOMESTIC WATER SUPPLY PIPE (MASTER DOWN COMER)
5	FLUSHING WATER SUPPLY PIPE (MASTER DOWN COMER)	FLUSHING WATER SUPPLY PIPE (MASTER DOWN COMER)
6A	DOMESTIC WATER SUPPLY BRANCH PIPE	DOMESTIC WATER SUPPLY BRANCH PIPE
6B	FLUSHING WATER SUPPLY BRANCH PIPE	FLUSHING WATER SUPPLY BRANCH PIPE
7	DOMESTIC WATER SUPPLY (TOP THREE FLOOR)	DOMESTIC WATER SUPPLY (TOP THREE FLOOR)
8	DOMESTIC WATER RISER FOR TOWER-A	DOMESTIC WATER RISER FOR TOWER-A
9	DOMESTIC WATER RISER FOR TOWER-B	DOMESTIC WATER RISER FOR TOWER-B
10A	FLUSHING WATER RISER FOR TOWER-A	FLUSHING WATER RISER FOR TOWER-A
10B	FLUSHING WATER RISER FOR TOWER-B	FLUSHING WATER RISER FOR TOWER-B
11A	DOMESTIC WATER HYD. SUPPLY FOR RETAIL	DOMESTIC WATER HYD. SUPPLY FOR RETAIL
11B	FLUSHING WATER HYD. SUPPLY FOR RETAIL	FLUSHING WATER HYD. SUPPLY FOR RETAIL
12	DOMESTIC WATER HYD. SUPPLY FOR EWS	DOMESTIC WATER HYD. SUPPLY FOR EWS
13	FLUSHING WATER HYD. SUPPLY FOR EWS	FLUSHING WATER HYD. SUPPLY FOR EWS
14	DOMESTIC WATER HYD. SUPPLY FOR CLUB	DOMESTIC WATER HYD. SUPPLY FOR CLUB
15	FLUSHING WATER HYD. SUPPLY FOR CLUB	FLUSHING WATER HYD. SUPPLY FOR CLUB
16	RAIN WATER PIPE	RAIN WATER PIPE
R	BACONY DRAIN PIPE	BACONY DRAIN PIPE
R1	AIR RELEASE VALVE	AIR RELEASE VALVE
ARV	BALL VALVE	BALL VALVE
BV		

ARCHITECT'S SEAL & SIGNATURE

OWNER'S SEAL & SIGNATURE

AUGUST-2023. Scale : 1:200

Drawing Title:-

Drawing No:-

BASEMENT-01

BS-01