


PLUMBING LEGEND:	
✕	BALL VALVE
▽	ARY AIR RELEASE VALVE
■	PRS PRESSURE REDUCING STATION
DWS	DOMESTIC WATER SUPPLY
FWS	FLUSHING WATER SUPPLY
FWR	FLUSHING WATER RISER
DWS	DOMESTIC WATER RISER
WC	WATER CLOSET
WB	WASH BASIN
WM	WASHING MACHINE
SINK	KITCHEN SINK
SH	SHOWER
UR	URINAL
DS	DRINKING STATION

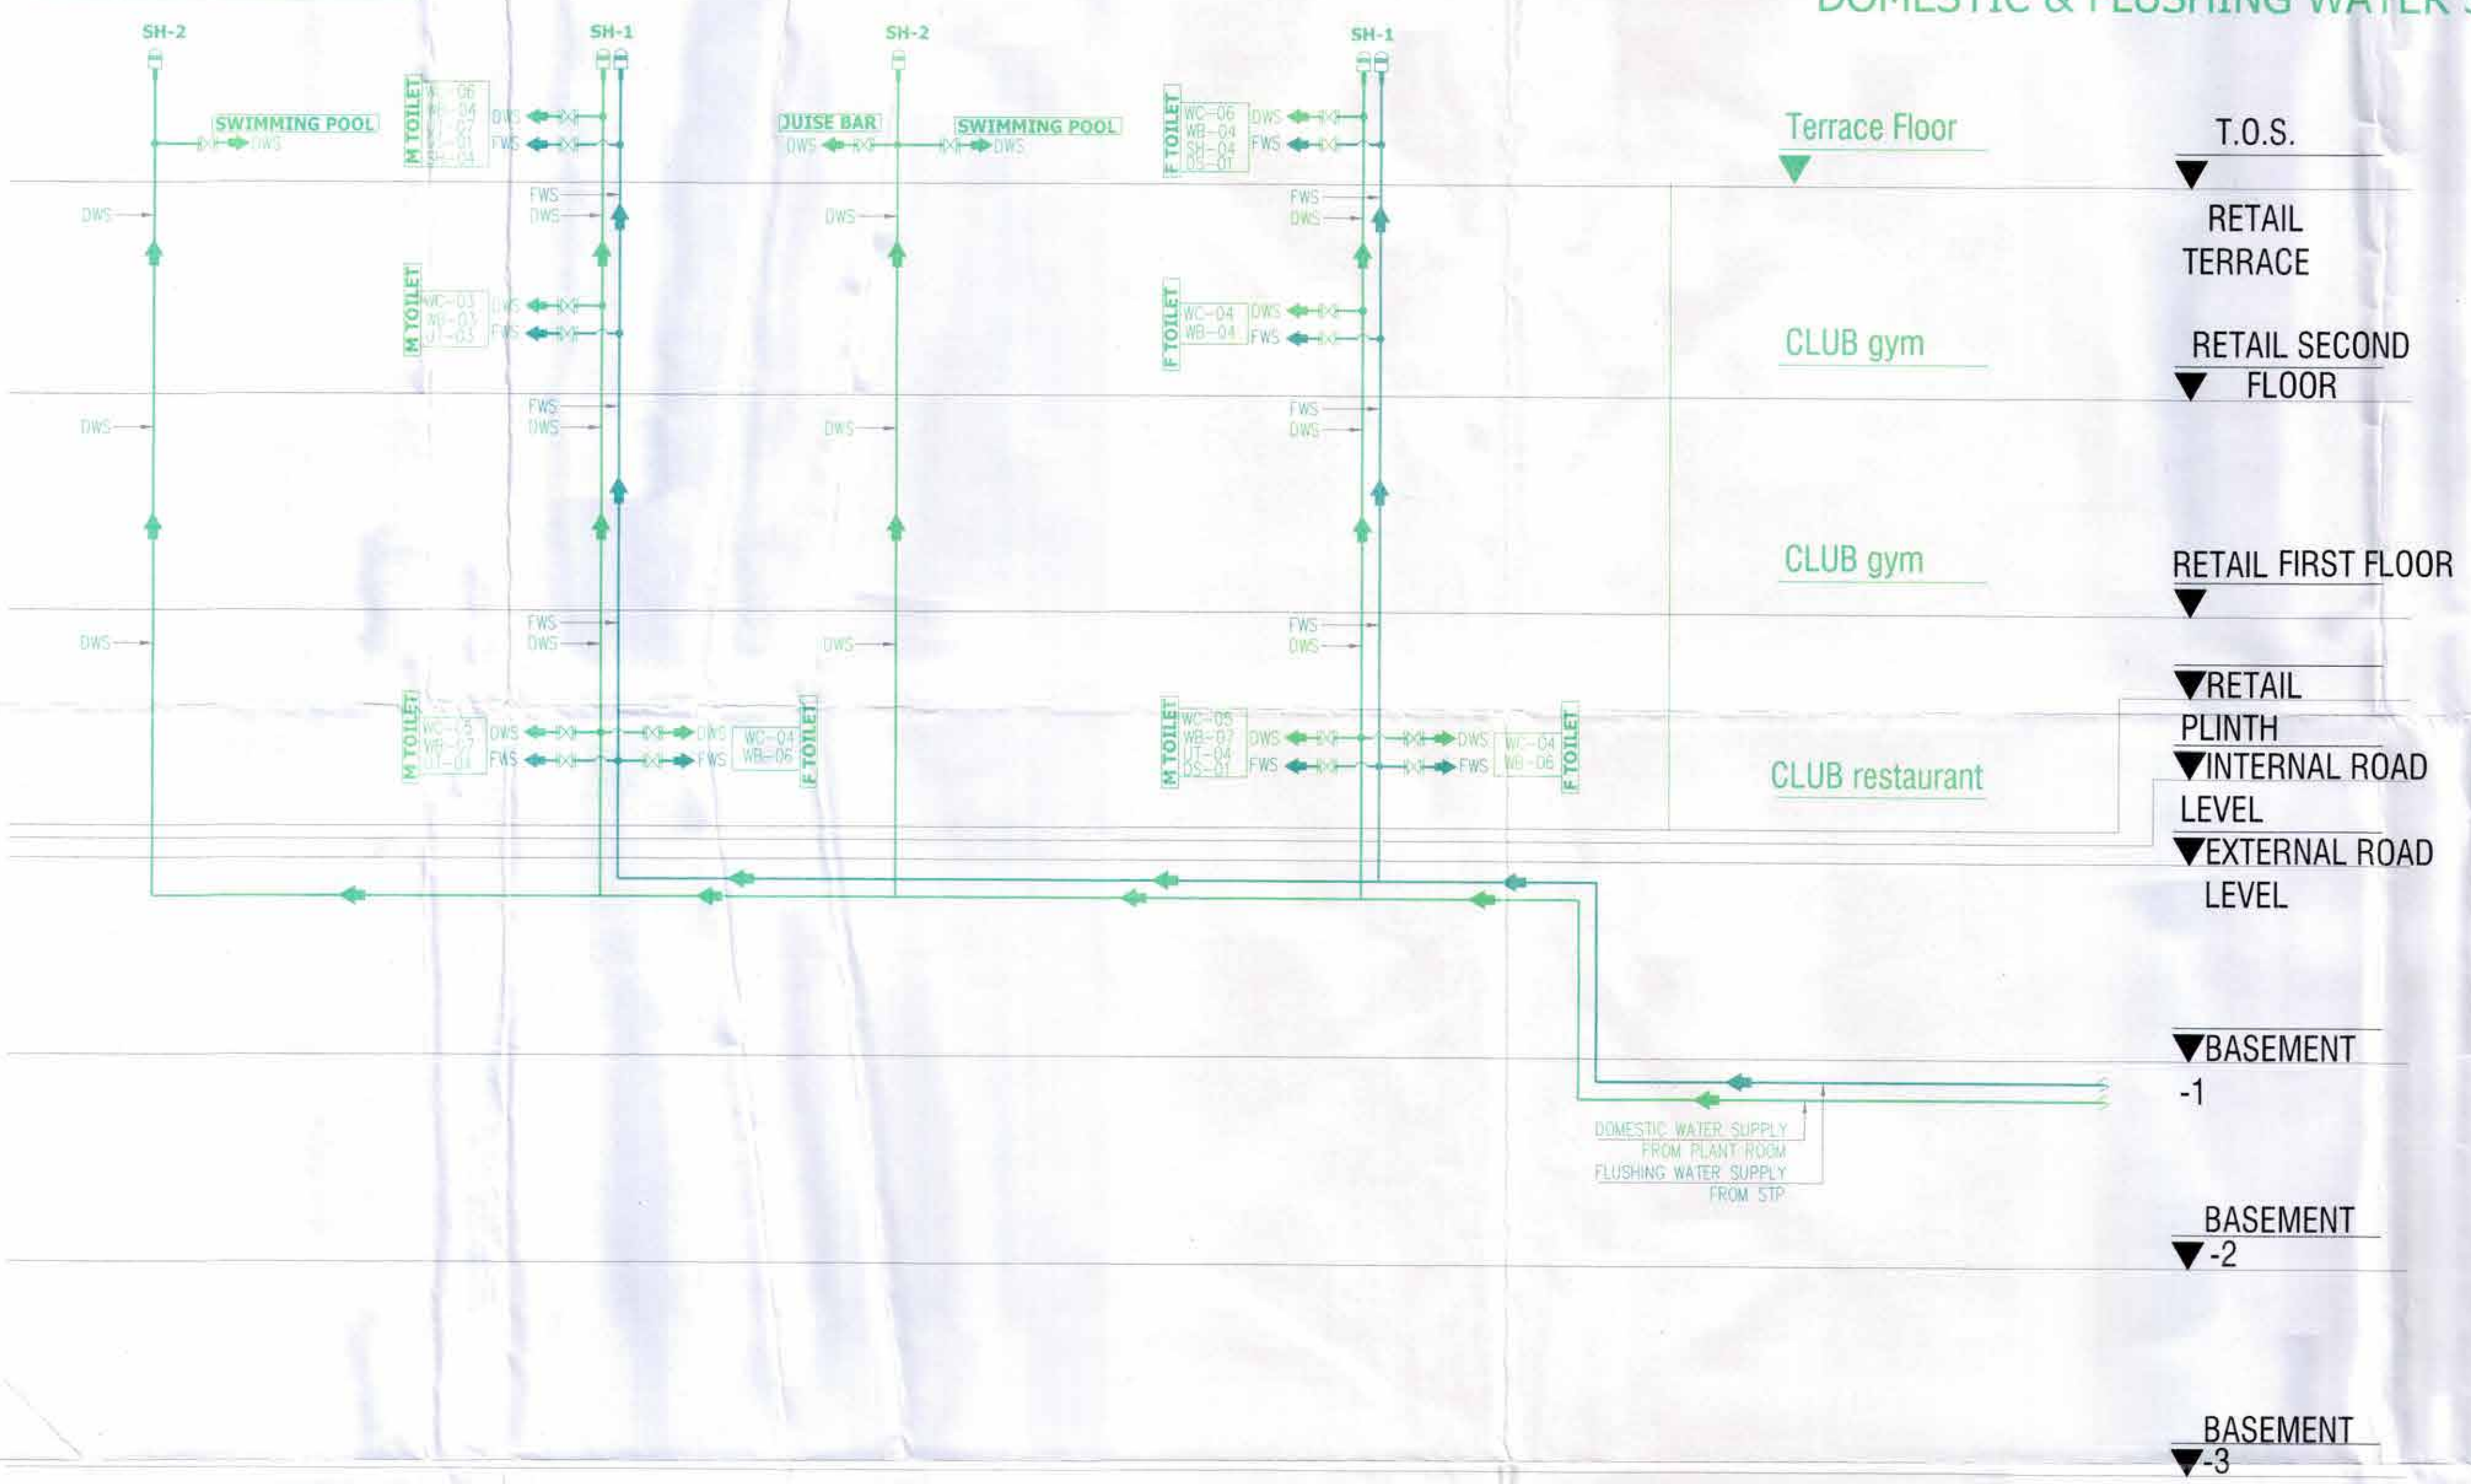

CLUB DOMESTIC & FLUSHING WATER SCHEMATIC

Checked and found ok for Public Health
(Internal) Service only subject to comments in
in forwarding letter No. 36752 Dtd 24-08-23

Supervising Engineer (H.O.)
for Chief Engineer-1
H.O. (P.W.D.)
(D.P.W.)

Note :-

1. BUILDING WILL BE DESIGNED (STRUCTURES) AS PER RELEVANT IS CODES FOR EARTH QUAKE RESISTANCE.
2. BUILDING IS HAS AUTOMATIC SPRINKLER SYSTEM ON ALL FLOORS.

LEGEND:-

STP (H.O.) STP (H.O.) STP (G) C.T.P.
Member Water Supply Member Chairman
B.P.A.C. B.P.A.C. B.P.A.C. B.P.A.C.

Consultant Architect

Ram Arjun Bhatti
JD(HQ)

JD, RA, A.T.P.

PROJECT:-

PROPOSED GROUP HOUSING COLONY UNDER
TOD POLICY (MIX LAND USE 70% RESIDENTIAL
+ 22 % COMMERCIAL) ON AN AREA MEASURING
4.84375 ACRES (LICENCE NO.114 OF 2023 DATED
2/06/2023) IN SECTOR-62, GURUGRAM MANESAR
URBAN COMPLEX BEING DEVELOPED BY MRS.
NEERU DEVI W/O LATE SH. NARESH CHAND JAIN
AND OTHER IN COLLABORATION WITH
CONSCIENT INFRASTRUCTURE PVT LTD.

Associate Architects

RISIMS
ARCHITECTS

RSMS ARCHITECTS PVT. LTD.
69,Nora Niwas, Bhawani Kunj
(Behind D2), Vasant Kunj,
New Delhi-110070.
Tel.: 011-26898616,26898617
www.rsms-arch.com

SANCTIONED
TO BE READ WITH THIS OFFICE
MEMO NO. 36752
DATED: 31-10-2023

ARCHITECT'S SEAL & SIGNATURE

OWNER'S SEAL & SIGNATURE

AUGUST.-2023, Scale : NTS

Drawing Title:- DOMESTIC & FLUSHING WATER SUPPLY SCHEMATIC (CLUB)

Drawing No:- SLD-06