


Note :-

1. BUILDING WILL BE DESIGNED (STRUCTURES)AS PER RELEVANT IS CODES FOR EARTH QUAKE RESISTANCE.
2. BUILDING IS HAS AUTOMATIC SPRINKLER SYSTEM ON ALL FLOORS.

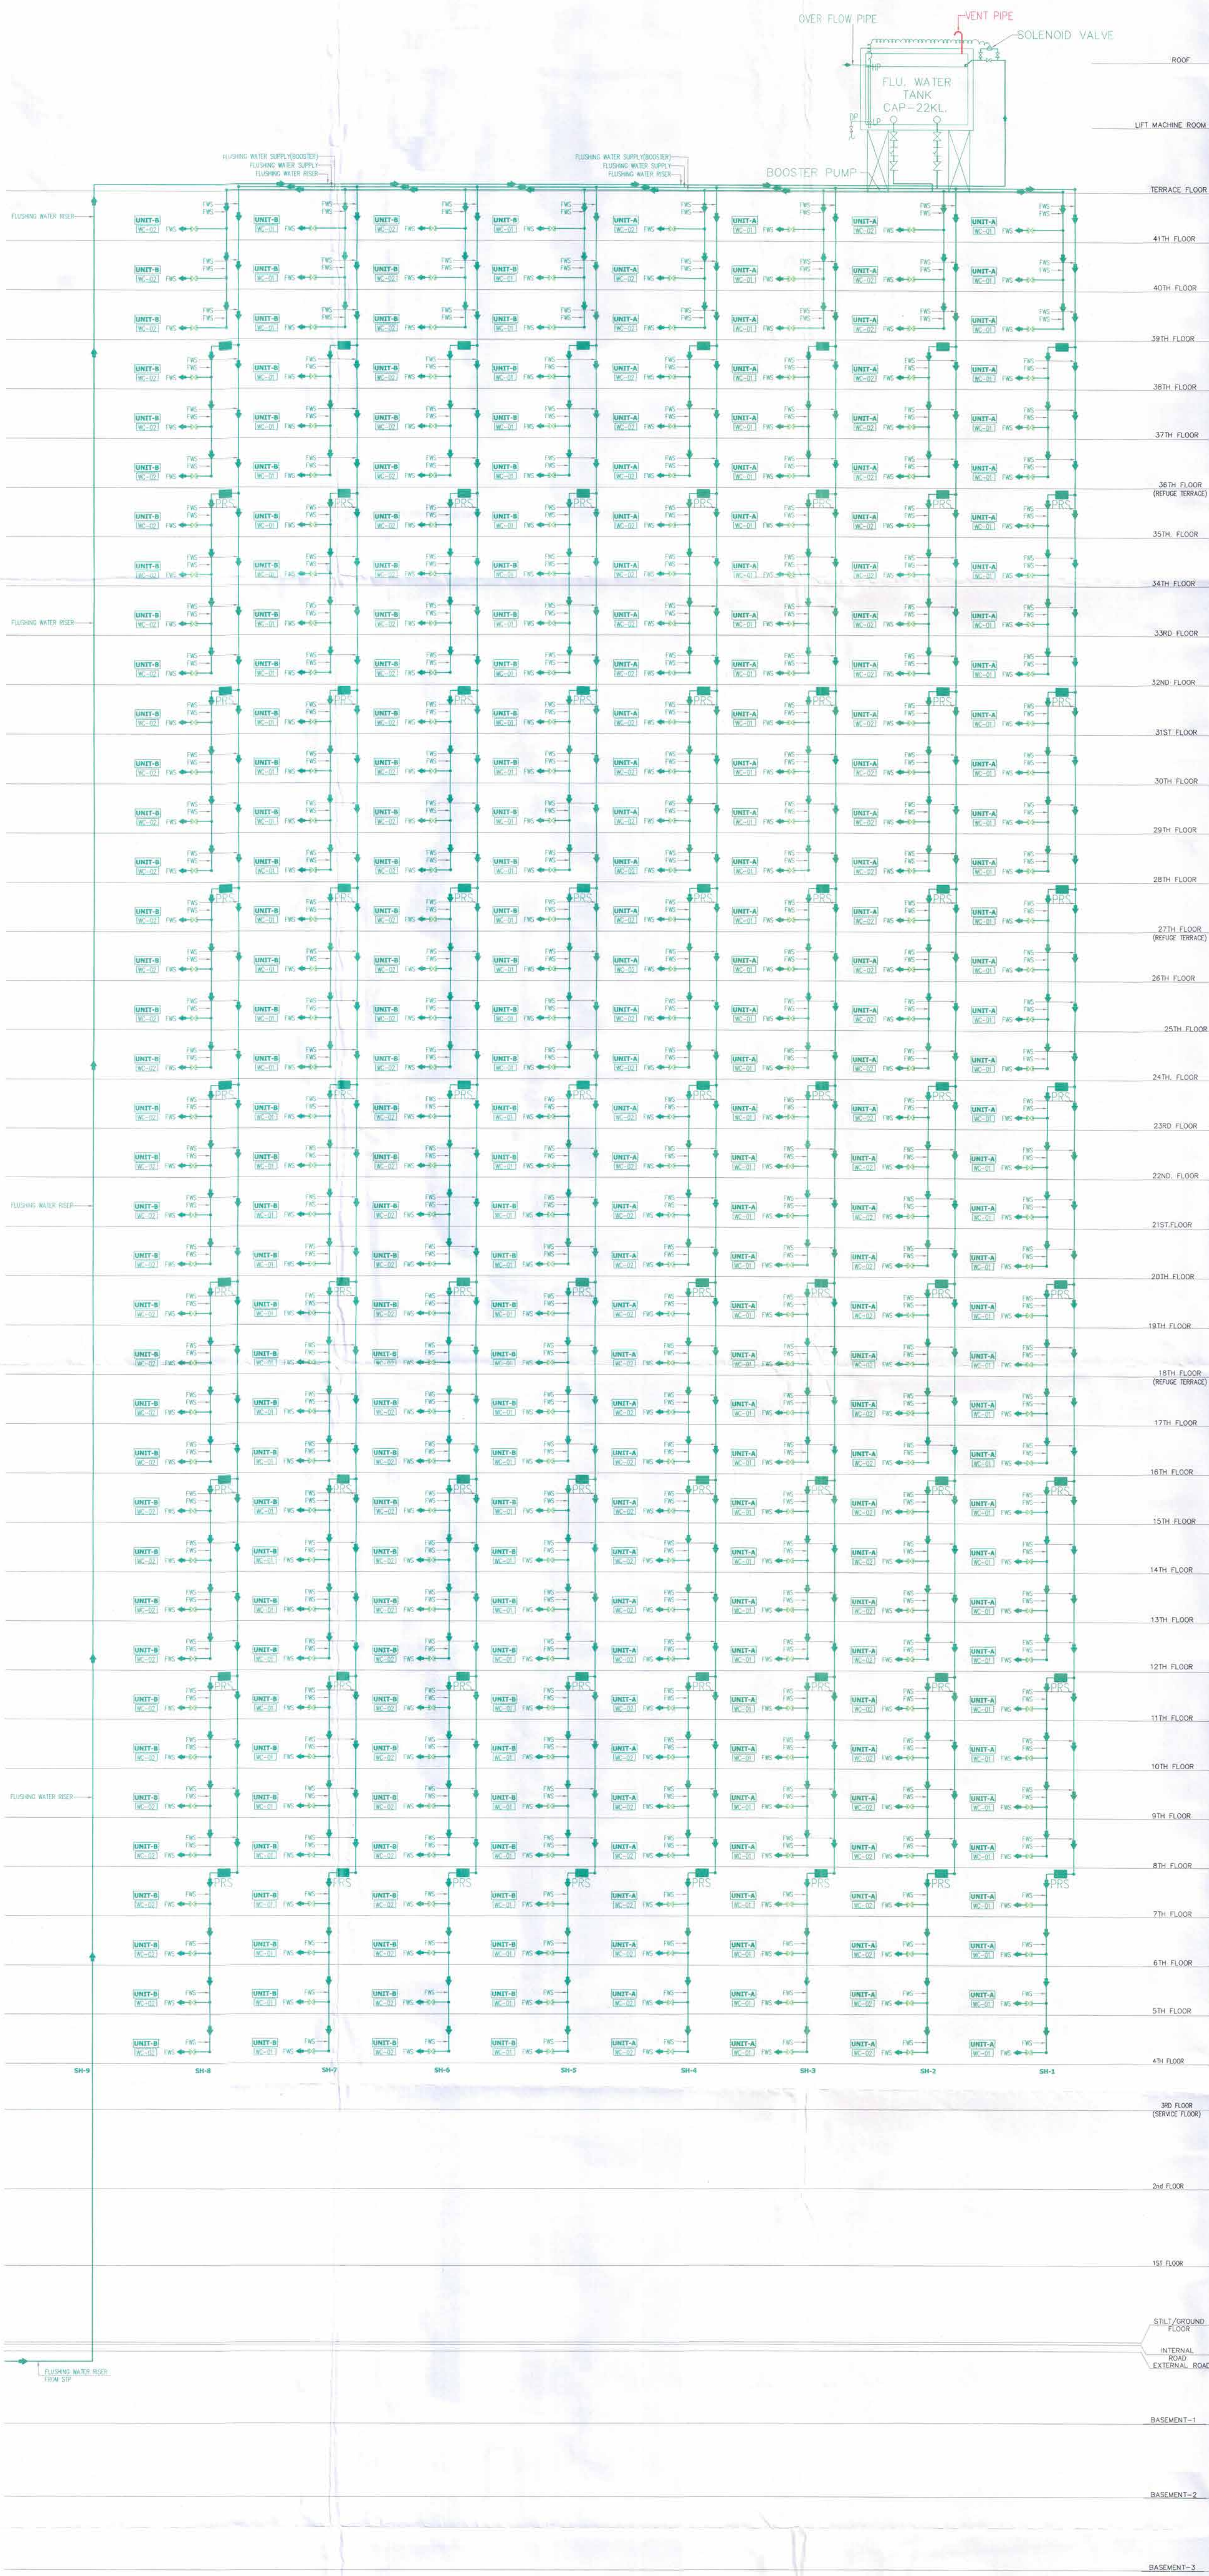

## TOWER-B FLUSHING WATER SCHEMATIC

| PLUMBING LEGEND |                         |
|-----------------|-------------------------|
| 1/2"            | BALL VALVE              |
| 1/2"            | AIR RELEASE VALVE       |
| 1/2"            | PRESSURE REDUCING VALVE |
| 1/2"            | WATER SUPPLY            |
| 1/2"            | FLUSHING WATER SUPPLY   |
| 1/2"            | FLUSHING WATER BRICK    |
| 1/2"            | WATER CLOSET            |
| 1/2"            | WASH BASIN              |
| 1/2"            | WASHING MACHINE         |
| 1/2"            | KITCHEN SINK            |
| 1/2"            | SHOWER                  |
| 1/2"            | URINAL                  |
| 1/2"            | DRAINAGE                |

### PROJECT:-

PROPOSED GROUP HOUSING COLONY UNDER TOD POLICY (MIX LAND USE 78% RESIDENTIAL + 22 % COMMERCIAL) ON AN AREA MEASURING 4.84375 ACRES (LICENCE NO.114 OF 2023 DATED 2/08/2023) IN SECTOR-62, GURUGRAM MANESAR URBAN COMPLEX BEING DEVELOPED BY MRS. NEERU DEVI W/O LATE SH. NARESH CHAND JAIN AND OTHER IN COLLABORATION WITH CONSCIENT INFRASTRUCTURE PVT LTD.

Associate Architects

**RISMS**  
ARCHITECTS

RSMS ARCHITECTS PVT. LTD.  
69,Nora Niwas, Bhawani Kunj  
(Behind D2), Vasant Kunj,  
New Delhi-110070.  
Tel.: 011-26898616,26898617  
www.rsms-arch.com

Checked and found ok for Public Health  
(Internal) Services and subject to comments in  
in forwarding letter to 123456789-123  
10/08/23

Sanctioned  
10/08/23  
123456789-123

|                                 |                          |
|---------------------------------|--------------------------|
| ARCHITECT'S SEAL & SIGNATURE    | OWNER'S SEAL & SIGNATURE |
|                                 |                          |
| AUGUST-2023.                    | Scale : NTS              |
| Drawing Title:-                 | Drawing No:-             |
| FLUSHING WATER SUPPLY SCHEMATIC | SLD-02                   |