


Note :-

1. BUILDING WILL BE DESIGNED (STRUCTURES) AS PER RELEVANT IS CODES FOR EARTH QUAKE RESISTANCE.
2. BUILDING HAS AUTOMATIC SPRINKLER SYSTEM ON ALL FLOORS.
3. CLUB AND RETAIL ARE ARTIFICIALLY LIGHTED MECHANICALLY VENTILATED & AIRCONDITIONED WITH 100% POWER BACKUP.
4. TOILETS ARE ARTIFICIALLY LIGHTED, MECHANICALLY VENTILATED & HAVE 100% POWER BACKUP (TOWER-A & B)

LEGEND: —

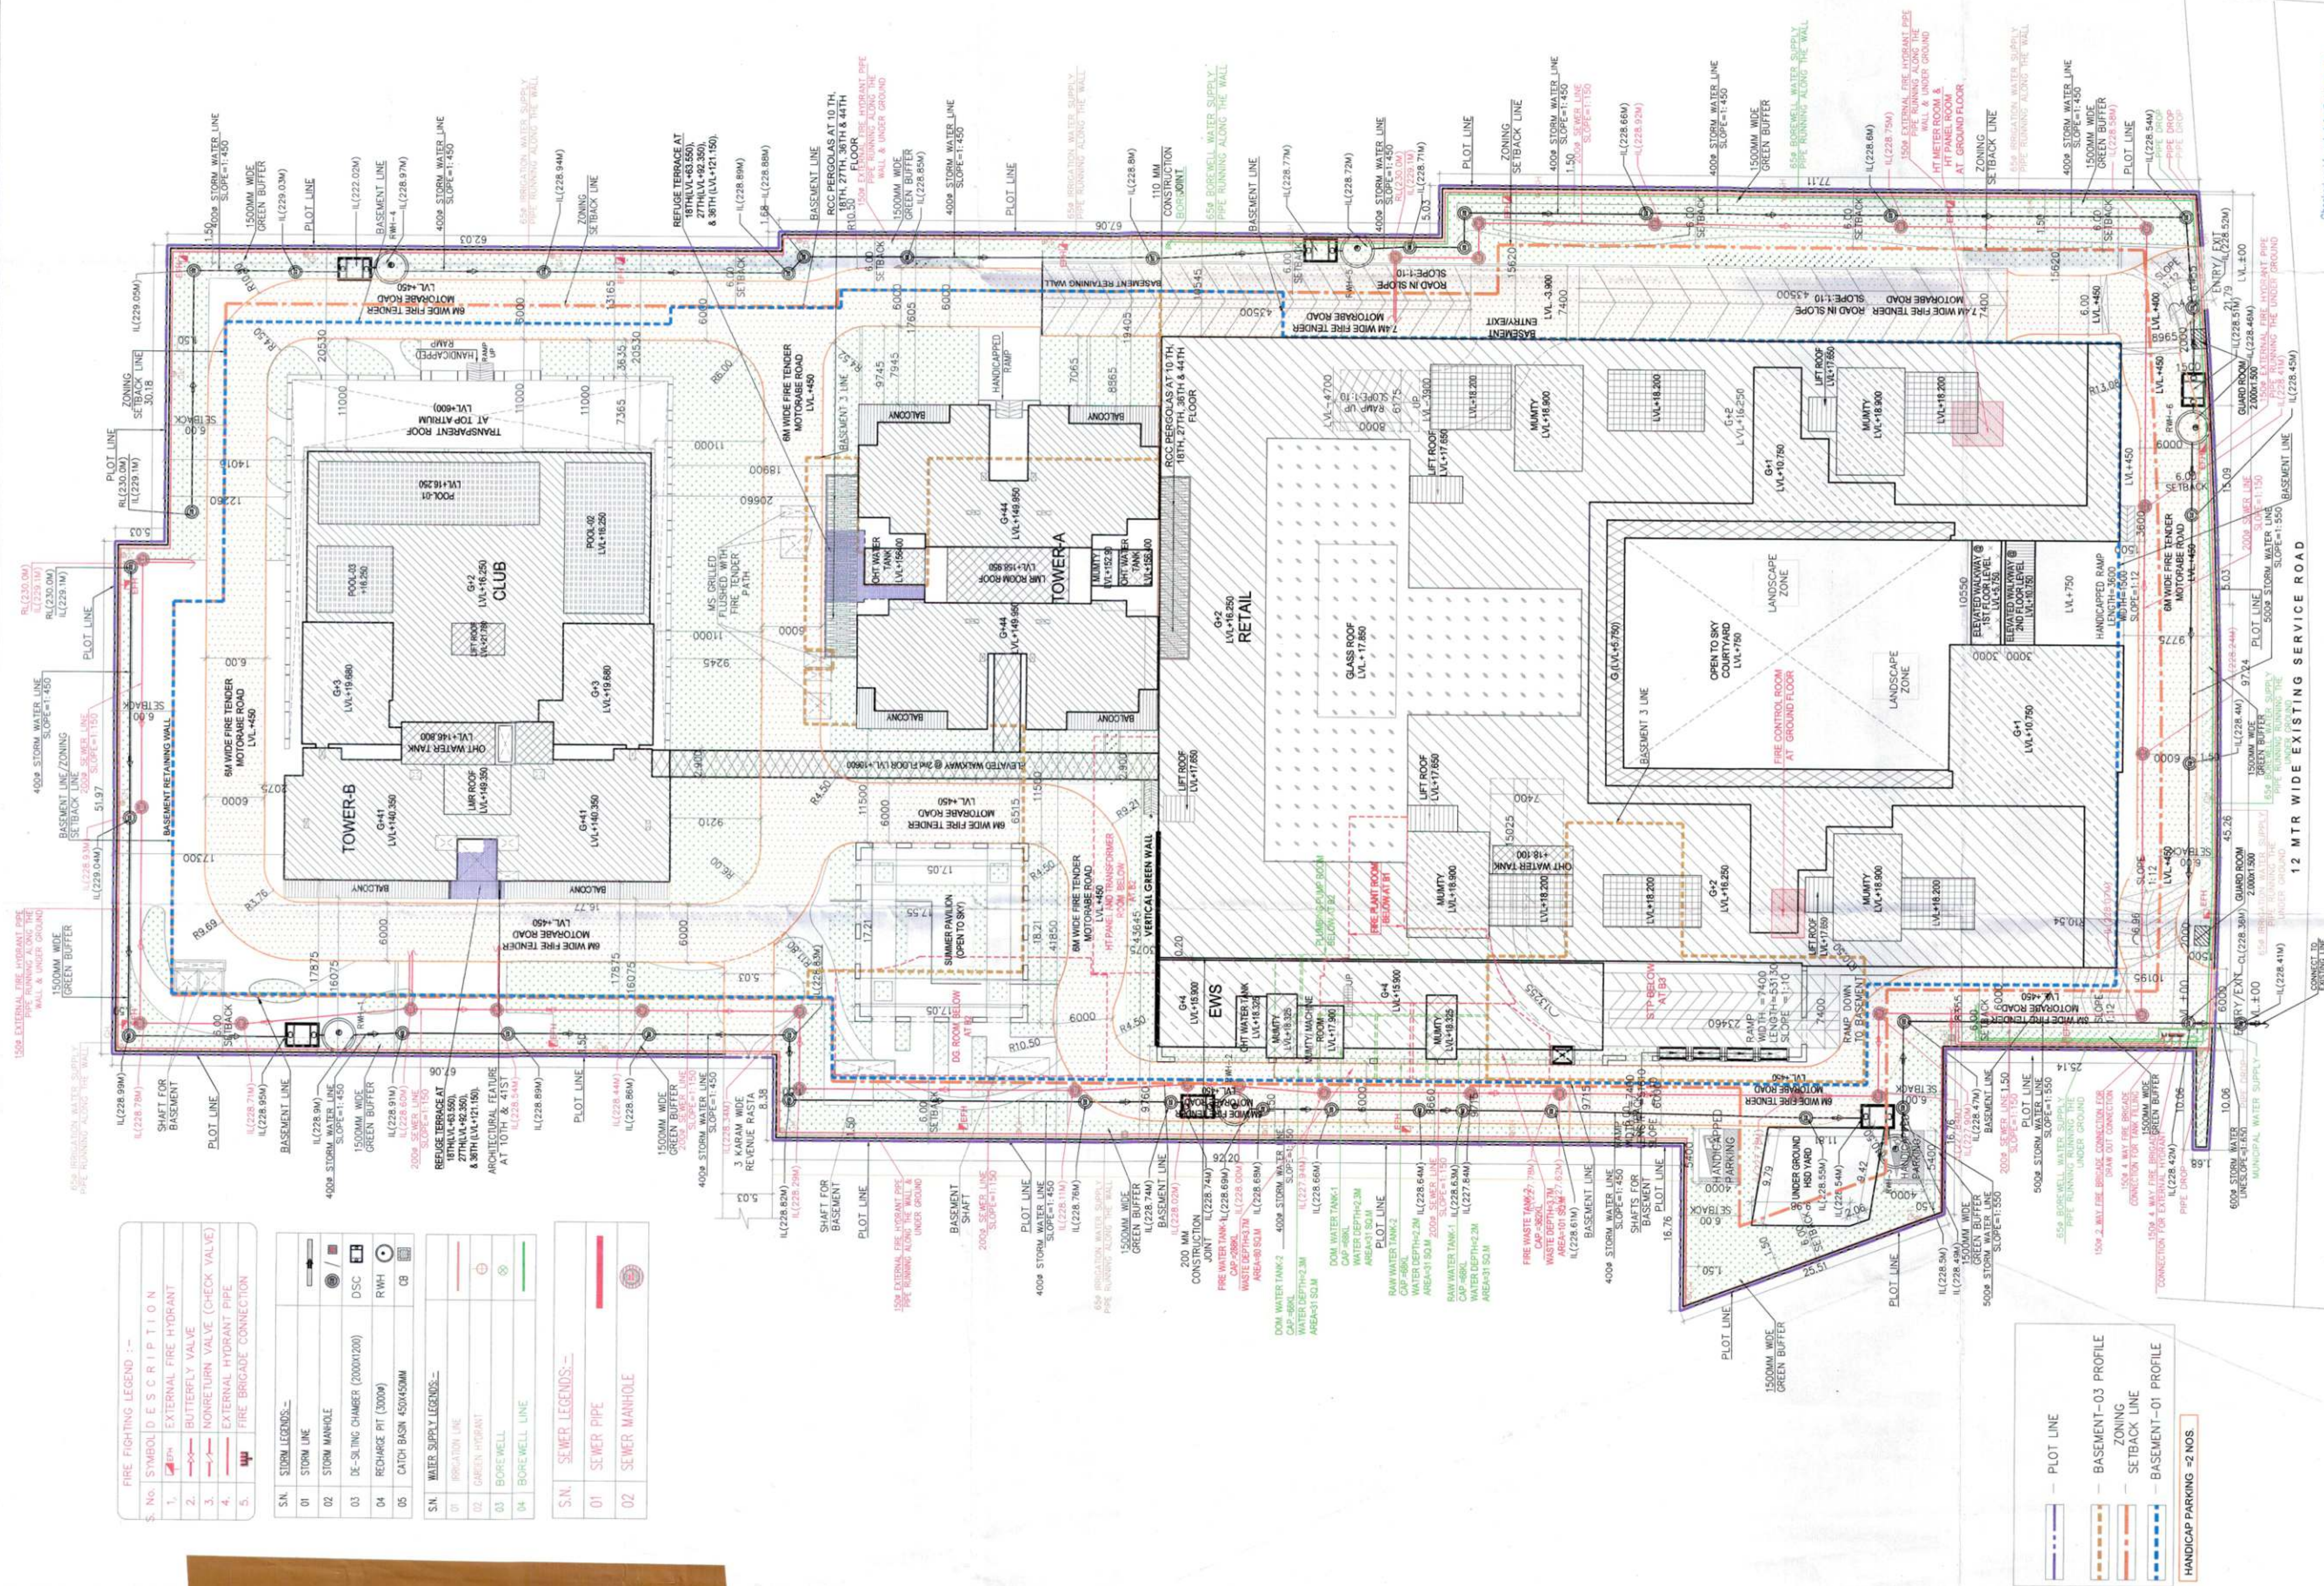

Checked and found ok for Public Health
(Internal) Service only subject to comments in
in forwarding letter No. 183432-Dv... 24-08-23

SANCTIONED
TO BE READ WITH THIS OFFICE
MEMO NO.: 36752
DATED: 31-10-2023

60 MTR WIDE EXISTING SECTOR ROAD

SECTOR-61

PROJECT:- PROPOSED GROUP HOUSING COLONY UNDER
TOD POLICY (MIX LAND USE 78% RESIDENTIAL
+ 22% COMMERCIAL) ON AN AREA MEASURING
84375 ACRES (LICENCE NO.114 OF 2023 DATED
06/08/2023) IN SECTOR-62, GURUGRAM MANESAR
URBAN COMPLEX BEING DEVELOPED BY MRS.
VEERU DEVI W/O LATE SH. NARESH CHAND JAIN
AND OTHER IN COLLABORATION WITH
CONSIENT INFRASTRUCTURE PVT LTD.

Associate Architects

RES|M|S
ARCHITECTS

RMS ARCHITECTS PVT. LTD.
69, Nora Niwas Bhawani Kunj
(Behind D2), Vasant Kunj,
New Delhi-110070.
Tel.: 011-26898616, 26898617
www.rsms-arch.com

— PLOT LINE
 — BASEMENT-03 PROFILE
 — ZONING
 — SETBACK LINE
 — BASEMENT-01 PROFILE

HANDICAP PARKING = 2 NOS.

OWNER'S SEAL & SIGNATURE	
ARCHITECT'S SEAL & SIGNATURE	

AUGUST, -2023.	Scale : 1:300	SITE PLAN ((IRRIGATION LINE,EXTERNAL FIRE LINE,WATER SUPPLY LINE, SEWAGE SCHEME, STORM WATER SCHEME)	Drawing No:- ST-02
Drawing Title: -			