

- Note :-
1. BUILDING WILL BE DESIGNED (STRUCTURES) AS PER PRESENT IS CODES FOR EARTH QUAKE RESISTANCE.
 2. BUILDING HAS AUTOMATIC SPRINKLER SYSTEM ON ALL FLOORS.
 3. CLUB AND RETAIL ARE ARTIFICIALLY LIGHTED MECHANICALLY VENTILATED & POWER BACKUP.
 4. TOILETS ARE ARTIFICIALLY LIGHTED, MECHANICALLY VENTILATED & HAVE 100% POWER BACKUP (TOWER-A & B)

LEGEND:-

PROJECT:-
PROPOSED GROUP HOUSING COLONY UNDER
TOD POLICY (MIX LAND USE 78% RESIDENTIAL
+ 22 % COMMERCIAL) ON AN AREA MEASURING
4.84375 ACRES (LICENSE NO.114 OF 2023 DATED
2008/2023) IN SECTOR-62, GURUGRAM MANESAR
URBAN COMPLEX BEING DEVELOPED BY MRS.
NEERU DEVI W/O LATE SH. NARESH CHAND JAIN
AND OTHER IN COLLABORATION WITH
CONSIST INFRASTRUCTURE PVT. LTD.

Associate Architects


RISIMIS
ARCHITECTS

RSMS ARCHITECTS PVT. LTD.
69,Nora Niwas Bhawan Kunj
(Behind D2), Vasant Kunj,
New Delhi-110070.
Tel: 011-26899616,26899617
www.rsms-arch.com

[Signature]
Architect
ATP(HQ)
Ravi Aarav Basal
JD(HQ)
Member
BPAAC
BPAAC

OWNER'S SEAL
& SIGNATURE
OWNER'S SEAL
& SIGNATURE

AUGUST - 2023. Scale : 1:100
Drawing Title:-
4TH TO 10TH FLOOR PLAN
(4TH TO 10TH FLOOR TO 10TH TO 26TH)
28TH TO 35TH FLOOR TO 43RD
REFER ONLY FOR CIRCULAR DIMENSION
(TYPICAL UNIT CARPET AREA)
(TOWER-A)

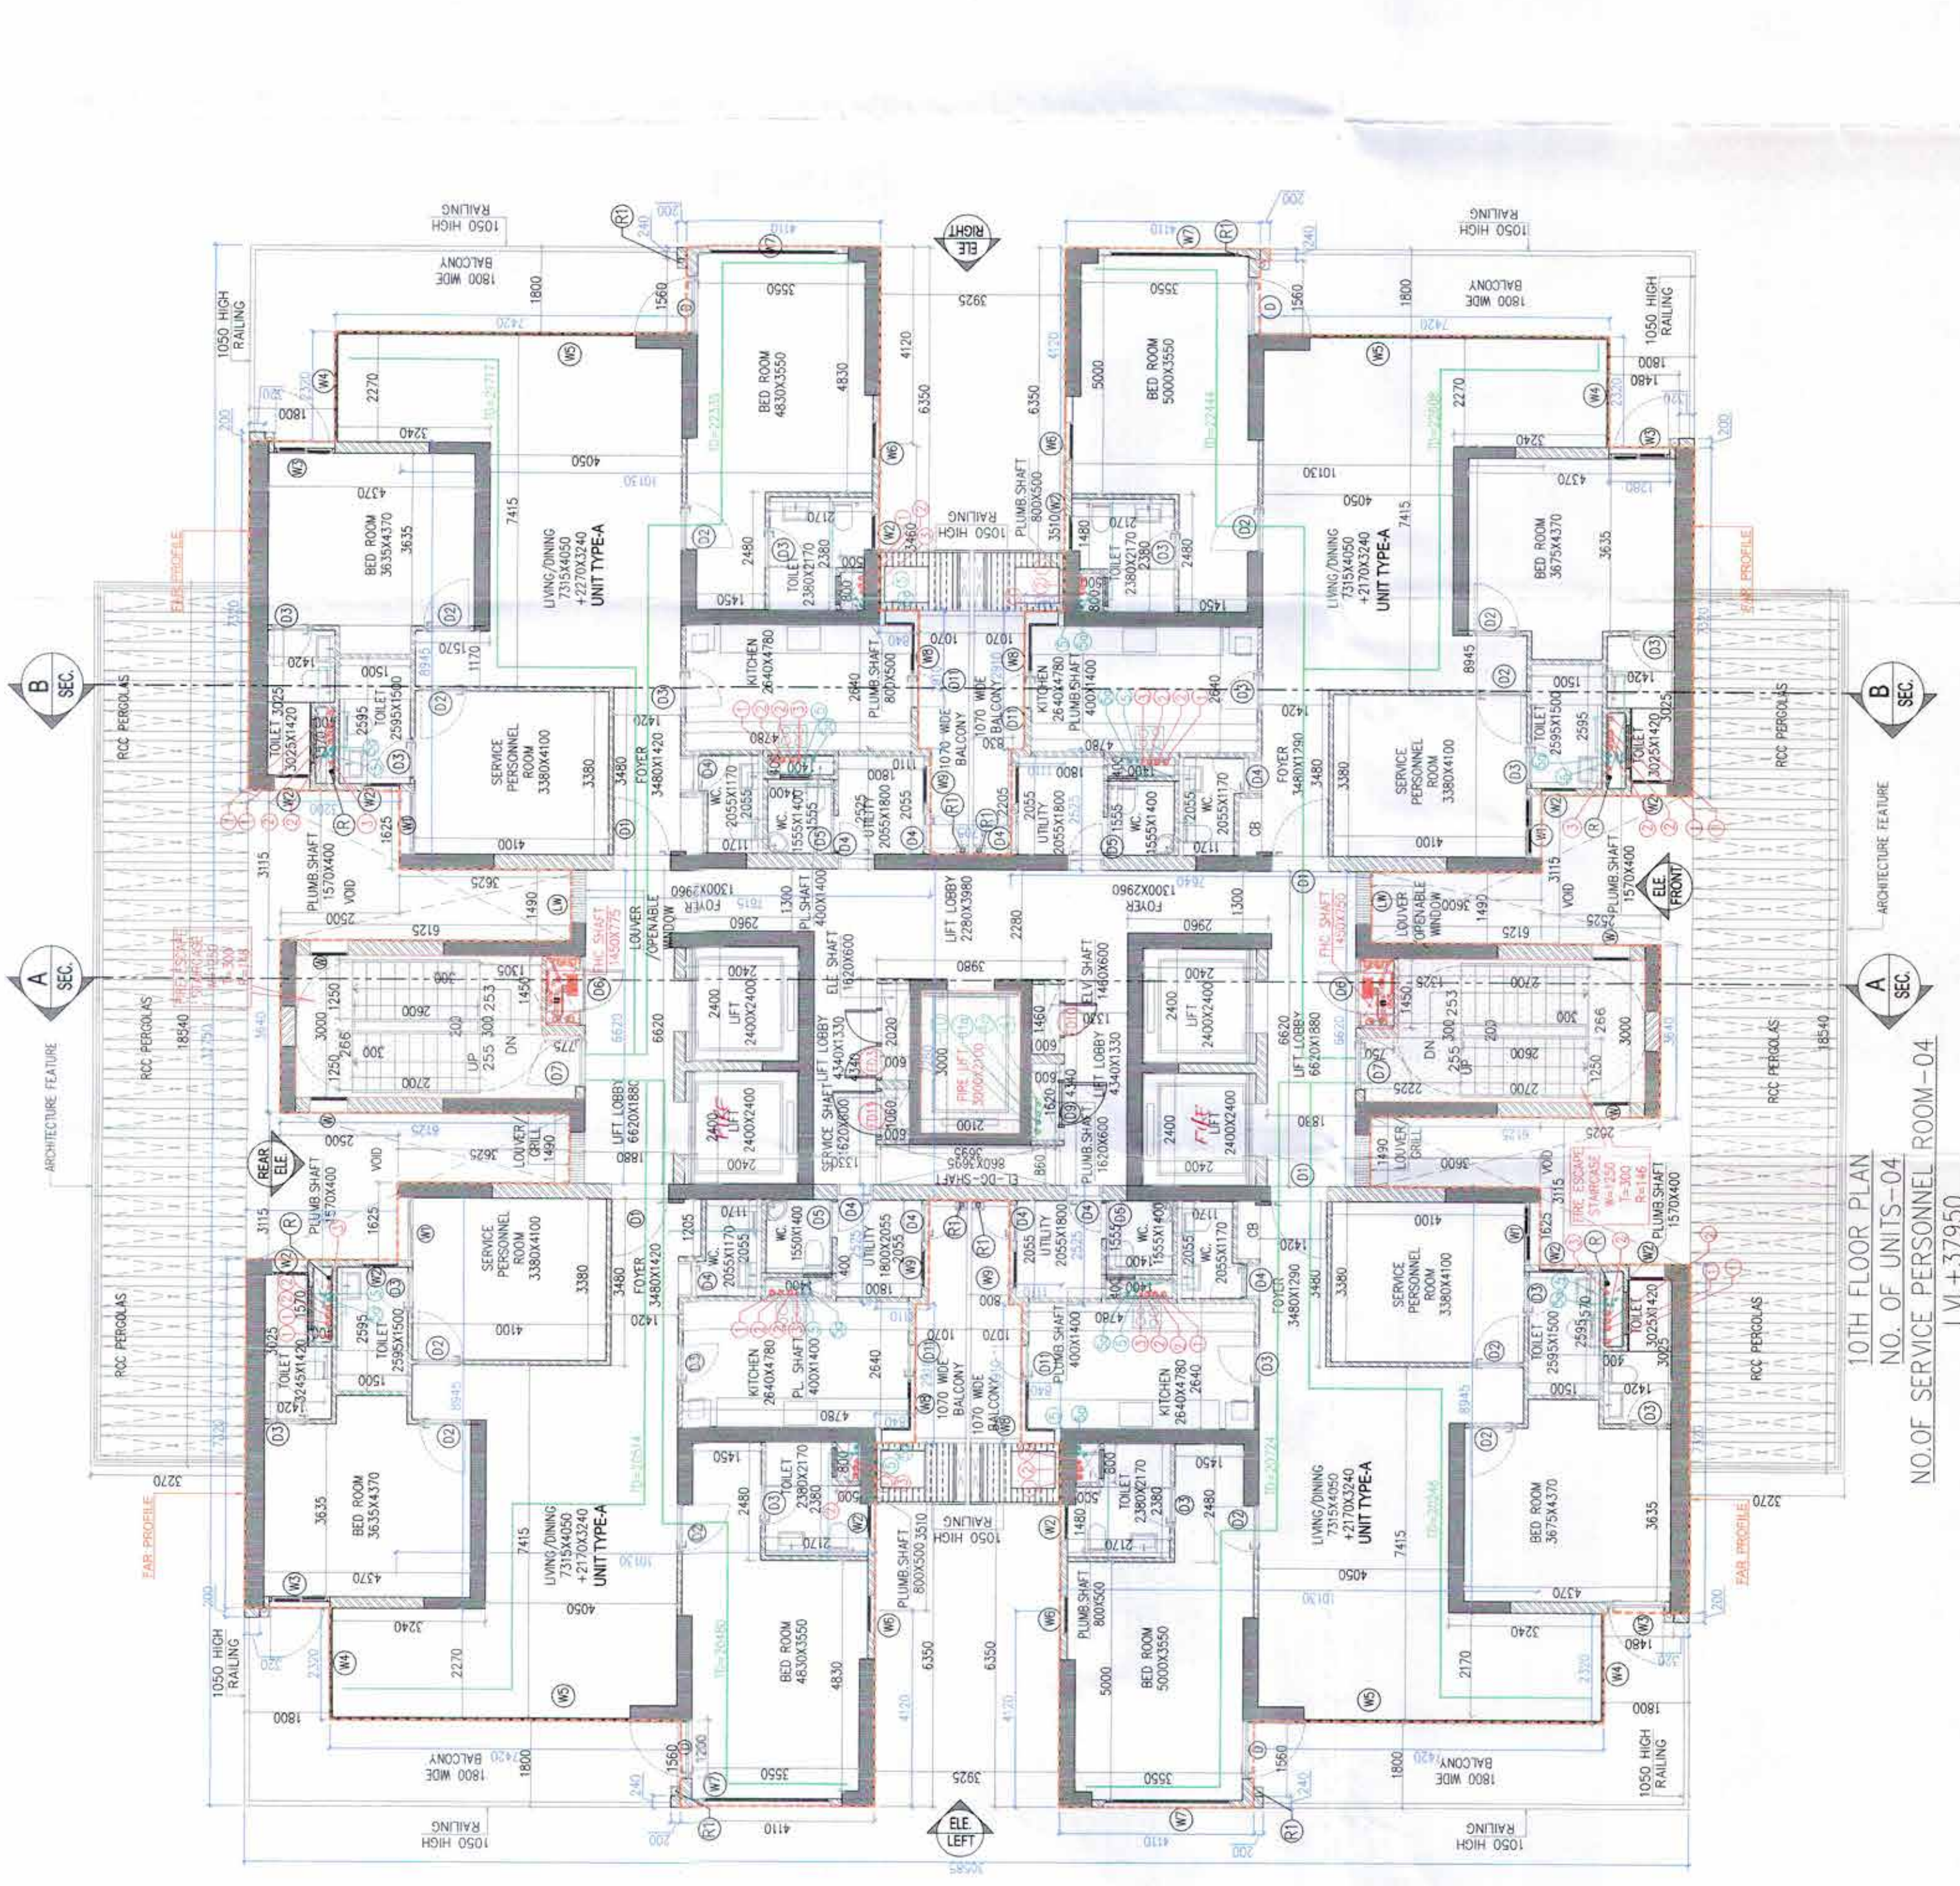


10TH FLOOR PLAN
NO. OF UNITS-04
NO. OF SERVICE PERSONNEL ROOM-04
LV+37950
(TOWER-A)


SYMBOL	DESCRIPTION
1	WATER PIPE
2	WATER PIPE
3	WATER PIPE
100	WATER PIPE

NO.	DESCRIPTION	LOCATION
1	WATER PIPE	TOWER A, 10TH FLOOR
2	WATER PIPE	TOWER A, 10TH FLOOR
3	WATER PIPE	TOWER A, 10TH FLOOR
100	WATER PIPE	TOWER A, 10TH FLOOR


NO.	DESCRIPTION	LOCATION
1	WATER PIPE	TOWER A, 10TH FLOOR
2	WATER PIPE	TOWER A, 10TH FLOOR
3	WATER PIPE	TOWER A, 10TH FLOOR
100	WATER PIPE	TOWER A, 10TH FLOOR

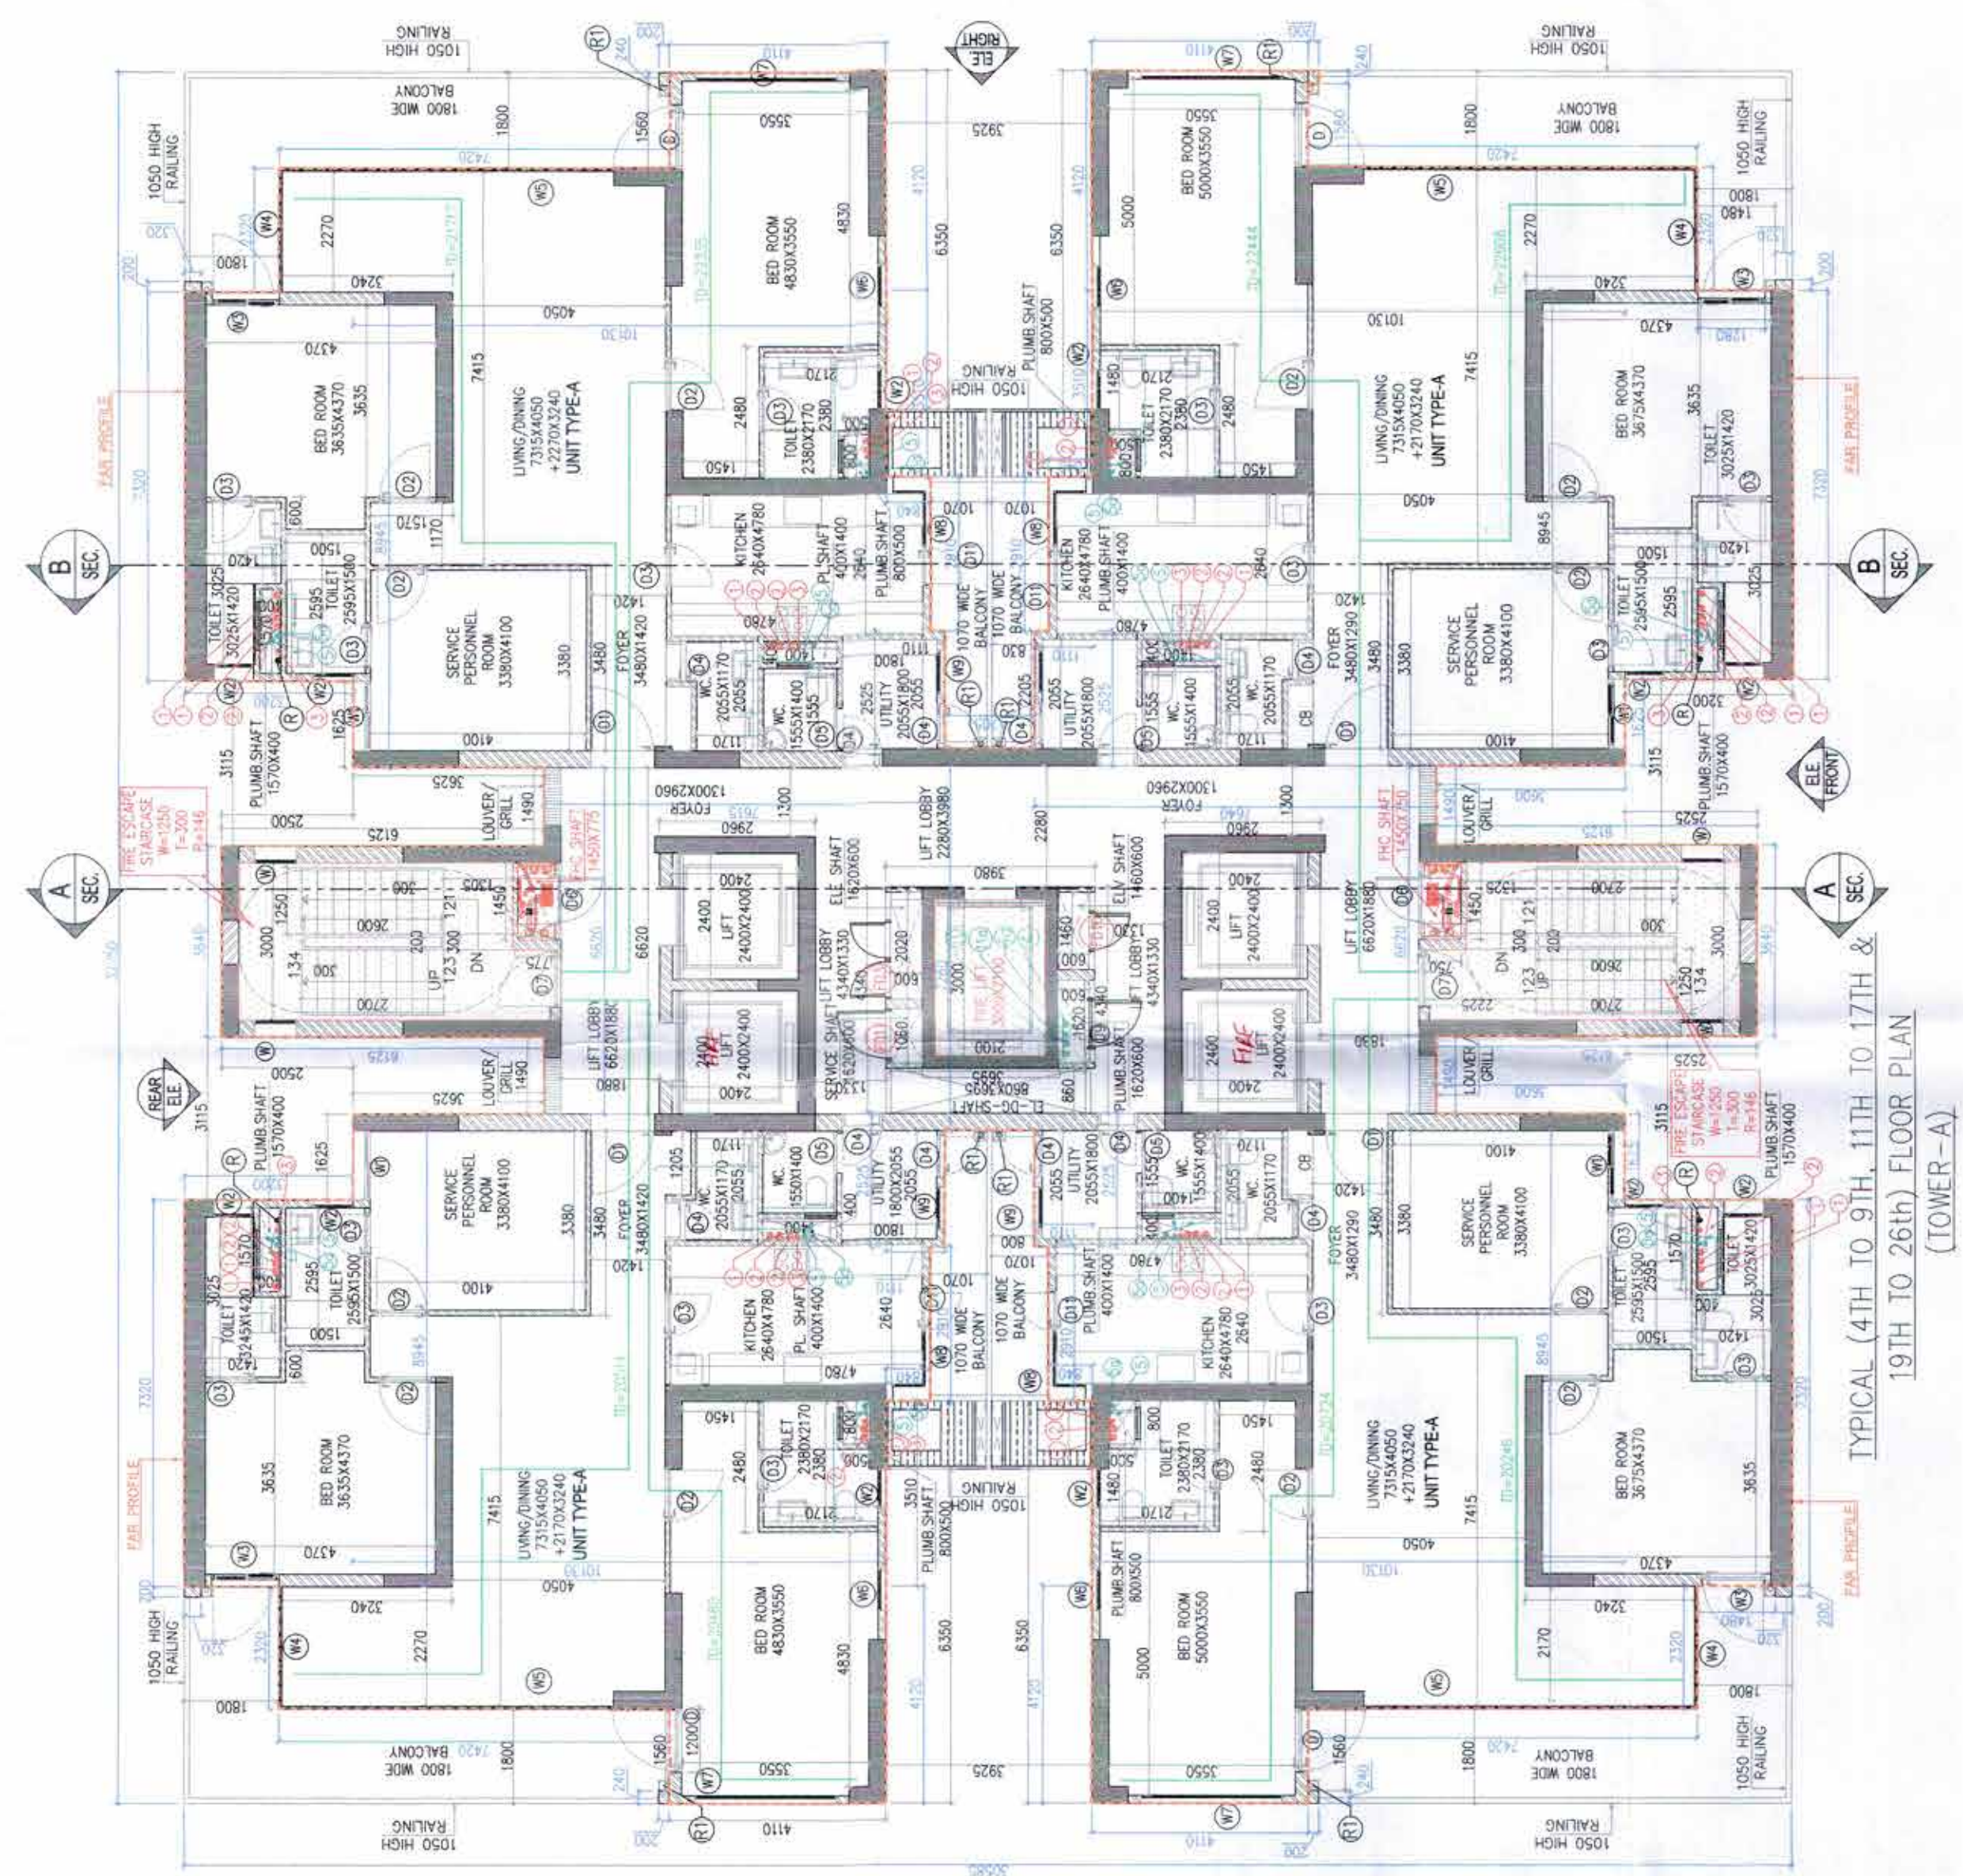


TYPICAL 19TH TO 26TH FLOOR PLAN
(TOWER-A)

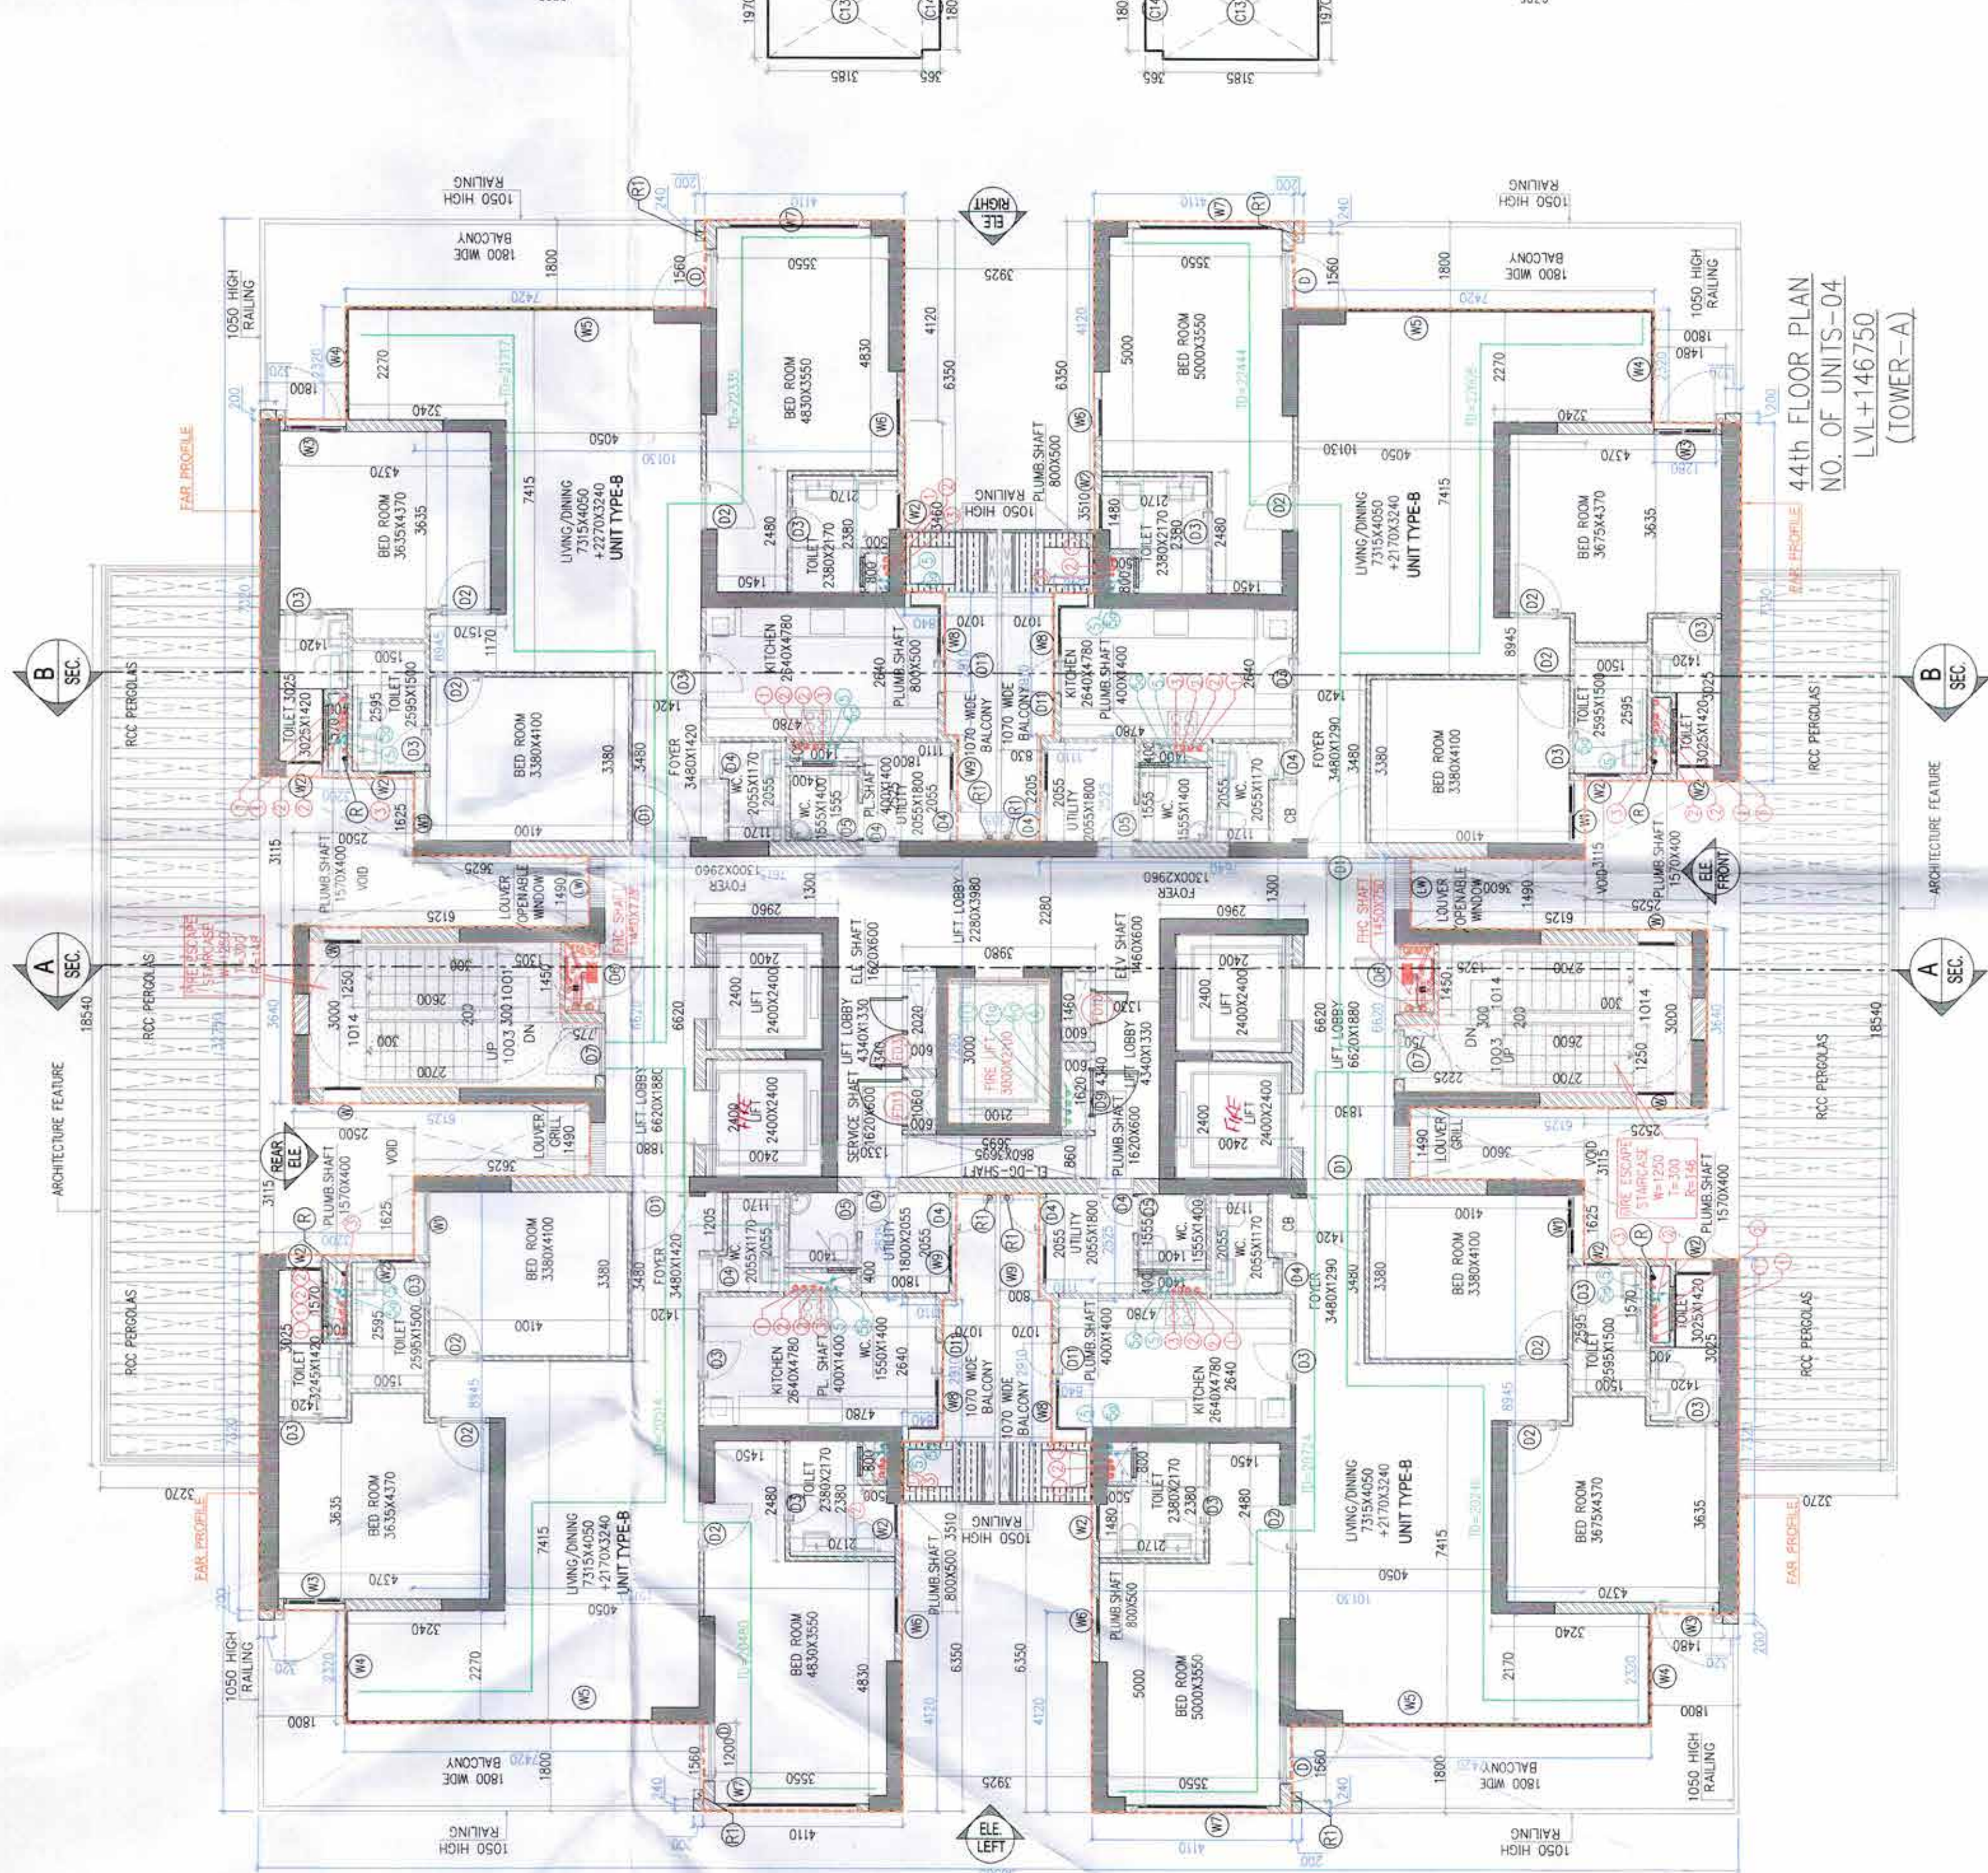

44TH FLOOR PLAN
NO. OF UNITS-04
LV+146750
(TOWER-A)

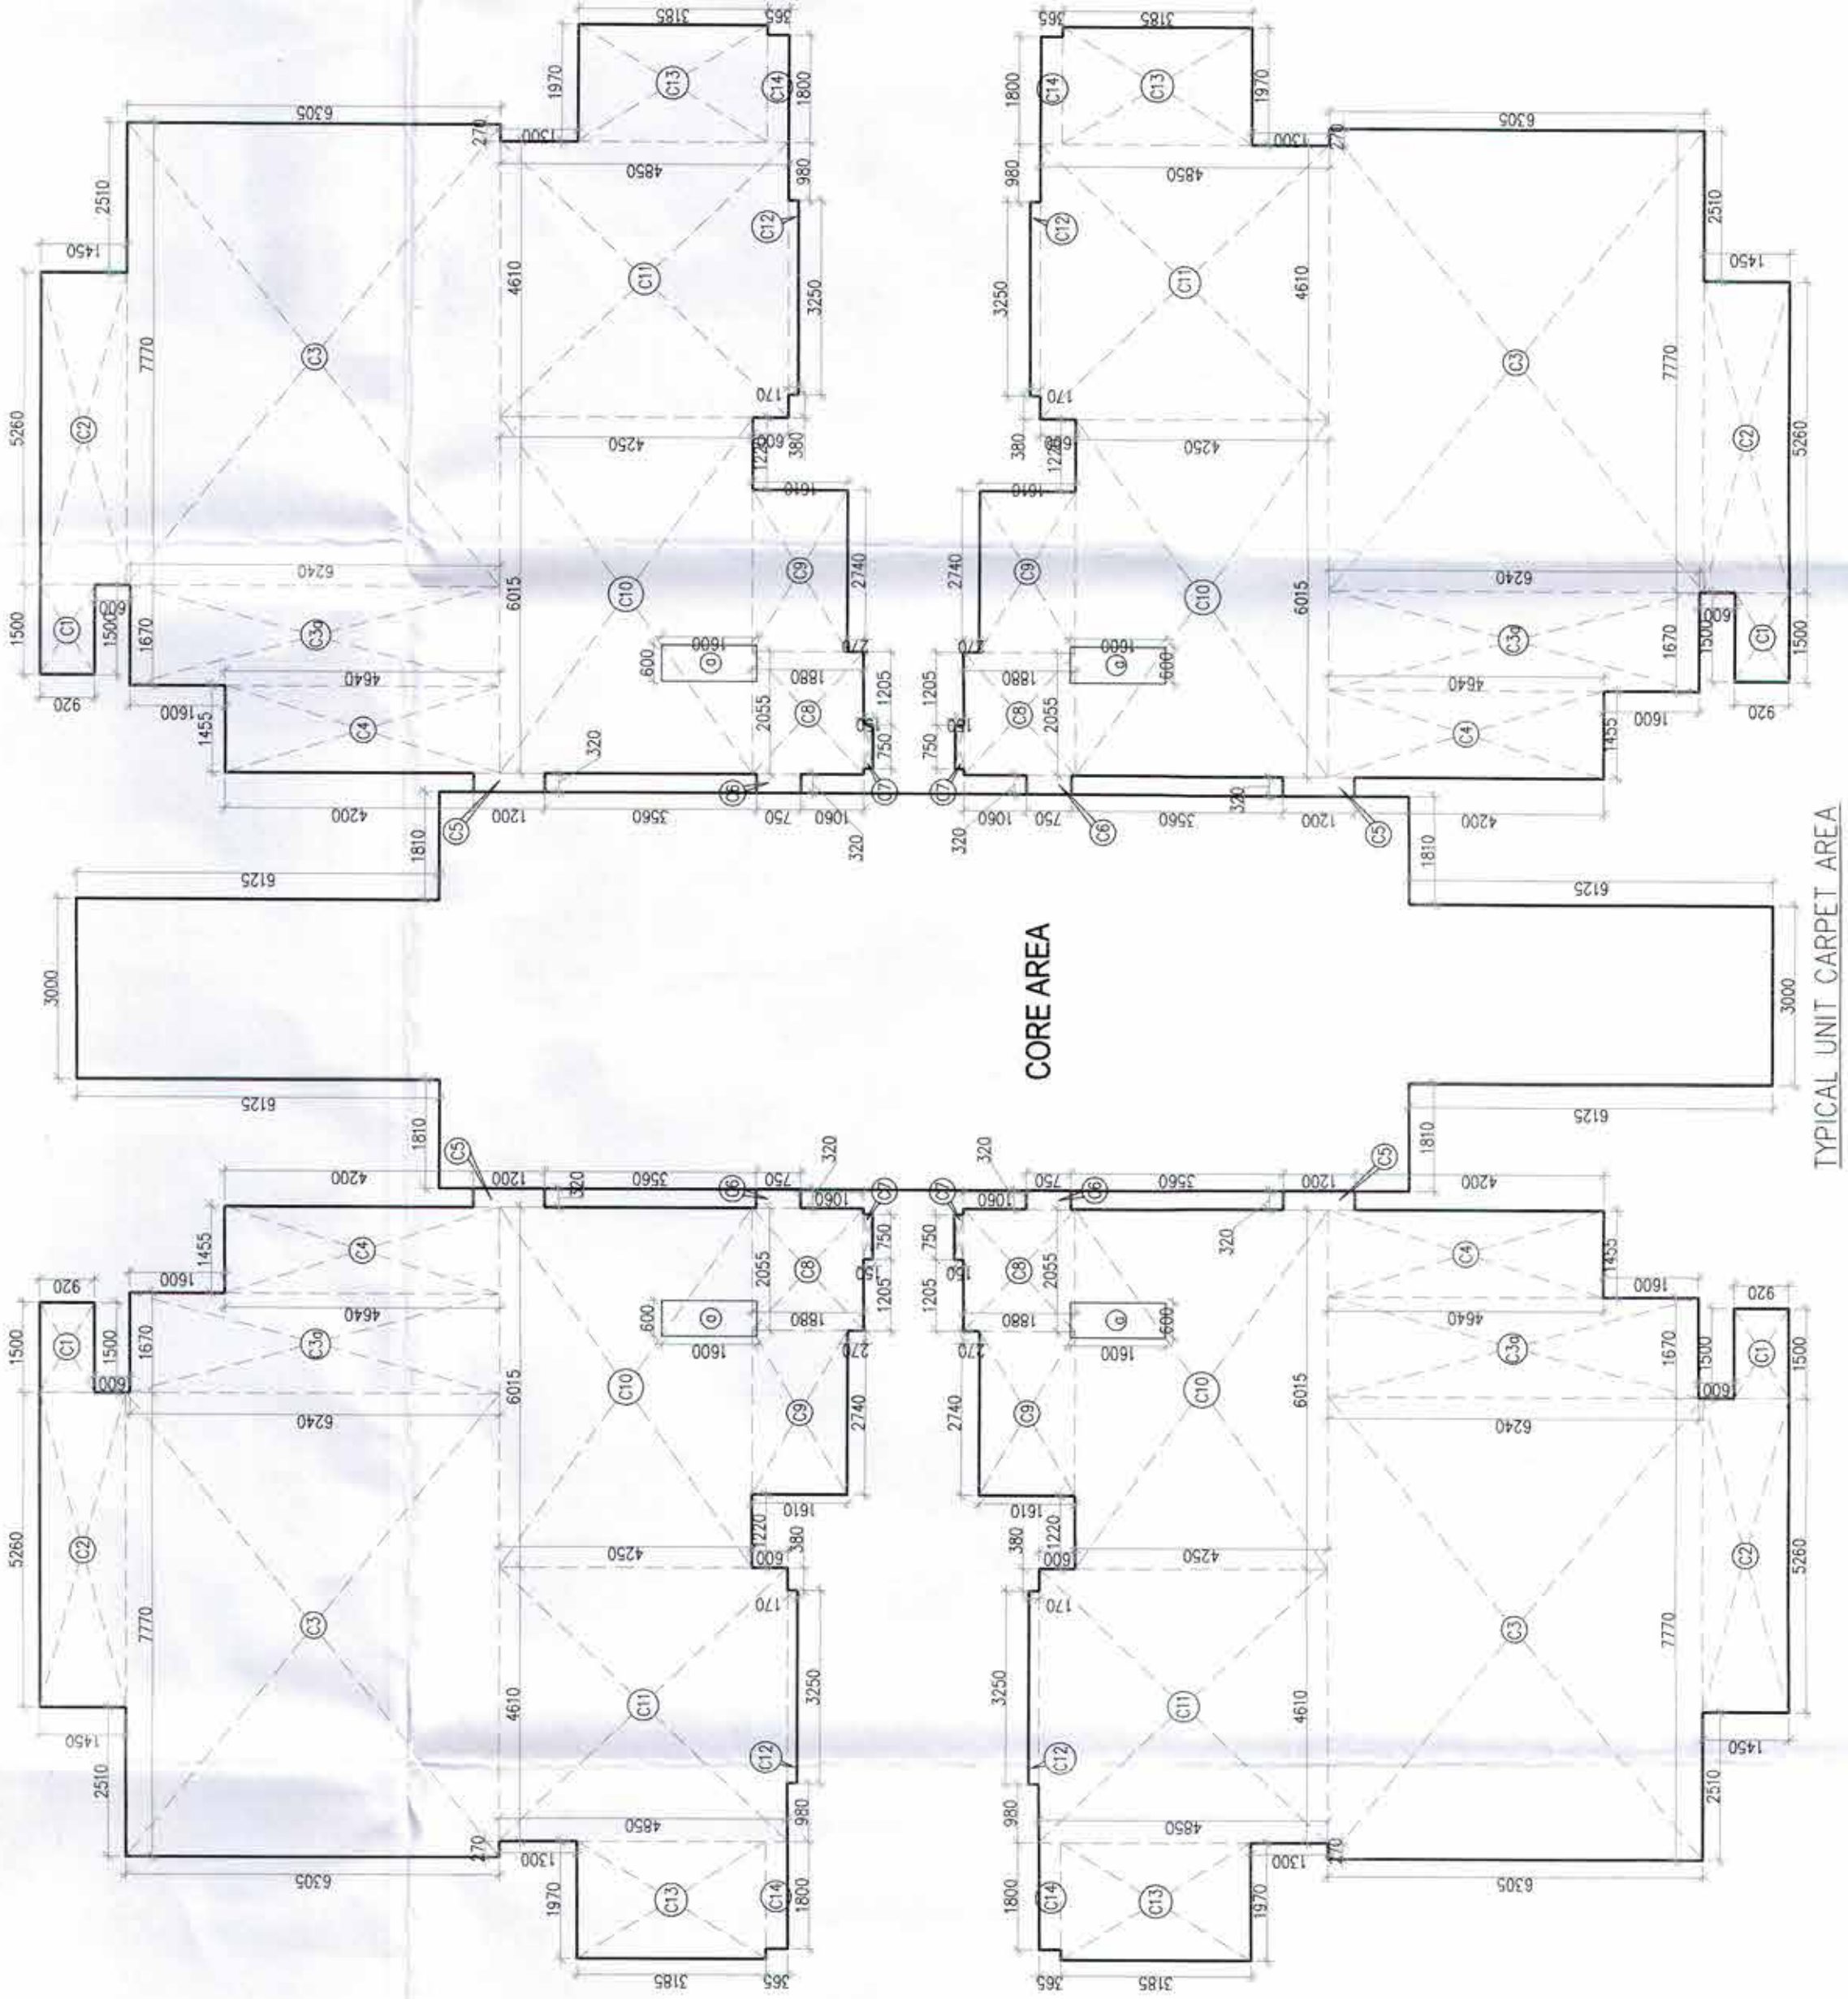

TYPICAL CORE AREA
(TOWER-A)

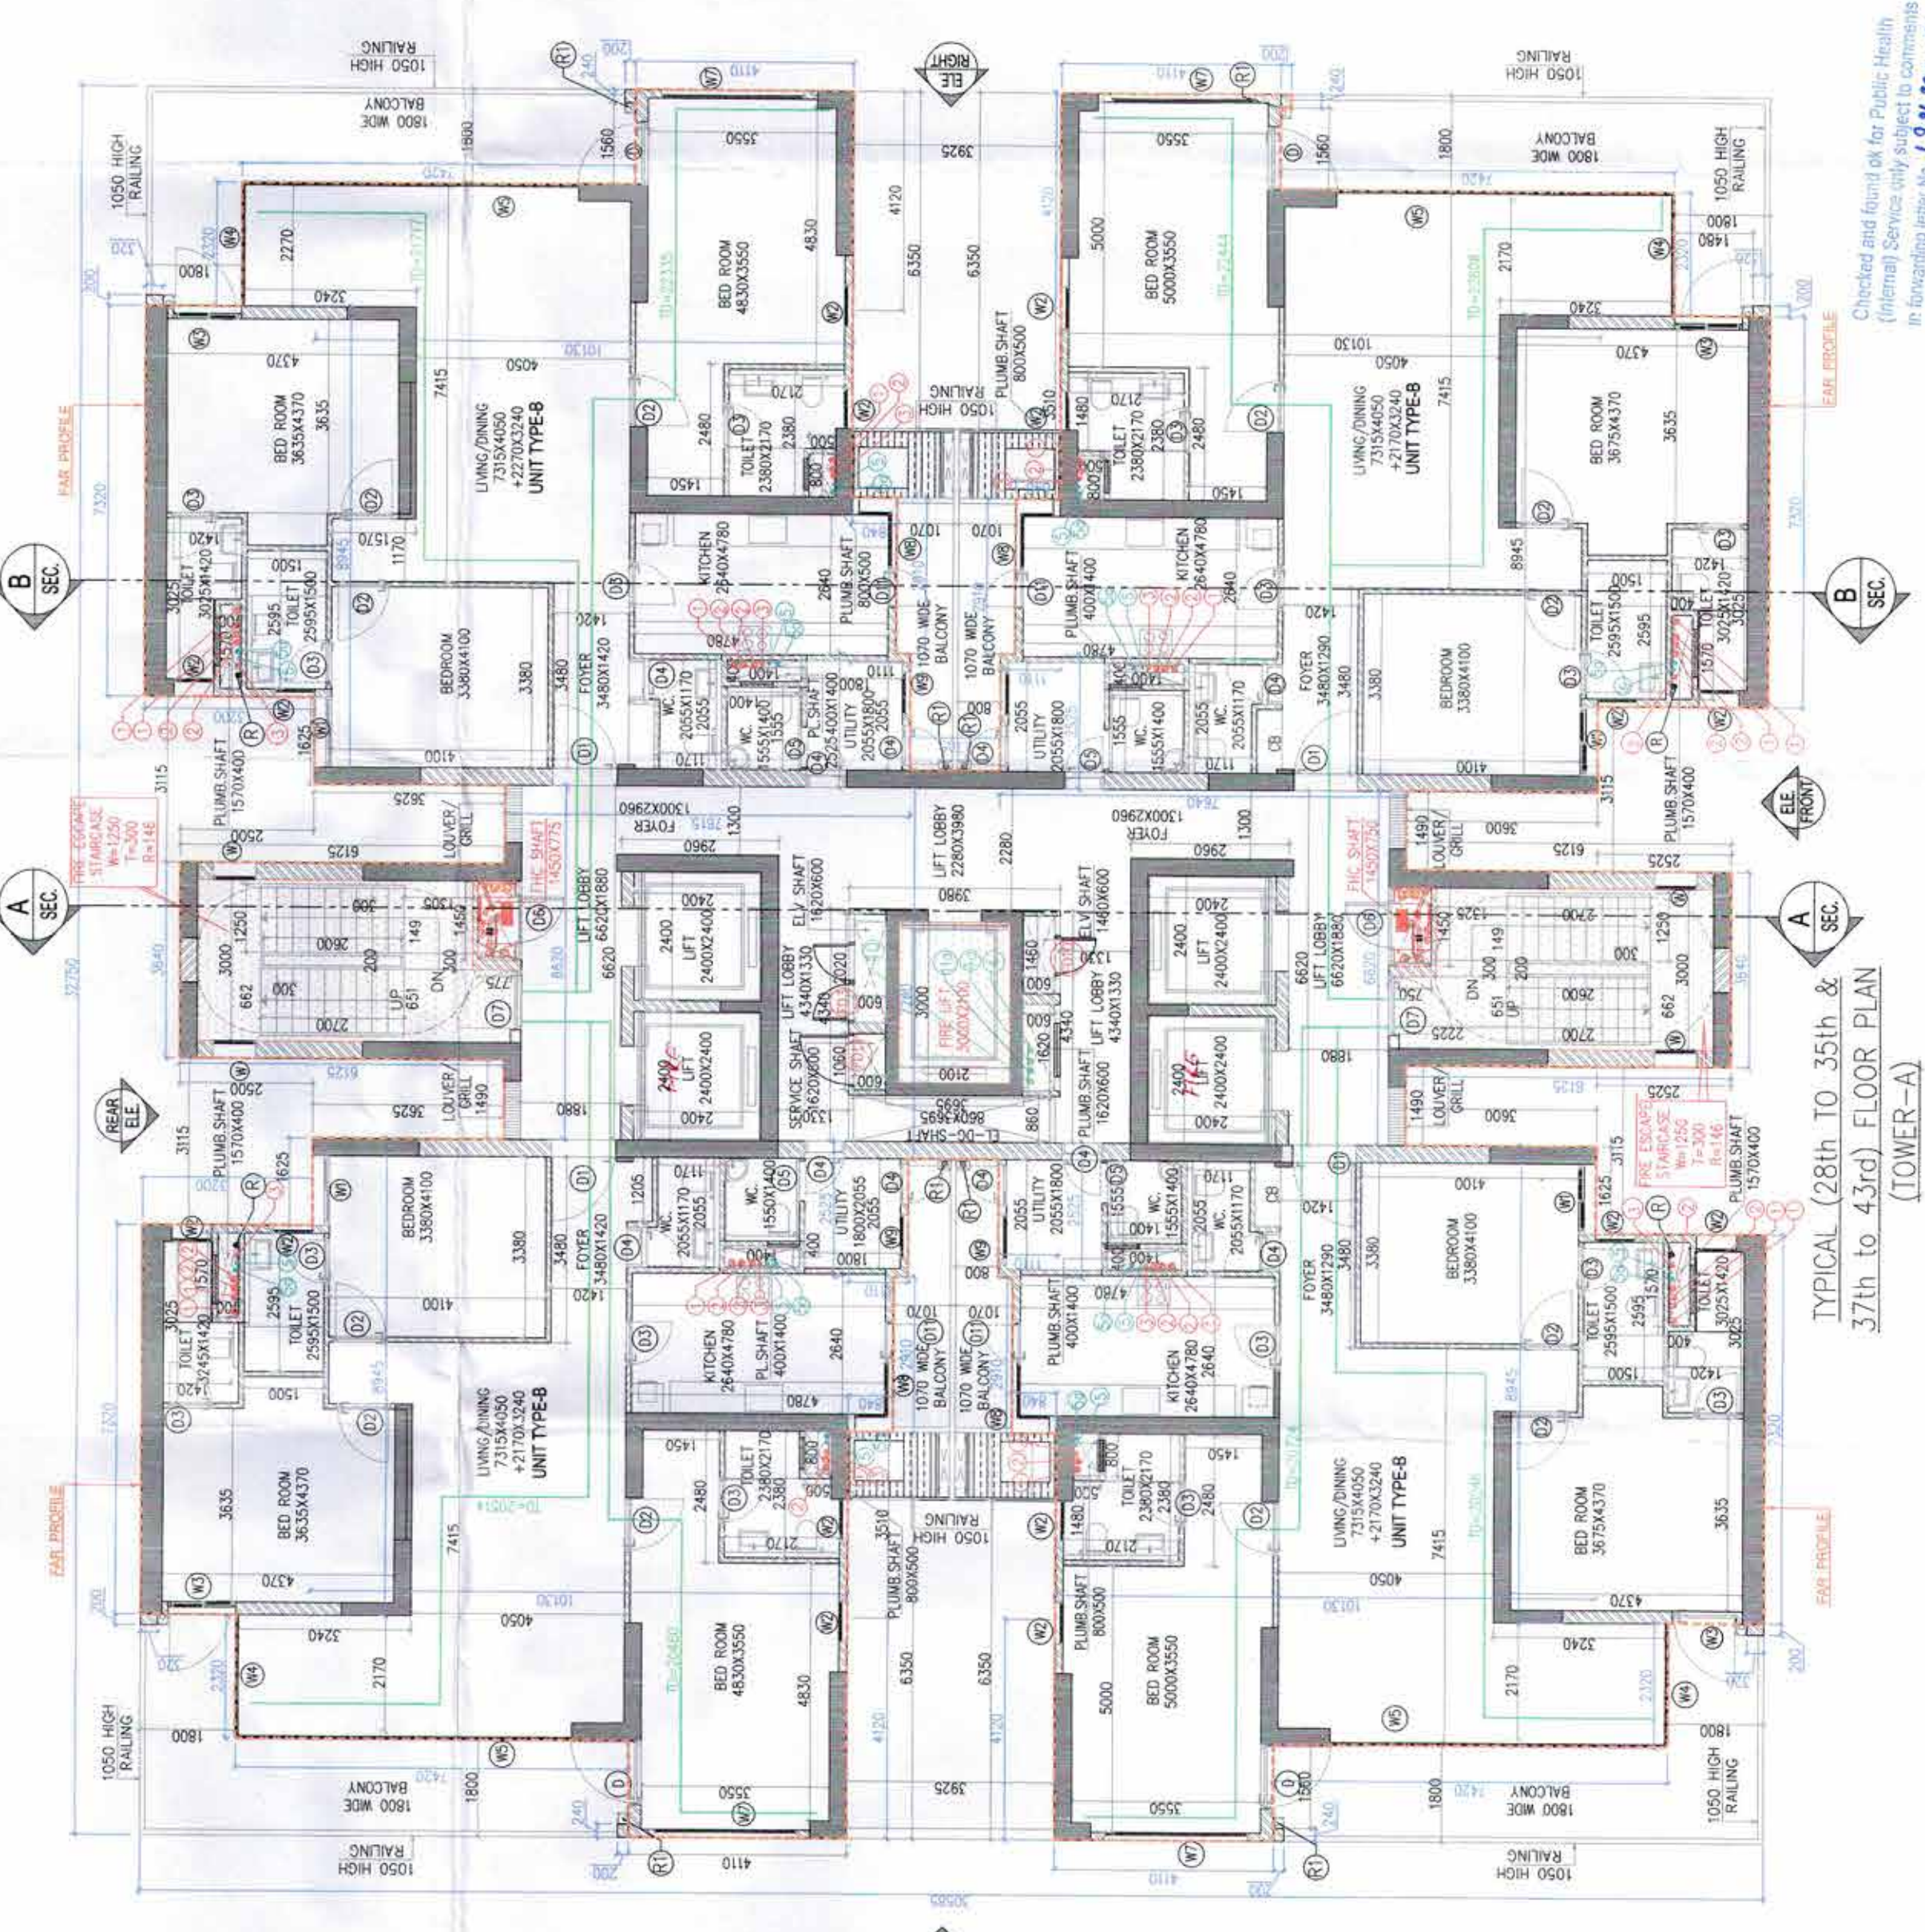

TYPICAL 28TH TO 35TH FLOOR PLAN
(TOWER-A)