

Note :-
1. BUILDING WILL BE DESIGNED (STRUCTURES) AS PER RELEVANT IS CODES FOR EARTH QUAKE RESISTANCE.
2. BUILDING HAS AUTOMATIC SPRINKLER SYSTEM ON ALL FLOORS.
3. CLUB AND RETAIL ARE ARTIFICIALLY LIGHTED MECHANICALLY VENTILATED & AIR CONDITIONED WITH 100% POWER BACKUP.
4. TOILETS ARE ARTIFICIALLY LIGHTED, MECHANICALLY VENTILATED & HAVE 100% POWER BACKUP (TOWER-A & B)

LEGEND:-

PROJECT:-
PROPOSED GROUP HOUSING COLONY UNDER TOD POLICY (MIX LAND USE 78% RESIDENTIAL + 22% COMMERCIAL) ON AN AREA MEASURING 4.84375 ACRES (LICENCE NO.114 OF 2023 DATED 20/02/2023) IN SECTOR-42, GURUGRAM MANESAR URBAN COMPLEX BEING DEVELOPED BY MRS. NEERU DEVI W/O LATE SH. NARESH CHAND JAIN AND OTHER IN COLLABORATION WITH CONSCIENT INFRASTRUCTURE PVT. LTD.

Associate Architects




RSMS ARCHITECTS PVT. LTD.
69,Nora Niwas Bhawani Kunj
(Behind D2), Vasanti Kunj,
New Delhi-110070.
Tel: 011-26898616,26898617
www.rsms-arch.com

Checked and Signed by Mr. Narender Singh
Project Engineer
31/10/2023

Sanctioned
To be used only for office use
31/10/2023

ARCHITECT'S SEAL & SIGNATURE
OWNER'S SEAL & SIGNATURE

AUGUST-2023 Scale : 1:100
Drawing Title:-
4th to 8th FLOOR (REFER ONLY FOR CARPET AREA DIMENSION)
FLOOR PLAN (REFER ONLY FOR CARPET AREA DIMENSION)
TYPICAL & REFUGEE FLOOR AREA CALCULATION
TOWER-B

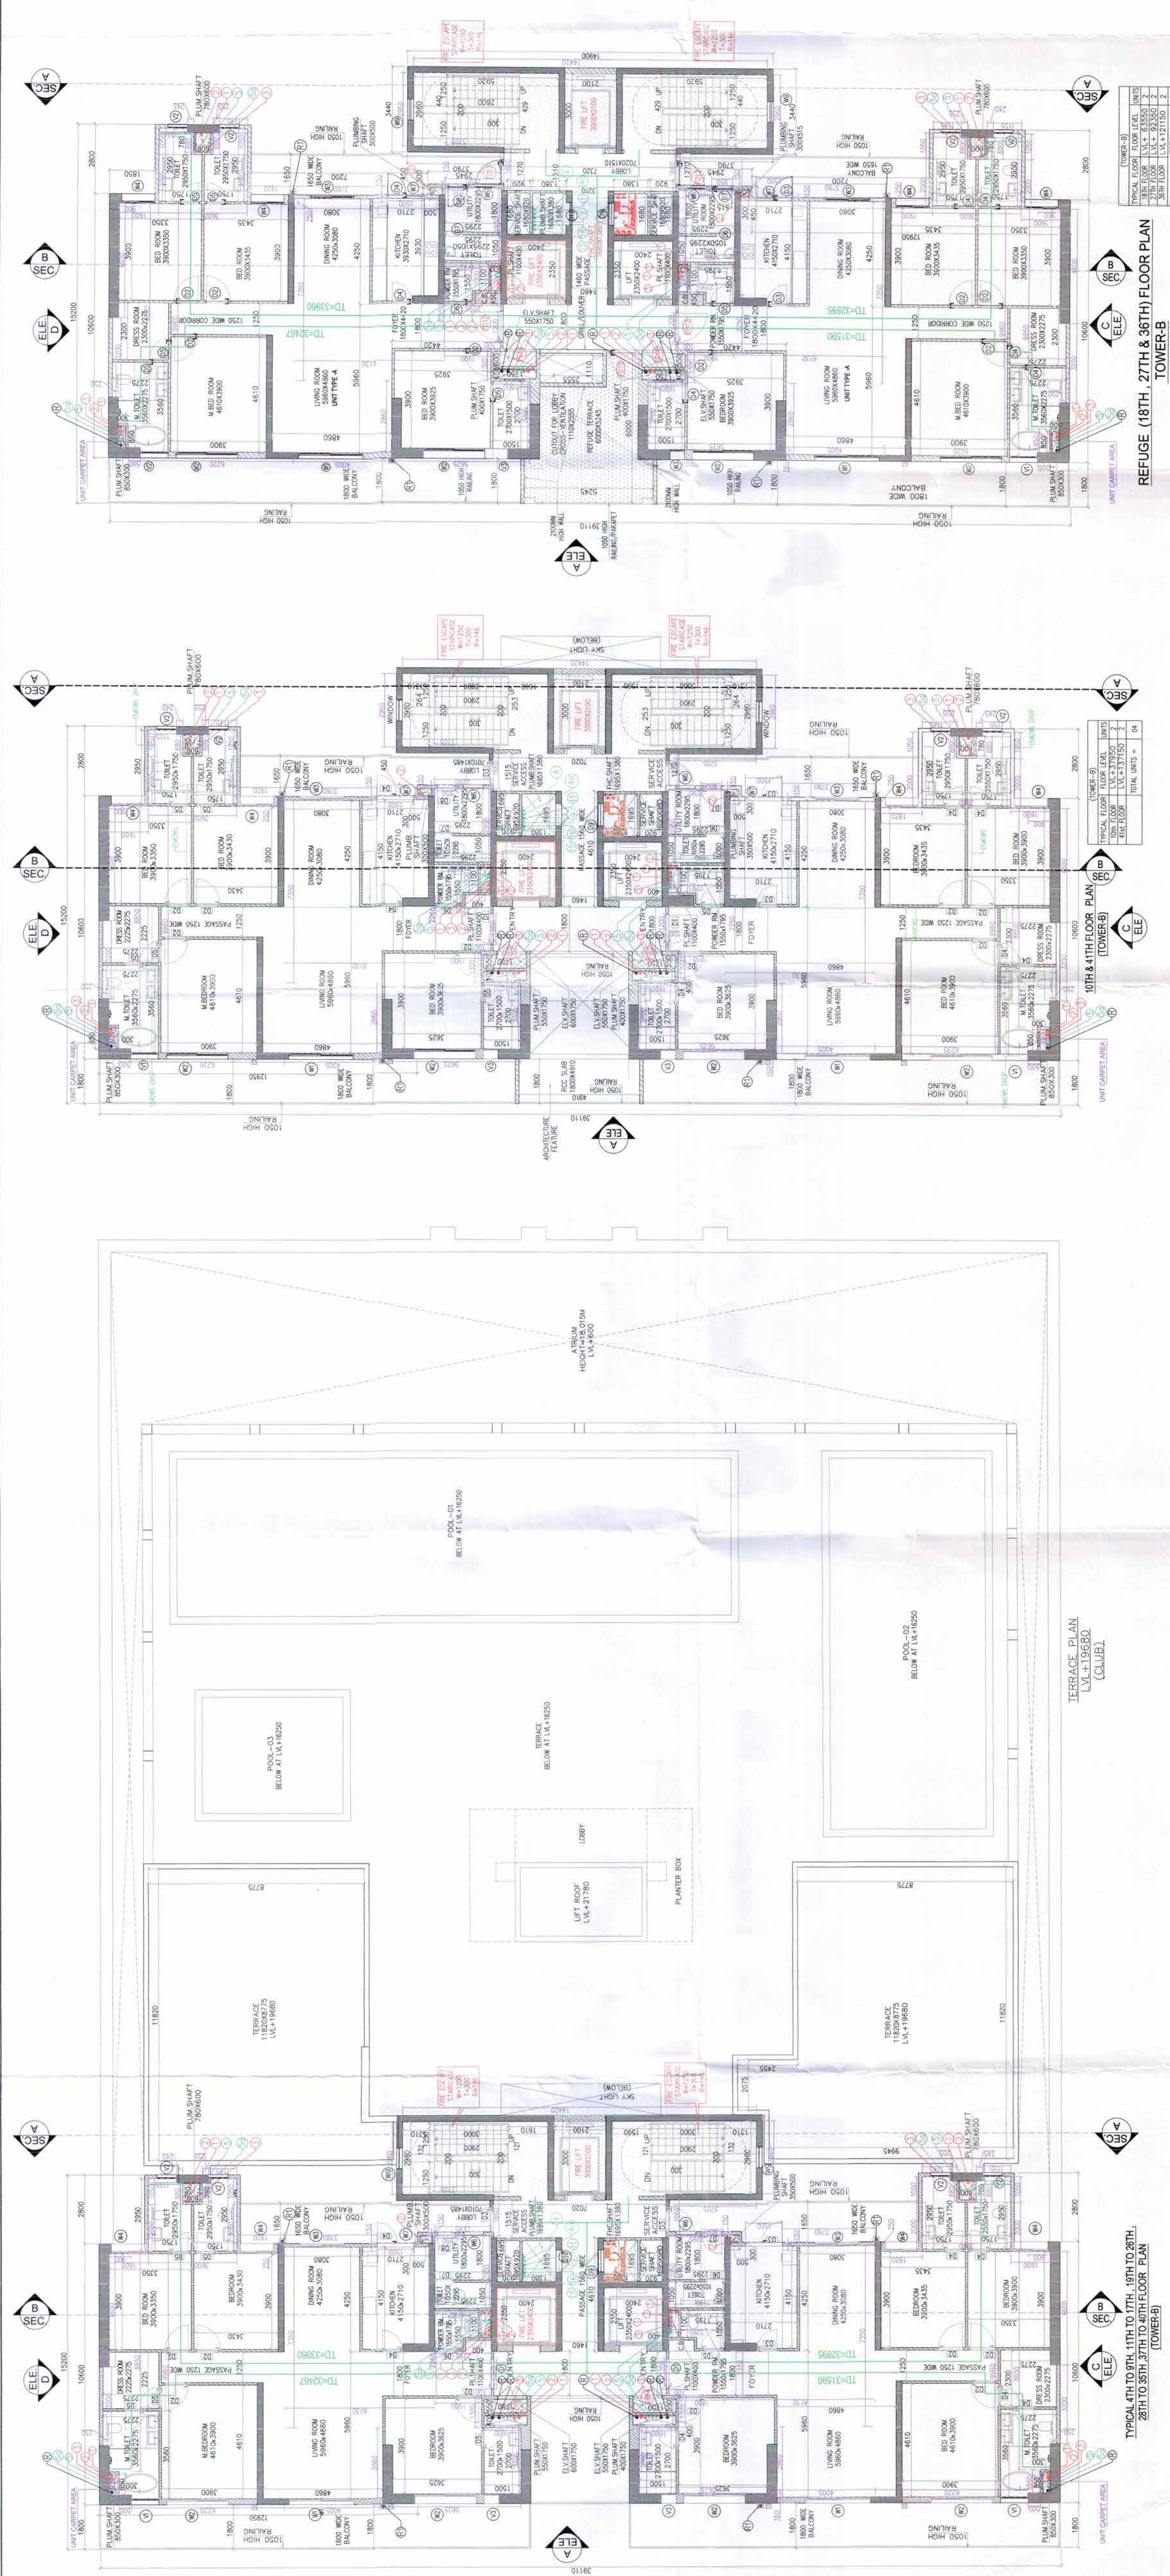

DOOR SCHEDULE (ALL DIMENSIONS ARE IN MM & ARE APPROX.)

S.NO.	DOOR TYPE	SIZE	LOCATION
1	ALUM. FRAME & GLASS	1000 x 2000	UNIT 401
2	ALUM. FRAME & GLASS	1000 x 2000	UNIT 402
3	ALUM. FRAME & GLASS	1000 x 2000	UNIT 403
4	ALUM. FRAME & GLASS	1000 x 2000	UNIT 404
5	ALUM. FRAME & GLASS	1000 x 2000	UNIT 405
6	ALUM. FRAME & GLASS	1000 x 2000	UNIT 406
7	ALUM. FRAME & GLASS	1000 x 2000	UNIT 407
8	ALUM. FRAME & GLASS	1000 x 2000	UNIT 408

CLUB SCHEDULE OF JOINTS



S.NO.	JOINT TYPE	SIZE	LOCATION
1	ALUM. FRAME & GLASS	1000 x 2000	UNIT 401
2	ALUM. FRAME & GLASS	1000 x 2000	UNIT 402
3	ALUM. FRAME & GLASS	1000 x 2000	UNIT 403
4	ALUM. FRAME & GLASS	1000 x 2000	UNIT 404
5	ALUM. FRAME & GLASS	1000 x 2000	UNIT 405
6	ALUM. FRAME & GLASS	1000 x 2000	UNIT 406
7	ALUM. FRAME & GLASS	1000 x 2000	UNIT 407
8	ALUM. FRAME & GLASS	1000 x 2000	UNIT 408

PIPE CONNECTION DIA :-

PIPE TYPE	CONNECTION DIA
1000 SOL. PIPE	1000
400 WASTE PIPE	400
500 WASTE PIPE	500
1000 WASTE PIPE	1000

PLUMBING LEGEND:-

S.NO.	ABBREVIATION	SYMBOL	DESCRIPTION
1	WP	---	1000 WASTE PIPE
2	WP	---	400/500 WASTE PIPE
3	SP	---	1000 SOL. PIPE
4	SP	---	500 SOL. PIPE
5	UT	---	JURNAL TRAP
6	FT	---	FLOOR TRAP
7	FD	---	FLOOR DRAIN
8	ARROW	---	SLOPE ARROW

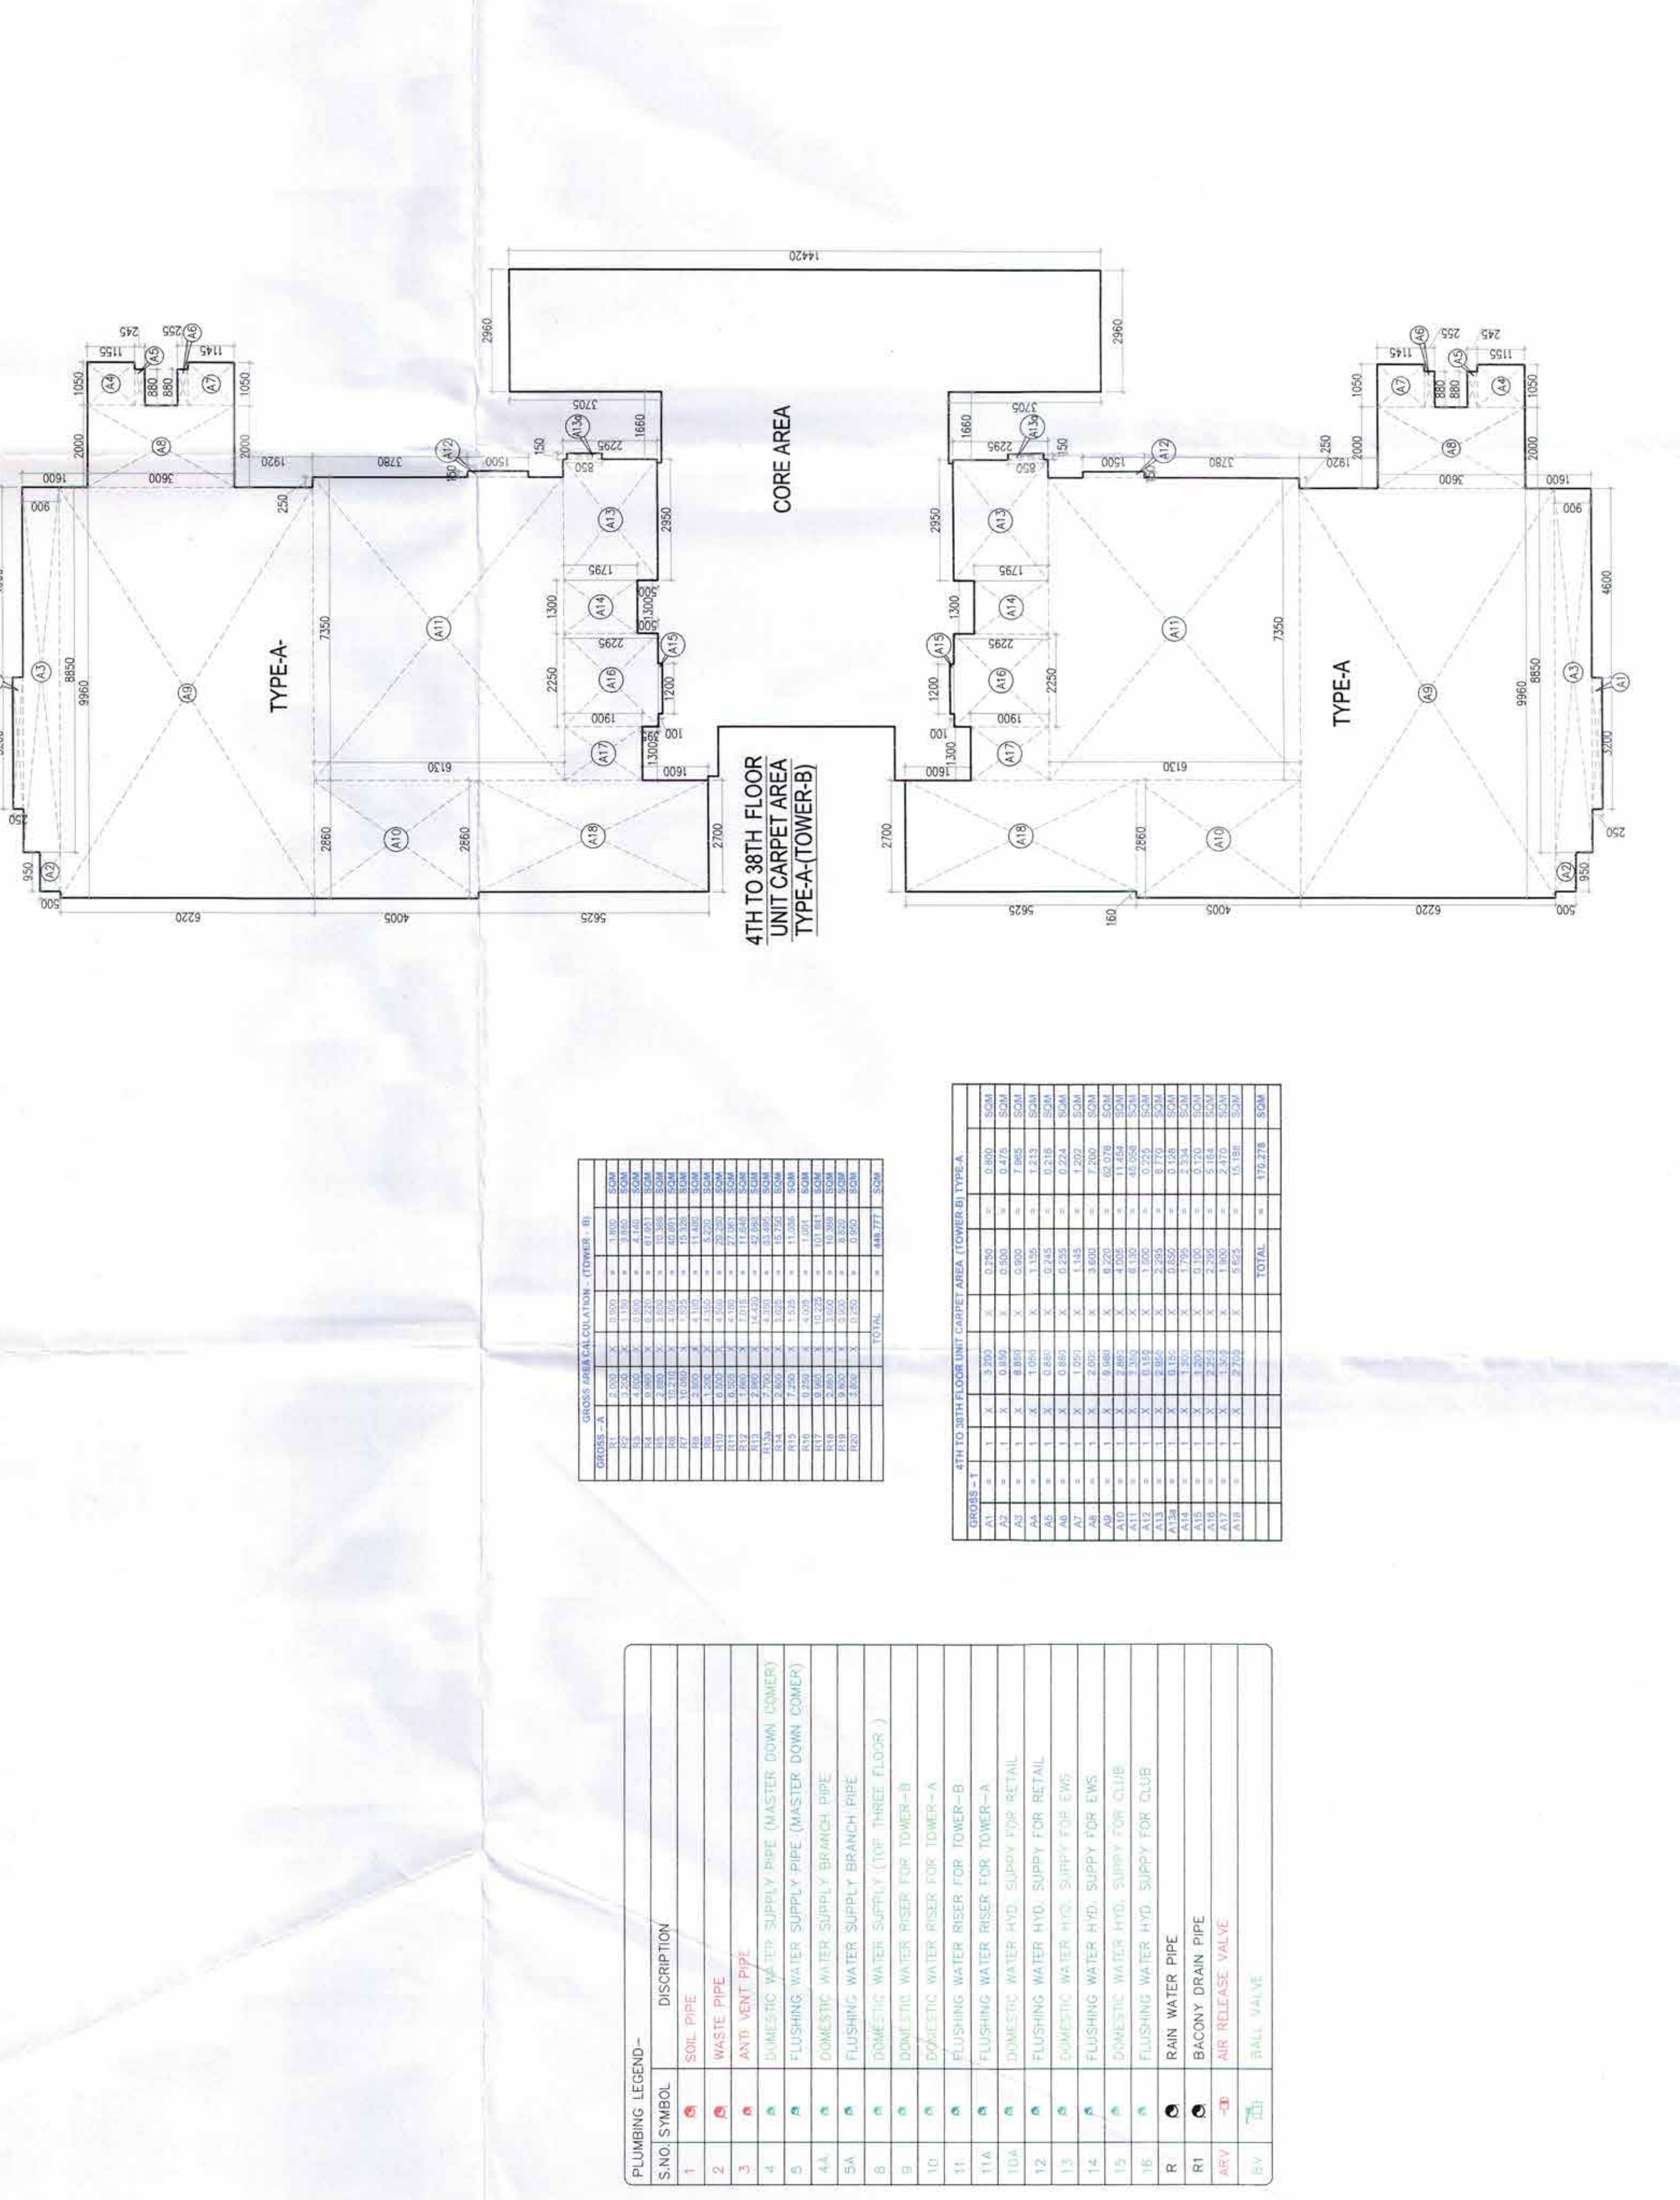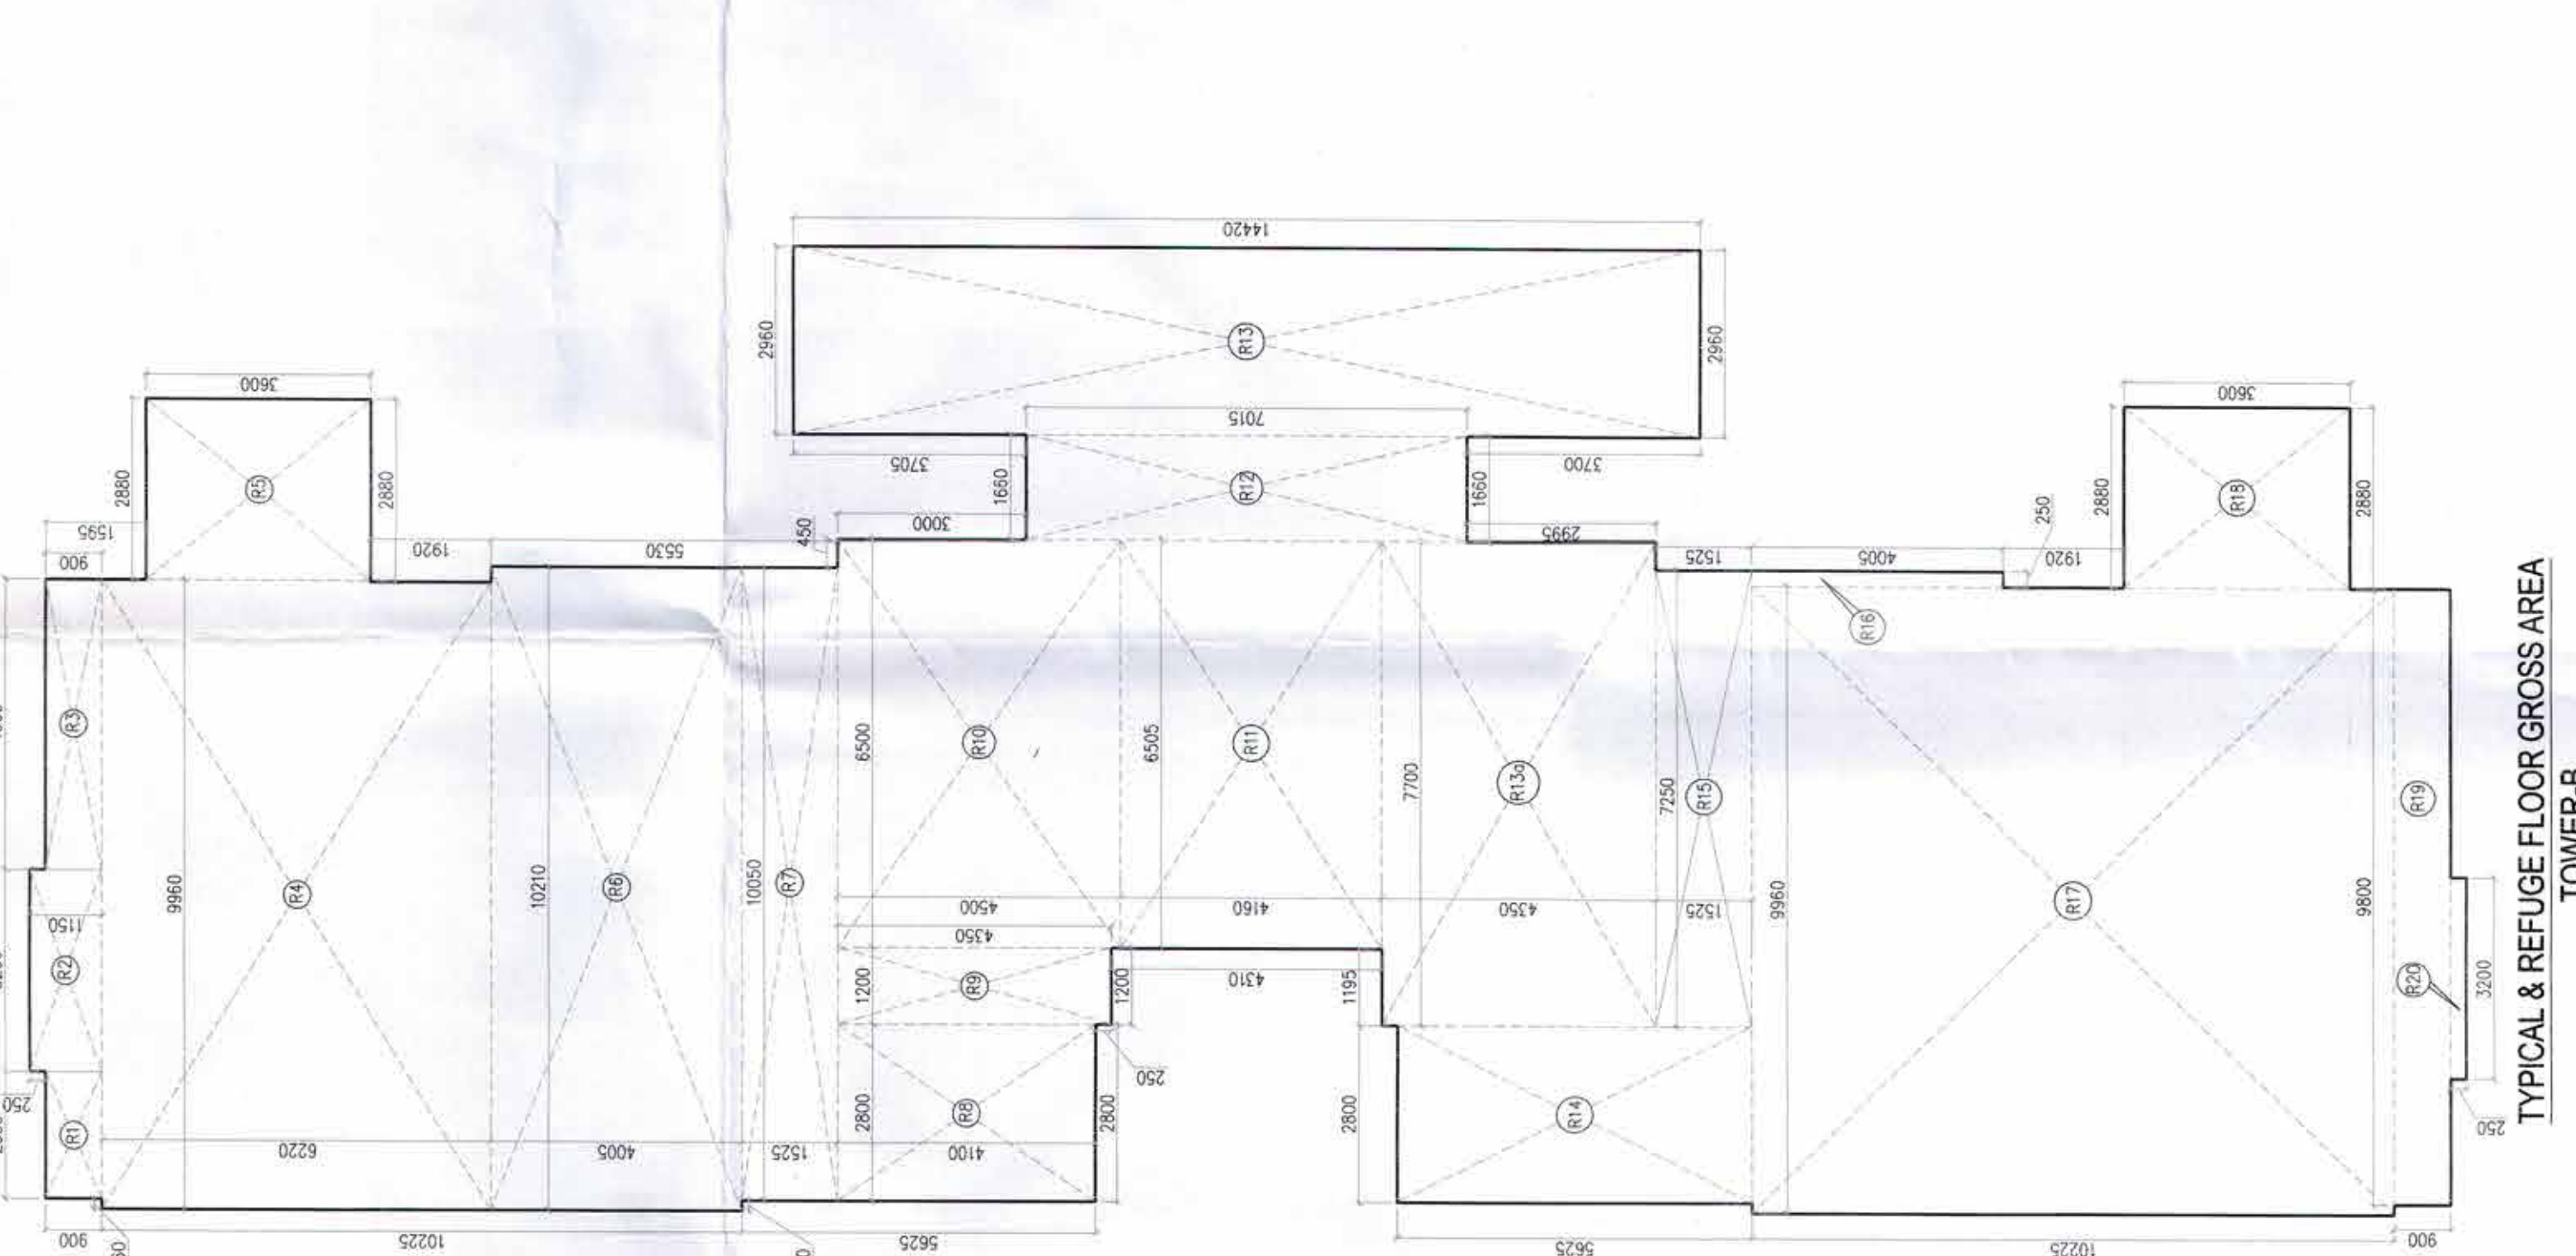

CLUB SCHEDULE OF JOINTS

S.NO.	JOINT TYPE	SIZE	LOCATION
1	ALUM. FRAME & GLASS	1000 x 2000	UNIT 401
2	ALUM. FRAME & GLASS	1000 x 2000	UNIT 402
3	ALUM. FRAME & GLASS	1000 x 2000	UNIT 403
4	ALUM. FRAME & GLASS	1000 x 2000	UNIT 404
5	ALUM. FRAME & GLASS	1000 x 2000	UNIT 405
6	ALUM. FRAME & GLASS	1000 x 2000	UNIT 406
7	ALUM. FRAME & GLASS	1000 x 2000	UNIT 407
8	ALUM. FRAME & GLASS	1000 x 2000	UNIT 408

PLUMBING LEGEND:-

S.NO.	ABBREVIATION	SYMBOL	DESCRIPTION
1	WP	---	1000 WASTE PIPE
2	WP	---	400/500 WASTE PIPE
3	SP	---	1000 SOL. PIPE
4	SP	---	500 SOL. PIPE
5	UT	---	JURNAL TRAP
6	FT	---	FLOOR TRAP
7	FD	---	FLOOR DRAIN
8	ARROW	---	SLOPE ARROW