

This is a "PROVISIONAL BUILDING PLAN" approved only for the purpose of inviting objections from the general public


[Signatures]
S.T.P. (HQ) S.T.P. (HQ) S.T.P. (G) S.T.P. (Hr.)
Member Member Secretary Member Chairman
B.P.A.C. B.P.A.C. B.P.A.C. B.P.A.C.
Consultant Architect ATP (HQ)
AD PA AP

MEMBER BPAC

(Dinesh Kumar) PA(HQ)

Checked and found ok for Public Health (Internal) Service only subject to comments in forwarding letter No.DV.....

Superior Engineering (HQ) for Chief Engineer HSVP, Panipat
JDEW-21

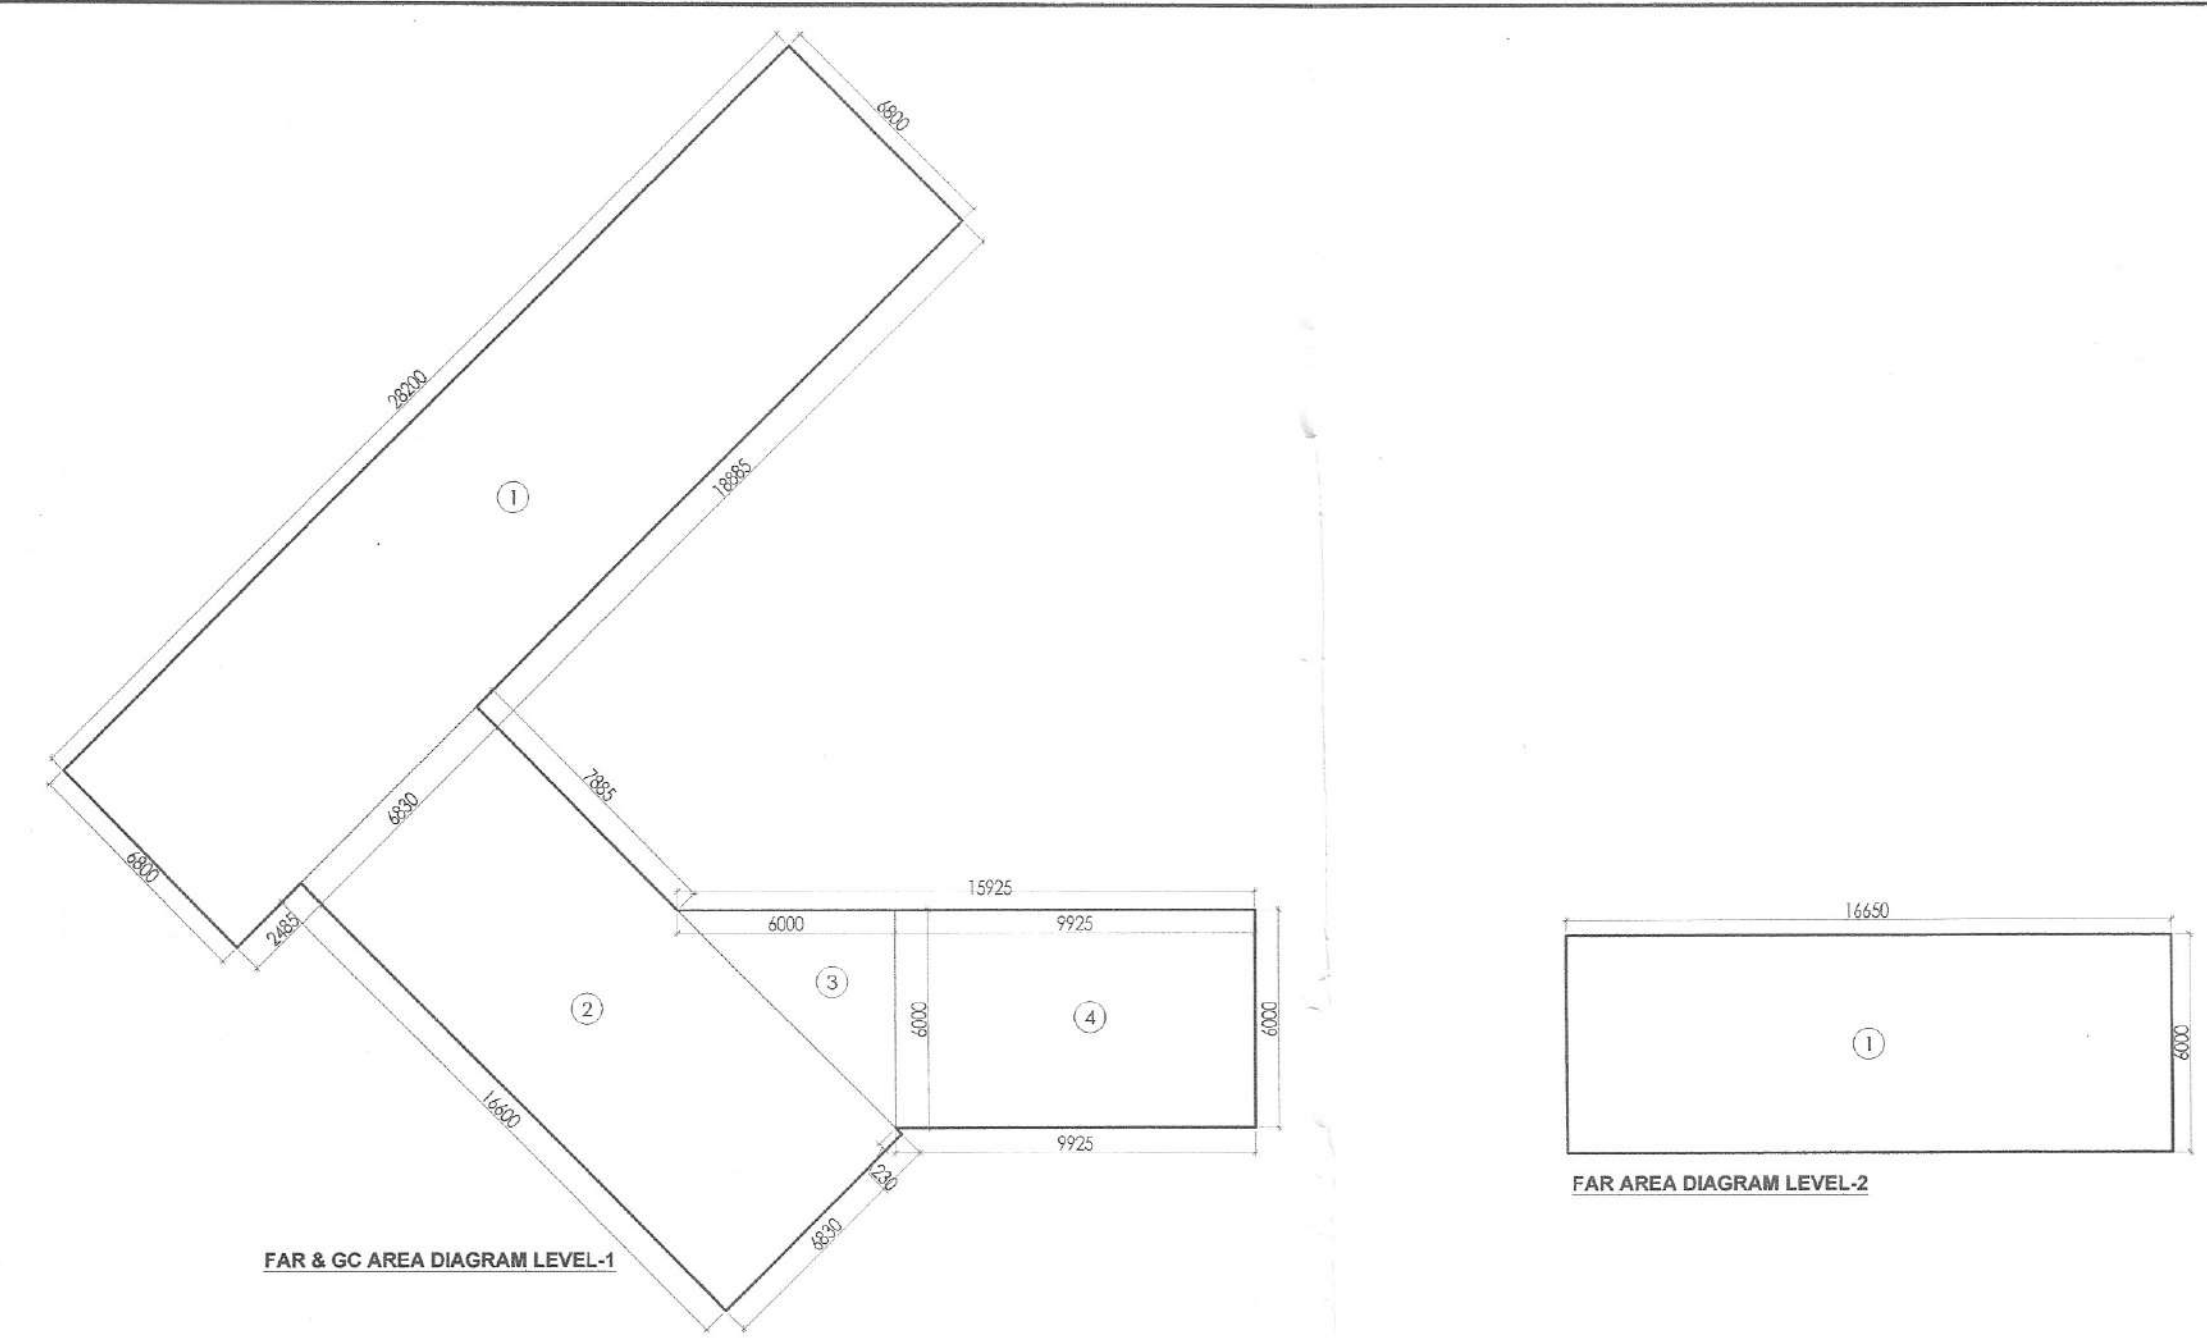



LEVEL-1 AREA CALCULATIONS					
NO.	COEFF.	LENGTH	BREADTH	QUANTITY	AREA (SQ.M)
1	1	28.200	6.800	1	191.760
2	1	18.600	6.830	1	113.378
3	0.5	6.000	6.000	1	18.000
4	1	9.925	6.000	1	59.550
TOTAL FAR & GC AREA					382.688

LEVEL-2 AREA CALCULATIONS					
NO.	COEFF.	LENGTH	BREADTH	QUANTITY	AREA (SQ.M)
1	1	16.650	6.000	1	99.900
TOTAL FAR AREA					99.900

DOOR SCHEDULE		
NAME	WIDTH	HEIGHT
D1	1200	2400
D2	900	2400
FD1	900	1800
FD2	900	1200

PLUMBING LEGEND	
①	1100 OD uPVC SP STACK
②	1100 OD uPVC WP STACK
③	DWS D/TAKE
④	DWS RISER
⑤	FLUSHING RISER
⑥	1100 OD uPVC R.W.P
⑦	750 uPVC DRAIN PIPE (BALCONY)

LEGEND:-	
SYMBOL	DESCRIPTION
—	SOIL PIPE
—	WASTE PIPE
—	FLOOR TRAP
—	CUTOUT
—	FLOOR DRAIN
—	DWS PIPE
—	FWS PIPE
—	CONTROL VALVE
—	FIRE PIPE

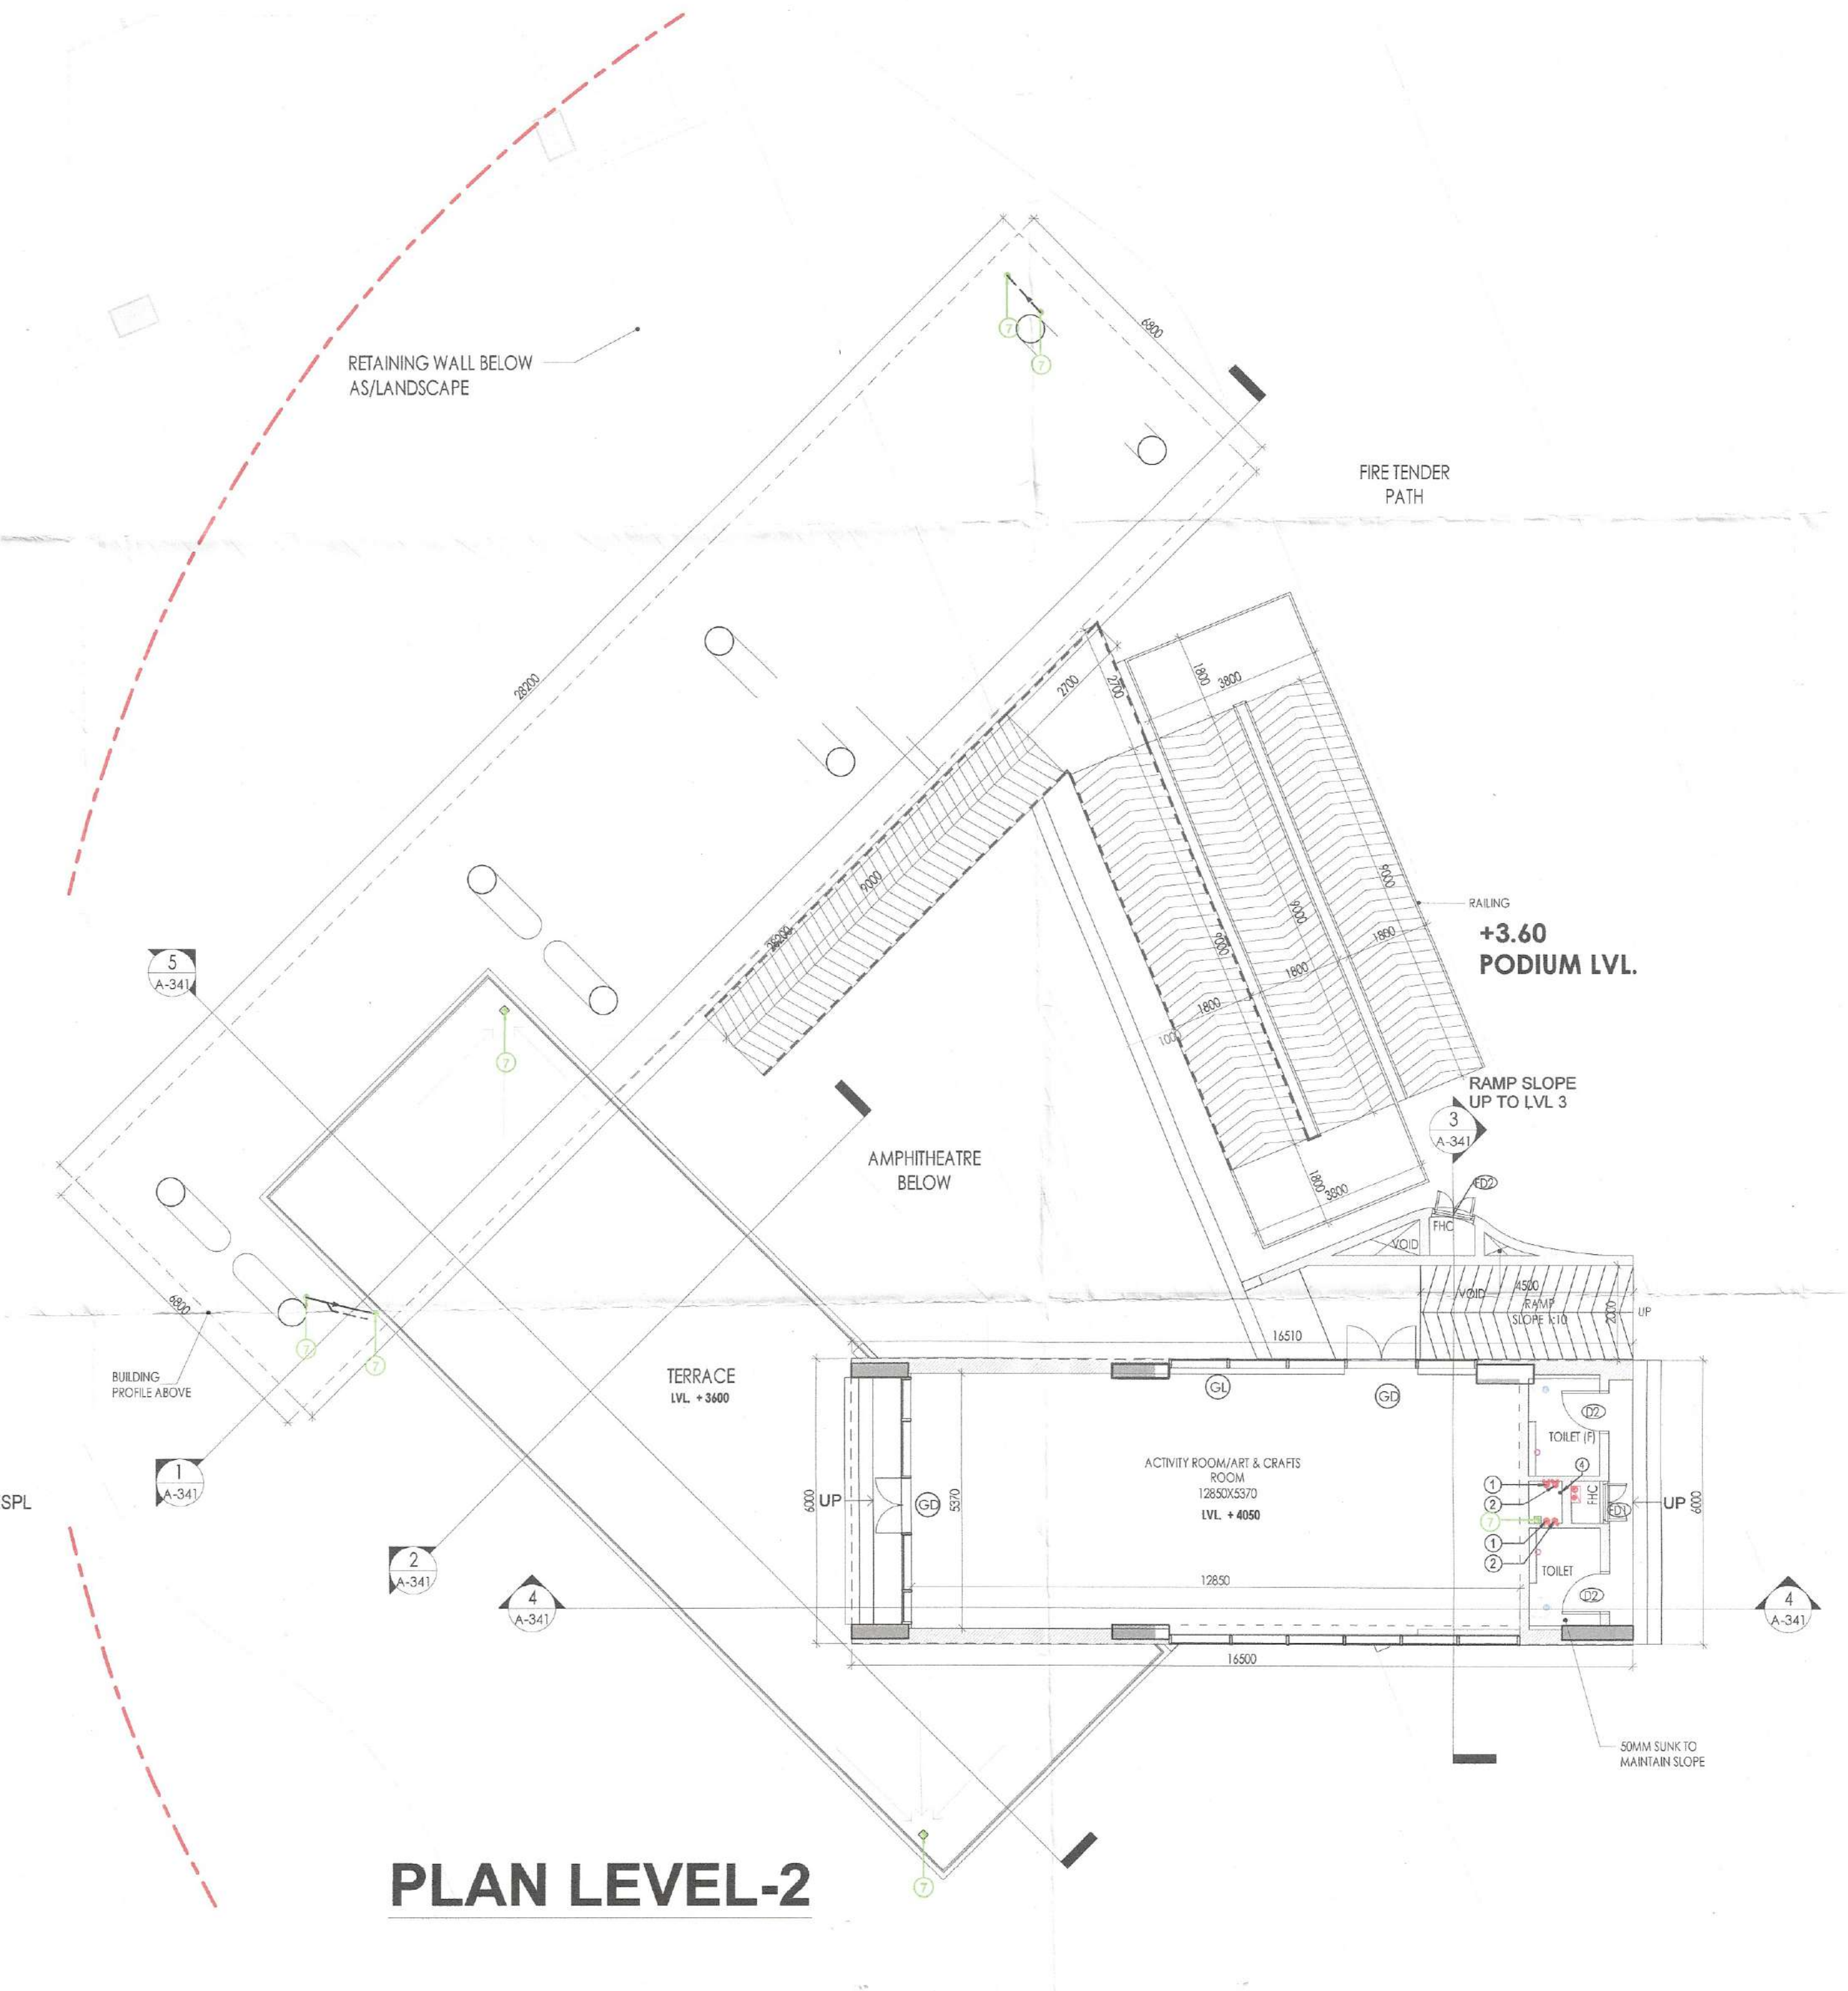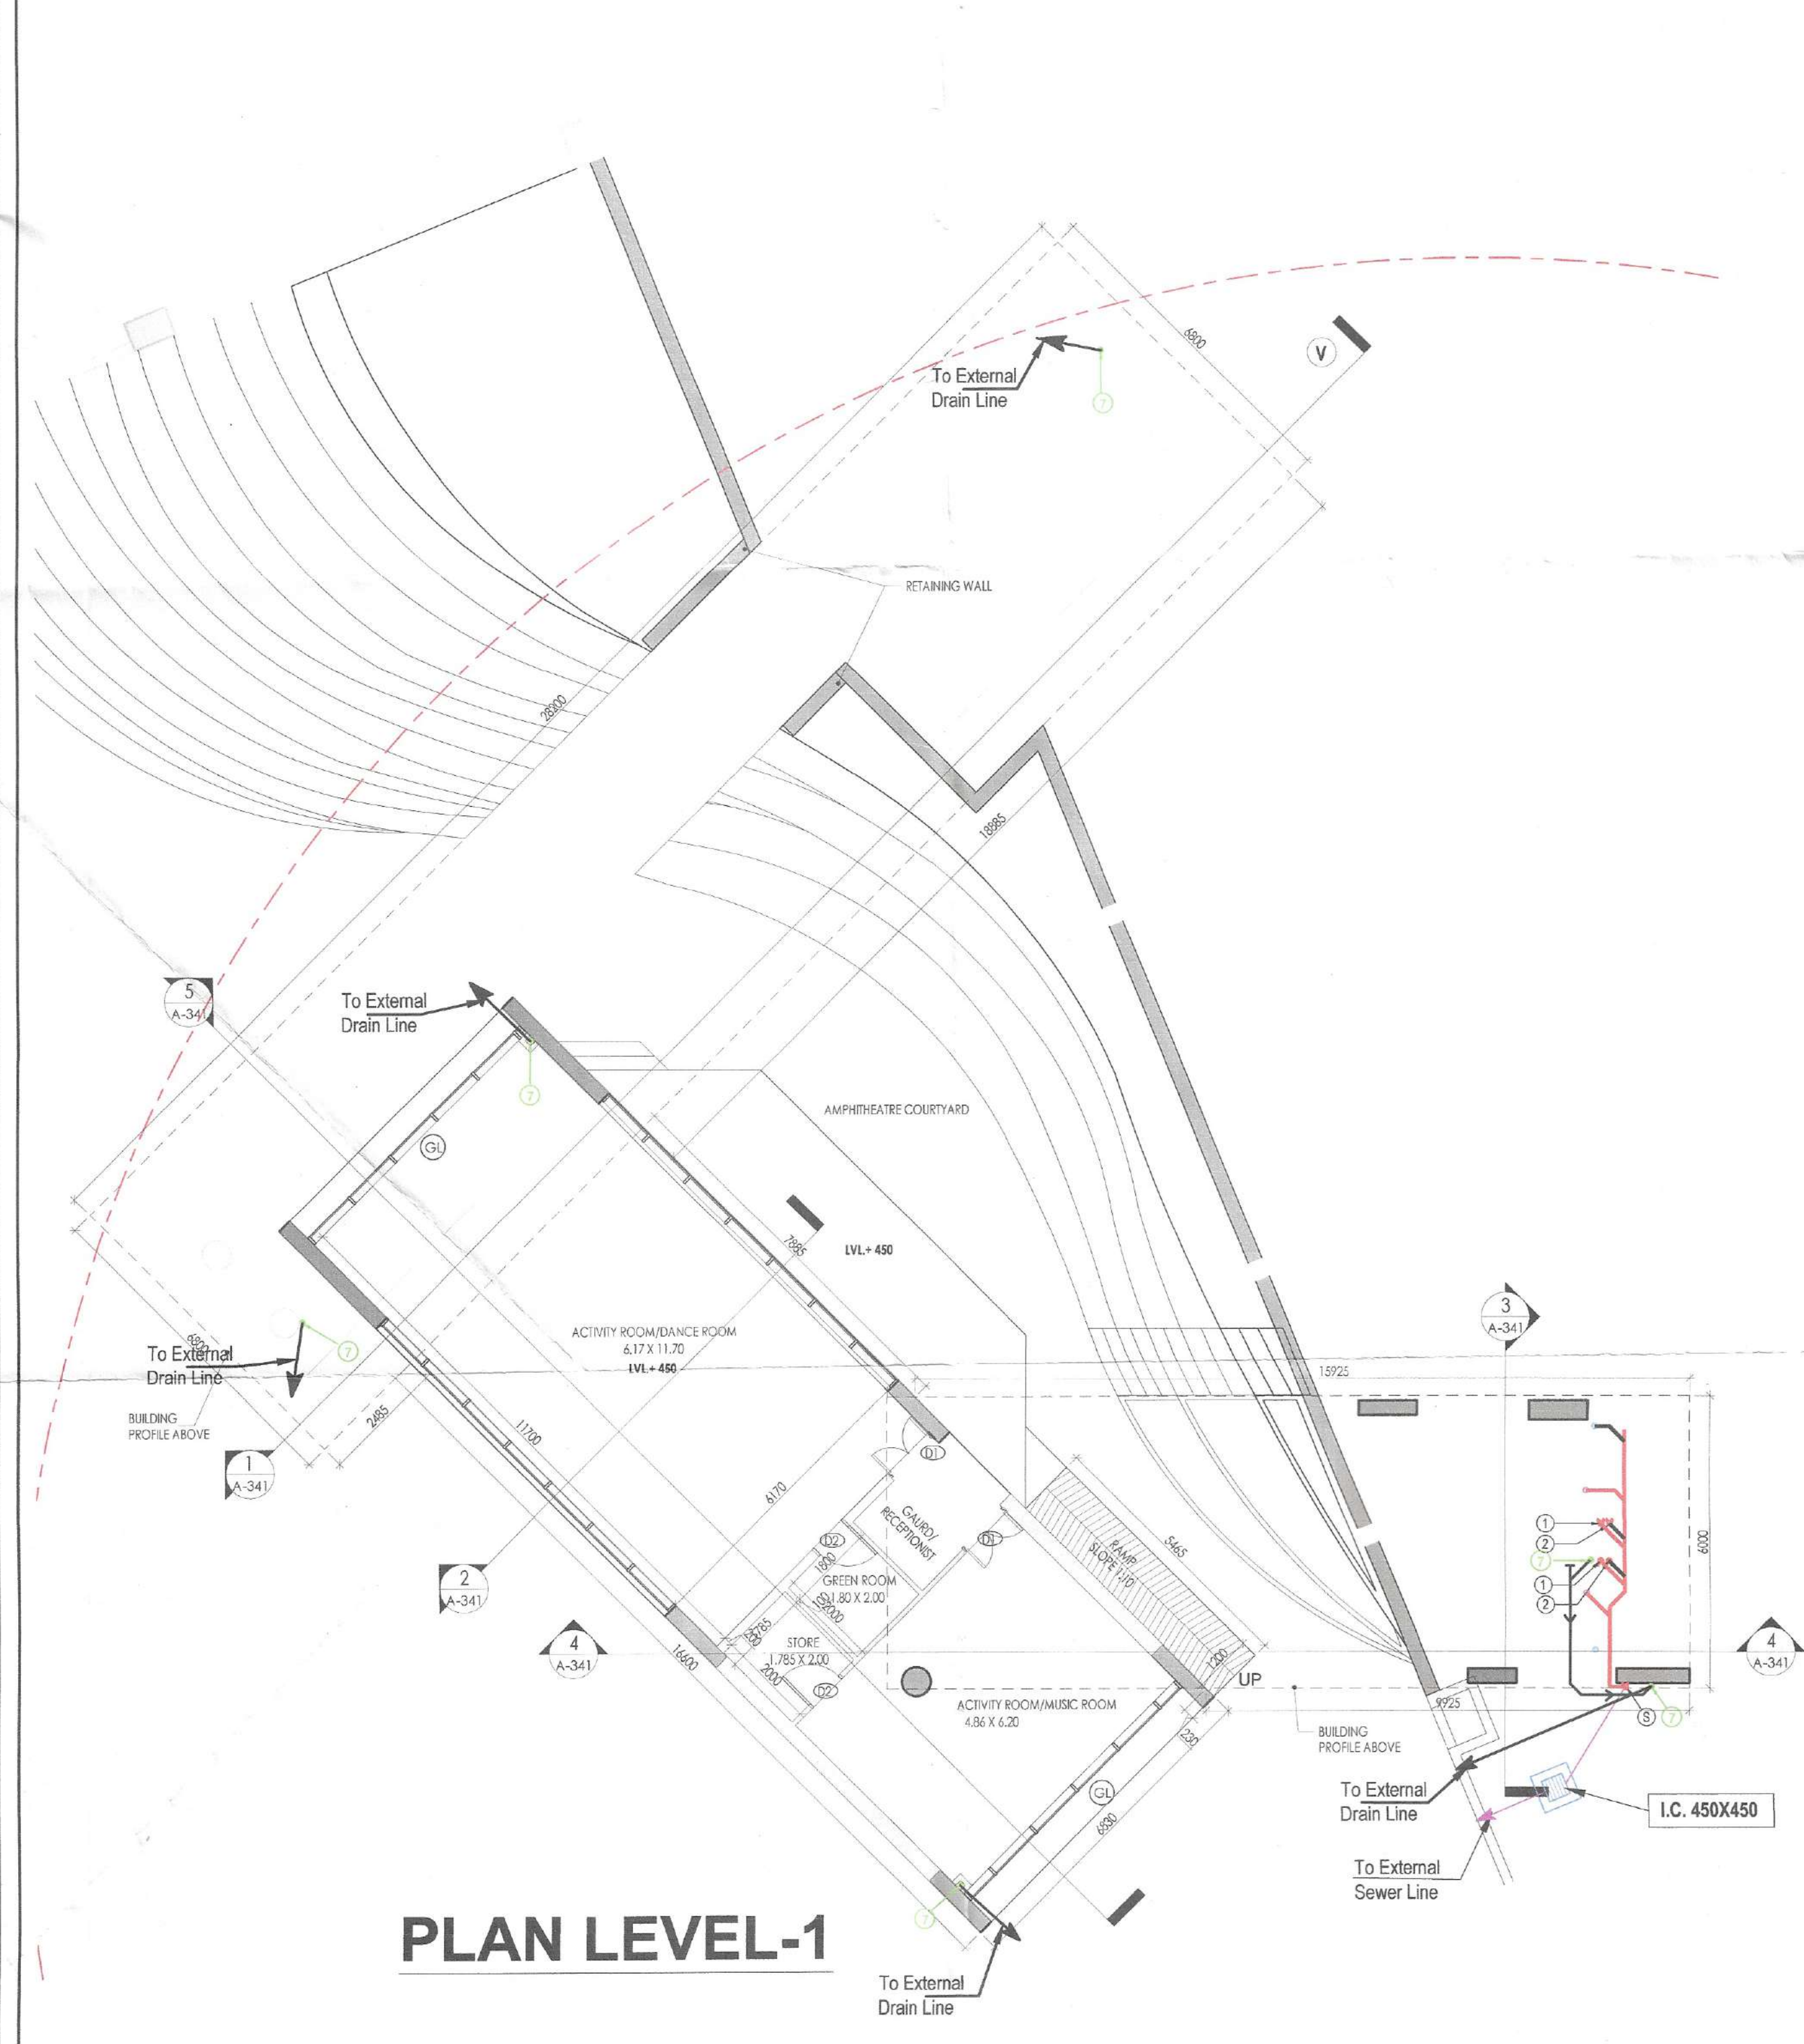

TO BE READ WITH THIS OFFICE MEMO NO.: DATED:

KEY PLAN

PROJECT

Revised Building Plans of Group Housing Colony measuring 22.344 Acres (License No. 41 of 2010 Dated 07.06.2010) in sector-93, Gurugram being developed by Ashiana Housing Ltd. comprising of total of Five (5) phases.

ARCHITECT'S SEAL & SIGNATURE	OWNER/AUTH. SIGN.
<i>[Signature]</i>	<i>[Signature]</i>
SYED MOHD. IMRAN CA 93/16665	ASHIANA HOUSING LTD. Authorized Signatory

Scale : 1 : 200

Drawing Title:- LEVEL-1 & 2 PLAN & AREA DETAILS (LEARNING HUB)

Drawing No:- A-61