


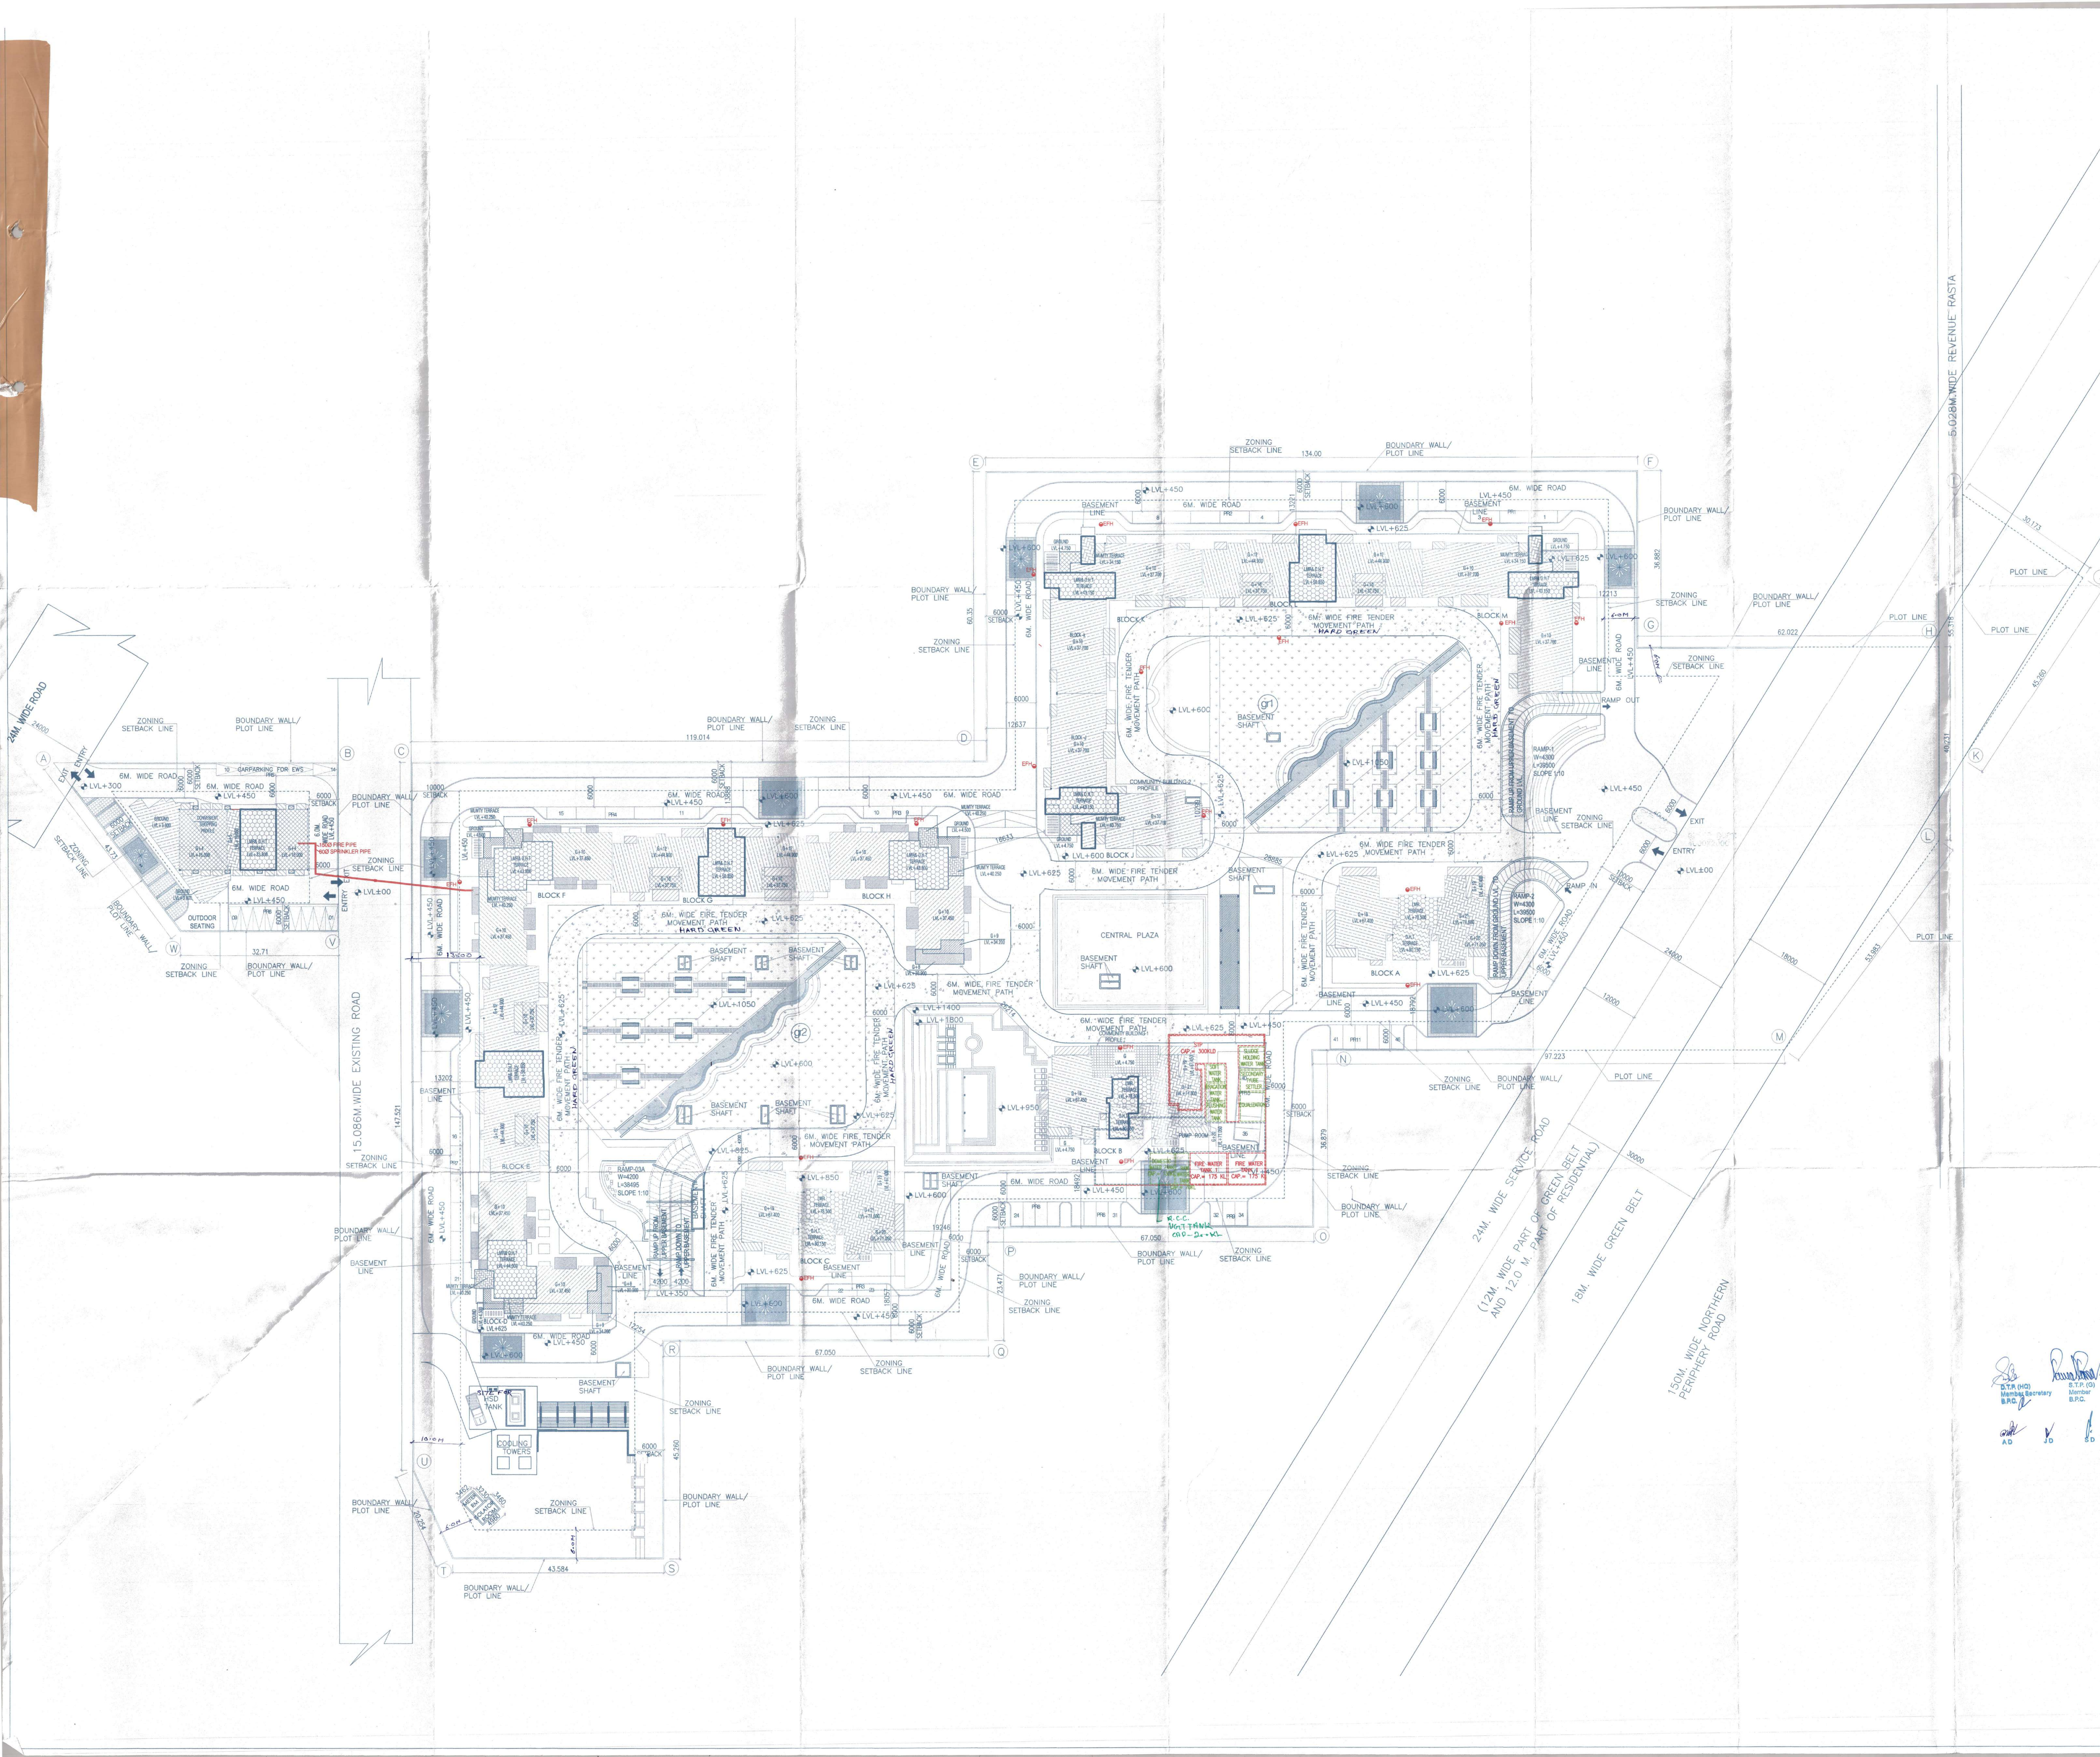

Note :-

1. BUILDING WILL BE DESIGNED (STRUCTURES) AS PER RELEVANT IS CODES FOR EARTH QUAKE RESISTANCE.
2. TOILETS WILL NATURAL VENTILATION WILL HAVE MECHANICAL VENTILATION

LEGEND :-

SYMBOL	DESCRIPTION
---	1000 M MANDIPAL LINE
---	M.S. FIRE LINE
---	TUBE WELL LINE
---	EXTERNAL SEWER LINE
---	STORM WATER LINE
---	MANHOLE
---	CATCH BASIN
---	TUBE WELL
---	GARDEN HYDRANT

Project:

PROPOSED BUILDING PLAN OF GROUP HOUSING MEASURING 10.43125 ACRES (LICENCE NO. 65 OF 2013 DATED 20-07-2013) & (LICENCE NO. 119 OF 2012 DATED 06.12.2012) IN SECTOR-99, GURGAON MANESAR URBAN COMPLEX BEING DEVELOPED BY PLANET EARTH ESTATES PVT. LTD.

Associate Architects

RSMS ARCHITECTS

RSMS ARCHITECTS PVT. LTD.
69, Nora Niwas, Bhawani Kunj
(Behind D2), Vasant Kunj,
New Delhi-110070.
Tel.: 011-26898616, 26898617
www.rsms-arch.com

Checked and approved by
22.11.15/14

Signature and Stamp of Architect and Owner.

ARCHITECT'S SEAL & SIGNATURE	OWNER'S SEAL & SIGNATURE
DECEMBER 2013	Scale : 1:400
Drawing Title:- SITE PLAN (FIRE SCHEME)	Drawing No:- ST-02
SITE PLAN	VATIKA - SOVEREIGN PARK