

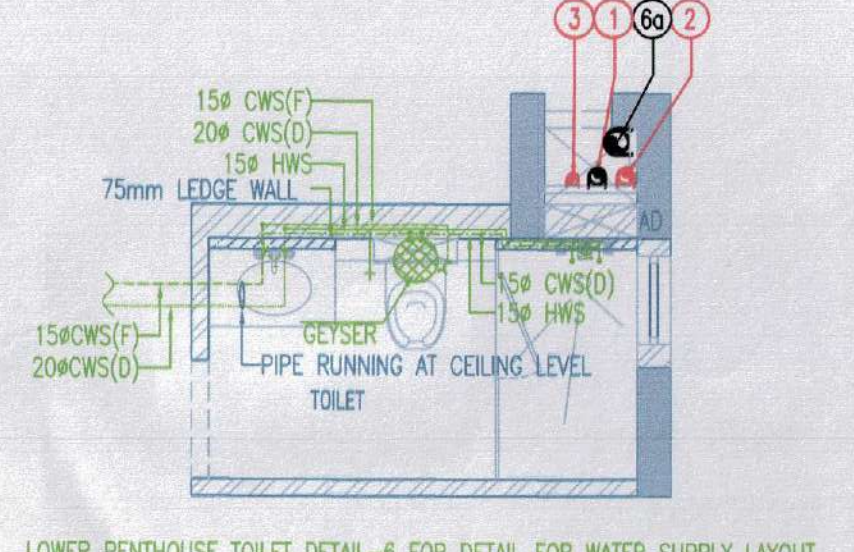
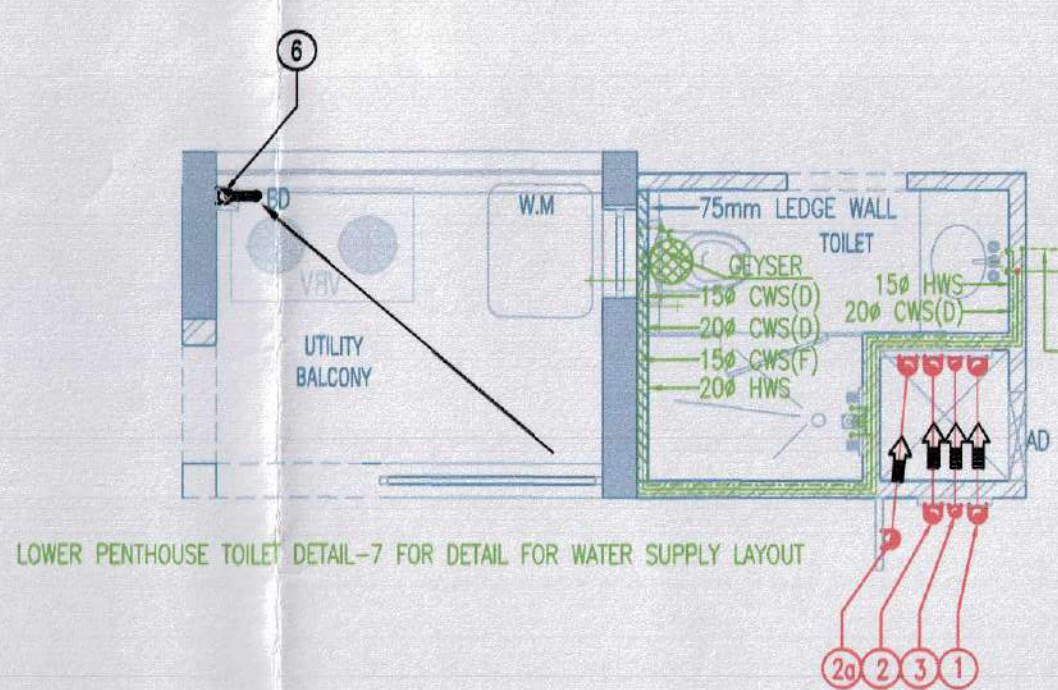
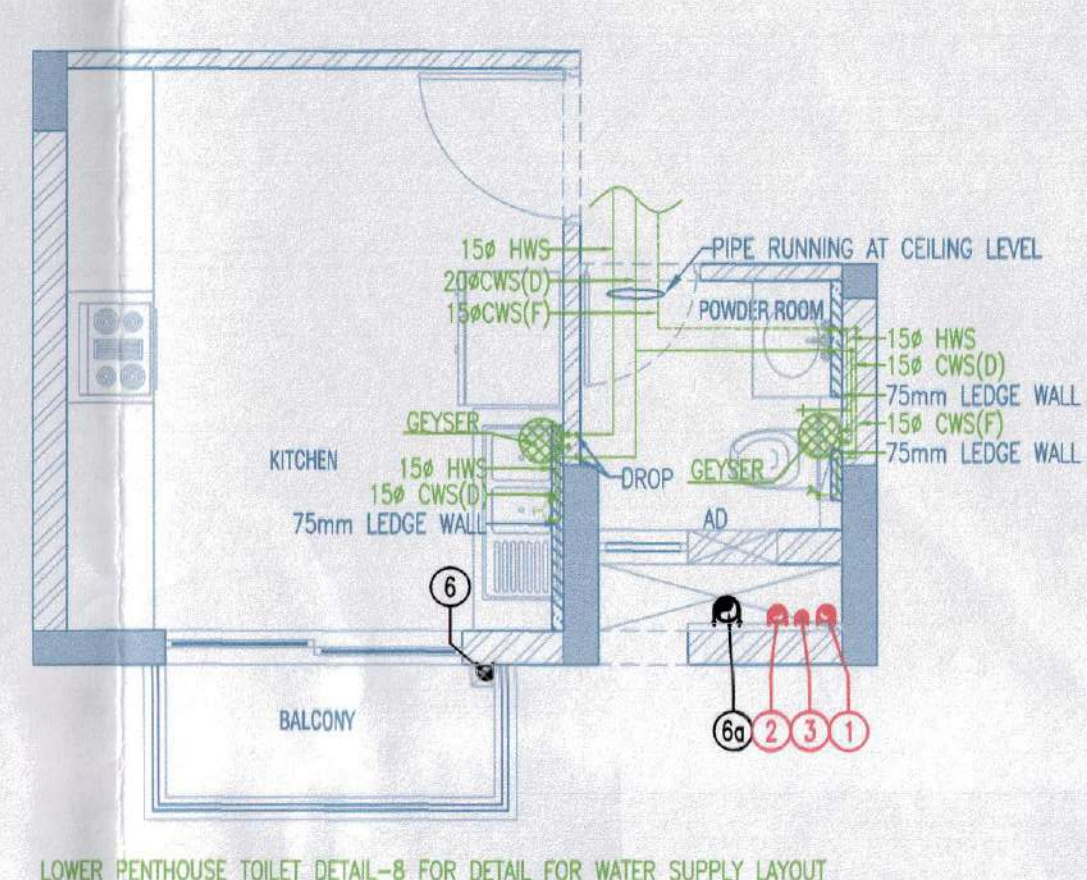
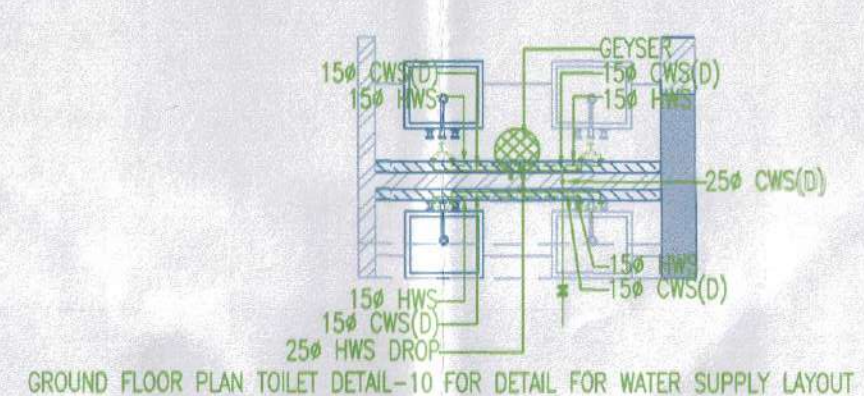
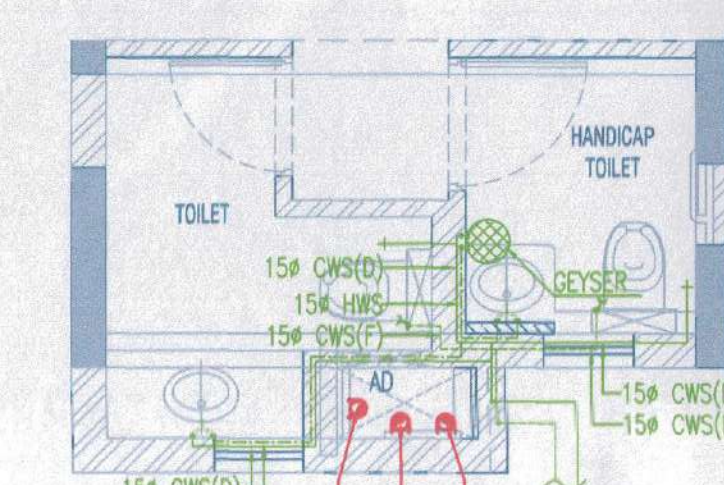
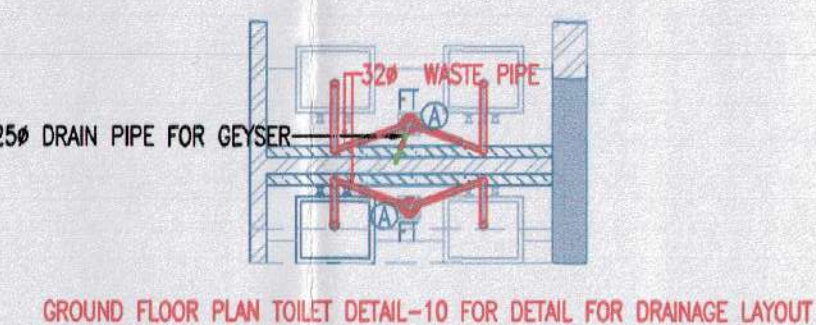
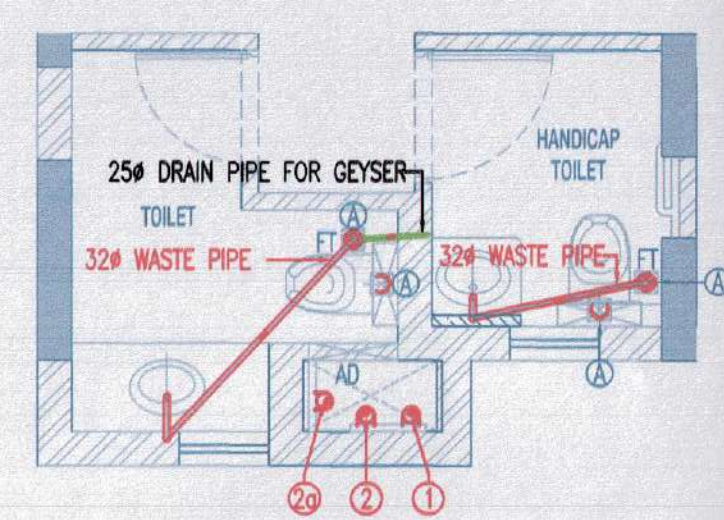
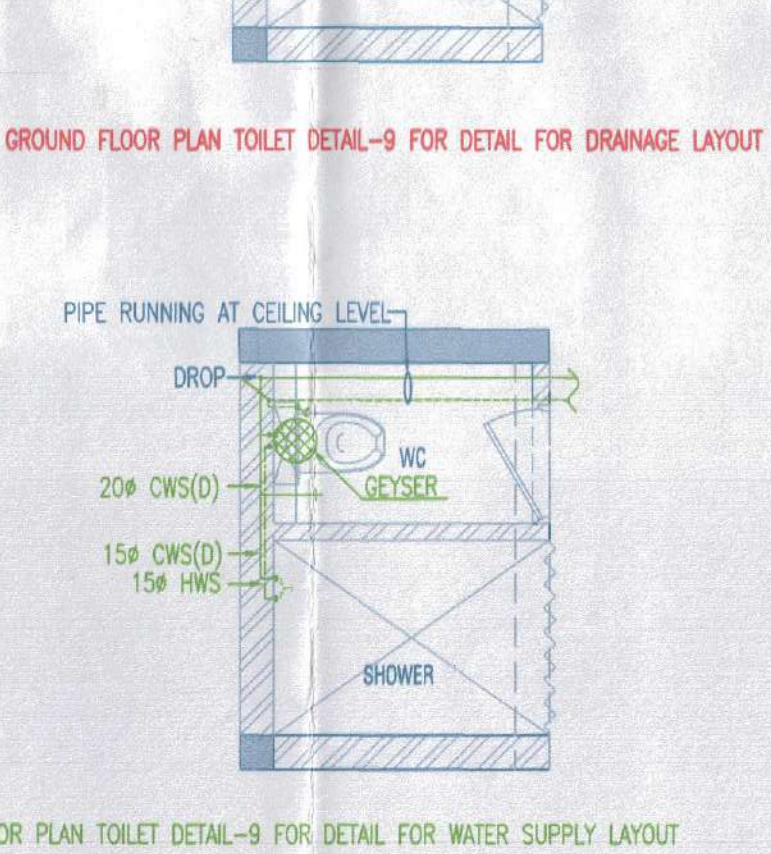
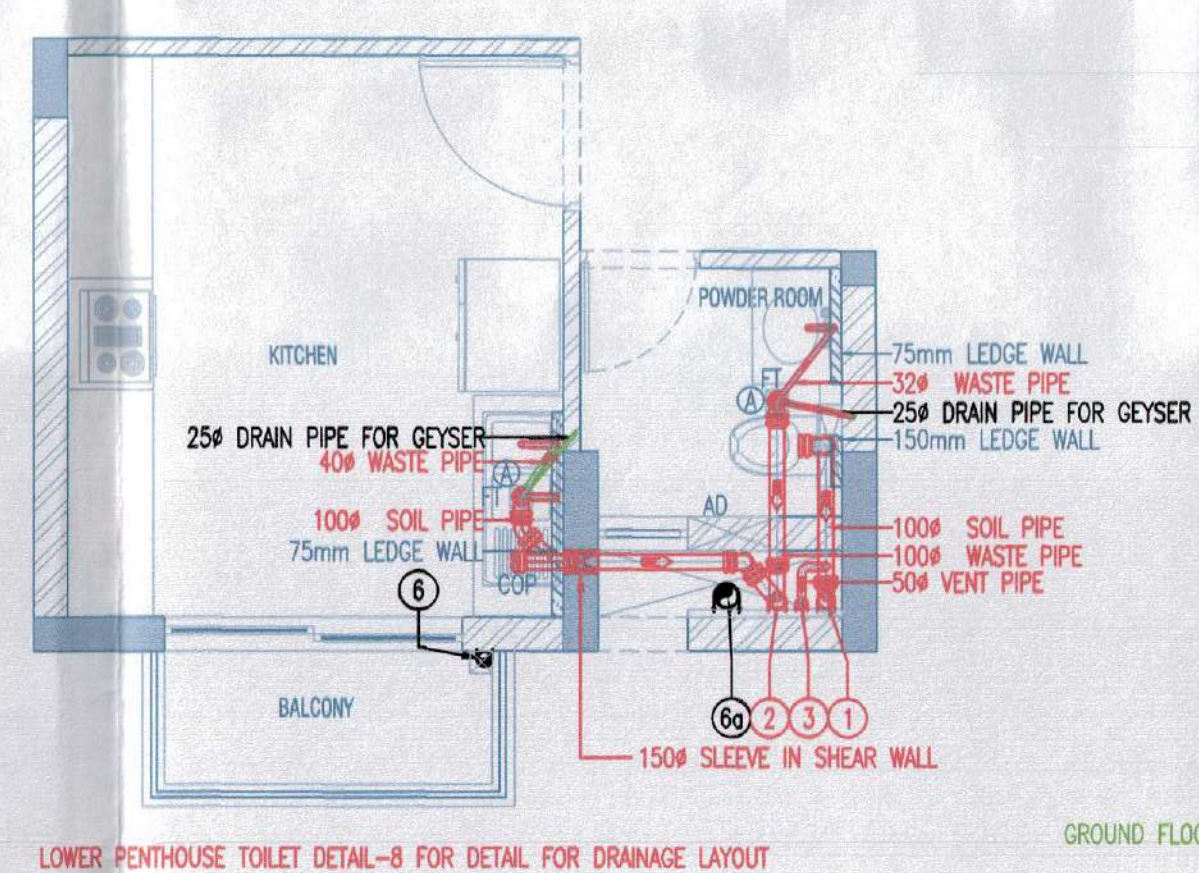
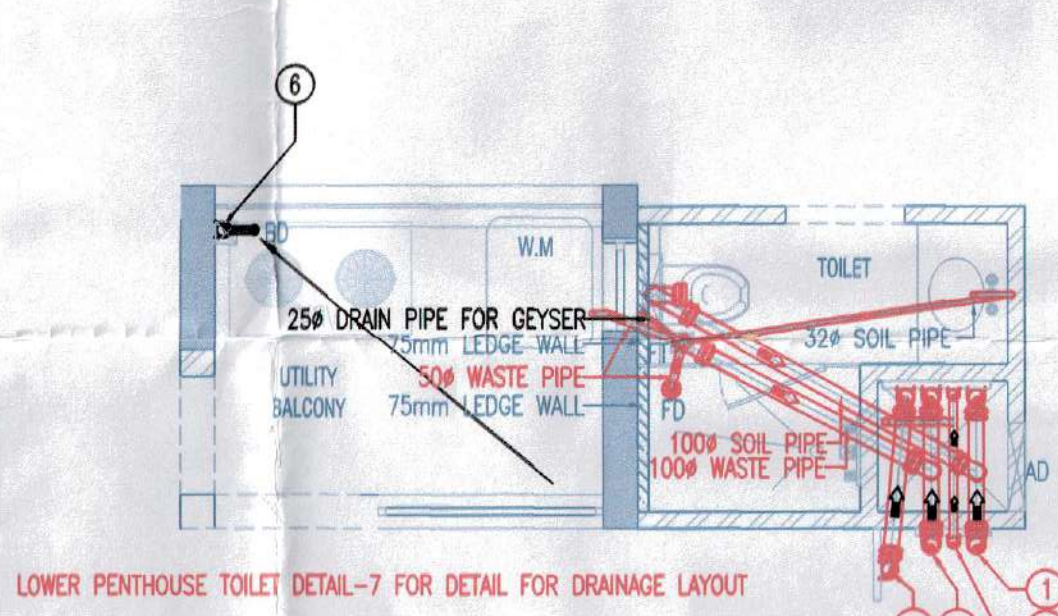
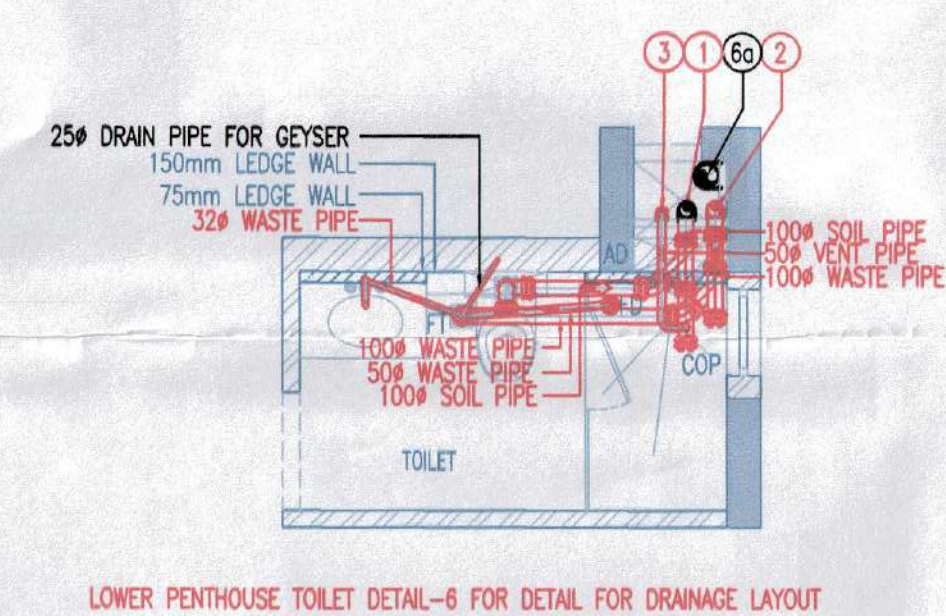
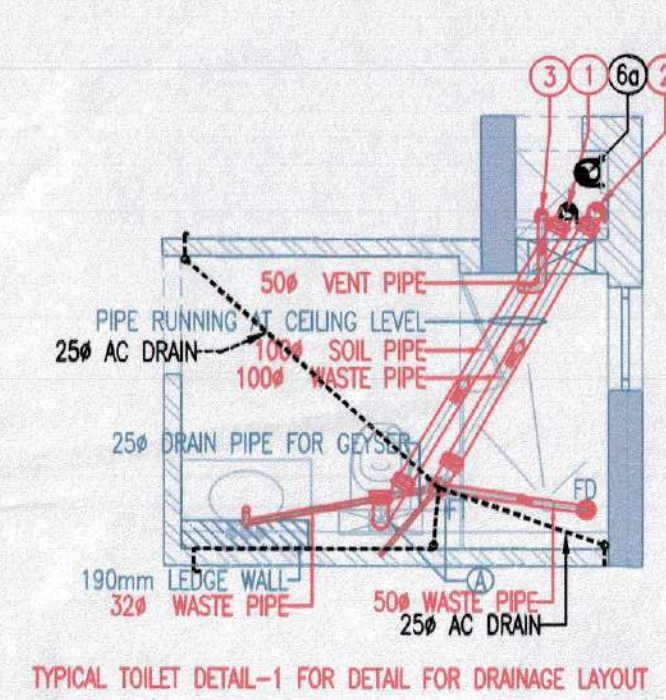
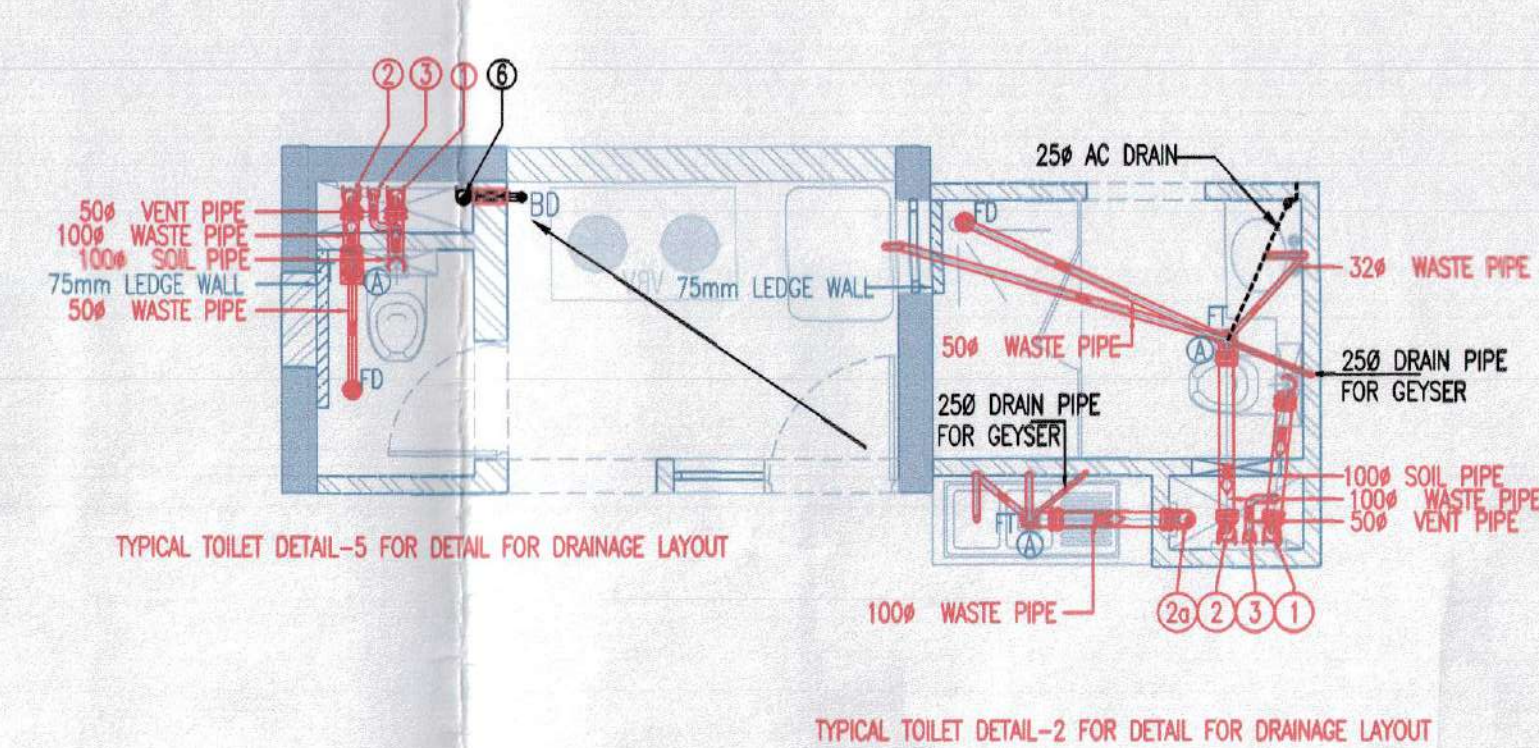
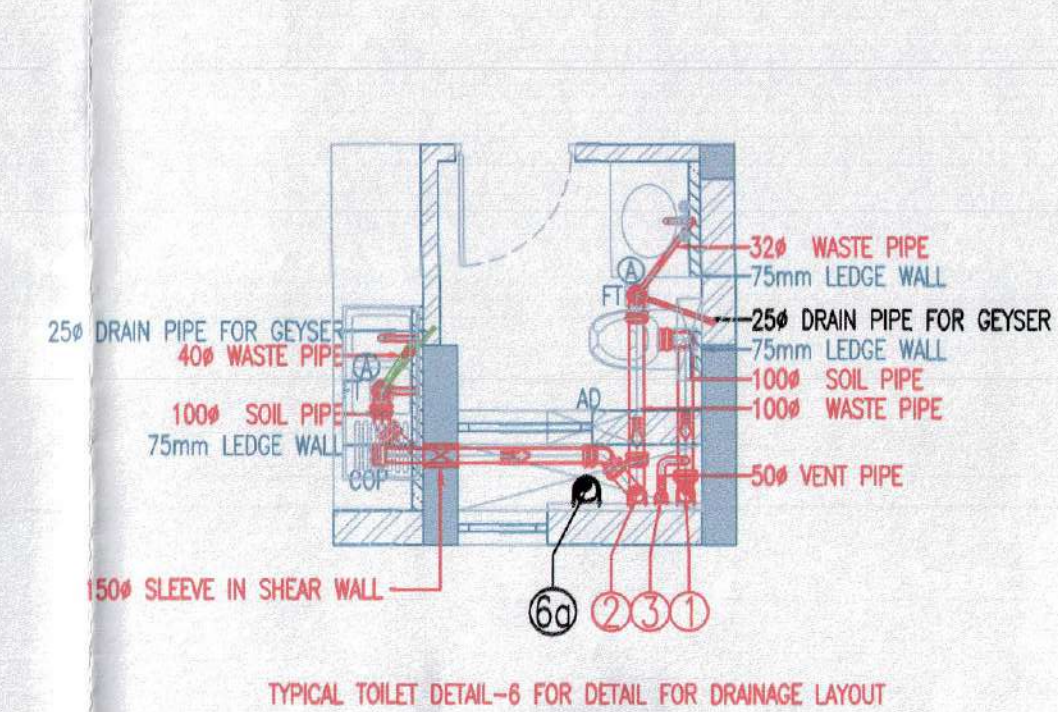
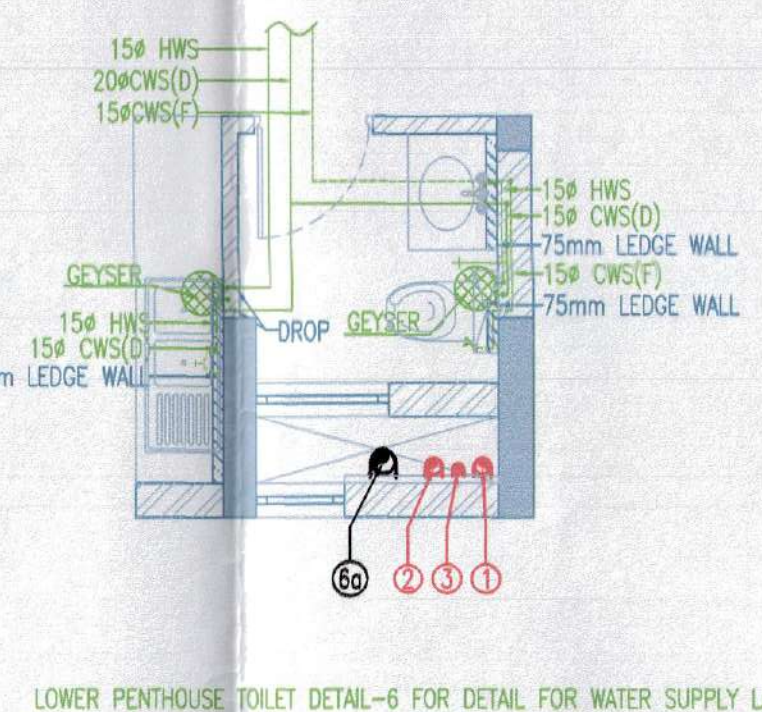
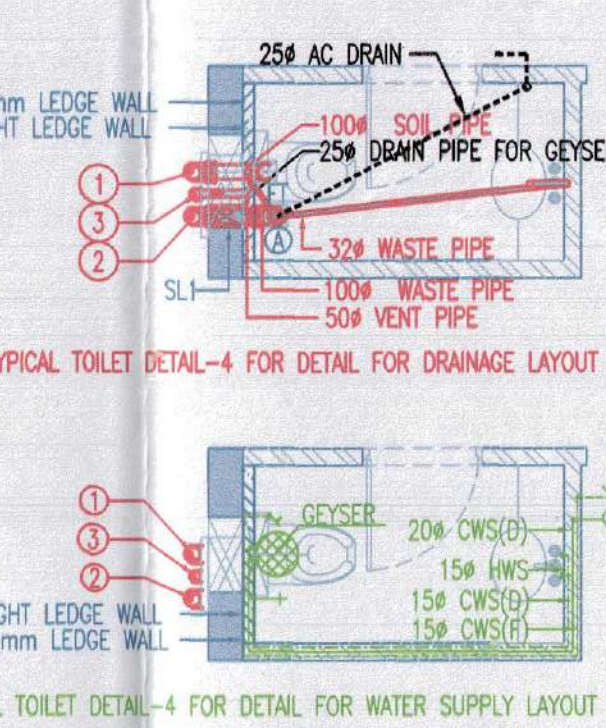
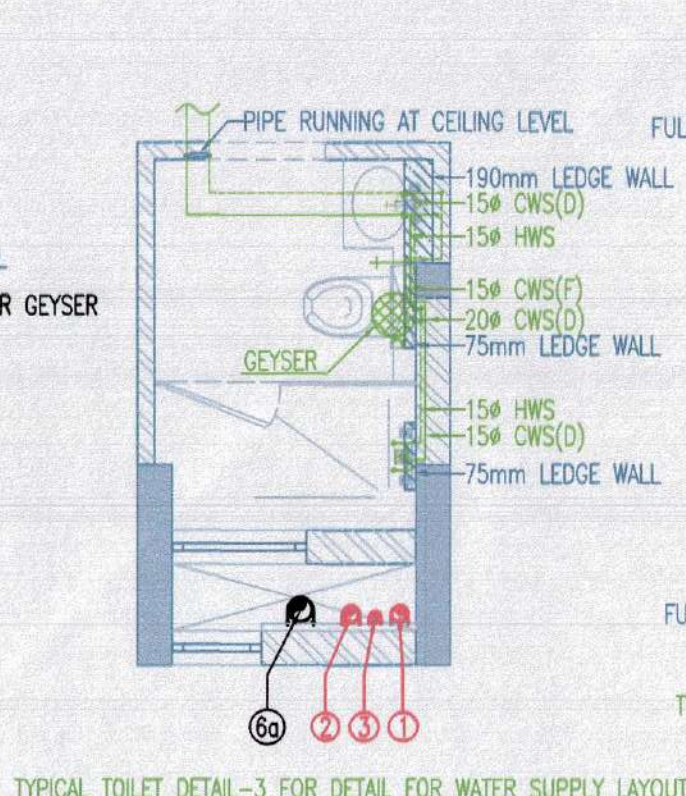
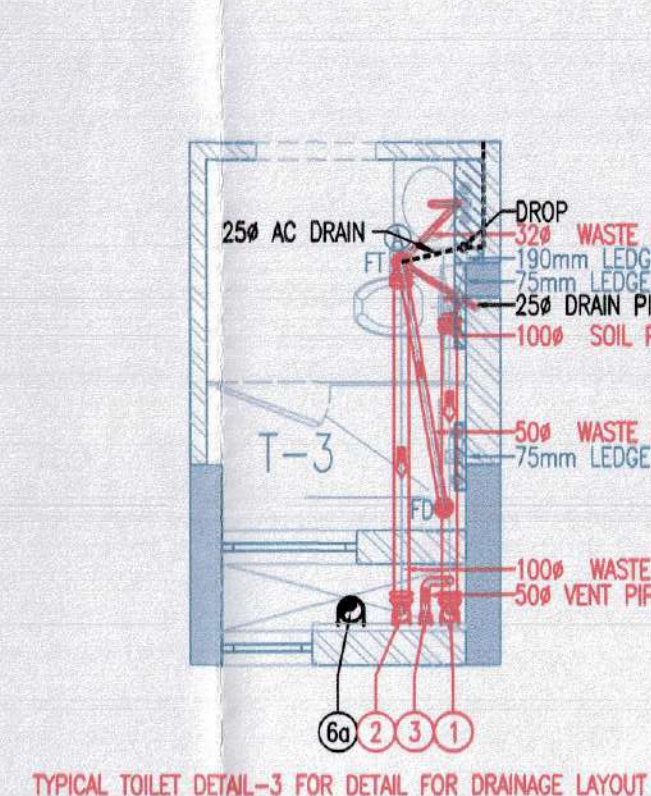
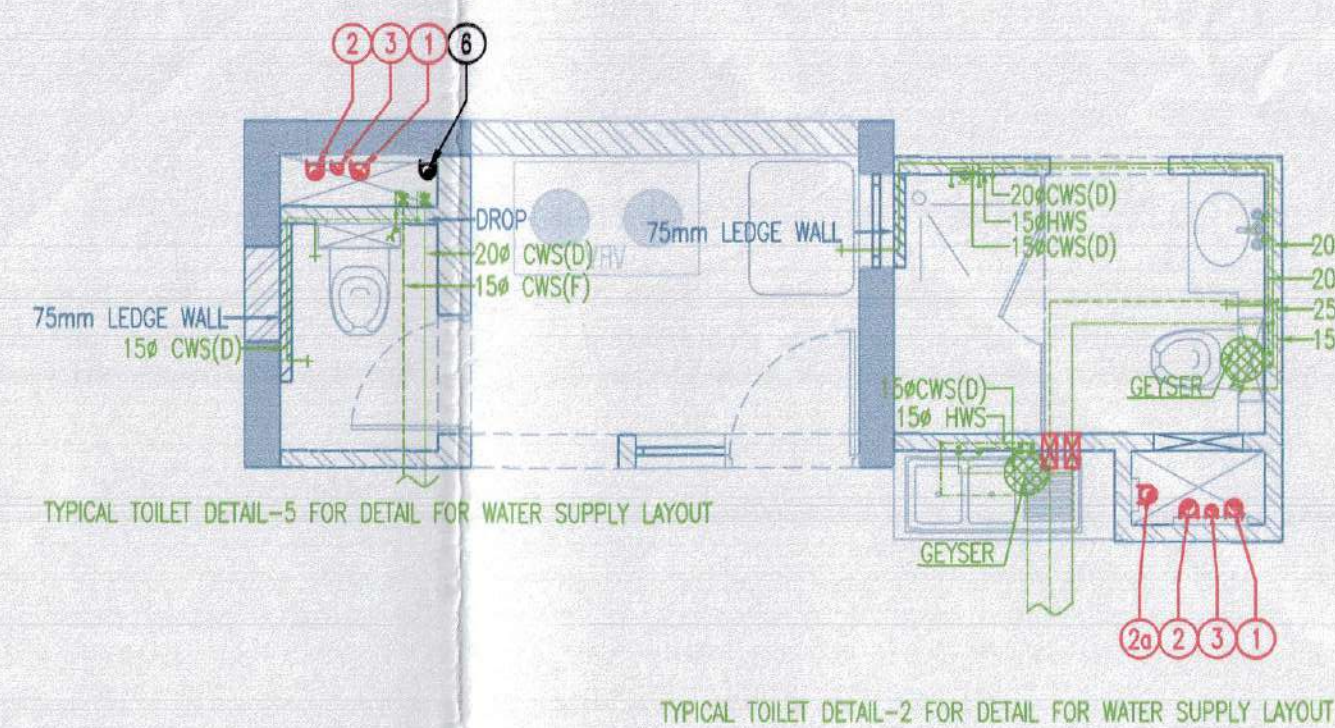


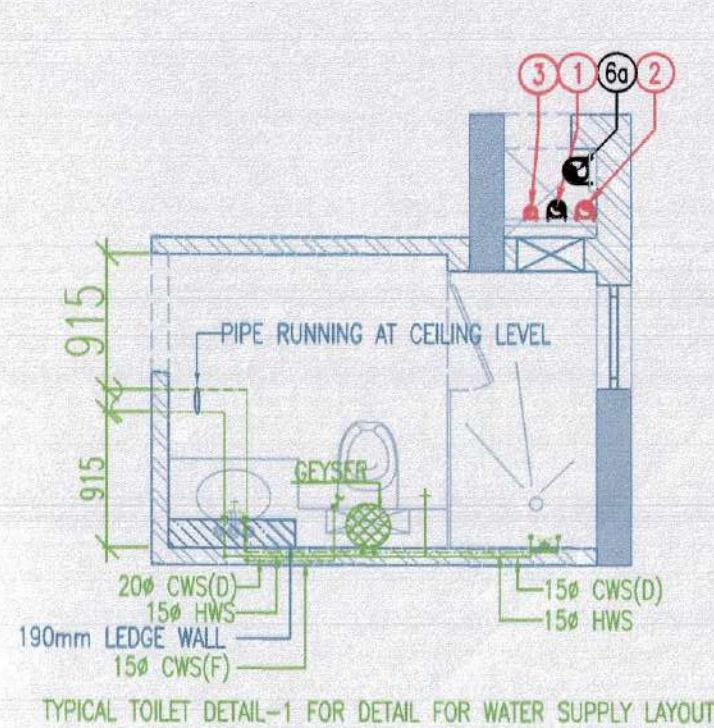

SYMBOL	DESCRIPTION
	SOIL PIPE
	WASTE PIPE
	COLD WATER SUPPLY(DOMESTIC)
	COLD WATER SUPPLY(FLUSHING)
	HOT WATER SUPPLY
	FLOOR TRAP 100x100mm
	FLOOR DRAIN 100x50mm
	URINAL TRAP 100x100mm
	CLEAN OUT PLUG
	BALL VALVE

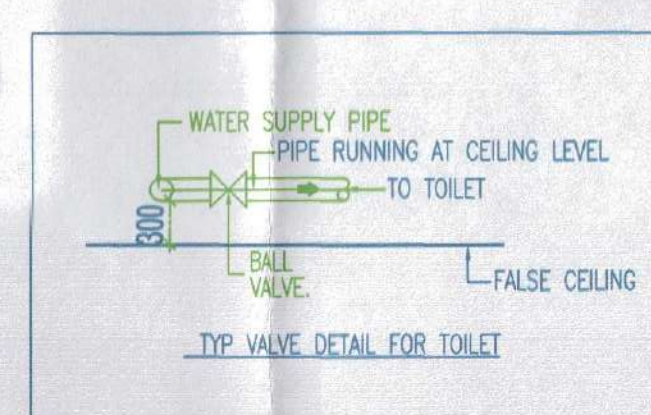

- LEGEND FOR VERTICAL PIPES:-
- ① 100mm SOIL & VENT PIPE
 - ② 100mm WASTE & VENT PIPE
 - ③ 100mm WASTE PIPE FOR KITCHEN
 - ④ 75mm ANTISIPHONAGE VENT PIPE
 - ⑤ COLD WATER SUPPLY(DOMESTIC) FOR LOWER ZONE
 - ⑥ COLD WATER SUPPLY(DOMESTIC) FOR UPPER ZONE
 - ⑦ HOT WATER SUPPLY FOR LOWER ZONE(KITCHEN)
 - ⑧ HOT WATER SUPPLY FOR UPPER ZONE(KITCHEN)
 - ⑨ COLD WATER SUPPLY(FLUSHING)
 - ⑩ 100mm BALCONY RAIN WATER PIPE
 - ⑪ 150mm RAIN WATER PIPE
 - ⑫ 65mm DOMESTIC WATER RISER
 - ⑬ 50mm FLUSHING WATER RISER
 - ⑭ CUTOUT 150x150
 - ⑮ 50mm SLEEVE
 - ⑯ 65mm SLEEVE
 - ⑰ 150mm M.S FIRE PIPE
 - ⑱ 80mm M.S DRAIN PIPE
 - ⑲ 150mm M.S SPRINKLER RISER
 - FHC FIRE HOSE CABINET

Note:-

1. BUILDING WILL BE DESIGNED (STRUCTURES) AS PER RELEVANT IS CODES FOR EARTH QUAKE RESISTANCE.

2. TOILETS WILL NATURAL VENTILATION WILL HAVE MECHANICAL VENTILATION

LEGEND:-

Project:

PROPOSED GROUP HOUSING MEASURING 10.43125 ACRES (LICENCE NO. 65 OF 2013 DATED 20-07-2013) & (LICENCE NO. 119 OF 2012 DATED 06.12.2012) IN SECTOR-99, GURGAON MANESAR URBAN COMPLEX BEING DEVELOPED BY PLANET EARTH ESTATES PVT. LTD.

Associate Architects

RSMS ARCHITECTS

RSMS ARCHITECTS PVT. LTD.
69, Nora Niwas - Bhawani Kunj
(Behind D2), Vasant Kunj,
New Delhi-110070.
Tel.: 011-26898616, 26898617
www.rsms-arch.com

Sd/- *Dr. Ravi Prakash*
S.P. (G) Secretary
Member B.P.C. Chairman B.P.C.
Sd/- *Dr. Ravi Prakash*
S.P. (G) Secretary
Member B.P.C. Chairman B.P.C.

ARCHITECT'S SEAL & SIGNATURE

OWNER'S SEAL & SIGNATURE

DECEMBER.2013 Scale : 1:50
Drawing Title:-
TOILET DETAIL OF ALL TOWER & BLOCK
TOILET DETAIL

N

Drawing No:-

T-01

VATKA - SOVEREIGN PARK