

Note:-

1. BUILDING WILL BE DESIGNED (STRUCTURES) AS PER RELEVANT IS CODES FOR EARTH QUAKE RESISTANCE.

2. TOILETS WILL NATURAL VENTILATION WILL HAVE MECHANICAL VENTILATION

LEGEND:-

Project:

PROPOSED GROUP HOUSING MEASURING 10.43125 ACRES (LICENCE NO. 65 OF 2013 DATED 20-07-2013) & (LICENCE NO. 119 OF 2012 DATED 06.12.2012) IN SECTOR-99, GURGAON MANESAR URBAN COMPLEX BEING DEVELOPED BY PLANET EARTH ESTATES PVT. LTD.

Associate Architects



RSMS ARCHITECTS PVT. LTD.
69,Nora Niwas Bhawani Kunj
(Behind D2), Vasant Kunj,
New Delhi-110070.
Tel.: 011-26898616,26898617
www.rsms-arch.com

Checked and found ok for P-11/12/2013
(Internal) Signatures and Stamps
Forwarding to: 23/12/2013
Signature of Architect
NADA Approval Stamp

Sd/- Sd/- Sd/-
Director (H) Member C.T.P. (H)
Secretary Member Chairman
B.P.C. B.P.C. B.P.C.
ATP

ARCHITECT'S SEAL & SIGNATURE

OWNER'S SEAL & SIGNATURE



For Planet Earth Estates Pvt. Ltd.
Authorised Signatory

DECEMBER.2013

Scale : 1:100

N

Drawing Title:-



Drawing No:-

TERRACE & WATER TANK & ROOF PLAN

BK-02

BLOCK-K

VATIKA - SOVEREIGN PARK

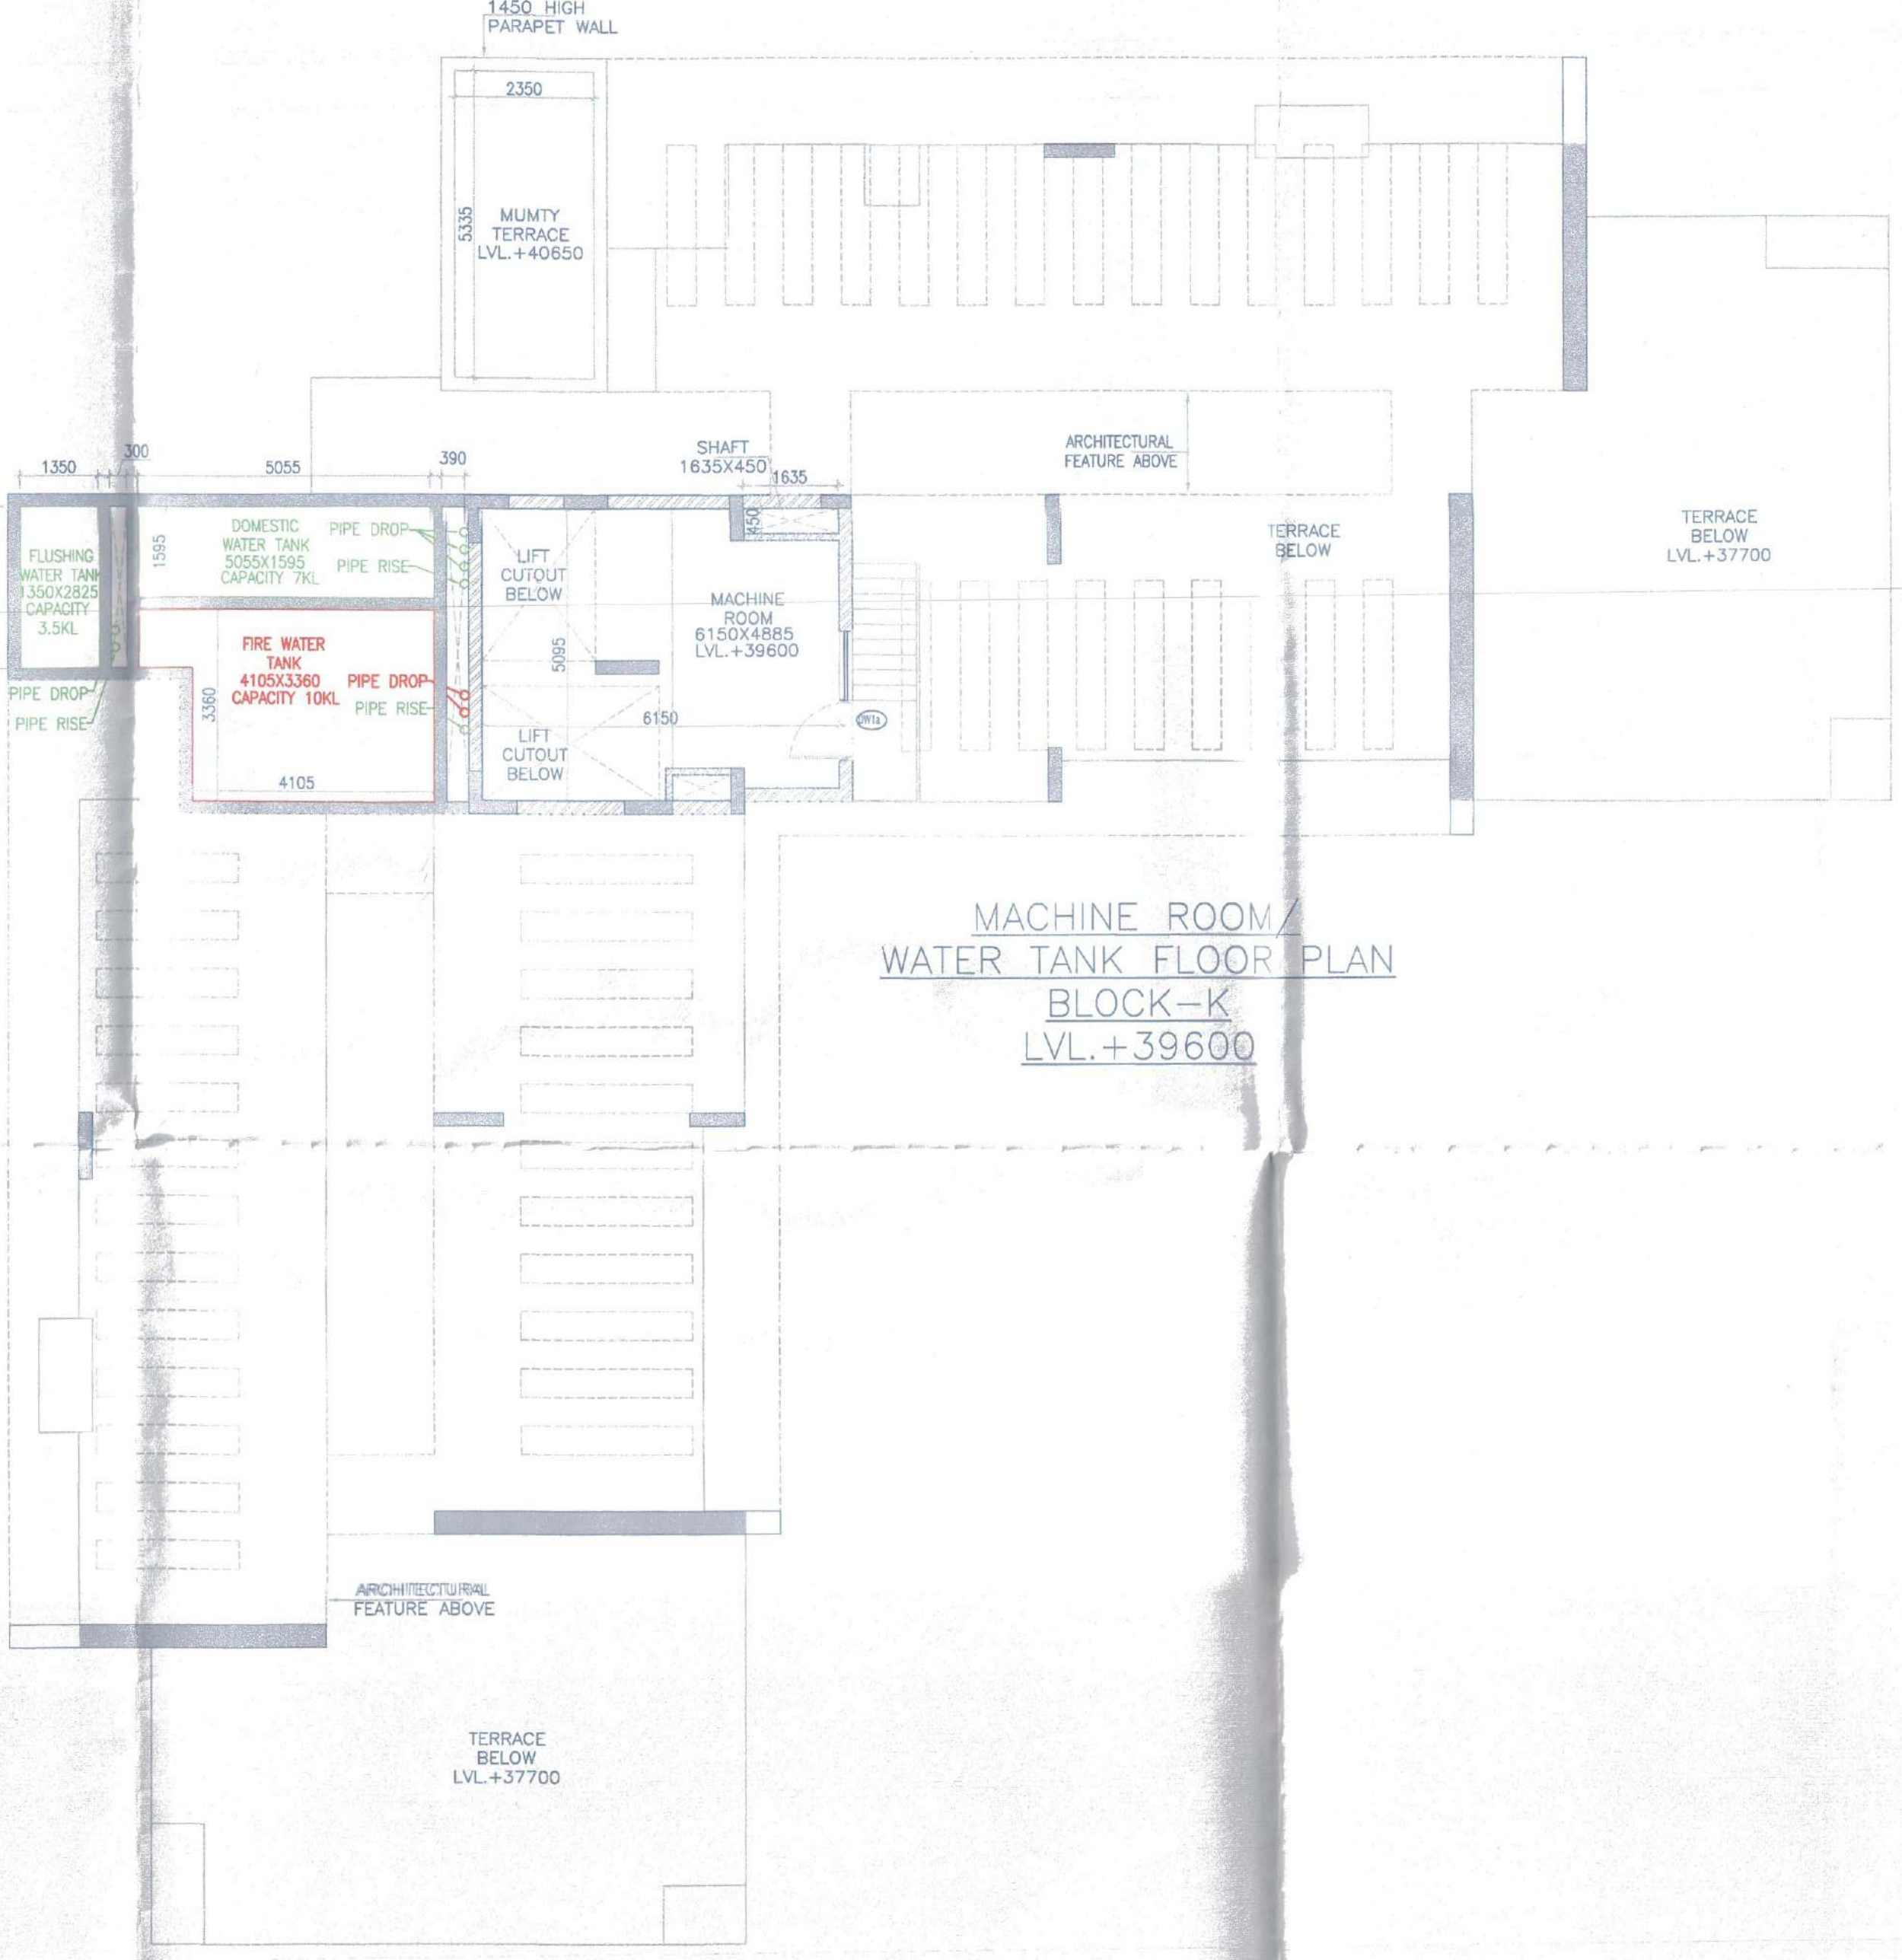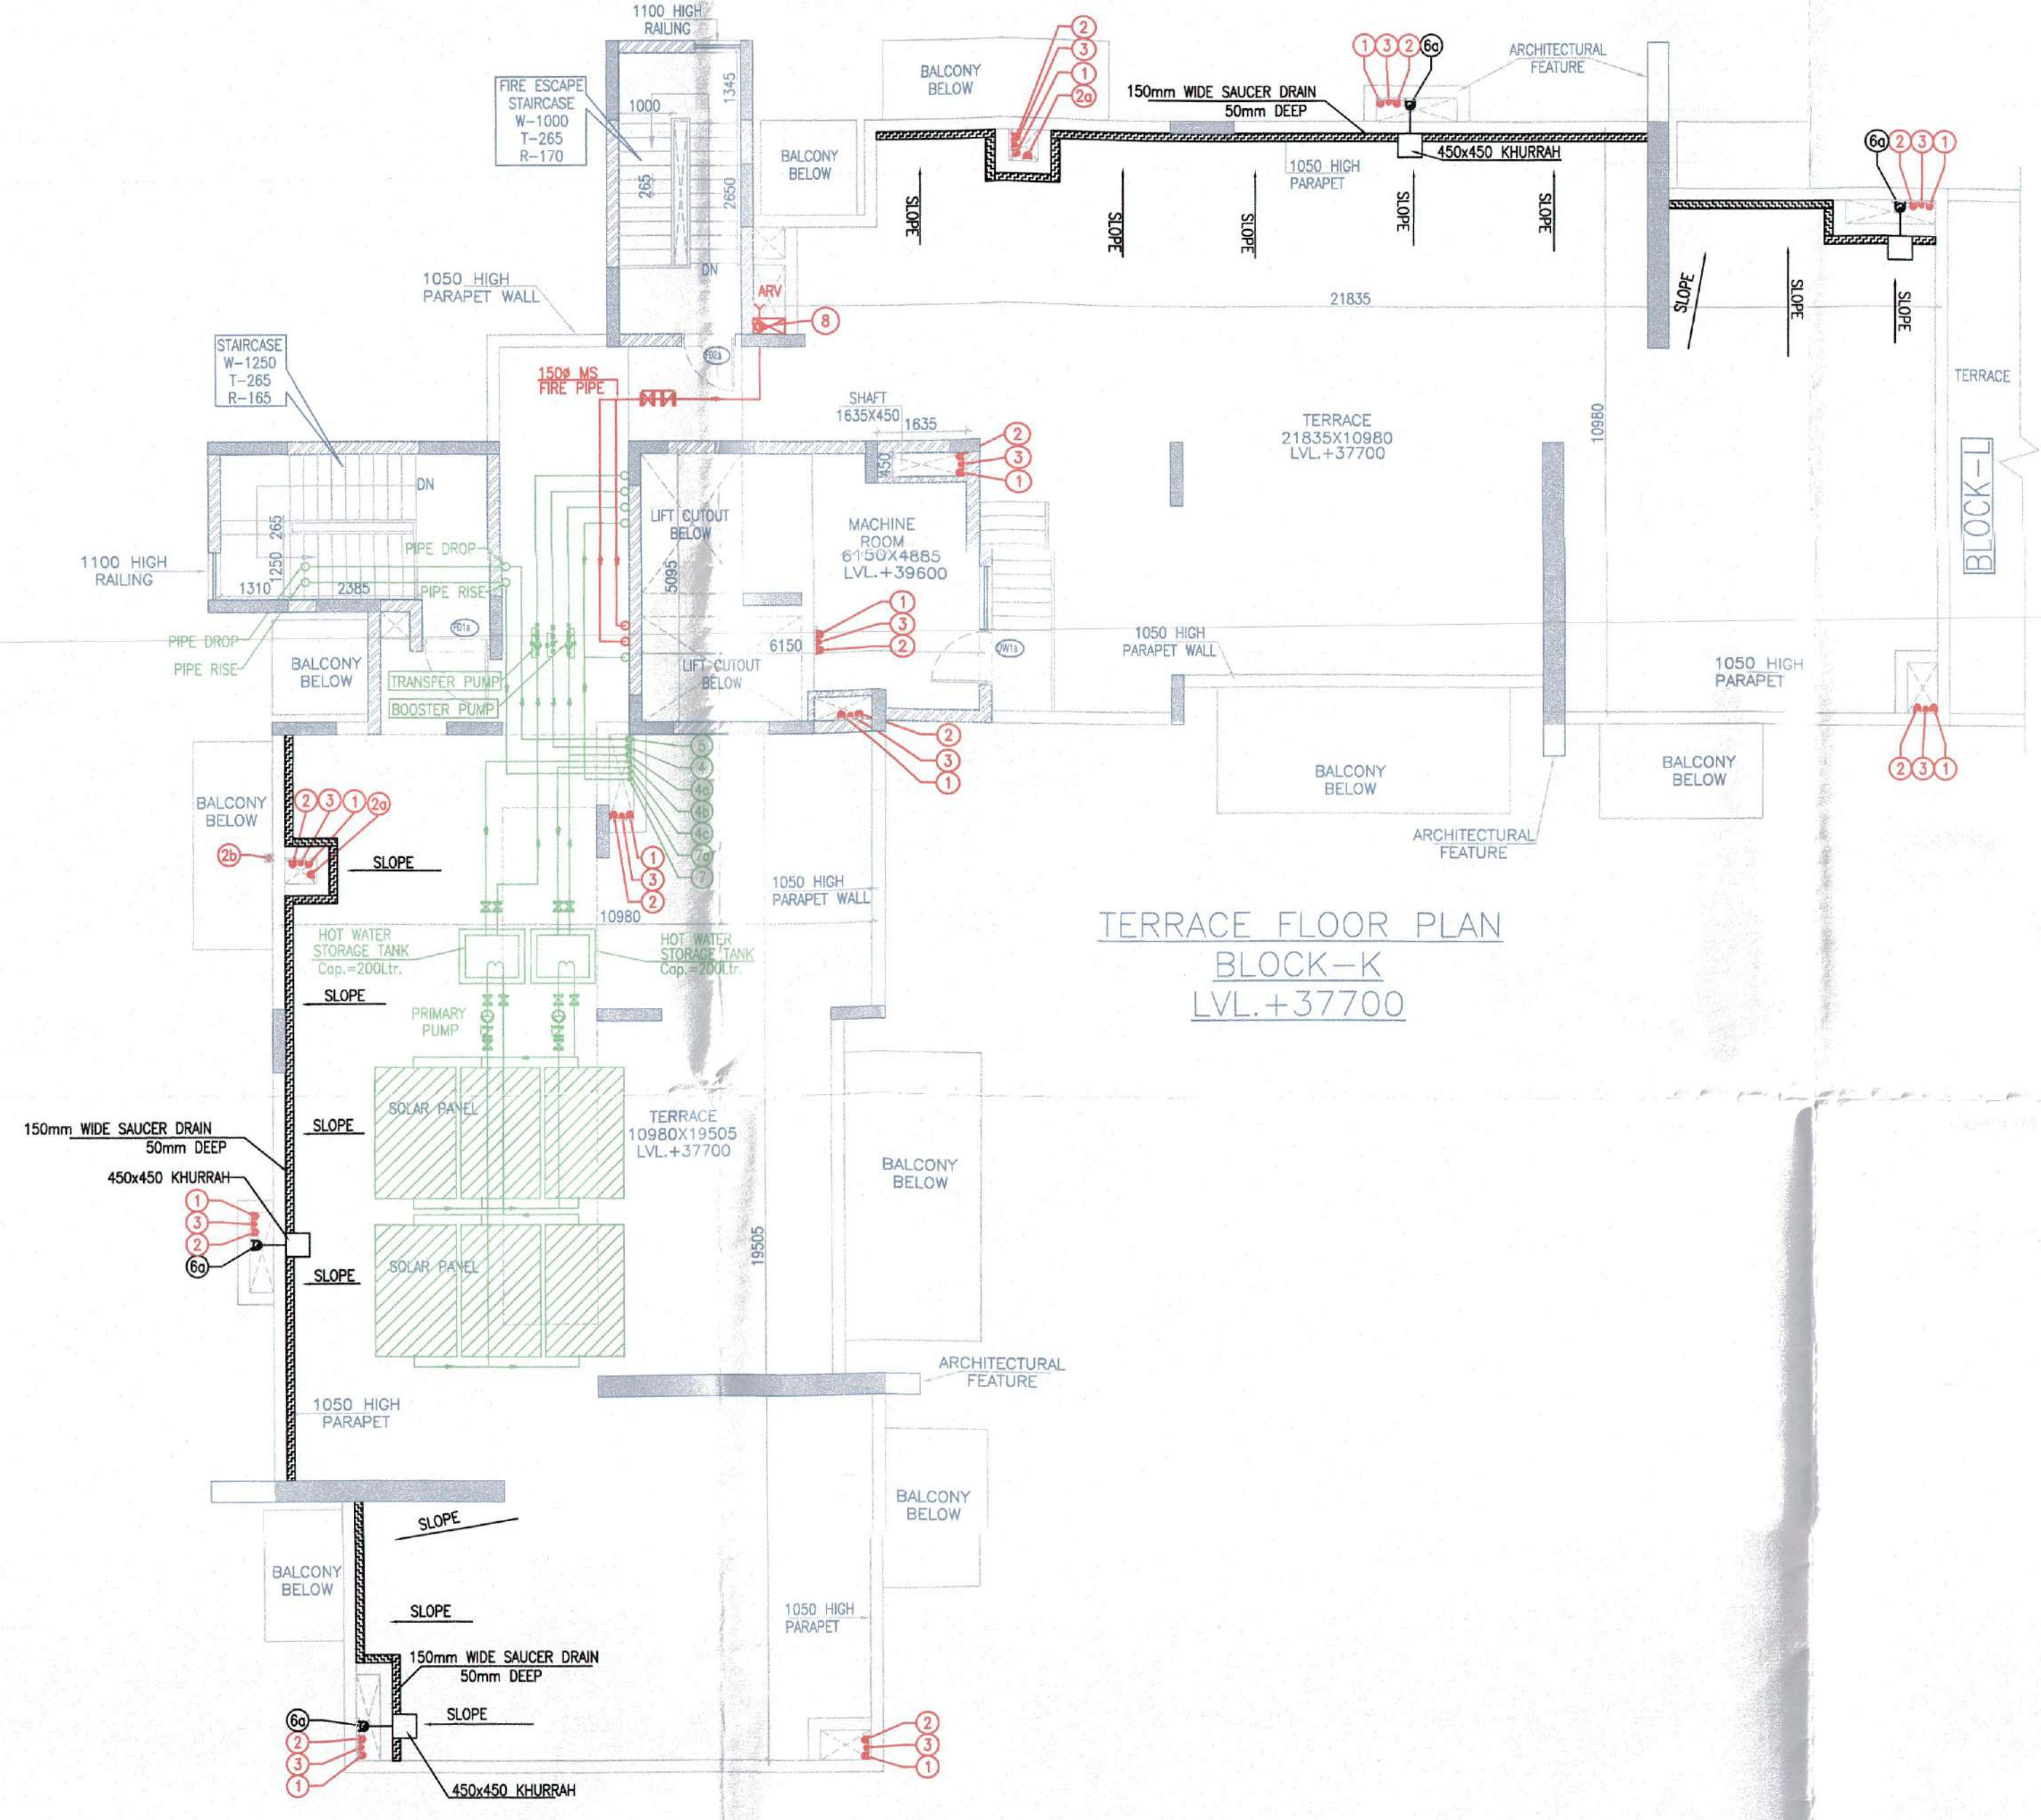

LEGEND FOR VERTICAL PIPES:-	
①	100ø SOIL & VENT PIPE
②	100ø WASTE & VENT PIPE
③	100ø WASTE PIPE FOR KITCHEN
④	100ø UTILITY DRAIN PIPE
⑤	75ø ANTISYPHONAGE VENT PIPE
⑥	COLD WATER SUPPLY(DOMESTIC) FOR LOW ZONE
⑦	COLD WATER SUPPLY(DOMESTIC) FOR UPPER ZONE
⑧	HOT WATER SUPPLY FOR LOWER FLOOR(KITCHEN)
⑨	HOT WATER SUPPLY FOR UPPER FLOOR(KITCHEN)
⑩	COLD WATER SUPPLY(FLUSHING)
⑪	75ø BALCONY RAIN WATER PIPE
⑫	150ø RAIN WATER PIPE
⑬	50ø DOMESTIC WATER RISER
⑭	40ø FLUSHING WATER RISER
⑮	150ø M.S FIRE PIPE
⑯	80ø M.S DRAIN PIPE
⑰	150ø M.S SPRINKLER RISER
FHC	FIRE HOSE CABINET

