

This is a "PROVISIONAL BUILDING PLAN" approved only for the purpose of inviting objections from the general public



[Signatures]
A.T.P. (HQ) Member B.P.A.C.
S.T.P. (HQ) Member Secretary B.P.A.C.
S.T.P. (G) Member B.P.A.C.
Chairman B.P.A.C.
ATP (HQ)
AD PA AP

MEMBER BPAC

(Dinesh Kumar) PA(HQ)

Checked and found ok for Public Health (Internal) Service only subject to comments in forwarding letter No.DV.....

Superintending Engineer (HQ) for Chief Engineer-1 HSVP, Patna
JDEW-21

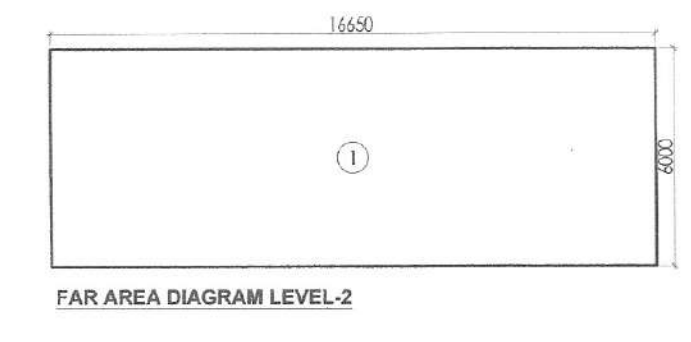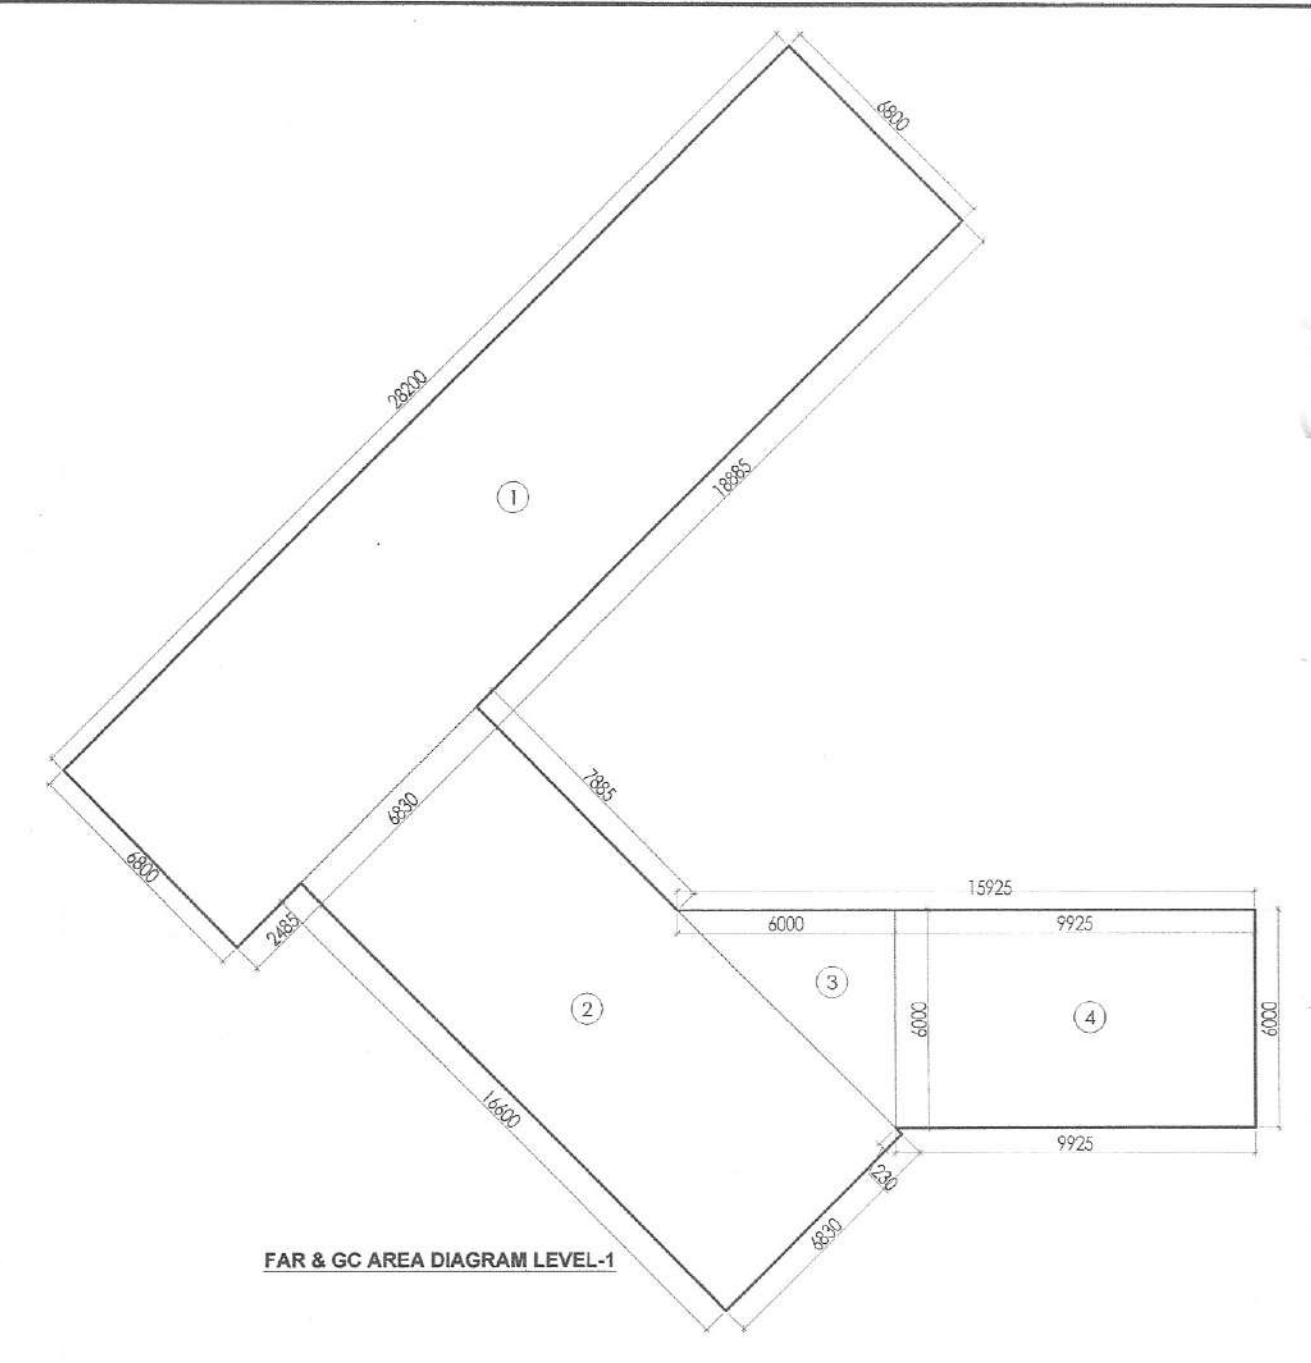




LEVEL-1 AREA CALCULATIONS					
NO.	COEFF.	LENGTH	BREADTH	QUANTITY	AREA (SQ.M)
1	1	28.200	6.800	1	191.760
2	1	18.600	6.830	1	113.378
3	0.5	6.000	6.000	1	18.000
4	1	9.925	6.000	1	59.550
TOTAL FAR & GC AREA					382.688

LEVEL-2 AREA CALCULATIONS					
NO.	COEFF.	LENGTH	BREADTH	QUANTITY	AREA (SQ.M)
1	1	16.650	6.000	1	99.900
TOTAL FAR AREA					99.900

DOOR SCHEDULE		
NAME	WIDTH	HEIGHT
D1	1200	2400
D2	900	2400
FD1	900	1800
FD2	900	1200

PLUMBING LEGEND	
①	110Ø OD uPVC SP STACK
②	110Ø OD uPVC WP STACK
④	DWS D/TAKE
⑤	DWS RISER
⑥	FLUSHING RISER
⑦	110Ø OD uPVC R.W.P
⑧	75Ø uPVC DRAIN PIPE (BALCONY)

LEGEND:-	
SYMBOL	DESCRIPTION
—	SOIL PIPE
—	WASTE PIPE
—	FLOOR TRAP
—	CUTOUT
—	FLOOR DRAIN
—	CWS PIPE
—	FWS PIPE
—	CONTROL VALVE
—	FIRE PIPE

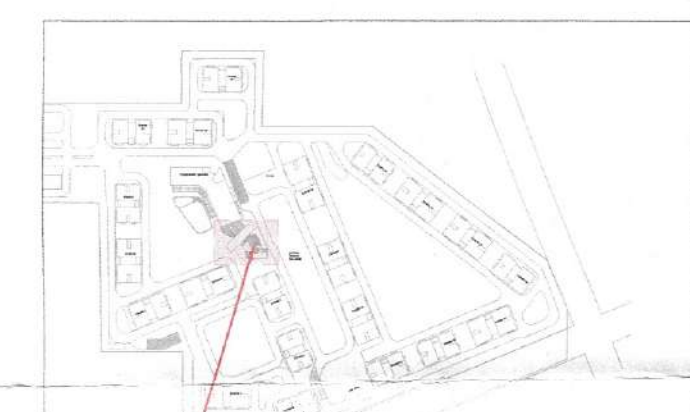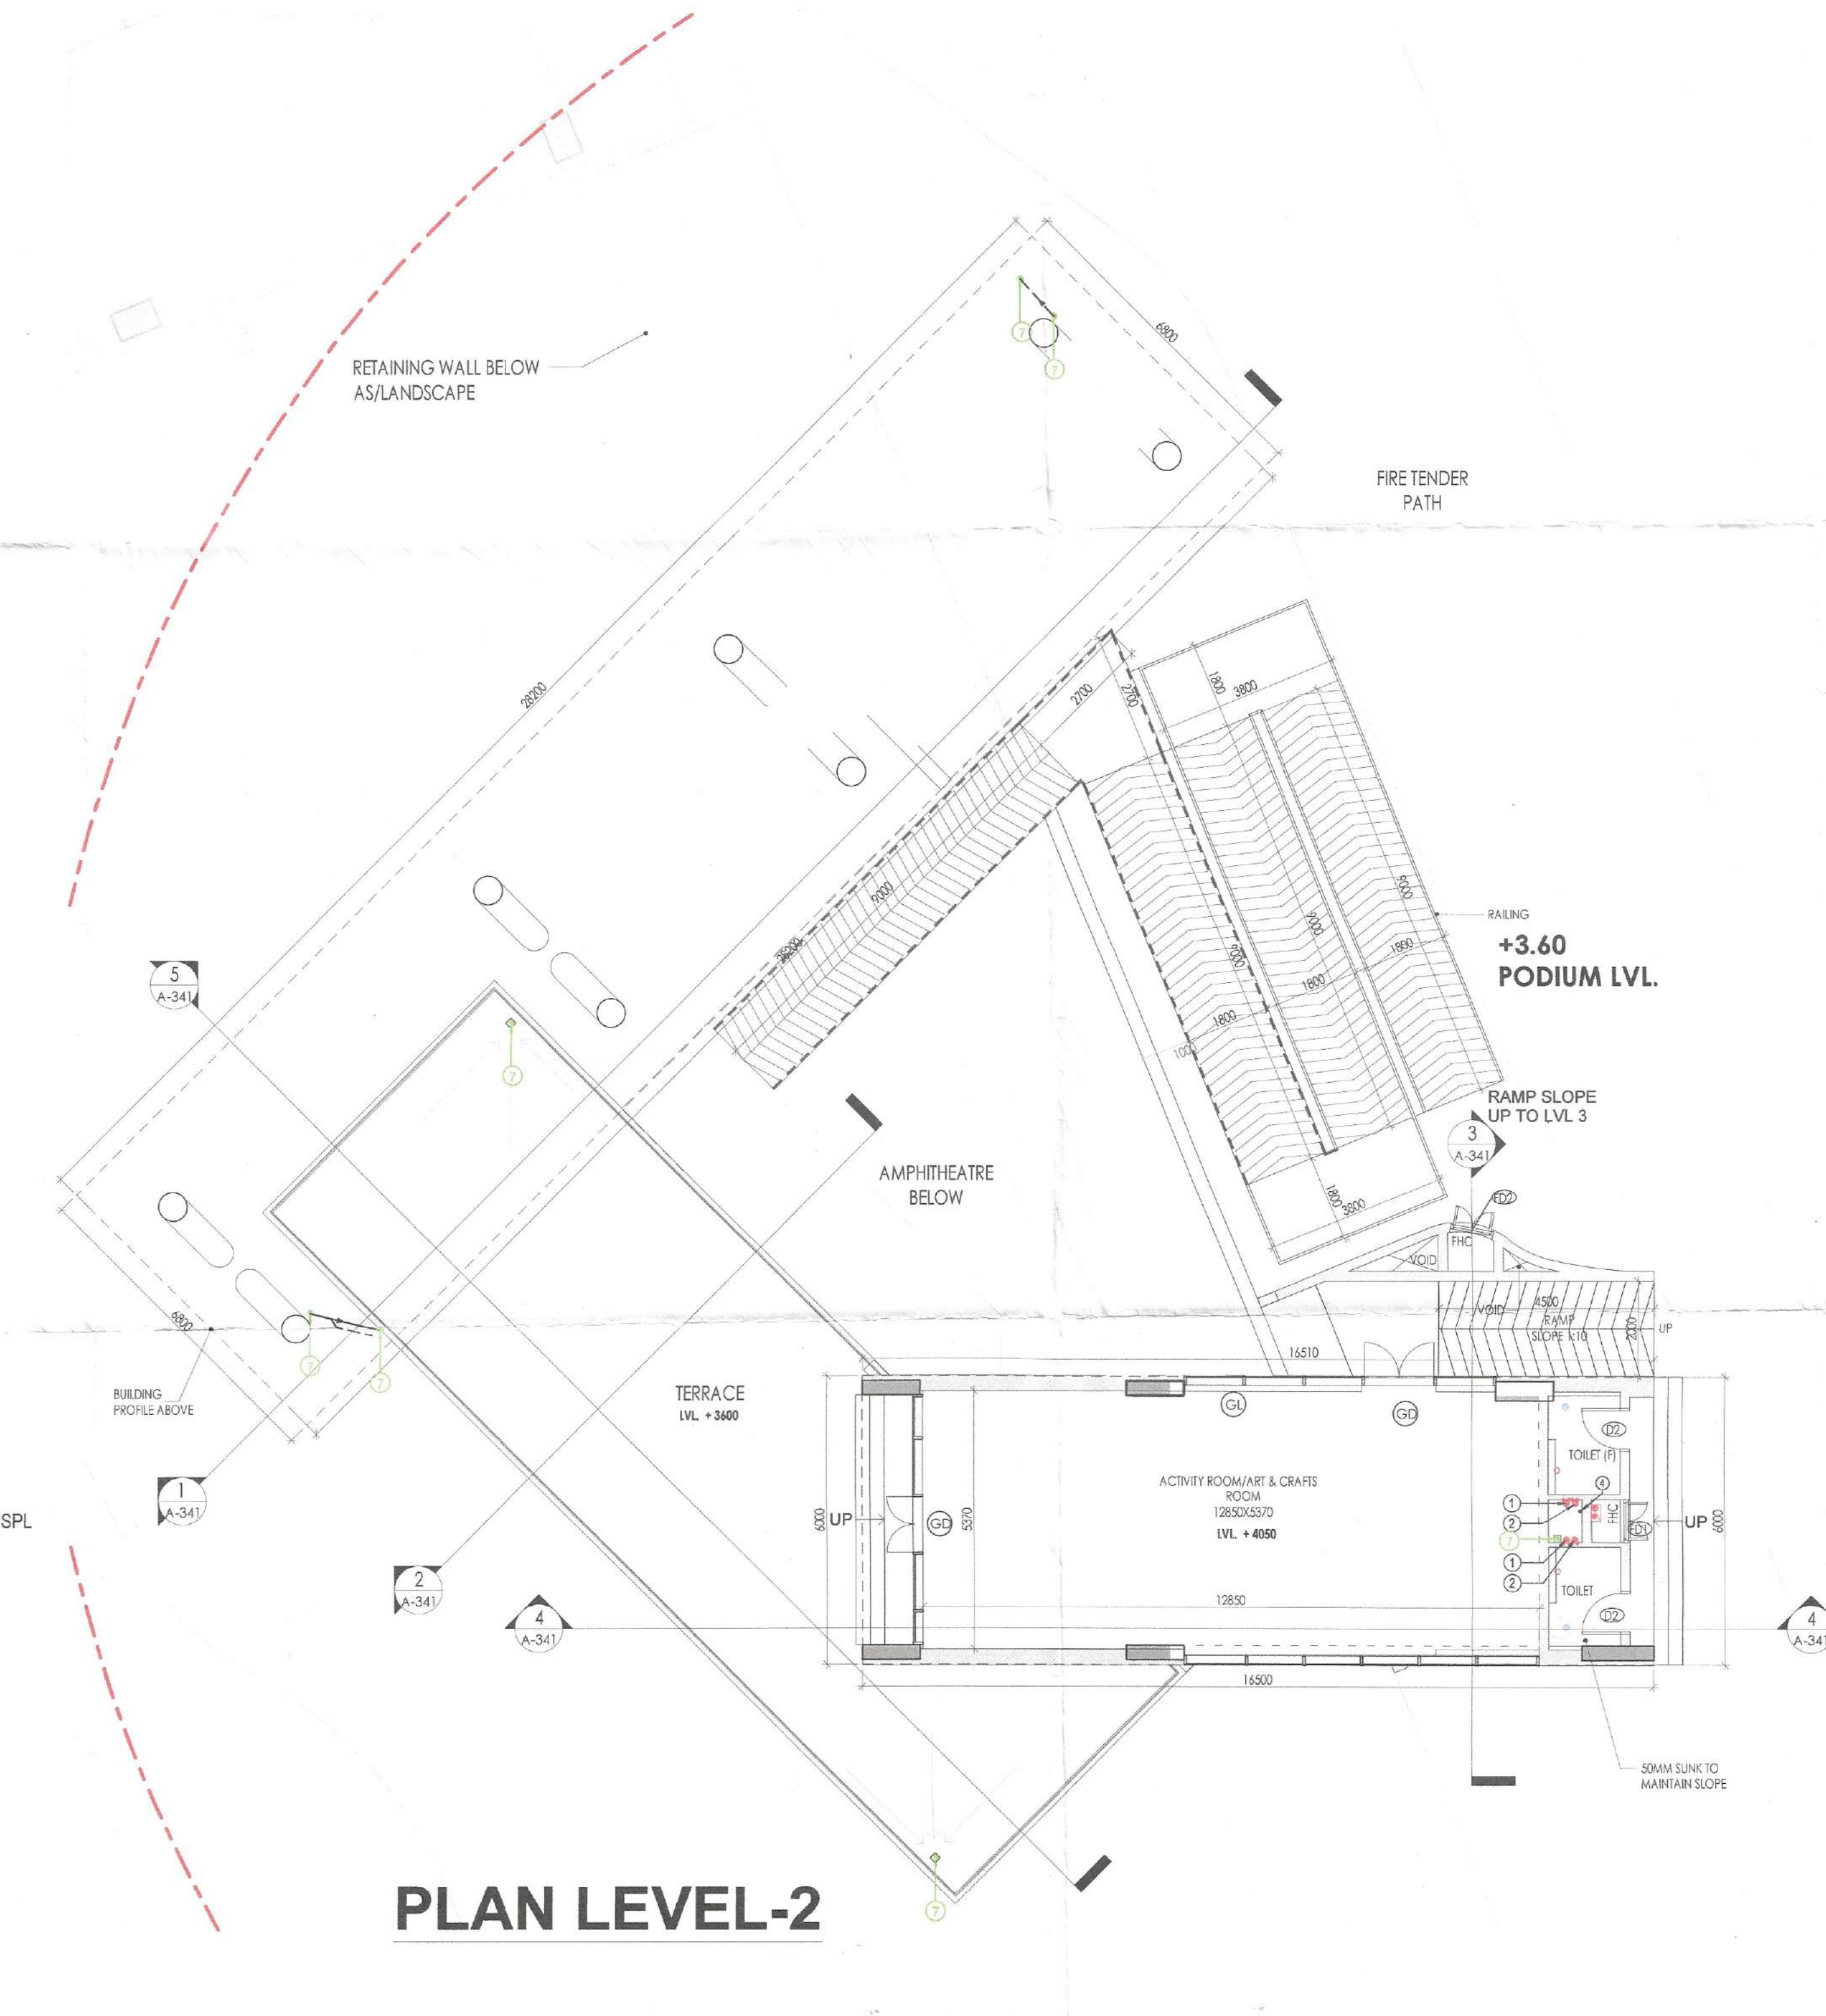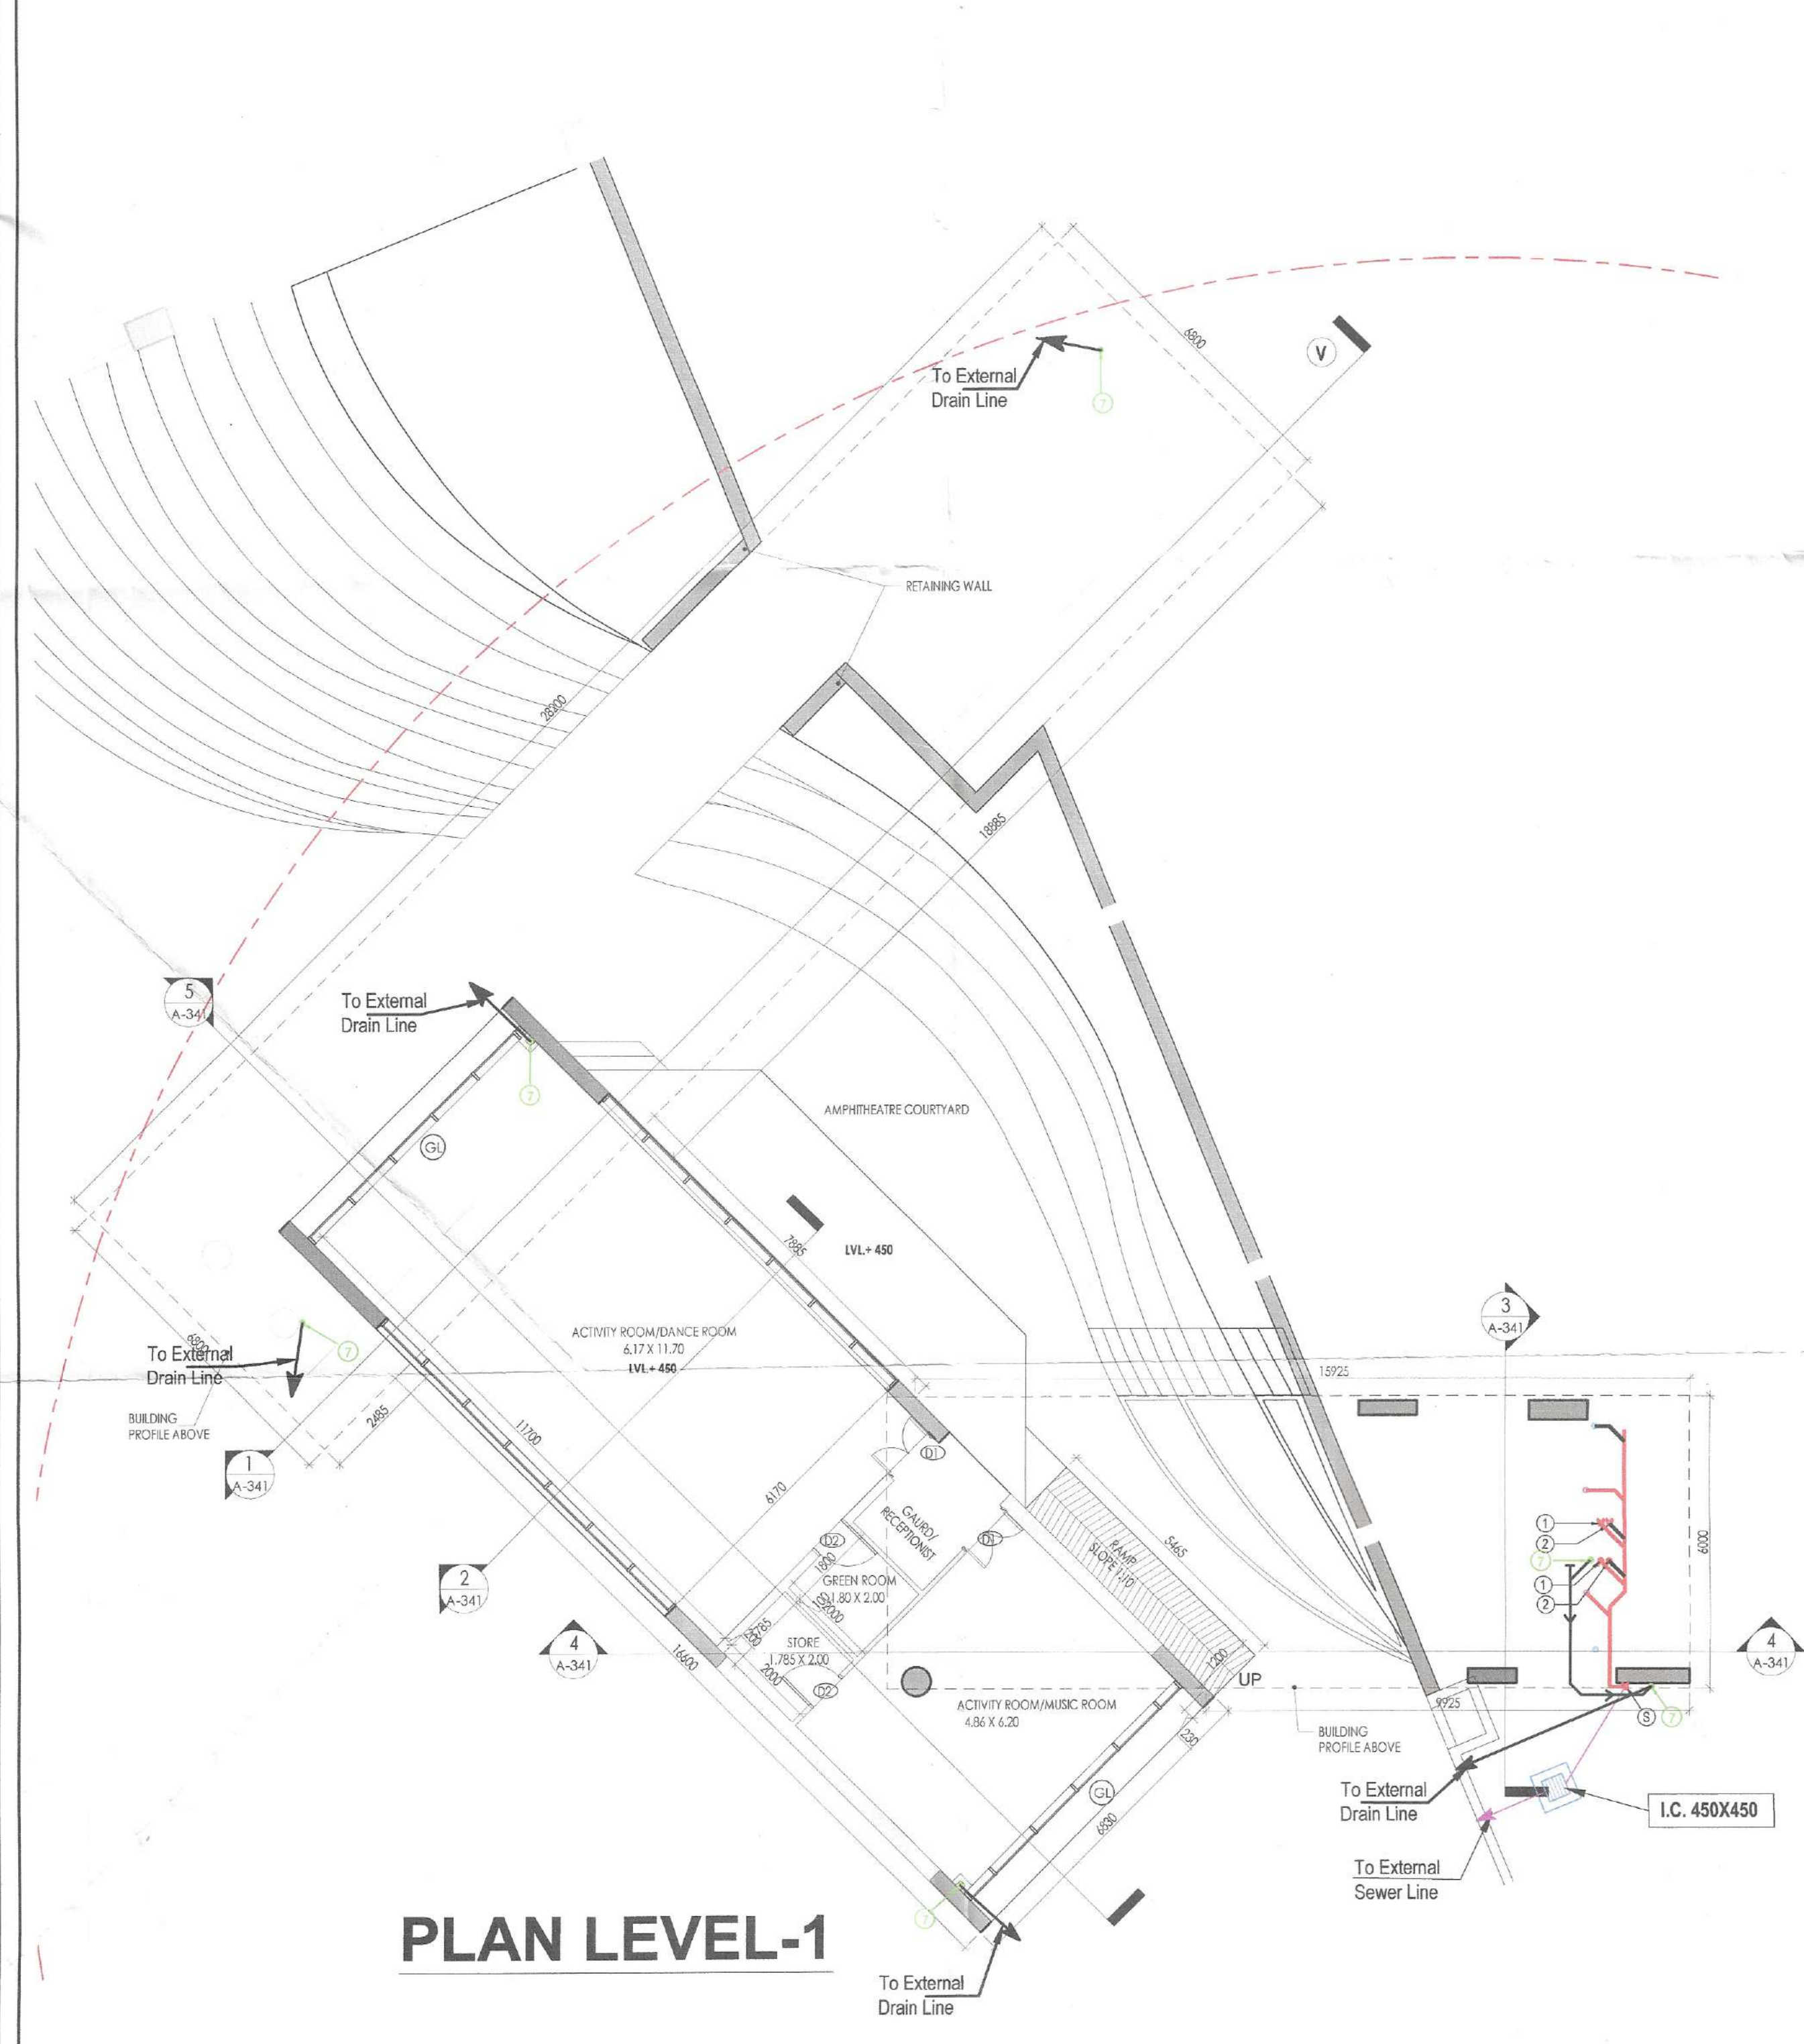

TO BE READ WITH THIS OFFICE MEMO NO.: DATED:

KEY PLAN	
PROJECT	
Revised Building Plans of Group Housing Colony measuring 22.344 Acres (License No. 41 of 2010 Dated 07.06.2010) in sector-93, Gurugram being developed by Ashiana Housing Ltd. comprising of total of Five (5) phases.	
ARCHITECT'S SEAL & SIGNATURE	OWNER/AUTH. SIGN.
<i>[Signature]</i> SYED MOHD. IMRAN CA 93/16665	<i>[Signature]</i> ASHIANA HOUSING LTD. Authorized Signatory
Scale : 1 : 200	Drawing No.: A-61
LEVEL-1 & 2 PLAN & AREA DETAILS (LEARNING HUB)	