




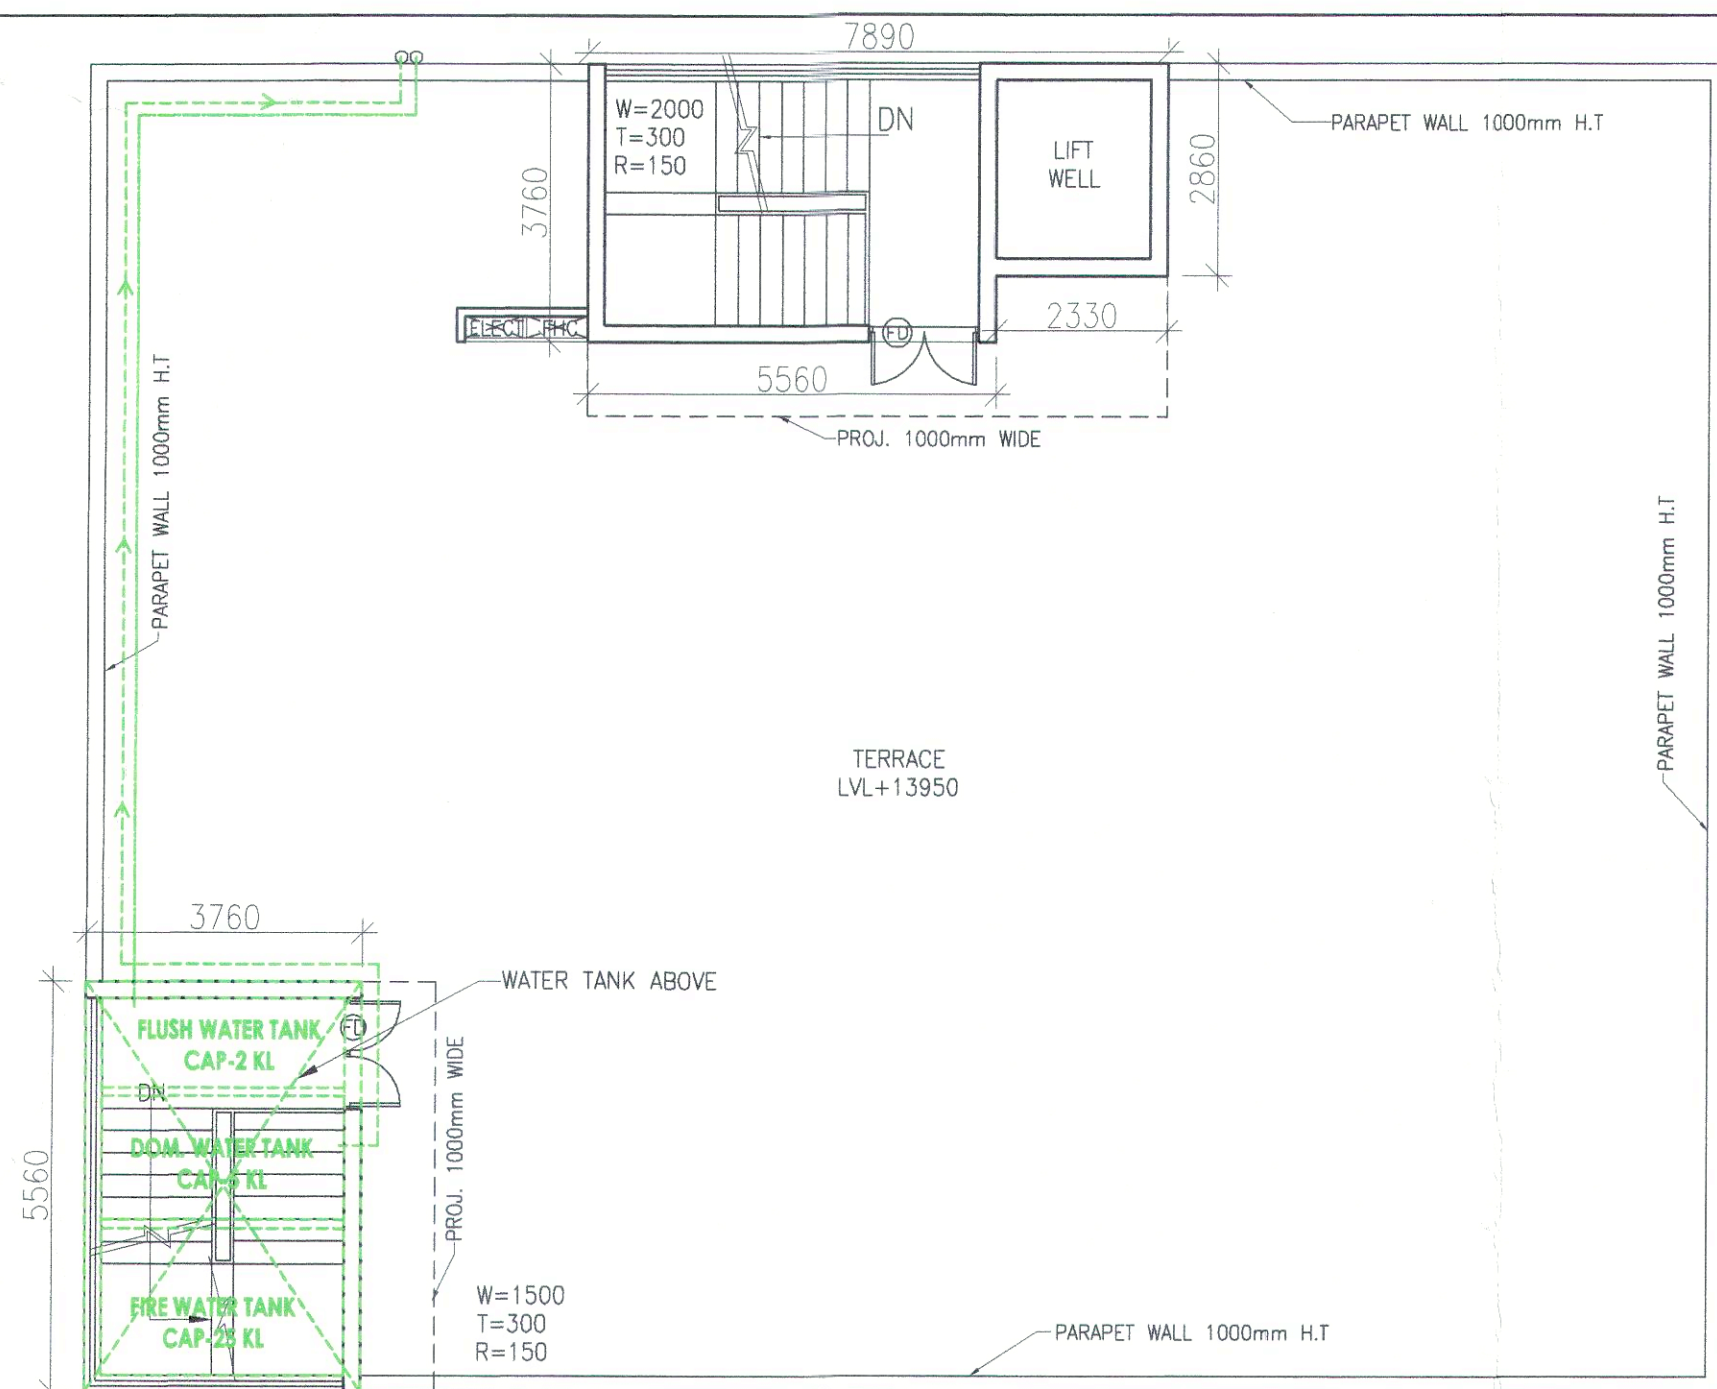

**TERRACE PLAN
COMMUNITY BUILDING -2**

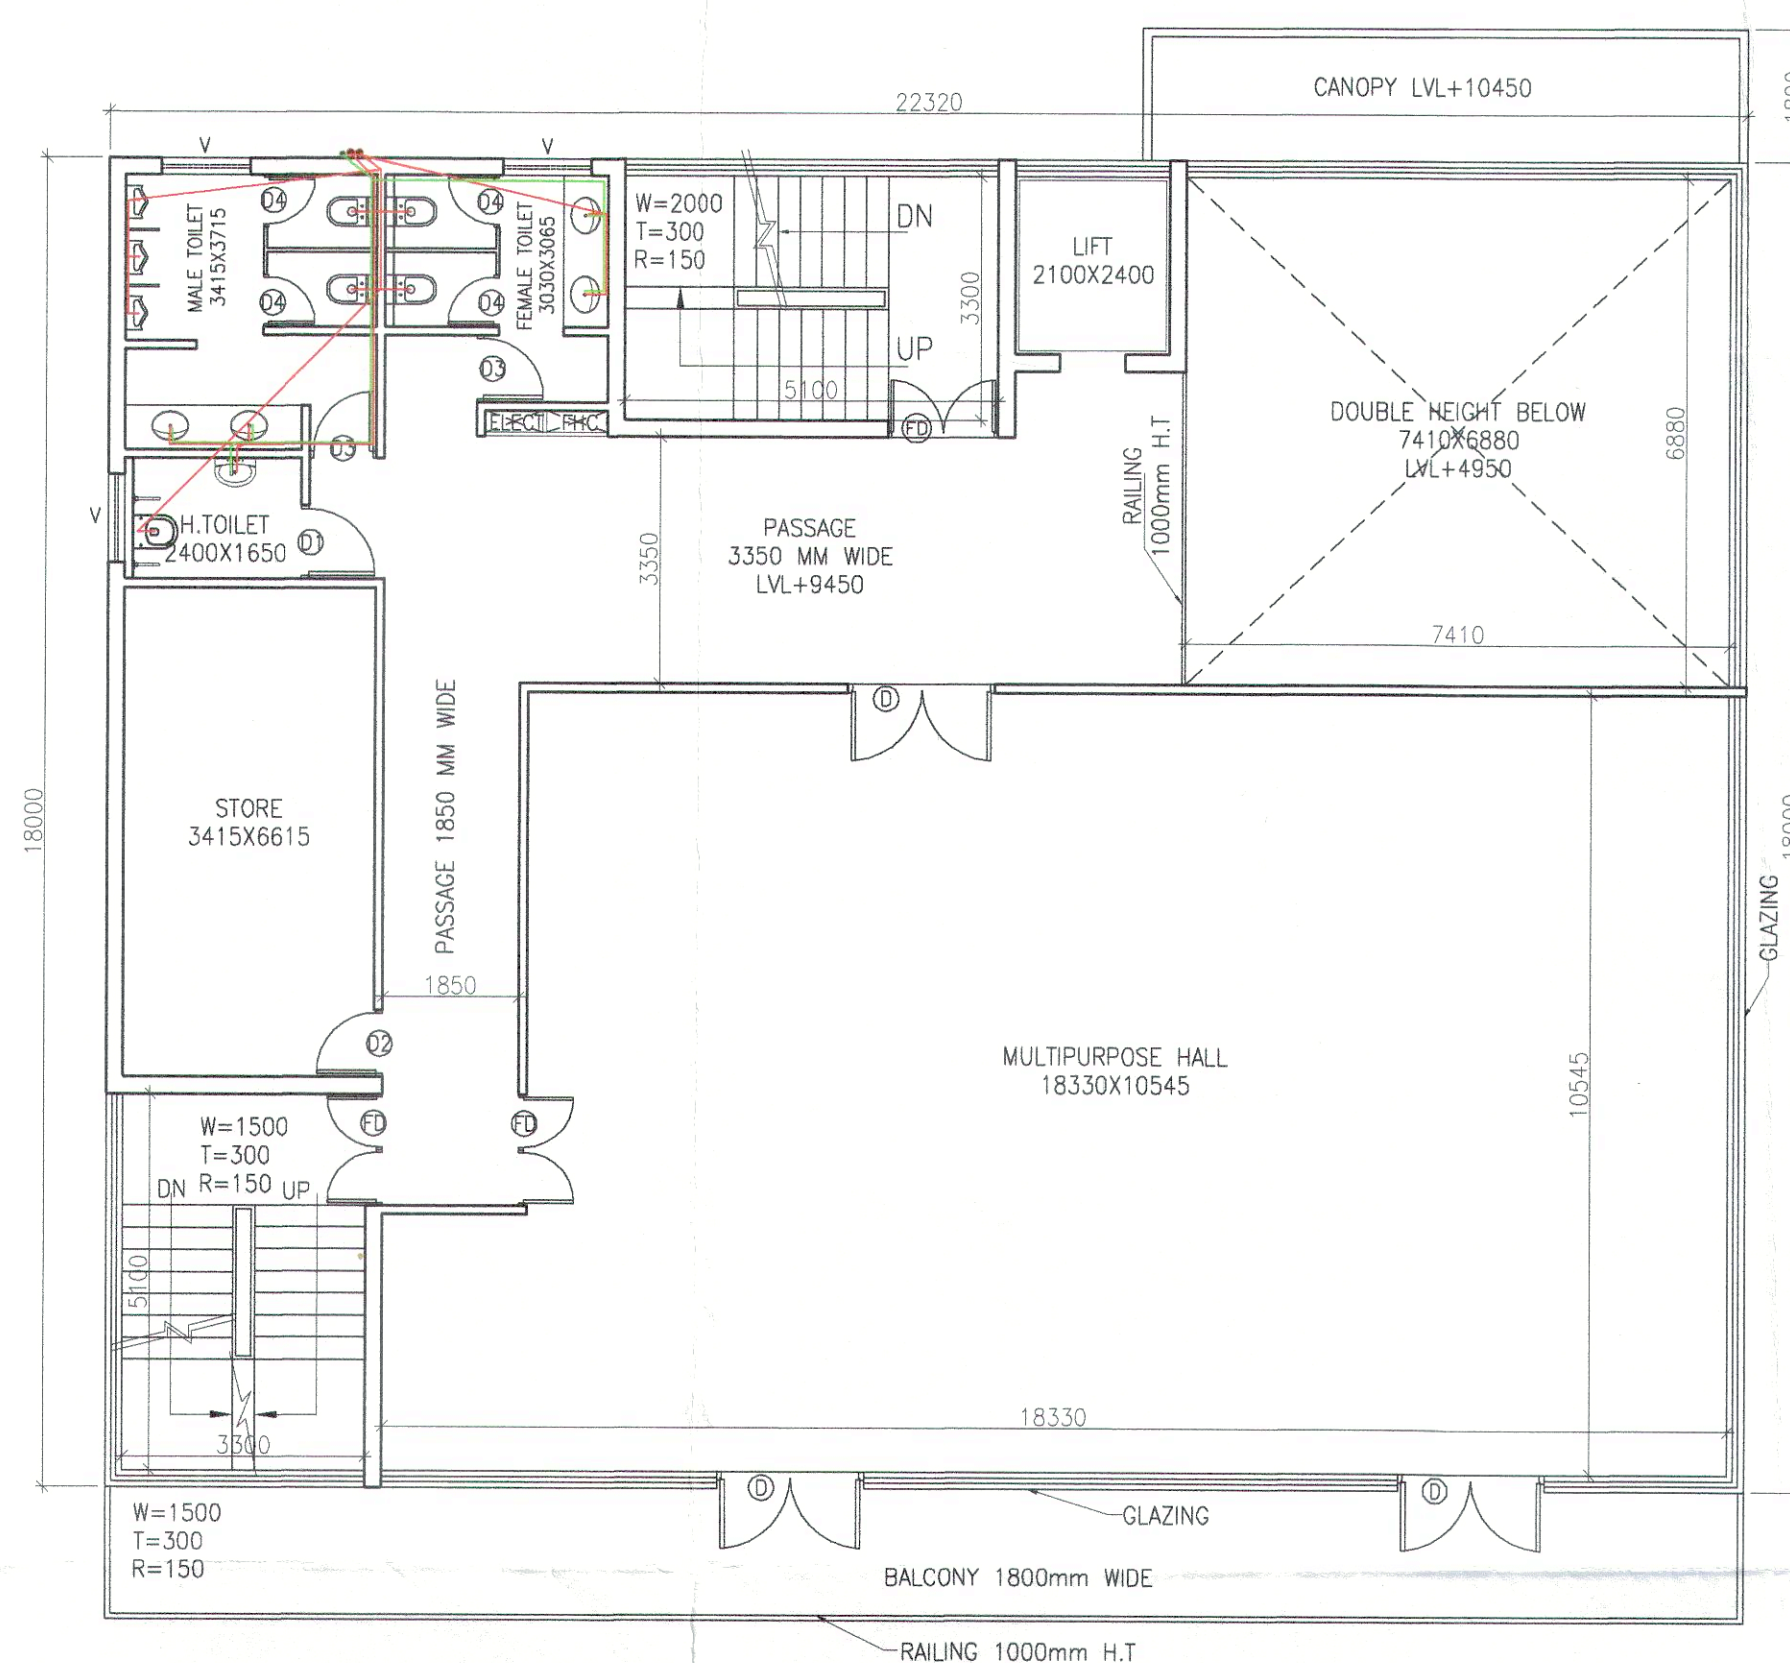


SECOND FLOOR PLAN COMMUNITY BUILDING -2

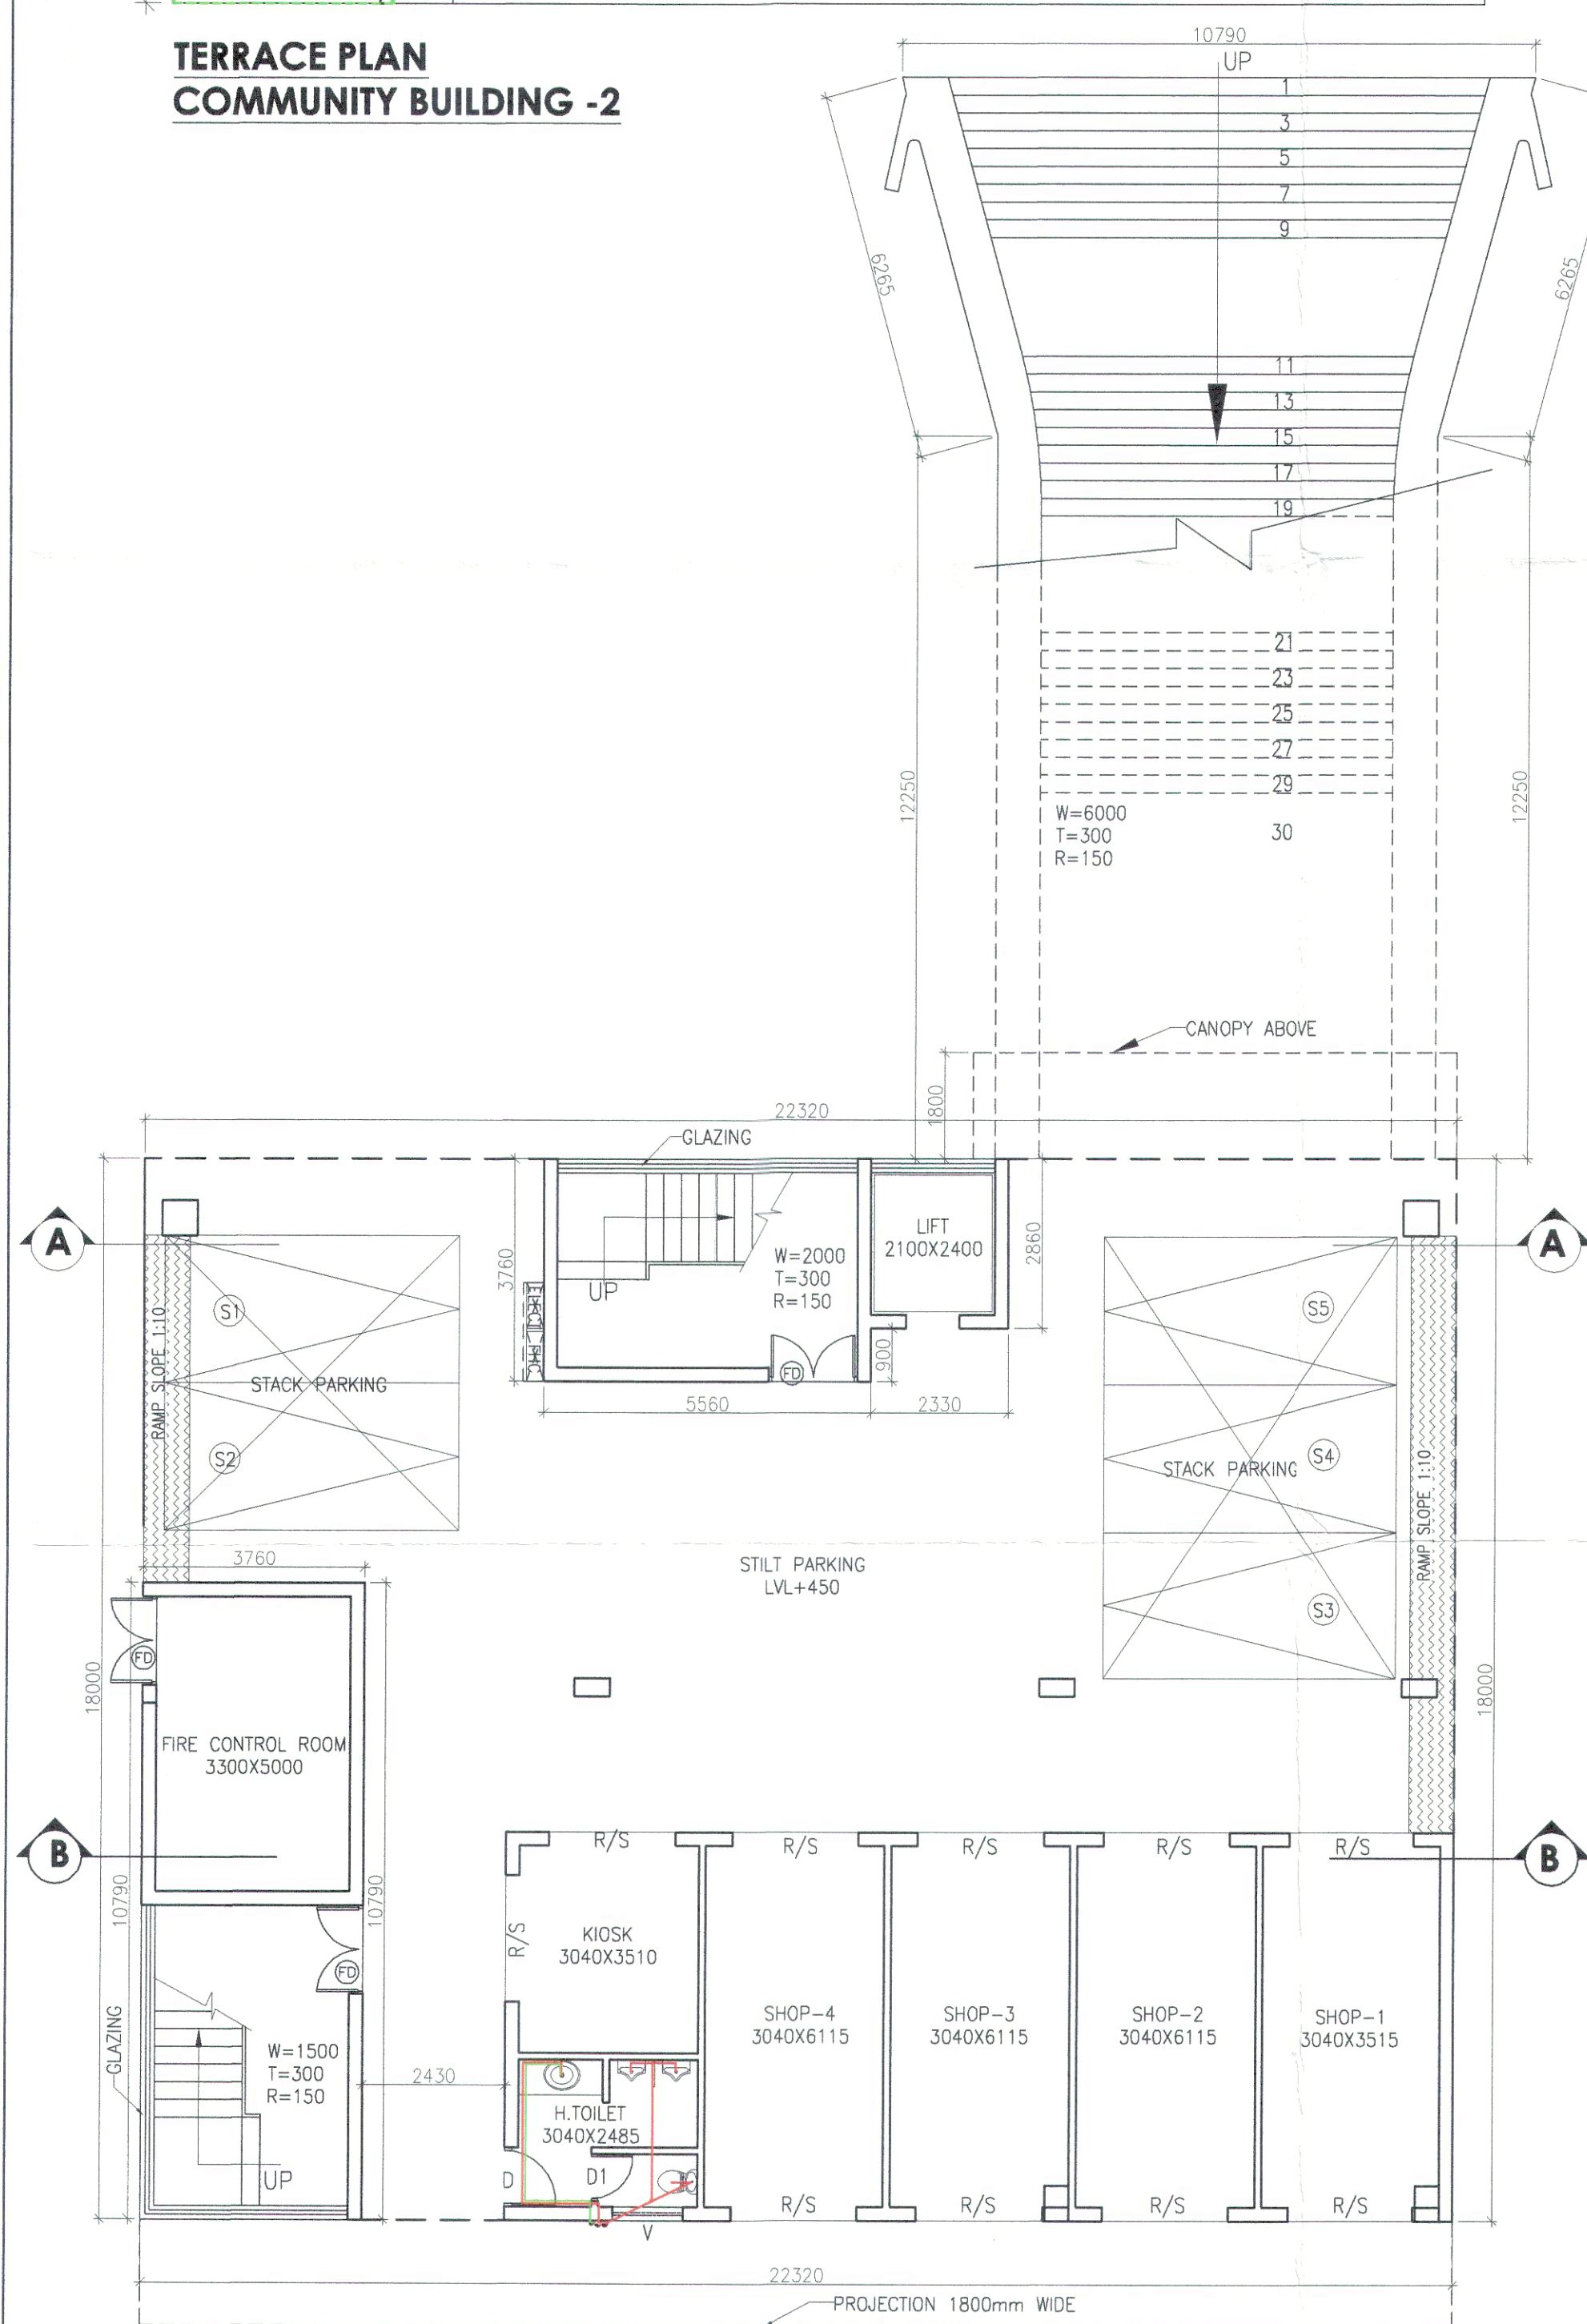


GROUND FLOOR PLAN CONV. SHOPPING-2 & COMMUNITY BUILDING -2

STACK PARKING PROVIDED = 5 X 2 = 10 Nos.

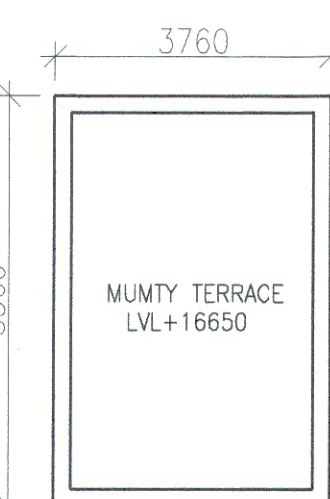


**MUMTY TERRACE PLAN
COMMUNITY BUILDING -2**

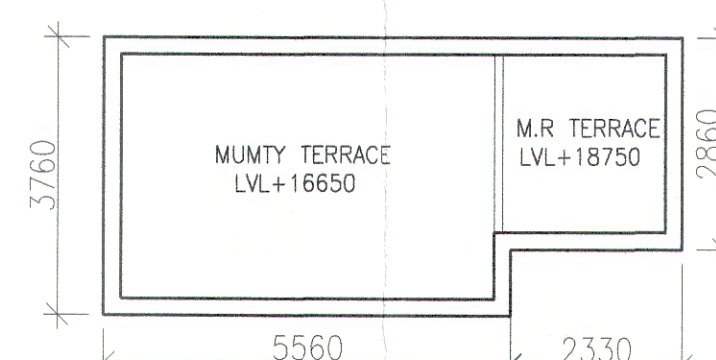

**MUMTY & M.R TERRACE PLAN
COMMUNITY BUILDING -2**

LEGEND:-

- 100 OD uPVC SOIL VENT PIPE
- 100 OD uPVC WASTE PIPE
- 75 OD uPVC VENT PIPE
- CWS (DOMESTIC) DN TAKE(G)
- CWS (FLUSHING) DN TAKE(G)
- CWS (DOMESTIC) RISER(G)
- CWS (FLUSHING) RISER(G)
- 400 OD uPVC RAIN WATER PIPE
- MANHOLE
- OT GULLY TRAP
- WASTE PIPE
- SOIL PIPE
- COLD WATER SUPPLY LINE

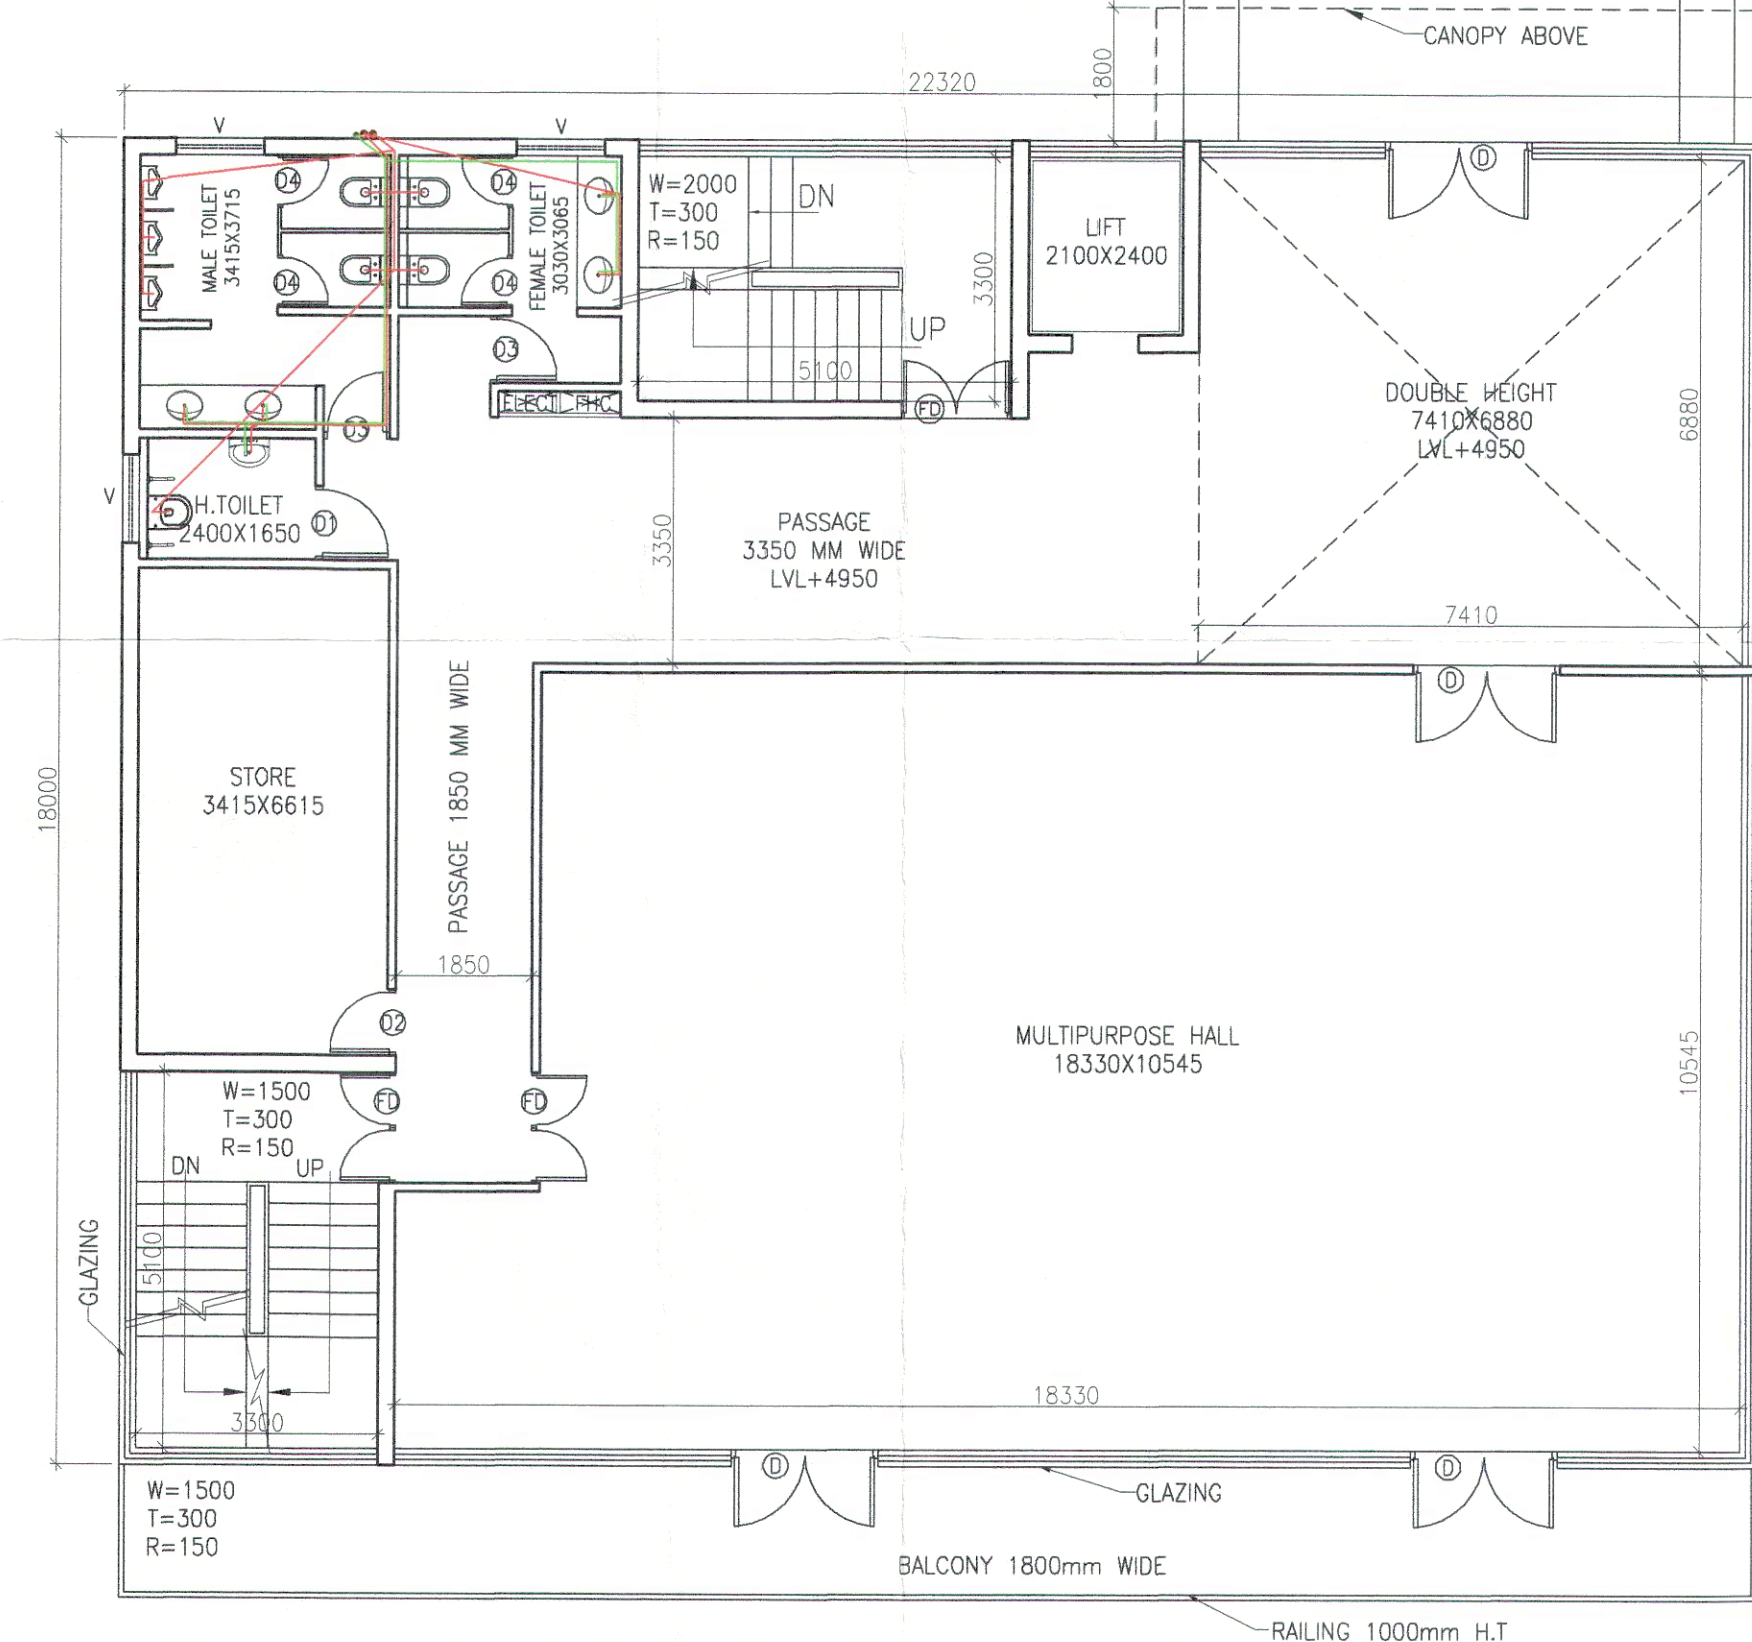

FIRST FLOOR PLAN COMMUNITY BUILDING -2

Checked and found ok for Public Health
(Internal) Service only subject to comments in
in forwarding letter No. 105379/11. 22/06/22

Superintending Engineer (HQ)
for Chief Engineer 1 HSV
Panchajanya
SPEW

This is a "PROVISIONAL BUILDING PLAN"
approved only for the purpose of inviting
Objections from the general public

DTP (HQ)
STP(HQ)
Member Secretary
BPAC
ATP(HQ)
(Dinesh Kumar)
PA(HQ)

TO BE READ WITH THIS OFFICE
MEMO NO.: 2660
DATED: 21-01-2023

TO BE READ WITH THIS OFFICE
MEMO NO.: 2660
DATED: 21-01-2023

TO BE READ WITH THIS OFFICE
MEMO NO.: 2660
DATED: 21-01-2023

SCHEDULE OF DOOR - WINDOW

RMK.	WIDTH	HEIGHT	CILL LVL.	LIN. LVL.
R/S	2100	2750	--	2750
D	1500	2400	--	2400
D1	1200	2400	--	2400
D2	1050	2400	--	2400
D3	1000	2400	--	2400
D4	750	2100	--	2100
V	1200	1200	1200	2400

PROJECT
REVISED BUILDING PLAN FOR BLOCK
-1,2,3,4,6,7,8,9,10, & 11 OF GROUP
HOUSING COLONY MEASURING
13.156 ACRES (LICENSE NO. 12 OF
2009 DATED 25.05.2009) IN
SECTOR-37D, GURGAON MANESAR
URBAN COMPLEX BEING DEVELOPED
BY RAMPRASTHA REALTORS PVT.LTD.
IN COLLABORATION
WITH S.A. INFRA TECH PVT.LTD.

PRINCIPAL ARCHITECTS
A.D. CONSULTANTS.
Parnami Tower, 3rd Floor, S.C.O. 50-51,
Old Judicial Complex, Civil Lines,
Gurgaon - 122001
Tel.: 0124-4081801, 4081802
email : adconsultants13@gmail.com

CONSULTING ARCHITECTS :-
SACHDEVA CONSULTANTS.

ARCHITECT'S SEAL
& SIGNATURE
For Navraj Infratech Private Limited
Authorised Signatory

Scale : 1:100
Drawing Title: ALL FLOOR PLAN
COMMUNITY BUILDING -2 &
CONV. SHOPPING-2
Drawing No.: 14