

Checked and found ok for Public Health
(Internal) Service only subject to comments in
in forwarding letter No. 10.5.377, Dtd. 27/06/22

Superintending Engineer (HQ)
for Chief Engineer, 1 HSVP
Panchajanya
SDEW


This is a "PROVISIONAL BUILDING PLAN"
approved only for the purpose of Inviting
Objections from the general public

DTP (HQ) STPHQ Member Secretary SPAC
ATP (HQ) STPHQ Member SPAC
(Dinesh Kumar) PA(HQ)

TO BE REAR...
MEMO NO. 2660
DATED: 31-01-2023


MEMO NO. 2660
DATED: 31-01-2023

Member
GPO

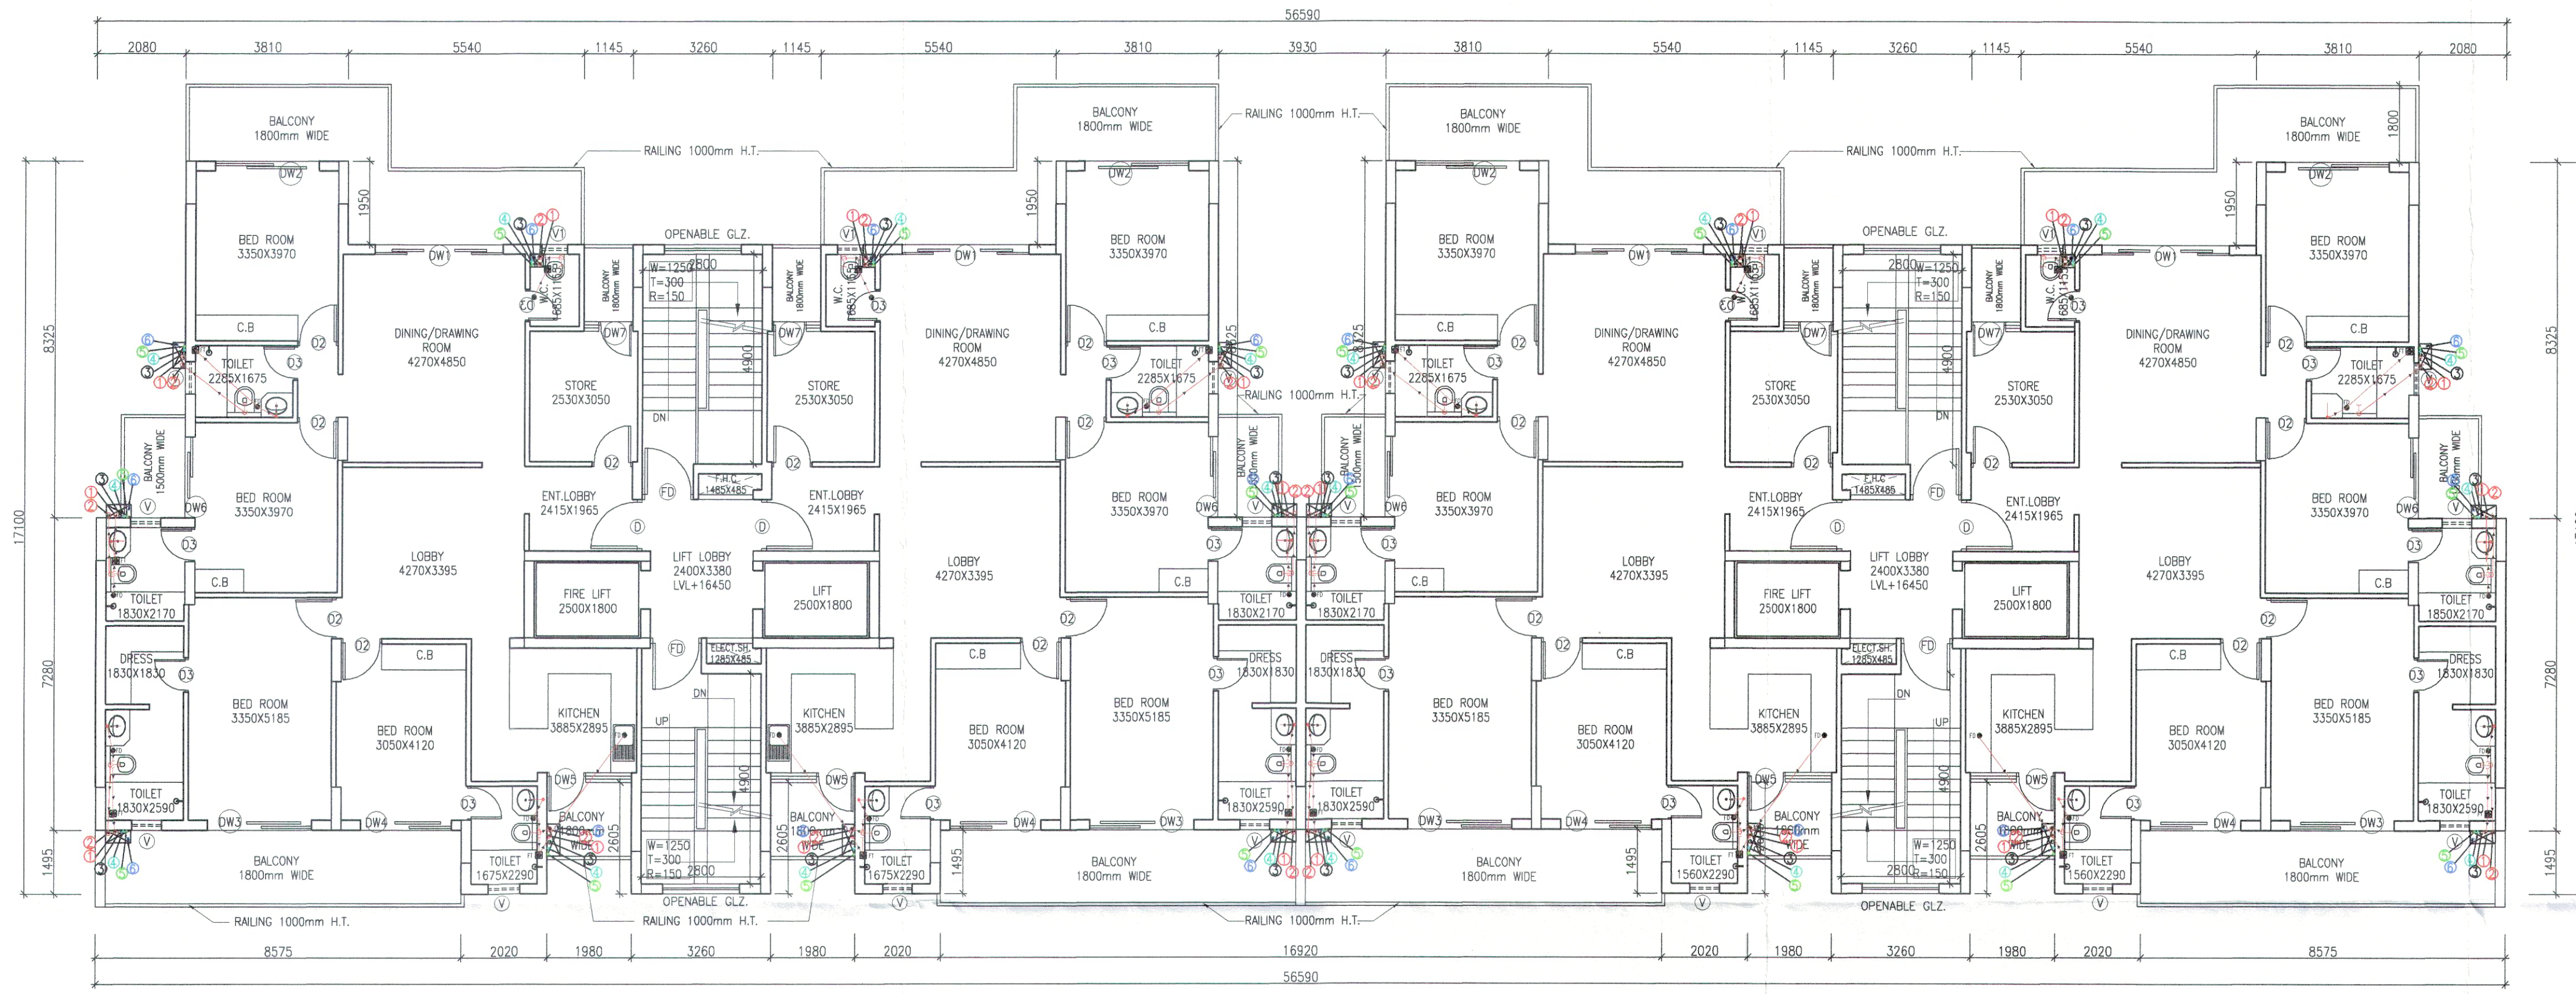

5TH FLOOR PLAN (BLOCK - 9, 10 & 11)

DOOR WINDOW SCHEDULE					
S.NO.	DESCRIPTION	SIZE	SILL LVL.	LINTEL LVL.	
1	DW1	3000 X 2750	±00	+2750	
2	DW2	1800 X 2750	±00	+2750	
3	DW3	2400 X 2750	±00	+2750	
4	DW4	985 X 2750	±00	+2750	
5	D1	1000 X 2100	±00	+2100	
6	D2	950 X 2100	±00	+2100	
7	D3	800 X 2100	±00	+2100	
8	W	1500 X 1700	+1050	+2750	
9	W1	2100 X 1700	+1050	+2750	
10	V	750 X 1250	+1500	+2750	
11	V1	450 X 1250	+1500	+2750	
12	GLZ.	1800 X 3000	AS PER DGN.		

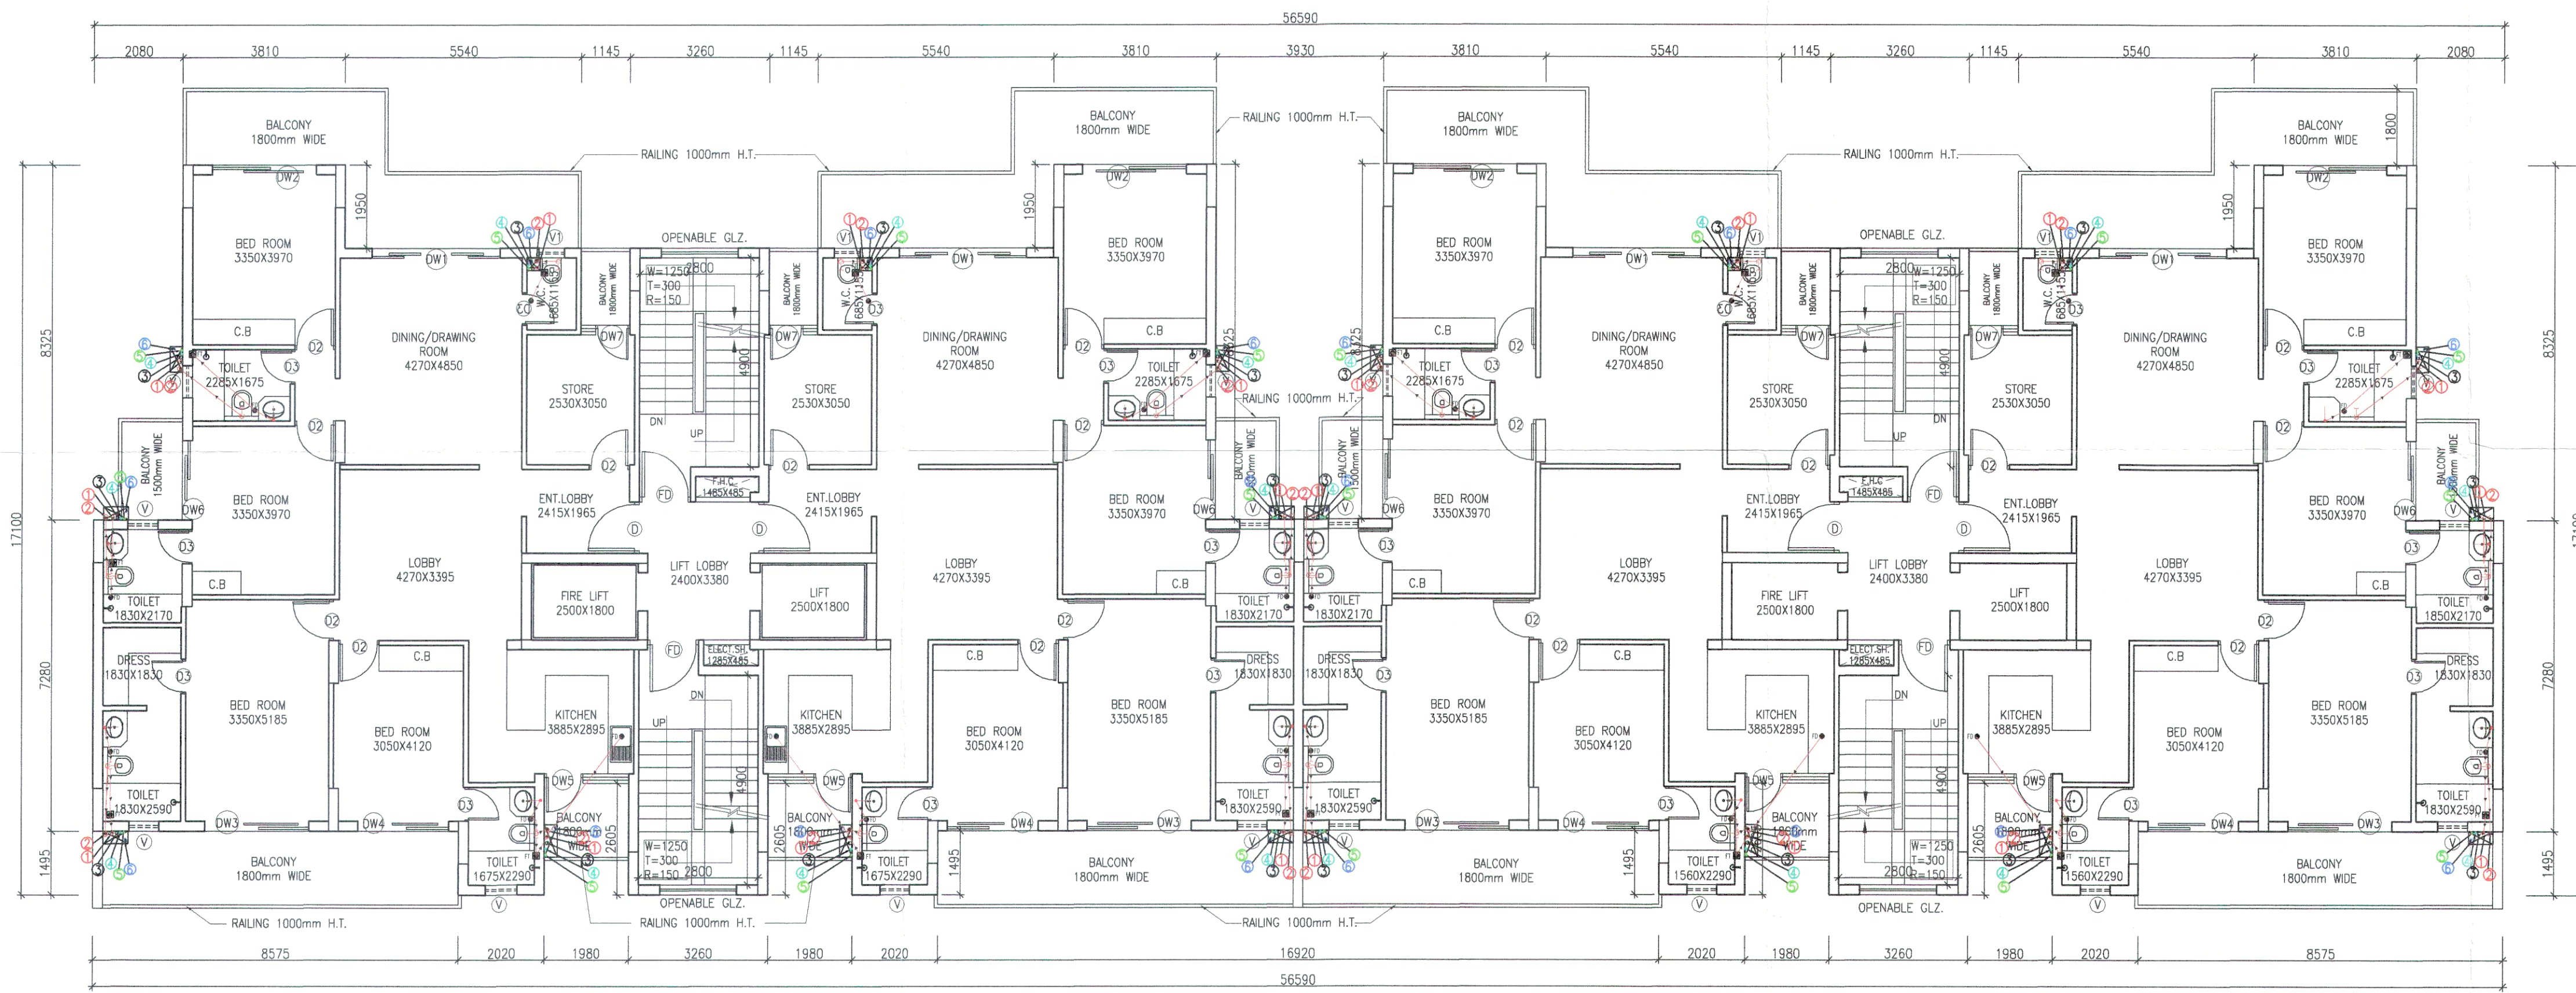

TYP. FLOOR PLAN (2ND TO 4TH) (BLOCK - 9, 10 & 11)

LEGEND:-	
①	100 OD uPVC WASTE PIPE
②	100 OD uPVC SOIL VENT PIPE
③	75 OD uPVC VENT PIPE
④	CWS (DOMESTIC) DN TAKE(GI)
⑤	CWS (FLUSHING) DN TAKE(GI)
⑥	CWS (DOMESTIC) RISER(GI)
⑦	CWS (FLUSHING) RISER(GI)
⑧	400 OD uPVC RAIN WATER PIPE
⑨	MANHOLE
⑩	GULLY TRAP
⑪	WASTE PIPE
⑫	SOIL PIPE
⑬	COLD WATER SUPPLY LINE

DOOR WINDOW SCHEDULE					
S.NO.	DESCRIPTION	SIZE	SILL LVL.	LINTEL LVL.	
1	DW1	3000 X 2750	±00	+2750	
2	DW2	1800 X 2750	±00	+2750	
3	DW3	2400 X 2750	±00	+2750	
4	DW4	985 X 2750	±00	+2750	
5	D1	1000 X 2100	±00	+2100	
6	D2	950 X 2100	±00	+2100	
7	D3	800 X 2100	±00	+2100	
8	W	1500 X 1700	+1050	+2750	
9	W1	2100 X 1700	+1050	+2750	
10	V	750 X 1250	+1500	+2750	
11	V1	450 X 1250	+1500	+2750	

PROJECT
REVISED BUILDING PLAN FOR BLOCK
-1,2,3,4,6,7,8,9,10, & 11 OF GROUP
HOUSING COLONY MEASURING
13.156 ACRES (LICENCE NO. 12 OF
2009 DATED 25.05.2009) IN
SECTOR-37D,GURGAON MANESAR
URBAN COMPLEX BEING DEVELOPED
BY RAMPRASTHA REALTORS PVT.LTD.
IN COLLABORATION WITH S.A.
INFRATECH PVT.LTD.

ARCHITECTS
A.D. CONSULTANTS.
Parnami Tower, 3rd Floor, S.C.O. 50-51,
Old Judicial Complex, Civil Lines,
Gurgaon - 122001
Tel.: 0124-4081801, 4081802
email : adconsultants13@gmail.com

CONSULTING ARCHITECTS :-
SACHDEVA CONSULTANTS.

ARCHITECT'S SEAL
& SIGNATURE
OWNER/AUTH.
SIGNATURE
For Navraj Infratech Private Limited
Authorised Signatory

Scale : 1:100
Drawing Title:- TYP. 2ND TO 5TH FLOOR
(BLOCK- 9, 10 & 11)
Drawing No:- 10