
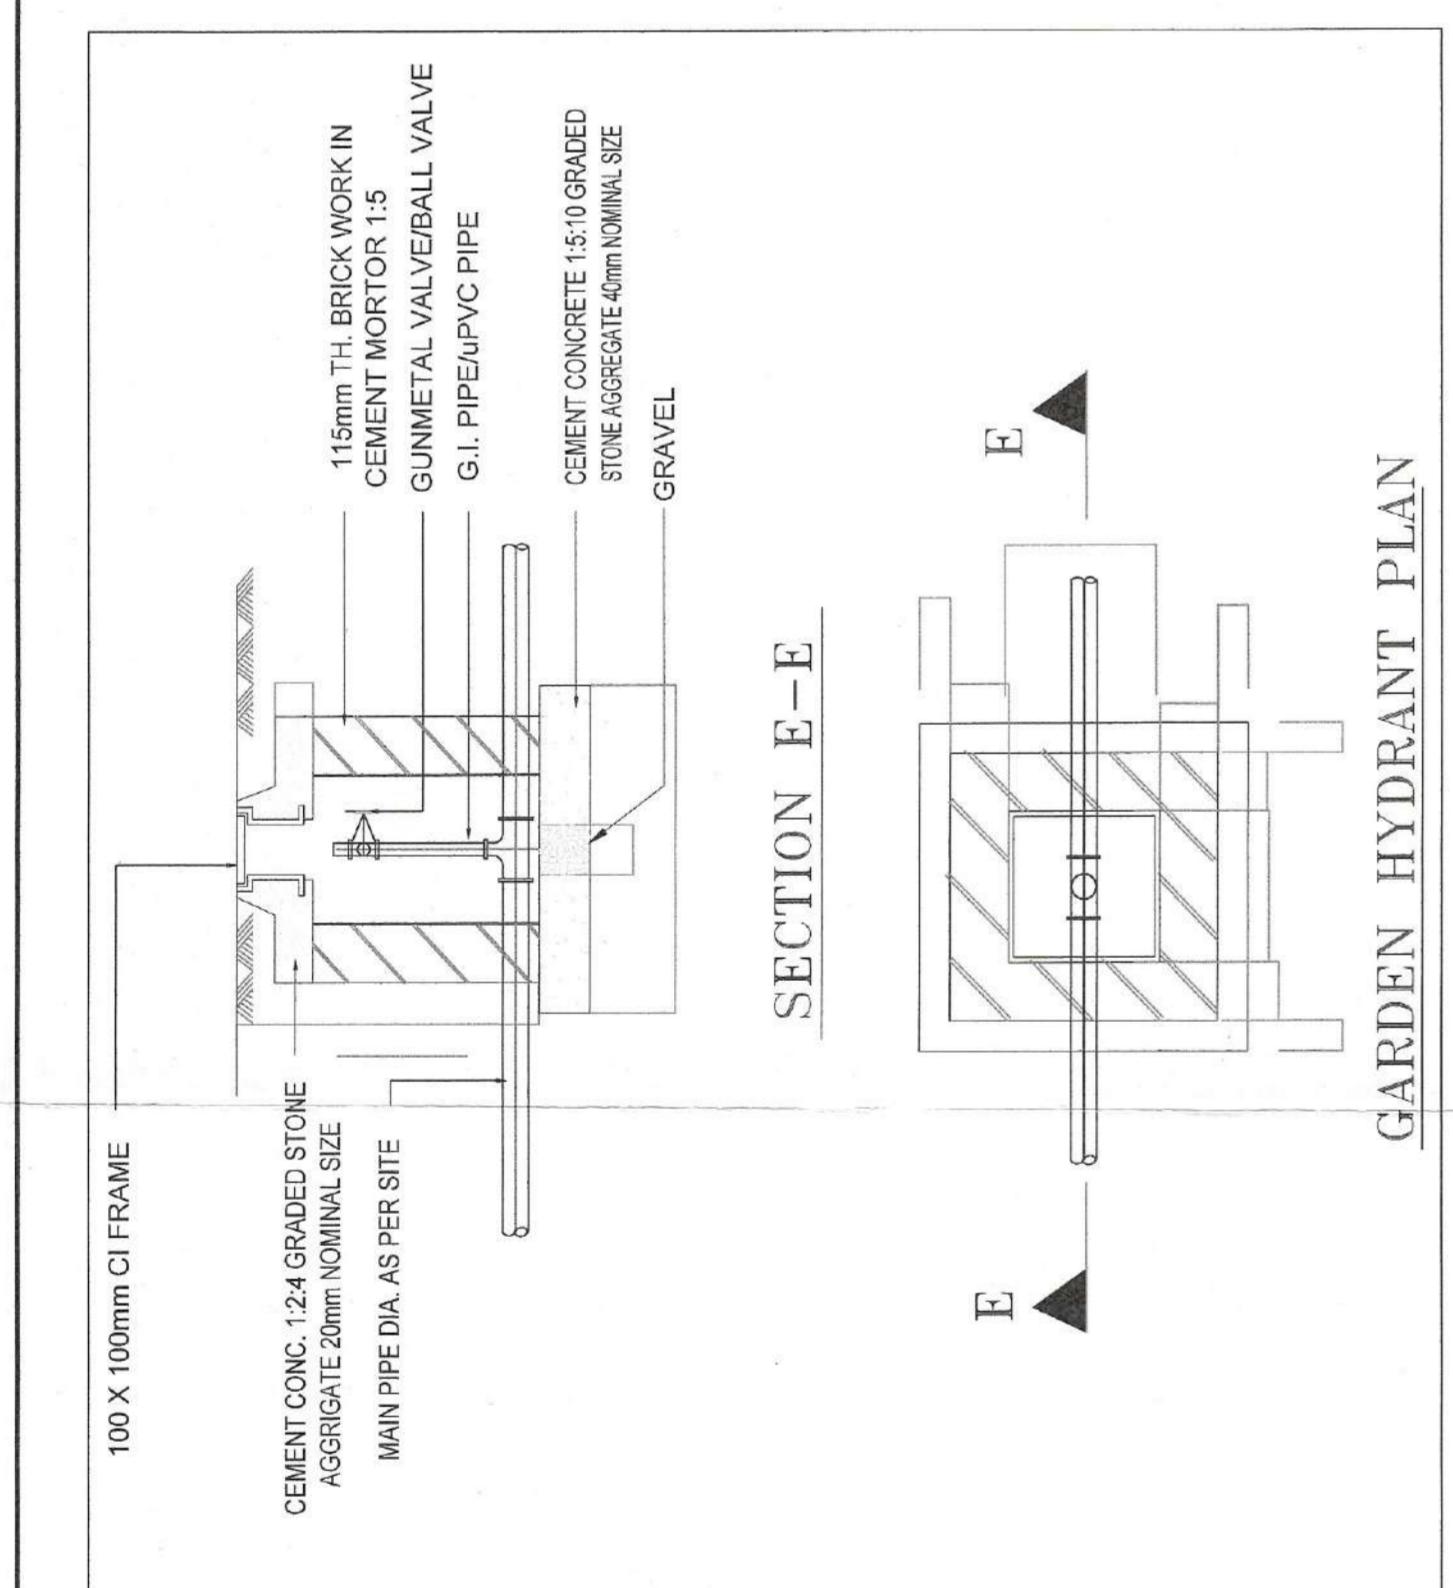
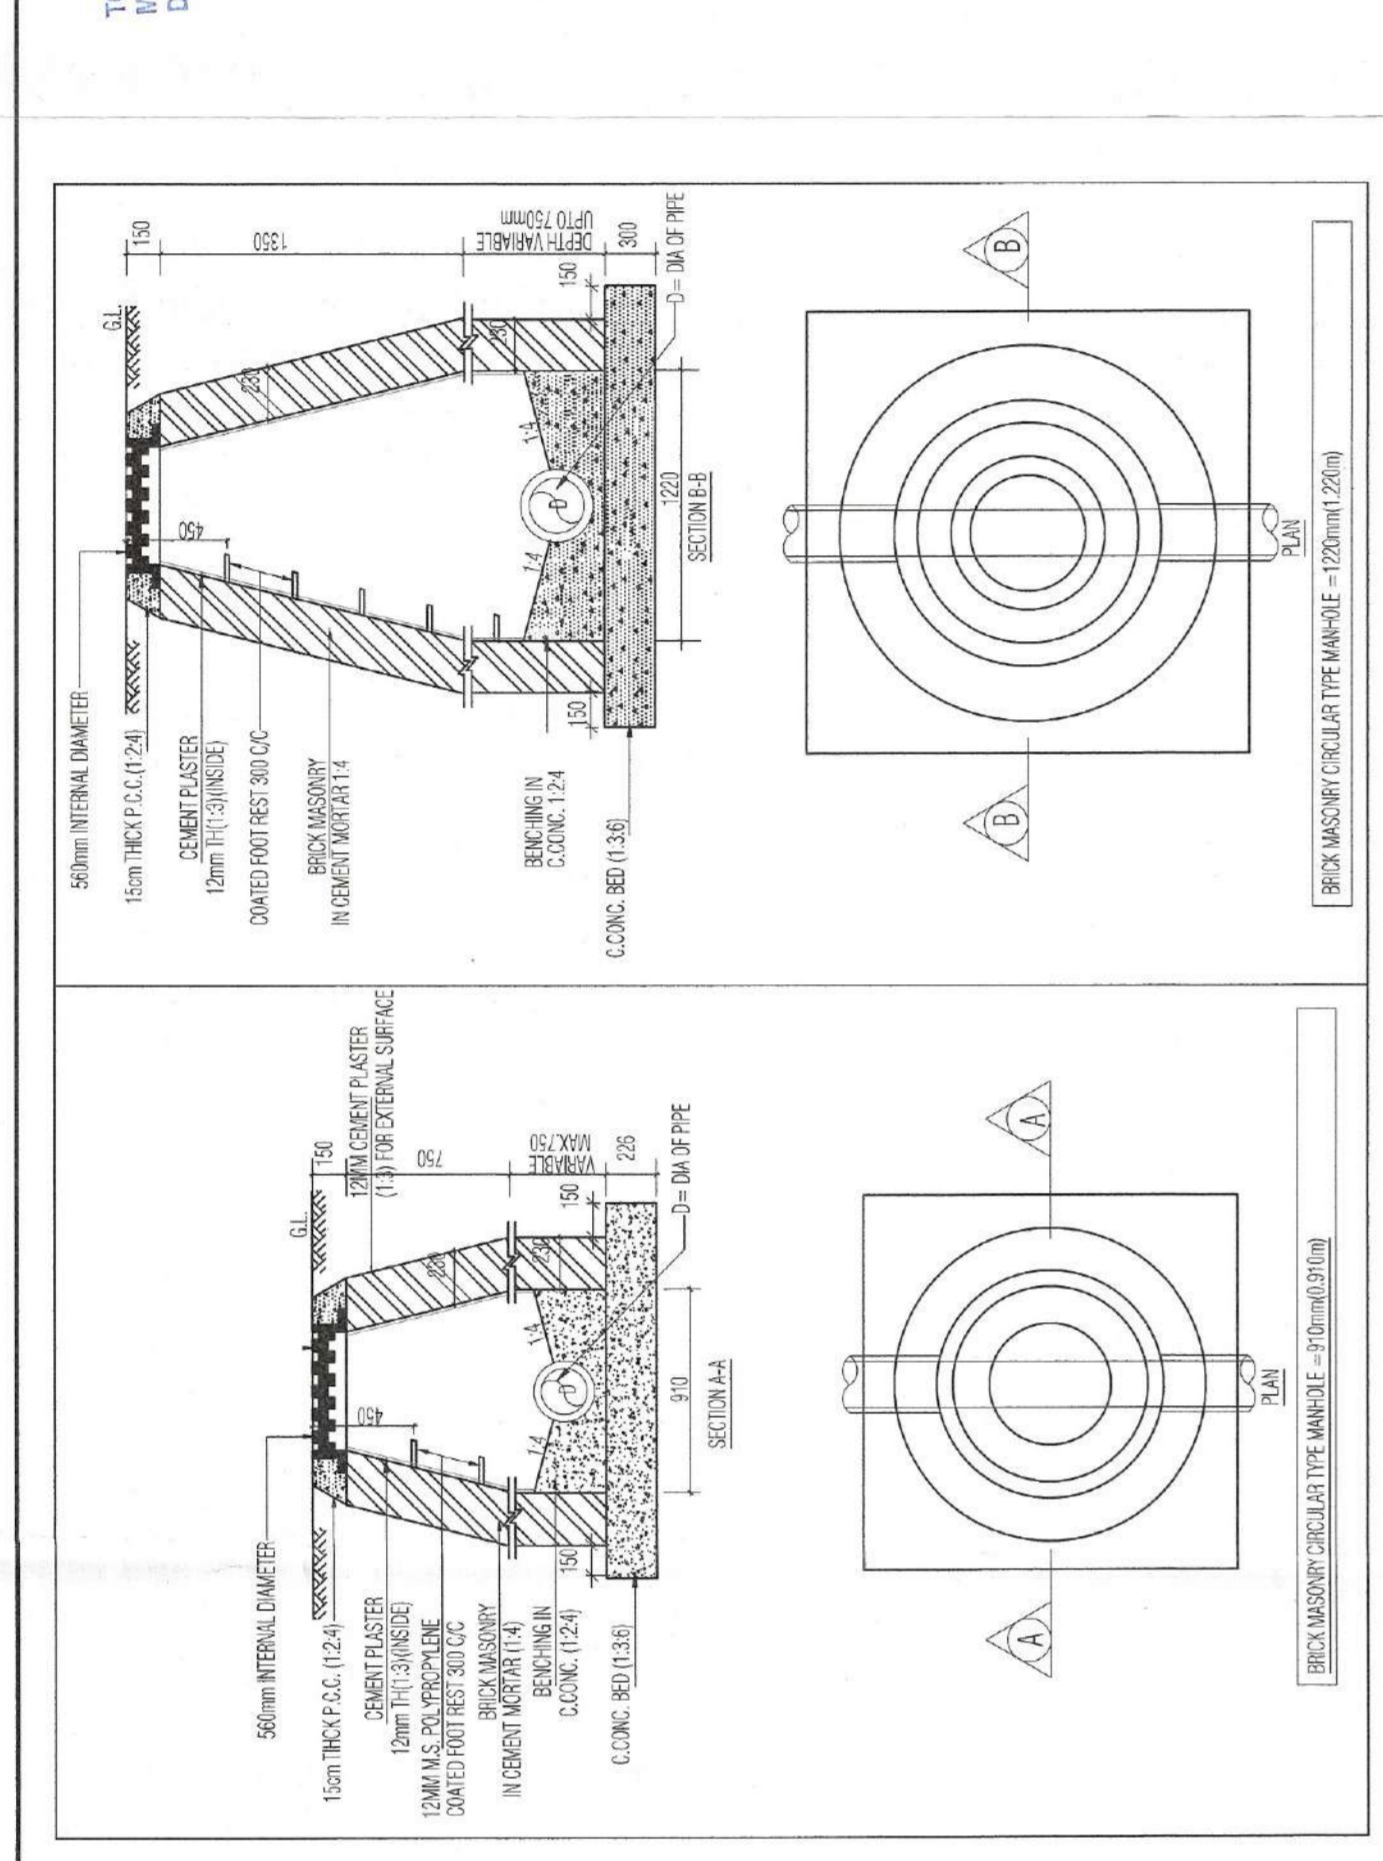


OWNER'S SEAL & SIGNATURE
 For Elm Impact Private Limited
 Authorized Signatory
ARCHITECT'S SEAL & SIGNATURE
 RAJINDER KUMAR
 CA/2490775

NOV. 2023. Scale: 1:400
Drawing Title - SITE PLAN SERVICES
Drawing No - A-02

PROJECT:
 *PROPOSED BUILDING PLANS OF COMMERCIAL PLANT MEASURING 3.6652 ACRES (LICENCE NO. OF 2013 DATED 16/07/2013) AND 3.9937 ACRES (LICENCE NO. OF 2013 DATED 16/07/2013) TOTAL AREA MEASURING 7.6589 ACRES IN SECTOR - 82, SURROUNDING MANASAR URBAN COMPLEX BEING FORMERLY KNOWN AS AMBIBENCE (FORMERLY KNOWN AS AMBIBENCE INFRASTRUCTURE DEVELOPERS PVT. LTD.)
ARCHITECTS

Note :-
 1. BUILDING HAS AUTOMATIC SPRINKLER SYSTEM WHEREVER REQUIRED BY NBC.
 2. BUILDING WILL BE DESIGNED (STRUCTURES) AS PER RELEVANT IS CODES FOR EARTH QUAKE RESISTANCE.
 3. ALL DIMENSIONS ARE IN METERS.

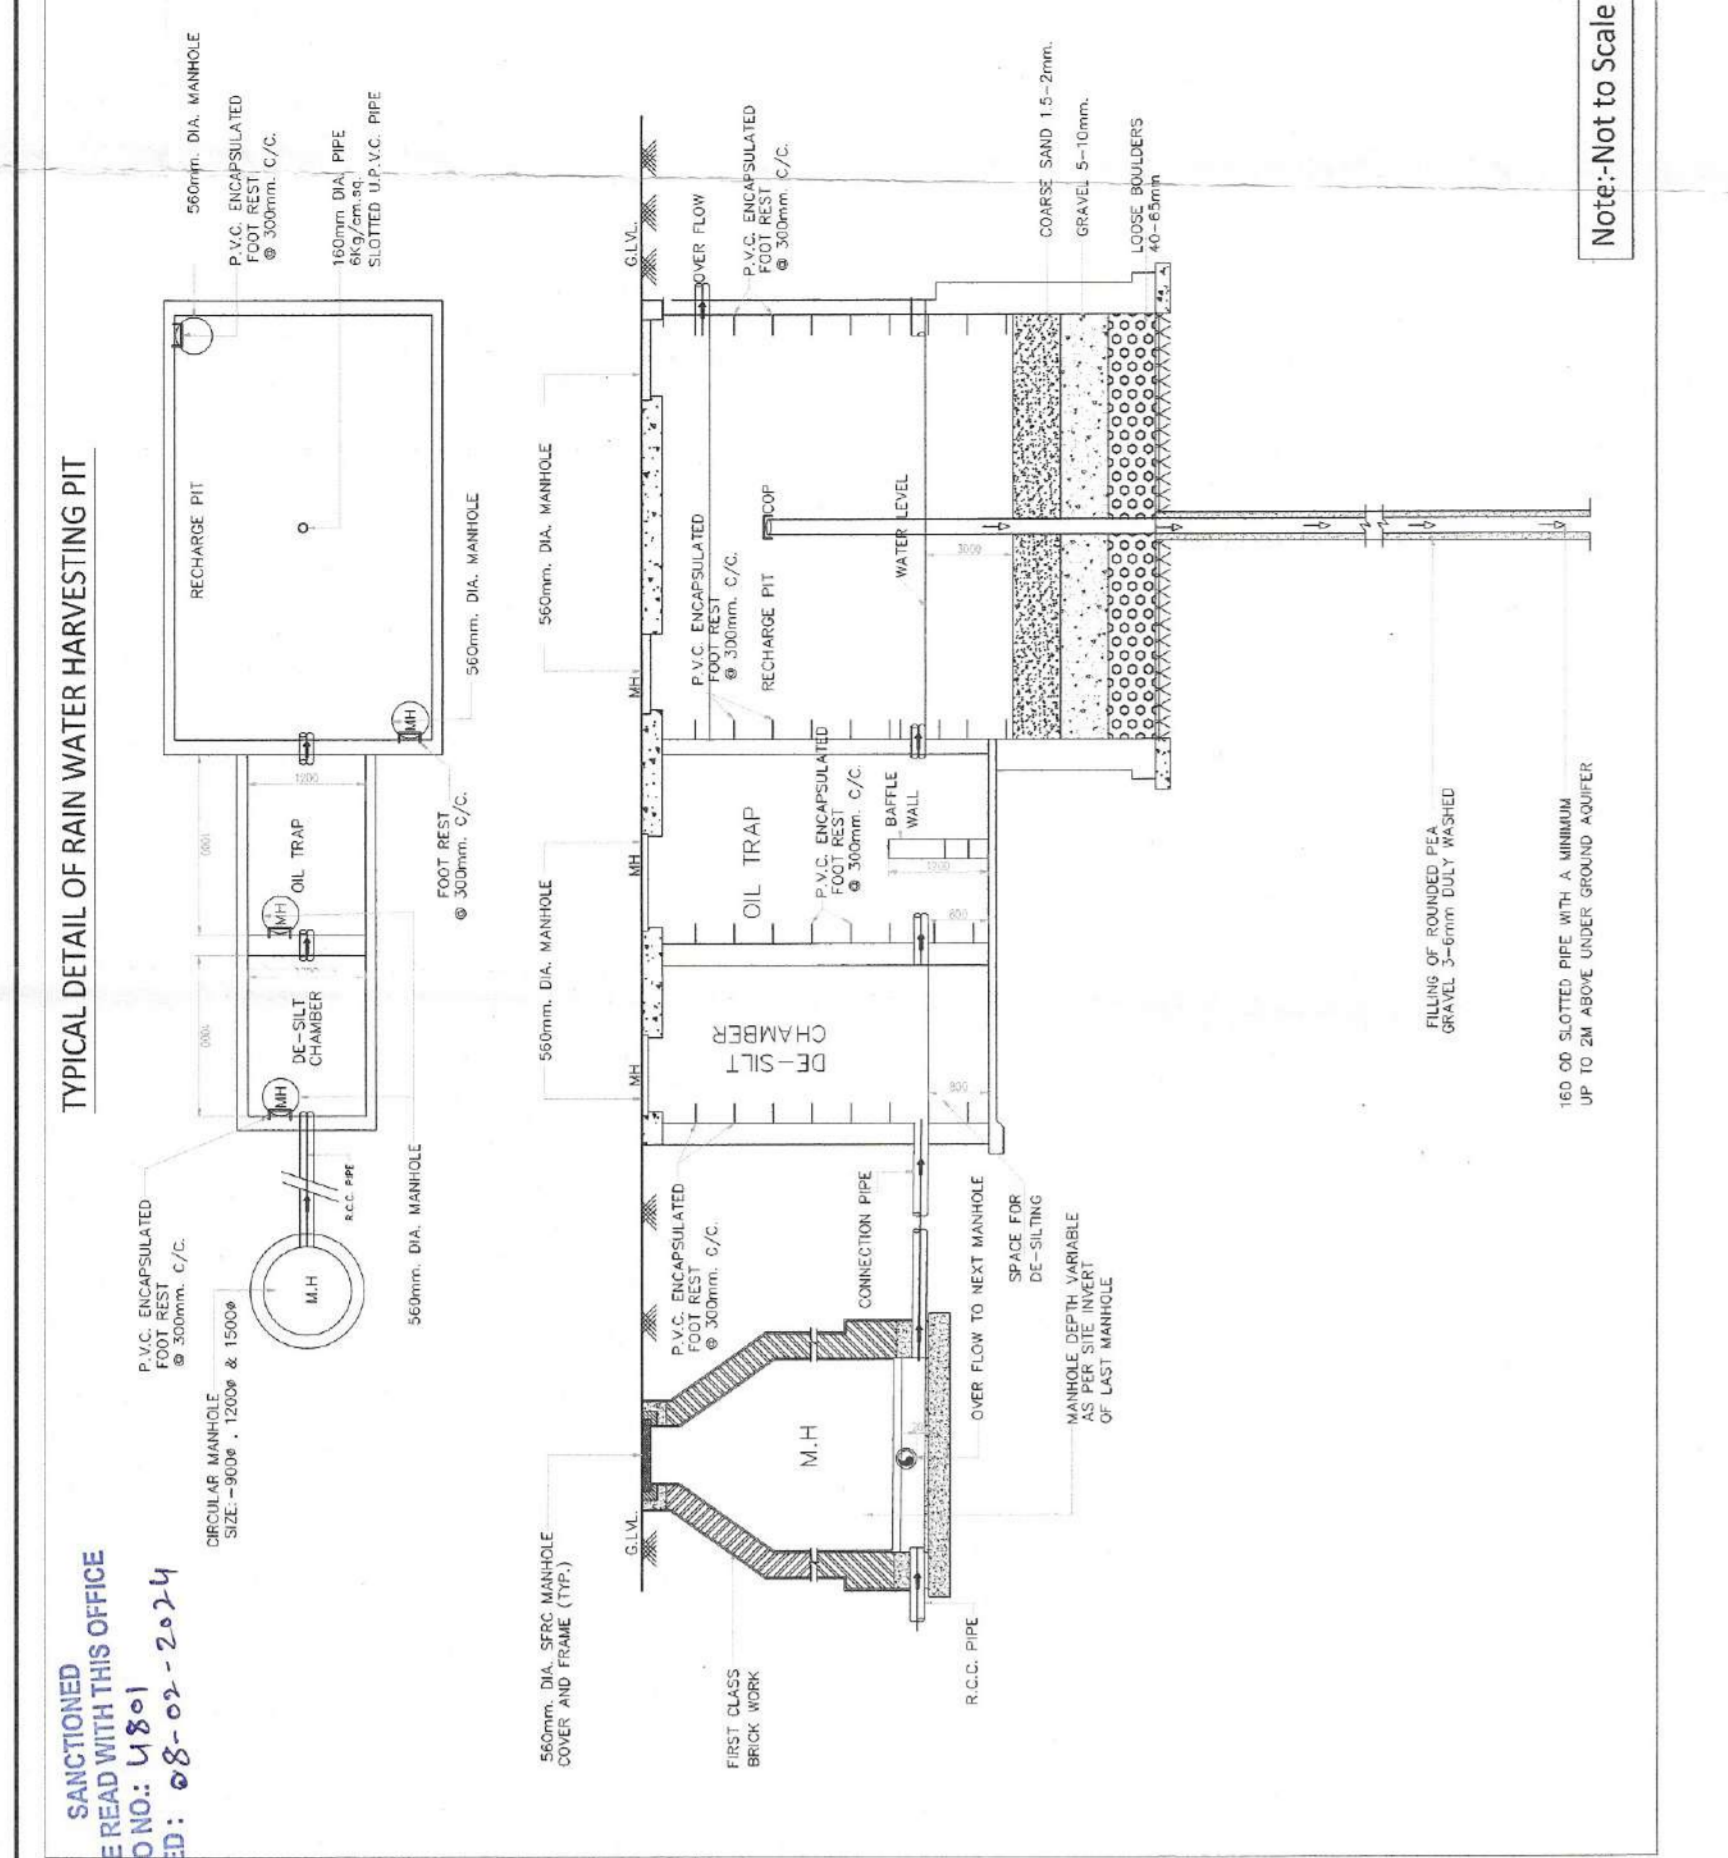

LEGEND FOR IRRIGATION SYSTEM:

S. No.	SYMBOL DESCRIPTION
01	IRRIGATION LINE
02	DOMESTIC LINE
03	TANKER LINE
04	GARDEN HYDRANT
05	WATER METER

LEGEND FOR DRAINAGE SYSTEM:


S. No.	SYMBOL DESCRIPTION
01	STORM WATER LINE
02	STORM MANHOLE
03	RAIN WATER HARVESTING PIT

LEGEND FOR FIRE SERVICES:

S. No.	SYMBOL DESCRIPTION
01	FIRE HYDRANT LINE
02	EXTERNAL FIRE HYDRANT
03	FOUR WAY FIRE BRIGADE CONNECTION
04	TWO WAY FIRE BRIGADE CONNECTION

LEGEND FOR SEWER LINE:

S. No.	SYMBOL DESCRIPTION
01	STP OVERFLOW PIPE

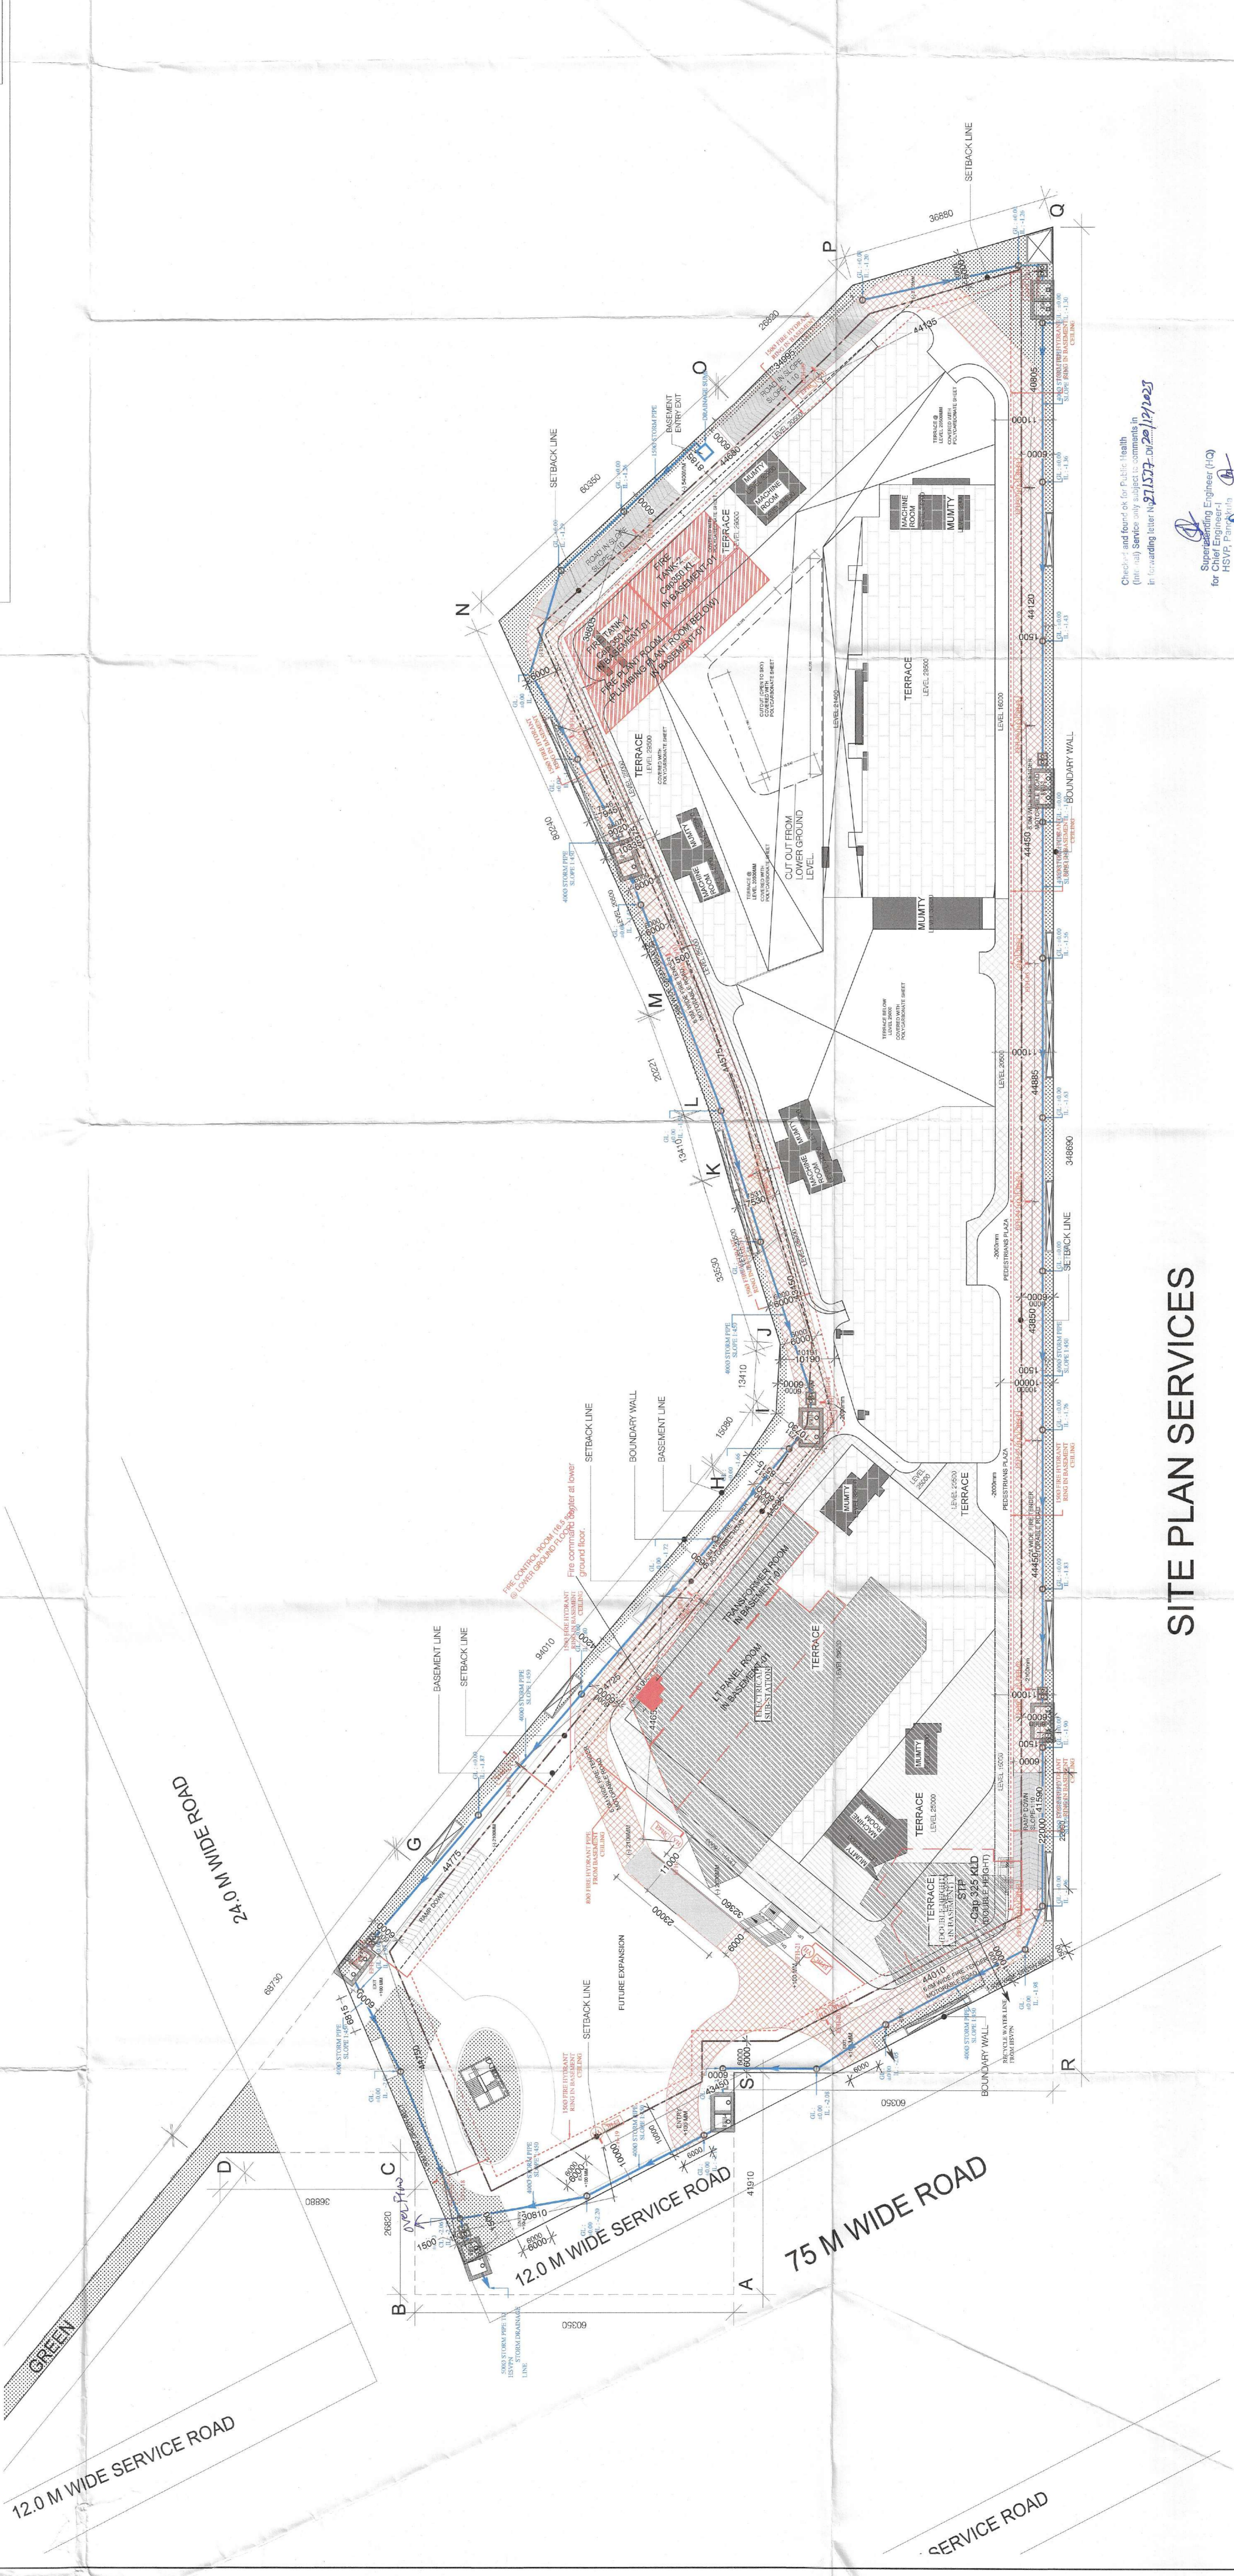

SITE PLAN SERVICES

Checked and found ok for Public Health
 (For all) Sectors only subject to comments in
 the following letter No. 271527-2020/12/2023
 Sanjay Singh Engineer (PG)
 HSWP Professionals