


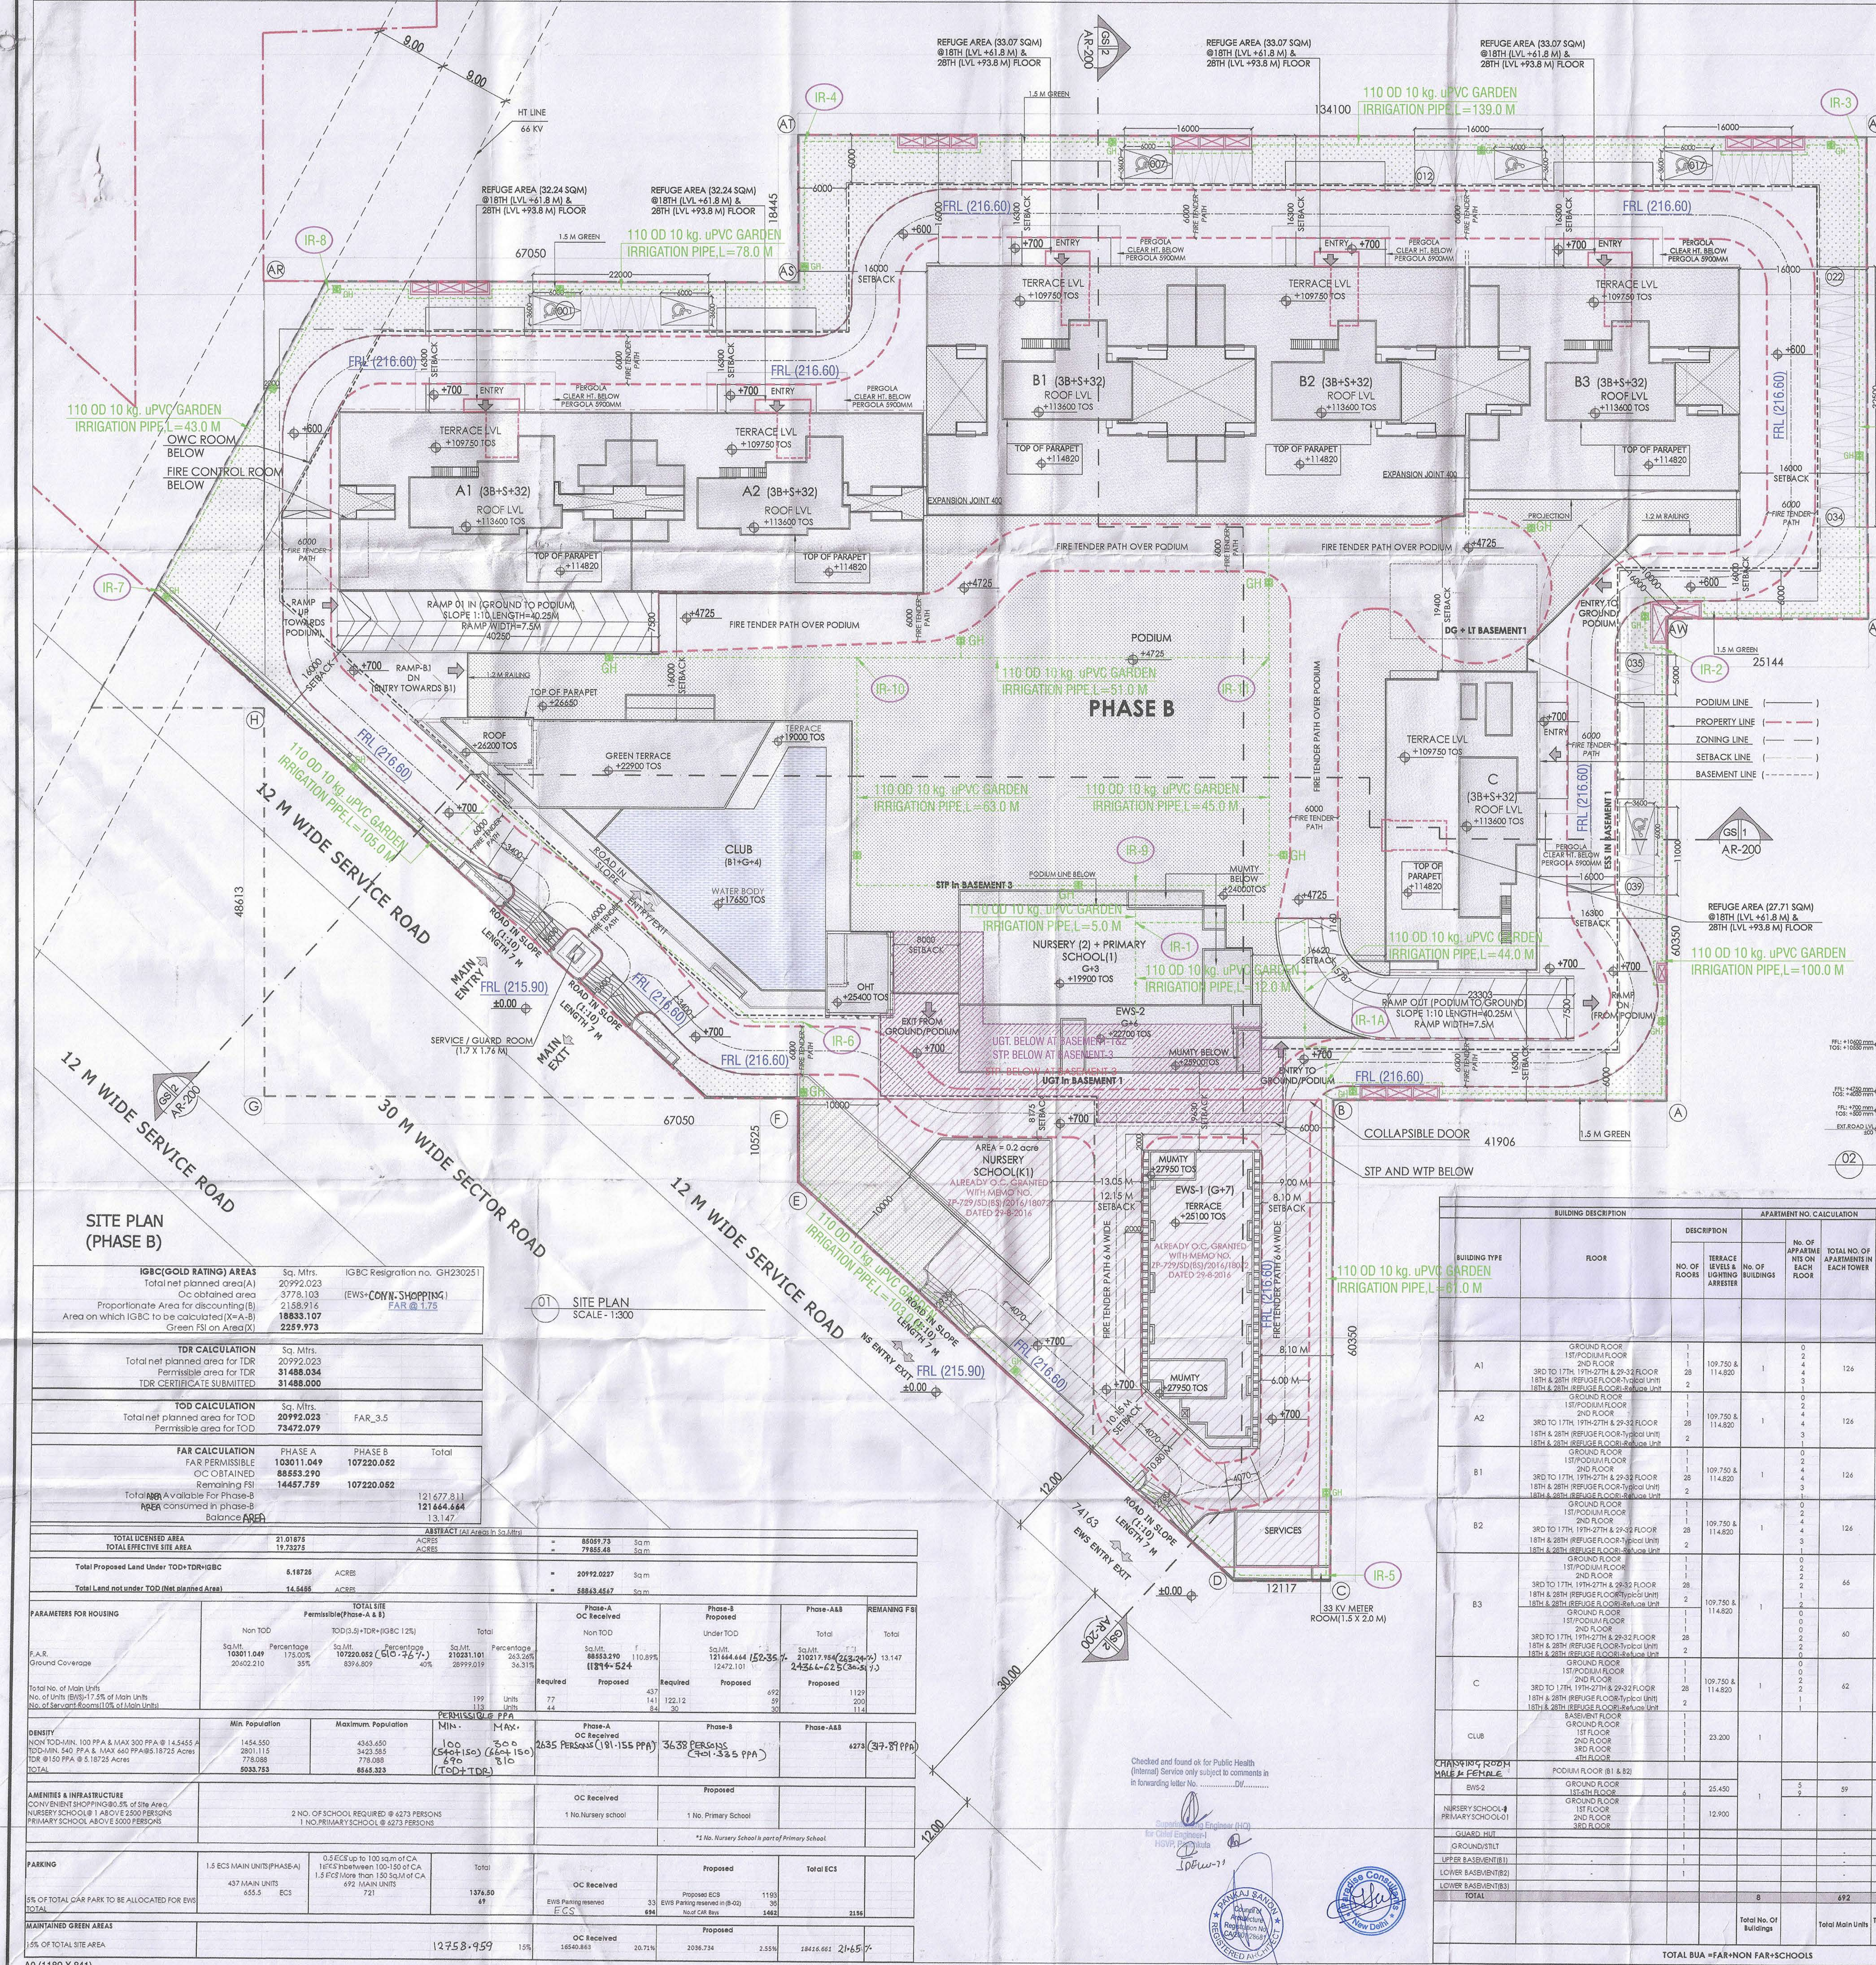

PERMISSIBLE PARKING AS PER AUTHORITY (PHASE B)				
PROPOSED UNIT TYPE	Total no. of units	Carpet Area (Sq.Mtrs.)	Proposed No. of Cars	Proposed No. of Cans
3BHK+3T+3S (C)	248	119.95	1	248
3BHK+3T+3S+4S (L1)	310	126.27	1	310
3BHK+3T+3S+4S (L2)	62	126.14	1	62
4BHK+4T+4S	60	189.27	1.5	90
2BHK+2T+4S (Refuse)	4	98.48	0.5	2
2BHK+2T+3S+3S+4S (L2) (Refuse)	4	105.97	1	4
3BHK+3T+4S (Refuse)	2	169.95	1.5	3
Total	692		5.5	721

SUMMARY - PARKING (PHASE B)				
ECs	Area in Sq.M.	Proposed ECs	Area in Sq.M.	Proposed ECs
TOTAL ECs ON SURFACE 23.54 Mtrs	35	677		
TOTAL AREA AT SITE/PODIUM	4000.00	10719.84		
TOTAL SERVICE AREA & CUTOFF AREA AT BASEMENT B1	224	6319		
ECs PROVIDED ON SURFACE/PODIUM	154	4000.00		
TOTAL AREA AT BASEMENT B1	308	7933		
ECs PROVIDED ON BASEMENT B1	450	5089.98		
TOTAL NUMBER OF CAR PARKS PROVIDED	648	10943.19		
TOTAL AREA AT BASEMENT B2	338	10544		
ECs PROVIDED ON BASEMENT B2	338	10544		
TOTAL NUMBER OF CAR PARKS PROVIDED	338	10544		
TOTAL AREA AT BASEMENT B3	338	10544		
ECs PROVIDED ON BASEMENT B3	338	10544		
TOTAL NUMBER OF CAR PARKS PROVIDED	338	10544		
TOTAL CAR PARKS	1462			
5% OF TOTAL CAR PARKS RESERVED FOR EVs	73			

APPROVED OC LETTER				
City/Governor: ...				
... (Detailed text about the OC letter) ...				

APPROVED SITE PLAN AREA SHEET				
... (Detailed site plan area sheet content) ...				

BUILDING DESCRIPTION				
BUILDING TYPE	DESCRIPTION	APARTMENT NO. CALCULATION	MASTER PLAN AREA SUMMARY	POPULATION STATEMENT
A1	GROUND FLOOR	1	308.351	5
A1	1ST FLOOR	2	432.420	2
A1	2ND FLOOR	3	591.918	3
A1	3RD FLOOR	4	591.918	4
A1	4TH FLOOR	5	591.918	5
A1	5TH FLOOR	6	591.918	6
A1	6TH FLOOR	7	591.918	7
A1	99TH FLOOR	100	591.918	100

PLUMBING LEGEND:-

- IRRIGATION WATER SUPPLY LINE
- GARDEN HYDRANT

CLIENTS

PURI CONSTRUCTION PVT. LTD.
4-7B, GROUND FLOOR,
TOLSTOY HOUSE
TOLSTOY MARG,
NEW DELHI-110001

STRUCTURES

TPC
Technical Projects Consultants Pvt. Ltd.
B-74 [Sector 57] [Noida 201301] [Uttar Pradesh] India
T: +91-120-4306800 | D: +91-120-4306806 |
M: +91-9910285917
www.tpcconsultants.co.in

ARCHITECTS

Atrop Associates Pvt. Ltd.
Plot-368, Sec-32, Gurgaon-122001
Ph: 26242050, 26242169
Montreal, Toronto, New-Delhi, Boston

PROJECT

Building plan of Phase-B, Under (TOD and TDR) policy area measuring 5.56175 Acres License no 87 of 2012 dated 29-08-2012 (4.268 Acres) & License no 33 of 2013 dated 25-05-2013 (1.29375 Acres) part of 21.01875 Acres License No. 55 of 2010 dated 25-07-2010 (15.457 Acres), License no 87 of 2012 dated 29-08-2012 (4.268 Acres) & License no 33 of 2013 dated 25-05-2013 (1.29375 Acres) in Sector-110A & 111, Gurugram being developed by M/s Puri Construction Pvt. Ltd.

ARCHITECT'S SIGNATURE

OWNER'S SIGNATURE

DRAWING TITLE
SITE PLAN
IRRIGATION LAYOUT

DRAWING NO.
AR-MP-03